


OWNER:  
 SMART LOCAL 47  
 TRAINING CENTER INC  
 765 GREEN CREEK DR  
 GLOUCESTER ON  
 K1J 0B2  
 613-724-6116

**LEGEND**

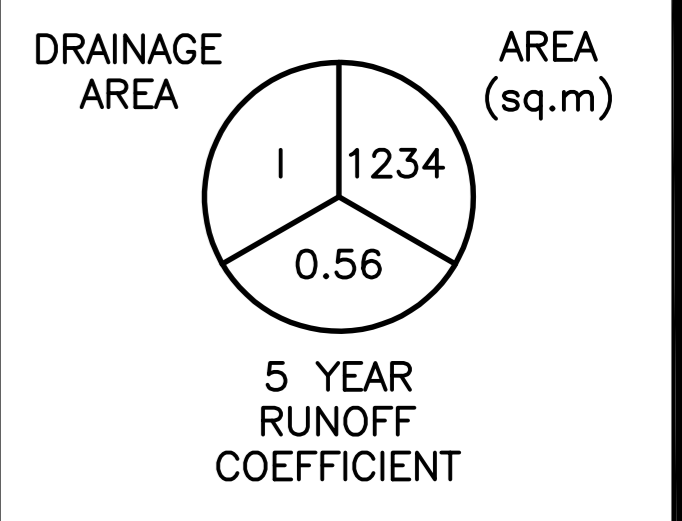


No.	DATE	REVISION
1	APR 21-23	ISSUED FOR APPROVAL

**D. B. GRAY ENGINEERING INC.**  
 Stormwater Management - Grading & Drainage - Storm & Sanitary Sewers - Manholes  
 700 Long Point Circle 613-425-8044  
 Ottawa, Ontario d.gray@dbgrayengineering.com

Project  
**SMART LOCAL 47  
 TRAINING CENTRE**  
 765 GREEN CREEK DRIVE  
 OTTAWA, ONTARIO

Drawing Title  
**PRE (EXISTING)  
 DEVELOPMENT  
 DRAINAGE PLAN**

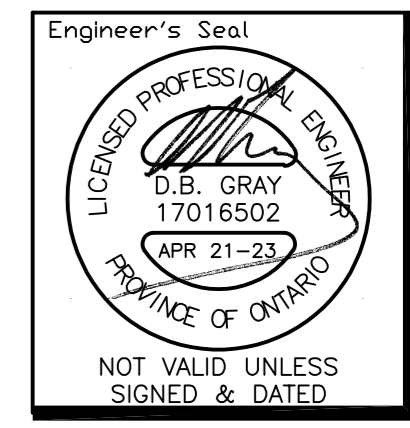

Drawn D.B.G.  
 Hor. Scale 1:200  
 Vert. Scale  
 Date SEP 10-20  
 Job 20014  
 Drawing No.  
**C-4**  
 of 4

NOT VALID UNLESS  
 SIGNED & DATED