



EXISTING GRADE ELEVATION	SANITARY SEWER INVERT	CHAINAGE ABOVE PROPOSED SANITARY
93.42	90.05(E)	A+067.6
93.61	89.99(W)	A+050
93.54	89.93(N)	A+048.7
93.40		

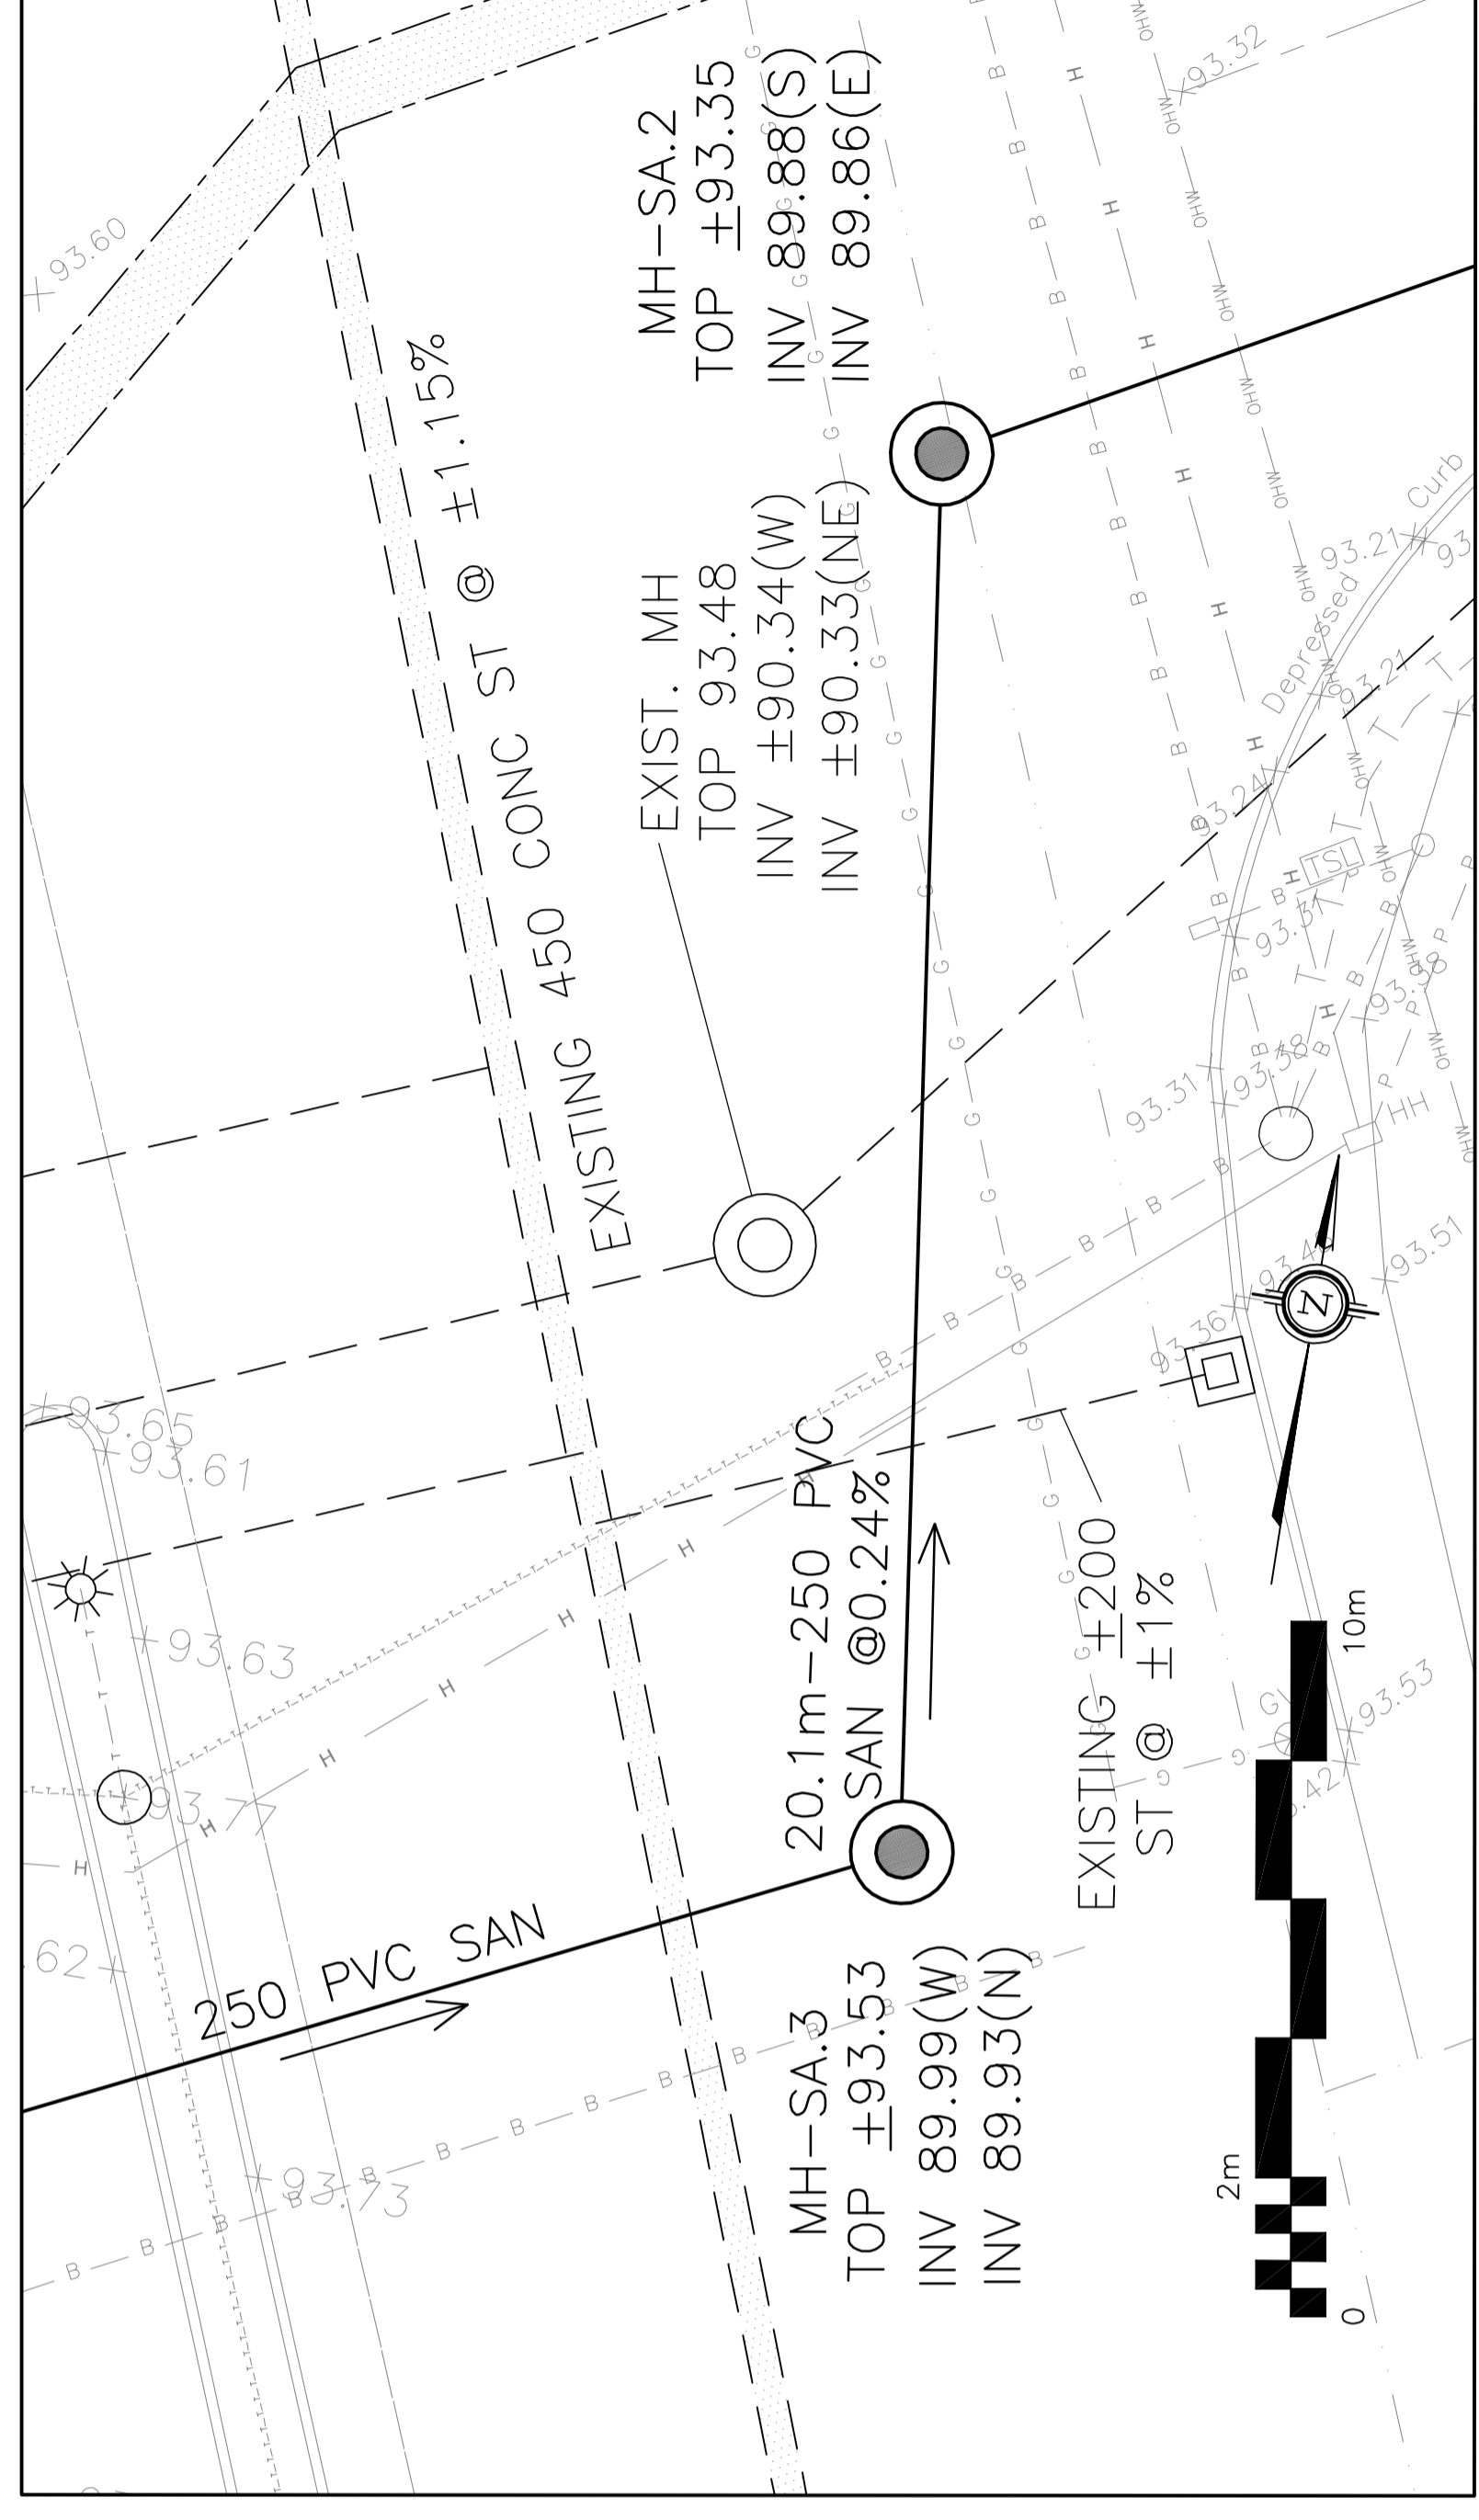

EXISTING GRADE ELEVATION	SANITARY SEWER INVERT	CHAINAGE ABOVE PROPOSED SANITARY
93.53	89.99(W)	A+048.7
93.45	89.86(S)	A+030
93.48	89.86(NE)	A+028.6

CB	CATCH-BASIN
MH	STORM MANHOLE
CB/MH	CATCH BASIN/MANHOLE
MH	SANITARY MANHOLE
VC	VALVE CHAMBER
SPL	SPRINGLINE OF PIPE
INV	INVERT OF PIPE
SAN	SANITARY SEWER
ST	STORM SEWER
WS/WV	WATER SERVICE/WATERMAIN
CS	CURB STOP & STANDPOST
VB	VALVE & VALVE BOX
FH	FIRE HYDRANT
OHW	EXISTING GRADE ELEVATION
H	OVER HEAD WIRE
H	HYDRO
B	BELL TELEPHONE
CAB	CABLE
G	GAS
T	TRAFFIC
---	PROPERTY LINE

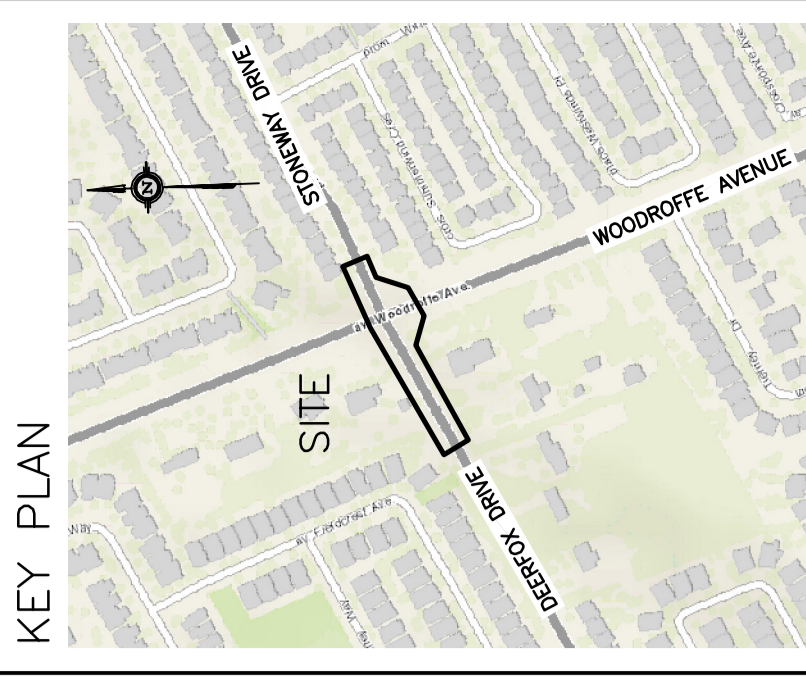


No.	DATE	REVISION
1	SEP 28-21	PRELIMINARY
2	DEC 21-21	ISSUED TO CITY FOR APPROVAL
3	MAR 17-22	RE-ISSUED TO CITY FOR APPROVAL
4	SEP 8-22	RE-ISSUED TO CITY FOR APPROVAL
5	OCT 31-22	RE-ISSUED TO CITY FOR APPROVAL
6	DEC 22-22	RE-ISSUED TO CITY FOR APPROVAL
7	JAN 27-23	RE-ISSUED TO CITY FOR APPROVAL
8	FEB 14-23	RE-ISSUED TO CITY FOR APPROVAL

D. B. GRAY ENGINEERING INC.
 Surveyor (Engineer - Grading & Drainage - Sewer & Storm Sewer - Electrical)
 700 Long Point Circle
 Ottawa, Ontario
 613-425-8044
 dgray@dbgrayengineering.com

MUNICIPAL SANITARY SEWER EXTENSION CROSSING WOODROFFE AVENUE FROM STERFOX DRIVE TO DEERFOX DRIVE OTTAWA, ONTARIO

PLAN AND PROFILE
 STA A+028.6 TO STA A+067.6

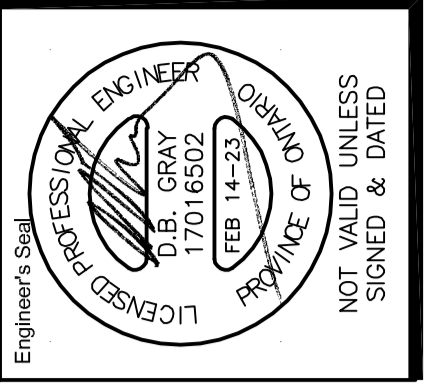

Drawn: D.B.G.
 Plot Scale: 1:100
 Date: SEP 28-21
 Rev. No.: 20085

Drawing No. **C-4** of **9**

#17351

07-12-22-0055

APPROVED
 By Lily Xu at 1:18 pm, Apr 27, 2023

LILY XU, MCP, RPP
 MANAGER, DEVELOPMENT REVIEW SOUTH
 PLANNING, INFRASTRUCTURE & ECONOMIC
 DEVELOPMENT DEPARTMENT, CITY OF OTTAWA

STA A+067.6 TO STA A+097.7
 LOCATED ON DRAWING C-5

STA A+000.0 TO STA A+028.6
 LOCATED ON DRAWING C-3