
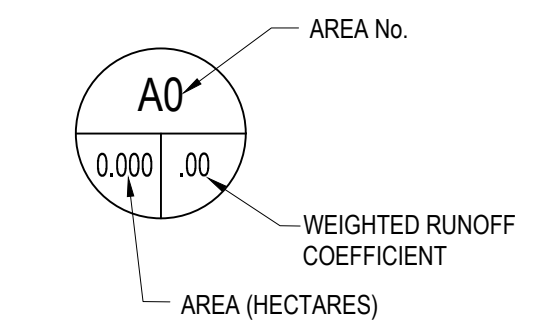


**RICKSON
OUTHET
ARCHITECT**


319 Daly Avenue
Ottawa - Ontario - K1N 6G6
613.728-1637 - FAX 613.728-8501

LEGEND

- 83.24x EXISTING GRADE ELEVATION
- CBCD EXISTING CATCHBASIN
- MH-ST EXISTING MANHOLE
- WV-88 EXISTING VALVE AND BOX
- FH EXISTING FIRE HYDRANT
- ST EXISTING STORM SEWER
- S EXISTING SANITARY SEWER
- w EXISTING WATERMAIN
- 82.82 PROPOSED GRADE ELEVATION
- 82.03C PROPOSED TOP AND BOTTOM OF CURB
- TG82.82 PROPOSED TOP OF GRATE
- 1.8% PROPOSED GRADE SLOPE
- PROPOSED CATCHBASIN
- PROPOSED MANHOLE
- PROPOSED CATCHBASIN MANHOLE
- STM PROPOSED STORM SEWER
- SAN PROPOSED SANITARY SEWER
- w PROPOSED WATER SERVICE
- PROPOSED FIRE HYDRANT
- SF LIGHT DUTY SILT FENCE
- FILTER CLOTH
- PROPOSED ROOF DRAIN
- PROJECT BOUNDARY
- OVERLAND FLOW
- RD ROOF DRAIN

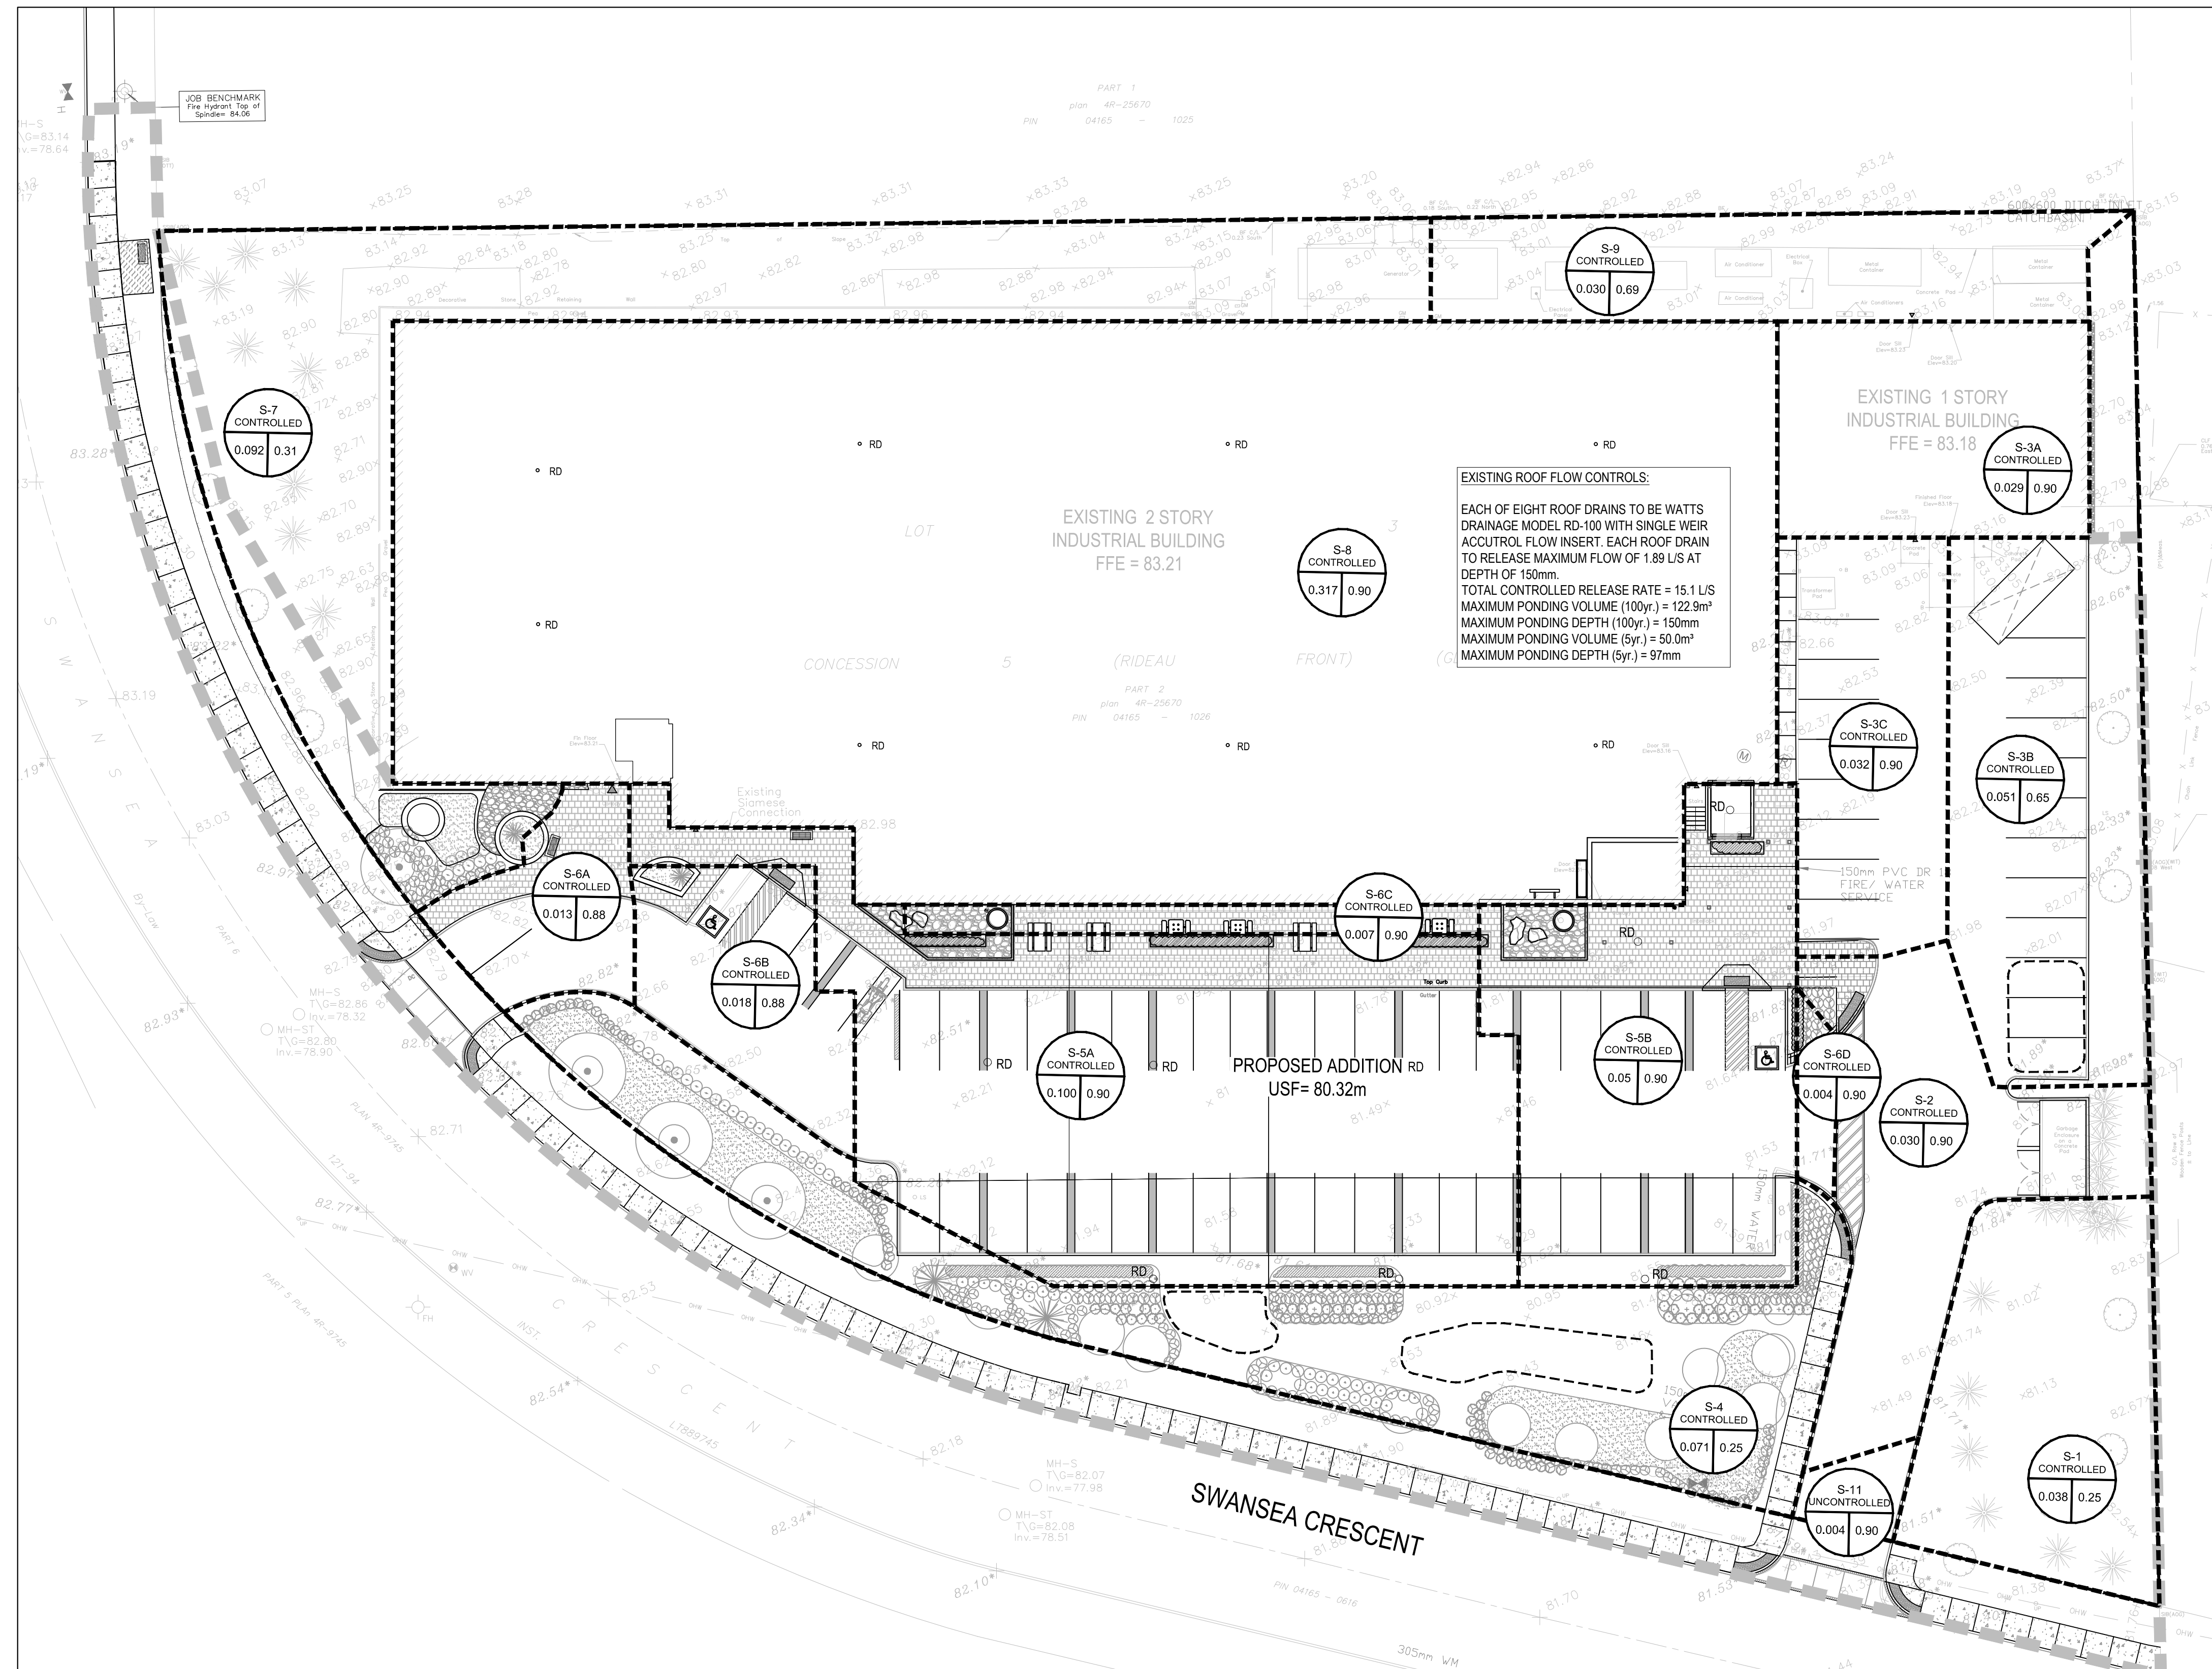

1 DRAINAGE PLAN
C004 SCALE= 1:250

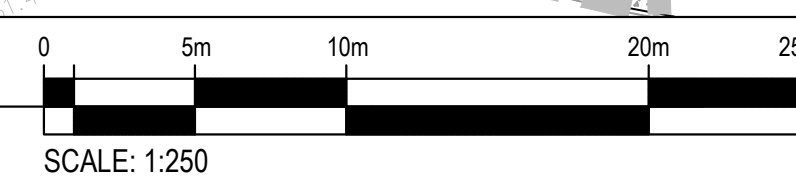

2	REISSUED FOR SPA	2023-05-03
1	ISSUED FOR SPA	2022-10-13

No.	Revision	Date
2	REISSUED FOR SPA	2023-05-03
1	ISSUED FOR SPA	2022-10-13

Project Title: **IRIDIAN SPECTRAL TECHNOLOGIES**
2700 SWANSEA OTTAWA, ONTARIO.

DRAINAGE PLAN

Designed by:	J.Z.	Conçu par:
Date:	MAY 3, 2023	
Drawn:	B.N.	Dessiné:
Date:	MAY 3, 2023	
Approved:	J.Z.	Approuvé:
Date:	MAY 3, 2023	
Project no.:	221-02216-00	No. du projet:

Scale: AS NOTED
Drawing no. C004