
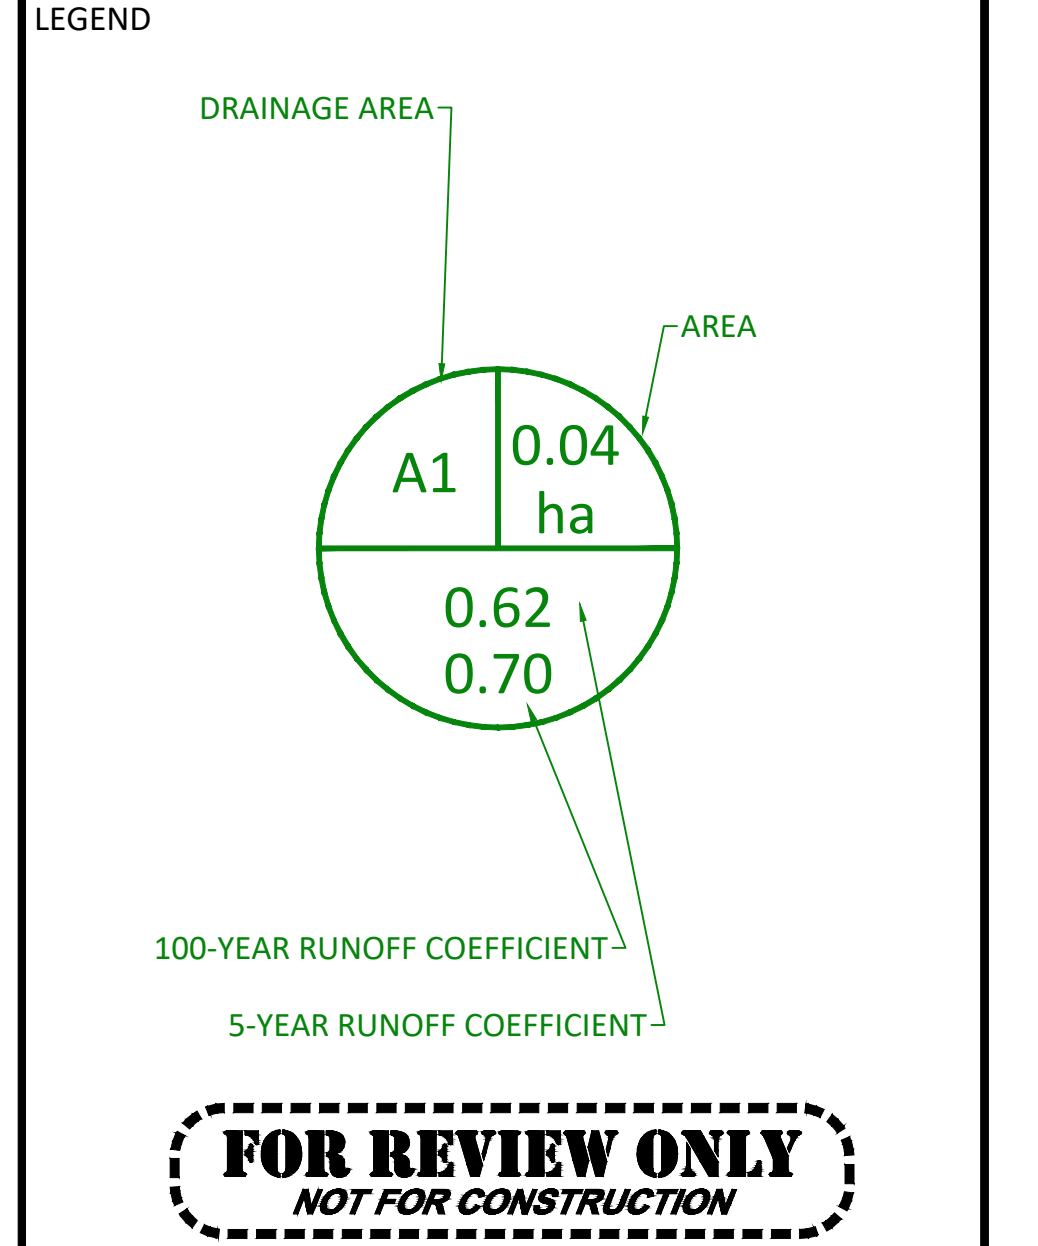
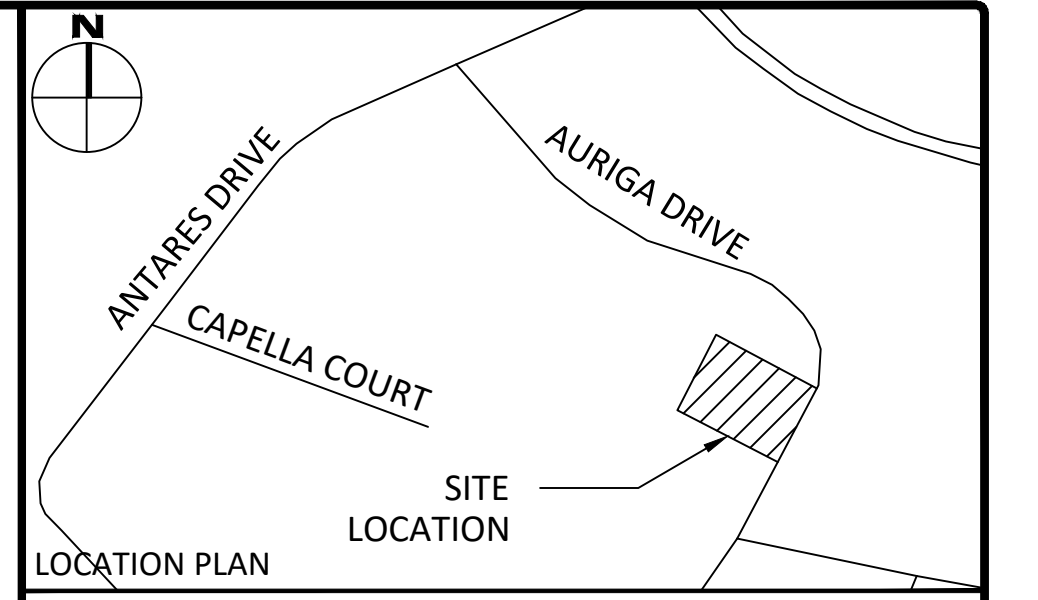


FILENAME: I:\Other\0101 Project - Proposed\2023\0914\001\CCO-23-0914 - Warehouse_3D_Auriga_DWG12 - Drainage\CCO-23-0914_Presentation.dwg
 DATE PLOTTED: Monday, May 15, 2023 1:52:38 PM
 USER: MJP
 PLOTTER: HP DesignJet T1100e

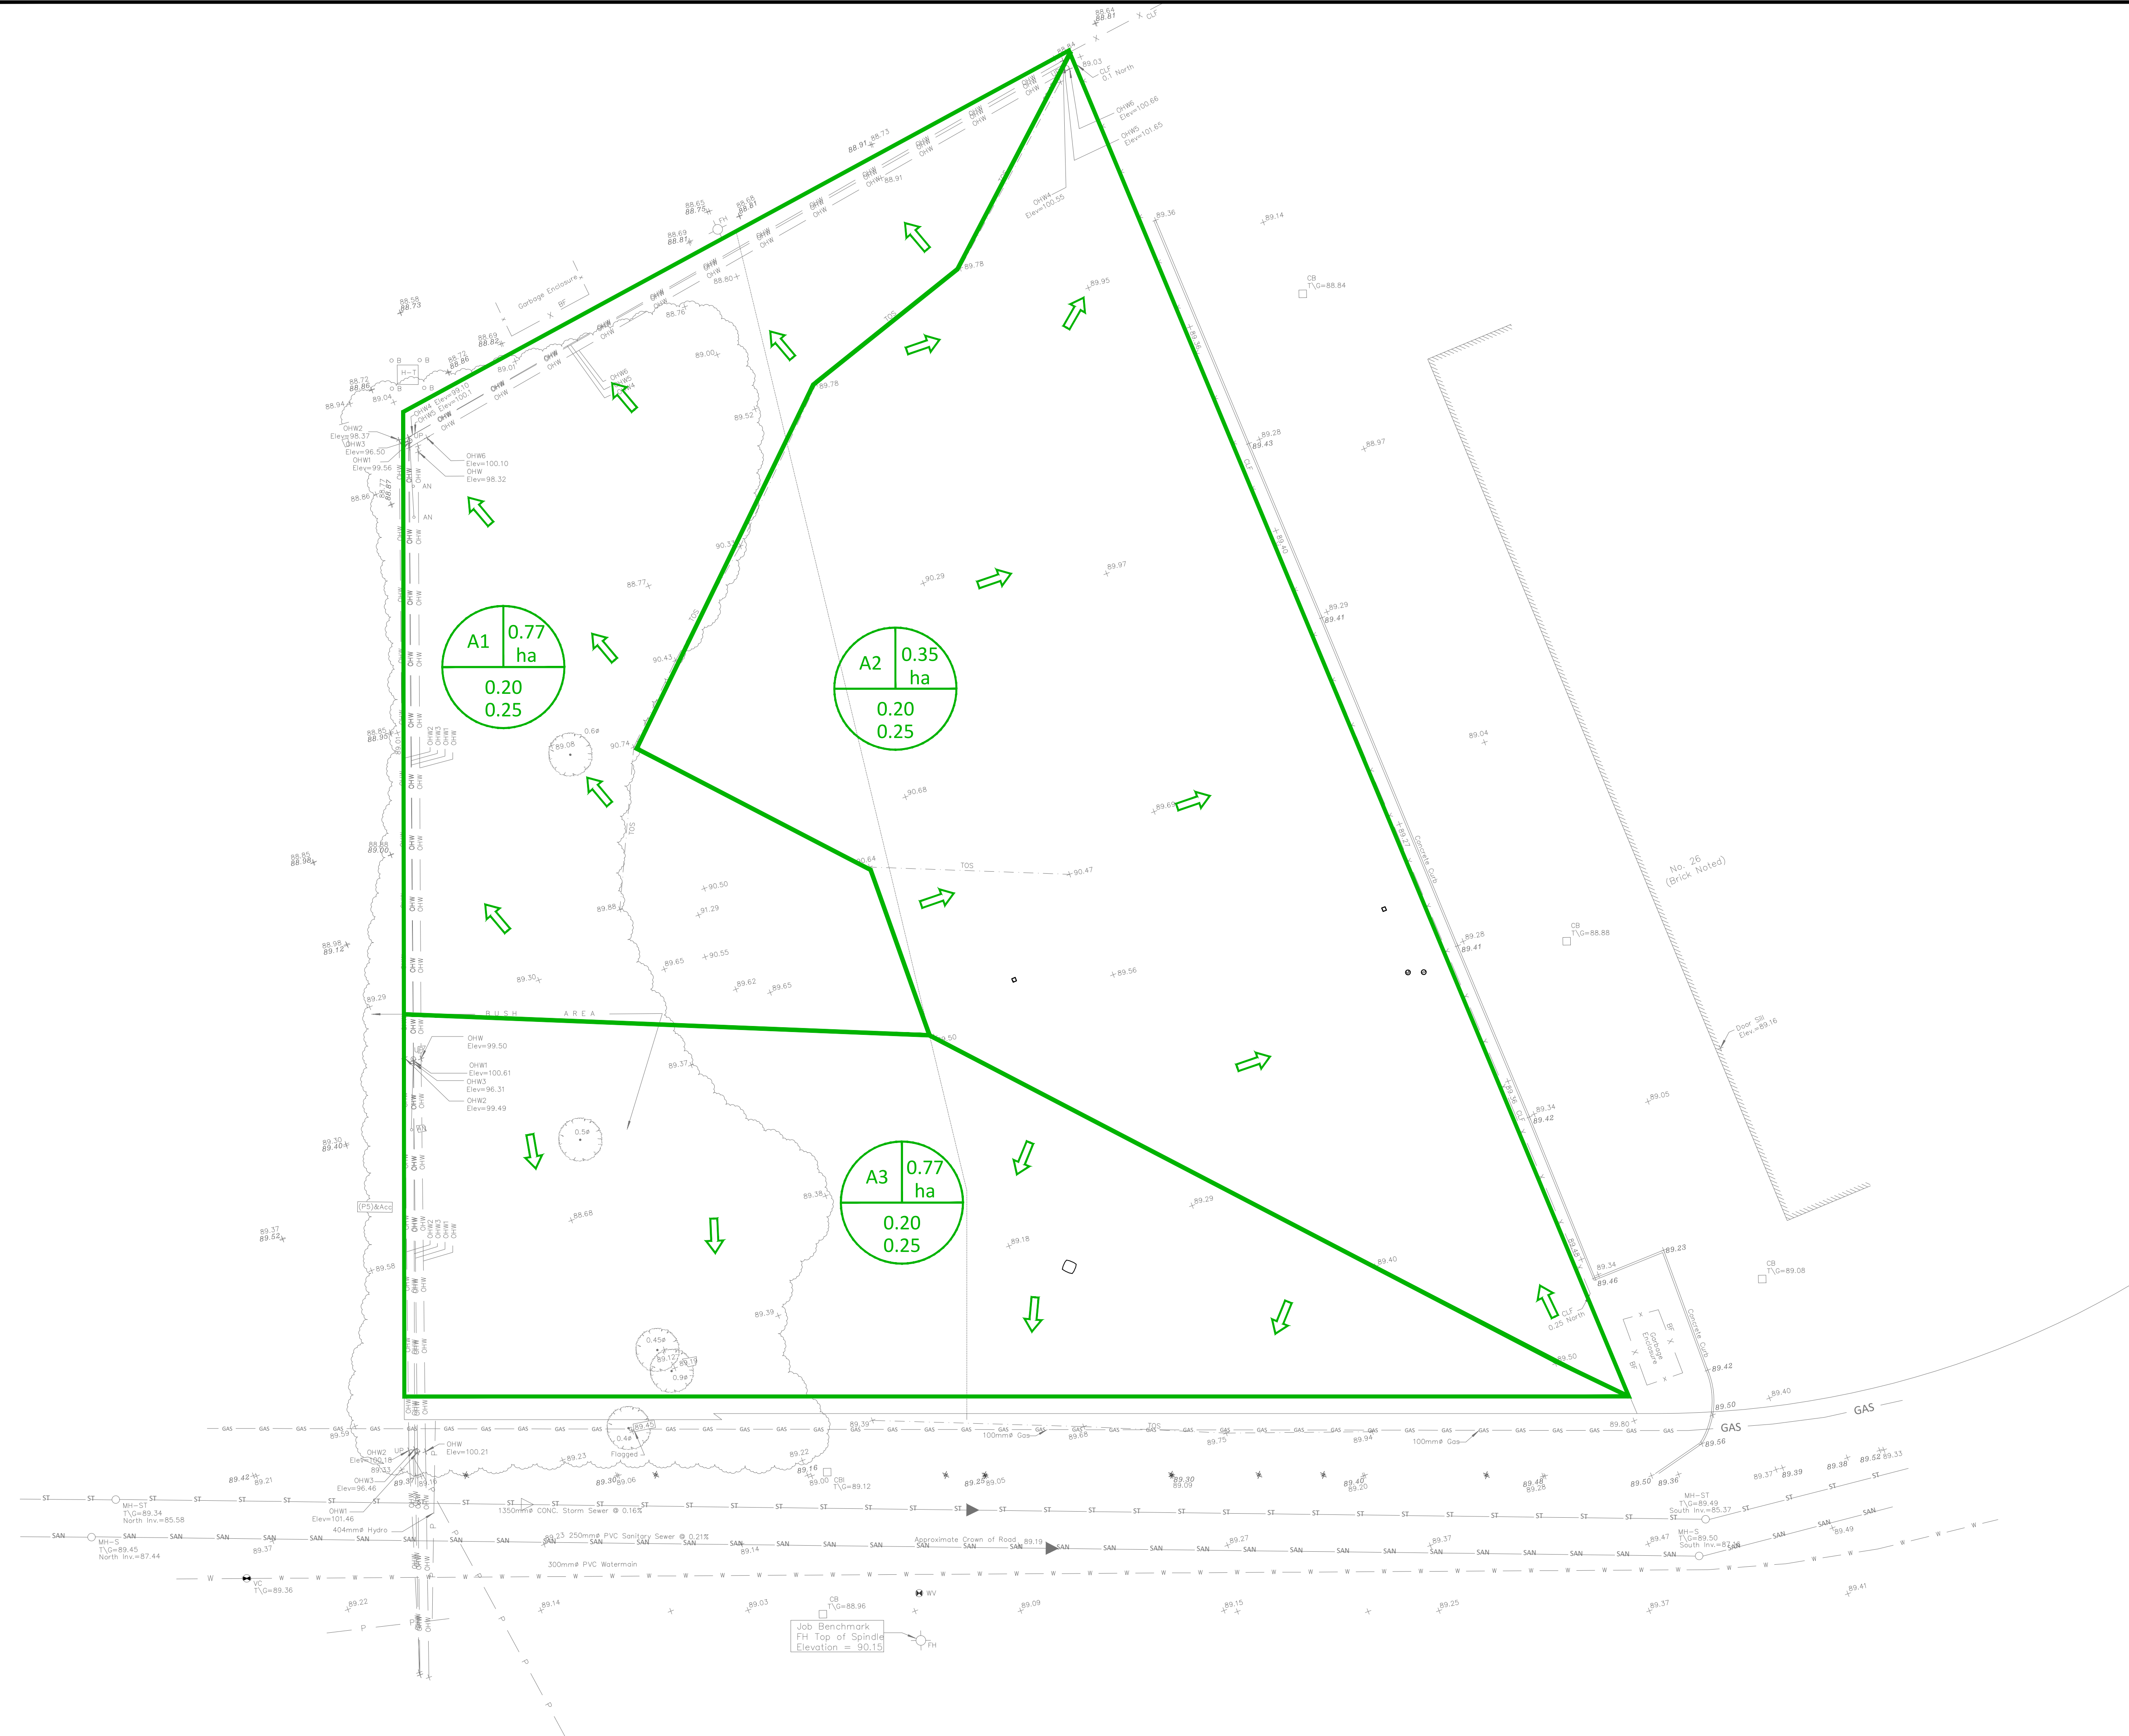


No.	Revisions	Date
2	REVISED PER CITY COMMENTS	2023-05-17
1	ISSUED FOR SITE PLAN APPLICATION	2022-12-22

Check and verify all dimensions before proceeding with the work. Do not scale drawings.

SCALE 1:250

McINTOSH PERRY
 115 Walgreen Road, RR3, Carp, ON K0A 1L0
 Tel: 613-836-2184 Fax: 613-836-3742
 www.mcintoshperry.com

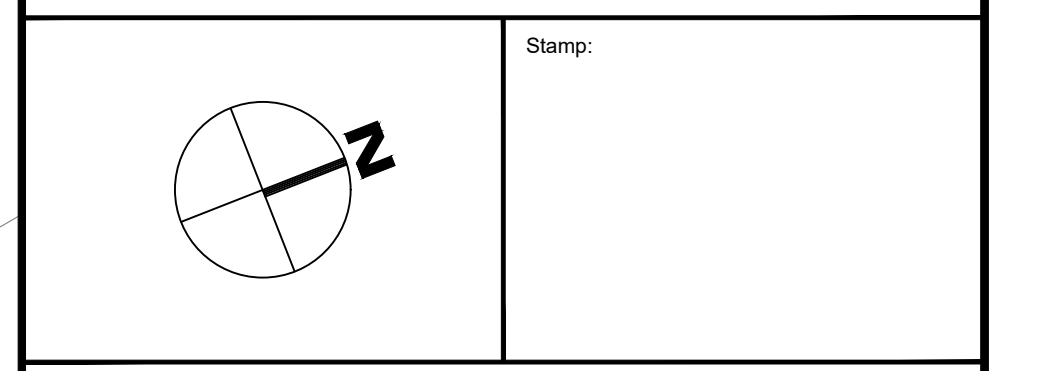

Client: **ROSSMANN ARCHITECTURE**
 86 BOUL. ST-JOSEPH
 GATINEAU, QC J8Y 3W5

Project: **PROPOSED WAREHOUSE**
 30 AURIGA DRIVE

Drawing Title: **PRE DEVELOPMENT AREA DRAINAGE PLAN**

Scale:	1:250	Project Number:	CCO-23-0914
Drawn By:	M.R.	Checked By:	AM
Designed By:	CJM	Drawing Number:	C103

D07-12-23-0016

XXXXX