
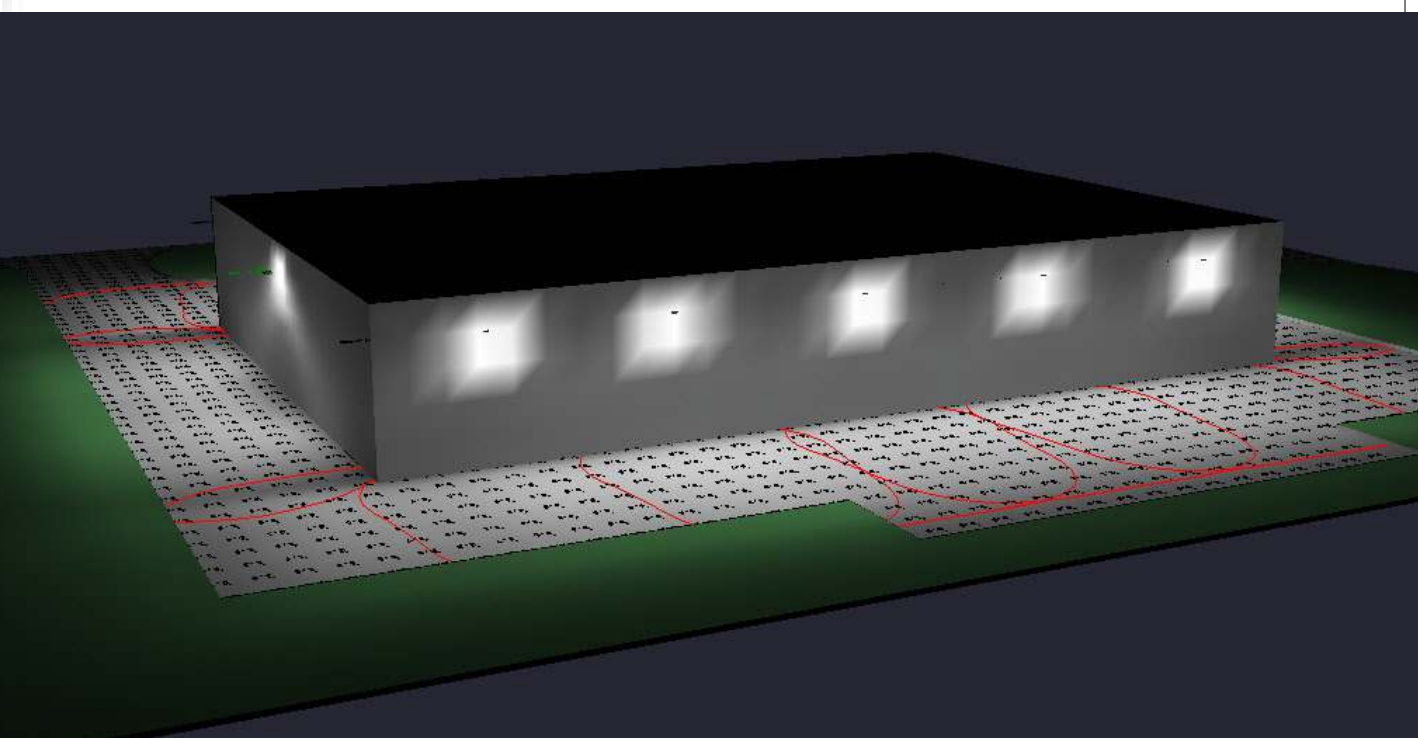
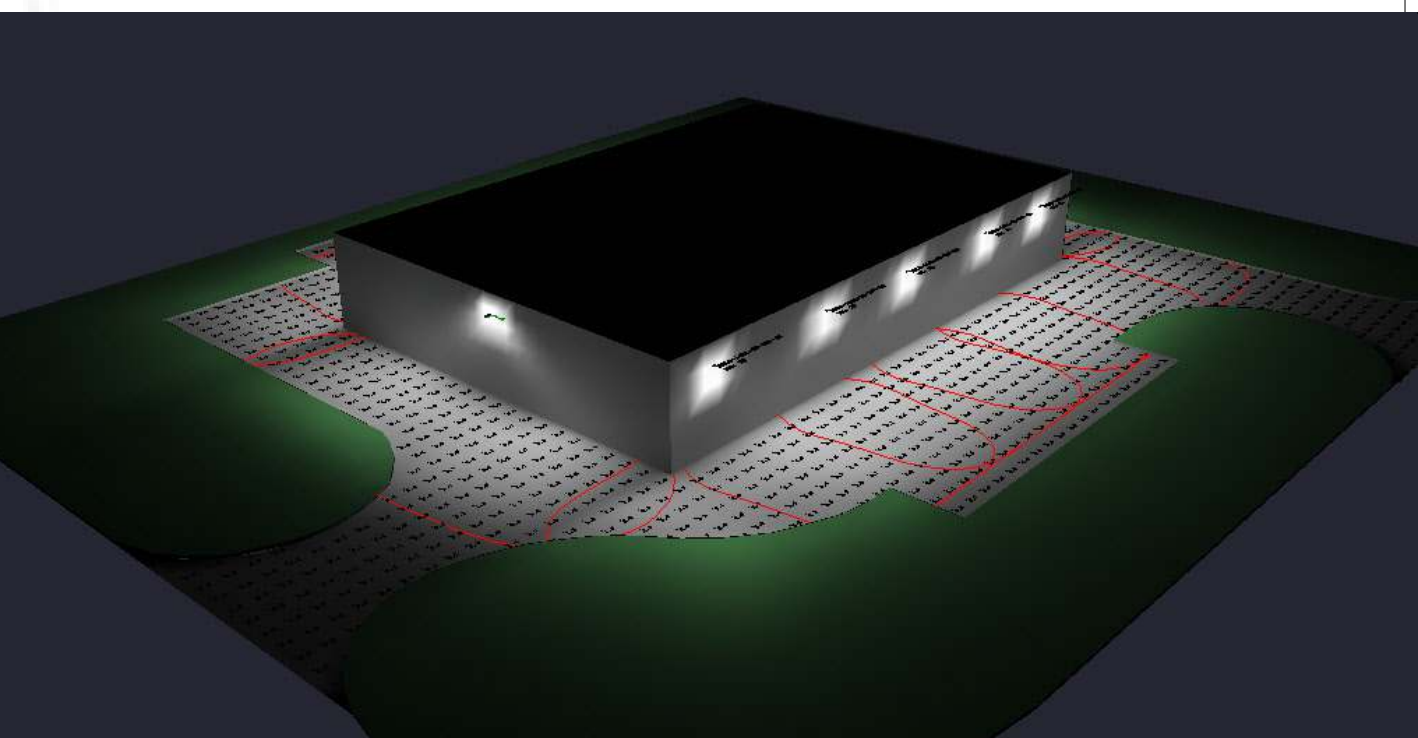


Luminaire Schedule						
Symbol	Qty	Label	Arrangement	LLF	Description	Lum. Lumens
	2	A2	SINGLE	0.900	CURRENT - RWL2-160L-115-4K7-3-U	15281
	10	RWL2-160L-65-3K7-4W	SINGLE	0.900	RWL2-160L-65-3K7-4-U	9098

Calculation Summary							
Label	CalcType	Units	Avg	Max	Min	Avg/Min	Max/Min
PARKING AREA_Planar	Illuminance	Fc	2.94	6.9	0.0	N.A.	N.A.

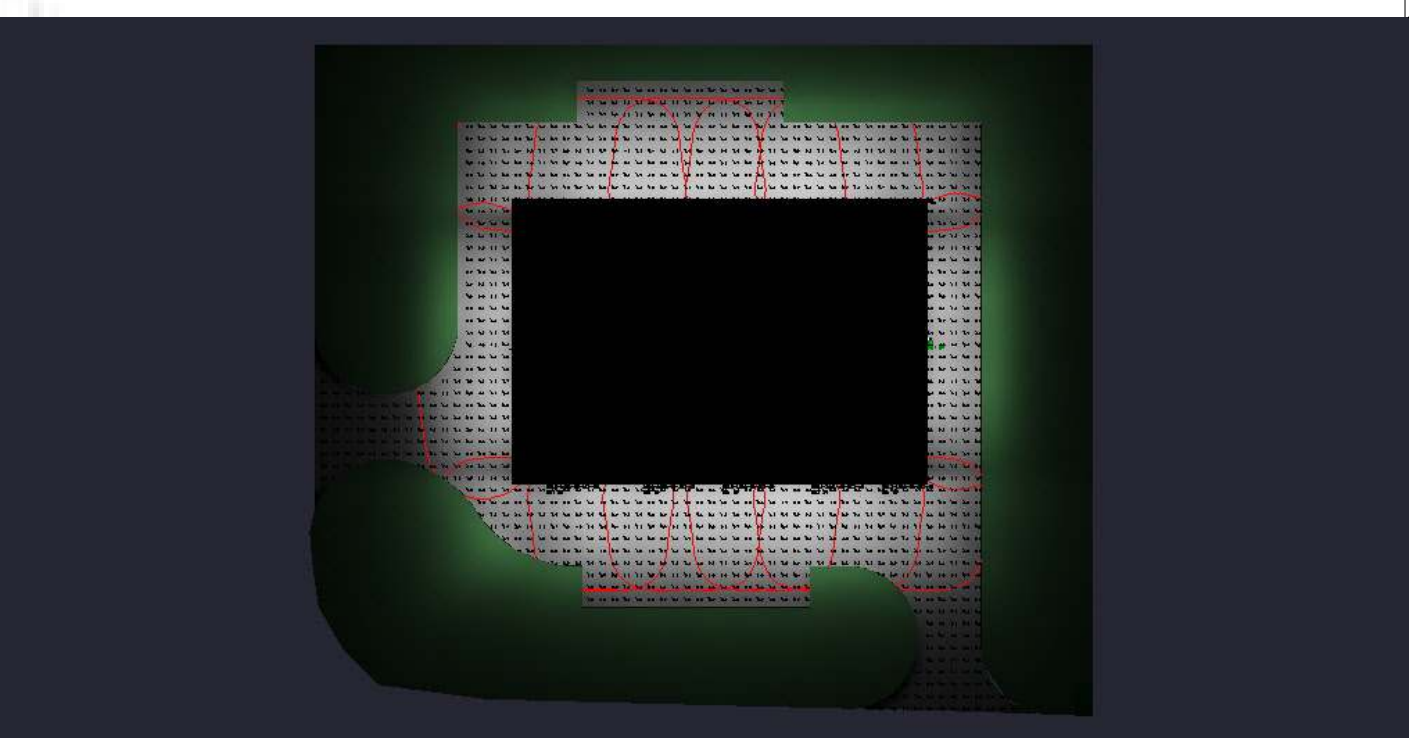

MVP LIGHTING
Liam Beck
em: liam@mvp-lighting.ca
ph: 613-601-2042

Drawn By:
Checked By:
Date: 5/12/2023

Scale:

2167 MCGEE SIDE

MVP LIGHTING