

1	ISSUED FOR TENDER	05/05/23
0	ISSUED FOR PRE-ENGINEERED BUILDING TENDER	26/10/22
No.	ISSUE / REVISION	DD/MM/YY

THESE DRAWINGS HAVE BEEN PRODUCED BY J.L. RICHARDS & ASSOCIATES LIMITED AND ARE SUBJECT TO COPYRIGHT AND USE RESTRICTIONS SET OUT IN THE APPLICABLE PROJECT CONTRACT. ANY USE, REUSE, OR MODIFICATION OF THESE DRAWINGS FOR PURPOSES OTHER THAN THE ORIGINAL PROJECT OR EXECUTION OF THE DESCRIBED WORK IS NOT PERMITTED OR ENDORSED WITHOUT THE PRIOR WRITTEN AUTHORIZATION OF J.L.R. J.L.R. MAKES NO WARRANTIES, EITHER EXPRESS OR IMPLIED, OF THE SUITABILITY OR FITNESS OF THESE DRAWINGS FOR ANY OTHER PURPOSE, AND ANY PARTY WHICH CHOOSES TO USE, MODIFY, OR OTHERWISE RELY ON THESE DRAWINGS WITHOUT J.L.R.'S AUTHORIZATION ACCEPTS THESE LIMITATIONS AND DOES SO AT THEIR SOLE RISK AND WITHOUT LIABILITY TO J.L.R.

VERIFY SHEET SIZE AND SCALES. THE BAR TO THE RIGHT IS 25mm IF THIS IS A FULL SIZE DRAWING.

SCALE: As indicated

CLIENT:

CONSULTANT:

 ENGINEERS - ARCHITECTS - PLANNERS

CONSULTANT:

 PROJECT NORTH


PROJECT:
 HYDRO ONE OPERATIONS CENTRE, ORLEANS
 3440 FRANK KENNY ROAD, NAVAN ONTARIO

DRAWING:
 ARCHITECTURAL
 ROOF PLAN

DESIGN: AE
 DRAWN: JG
 CHECKED: MF/AE
 JLR #: 31500-000
 DRAWING #:
A202

APPROVED
 By Adam Brown at 2:54 pm, Jul 25, 2023

ADAM BROWN
 MANAGER, DEVELOPMENT REVIEW - RURAL
 PLANNING, REAL ESTATE & ECONOMIC DEVELOPMENT
 DEPARTMENT, CITY OF OTTAWA

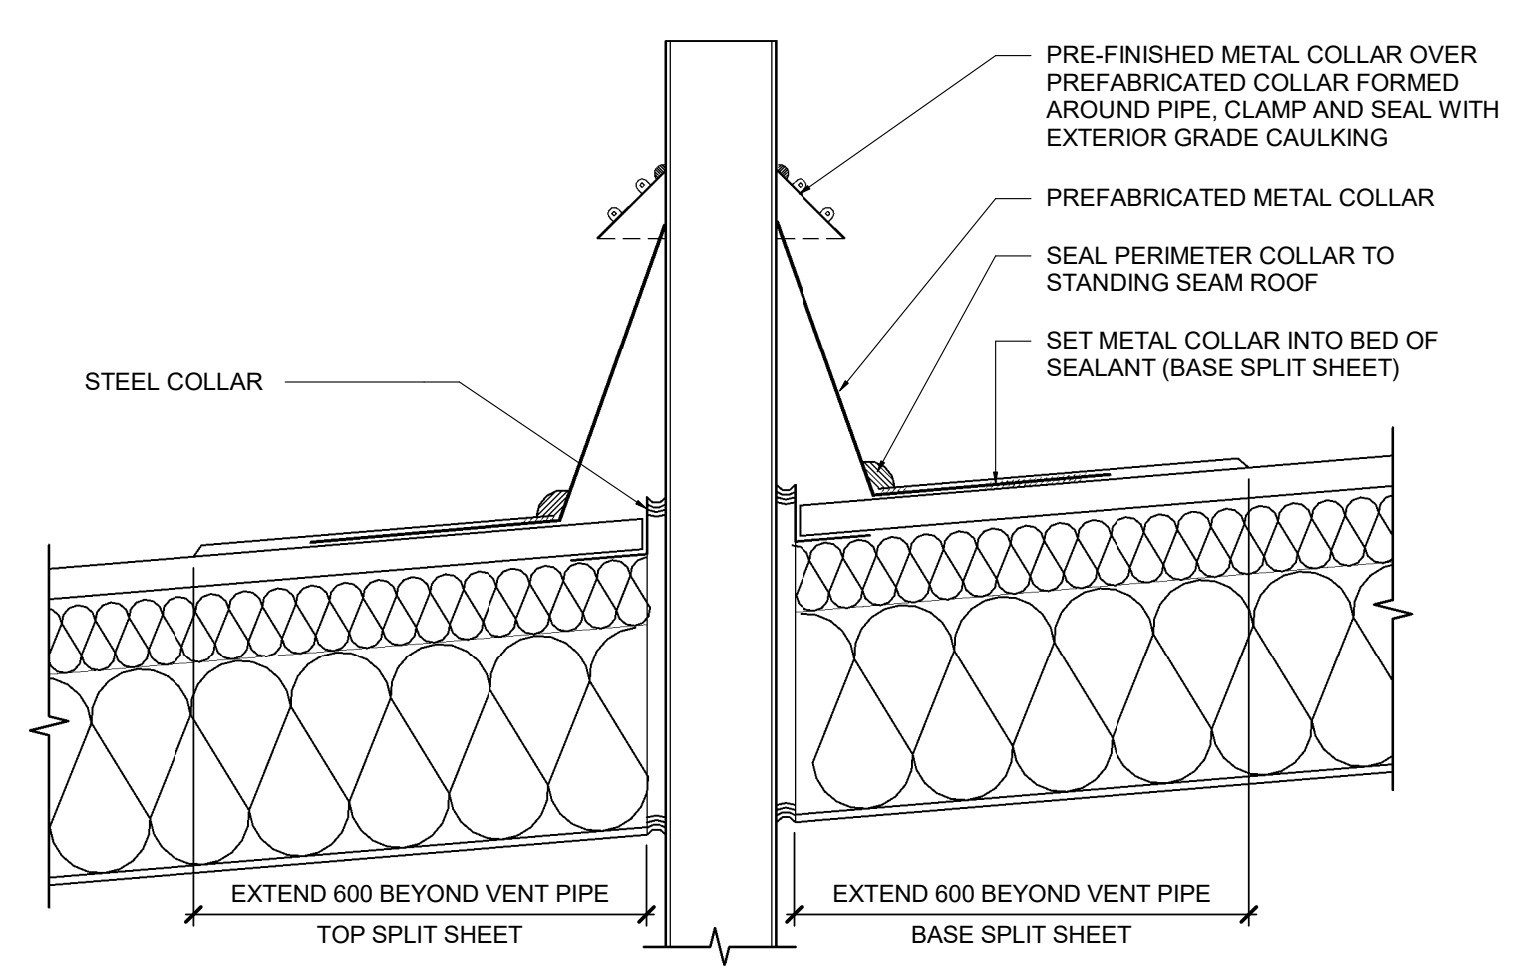

ROOF PIPE PENETRATION DETAIL
 SCALE: 1:10

File Location: C:\Users\Gcauthier\Desktop\31500-000\HONI\Orleans\31500-000 - Architectural.MT
 CITY PLAN No. 18971 - CITY FILE No. D07-12-22-057