

Lighting • Controls • Shades




Control the Experience

Project name 4 CAMPBELL REID COURT	Project number 23080	Date 2023.06.19	2936 Baseline Road, Suite 100 Tel: 613-592-9948 Ottawa, Ontario Fax: 613-592-9984 K2H 1B3 www.fluxlighting.ca
Drawing name PHOTOMETRIC SUMMARY	Drawing number PP-01	Drawn by E CARMICHAEL	

DRAWING INFORMATION

- ① LUMINAIRE MOUNTING HEIGHTS INDICATED IN DRAWINGS BY EC
- ② WALL SCONCE - M/H INDICATED IS DISTANCE FROM FLOOR TO CENTER OF FIXTURE
- ③ REFER TO ENGINEERED DRAWINGS FOR FURTHER SITE INFORMATION
- ④ CALCULATION POINT PLANE INDICATED IN SCHEDULE BY EC

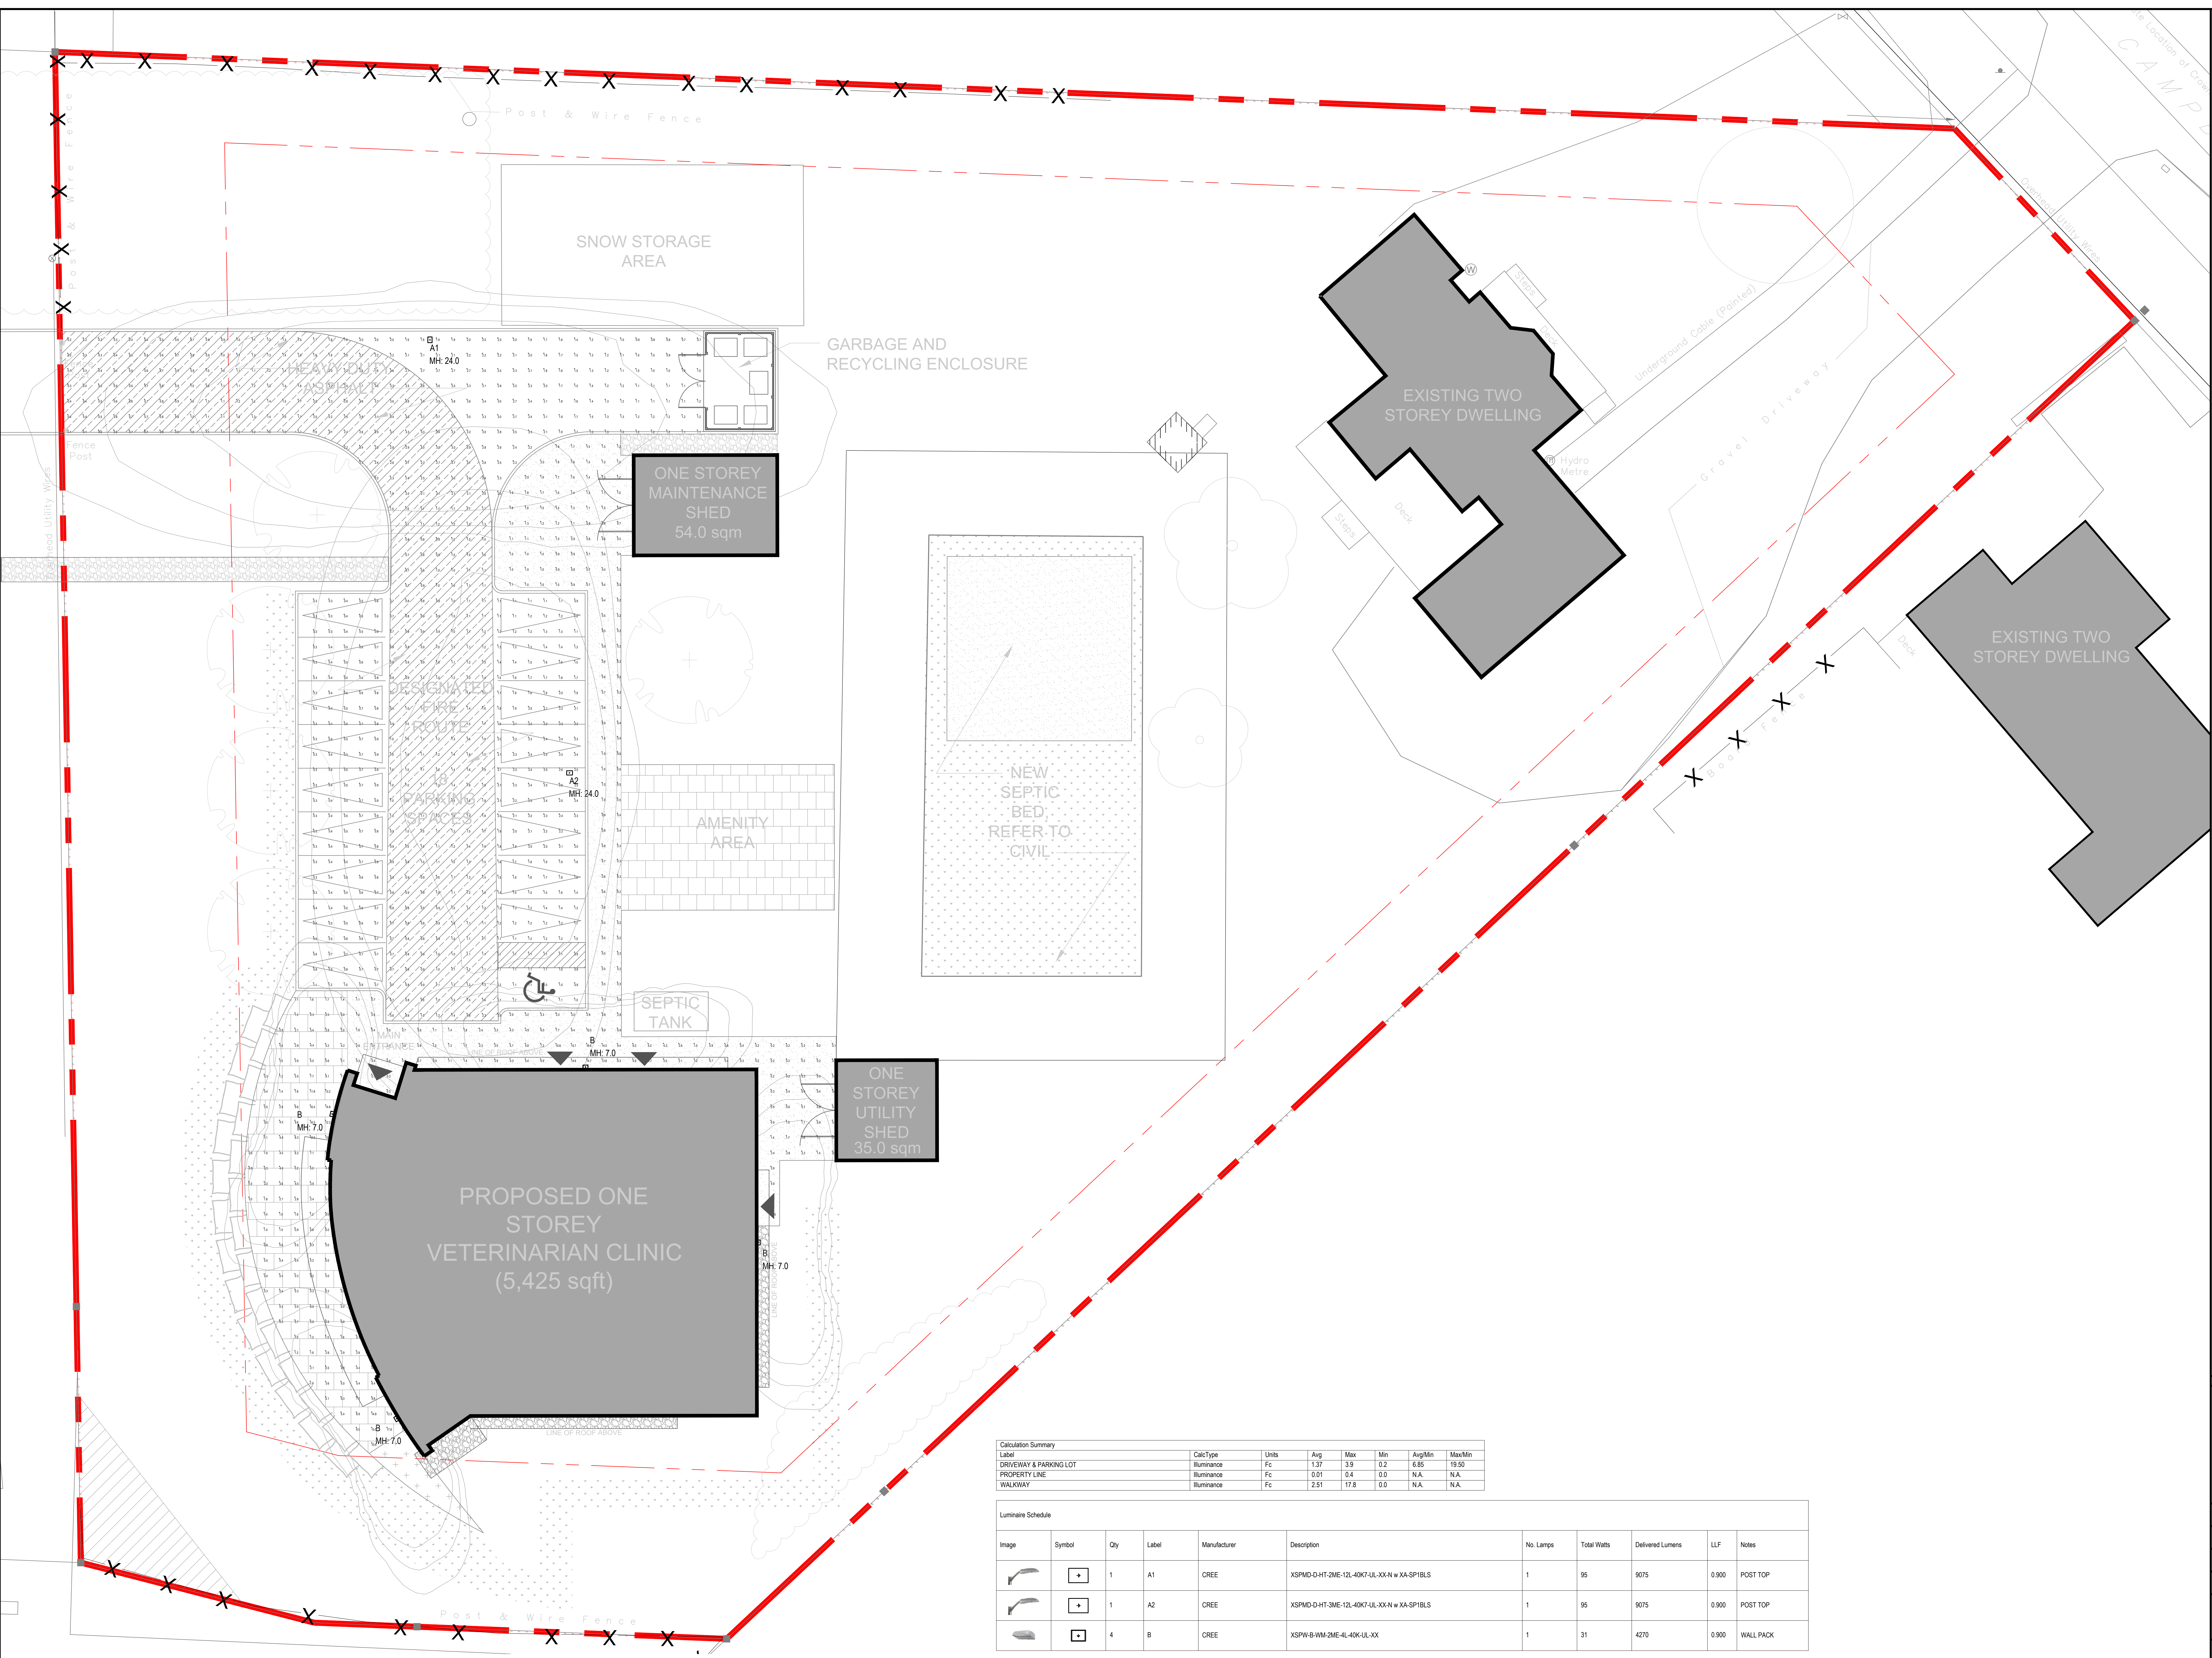

Calculation Summary

Label	Calc Type	Units	Avg	Max	Min	Avg/Min	Max/Min
DRIVEWAY & PARKING LOT	Illuminance	Fc	1.37	3.9	0.2	6.85	19.50
PROPERTY LINE	Illuminance	Fc	0.01	0.4	0.0	N.A.	N.A.
WALKWAY	Illuminance	Fc	2.51	17.6	0.0	N.A.	N.A.

Luminaire Schedule

Image	Symbol	Qty	Label	Manufacturer	Description	No. Lamps	Total Watts	Delivered Lumens	LLF	Notes
	+	1	A1	CREE	XSPMD-HT-2ME-12L-40K-UL-XX-N w XX-SP18LS	1	95	9075	0.900	POST TOP
	+	1	A2	CREE	XSPMD-HT-3ME-12L-40K-UL-XX-N w XX-SP18LS	1	95	9075	0.900	POST TOP
	+	4	B	CREE	XSPW-B-WM-2ME-4L-40K-UL-XX	1	31	4270	0.900	WALL PACK

① POINT BY POINT PHOTOMETRIC CALCULATION
L-02 SCALE: 1:120

② SCHEDULE AND CALCULATION SUMMARY
L-02 SCALE: NTS

2	ISSUED FOR SITE PLAN APPLICATION	SEPT 13, 23
1	ISSUED FOR REVIEW	
REV	DESCRIPTION	DATE
STAMP		



Project Name: 4 CAMPBELL REID COURT
Drawing Name: PHOTOMETRIC SUMMARY

Scale: AS SHOWN	Drawn by: E CARMICHAEL
Date: 2023.06.19	Checked by:
Project Number: 23080	Drawing Number: PP-02

Lighting • Controls • Shades
FUX
Control the Experience