

LEGEND



- PROPERTY LINE
- PROPOSED CURB
- PROPOSED DEPRESSED CURB
- PROPOSED FLUSH CURB
- PROPOSED RETAINING WALL CW GUARD RAIL
- PROPOSED WALKWAY
- TACTILE WALKING SURFACE INDICATOR (TWS) PER CITY DETAIL S.C7.3
- PROPOSED CAP
- PROPOSED SANITARY SERVICE c/w MANHOLE
- PROPOSED STORM SEWER AND MANHOLE
- PROPOSED CATCHBASIN MANHOLE
- PROPOSED CATCHBASIN
- PROPOSED LANDSCAPE DRAIN
- PROPOSED AREA DRAIN
- PROPOSED TRENCH DRAIN
- PROPOSED INLET CONTROL DEVICE
- PROPOSED SIAMESE CONNECTION
- PROPOSED WATER SERVICE

- PROPOSED HYDRANT c/w LEAD & VALVE
- PROPOSED VALVE AND VALVE BOX
- PROPOSED WATER METER
- PROPOSED REMOTE WATER METER
- PROPOSED BUILDING ENTRANCE
- DIRECTION OF FLOW
- BOREHOLE LOCATION (REFER TO GEOTECH REPORT)
- EXISTING UTILITY POLE c/w GUY WIRES
- EXISTING WATERMAIN c/w VALVE & VALVE CHAMBER
- EXISTING HYDRANT c/w VALVE & LEAD
- EXISTING SANITARY MANHOLE & SEWER
- EXISTING STORM MANHOLE & SEWER
- EXISTING CATCHBASIN
- EXISTING GAS MAIN
- EXISTING HYDRO LINE
- EXISTING BELL LINE

- EXISTING TELECOMMUNICATIONS LINE
- EXISTING TRAFFIC LINE
- EXISTING HYDRANT
- EXISTING STREETLIGHT LINE
- EXISTING ROGERS LINE
- EXISTING STREETLIGHT
- EXISTING PARKING LOT SIGNAGE

NOTE:

- ALL SERVICE CONNECTIONS AND CATCHBASIN CONNECTIONS TO BE MADE PER CITY OF OTTAWA DETAIL S11 AND S11.2
- BACKWATER VALVES TO BE PROVIDED ON ALL STORM AND SANITARY LATERALS AS PER CITY OF OTTAWA DETAILS S14, S14.1, AND S14.2. DOWNSTREAM OF ANY GRAVITY OUTLET FROM THE BUILDING. REFER TO MECHANICAL PLANS FOR DETAIL.
- ALL FLOWS FROM THE UNDERGROUND PARKING GARAGE ARE TO BE PUMPED TO THE PROPOSED SANITARY SERVICE (TYP)
- PROPOSED SERVICES TO BE SLEEVED THROUGH FOUNDATION WALL. FOUNDATION DRAINS TO BE PUMPED TO STORM SERVICE. REFER TO MECHANICAL DRAWINGS FOR FURTHER DETAILS ON INTERNAL PLUMBING (TYP).
- PROPOSED AREA DRAINS ARE TO BE CONVEYED TO THE PROPOSED CISTERN VIA THE INTERNAL PLUMBING. REFER TO THE MECHANICAL DRAWINGS FOR DETAILS.

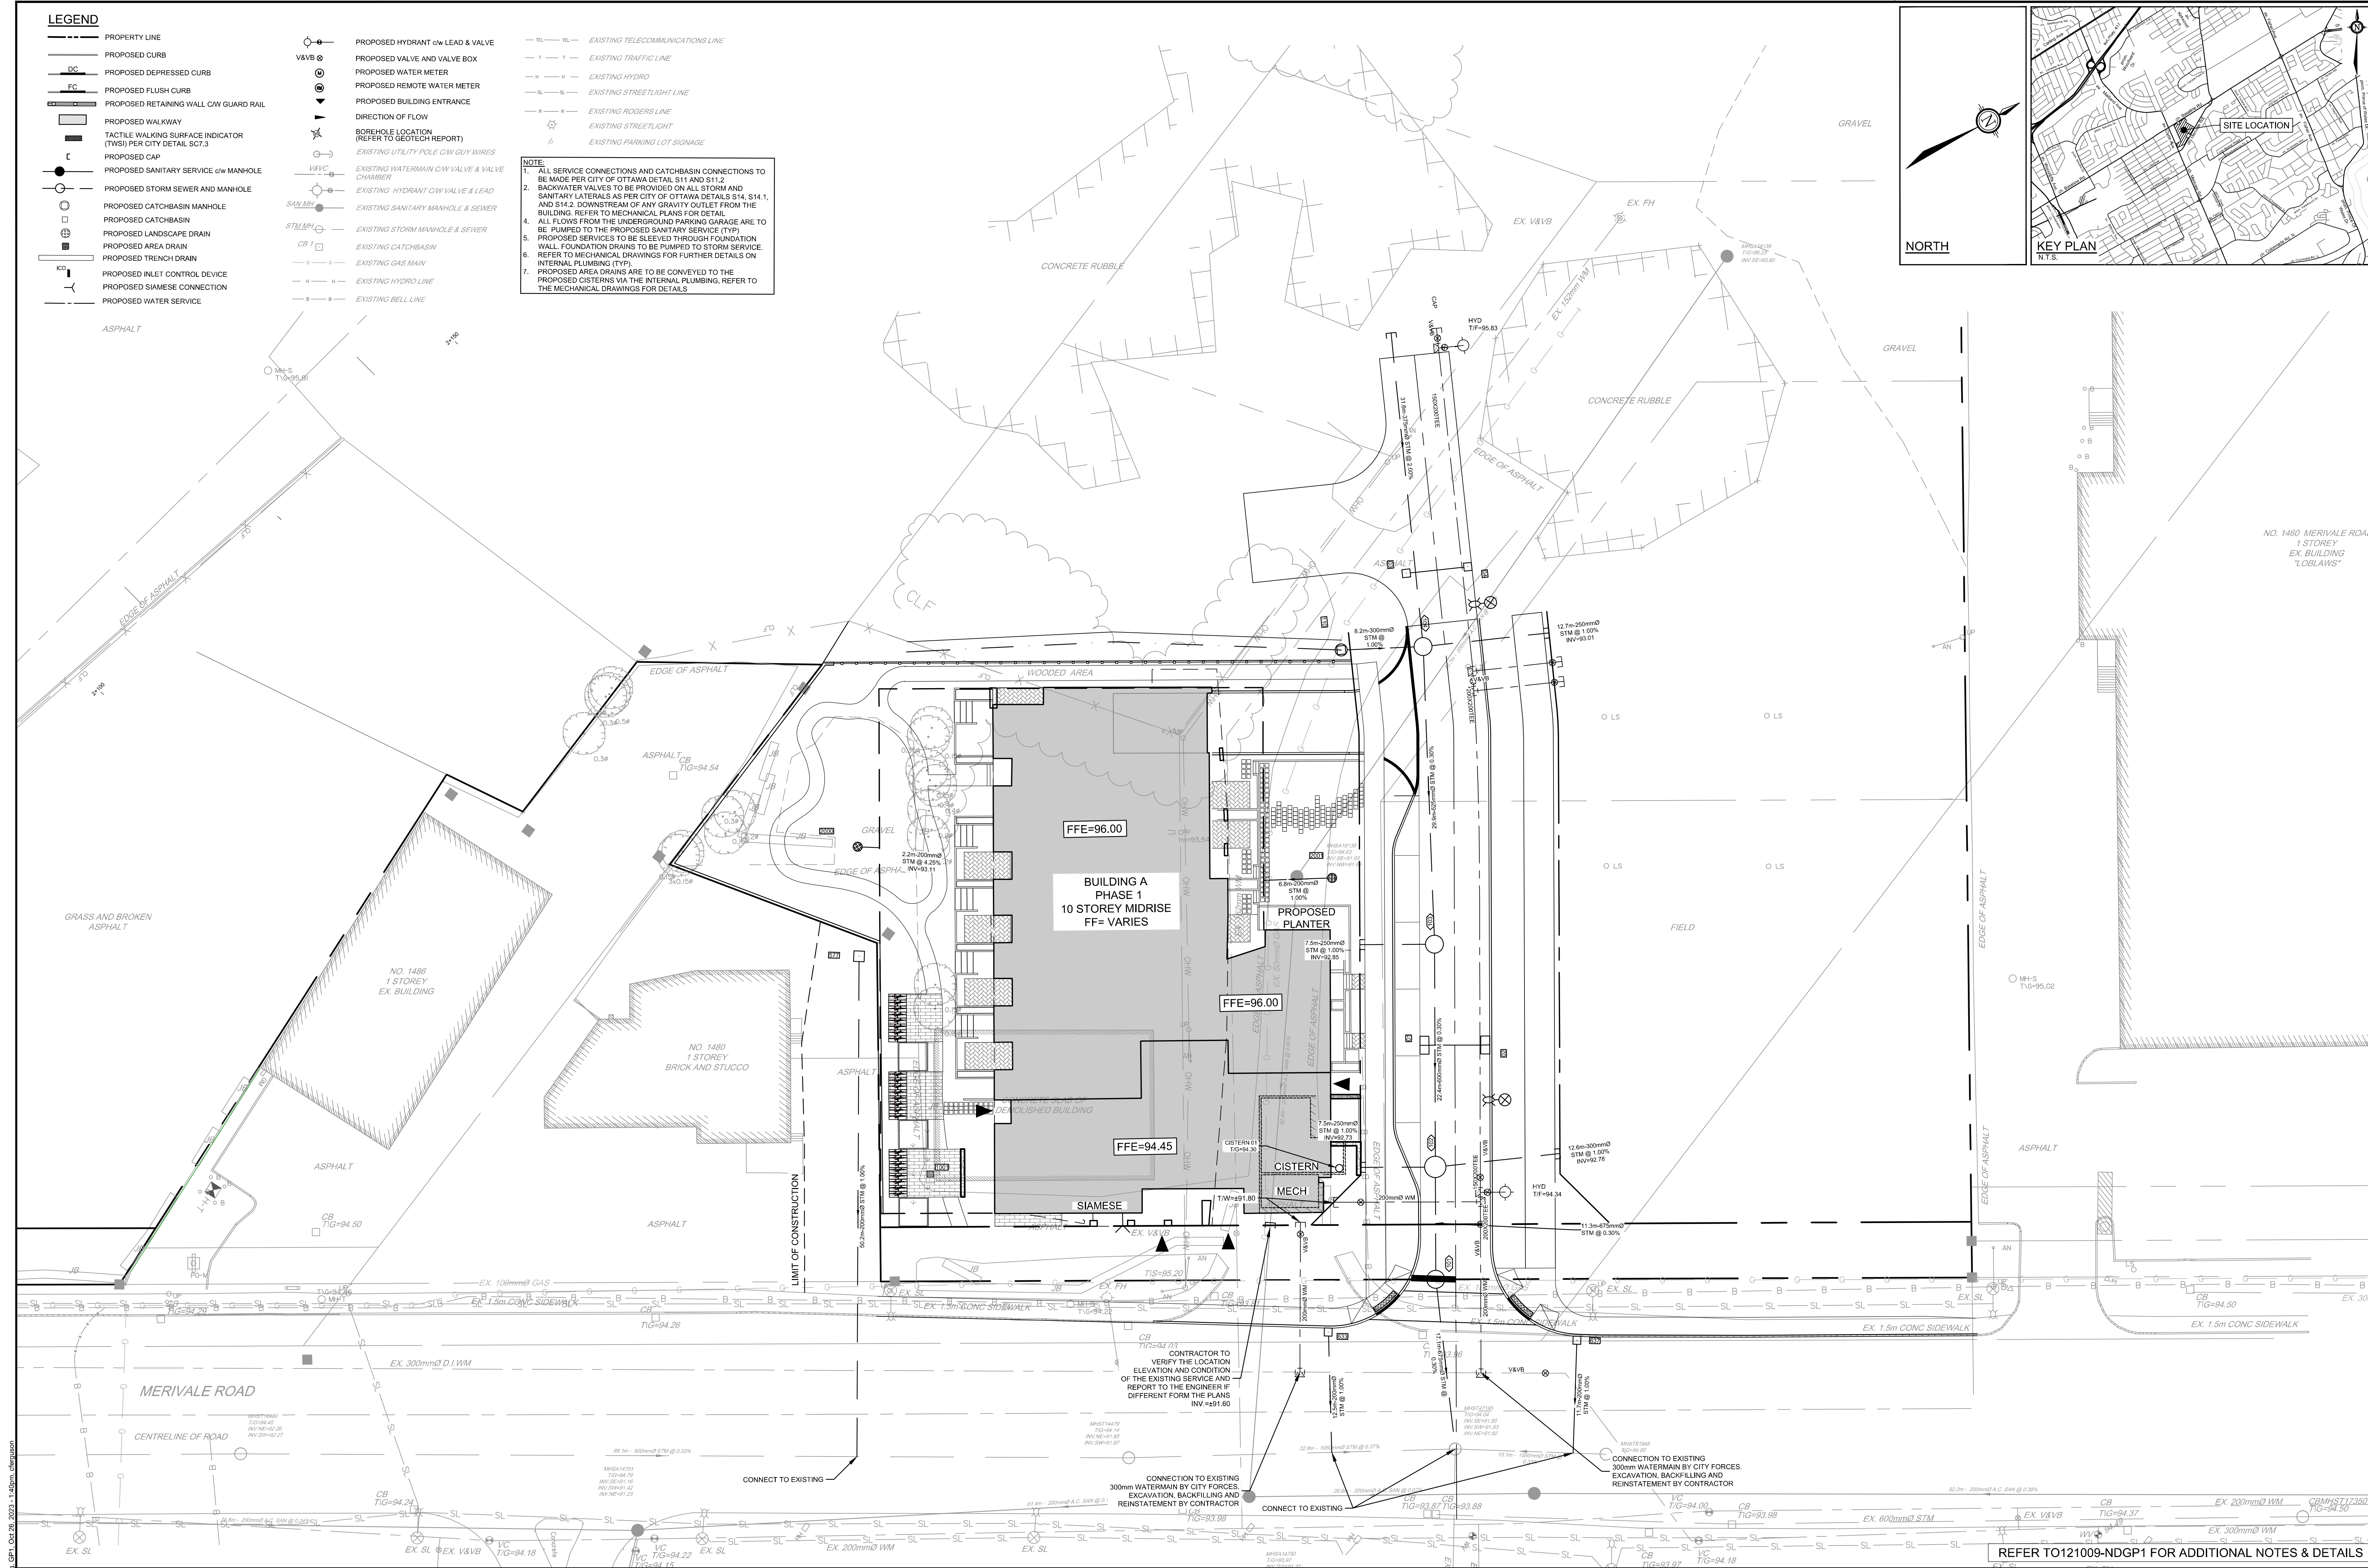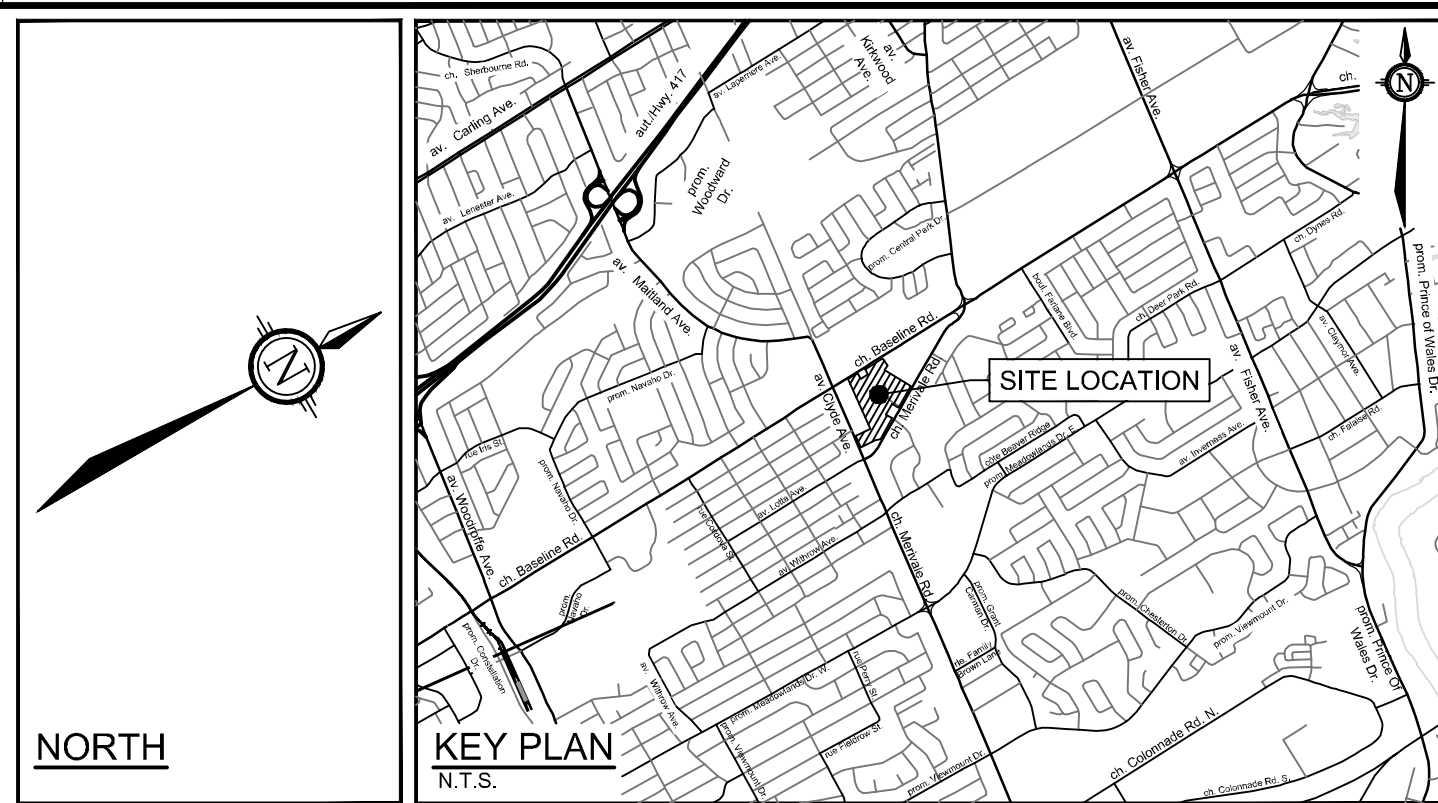


NOTE:
THE POSITION OF ALL POLE LINES, CONDUITS, WATERMANS, SEWERS AND OTHER UNDERGROUND AND OVERGROUND UTILITIES AND STRUCTURES IS NOT NECESSARILY SHOWN ON THE CONTRACT DRAWINGS, AND WHERE SHOWN, THE ACCURACY OF THE POSITION OF SUCH UTILITIES AND STRUCTURES IS NOT GUARANTEED. BEFORE STARTING WORK, DETERMINE THE EXACT LOCATION OF ALL SUCH UTILITIES AND STRUCTURES AND ASSUME ALL LIABILITY FOR DAMAGE TO THEM.

CLARIDGE HOMES
CLARIDGE HOMES
505 PRESTON STREET,
2ND FLOOR
OTTAWA, ONTARIO
K1S 4N7




NOT FOR CONSTRUCTION

No.	REVISION	DATE	BY
3.	ISSUED PHASE 1 ONLY	OCT 27/2023	GJM
2.	REVISED AND ISSUED FOR CITY APPROVAL	DEC 09/2022	GJM
1.	ISSUED WITH SITE PLAN APPLICATION	SEPT 03/2021	JAG

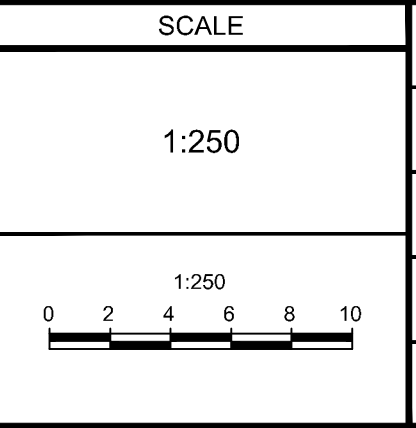

ARM
GJM
C.J.F./ARM
ARM
GJM

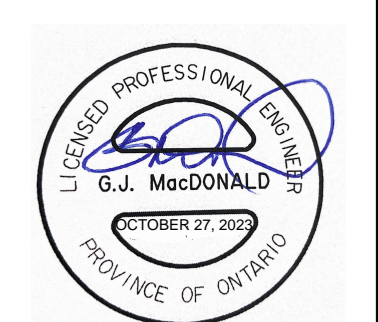

NOVATECH
Engineers, Planners & Landscape Architects
Suite 200, 240 Michael Cowland Drive
Ottawa, Ontario, Canada K2M 1P6
Telephone: (613) 254-9643
Facsimile: (613) 254-5867
Website: www.novatech-eng.com

LOCATION
1500 MERIVALE
1500 MERIVALE, CITY OF OTTAWA

DRAWING NAME
GENERAL PLAN OF SERVICES (PHASE 1)

PROJECT NO.: 121009
REV: REV#3
DRAWING NO.: 121009-GP1

CITY PLAN No. 18612

REFER TO 121009-NDGP1 FOR ADDITIONAL NOTES & DETAILS