


PUMP SPECIFICATIONS


P1 & P2: 15 L/S @ 7.6M HEAD; EQUAL TO ZOELLER MODEL 641, 3 HP, 208V, 3 PHASE

P3 & P4: 10 L/S @ 7.6M HEAD; EQUAL TO ZOELLER MODEL 631, 2 HP, 208V, 3 PHASE

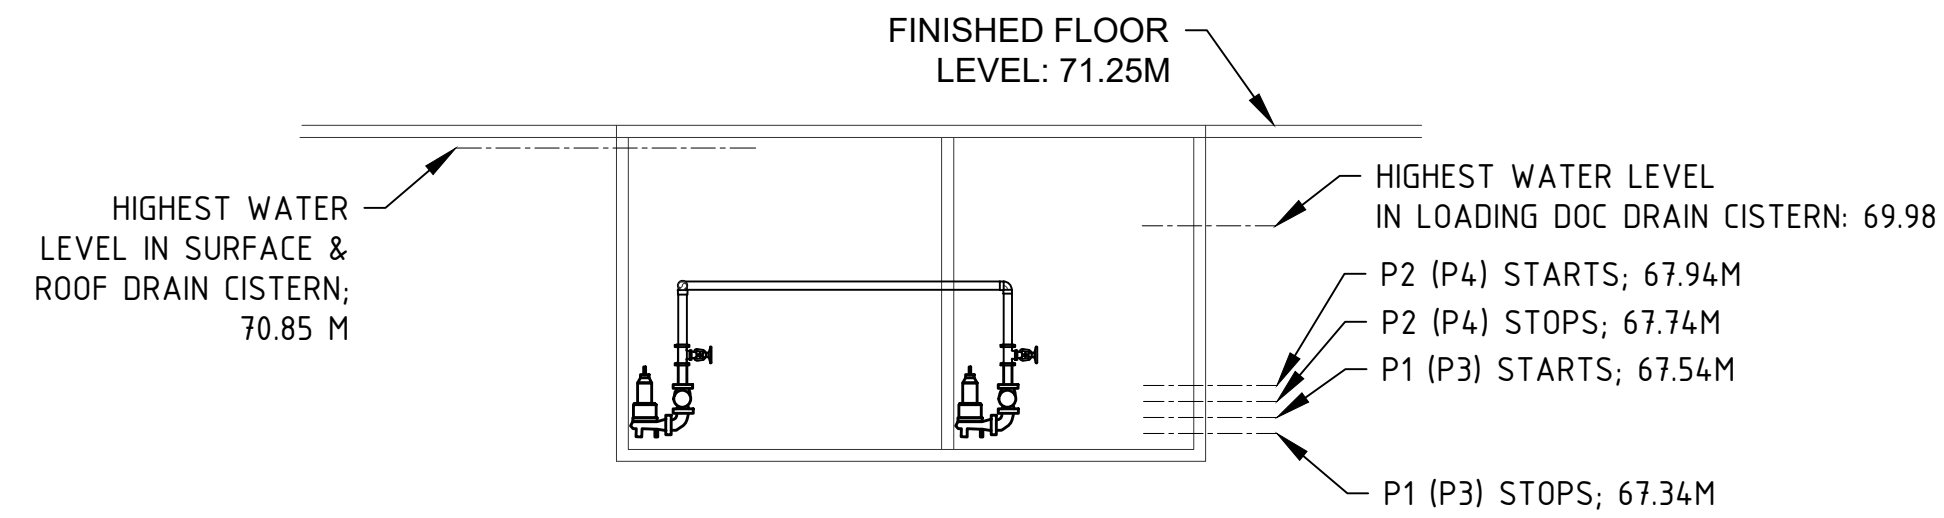


SECTION THROUGH A-A

SC: 1:100

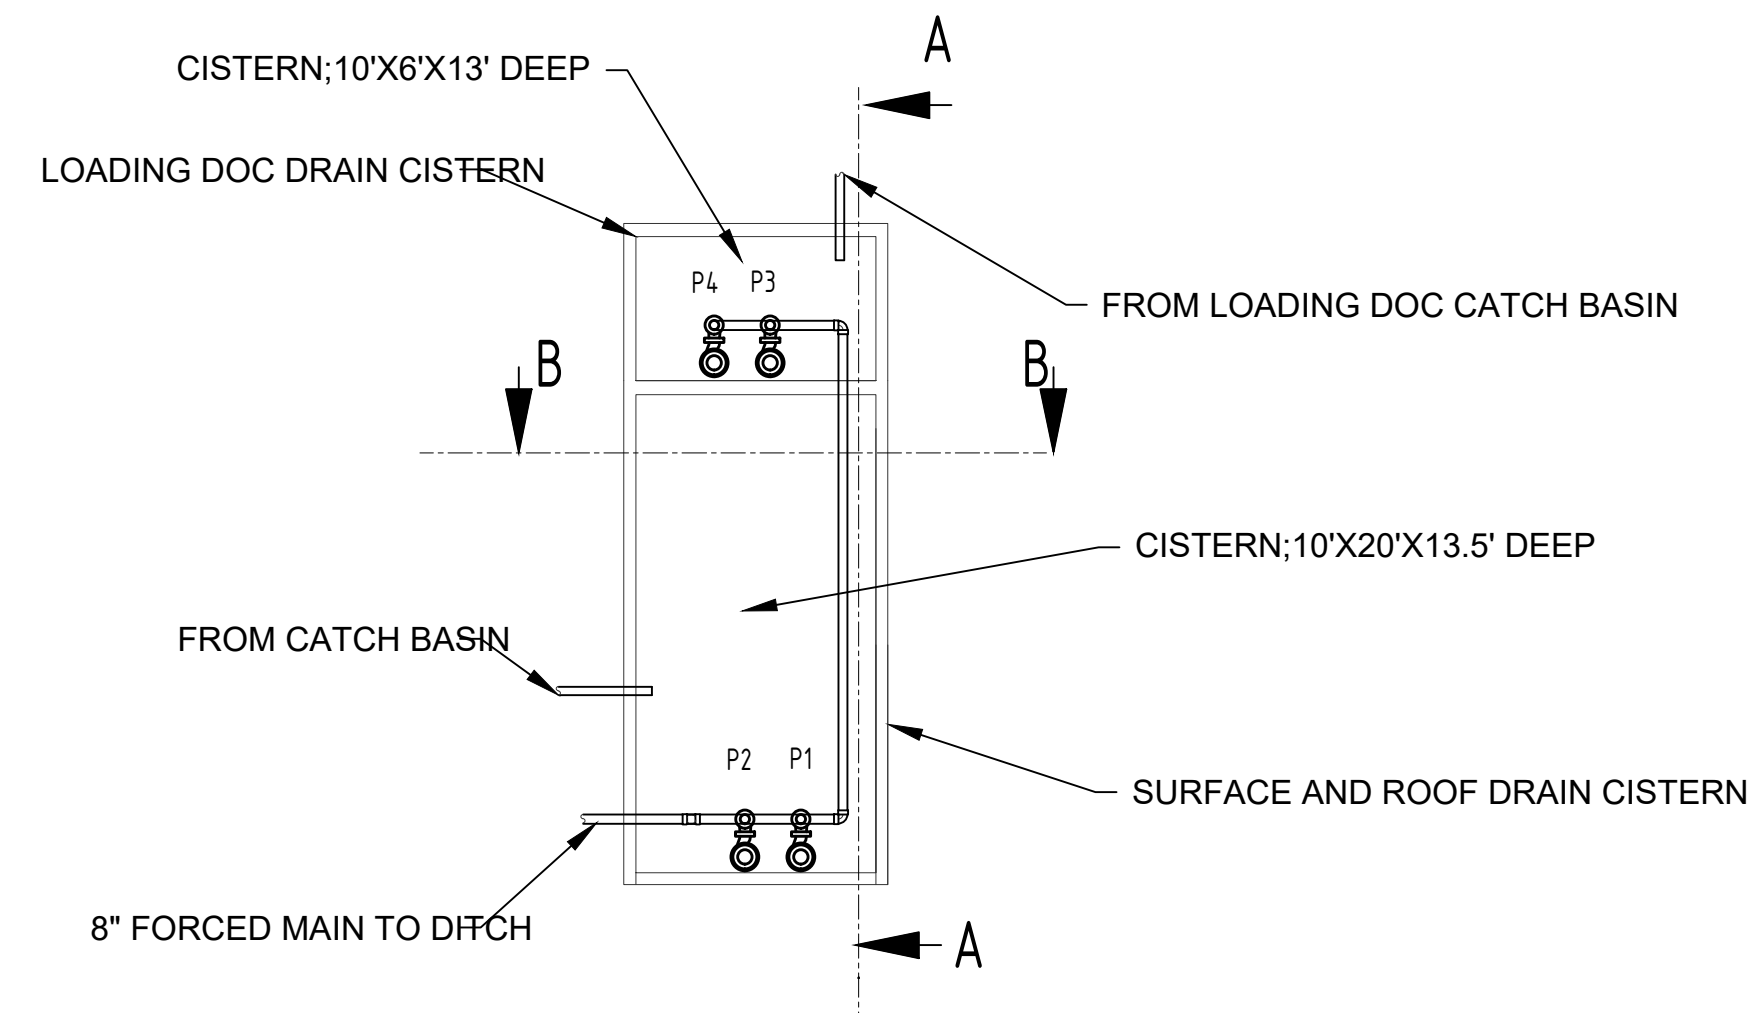

PLAN VIEW OF SURFACE & RAIN DRAIN CISTERN AND LOADING DOC DRAIN CISTERN


SC: 1:100

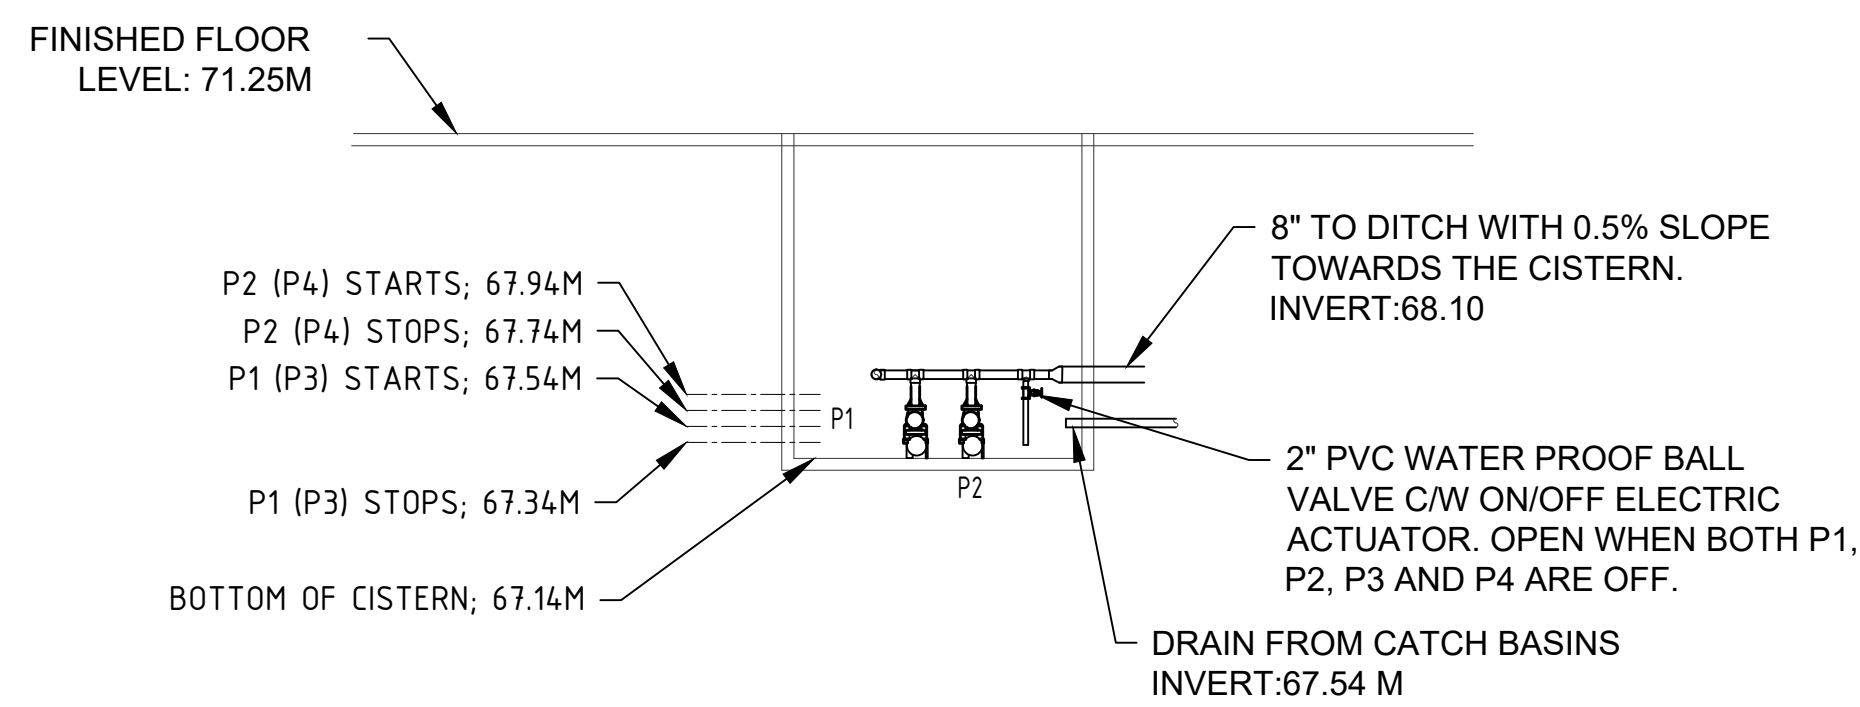

SECTION THROUGH B-B

SC: 1:100

| ISSUE | DESCRIPTION | CHECKED | DATE |
|-------|-------------------------------|---------|------------|
| 1 | COORDINATION | FH | 2023-01-19 |
| 2 | ISSUED FOR SITE PLAN APPROVAL | MY | 2023-10-13 |
| | | | |
| | | | |
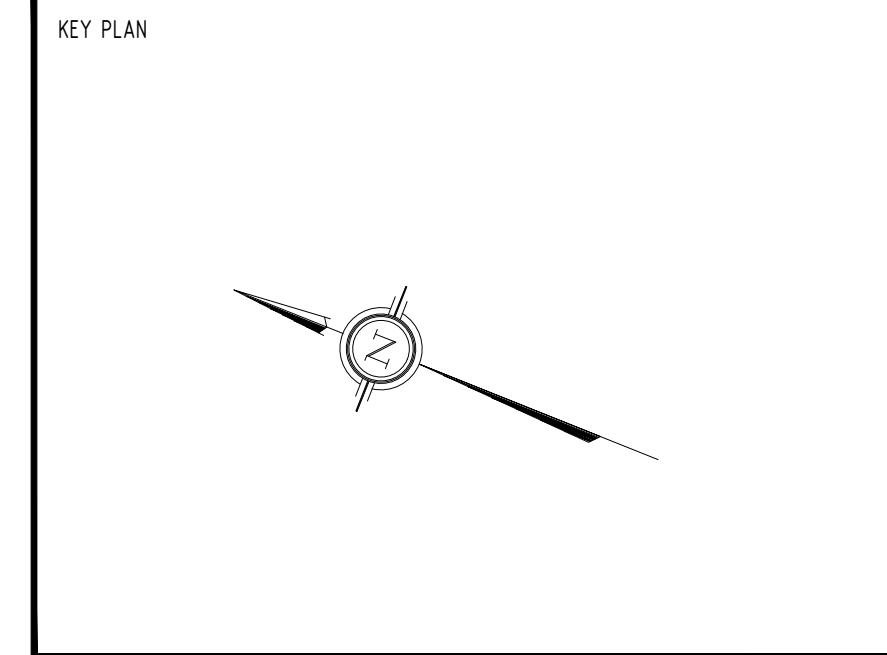

DRAWINGS ARE TO BE READ AS A PACKAGE AND ARE NOT INTENDED TO BE SEPARATED AND VIEWED INDIVIDUALLY BY DISCIPLINE.

| | |
|--------------|---------------------|
| DESIGNED BY: | FH |
| DRAWN BY: | FH |
| CHECKED BY: | |
| CLIENT: | NICHOLAS CARAGIANIS |

PROJECT:
MICHAEL STREET
1591 & 1611 MICHAEL ST., OTTAWA, ON, K1B 3T3

DRAWING TITLE:
**CISTERN DETAILS
PLUMBING**

| | |
|--------------|--------|
| SCALE: | 1:100 |
| SHEET NO.: | 1 OF 1 |
| PROJECT NO.: | 22017 |
| M1 | |