

LOT 26

CONCESSION 2

(OTTAWA FRONT)

(GLOUCESTER)

PART 1 PLAN SR - 481
pin 04263 - 0221

PART 1 PLAN SR - 2141
pin 04263 - 0222

PART 2
PLAN SR-168

PART 6 PLAN SR-168

PART 2 PLAN SR - 481

PART 2 PLAN SR - 2141

pin 04263 - 0101

LOT 27

CONCESSION 2

(OTTAWA FRONT)


(GLOUCESTER)

PART 4 pin 04263 - 0425

PART 1 pin 04263 - 0455


PART 1 pin 04263 - 0457

pin 04263 - 0102

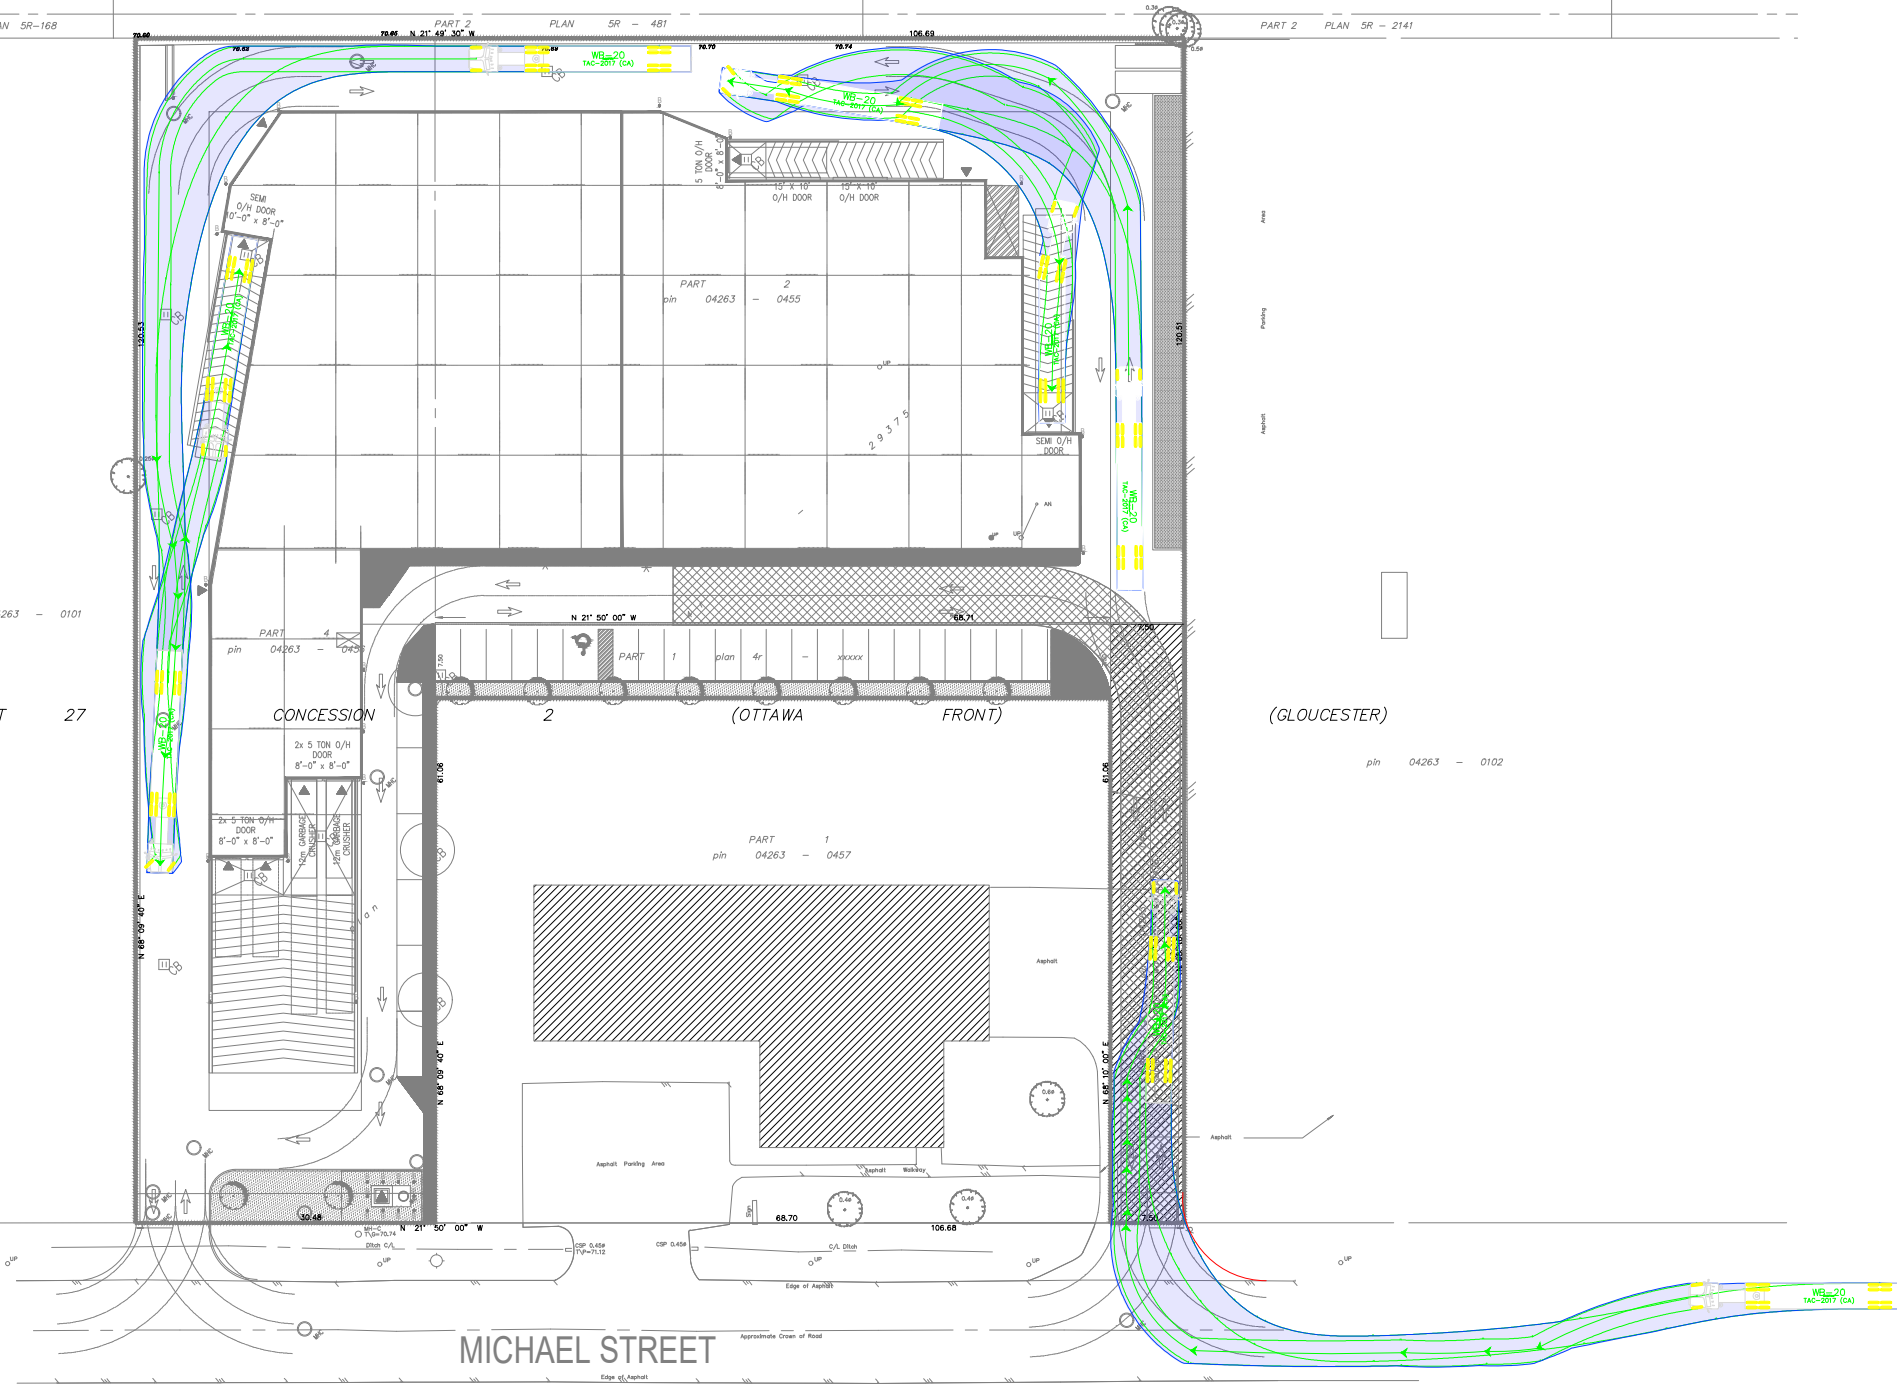

MICHAEL STREET

 
MICHAEL STREET (AS WIDENED BY BY-LAW 241-58, INST.Q.32524) (PLAN BA-2542)
pin 04263 - 0292



REFER TO ELECTRICAL SITE PLAN FOR LIGHTING, TRANSFORMER AND GENERATOR DETAILS
BOUNDARY INFORMATION FROM CAD SURVEY BY: ANNS, O'SULLIVAN, HOLLEBERG, LTD. - ONTARIO LAND SURVEYORS COMPLETED ON JULY 6, 2022

Plan #18942 007-12-23-0017

Notes:

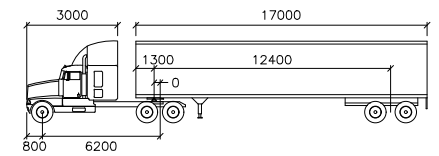

WB-20

mm	
Tractor Width	: 2600
Trailer Width	: 2600
Tractor Track	: 2600
Trailer Track	: 2600
Lock to Lock Time	: 6.0
Steering Angle	: 28.2
Articulating Angle	: 70.0

03	Issued for Review	MS	2023-12-12
02	Issued for Review	AN	2022-12-05
01	Issued for Review	BB	2023-12-12
REV:	DESCRIPTION:	BY:	DATE:
STATUS:			

CGH Transportation
6 Plaza Court
Ottawa, ON
K2H 7W1
(343) 999-9117

CLIENT: Roca Homes
424 George St W,
Ottawa, ON
K1S 3J2

ARCHITECT: Nicholas Caragianis Architect Inc.
137 Pamilla Street
Ottawa, ON
K1s 3K9

SITE: 1591 Michael Street			
TITLE: Turning Movement Analysis WB-20 In-Bound Movements			
SCALE AT A3: NTS	DATE: 2023-12-12	DRAWN: MS	CHECKED: MC
PROJECT NO: 2023-176	DRAWING NO: 001	REVISION: 03	

LOT 26

CONCESSION 2 (OTTAWA FRONT) (GLOUCESTER)

PART 1 PLAN SR - 481
pin 04263 - 0221

PART 1 PLAN SR - 2141
pin 04263 - 0222

PART 6 PLAN SR-168

PART 2 PLAN SR - 481

PART 2 PLAN SR - 2141

pin 04263 - 0101

LOT 27

CONCESSION 2 (OTTAWA FRONT) (GLOUCESTER)


PART 4

pin 04263 - 0455

PART 1


pin 04263 - 0457

pin 04263 - 0102

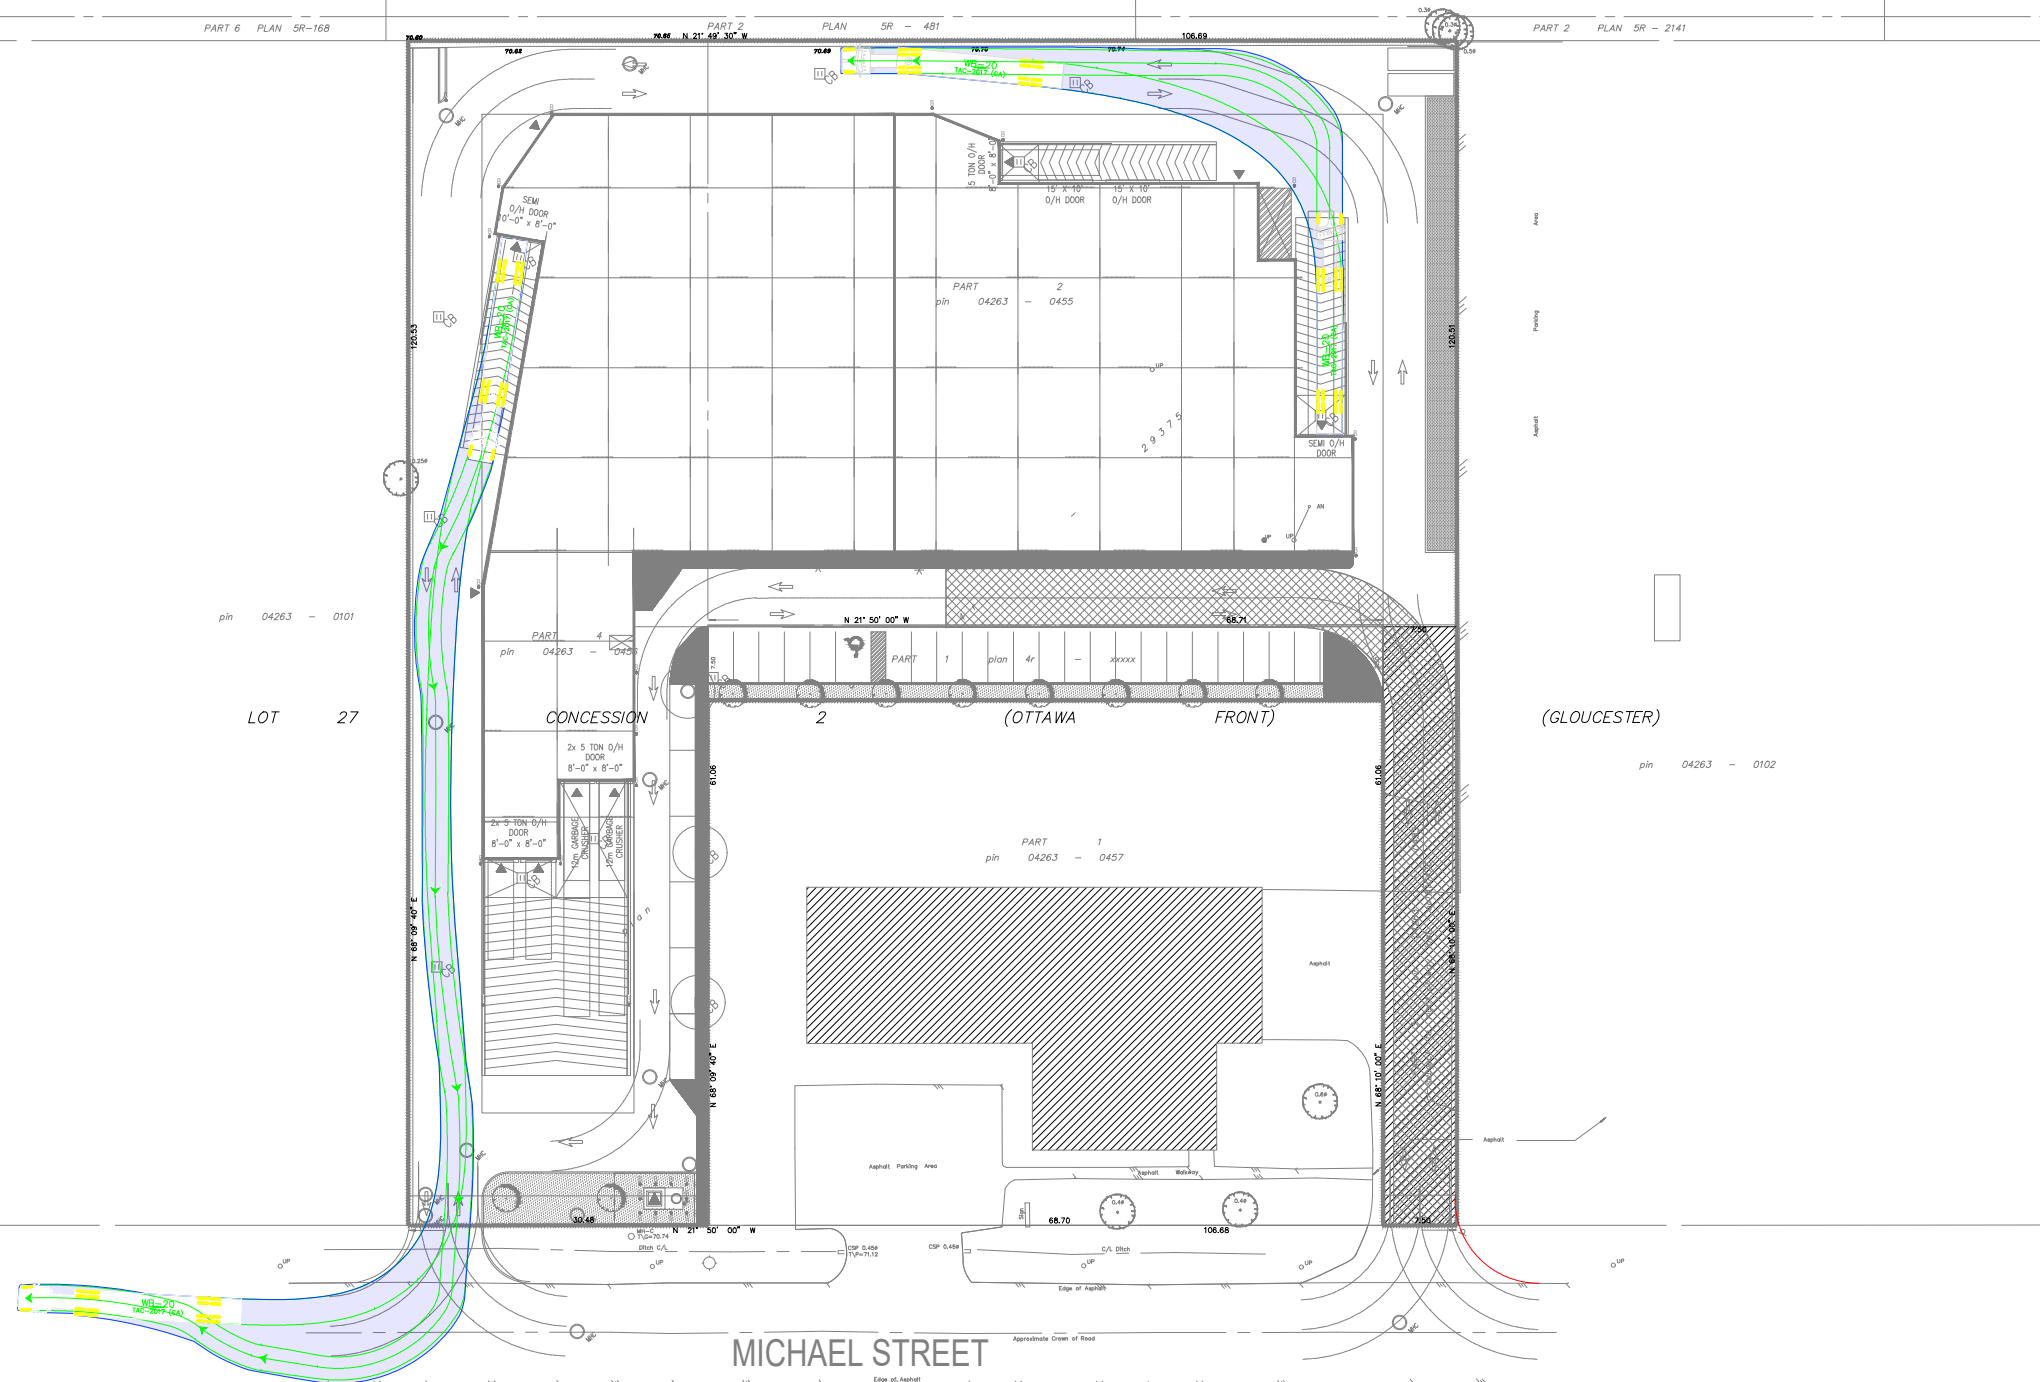


MICHAEL STREET

 MICHAEL STREET (AS WIDENED BY BY-LAW 241-58, INST.GL32524) (PLAN BA-2542)
pin 04263 - 0292



Plan #18942 007-12-23-0017

Notes:

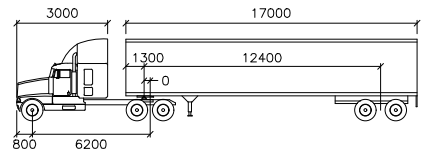

WB-20

mm			
Tractor Width	: 2600	Lock to Lock Time	: 6.0
Trailer Width	: 2600	Steering Angle	: 28.2
Tractor Track	: 2600	Articulating Angle	: 70.0
Trailer Track	: 2600		

03	Issued for Review	MS	2023-12-12
02	Issued for Review	AN	2022-12-05
01	Issued for Review	BB	2022-02-17
REV:	DESCRIPTION:	BY:	DATE:
STATUS:			

CGH Transportation
6 Plaza Court
Ottawa, ON
K2H 7W1
(343) 999-9117

CLIENT: Roca Homes
424 George St W,
Ottawa, ON
K1S 3J2


ARCHITECT: Nicholas Caragianis Architect Inc.
137 Pamilla Street
Ottawa, ON
K1s 3K9

SITE:
1591 Michael Street


TITLE: Turning Movement Analysis
WB-20 Out-Bound Movements

SCALE AT A3:	DATE:	DRAWN:	CHECKED:
NTS	2023-12-12	MS	MC
PROJECT NO:	DRAWING NO:	REVISION:	
2023-176	002	03	


**GARBAGE In-bound
WEST Garbage Crusher**

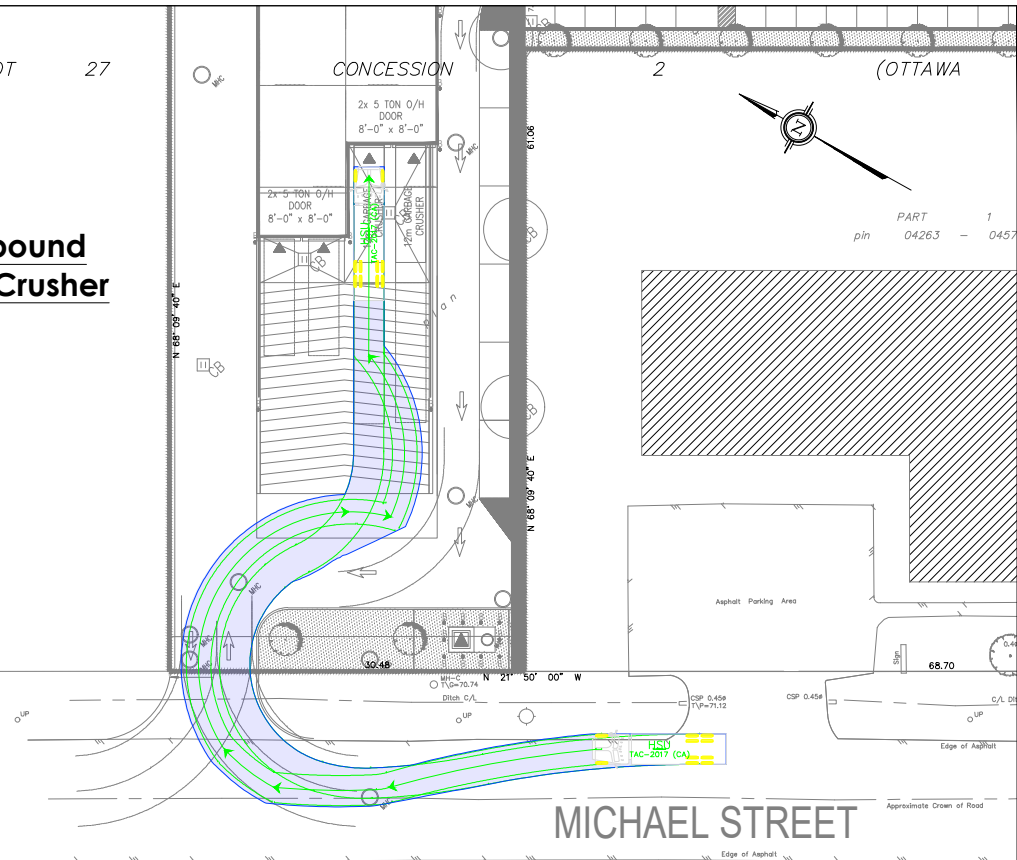


**GARBAGE Out-bound
WEST Garbage Crusher**

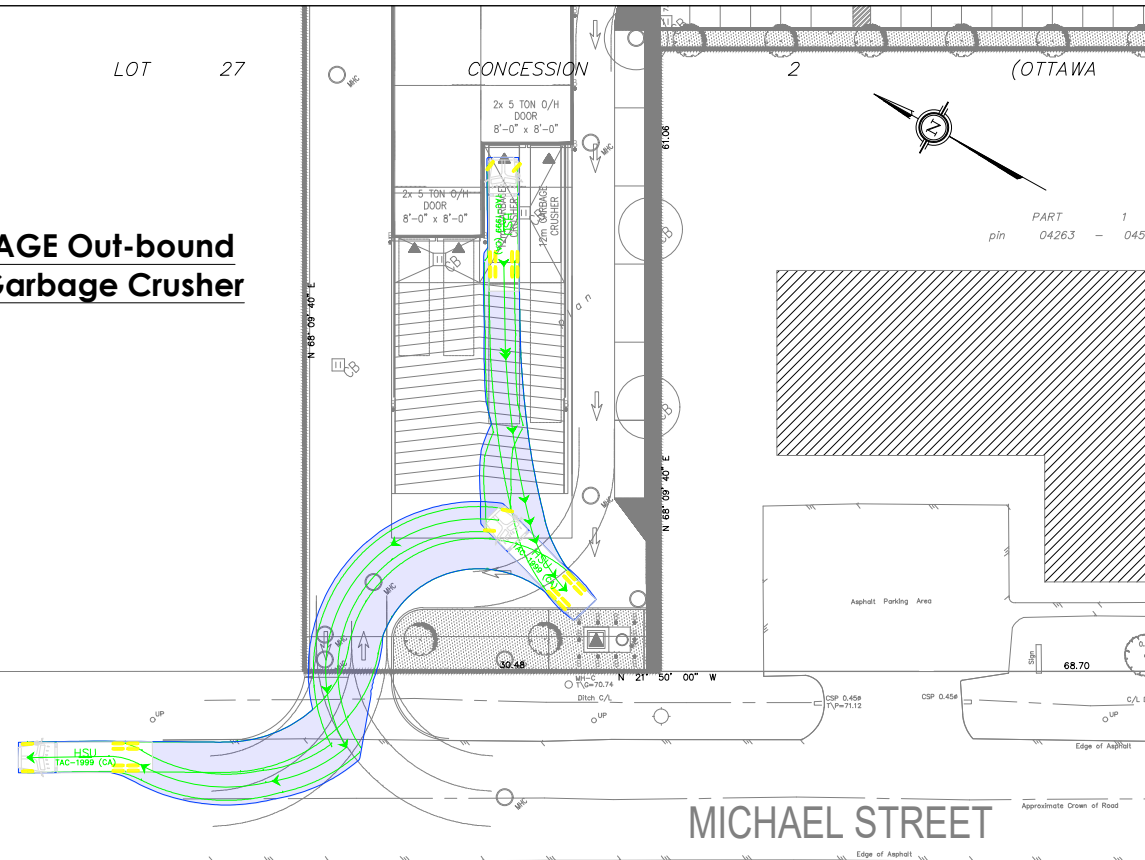



**GARBAGE In-bound
EAST Garbage Crusher**

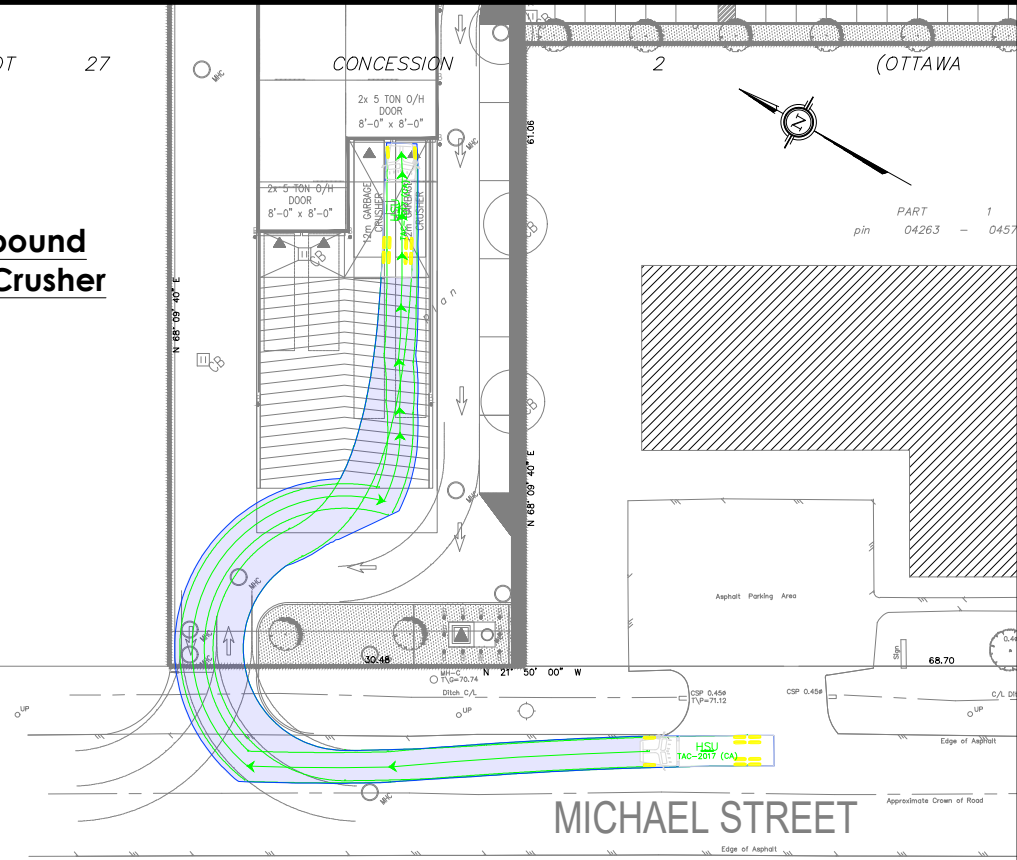

**GARBAGE Out-bound
EAST Garbage Crusher**

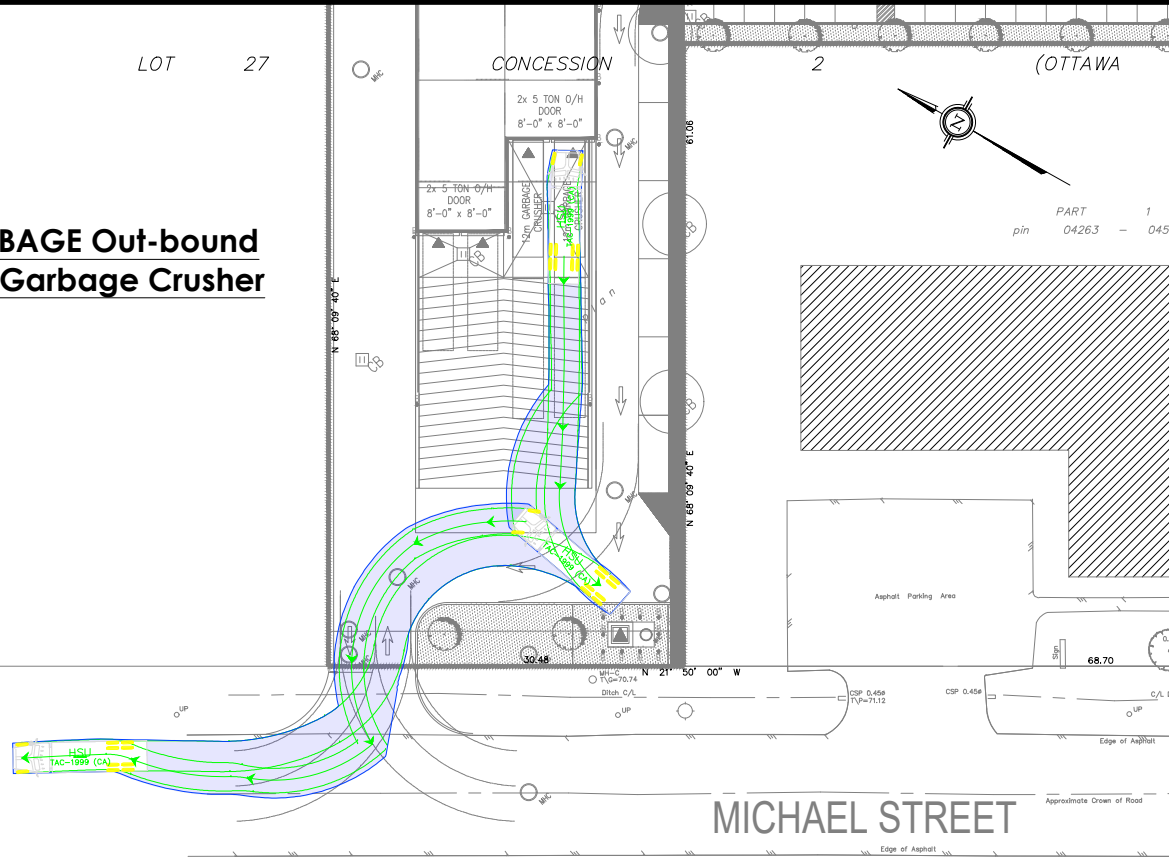

Notes:

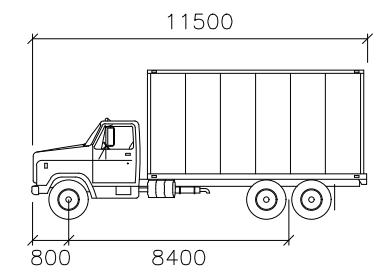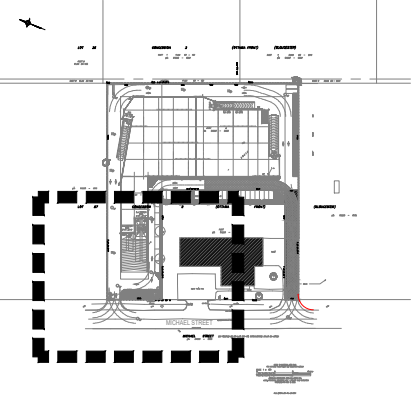

HSU

	mm
Width	: 2600
Track	: 2600
Lock to Lock Time	: 6.0
Steering Angle	: 40.0

03	Issued for Review	MS	2023-12-12
02	Issued for Review	AN	2022-12-05
01	Issued for Review	BB	2022-02-17
REV:	DESCRIPTION:	BY:	DATE:
STATUS:			

CGH Transportation
 6 Plaza Court
 Ottawa, ON
 K2H 7W1
 (343) 999-9117







CLIENT: Roca Homes
 424 George St W,
 Ottawa, ON
 K1S 3J2

ARCHITECT: Nicholas Caragianis Architect Inc.
 137 Pamilla Street
 Ottawa, ON
 K1S 3K9

SITE:
 1591 Michael Street

TITLE:
 Turning Movement Analysis
 GARBAGE Turning Movements

SCALE AT A3: NTS	DATE: 2023-12-12	DRAWN: MS	CHECKED: MC
PROJECT NO: 2023-176	DRAWING NO: 003	REVISION: 03	

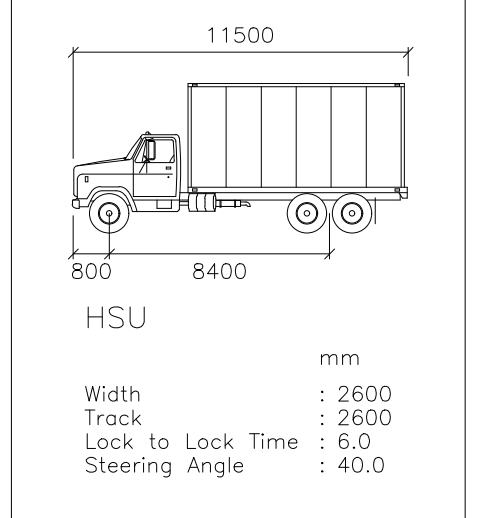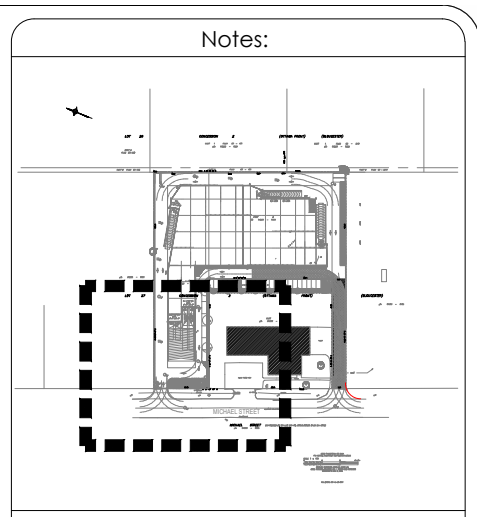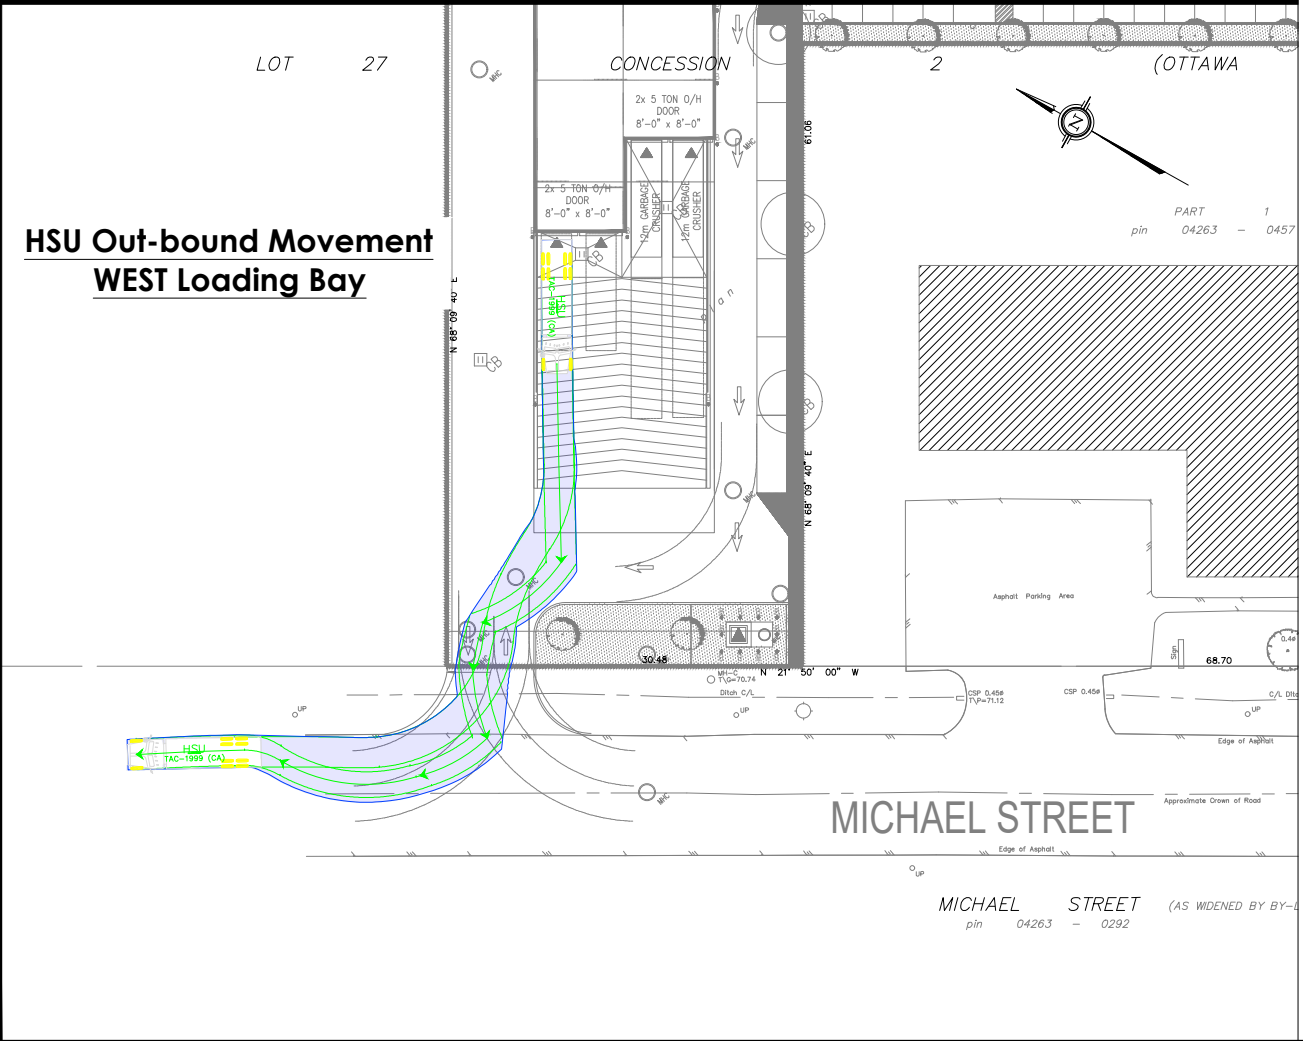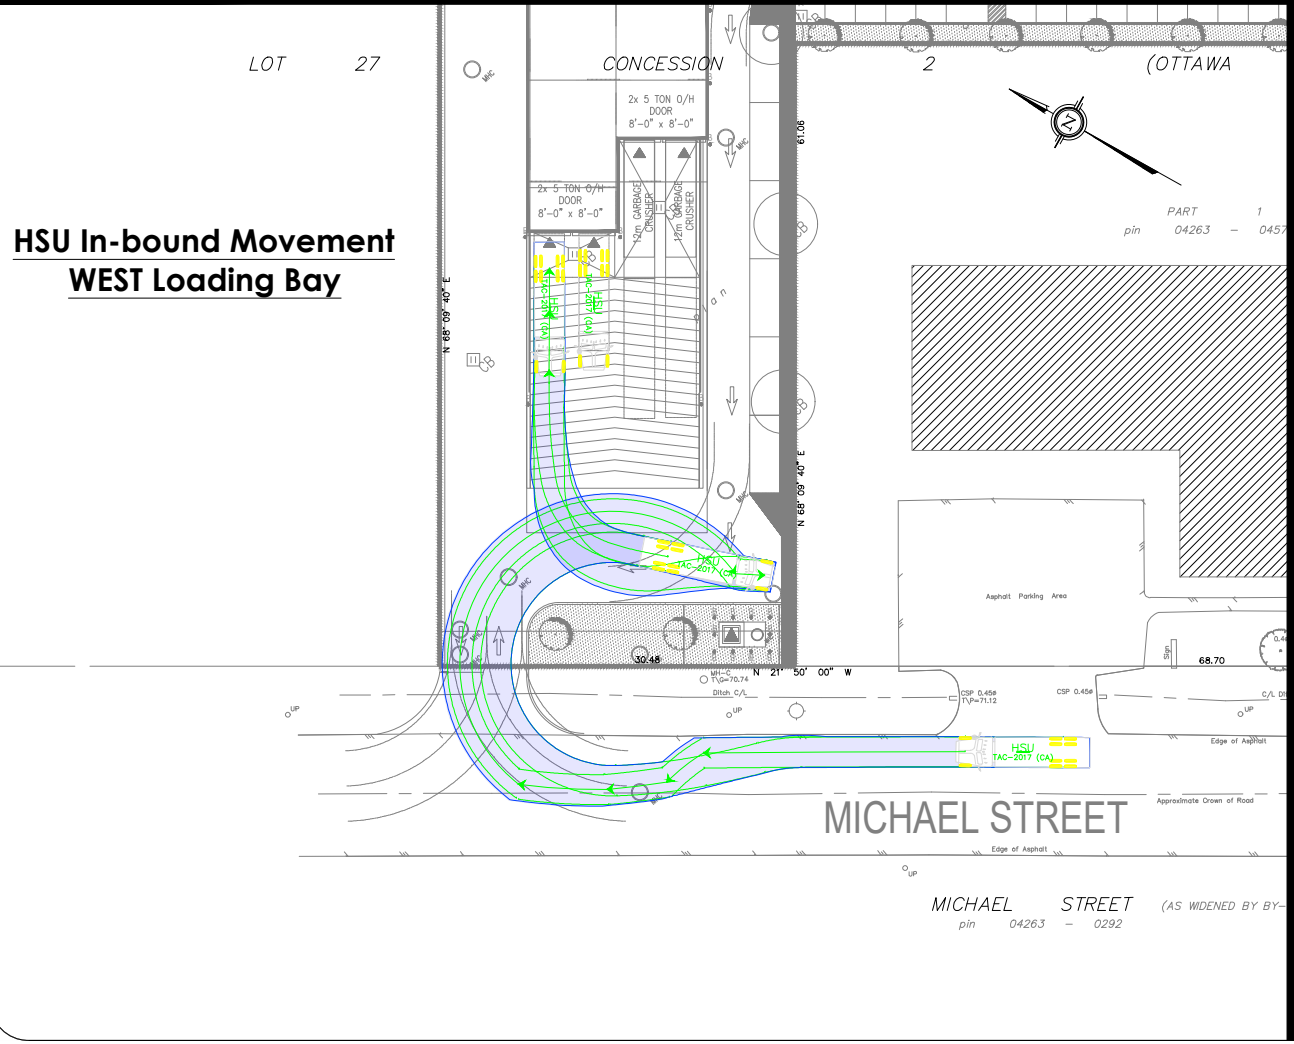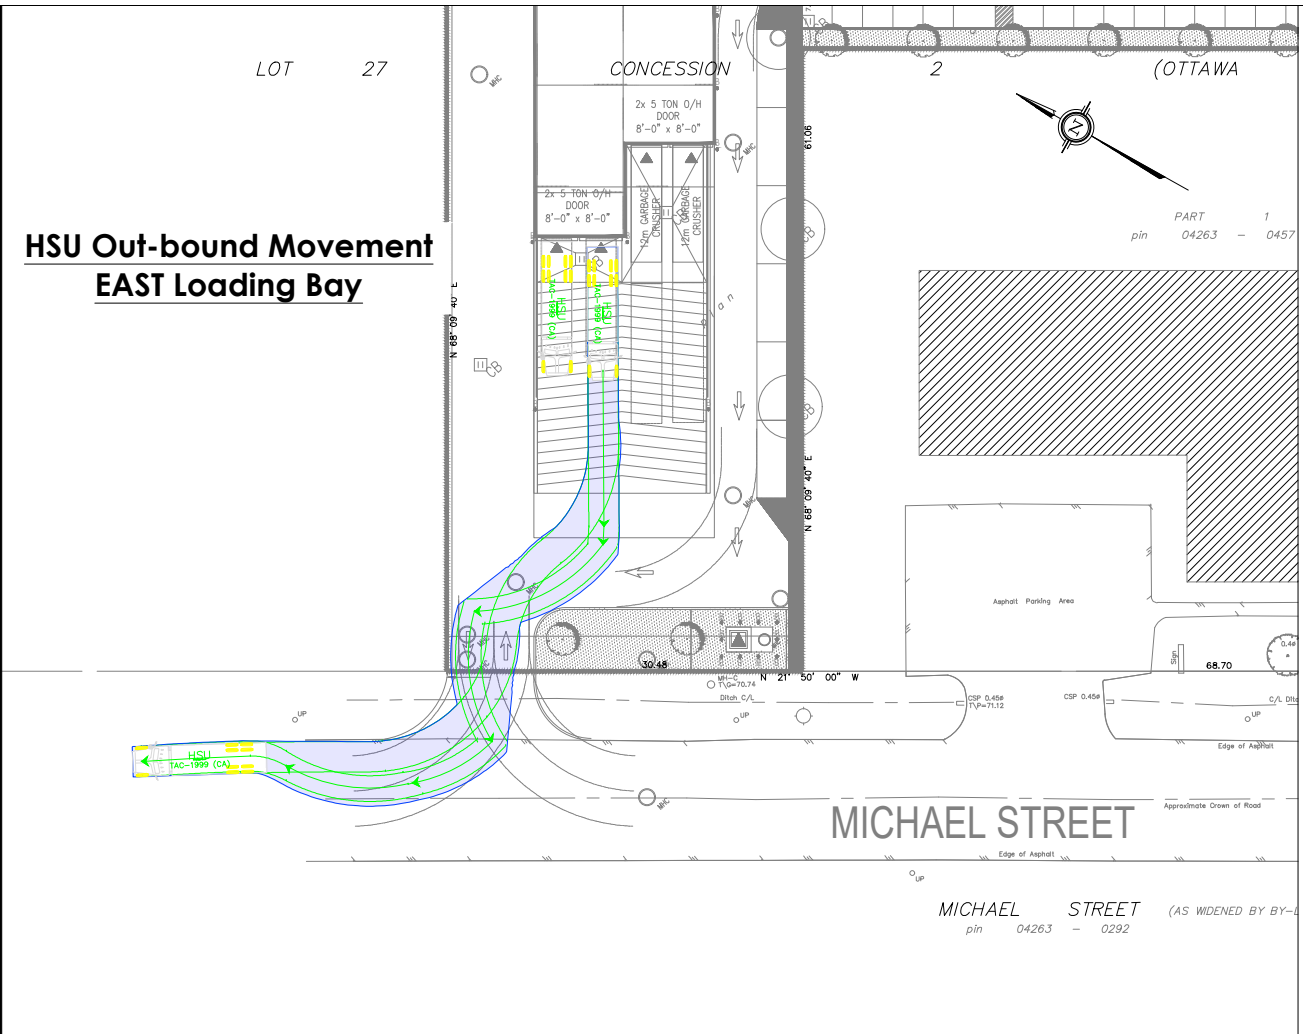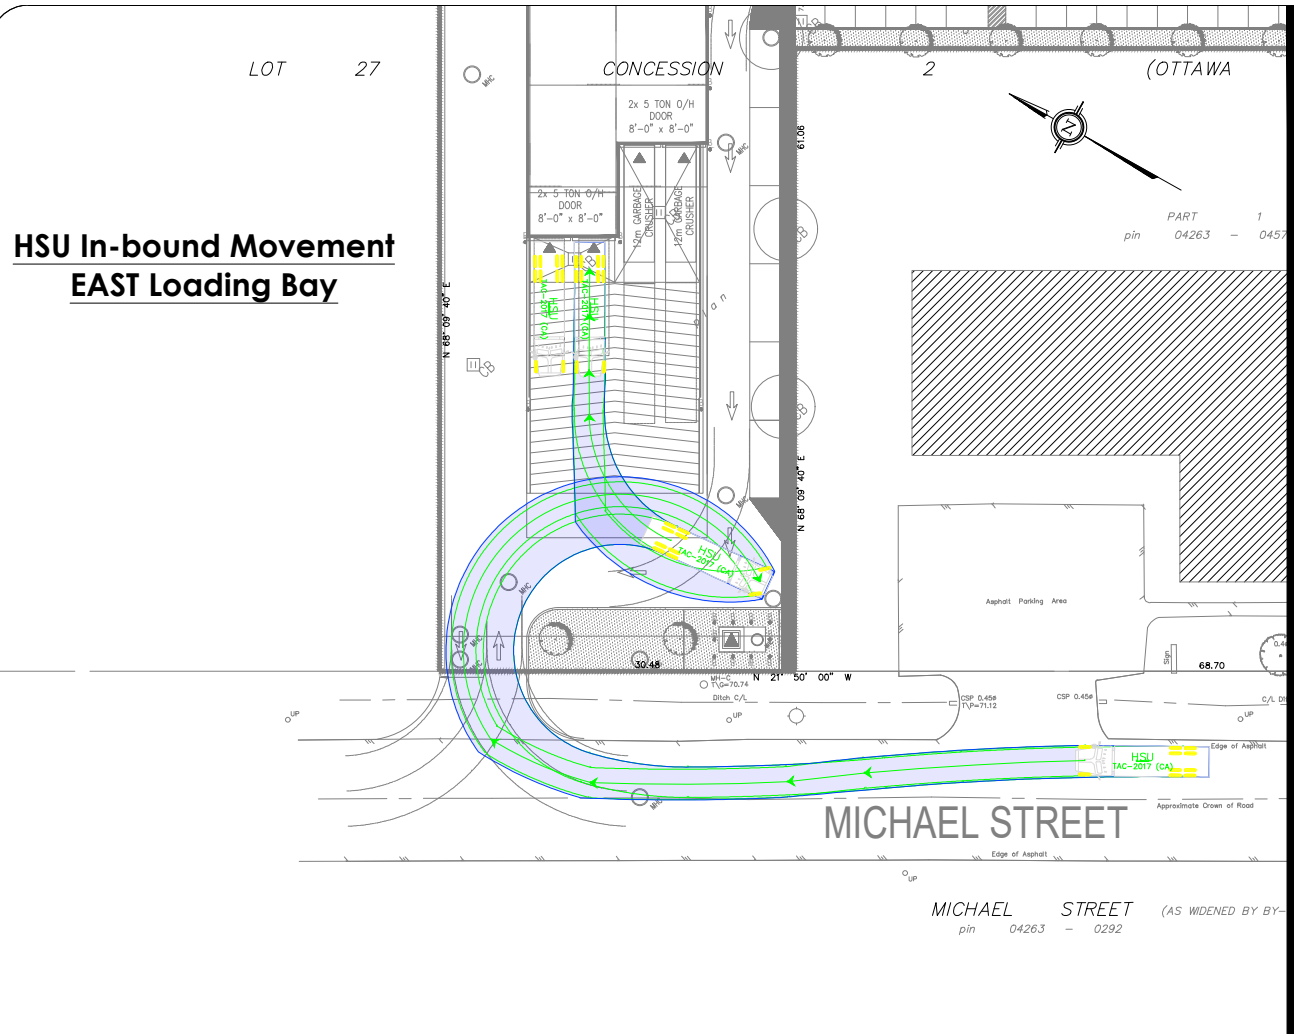

03	Issued for Review	MS	2023-12-12
02	Issued for Review	AN	2022-12-05
01	Issued for Review	BB	2022-02-17
REV:	DESCRIPTION:	BY:	DATE:
STATUS:			

CGH Transportation
6 Plaza Court
Ottawa, ON
K2H 7W1
(343) 999-9117

CLIENT: Roca Homes
424 George St W,
Ottawa, ON
K1S 3J2

ARCHITECT: Nicholas Caragianis Architect Inc.
137 Pamilla Street
Ottawa, ON
K1S 3K9

SITE: 1591 Michael Street

TITLE: Turning Movement Analysis
HSU Turning Movements (1)

SCALE AT A3:	DATE:	DRAWN:	CHECKED:
NTS	2023-12-12	MS	MC
PROJECT NO:	DRAWING NO:	REVISION:	
2023-176	004	03	

PART 2
PLAN 5R-168

pin 04263 - 0221

pin 04263 - 0222

PART 6 PLAN 5R-168


PART 2 PLAN 5R - 481

PART 2 PLAN 5R - 2141

pin 04263 - 0101

LOT 27


pin 04263 - 0102

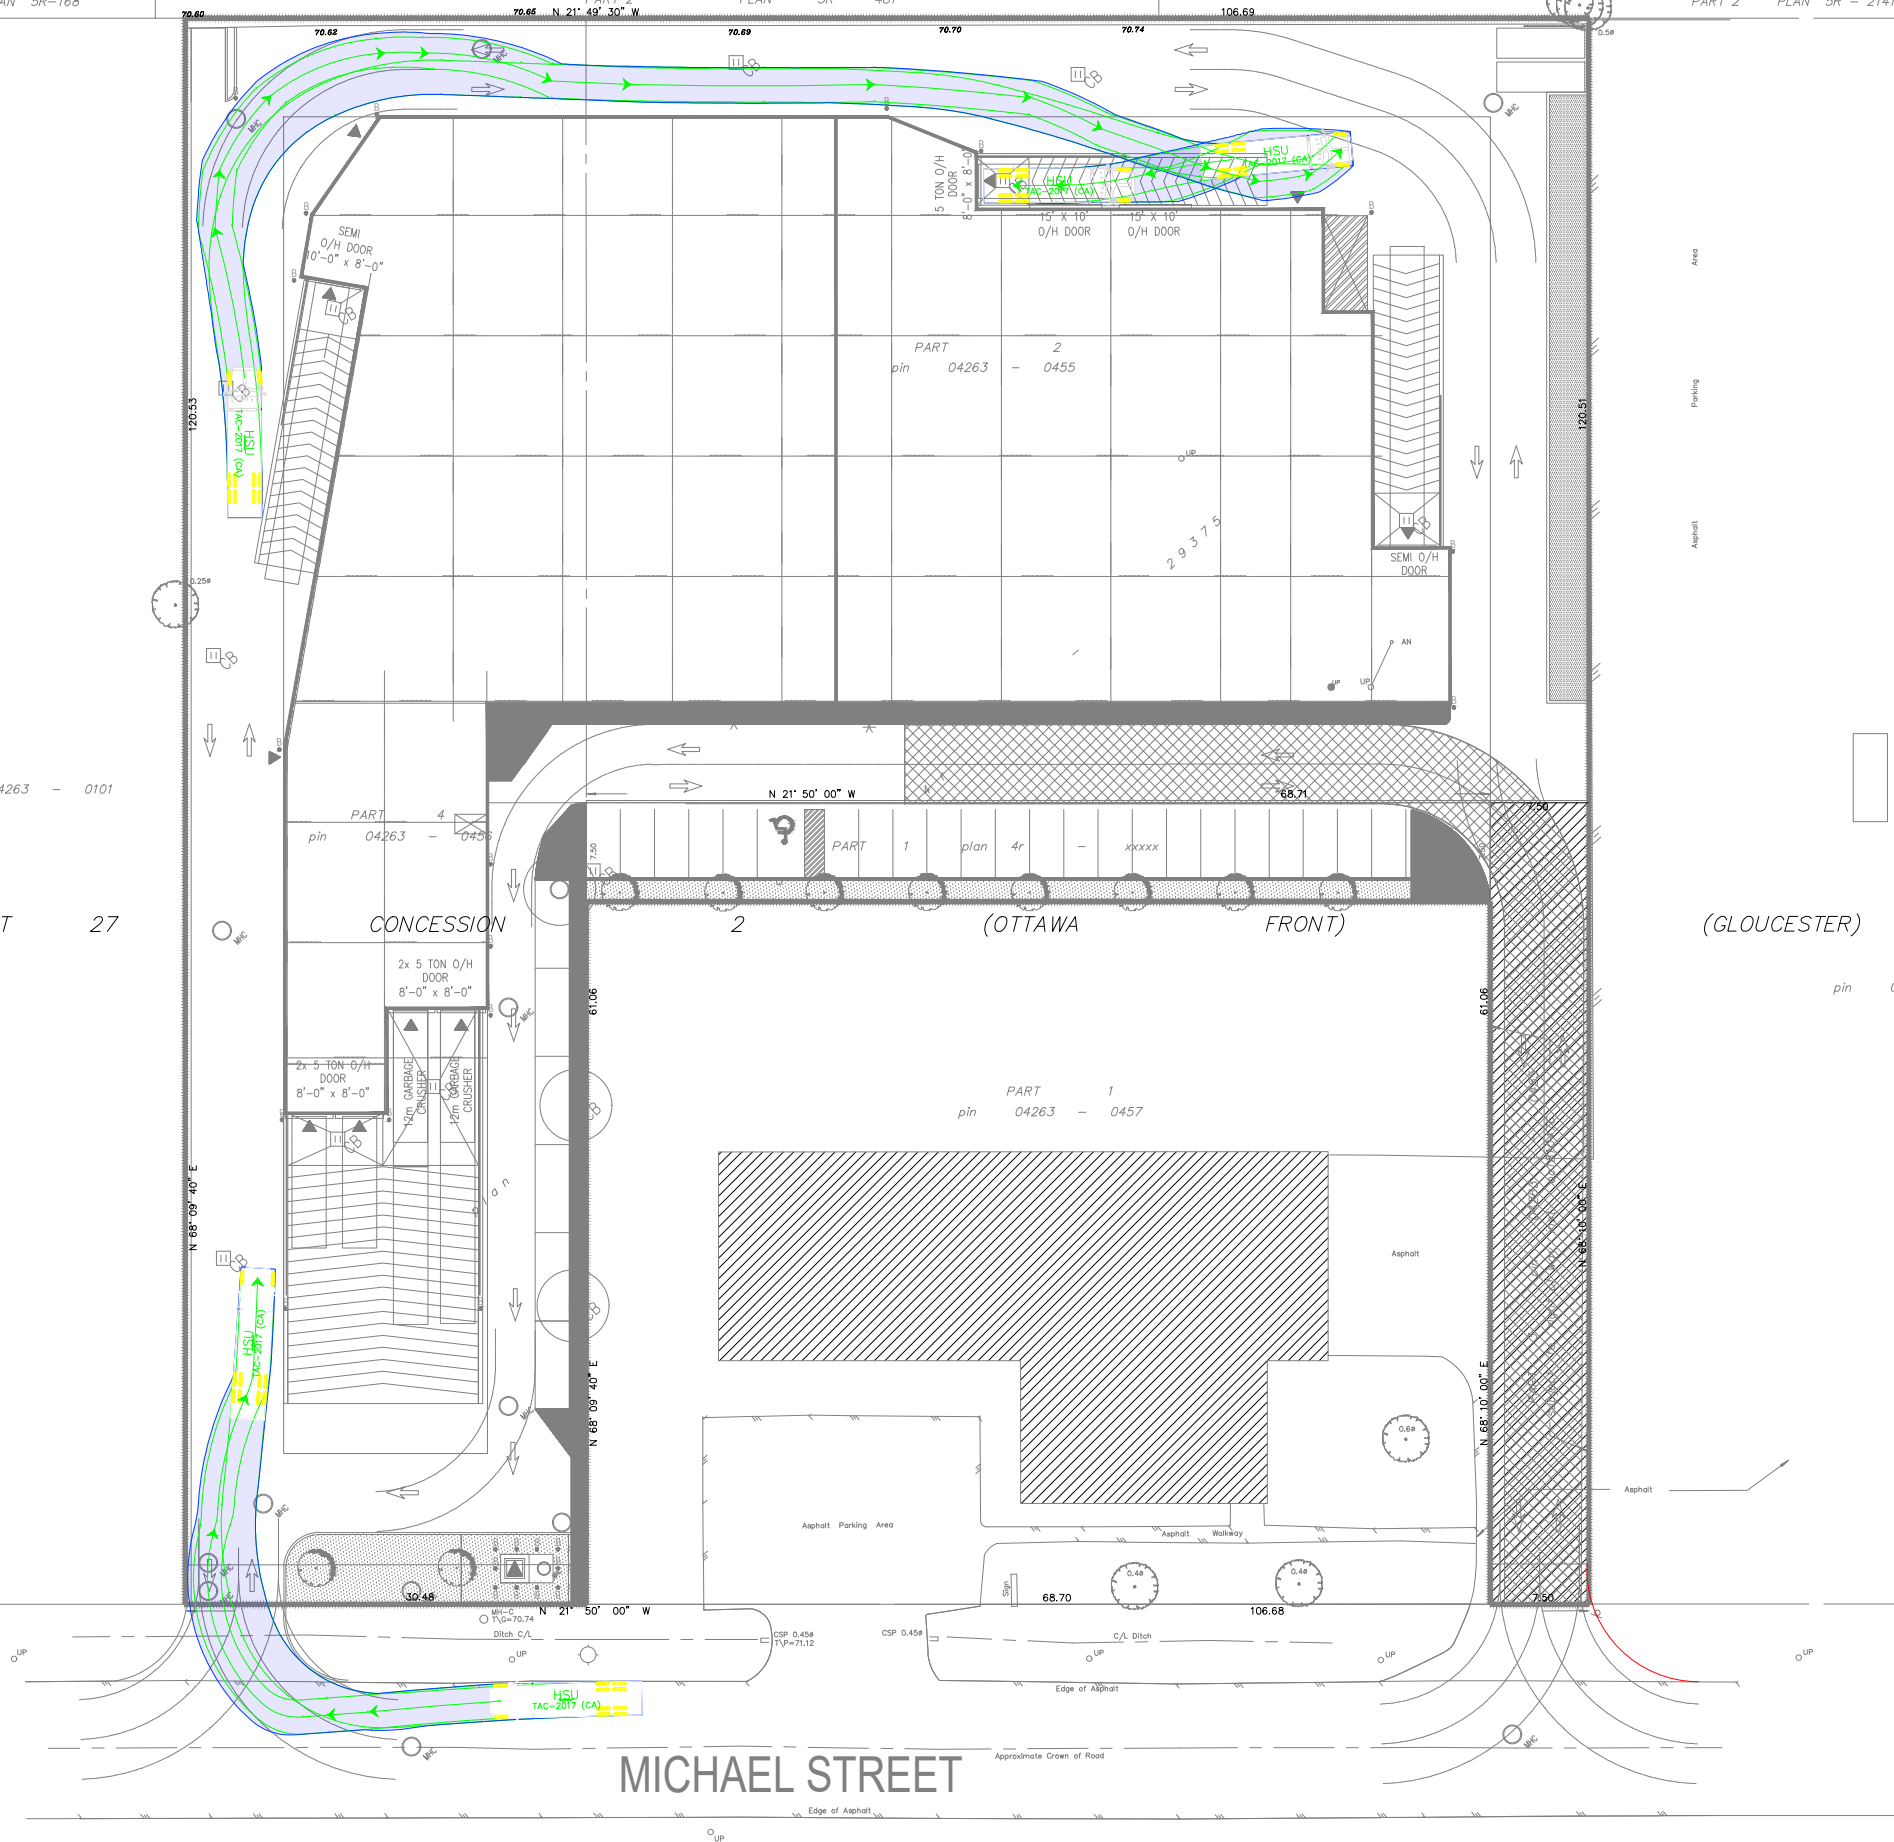

MICHAEL STREET

MICHAEL STREET (AS WIDENED BY BY-LAW 241-58, INST.GL32524) (PLAN BA-2542)
pin 04263 - 0292

Notes:

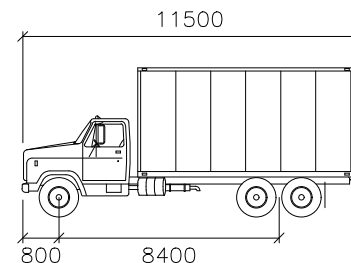

HSU

mm
Width : 2600
Track : 2600
Lock to Lock Time : 6.0
Steering Angle : 40.0

03	Issued for Review	MS	2023-12-12
02	Issued for Review	AN	2022-12-05
01	Issued for Review	BB	2022-02-17
REV:	DESCRIPTION:	BY:	DATE:
STATUS:			

CGH Transportation
6 Plaza Court
Ottawa, ON
K2H 7W1
(343) 999-9117

CLIENT: Roca Homes
424 George St W,
Ottawa, ON
K1S 3J2

ARCHITECT: Nicholas Caragianis Architect Inc.
137 Pamilla Street
Ottawa, ON
K1S 3K9

SITE: 1591 Michael Street

TITLE: Turning Movement Analysis
HSU Turning Movements (2)

SCALE AT A3:	DATE:	DRAWN:	CHECKED:
NTS	2023-12-12	MS	MC
PROJECT NO:	DRAWING NO:	REVISION:	
2023-176	005	03	

PART 2
PLAN 5R-168

pin 04263 - 0221

pin 04263 - 0222

PART 6 PLAN 5R-168


PART 2 PLAN 5R - 481

PART 2 PLAN 5R - 2141

pin 04263 - 0101

LOT 27


pin 04263 - 0102

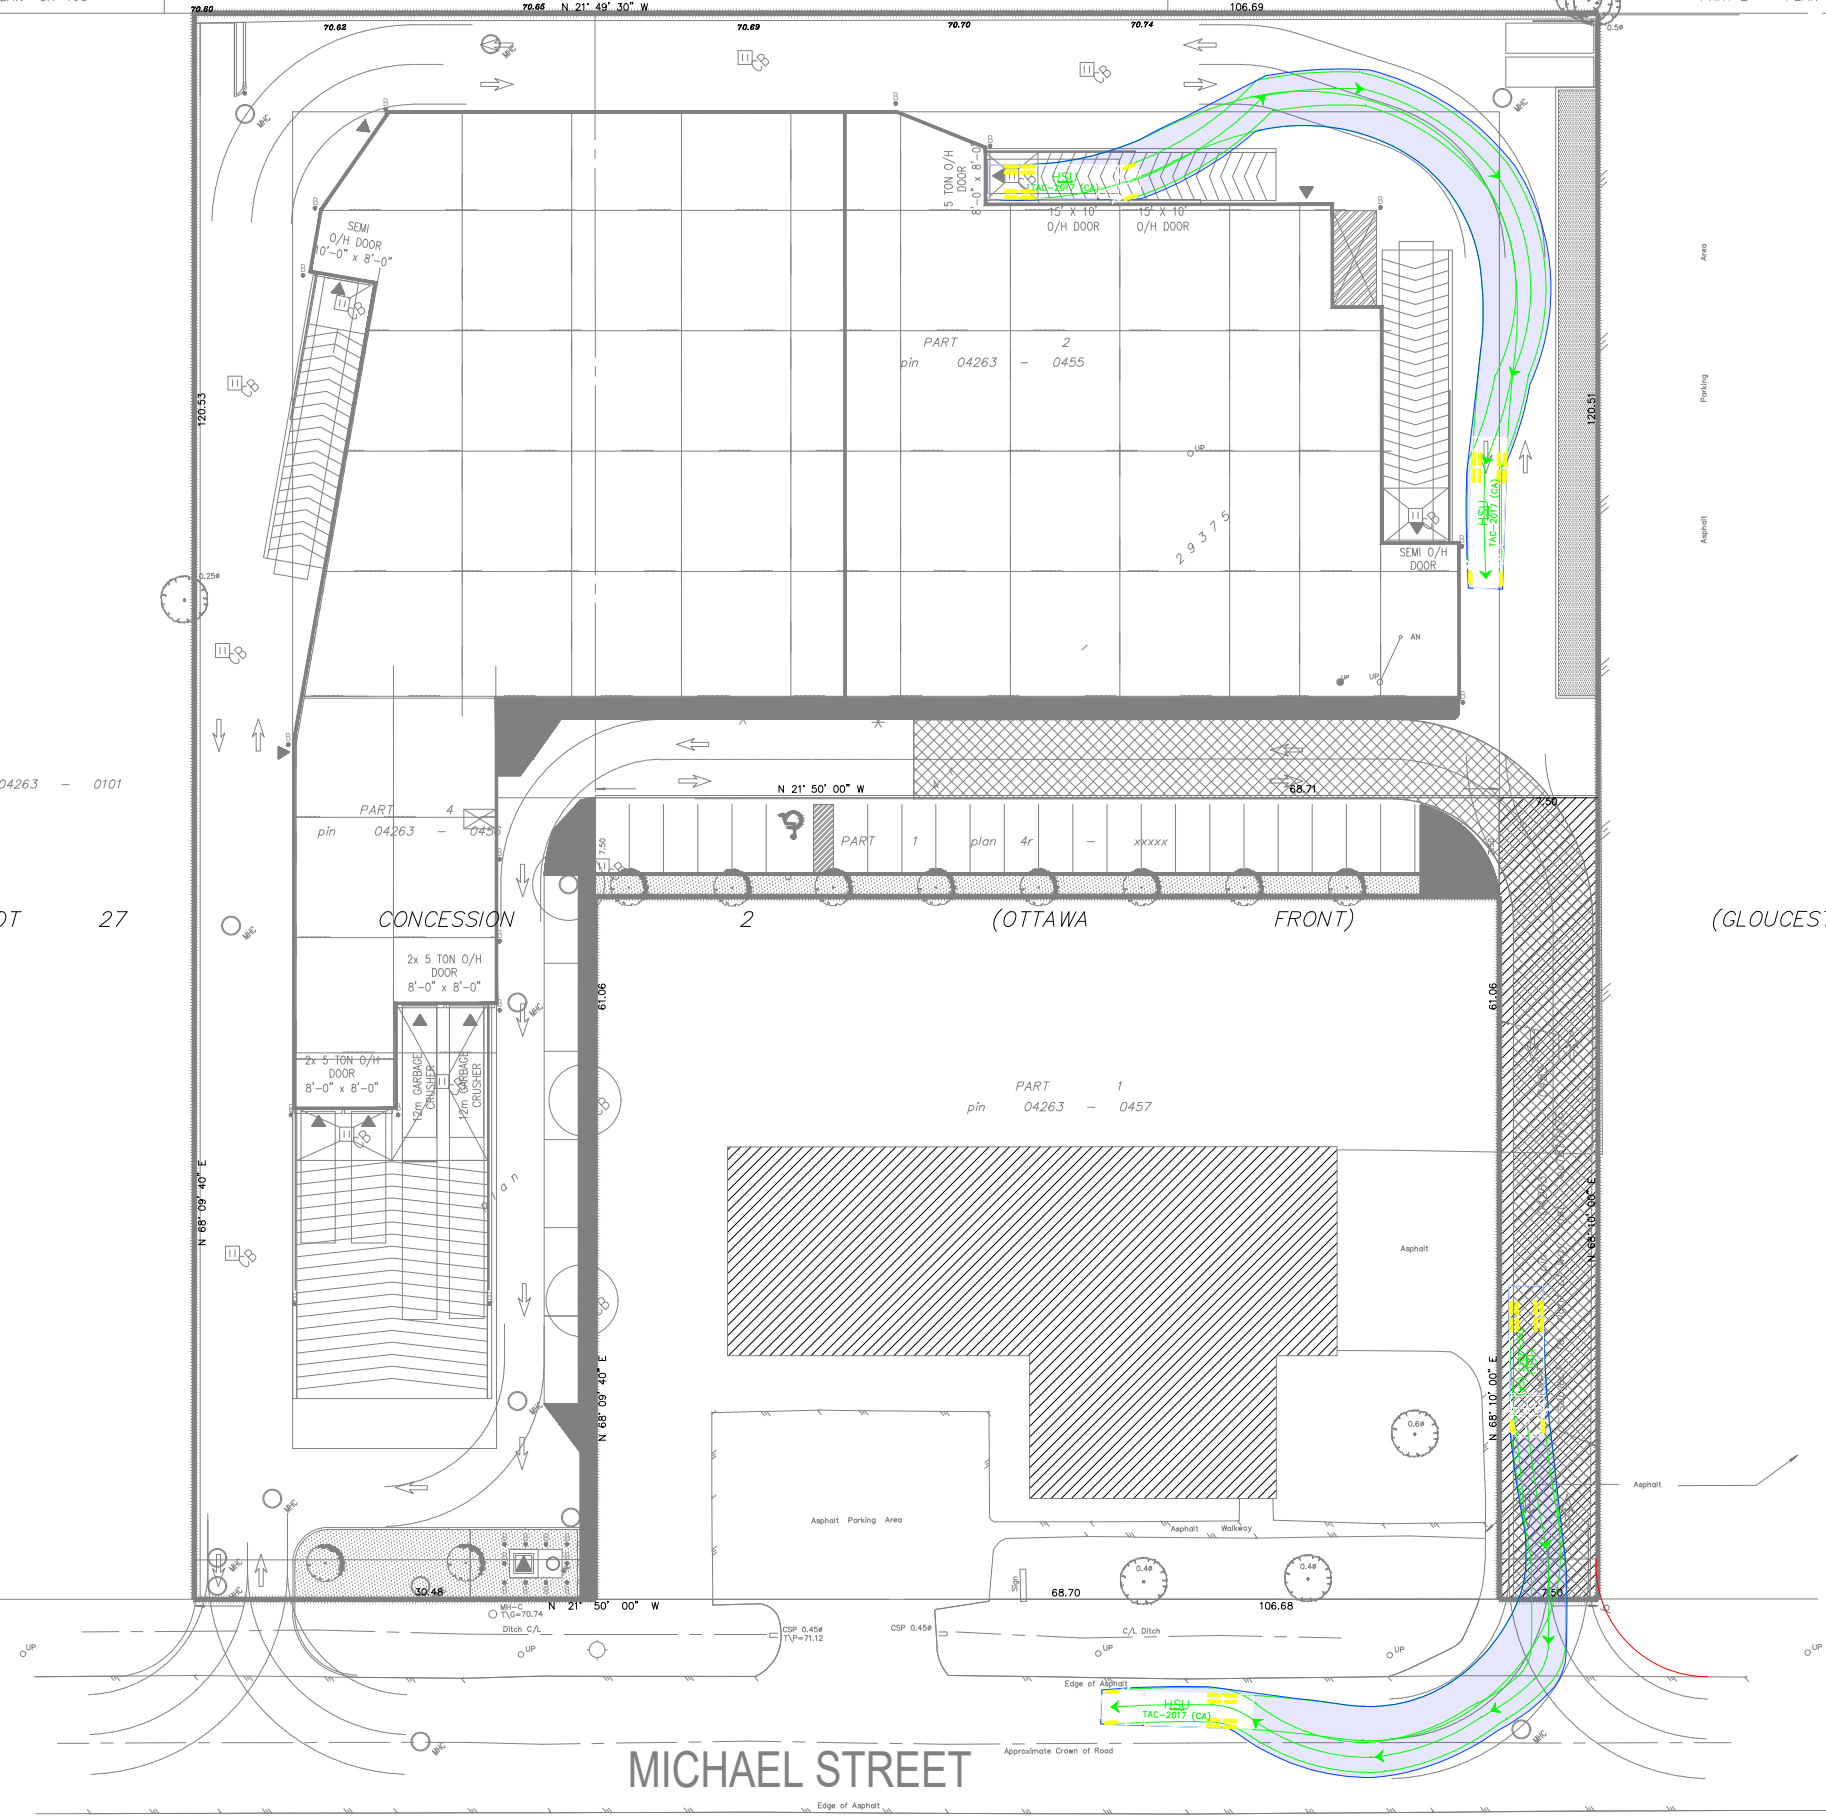

MICHAEL STREET

MICHAEL STREET (AS WIDENED BY BY-LAW 241-58, INST.GL32524) (PLAN BA-2542)
pin 04263 - 0292

Notes:

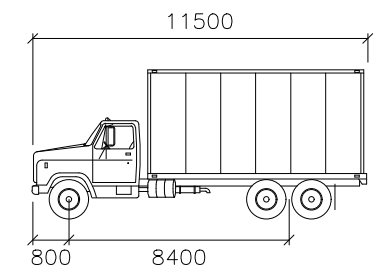

HSU
mm
Width : 2600
Track : 2600
Lock to Lock Time : 6.0
Steering Angle : 40.0

03	Issued for Review	MS	2023-12-12
02	Issued for Review	AN	2022-12-05
01	Issued for Review	BB	2022-02-17
REV:	DESCRIPTION:	BY:	DATE:
STATUS:			

CGH Transportation
6 Plaza Court
Ottawa, ON
K2H 7W1
(343) 999-9117

CLIENT: Roca Homes
424 George St W,
Ottawa, ON
K1S 3J2

ARCHITECT: Nicholas Caragianis Architect Inc.
137 Pamilla Street
Ottawa, ON
K1S 3K9

SITE: 1591 Michael Street

TITLE: Turning Movement Analysis
HSU Turning Movements (3)

SCALE AT A3: NTS	DATE: 2023-12-12	DRAWN: MS	CHECKED: MC
PROJECT NO: 2023-176	DRAWING NO: 006	REVISION: 03	