


### LEGEND

- B, D POLE MOUNTED LIGHT (LIGHT STANDARD) CW 18' POLE PLUS 2' CONCRETE BASE
- A WALL MOUNTED LIGHT; MOUNTING HEIGHT: 20'
- C WALL MOUNTED LIGHT; MOUNTING HEIGHT: 15'

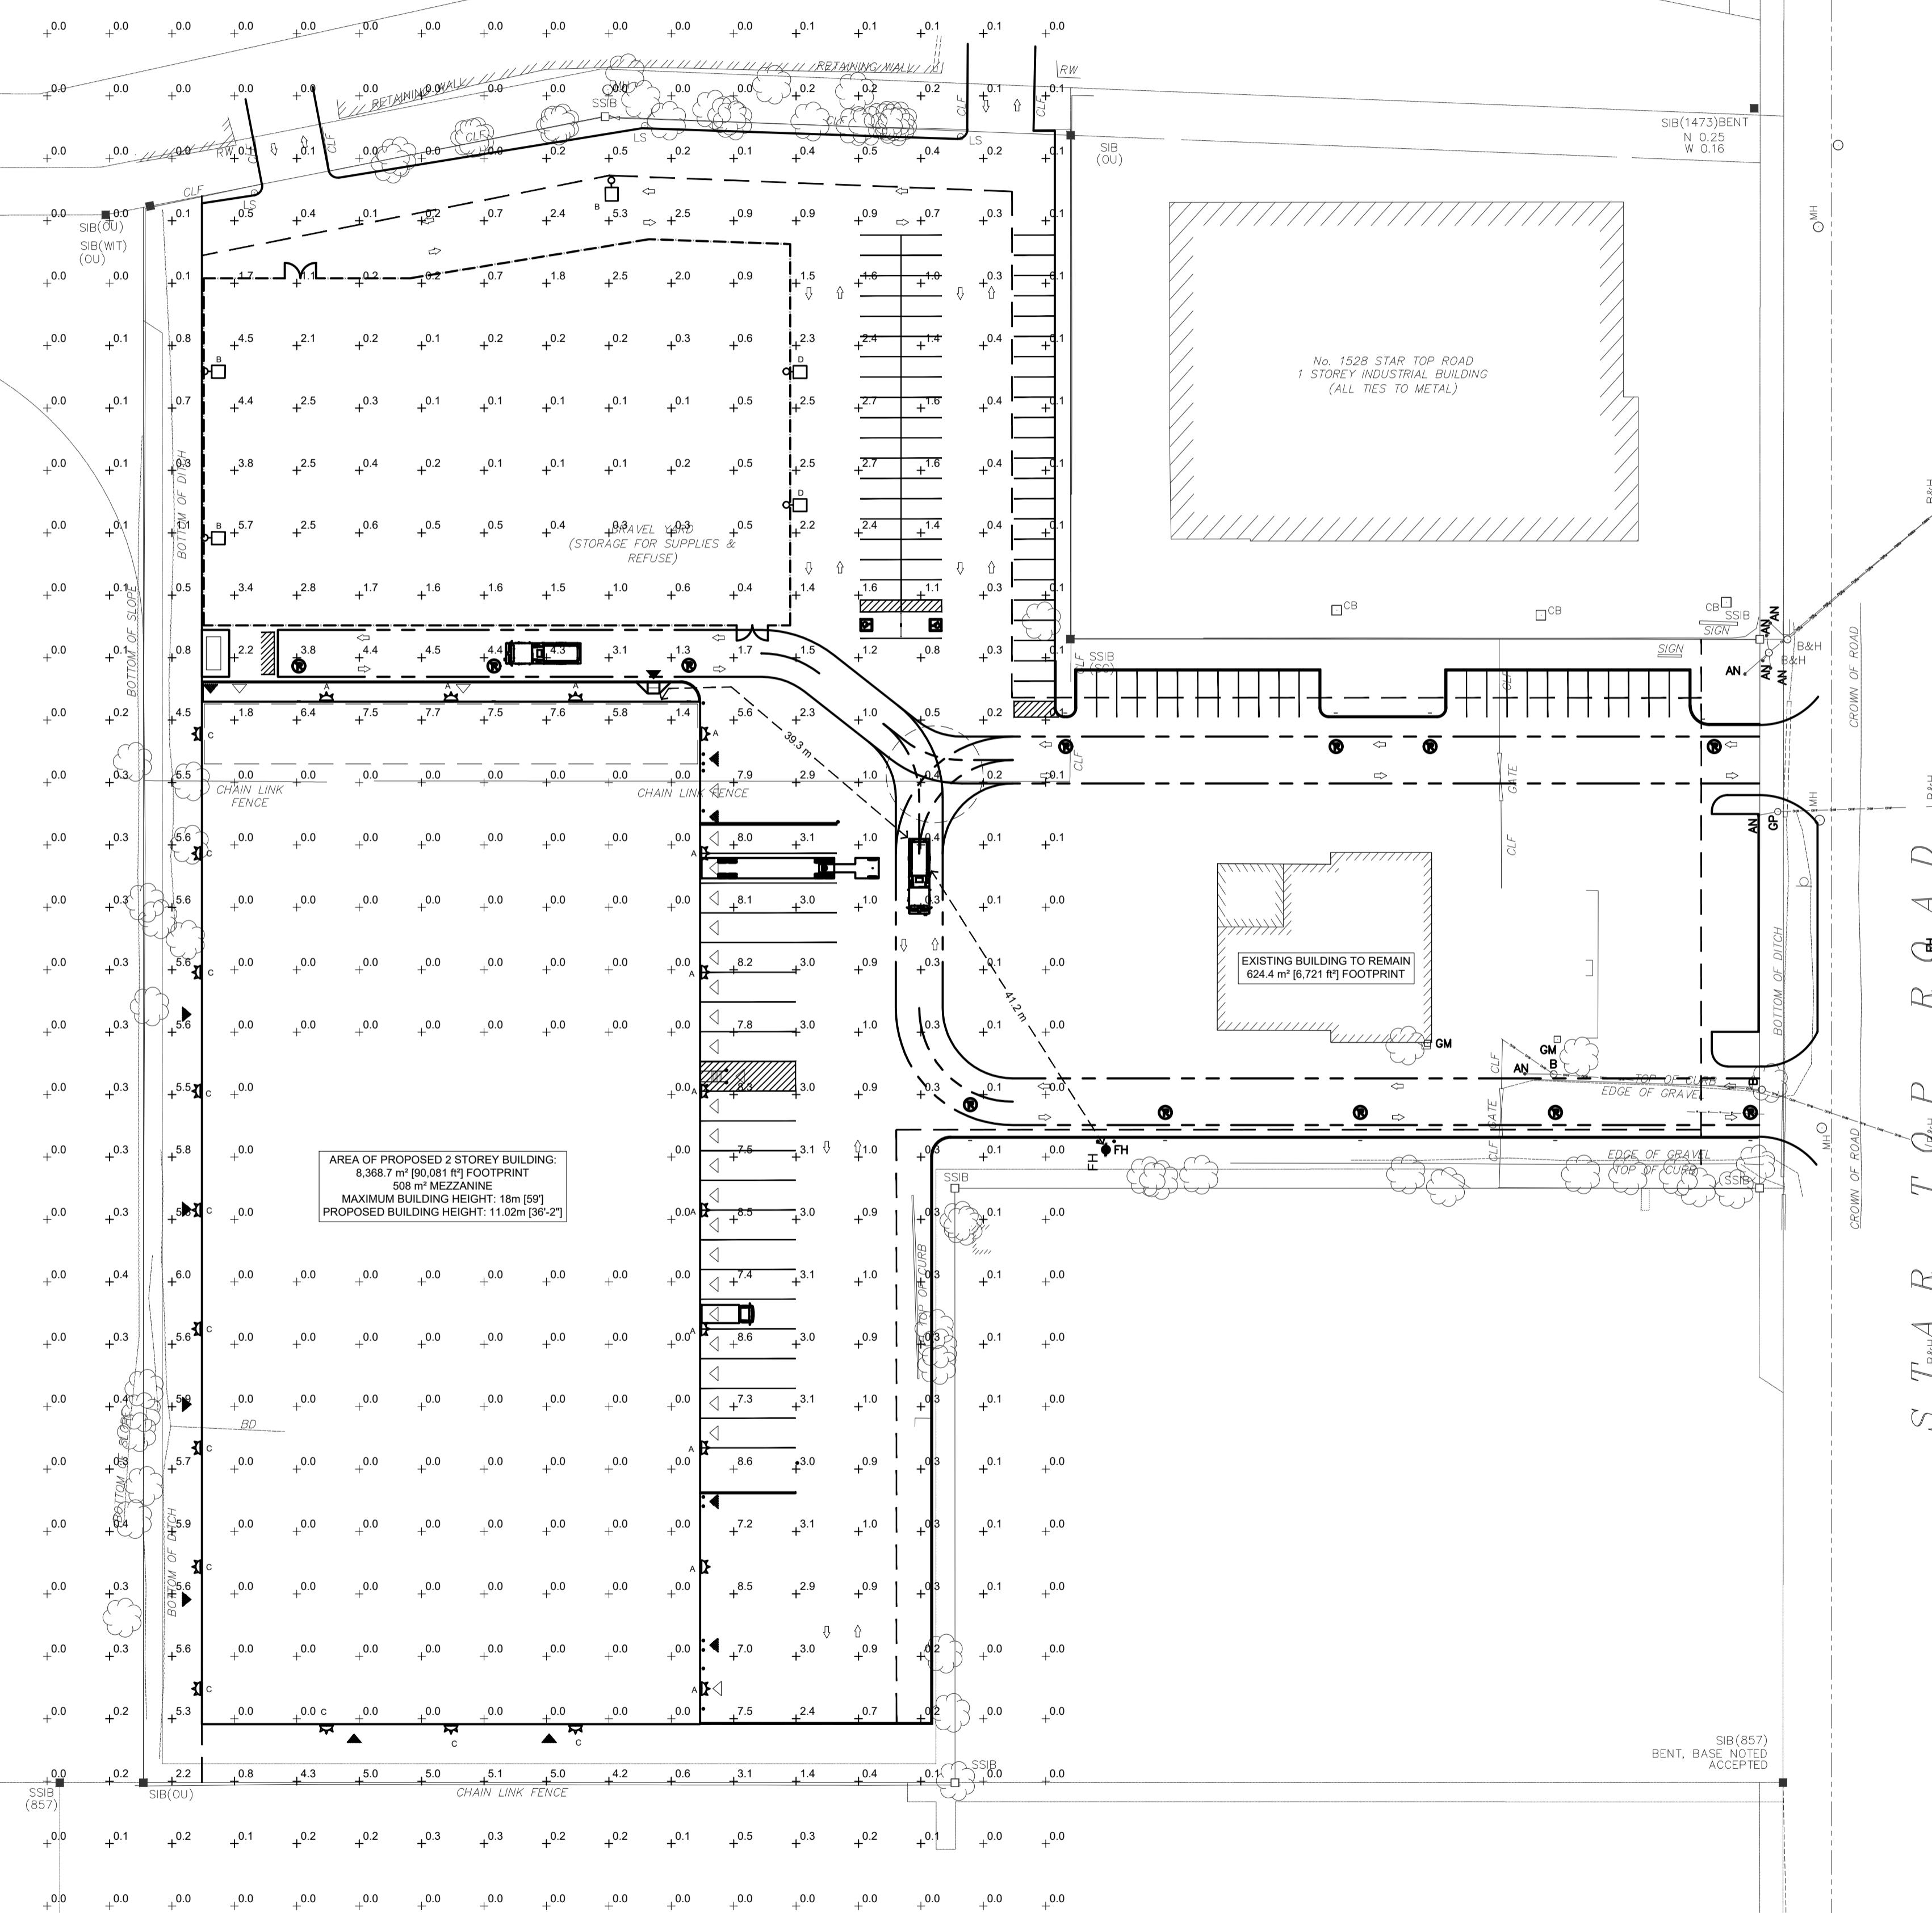

Symbol	Label	Image	QTY	Manufacturer	Catalog	Description	Number Lamps	Lamp Output	LLF	Input Power	Polar Plot
	A		12	Lithonia Lighting	WDG64 LED P4 70CKI RFT 40K	WDG64 LED WITH P4 - PERFORMANCE PACKAGE, 4000K, 70CKI, FORWARD THROW OPTIC	1	20445	1	146.90	
	B		3	Lithonia Lighting	DSX1 LED P7 40K T4M MVOLT HS G1	DSX1 LED P7 40K T4M MVOLT with houseshield	1	15750	1	183	
	C		12	Lithonia Lighting	WDG63 LED P3 70CKI R3 40K	WDG63 LED WITH P3 - PERFORMANCE PACKAGE, 4000K, 70CKI, TYPE 3 OPTIC	1	10054	1	71.6952	
	D		2	Lithonia Lighting	DSX1 LED P7 35K 80CKI T3M HS	D-Series Size 1 Area Luminaire P7 Performance Package 3500K CCT 80 CRI Type 3 Medium Houseshield	1	17317	1	184.4348	

Statistics						
Description	Symbol	Avg	Max	Min	Max/Min	Avg/Min
Calc Zone #2	+	1.0 fc	8.6 fc	0.0 fc	N/A	N/A

..\DAID Logo\DAID Logo\_Cropped for TBLK.jpg

..\Logos\BBS Logo.jpg



..\Logos\boone-1.jpg

North

Revisions			
No.	By	Description	Date
1	MY	LTG COORDINATION	JULY 18, 2023
2	MY	REVISED SITE LTG	JULY 27, 2023

Project  
**BOONE PLUMBING  
NEW WAREHOUSE**

1540 STAR TOP ROAD, OTTAWA, ONTARIO  
Drawing

## SITE PLAN ELECTRICAL LAYOUT

Scale \_\_\_\_\_ Stamp \_\_\_\_\_

Drawn \_\_\_\_\_  
Checked \_\_\_\_\_



Project No. 23-128  
Date JULY 2023  
Drawing No. E-S1