


LEGEND

DRAINAGE AREA (sq.m)

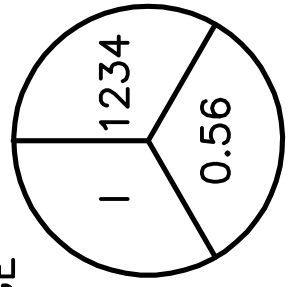

5 YEAR RUNOFF COEFFICIENT




No.	DATE	REVISION
2	MAY 10-24	RE-ISSUED FOR APPROVAL
1	APR 21-23	ISSUED FOR APPROVAL

**D. B. GRAY ENGINEERING INC.**  
 Surveying, Management, Consulting & Drainage, Smart & Building Systems, Estimation  
 700 Long Point Circle  
 Ottawa, Ontario  
 613-425-8044  
 d.gray@dbgrayengineering.com


**Project**  
 SMART LOCAL 47  
 TRAINING CENTRE  
 765 GREEN CREEK DRIVE  
 OTTAWA, ONTARIO

**Drawing Title**  
 PRE (EXISTING)  
 DEVELOPMENT  
 DRAINAGE PLAN

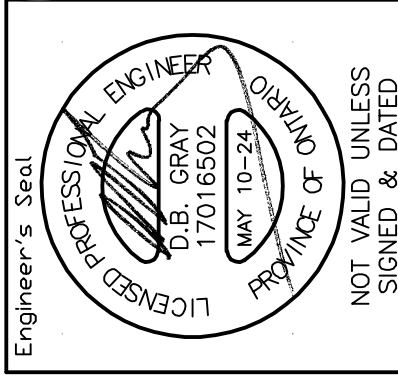

Drawn: D.B.G.  
 Proj. Scale: 1:200  
 Vert. Scale: 1:1  
 Date: SEP 10-20  
 Job: 20014  
 Drawing No. C-4  
 of 4

#18689

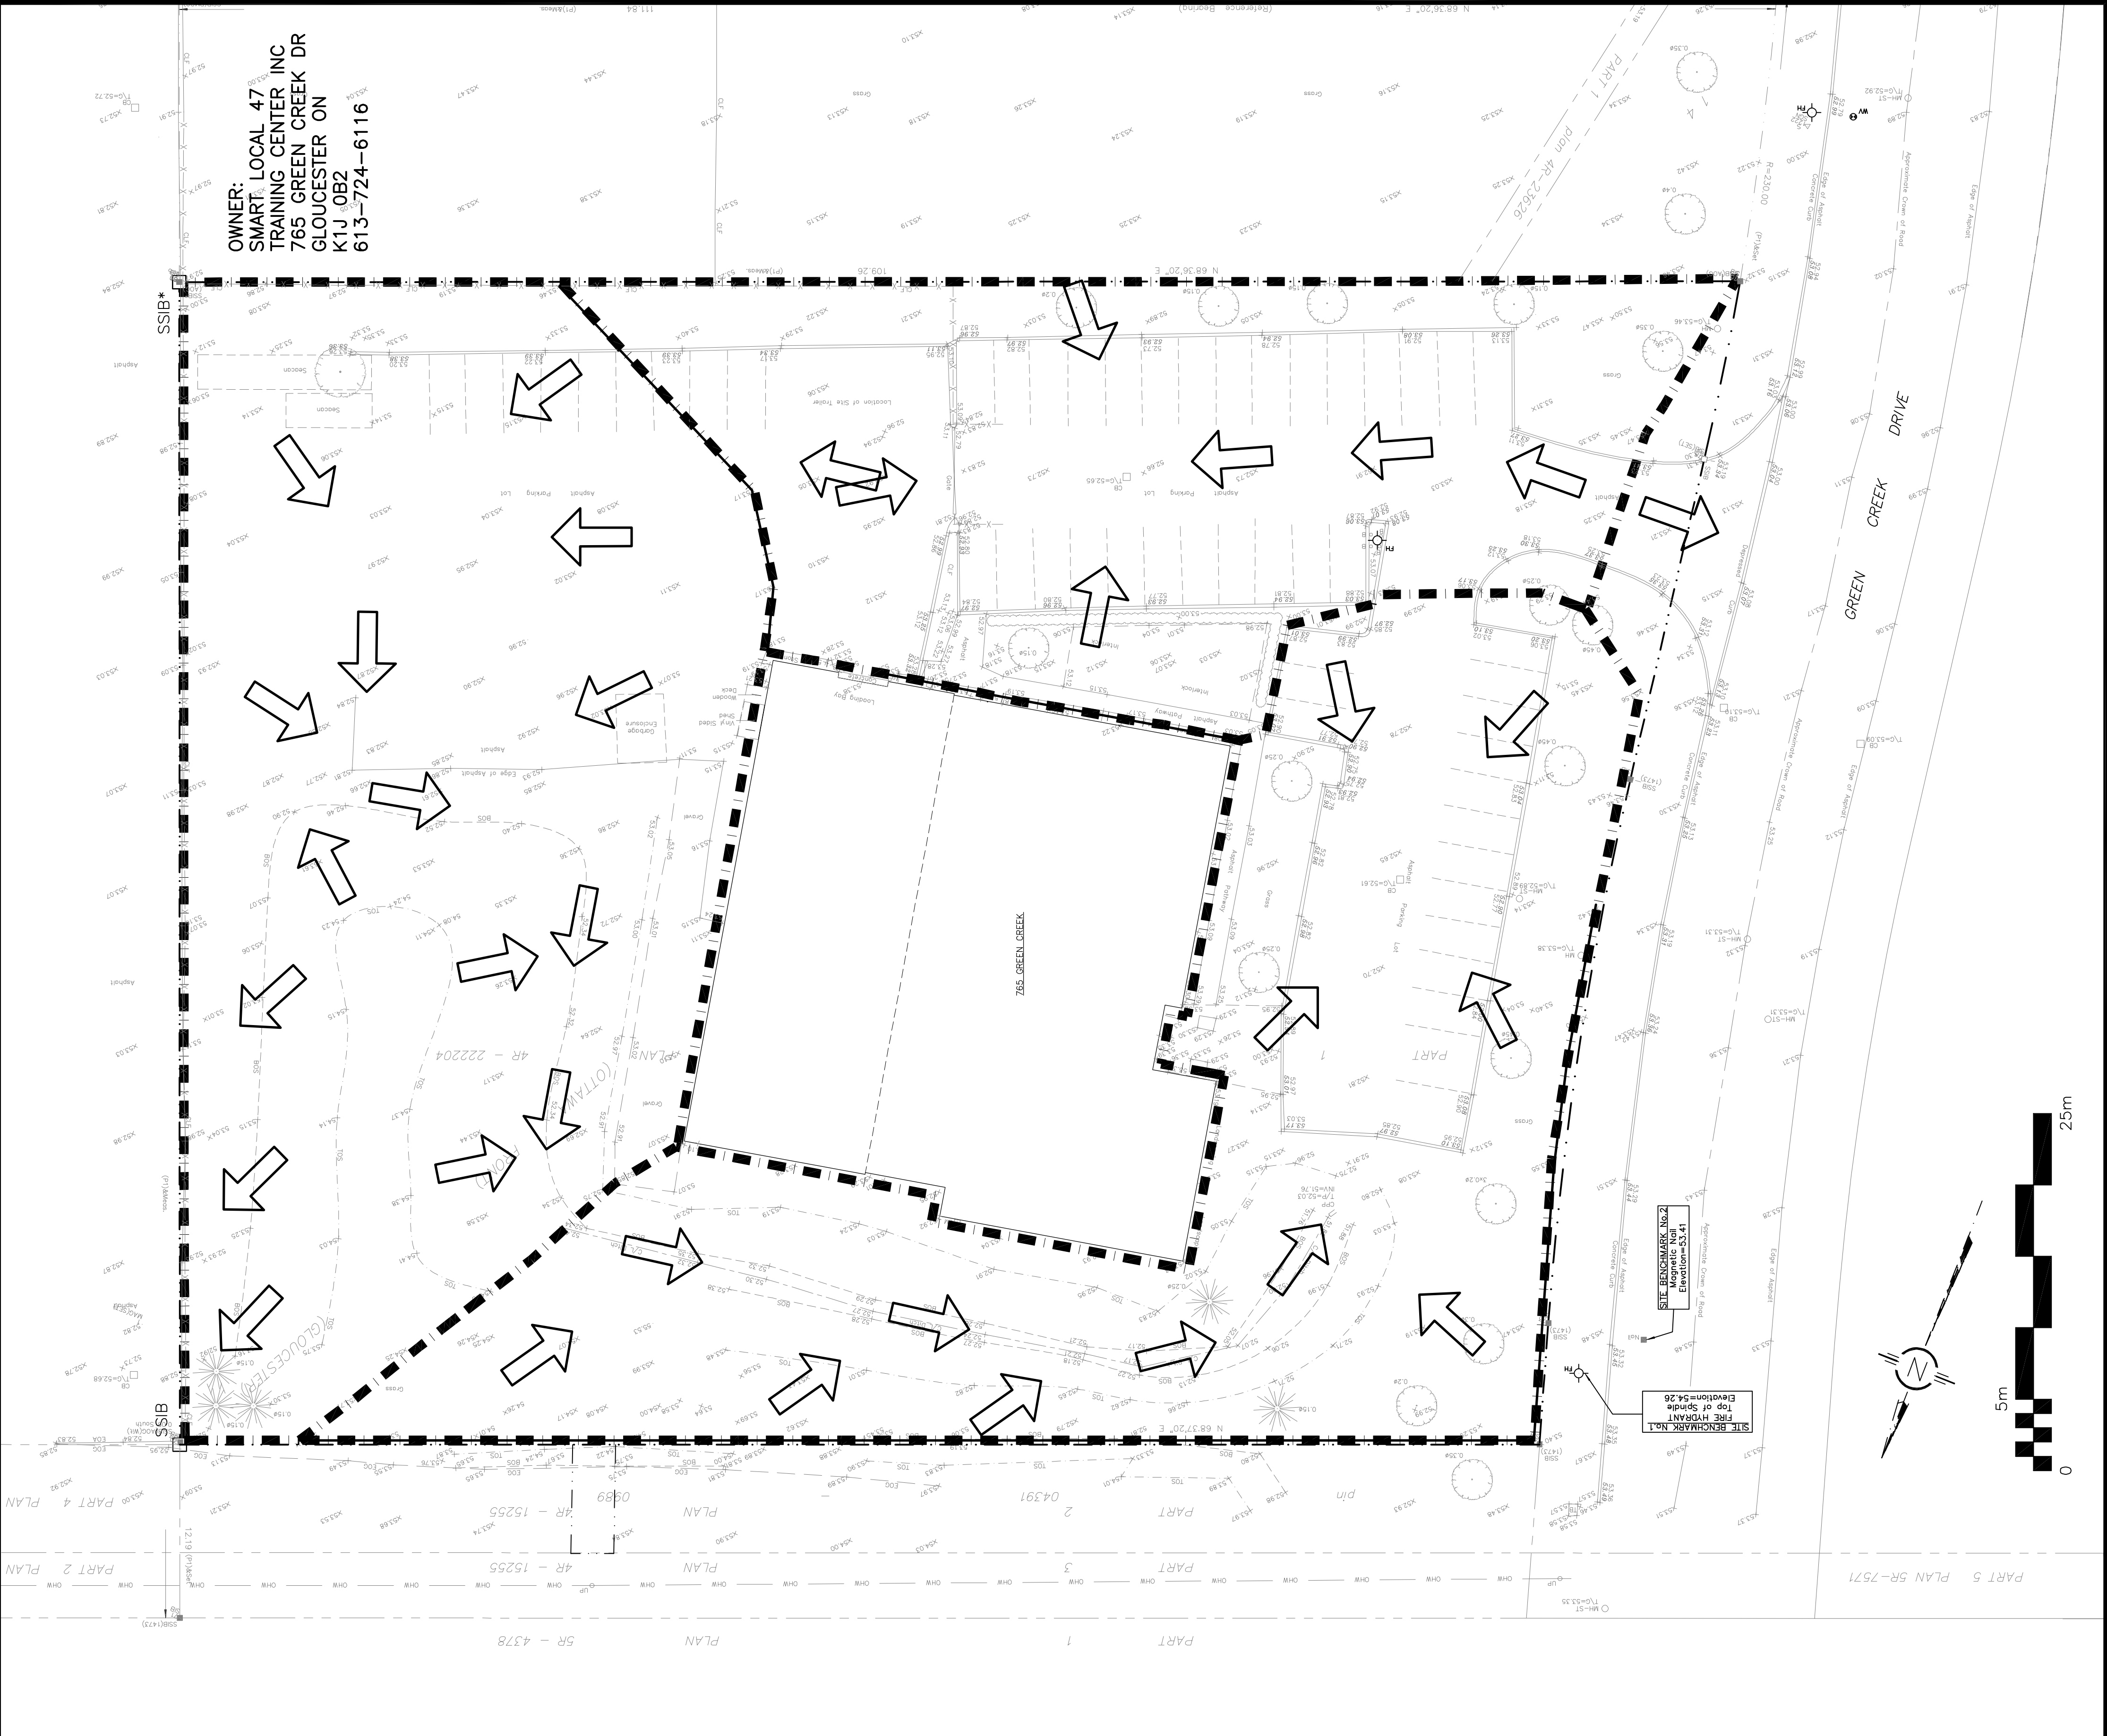

D07-12-21-0235