


SAN STRUCTURE TABLE				
NAME	RIM ELEV.	INVERT IN	INVERT OUT	DESCRIPTION
MH2C	75.79	S673.520	N73.278	STRUC. OPSD 701.011 COVER CITY 524 FRAME CITY 525
MH2B	75.25	S73.131	N71.194	STRUC. OPSD 701.011 COVER CITY 524 FRAME CITY 525
MH2C	71.16	S68.710	NW68.650	STRUC. OPSD 701.011 COVER CITY 524 FRAME CITY 525
MH2D	70.11	S67.200	SW66.440	STRUC. OPSD 701.011 COVER CITY 524 FRAME CITY 525
MH2E	69.45	NE65.500	NW65.080	STRUC. OPSD 701.011 COVER CITY 524 FRAME CITY 525

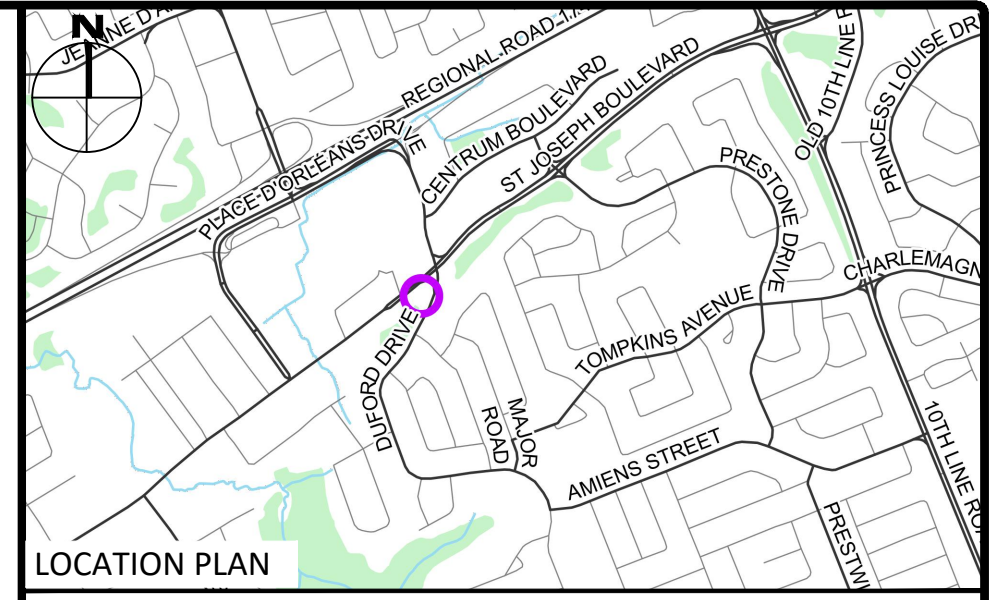

LEGEND	
UC	BARRIER CURB & CURB DEPRESSION
PROPOSED CONCRETE PAVERS	SLOPING AT 3:1 UNLESS SPECIFIED
MHR	STORM MANHOLE
CB	CATCHBASIN, CURB INLET OR DITCH INLET
MH2A	SANITARY MANHOLE
PROPERTY LINE	PROPOSED ELEVATION EXISTING ELEVATION
EX. WATER VALVE/CHAMBER	SWALE ELEVATION
PROP. VALVE PER CITY W24	TOP/BOTTOM WALL FACE ELEVATIONS
FIRE HYDRANT	PRE AND POST-DEVELOPMENT DRAINAGE DIRECTIONS
PROPOSED WALL	HEAVY DUTY SILT FENCE BARRIER PER OPSD 219.130
PROPOSED SIAMENSE CONNECTION	BUILDING ENTRANCE
PROPOSED WATER METER AND REMOTE METER	PROPOSED GRASS
PROPOSED CONCRETE SIDEWALK	CENTRELINE OF SWALE
PROP AND EX. REDUCER	PROPOSED ROAD/CUT AND REINSTATEMENT PER CITY R10
1/16" HYDRO DUCT PER ELEC.	CB SILT SACK PER C101 DETAIL
EX. SAN SEWER	SERVICE/SEWER CROSSING
	EX. EX. STREET LIGHT
	EX. TRAFFIC LINE
	EX. WATERMAIN
	EX. GAS
	EX. OHW
	EX. TRAFFIC CABLE
	EX. BELL
	EX. ROGERS

SUBJECT TO APPROVAL

2	ISSUED FOR REVIEW	JUL 31, 2024
1	ISSUED FOR SITE PLAN CONTROL	MAR 07, 2024
No.	Revisions	Date

Check and verify all dimensions before proceeding with the work. Do not scale drawings.

SCALE 1 : 200

**egis** 115 Walgreen Road, R.R.3  
Carp, ON K0A 1L0  
Tel: 613-836-2184  
Fax: 613-836-3742  
www.egis-group.com


Client: **THEBERGE DEVELOPMENTS LTD**  
1600 LAPERRIERE AVE  
OTTAWA, ON K1Z 8P5

Project: **3030 ST. JOSEPH BOULEVARD**

OTTAWA ON

Drawing Title: **PLAN & PROFILE STA. 2+000 TO 2+040**

Scale:	1:200	Project Number:	CCO-24-0142
Drawn By:	RRR	Checked By:	AM
Designed By:	RRR	Drawing Number:	C202

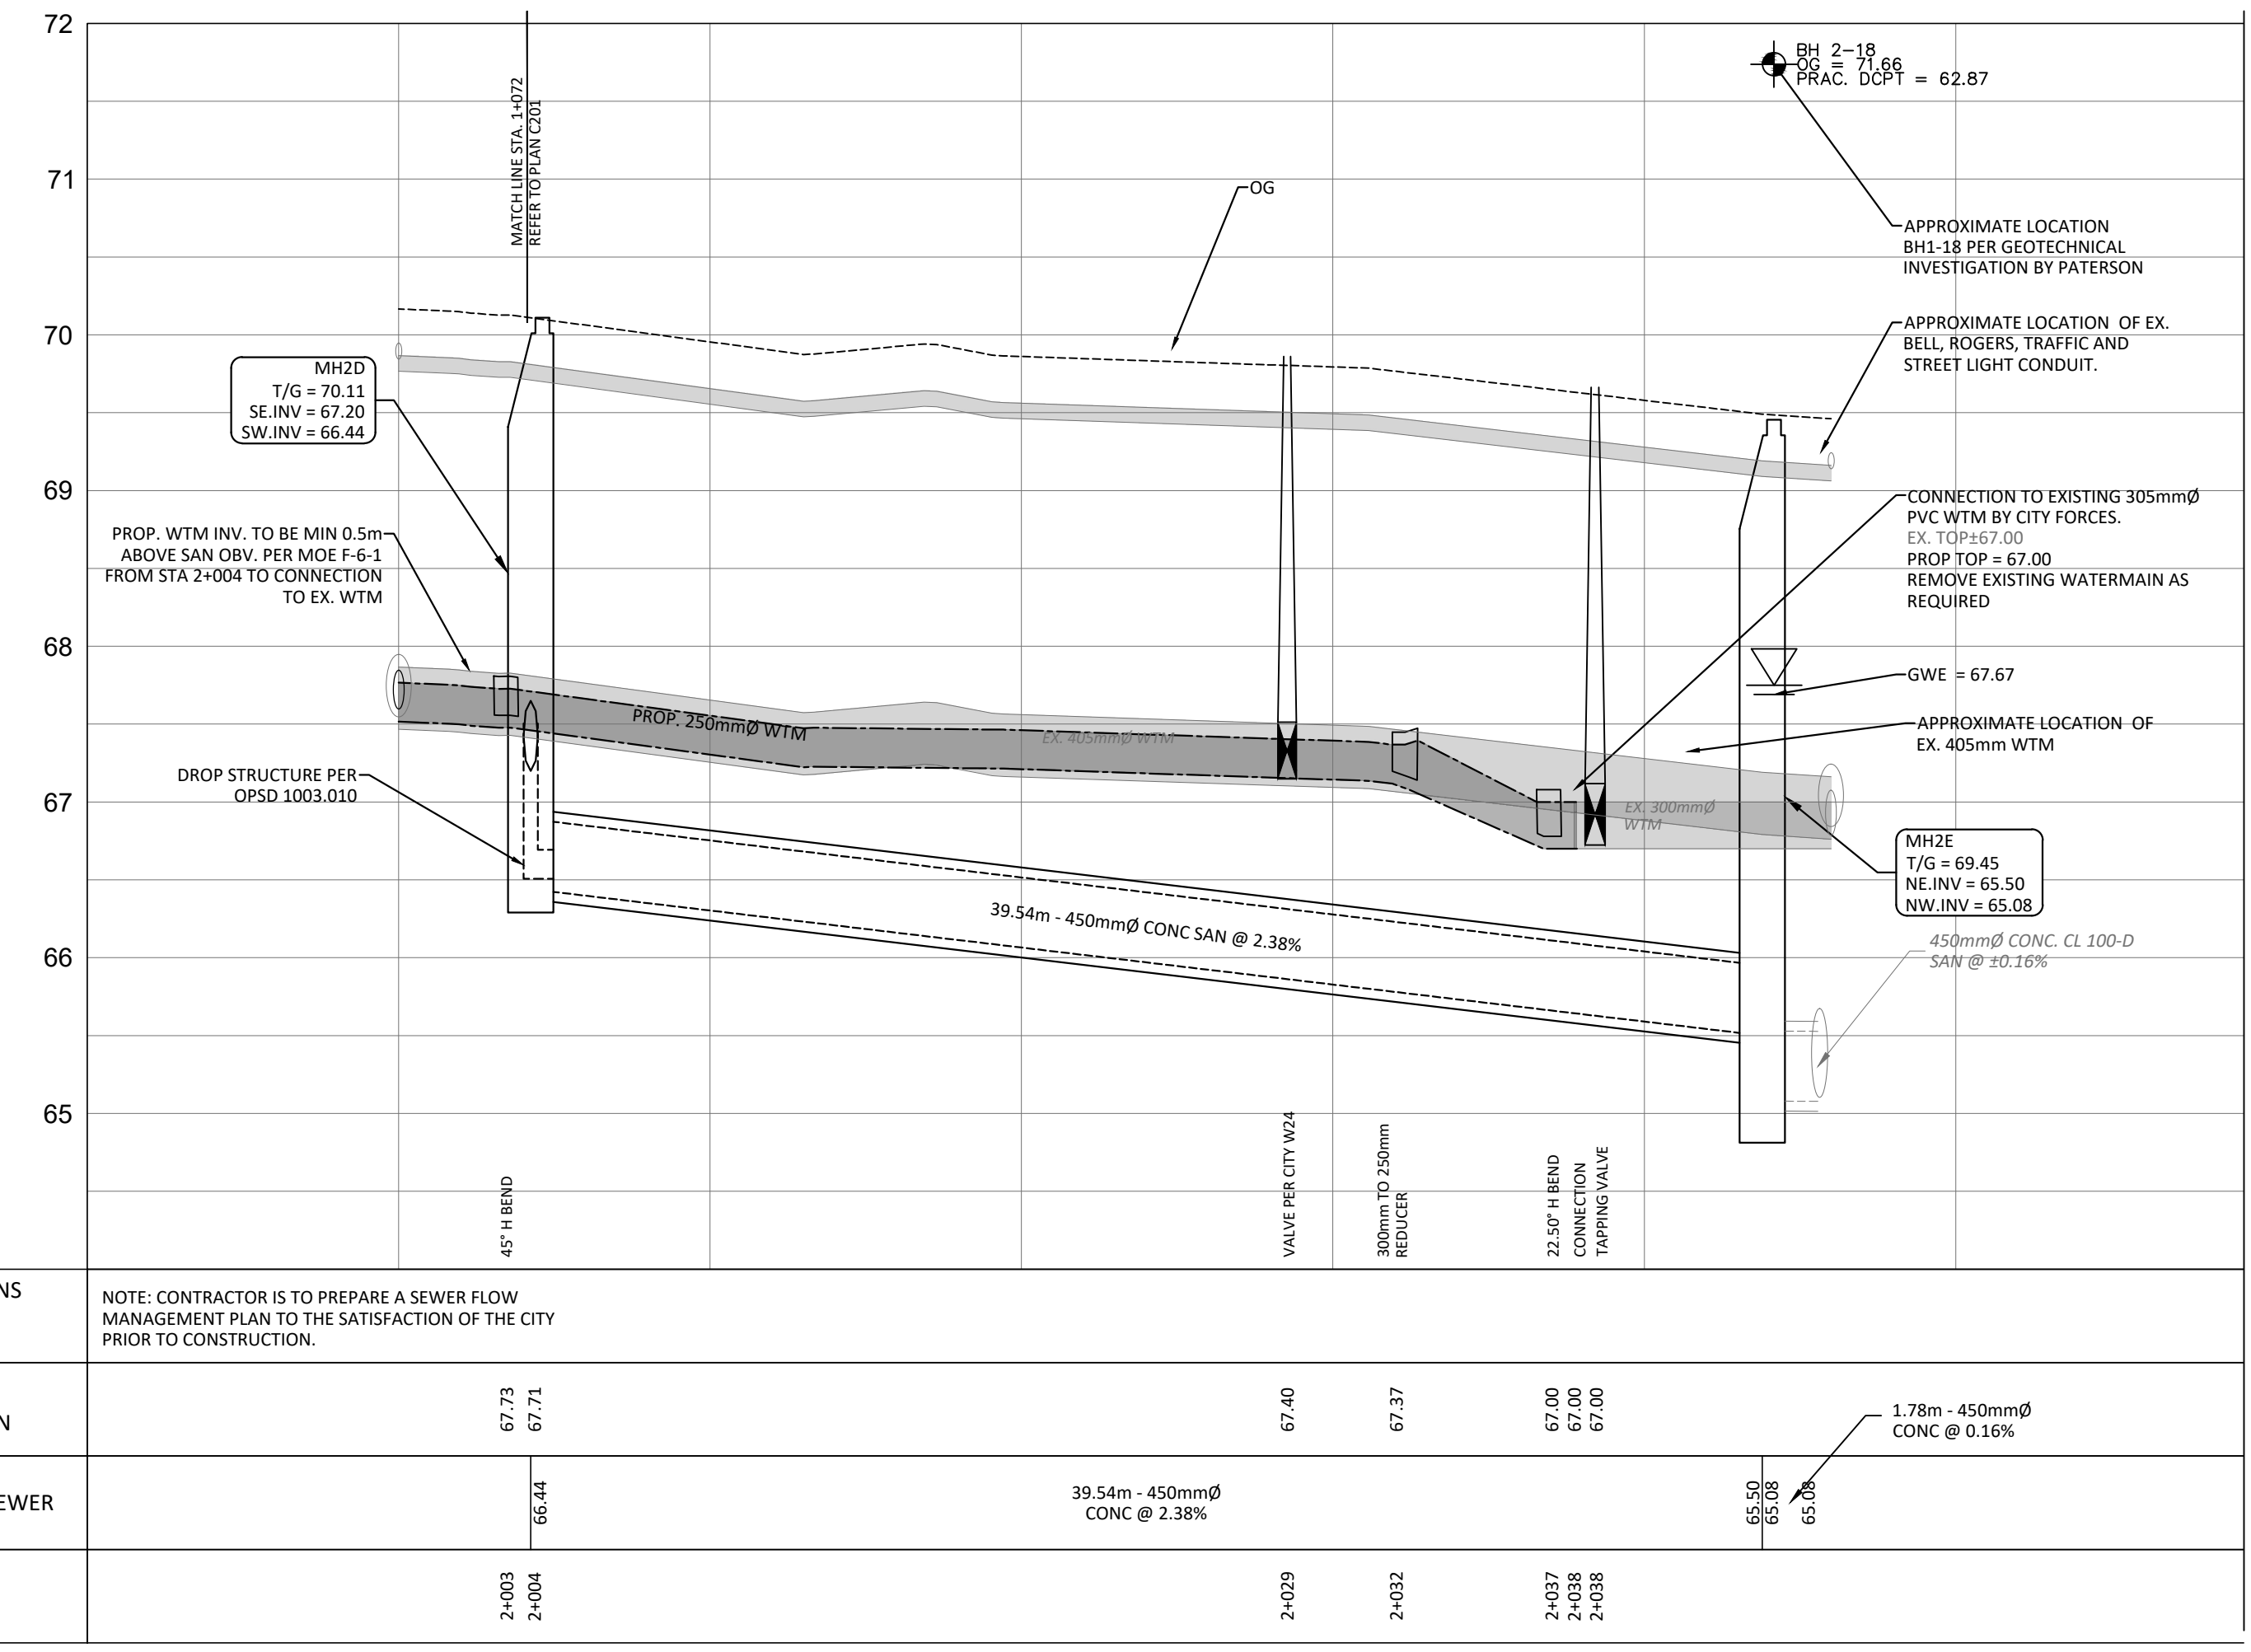

STATION	TOP OF WATERMAIN	SANITARY SEWER	PROPOSED
2+003	67.73	66.44	67.73
2+004	67.71		67.71
2+029			67.40
2+032			67.37
2+037			67.00
2+038			67.00
2+038			67.00

NOTE: CONTRACTOR IS TO PREPARE A SEWER FLOW MANAGEMENT PLAN TO THE SATISFACTION OF THE CITY PRIOR TO CONSTRUCTION.

FILENAME: \\h:\projects\2024\CCO-24-0142\Theberge - 2024\9 - Joseph Blvd\11 - Drawing\CCO-24-0142 - PRESENTATION.dwg  
 LAST SAVED: Wednesday, July 31, 2024 10:54 AM  
 LAST SAVER: B. J. B. (B. J. B.)  
 LAST PLOTTED: Wednesday, July 31, 2024 10:54 AM  
 C:\Users\B. J. B. (B. J. B.)\AppData\Local\Temp\CCO-24-0142 - PRESENTATION.dwg

D07-12-23-0090