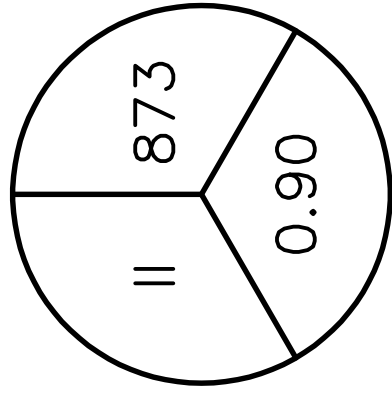
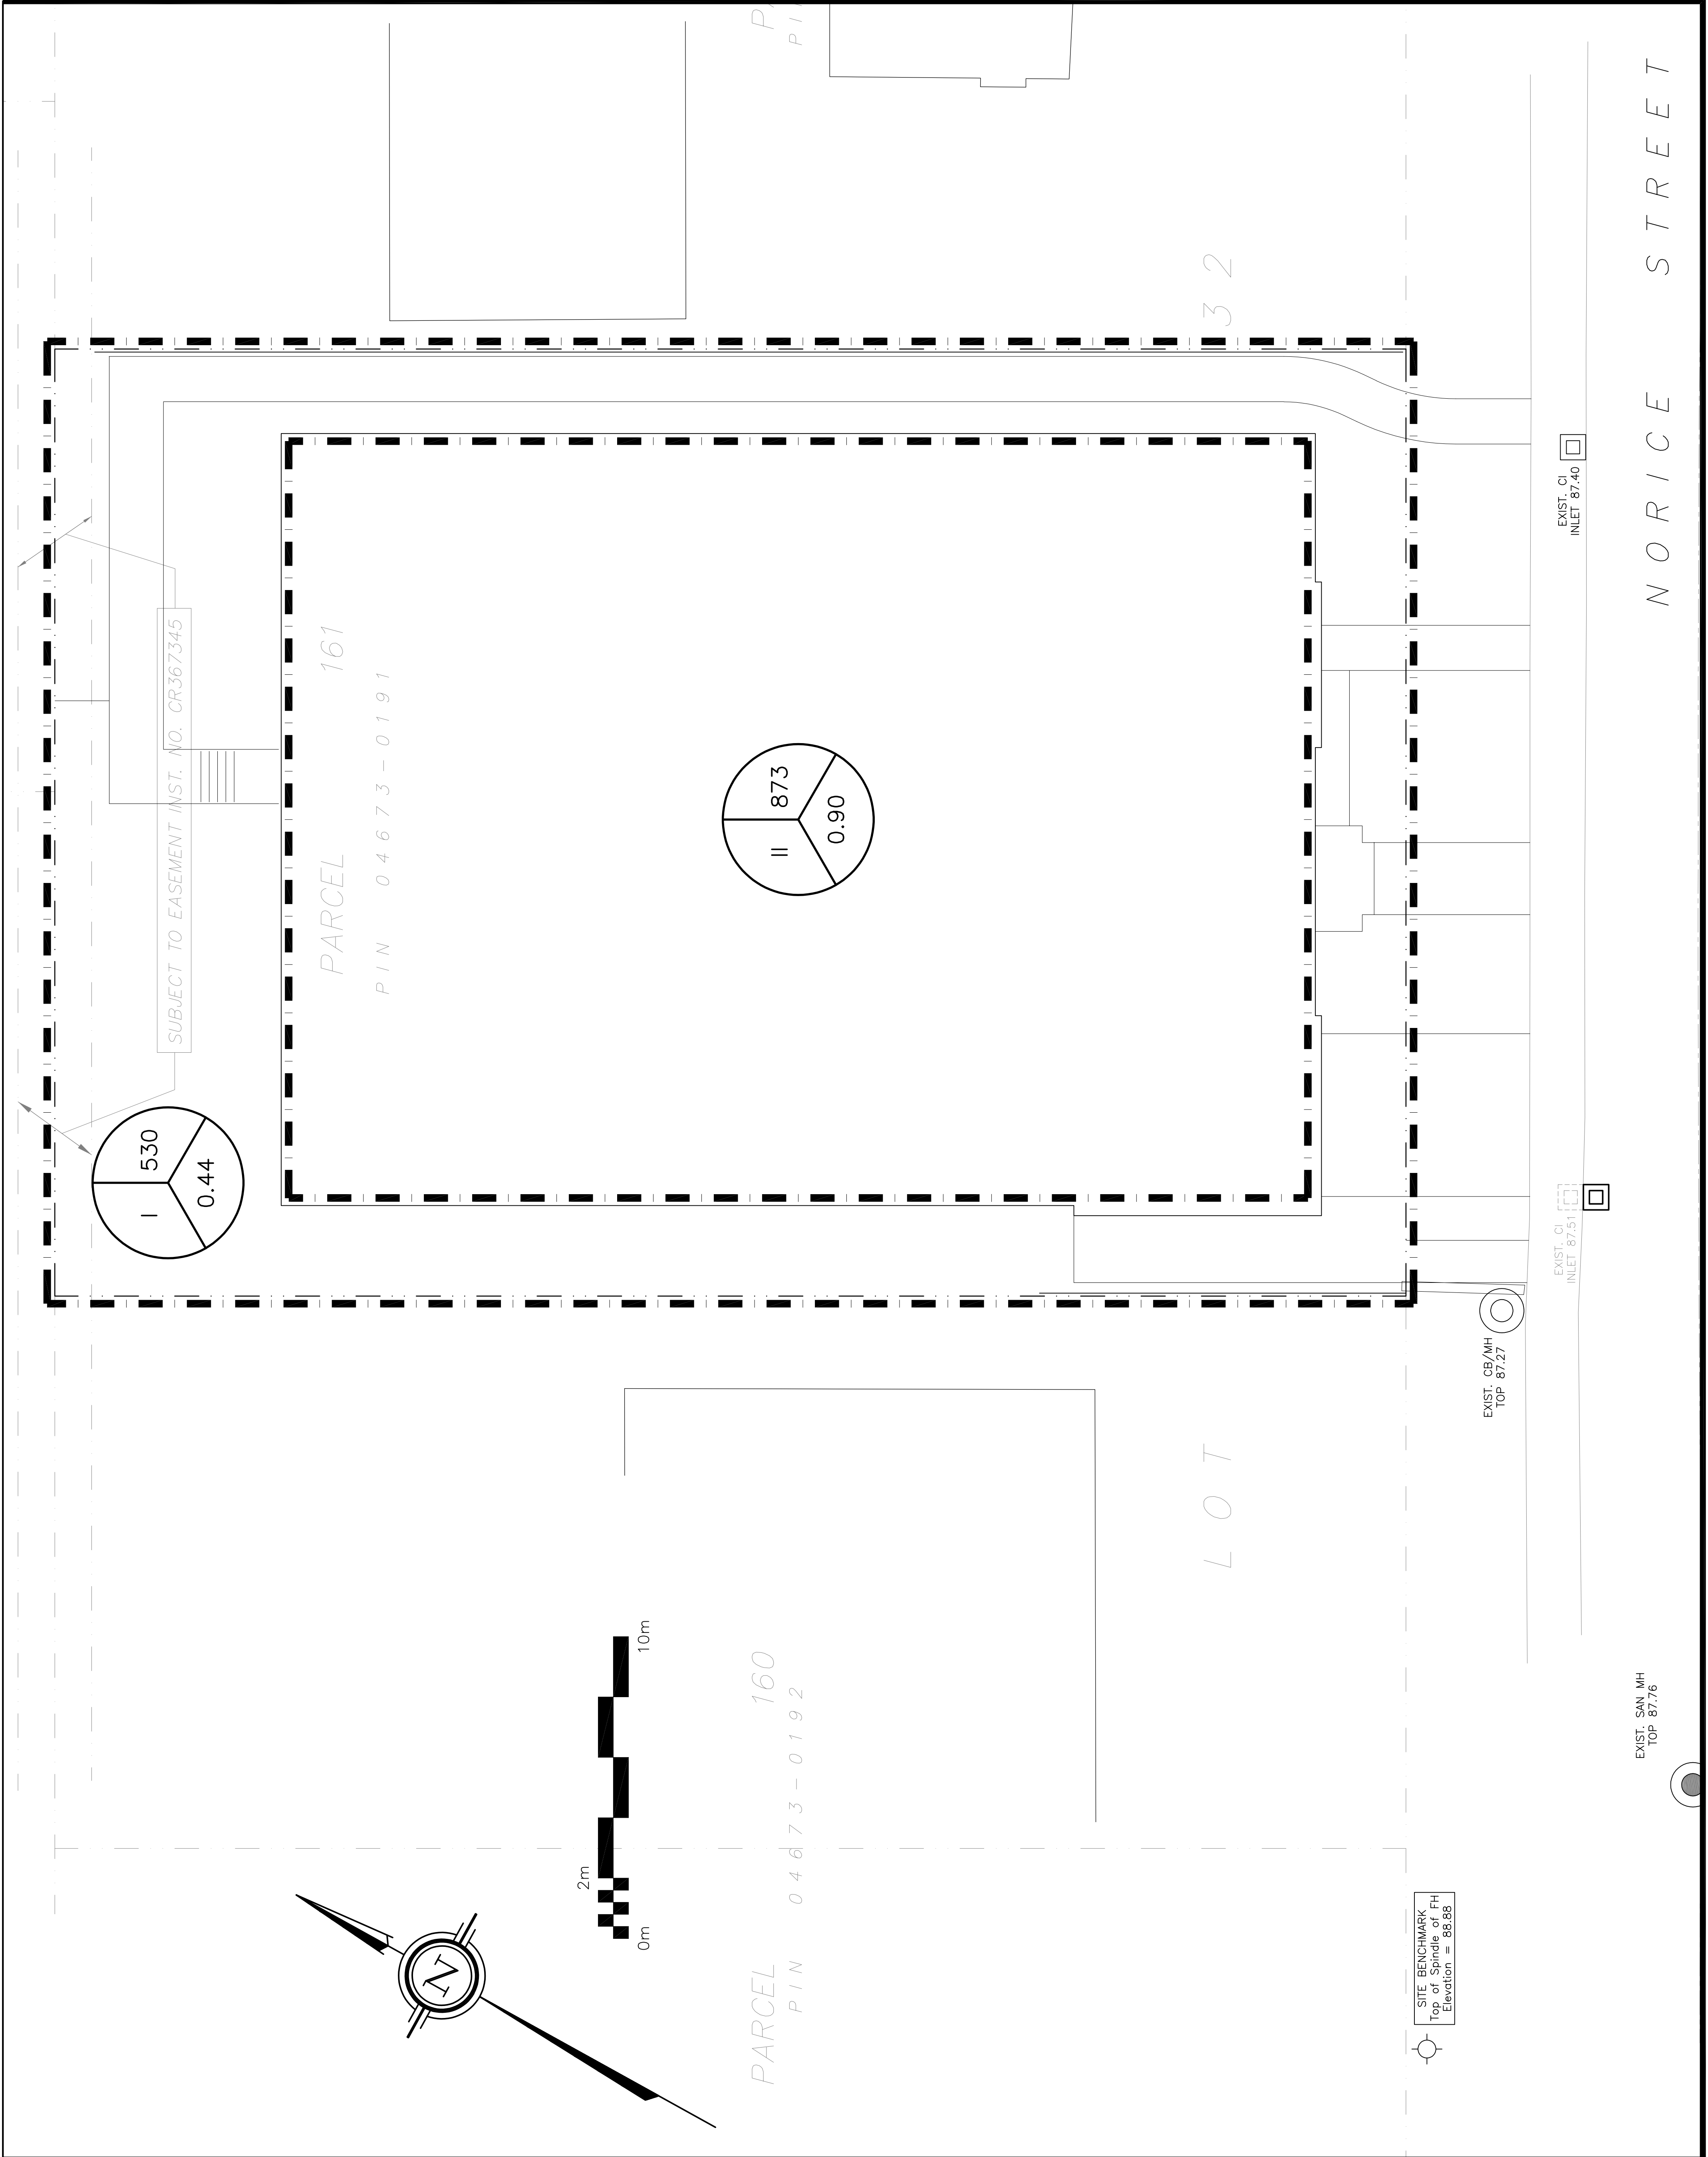
5-YEAR
RUNOFF
COEFFICIENT

KEY PLAN

[illegible]


D. B. GRAY ENGINEERING INC.
Stormwater Management - Grading & Drainage - Storm & Sanitary Sewers - Watermain
 700 Long Point Circle 613-425-8044
 Ottawa, Ontario d.gray@dbgrayengineering.com

Project

PROPOSED 4-STORY
RESIDENTIAL BUILDING
193 NORICE STREET
OTTAWA, ONTARIO

Drawing Title

DRAINAGE PLAN

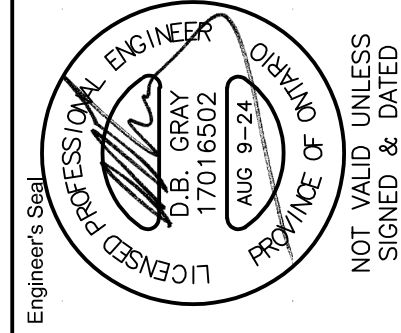

Drawn	D.B.G
H. Scale	1:100
V. Scale	
Date	SEP 27-23
Job No.	23104

Drawing No. C-5 of 5