

1047 RICHMOND RD

PROJECT DESCRIPTION

A PROJECT OF
FENGATE ASSET MANAGEMENT
 2275 UPPER MIDDLE RD. E.,
 SUITE 700
 OAKVILLE, ON L6H 0C3



LANDSCAPE ARCHITECT



20 Champlain Boulevard, Suite 102
 Toronto, ON M3H 2Z1

(416) 638-4911
 info@studiotla.ca
 www.studiotla.ca

CONSULTANTS

RLA/ARCHITECTURE
 56 BEECH STREET
 OTTAWA, ONTARIO, K1S 3J6



STAMP

REVISIONS

2	ISSUED FOR SPA	2024-09-03
1	ISSUED FOR ZBA	2023-07-12

DATE
 2024

PHASE
 SPA

PROJECT NUMBER
 22-178



Sheet List Table

Sheet Number	Sheet Title
LC.000	COVER PAGE
LS.101	LANDSCAPE PLAN-ULTIMATE
LS.102	LANDSCAPE PLAN-INTERIM
LSV.100	SOIL VOLUME NOTES & SCHEDULE
LSV.101	SOIL VOLUME PLAN
LU.100	COMPOSITE UTILITY PLAN
LL.100	LANDSCAPE LIGHTING PLAN
LP.100	PLANTING SCHEDULE AND NOTES
LP.101	PLANTING PLAN
LS.200	LANDSCAPE DETAILS
LS.201	LANDSCAPE DETAILS
LS.202	LANDSCAPE DETAILS
LS.203	LANDSCAPE VIEWS

THE INTENT OF THIS DRAWING IS TO REPRESENT THE ULTIMATE SITE DESIGN FOR PHASE 1 AND PHASE 2.

- LEGEND**
- PLANTING AREA
 - SOD
 - UNIT PAVER
 - HEAVY DUTY UNIT PAVER
 - CONCRETE
 - WOOD DECK
 - PROPERTY LINE
 - BUILDING SETBACK LINE
 - BIKE RACK
 - BENCH
 - CATENARY LIGHTING
 - TACTILE PAVING
 - PROPOSED TREES
 - TREE REMOVAL
 - FIRE HYDRANT
 - VEHICULAR DIRECTION
 - SIAMESE CONNECTION
 - ROAD SIGN

Landscape Architect

STUDIO tla

20 Champlain Blvd, Suite 102 - Toronto ON - M3H 2Z1
(416) 638-4911 - info@studiotla.ca - studiotla.ca

1047 RICHMOND RD

OTTAWA, ON K2B 6R1

Project Number
22-178


Client
FENGATE
2275 UPPER MIDDLE RD. E.,
SUITE 700
OAKVILLE, ON L6H 0C3

Consultant
RLA/ARCHITECTURE
55 Beach Street
OTTAWA, ON K1S3J6, CANADA
TEL: 613.724.9932

Revisions

Rev	Description	Date	By
8	ISSUED FOR SPA	2024-09-03	AK
7	ISSUED FOR COORDINATION	2024-08-30	AK
6	ISSUED FOR COORDINATION	2024-08-27	AK
5	ISSUED FOR COORDINATION	2024-08-21	AK
4	ISSUED FOR UDRP	2024-07-30	AK
3	ISSUED FOR COORDINATION	2024-07-15	AK
2	ISSUED FOR COORDINATION	2024-07-12	AK
1	ISSUED FOR COORDINATION	2024-07-09	AK

Signature
YYYY-MM-DD
Date

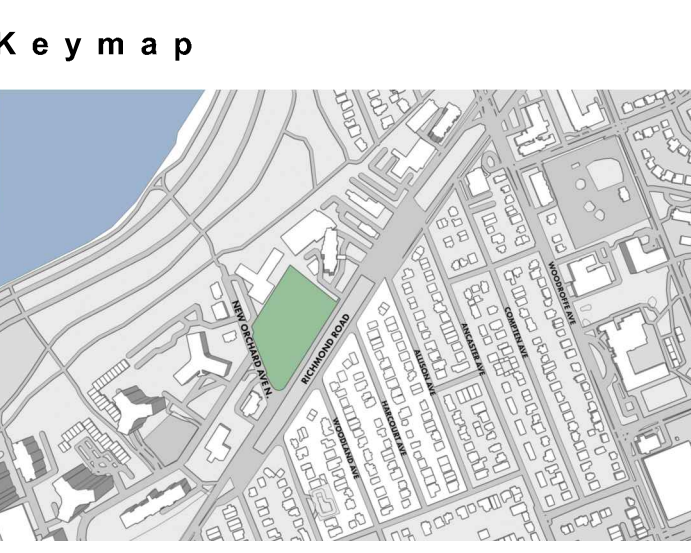

Scale
AS SHOWN

North


Phase
SPA

Date
2024-07-09

Drawing Name
LANDSCAPE PLAN-ULTIMATE

Sheet Number
NOT FOR CONSTRUCTION

LS.101

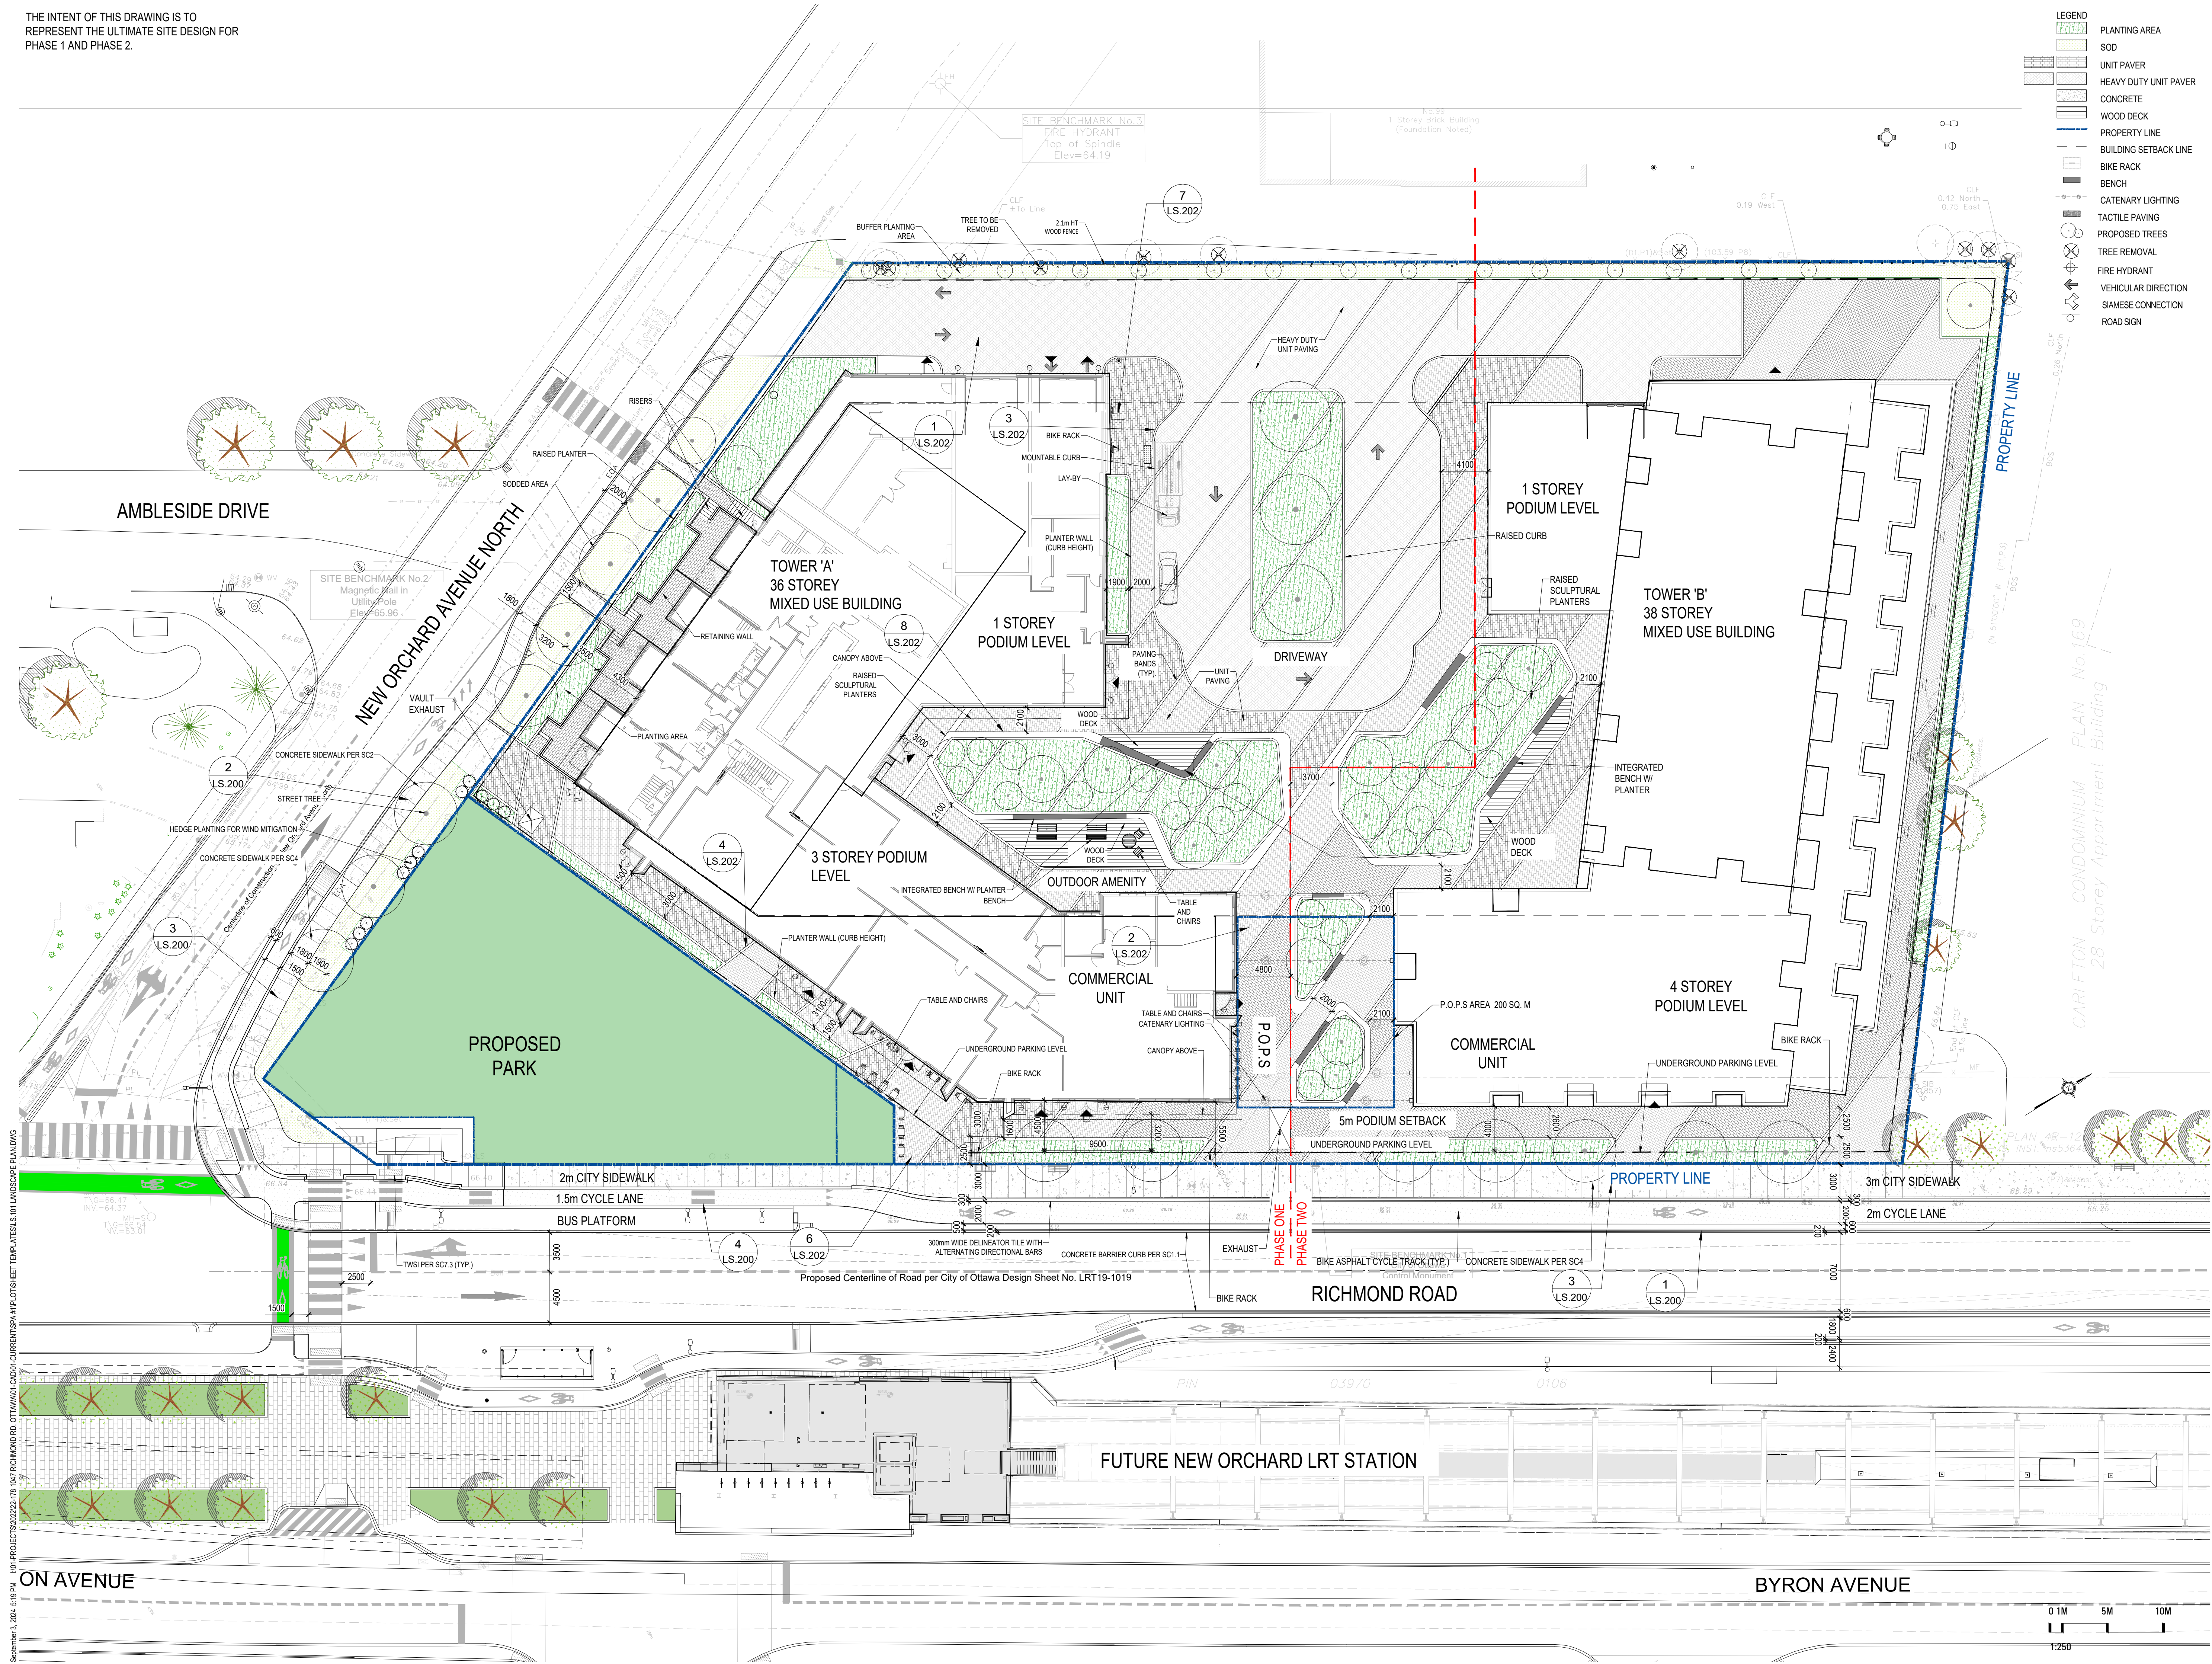

September 3, 2024, 5:19 PM I:\01-PROJECTS\2022\22-178 1047 RICHMOND RD, OTTAWA\CAD\01-CURRENT\SPA\PLOTSHEET TEMPLATES\01 LANDSCAPE PLAN.DWG

1047 RICHMOND RD

OTTAWA, ON K2B 6R1

Project Number
22-178

Client
FENGATE
FENGATE
2275 UPPER MIDDLE RD. E.,
SUITE 700
OAKVILLE, ON L6H 0C3

Consultant
RLA/ARCHITECTURE
55 Beach Street
OTTAWA, ON K1S3J6, CANADA
TEL: 613.724.9932
rla/architecture

Revisions

8	ISSUED FOR SPA	2024-09-03	AK
7	ISSUED FOR COORDINATION	2024-08-30	AK
6	ISSUED FOR COORDINATION	2024-08-27	AK
5	ISSUED FOR COORDINATION	2024-08-21	AK
4	ISSUED FOR UDRP	2024-07-30	AK
3	ISSUED FOR COORDINATION	2024-07-15	AK
2	ISSUED FOR COORDINATION	2024-07-12	AK
1	ISSUED FOR COORDINATION	2024-07-09	AK

 
Signature
YYYY-MM-DD
Date

Key map



Scale
AS SHOWN

North



Phase
SPA

Date
2024-07-09


Drawing Name

LANDSCAPE PLAN-INTERIM

Sheet Number

NOT FOR CONSTRUCTION

LS.102

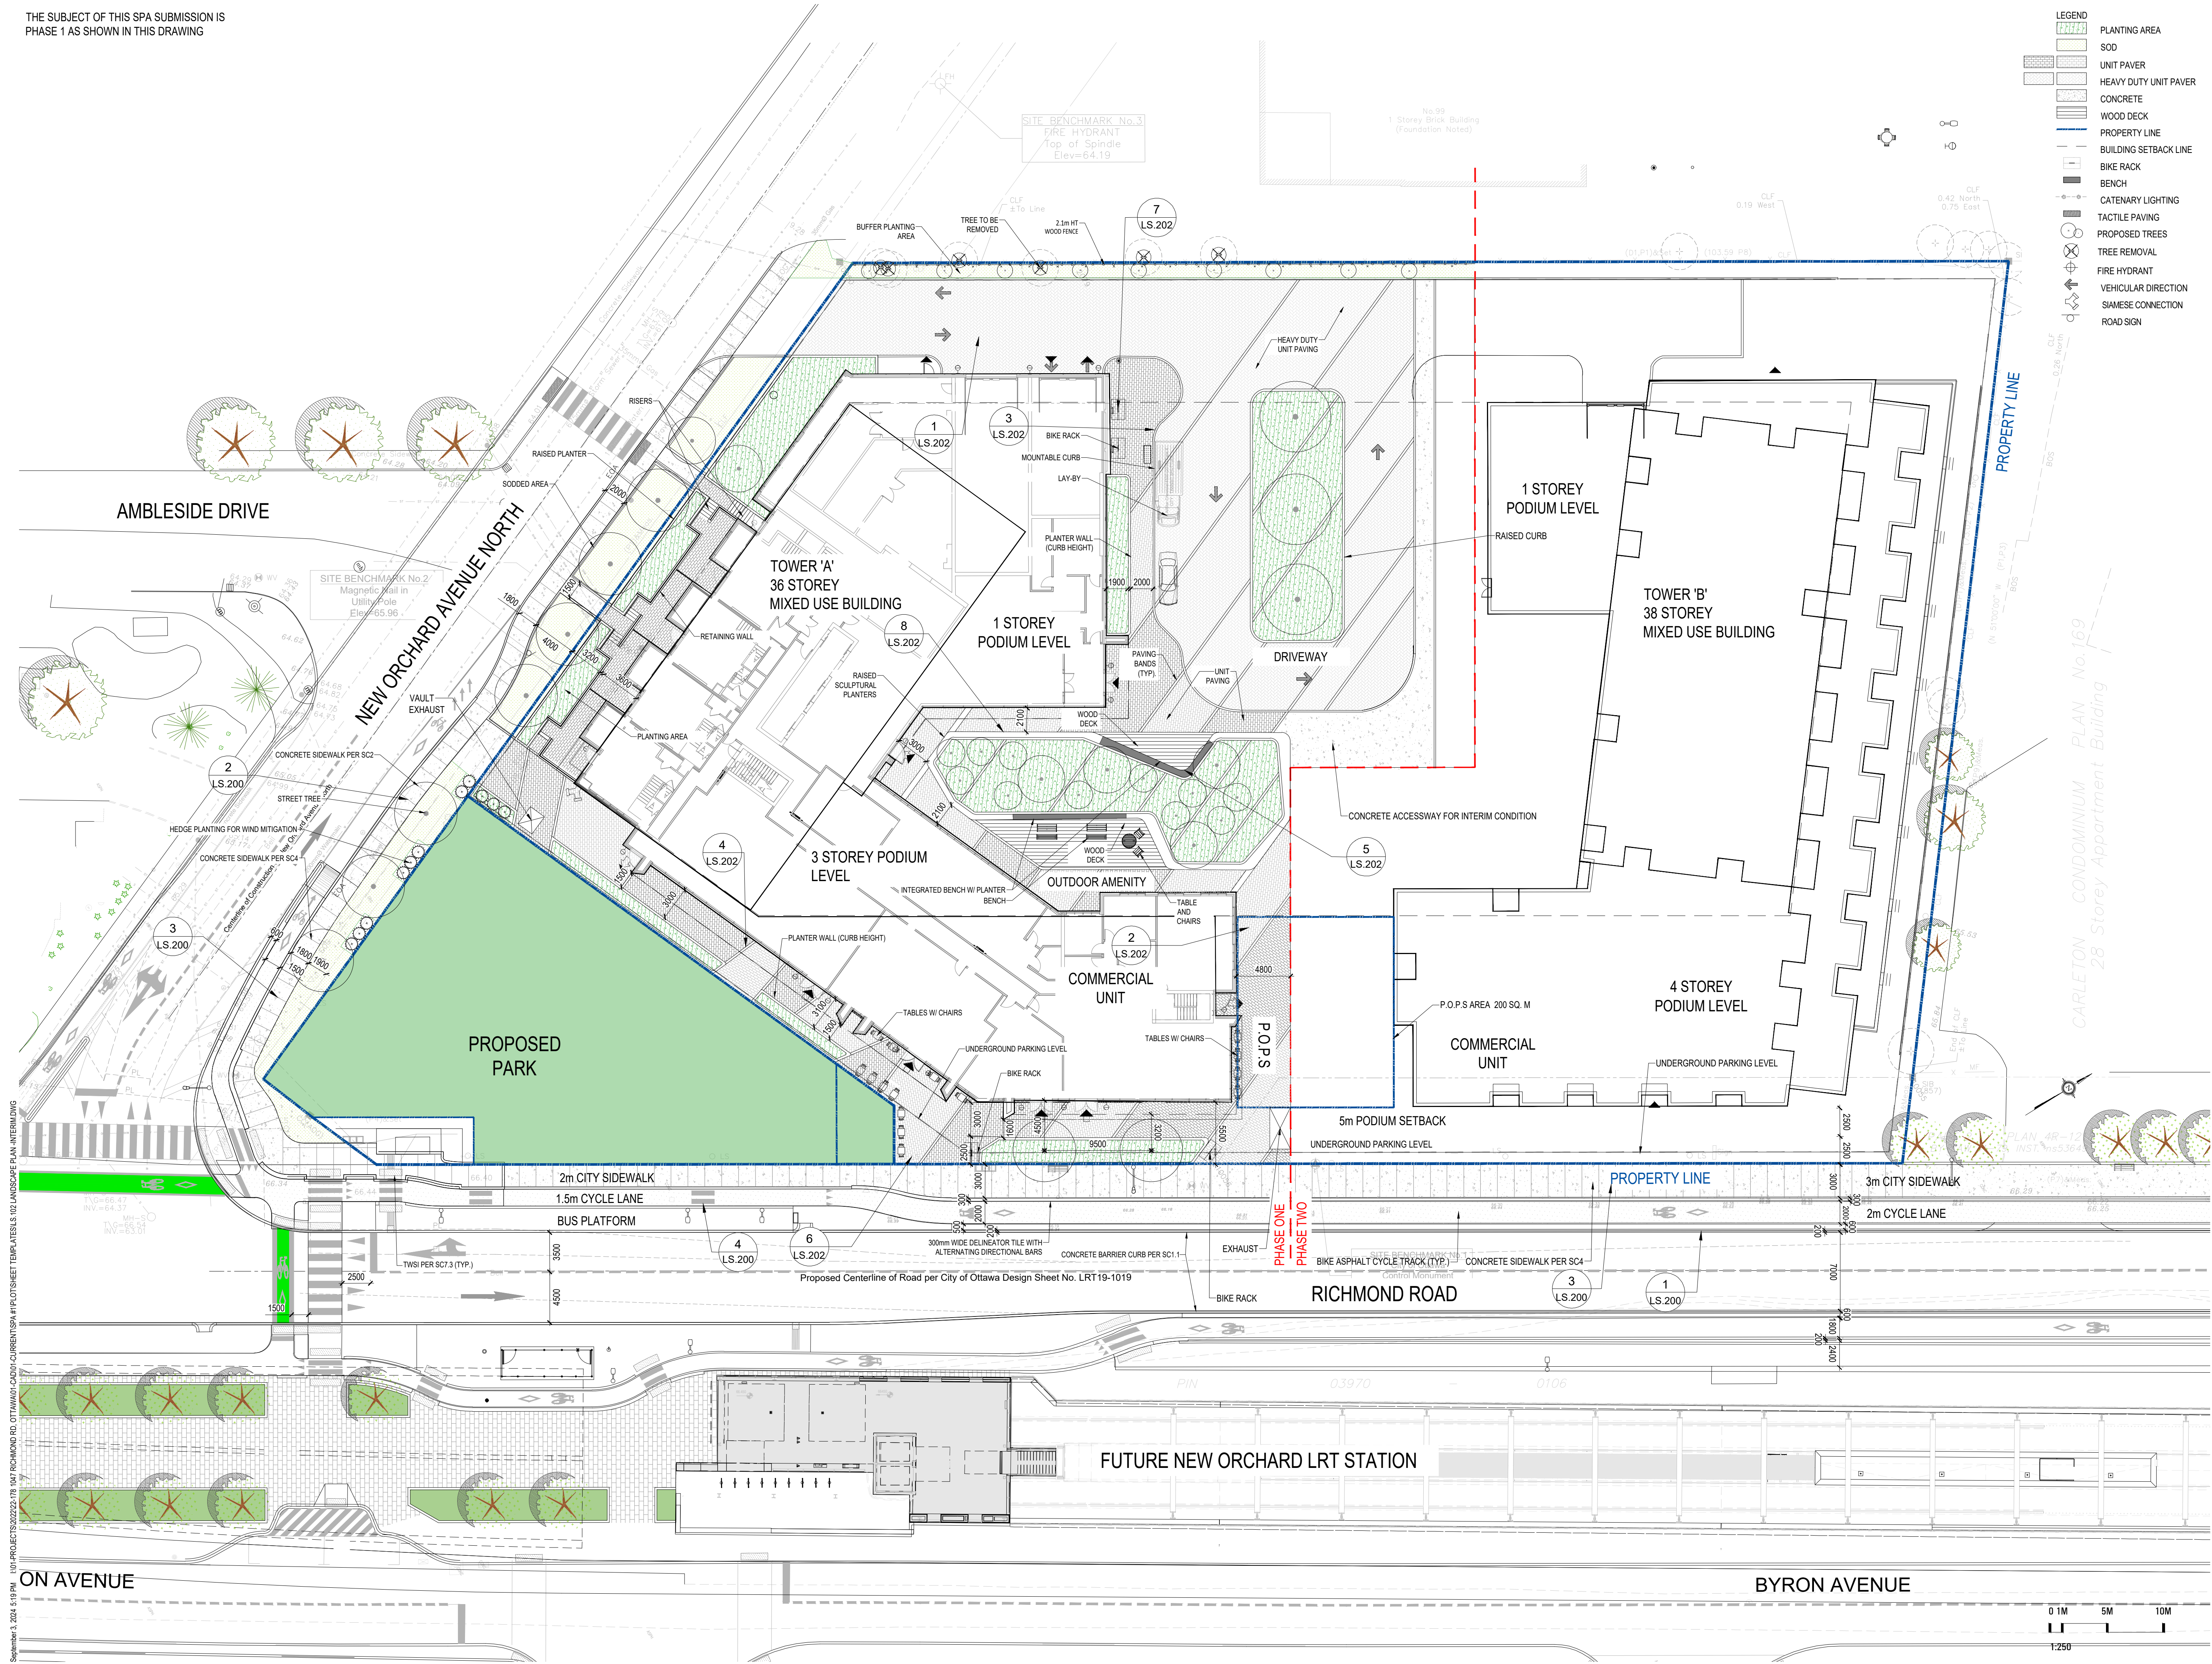

September 3, 2024, 5:19 PM I:\01-PROJECTS\2022\1047 RICHMOND RD, OTTAWA\CAD\CURRENT SPA\PLOTSHEET TEMPLATES\02 LANDSCAPE PLAN-INTERIM.DWG

1047 RICHMOND RD

OTTAWA, ON K2B 6R1

Project Number
22-178

Client **FENGATE**
FENGATE
2275 UPPER MIDDLE RD. E.,
SUITE 700
OAKVILLE, ON L6H 0C3

Consultant **rla/architecture**
ARCHITECTURE
RLA/ARCHITECTURE
55 Beach Street
OTTAWA, ON K1S3J6, CANADA
TEL: 613.724.9932

Revisions

8	ISSUED FOR SPA	2024-09-03	AK
7	ISSUED FOR COORDINATION	2024-08-30	AK
6	ISSUED FOR COORDINATION	2024-08-27	AK
5	ISSUED FOR COORDINATION	2024-08-21	AK
4	ISSUED FOR UDRP	2024-07-30	AK
3	ISSUED FOR COORDINATION	2024-07-15	AK
2	ISSUED FOR COORDINATION	2024-07-12	AK
1	ISSUED FOR COORDINATION	2024-07-09	AK



Signature

Date

YYYY-MM-DD

Key map



Scale North
AS SHOWN

Phase
SPA
Date
2024-07-09

Drawing Name
SOIL VOLUME NOTES & SCHEDULE

Sheet Number
NOT FOR CONSTRUCTION

LSV.100

	Location (City ROW, private property)	Soil Area (m ²)	Soil Depth(m*)	Proposed Soil Volume (m ³)	Tree Quantity	Proposed Soil Volume per tree (m ³)	Ottawa Target Soil Volume per tree (m ³)	Soil Adequacy percentagepp er tree	Soil Cells (Yes/No)
1 (Small Trees)	ROW	39	1.2	46.8	1	46.8	20	234%	No
2 (Large Trees)	ROW	53	1.2	63.6	2	31.8	18	177%	No
3 (Large Trees)	ROW	45	1.2	54	2	27.0	18	150%	No
4 (Large Trees)	ROW	58	1.2	69.6	3	23.2	18	129%	No
5 (Small Treess)	Private Property	59	0.7	41.3	1	41.3	20	207%	No
6 (Large Trees)	Private Property	175	0.5	87.5	3	29.2	18	162%	No
7 (Small Trees)	Private Property	266	1.3	345.8	15	23.1	12	192%	No
8 (Large Trees)	Private Property	39	1	39	2	19.5	18	108%	No
9 (Large Trees)	Private Property	60	1	60	3	20.0	18	111%	Yes
10 (Large Trees)	Private Property	40	1	40	2	20.0	18	111%	Yes
11 (Small Trees)	Private Property	29	1.3	37.7	3	12.6	12	105%	No
12 (Small Trees)	Private Property	32	1.3	41.6	3	13.9	12	116%	No
13 (Small Trees)	Private Property	206	1.3	267.8	12	22.3	12	186%	No
Totals		1101	14.2	1194.7	52	330.6	214	154%	

1047 RICHMOND RD

OTTAWA, ON K2B 6R1

Project Number
22-178

Client
FENGATE
2275 UPPER MIDDLE RD. E.,
SUITE 700
OAKVILLE, ON L6H 0C3

Consultant
RLA/ARCHITECTURE
55 Beach Street
OTTAWA, ON K1S3J6, CANADA
TEL: 613.724.9932



Revisions

8	ISSUED FOR SPA	2024-09-03	AK
7	ISSUED FOR COORDINATION	2024-08-30	AK
6	ISSUED FOR COORDINATION	2024-08-27	AK
5	ISSUED FOR COORDINATION	2024-08-21	AK
4	ISSUED FOR UDRP	2024-07-30	AK
3	ISSUED FOR COORDINATION	2024-07-15	AK
2	ISSUED FOR COORDINATION	2024-07-12	AK
1	ISSUED FOR COORDINATION	2024-07-09	AK




Signature
YYYY-MM-DD
Date

Key map



Scale
AS SHOWN

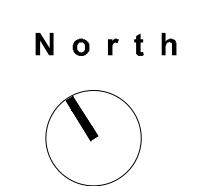


Phase
SPA
Date
2024-07-09

Drawing Name
SOIL VOLUME PLAN

Sheet Number
NOT FOR CONSTRUCTION

LSV.101

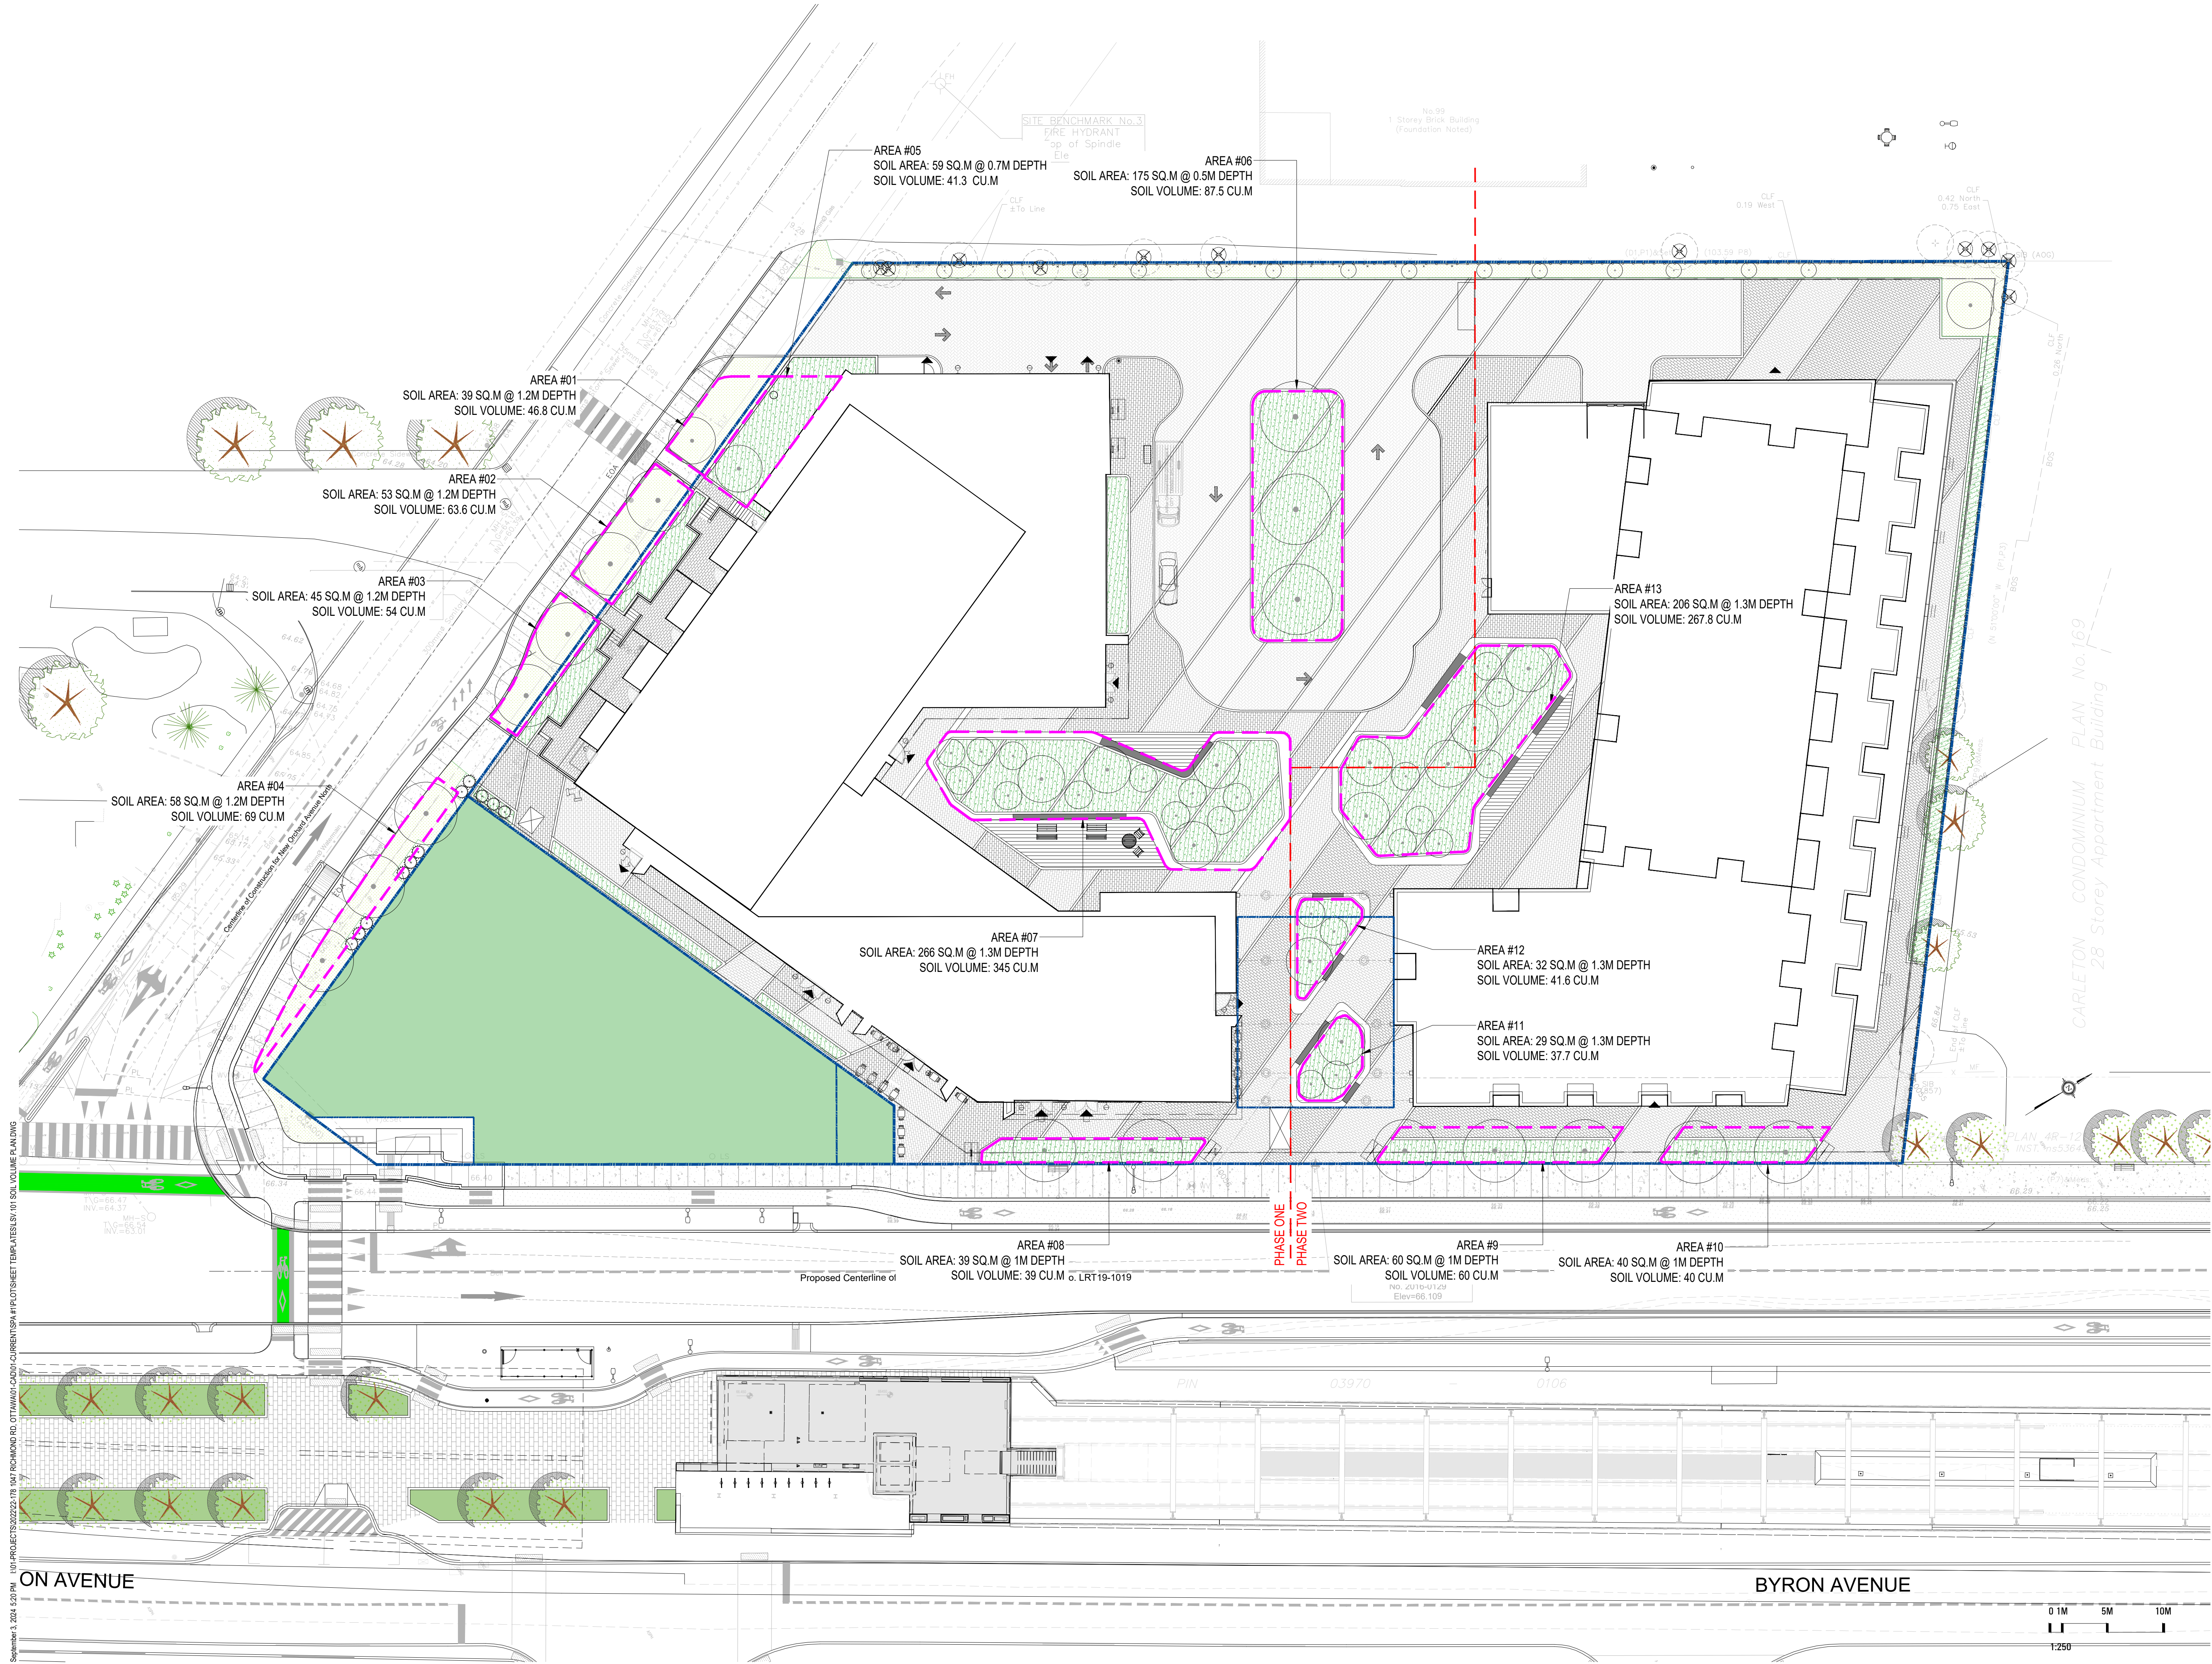

September 3, 2024 5:20 PM I:\01-PROJECTS\2022\178-1047 RICHMOND RD, OTTAWA\CAD\04-CURRENT\SPA\PLOTSHEET\TEMPLATES\SV\01 SOIL VOLUME PLAN.DWG

1047 RICHMOND RD

OTTAWA, ON K2B 6R1

Project Number
22-178

Client
FENGATE
2275 UPPER MIDDLE RD. E.,
SUITE 700
OAKVILLE, ON L6H 0C3

Consultant
ARCHITECTURE
rla/architecture
56 Beach Street
OTTAWA, ON K1S3J6, CANADA
TEL: 613.724.9932


Revisions

8	ISSUED FOR SPA	2024-09-03	AK
7	ISSUED FOR COORDINATION	2024-08-30	AK
6	ISSUED FOR COORDINATION	2024-08-27	AK
5	ISSUED FOR COORDINATION	2024-08-21	AK
4	ISSUED FOR UDRP	2024-07-30	AK
3	ISSUED FOR COORDINATION	2024-07-15	AK
2	ISSUED FOR COORDINATION	2024-07-12	AK
1	ISSUED FOR COORDINATION	2024-07-09	AK




Signature
YYYY-MM-DD
Date

Key map

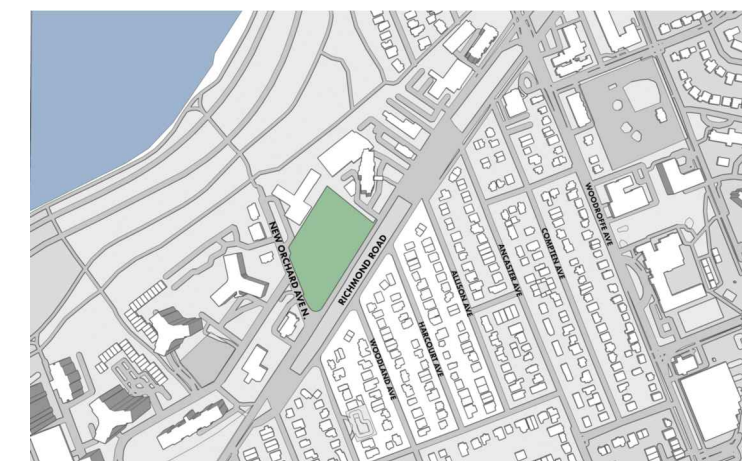

Scale
AS SHOWN

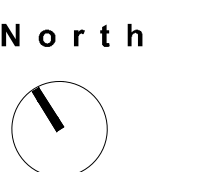

Phase
SPA

Date
2024-07-09


Drawing Name

COMPOSITE UTILITY PLAN

Sheet Number

NOT FOR CONSTRUCTION

LU.100

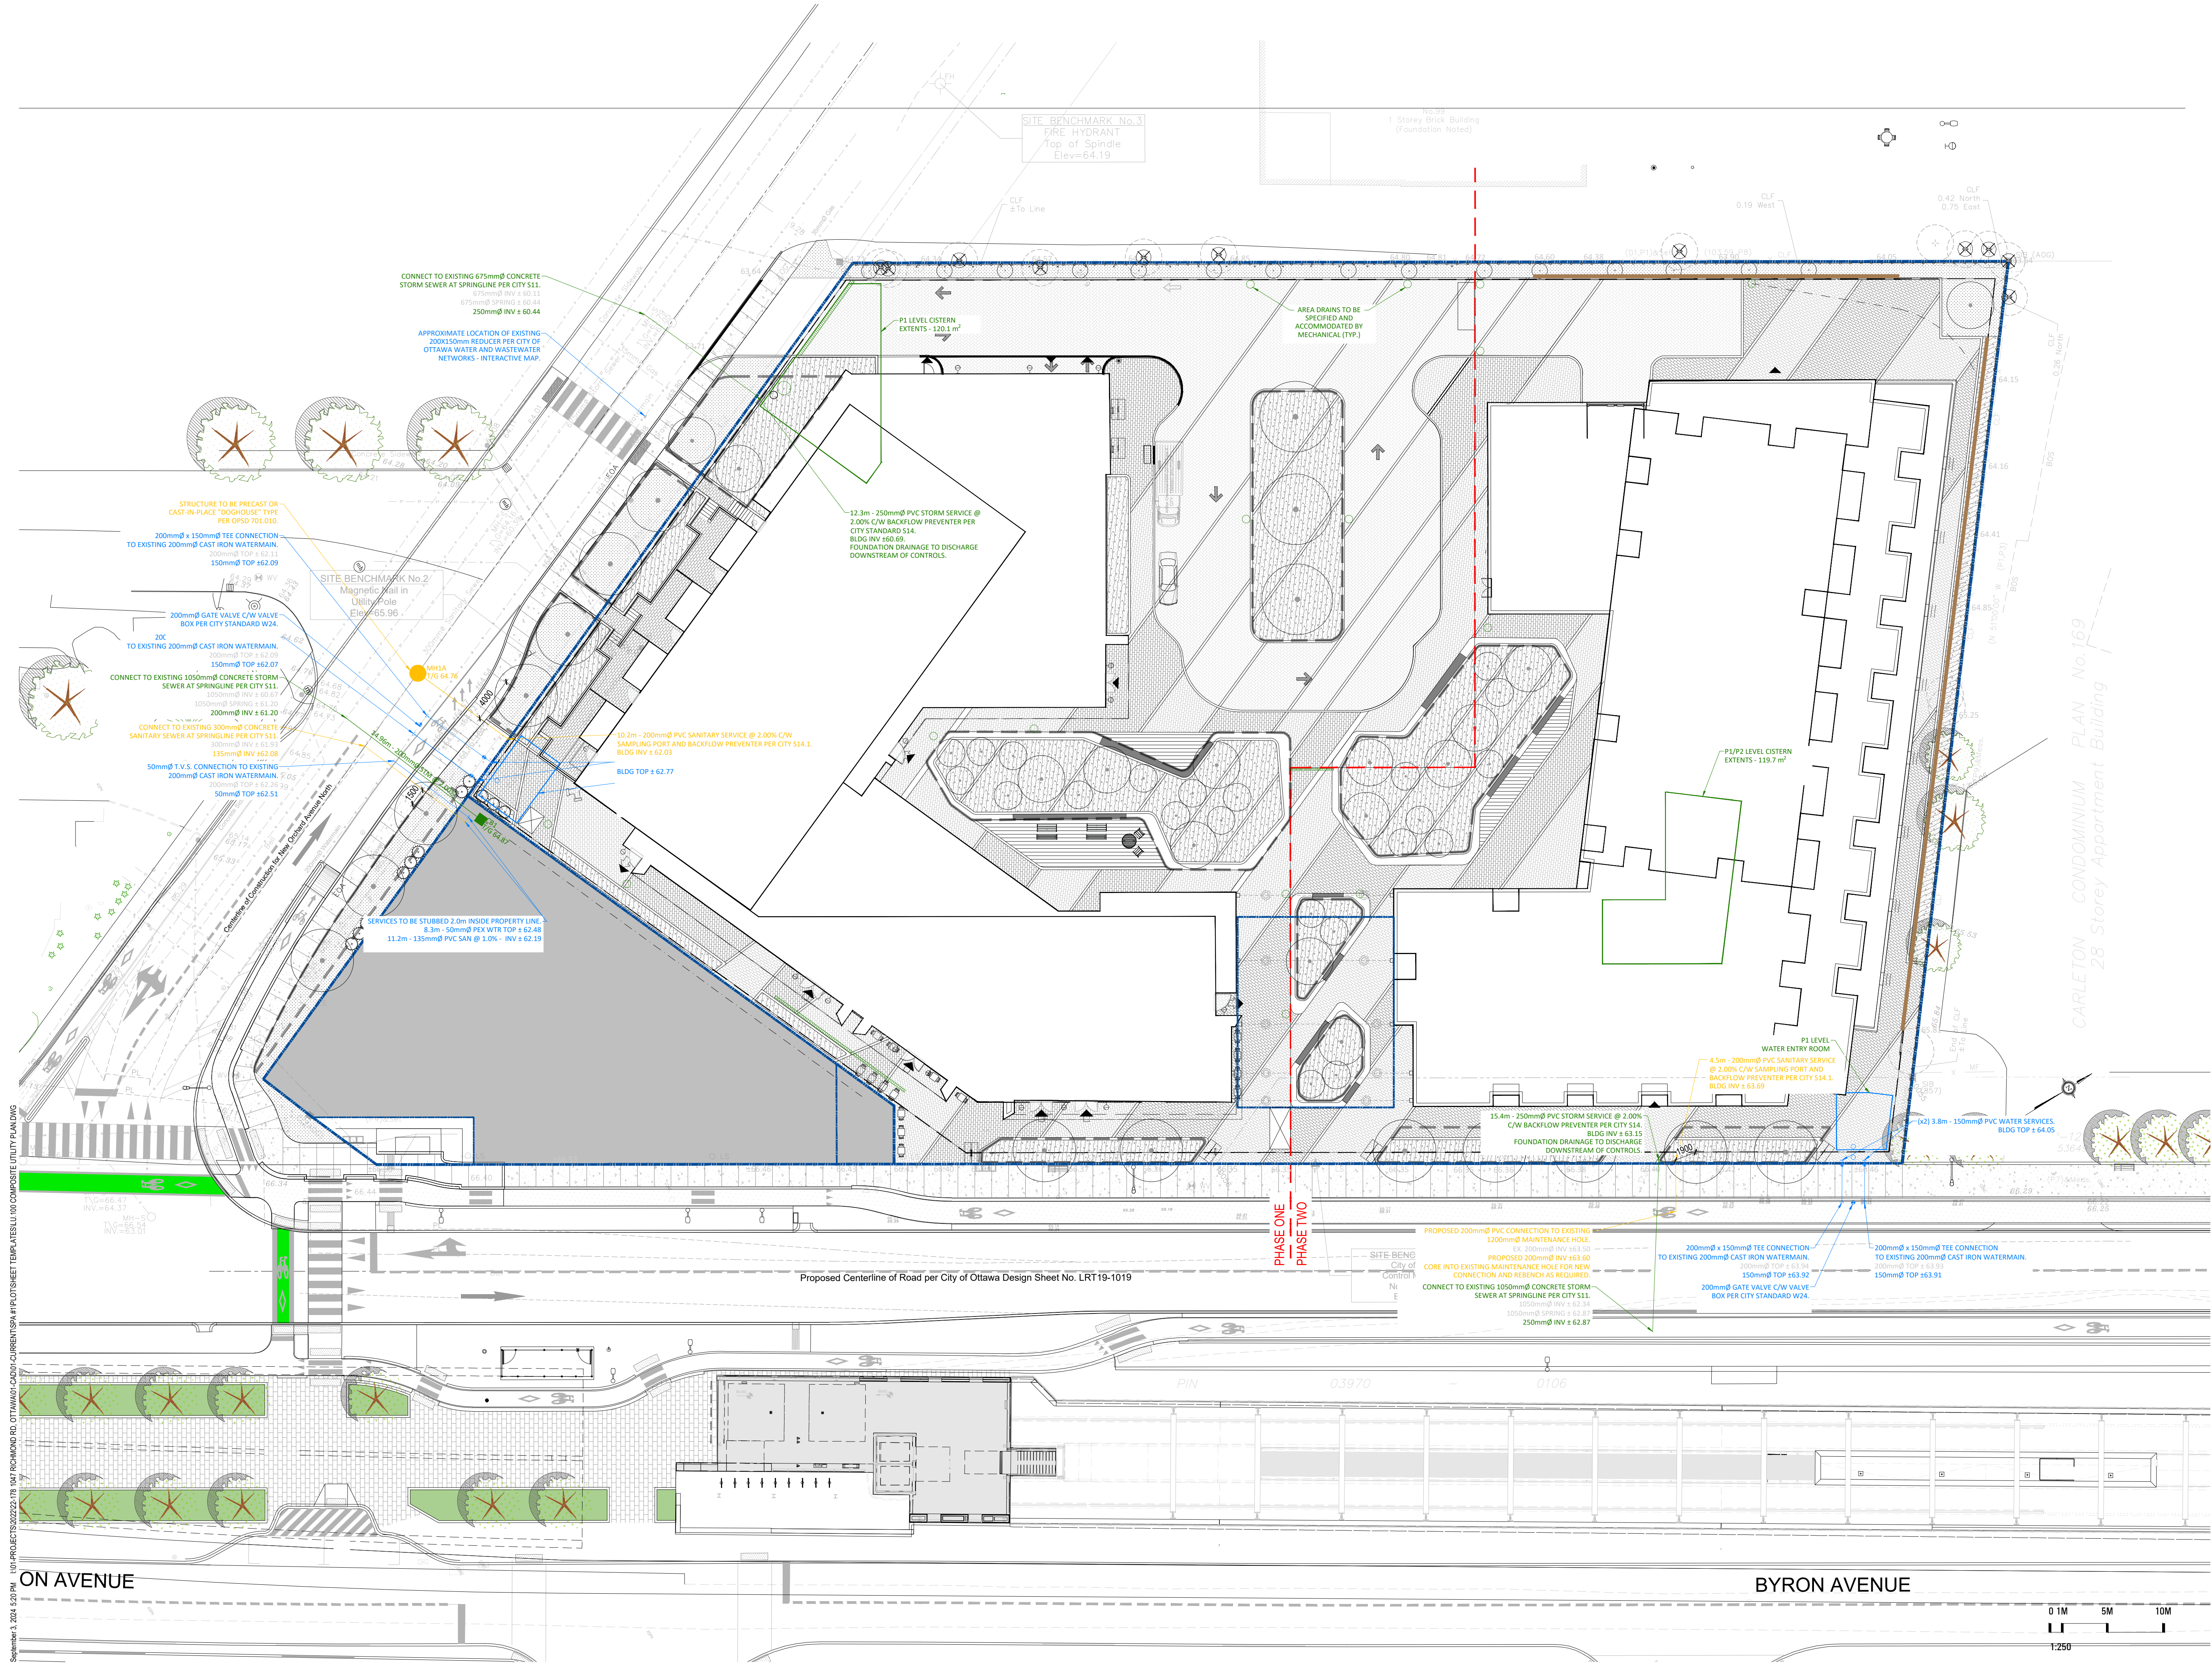

September 3, 2024 5:20 PM I:\01-PROJECTS\2022\21-18 1047 RICHMOND RD, OTTAWA\CAD\DWG\CURRENTS\SP\PILOTS\LU.100-COMPOSITE UTILITY PLAN.DWG

1047 RICHMOND RD

OTTAWA, ON K2B 6R1

Project Number
22-178

Client
FENGATE
2275 UPPER MIDDLE RD. E.,
SUITE 700
OAKVILLE, ON L6H 0C3

Consultant
R/L ARCHITECTURE
58 Beach Street
OTTAWA, ON K1S3J6, CANADA
TEL: 613.724.9932




Revisions

8	ISSUED FOR SPA	2024-09-03	AK
7	ISSUED FOR COORDINATION	2024-08-30	AK
6	ISSUED FOR COORDINATION	2024-08-27	AK
5	ISSUED FOR COORDINATION	2024-08-21	AK
4	ISSUED FOR UDRP	2024-07-30	AK
3	ISSUED FOR COORDINATION	2024-07-15	AK
2	ISSUED FOR COORDINATION	2024-07-12	AK
1	ISSUED FOR COORDINATION	2024-07-09	AK




Signature
YYYY-MM-DD
Date

Key map

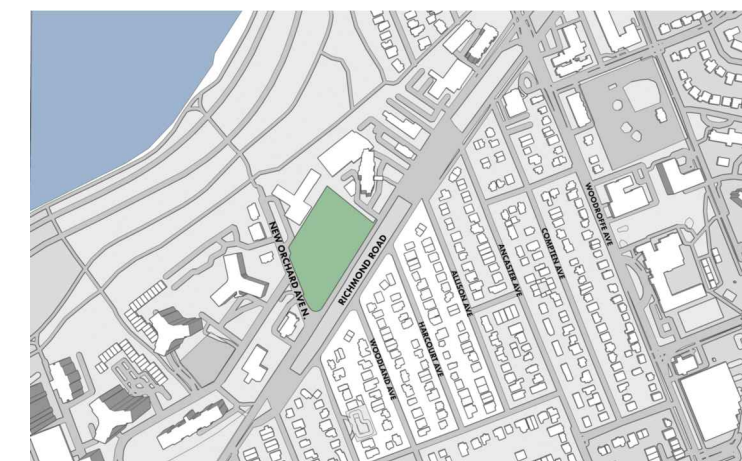

Scale
AS SHOWN

North

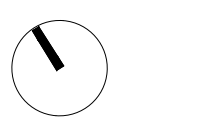

Phase
SPA

Date
2024-07-09

Drawing Name
LANDSCAPE LIGHTING PLAN


Sheet Number

NOT FOR CONSTRUCTION

LL.100

- LEGEND
- BOLLARD
 - LED LIGHT POLE
 - IN-WALL RECESSED LIGHT

NOTE:
REFER TO ELECTRICAL ENGINEER'S PHOTOMETRIC
PLAN FOR LIGHTING CALCULATIONS.

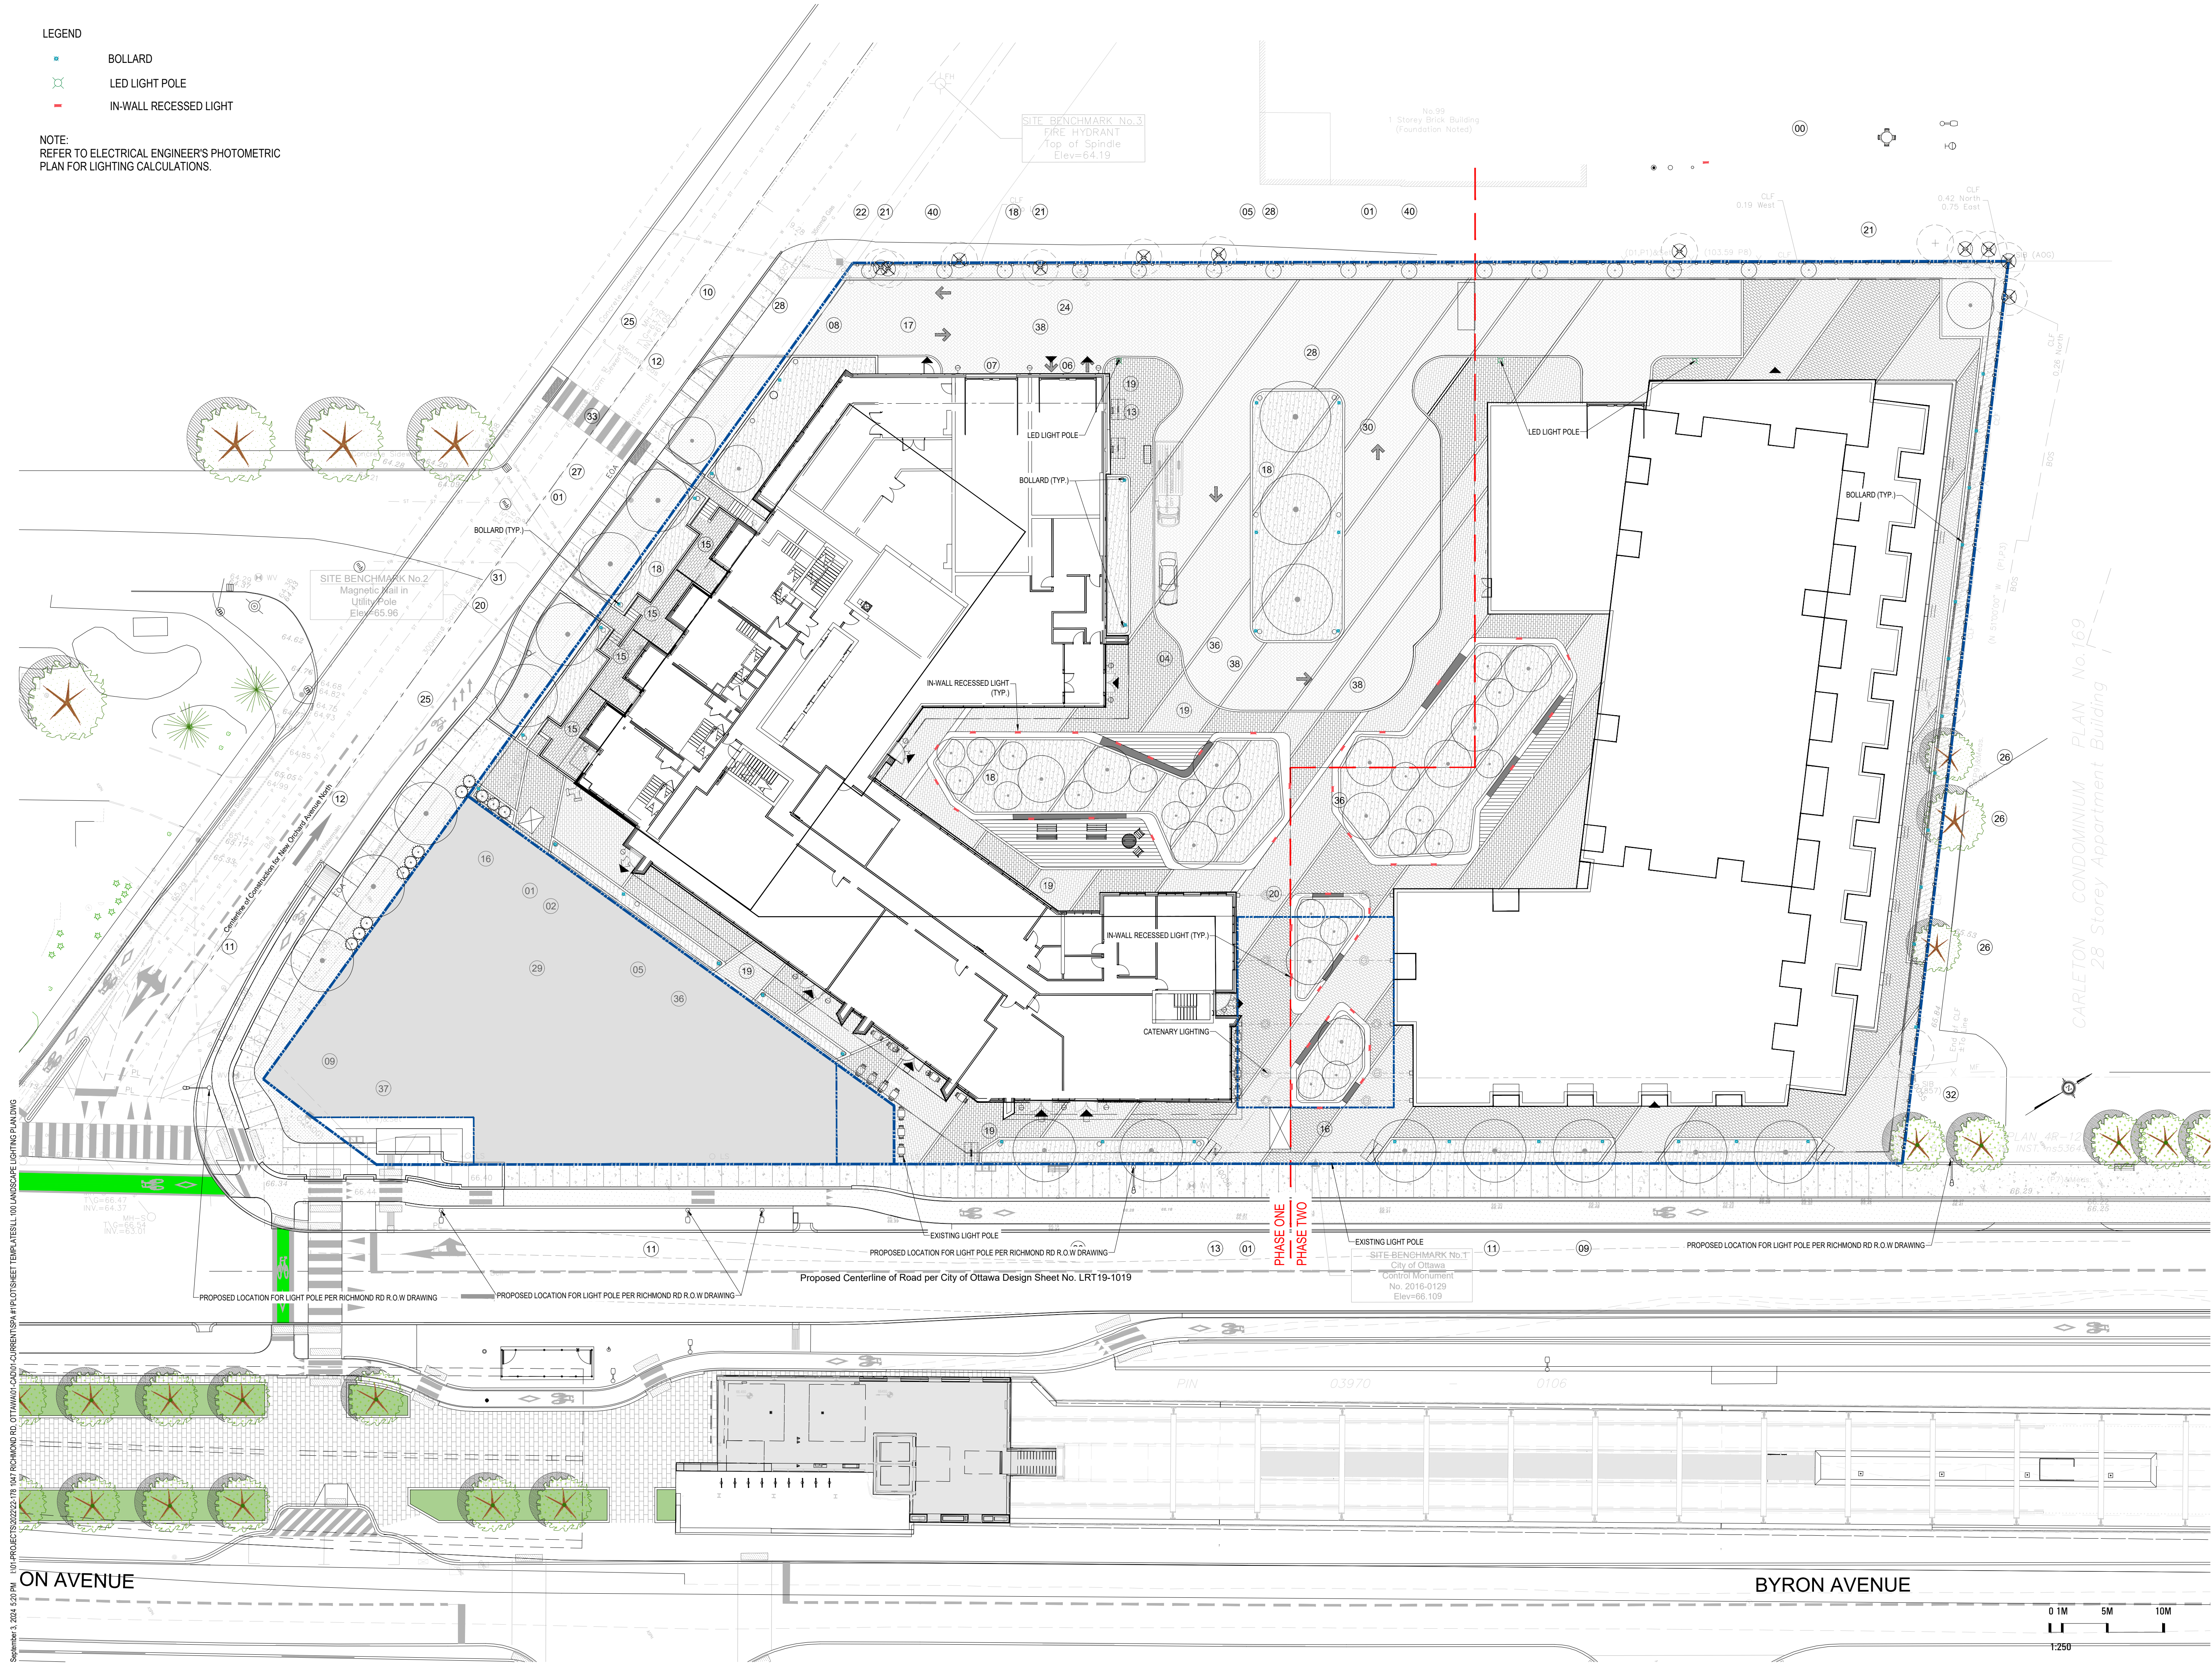

September 3, 2024 5:20 PM I:\01-PROJECTS\2022\22-178 1047 RICHMOND RD, OTTAWA\CAD\01-CURRENT\SPA\PILOTSHEET\100-LANDSCAPE LIGHTING PLAN.DWG

PLANT SCHEDULE							
SYMBOL	CODE	QTY	BOTANICAL NAME	COMMON NAME	CONT.	CAL.	REMARKS
TREES							
	AX	4	ACER X FREEMANII	FREEMAN MAPLE	B&B	60MM CAL.	
	AA	10	AMELANCHIER ARBOREA	DOWNY SERVICEBERRY	B&B	60MM CAL.	NATIVE TO ONTARIO
	CO	3	CELTIS OCCIDENTALIS	COMMON HACKBERRY	B&B	60MM CAL.	NATIVE TO ONTARIO
	CC	7	CRATAEGUS CRUS-GALLI	COCKSPUR HAWTHORN	B&B	60MM CAL.	NATIVE TO ONTARIO
	PW	6	PRUNUS SEROTINA	BLACK CHERRY	B&B	60MM CAL.	NATIVE TO ONTARIO
	QR	3	QUERCUS RUBRA	NORTHERN RED OAK	B&B	70MM CAL.	NATIVE TO ONTARIO
SYMBOL	CODE	QTY	BOTANICAL NAME	COMMON NAME	CONT.	HT.	REMARKS
SHRUBS							
	Jj	20	JUNIPERUS COMMUNIS	COMMON JUNIPER	2 GAL.		
	Rt	9	RHUS TYPHINA	STAGHORN SUMAC	2 GAL.		

1047 RICHMOND RD

OTTAWA, ON K2B 6R1

Project Number
22-178

Client
FENGATE
2275 UPPER MIDDLE RD. E.,
SUITE 700
OAKVILLE, ON L6H 0C3

Consultant

ARCHITECTURE
RLA/ARCHITECTURE
55 Beach Street
OTTAWA, ON K1S3J6, CANADA
TEL: 613.724.9932



Revisions

8	ISSUED FOR SPA	2024-09-03	AK
7	ISSUED FOR COORDINATION	2024-08-30	AK
6	ISSUED FOR COORDINATION	2024-08-27	AK
5	ISSUED FOR COORDINATION	2024-08-21	AK
4	ISSUED FOR UDRP	2024-07-30	AK
3	ISSUED FOR COORDINATION	2024-07-15	AK
2	ISSUED FOR COORDINATION	2024-07-12	AK
1	ISSUED FOR COORDINATION	2024-07-09	AK




Signature

Date

YYYY-MM-DD

Keymap

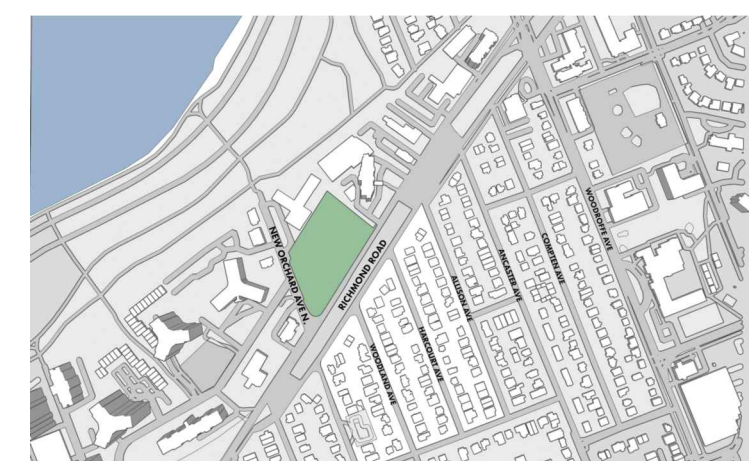

Scale
AS SHOWN



Phase
SPA

Date
2024-07-09

Drawing Name

PLANTING SCHEDULE AND NOTES

Sheet Number

NOT FOR CONSTRUCTION

LP.100

1047 RICHMOND RD

OTTAWA, ON K2B 6R1

Project Number
22-178

Client
FENGATE
FENGATE
2275 UPPER MIDDLE RD. E.,
SUITE 700
OAKVILLE, ON L6H 0C3

Consultant
ARCHITECTURE
RLA/ARCHITECTURE
55 Beach Street
OTTAWA, ON K1S3J6, CANADA
TEL: 613.724.9932



Revisions

8	ISSUED FOR SPA	2024-09-03	AK
7	ISSUED FOR COORDINATION	2024-08-30	AK
6	ISSUED FOR COORDINATION	2024-08-27	AK
5	ISSUED FOR COORDINATION	2024-08-21	AK
4	ISSUED FOR UDRP	2024-07-30	AK
3	ISSUED FOR COORDINATION	2024-07-15	AK
2	ISSUED FOR COORDINATION	2024-07-12	AK
1	ISSUED FOR COORDINATION	2024-07-09	AK




Signature
YYYY-MM-DD
Date

Key map



Scale
AS SHOWN

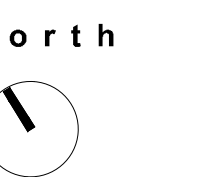

Phase
SPA

Date
2024-07-09


Drawing Name

PLANTING PLAN


Sheet Number

NOT FOR CONSTRUCTION


LP.101

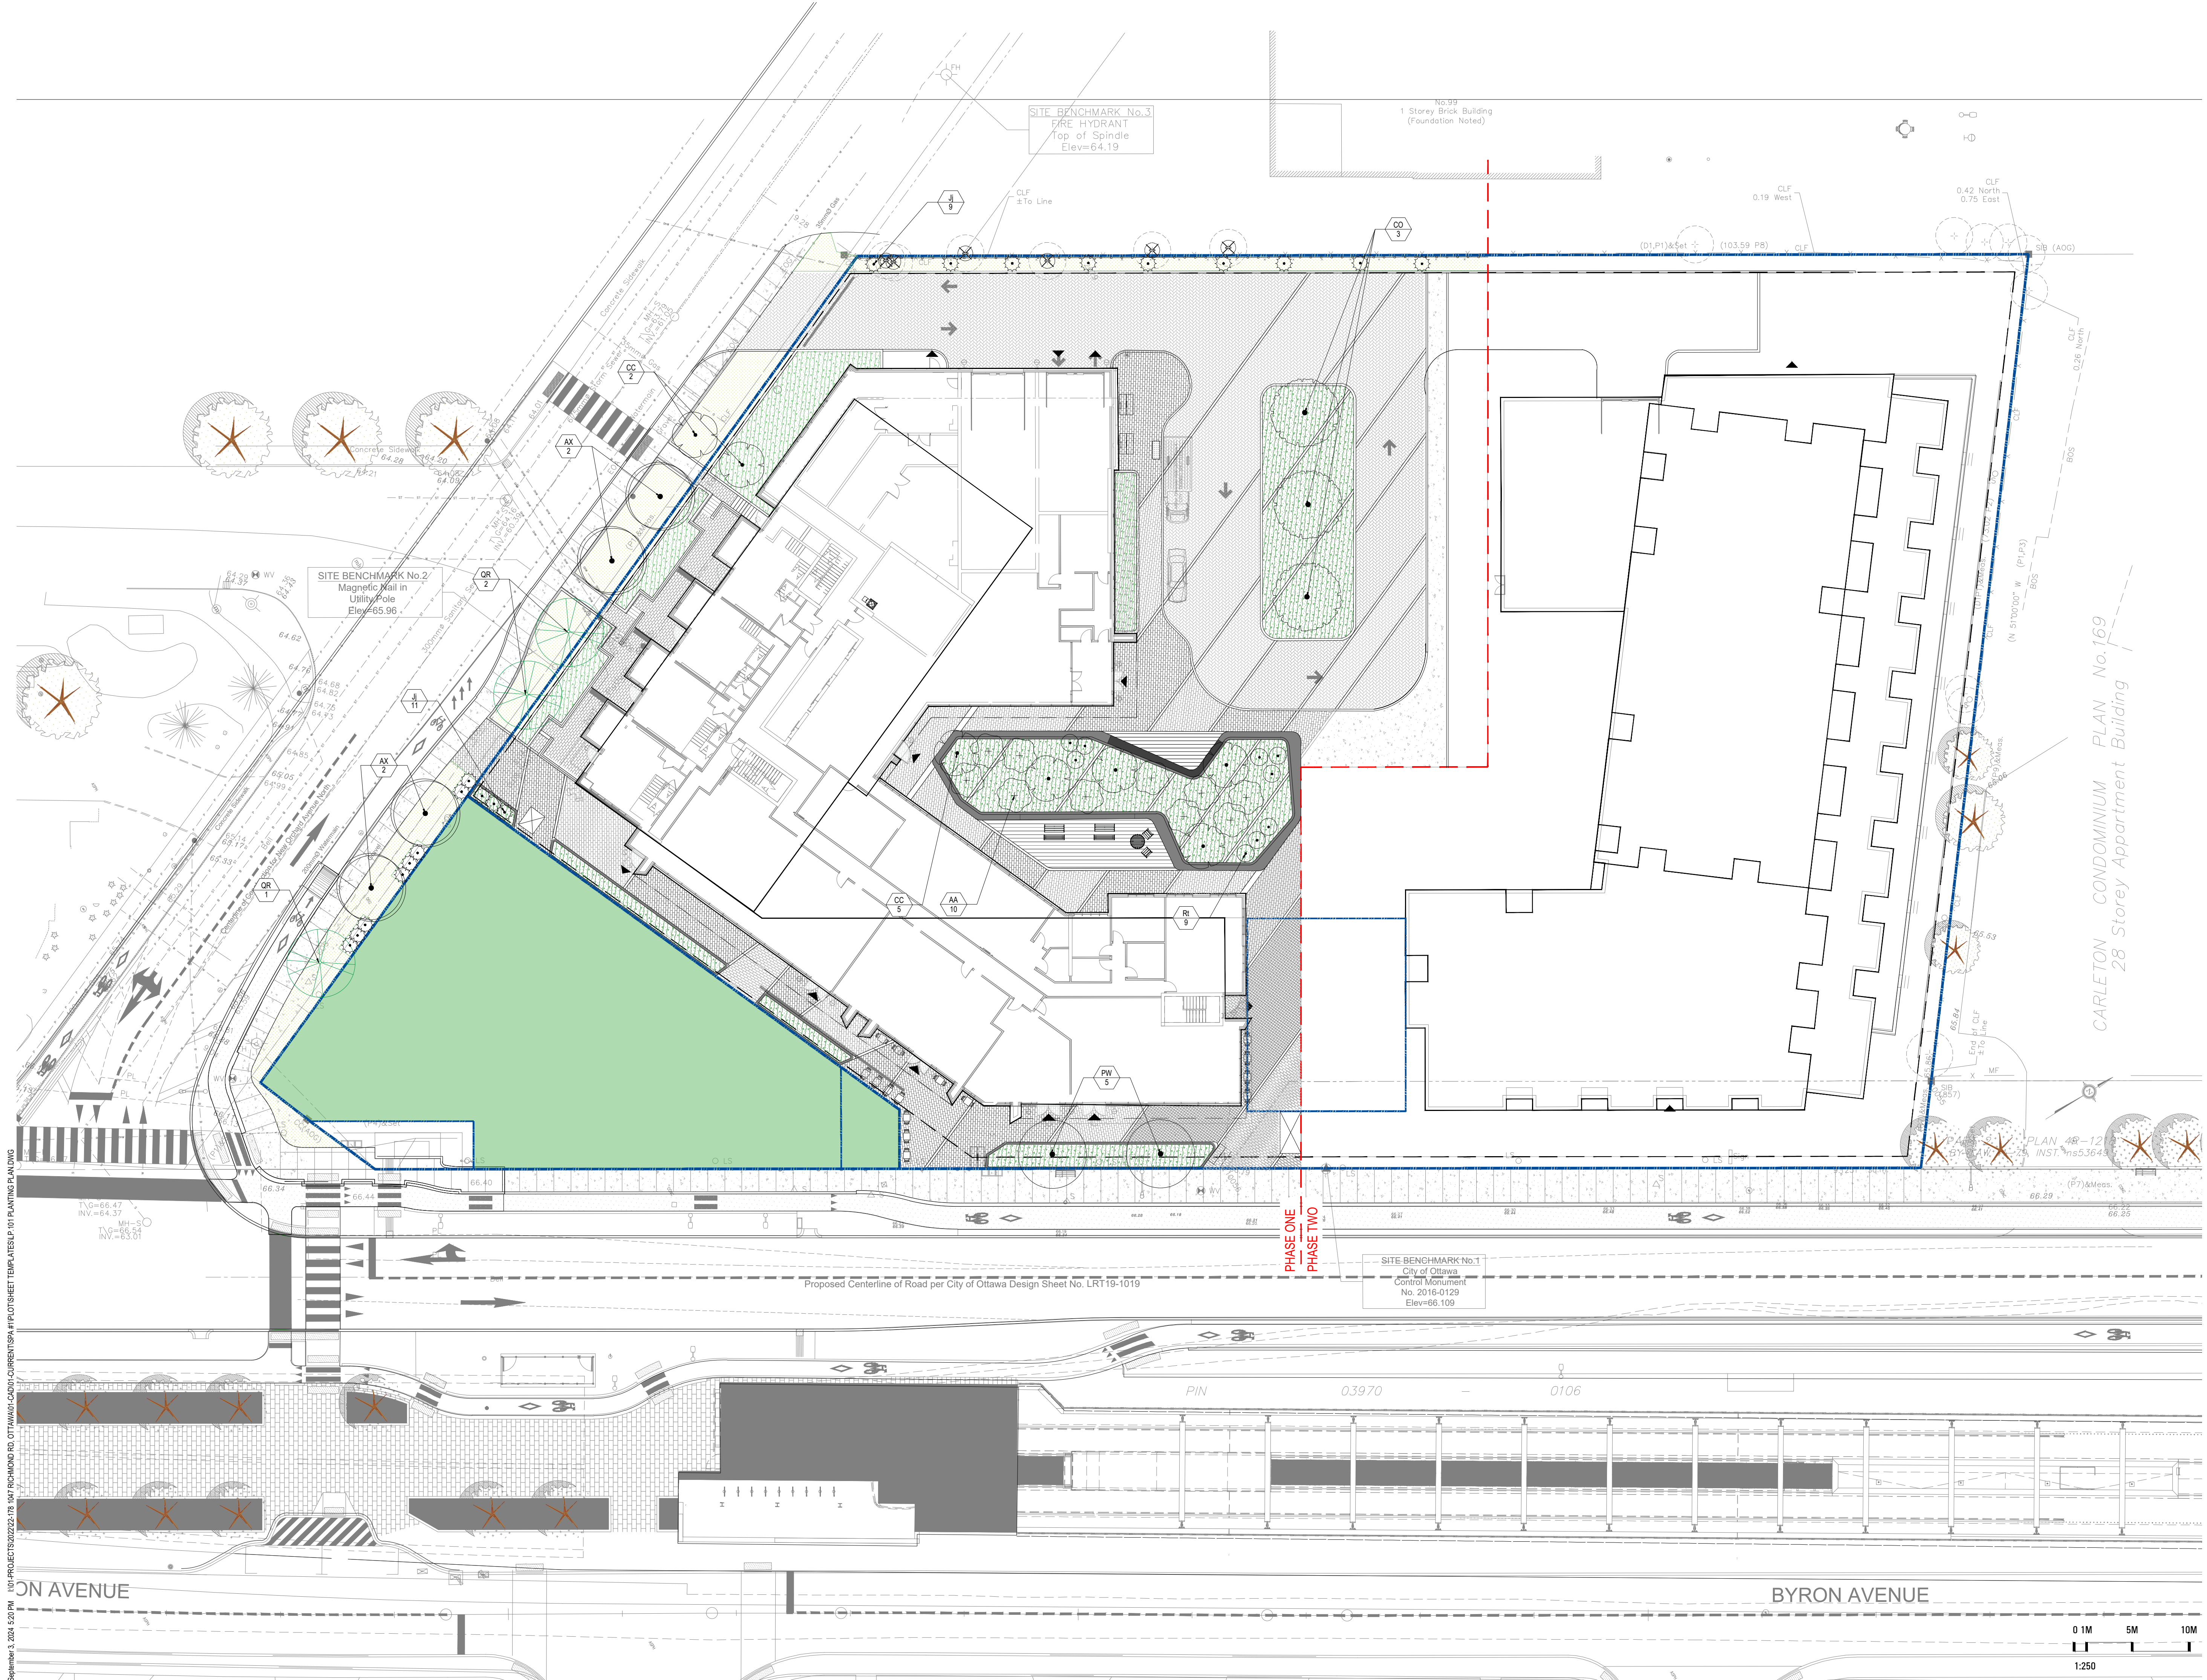


September 3, 2024 5:20 PM I:\01-PROJECTS\2022\21-1047 RICHMOND RD, OTTAWA\CDU\CURRENT\SPA\PLOT SHEET TEMPLATES\LP.101 PLANTING PLAN.DWG

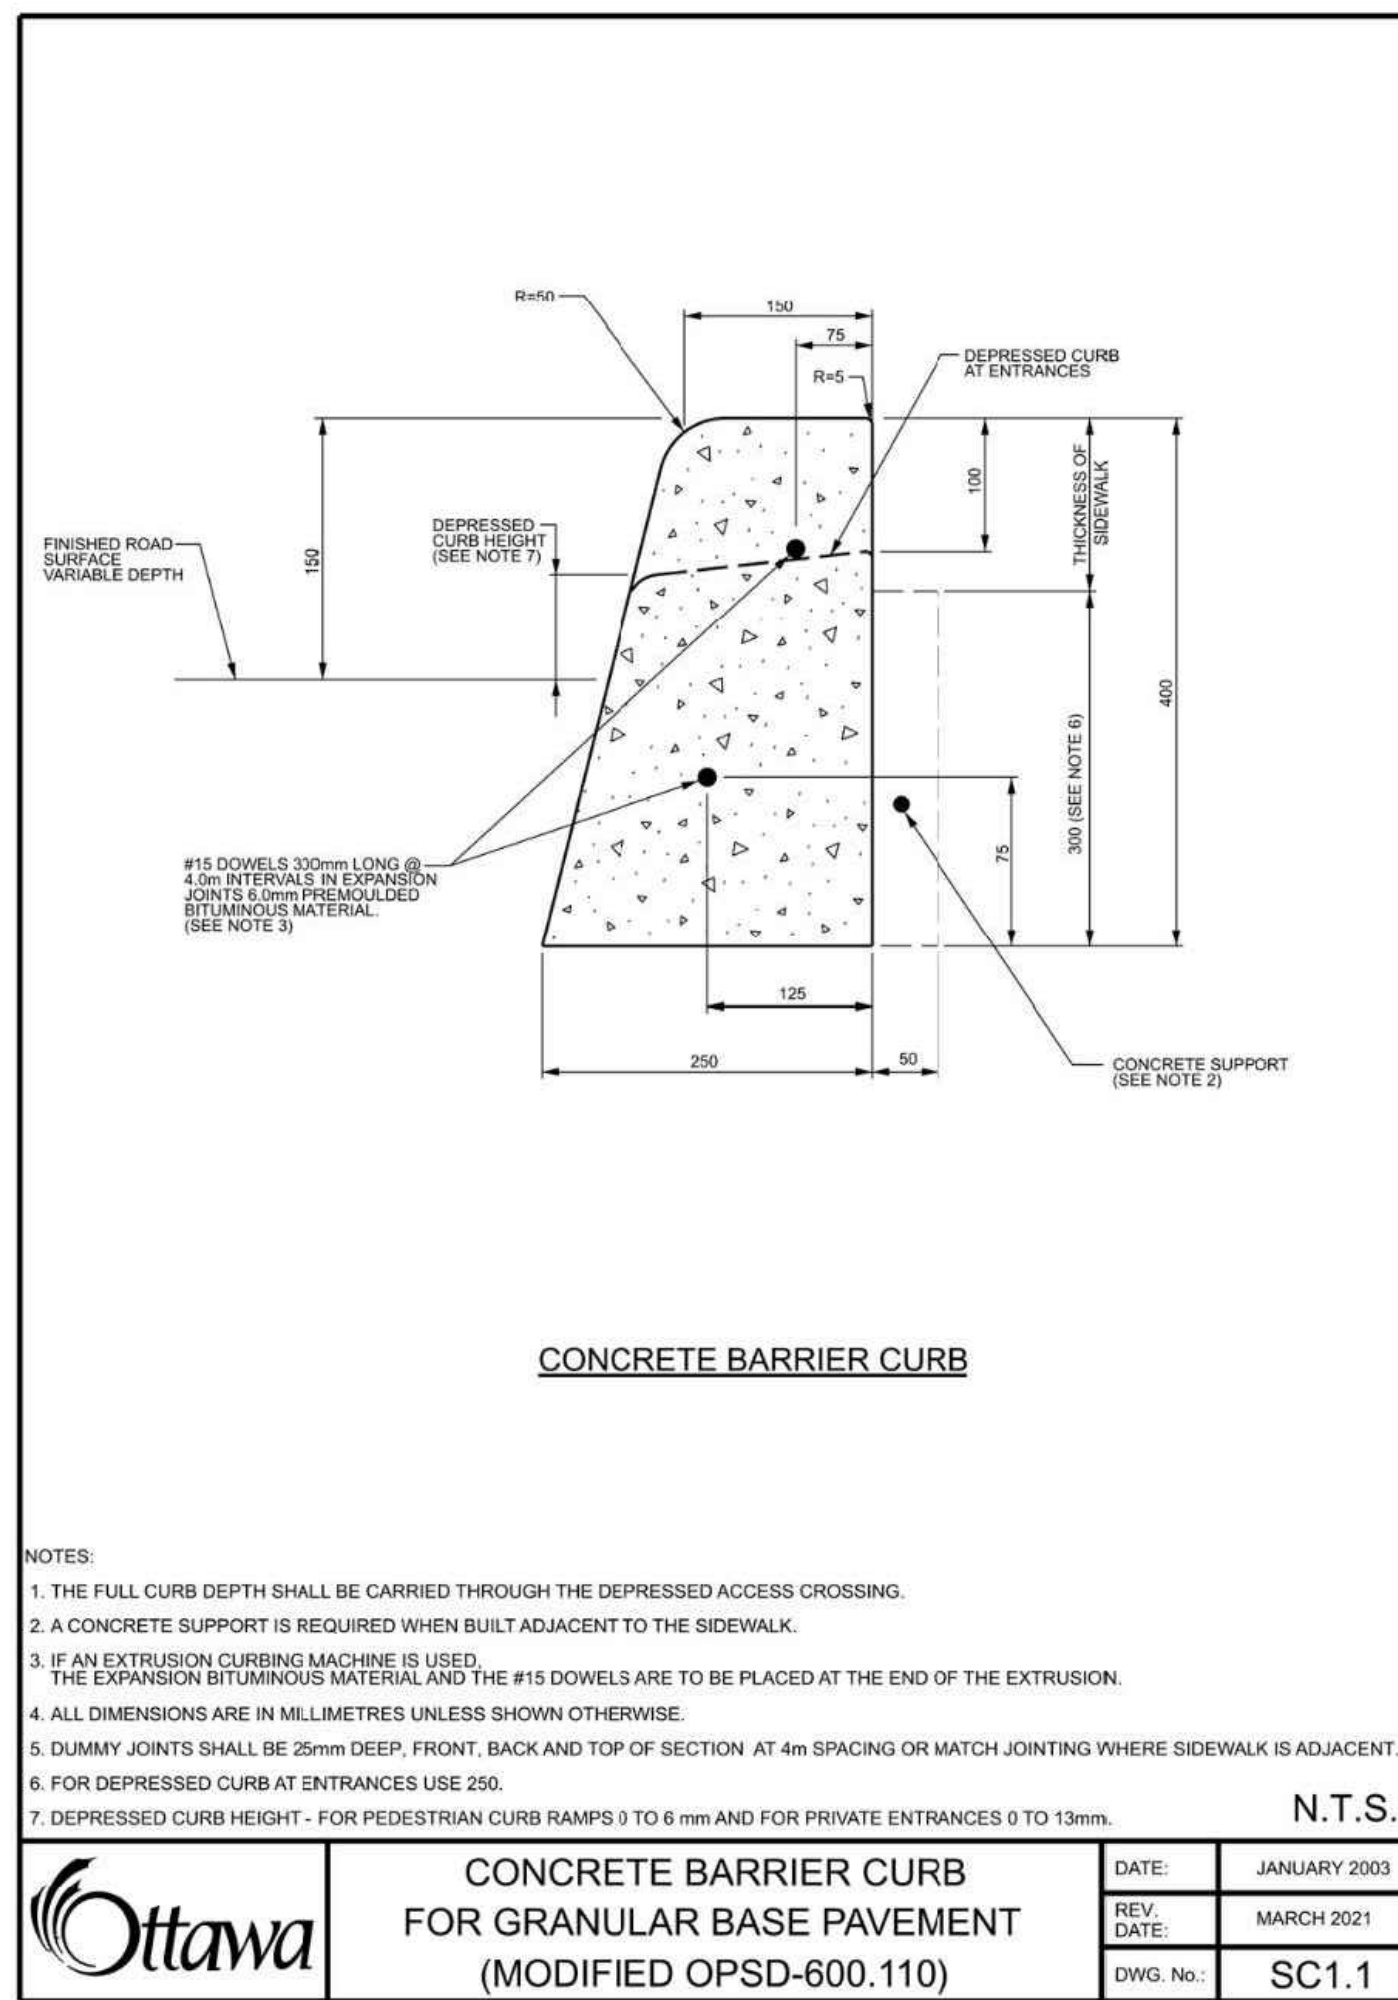


1 CONCRETE BARRIER CURB. SC 1.1
N.T.S.

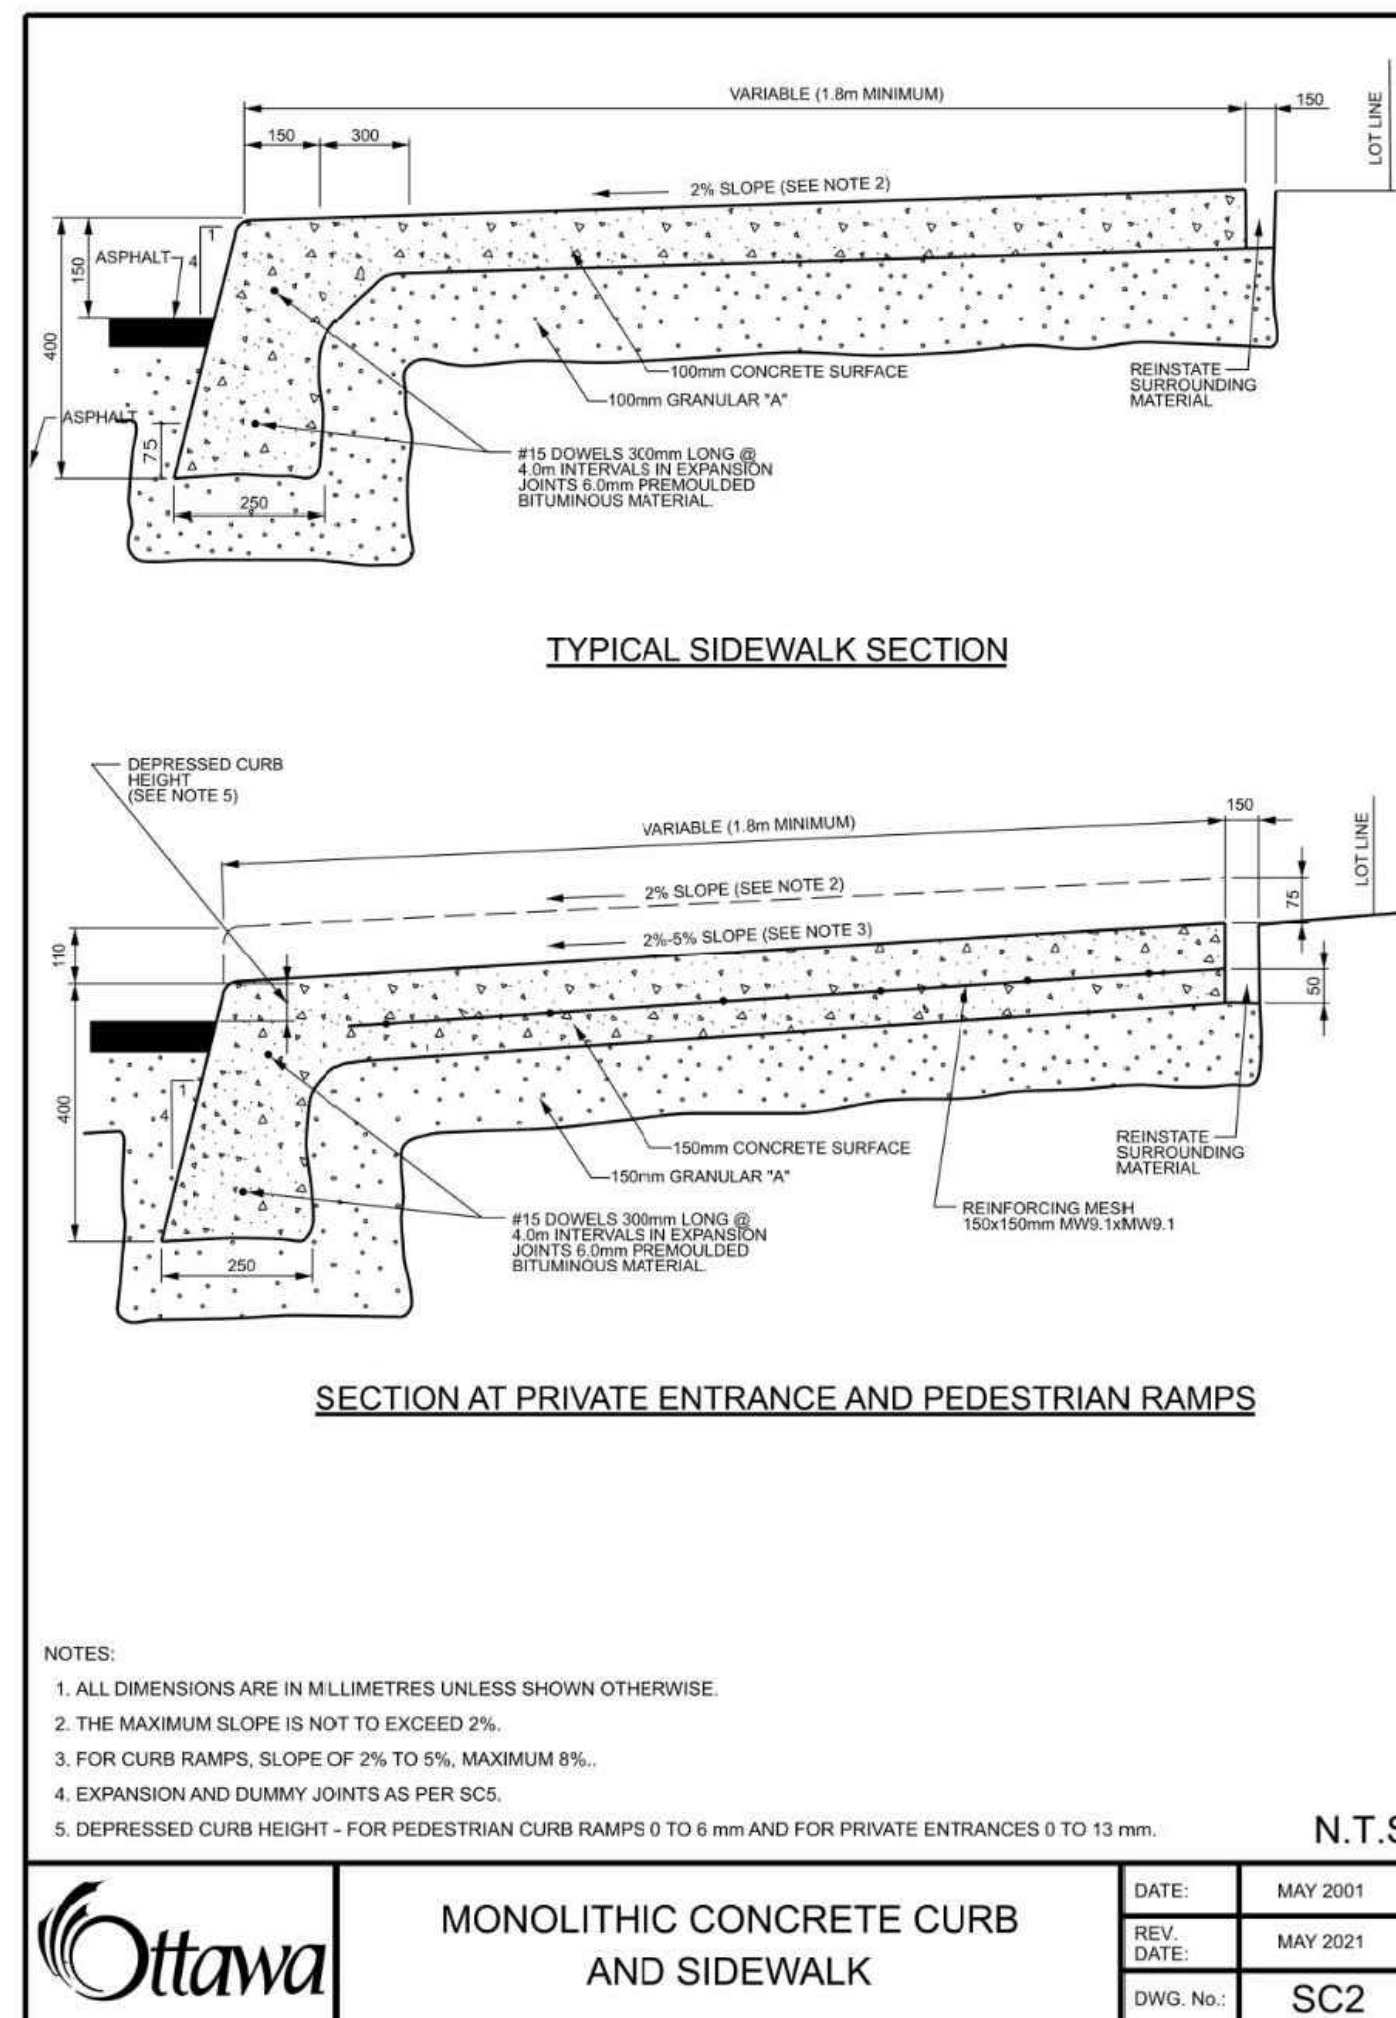


2 MONOLITHIC CONCRETE CURB AND SIDEWALK. SC2
N.T.S.

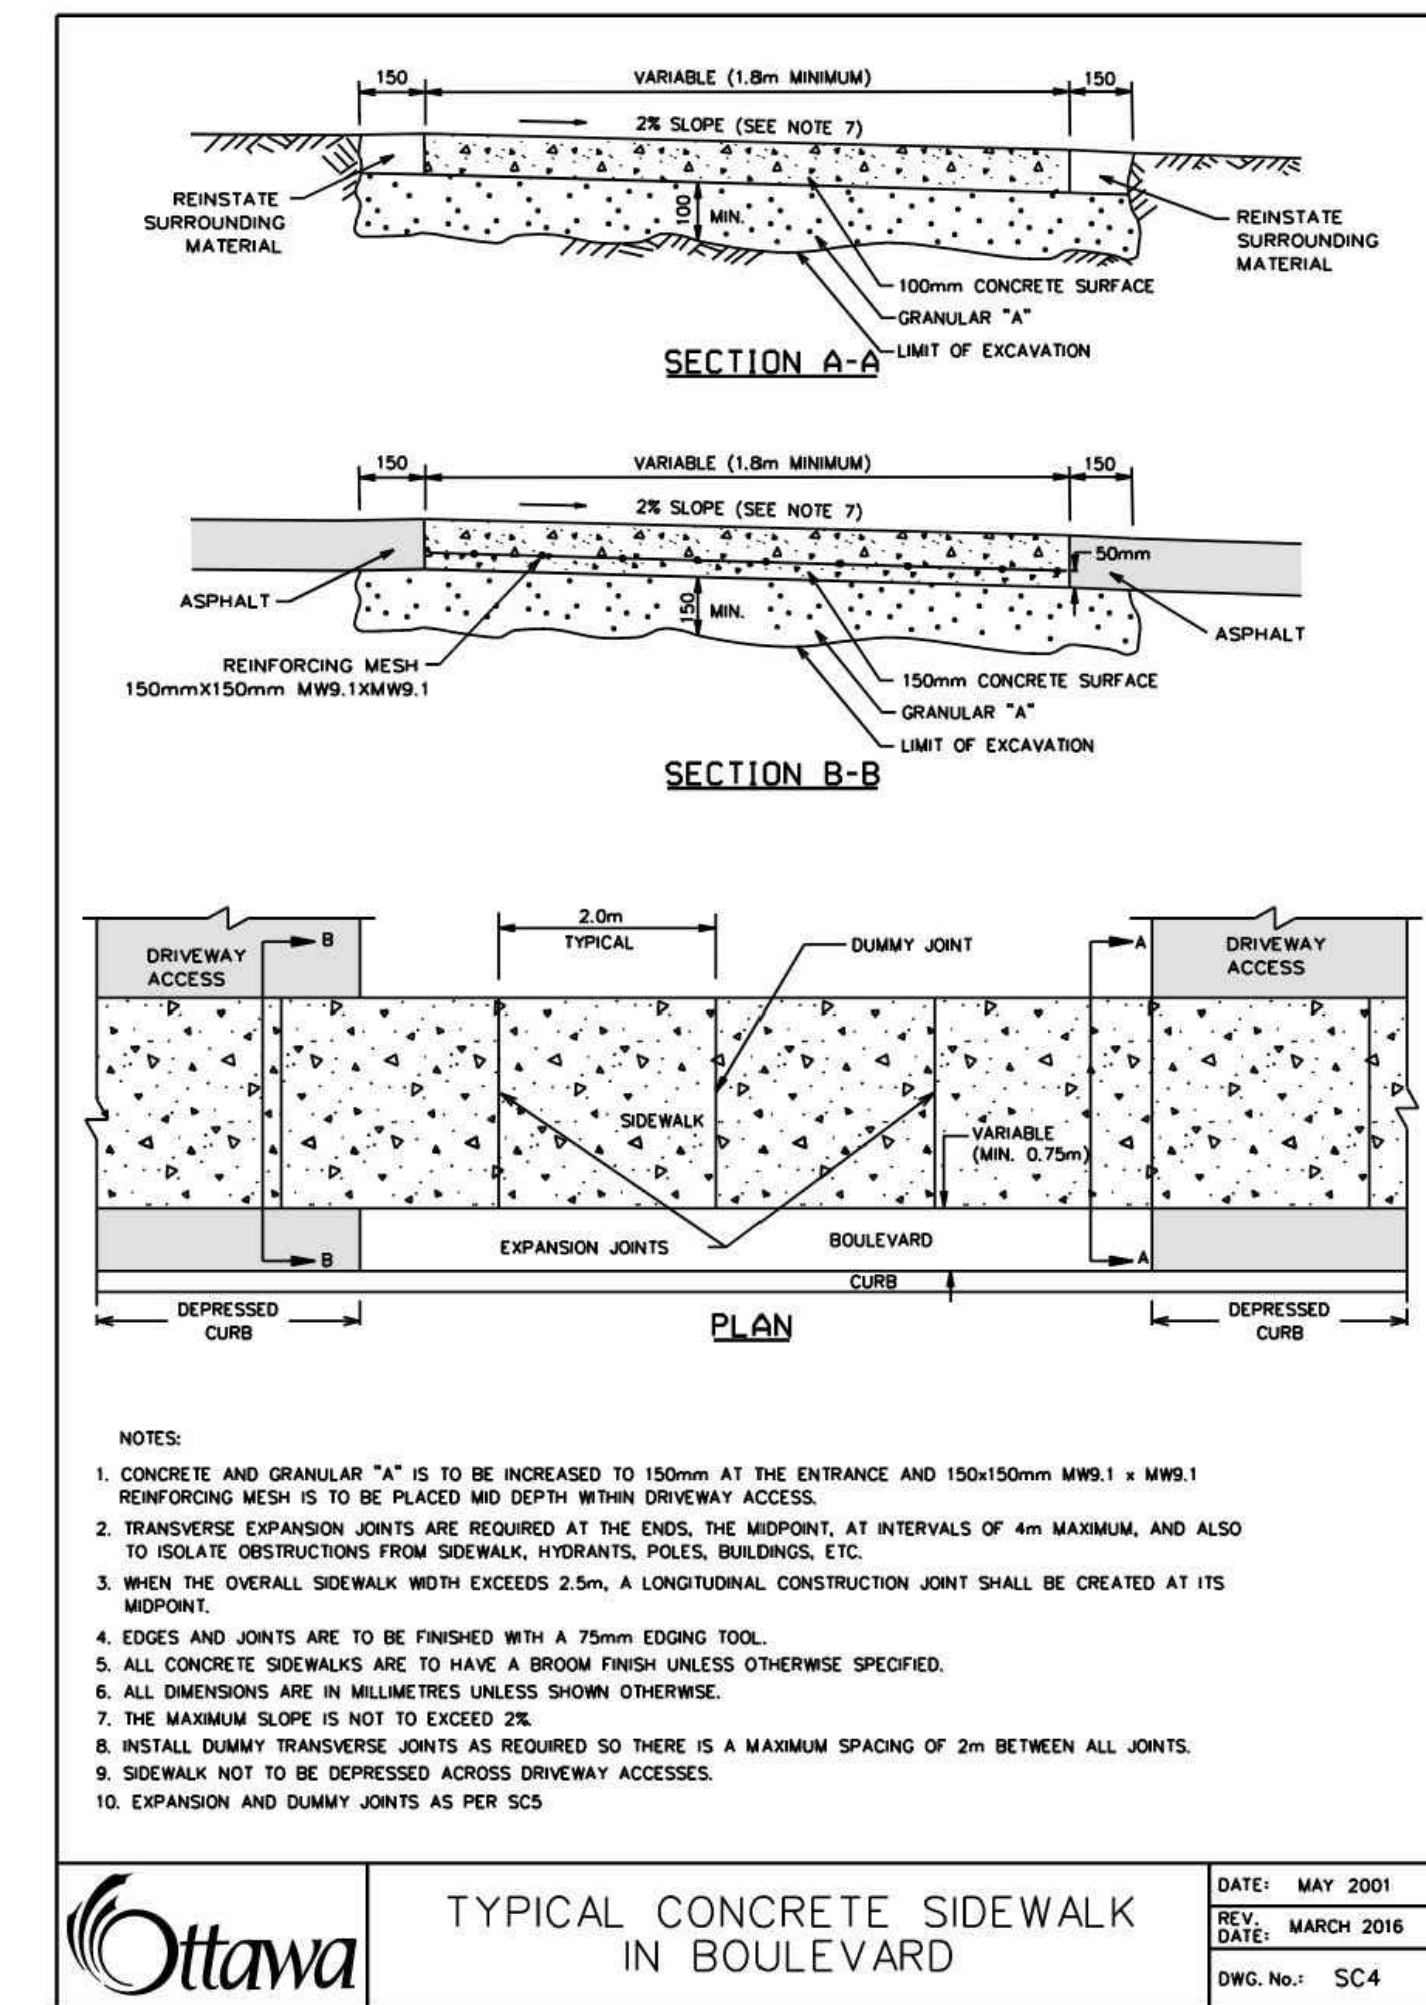


3 TYPICAL CONCRETE SIDEWALK IN BOULEVARD. SC4
N.T.S.

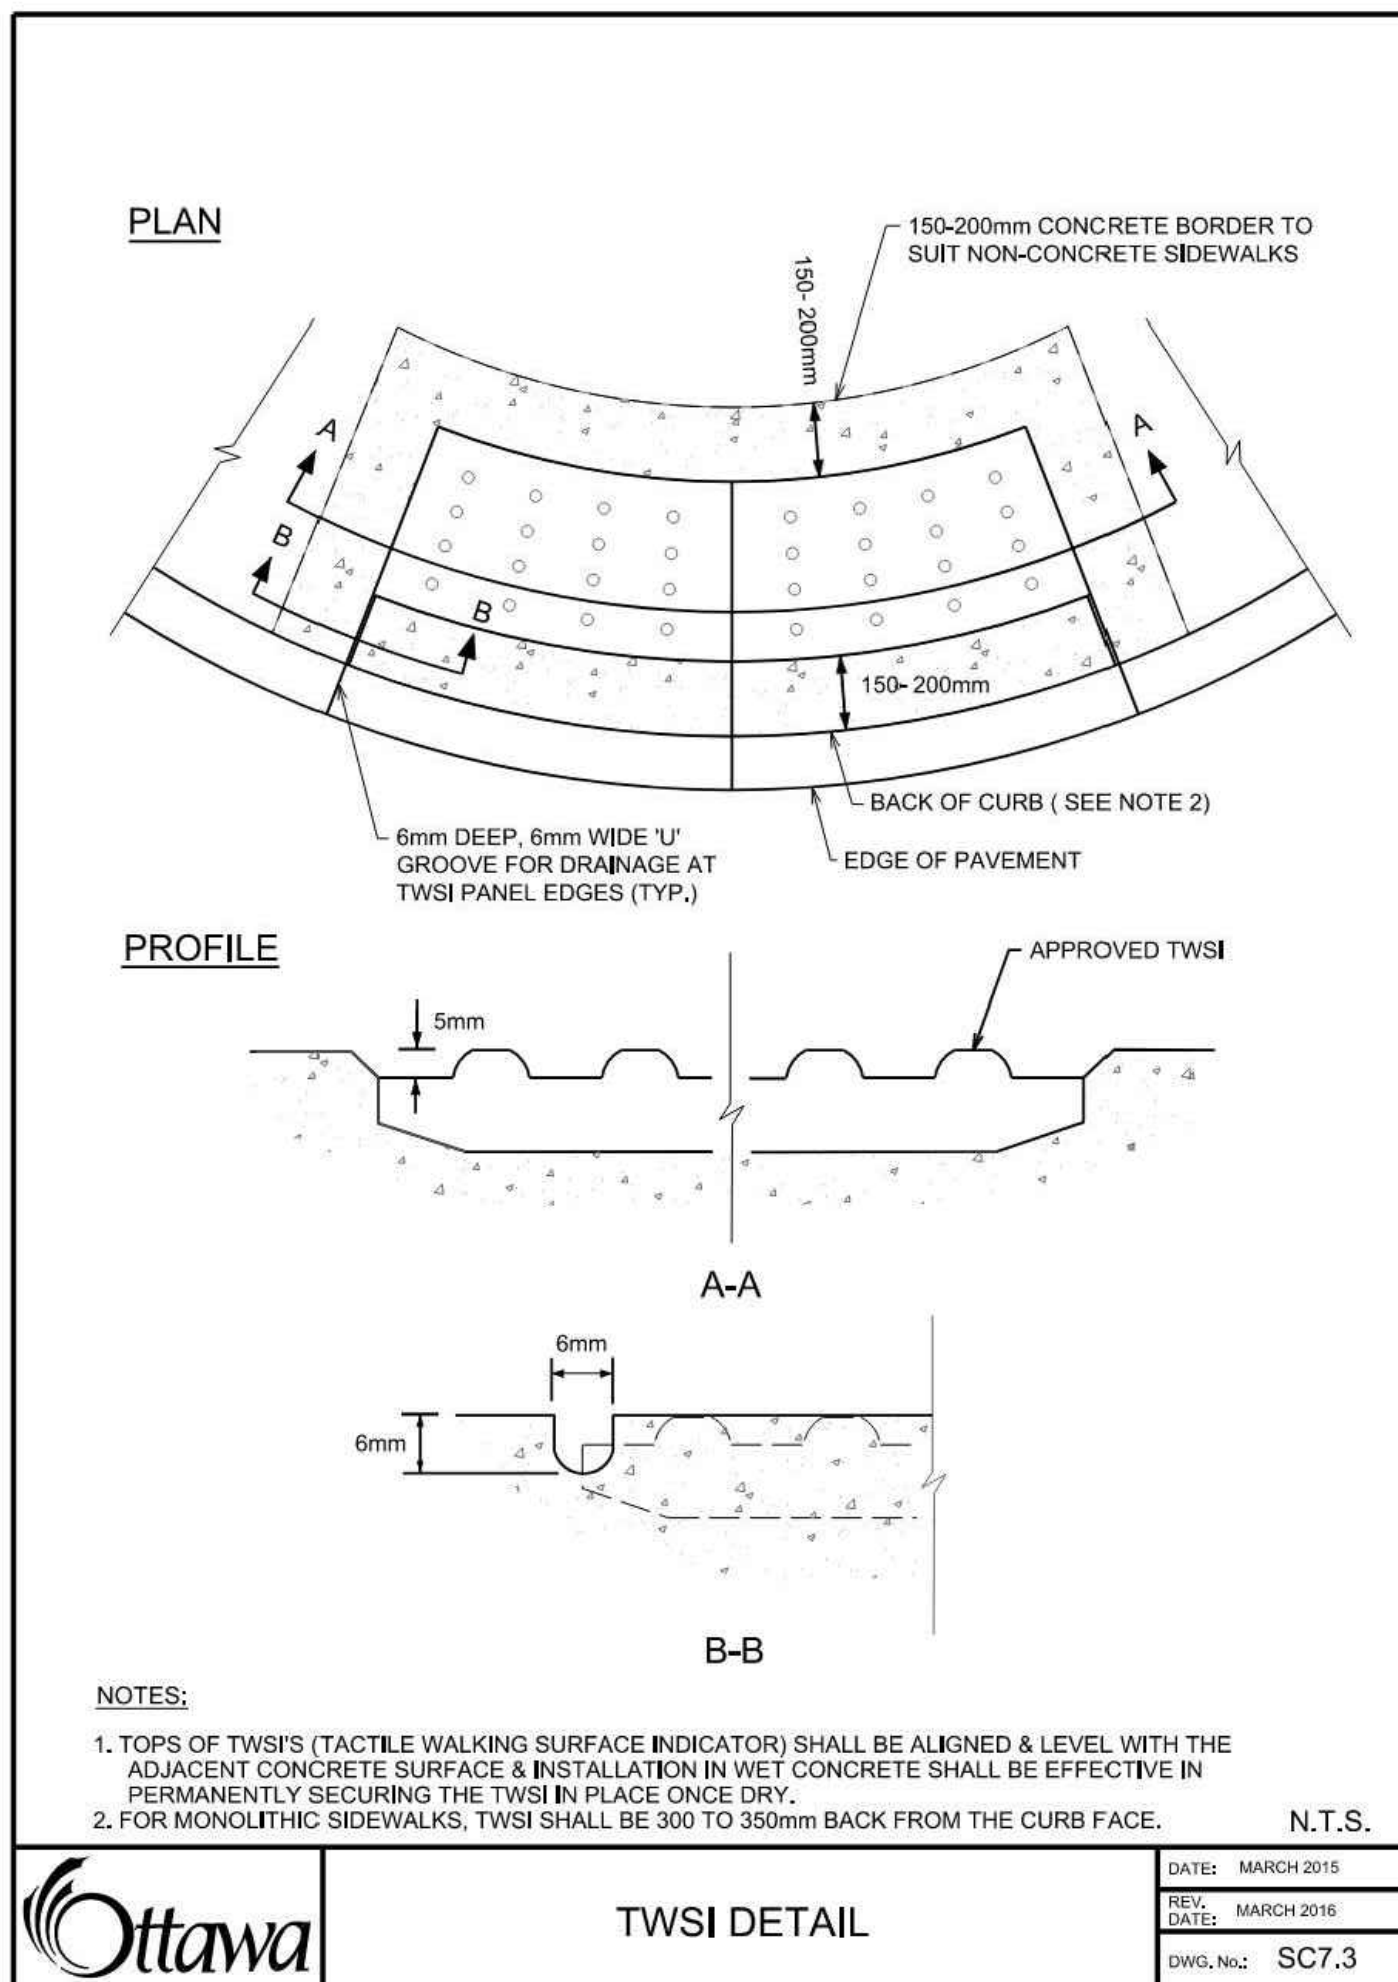

4 TWSI DETAIL. SC 7.3
N.T.S.

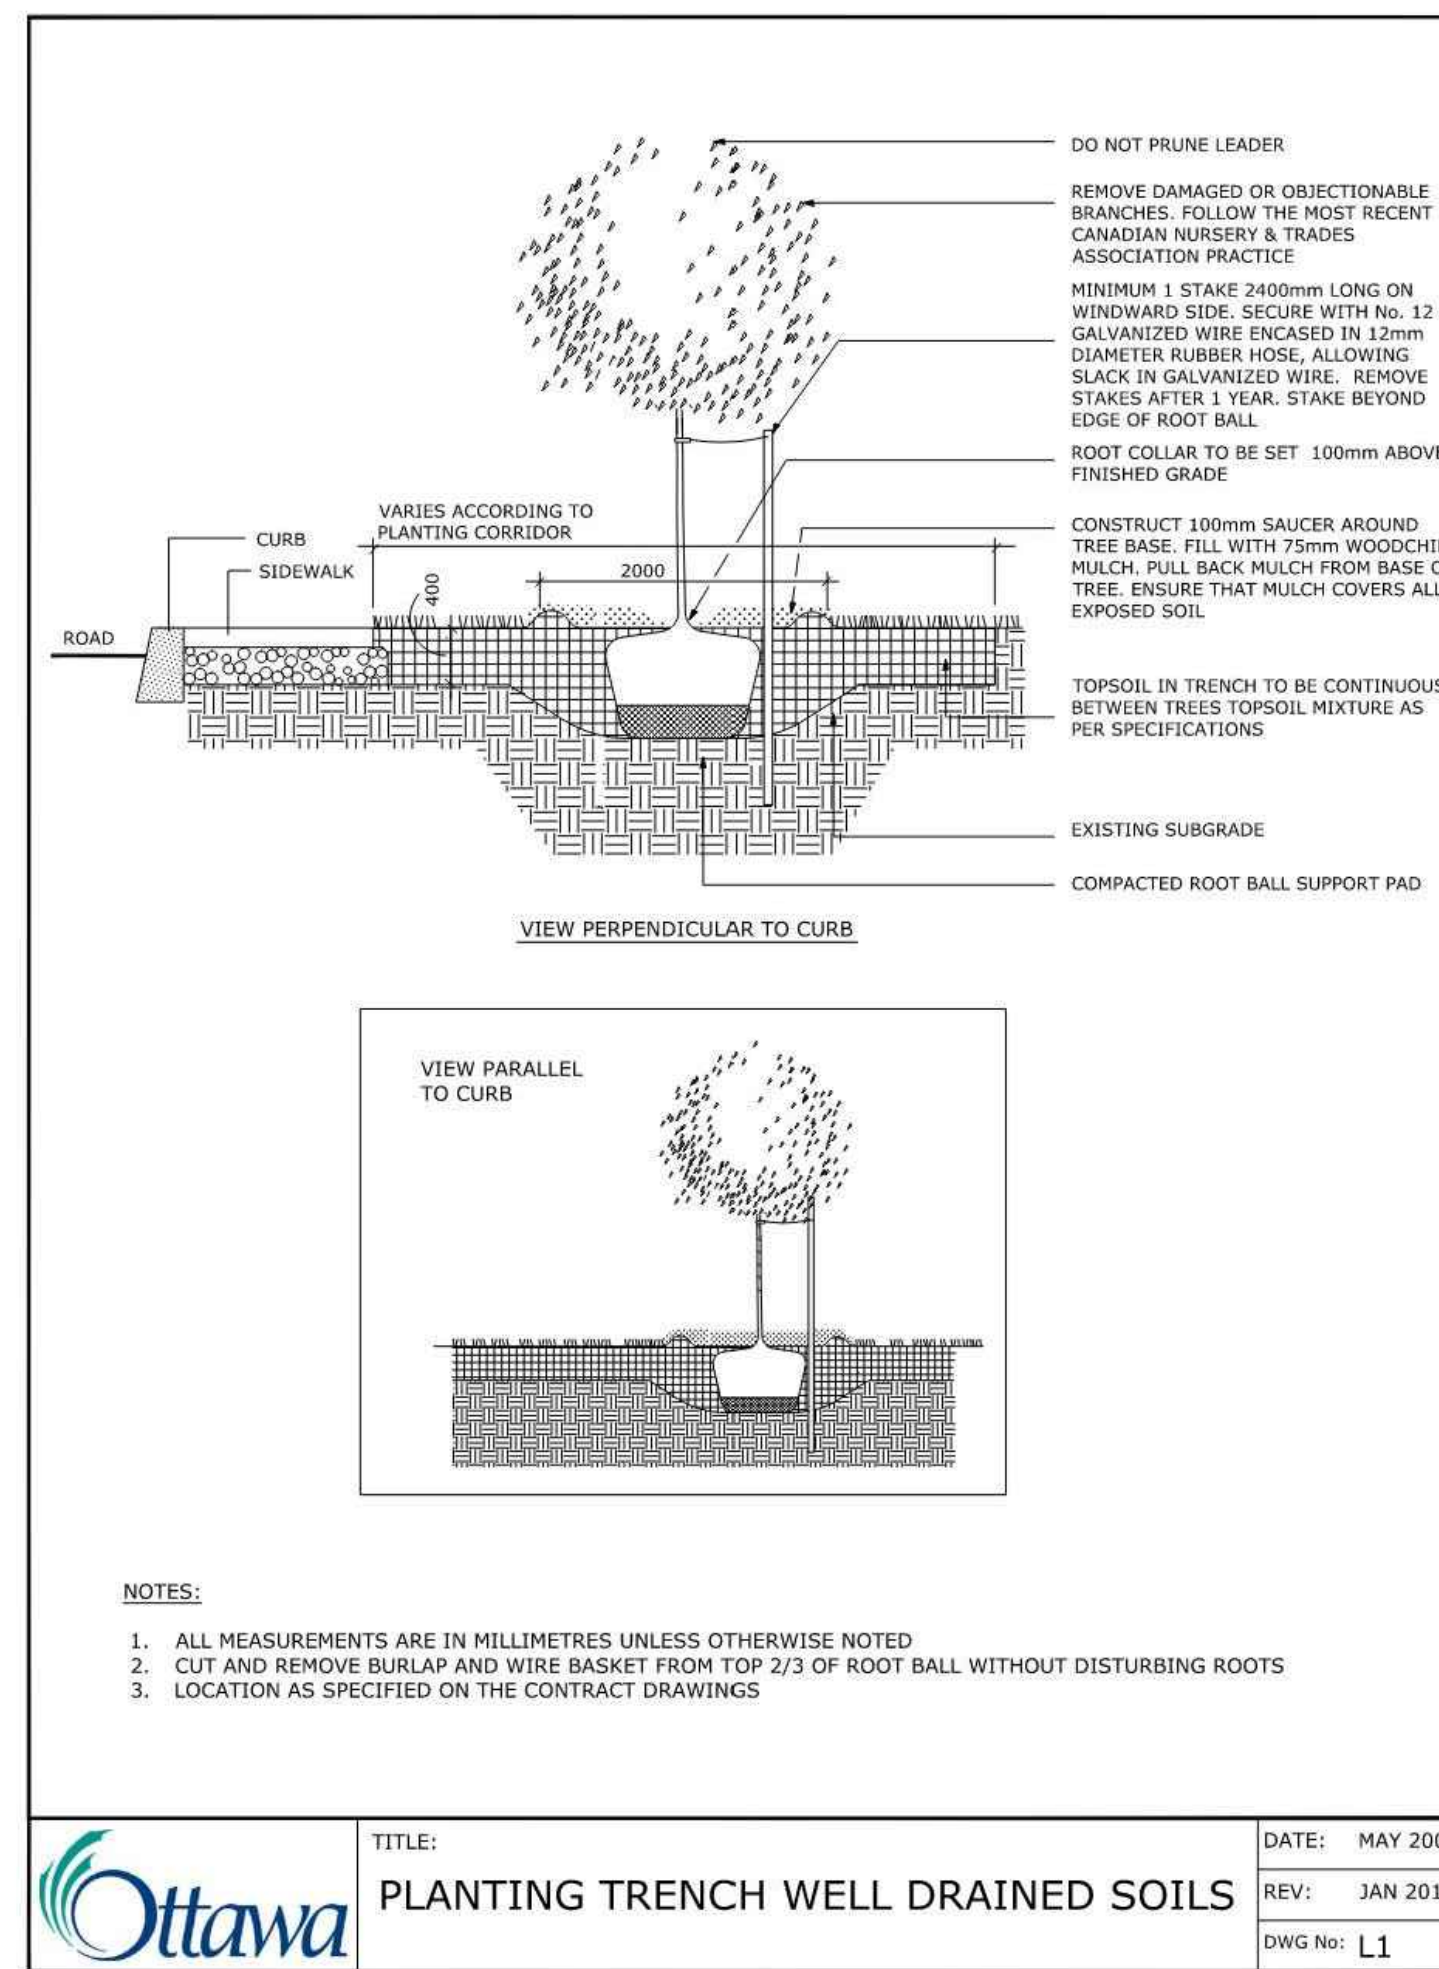

5 PLANTING TRENCH WELL DRAINED SOILS
N.T.S.

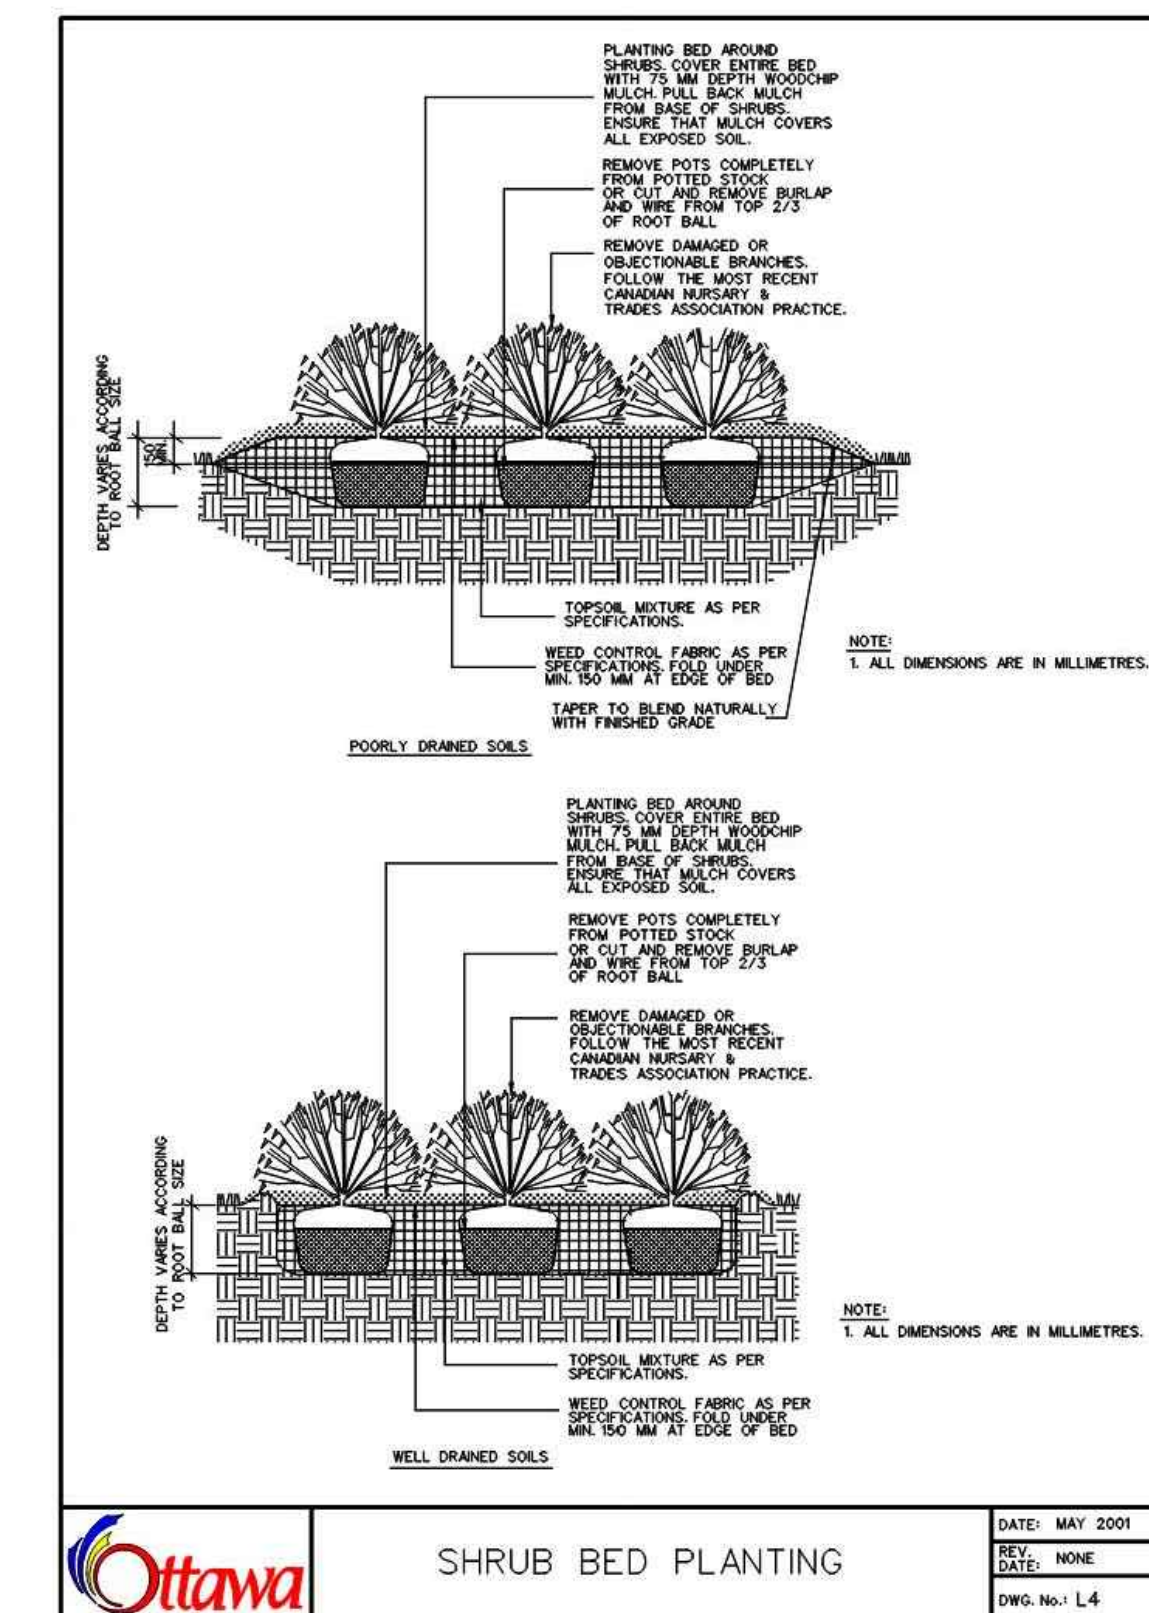


6 SHRUB BED PLANTING
N.T.S.

Revisions

8	ISSUED FOR SPA	2024-09-03	AK
7	ISSUED FOR COORDINATION	2024-08-30	AK
6	ISSUED FOR COORDINATION	2024-08-27	AK
5	ISSUED FOR COORDINATION	2024-08-21	AK
4	ISSUED FOR UDRP	2024-07-30	AK
3	ISSUED FOR COORDINATION	2024-07-15	AK
2	ISSUED FOR COORDINATION	2024-07-12	AK
1	ISSUED FOR COORDINATION	2024-07-09	AK

Signature
YYYY-MM-DD
Date

ASSOCIATION OF LANDSCAPE ARCHITECTS ONTARIO
MEMBER
PAUL MARSALE

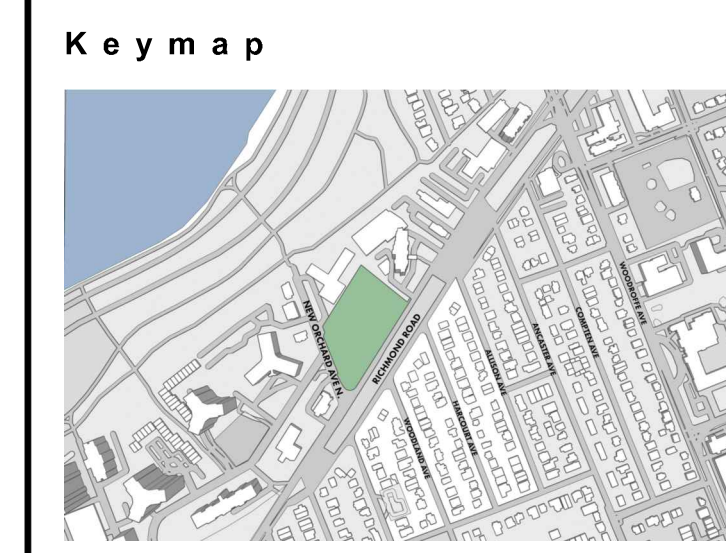

Scale North
AS SHOWN

Phase
SPA
Date
2024-07-09

Drawing Name
LANDSCAPE DETAILS

Sheet Number
NOT FOR CONSTRUCTION

LS.200
© STUDIO fla


1047 RICHMOND RD

OTTAWA, ON K2B 6R1


Project Number
22-178

Client
FENGATE
2275 UPPER MIDDLE RD. E.,
SUITE 700
OAKVILLE, ON L6H 0C3


Consultant
RLA/ARCHITECTURE
55 Beach Street
OTTAWA, ON K1S3J6, CANADA
TEL: 613.724.9932

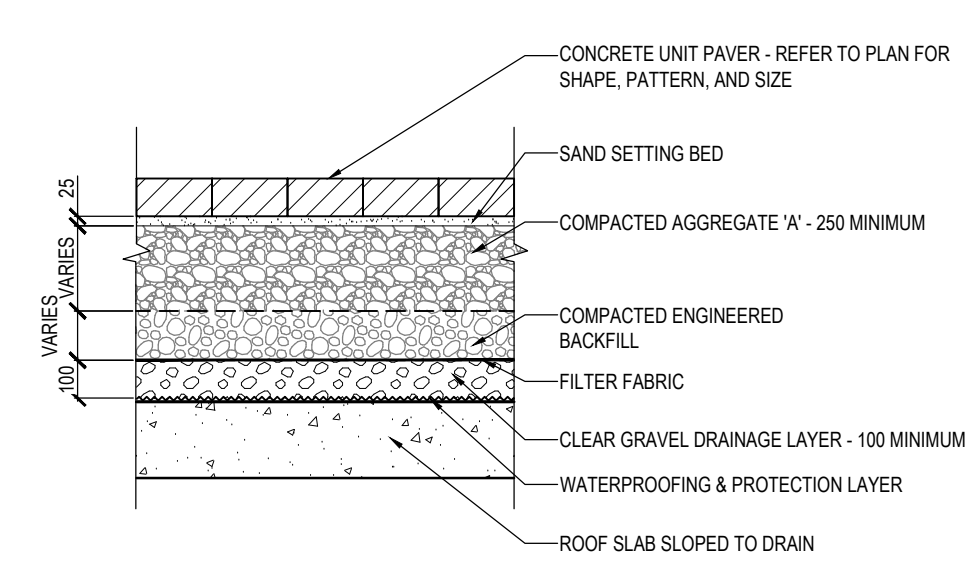


1 HEAVY DUTY UNIT PAVERS ON SLAB
1:20

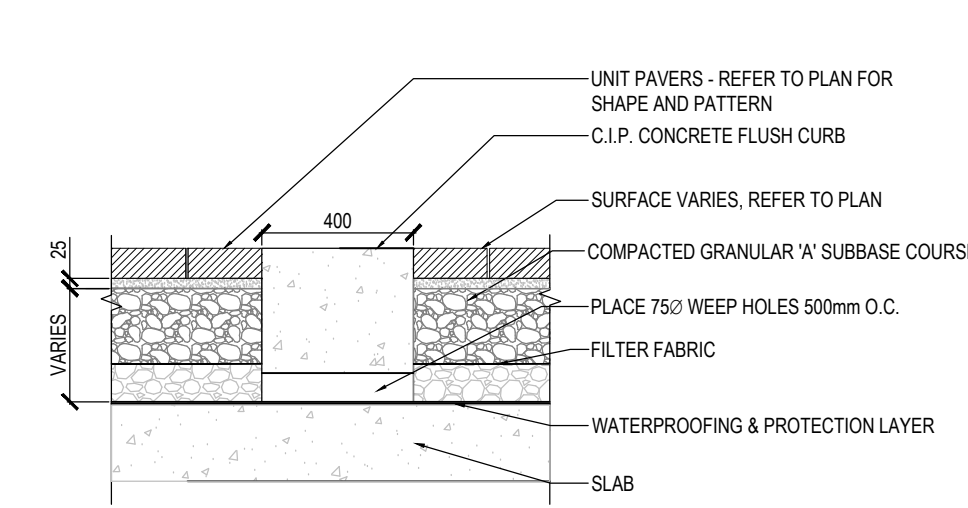


2 UNIT PAVERS ON SLAB
1:20

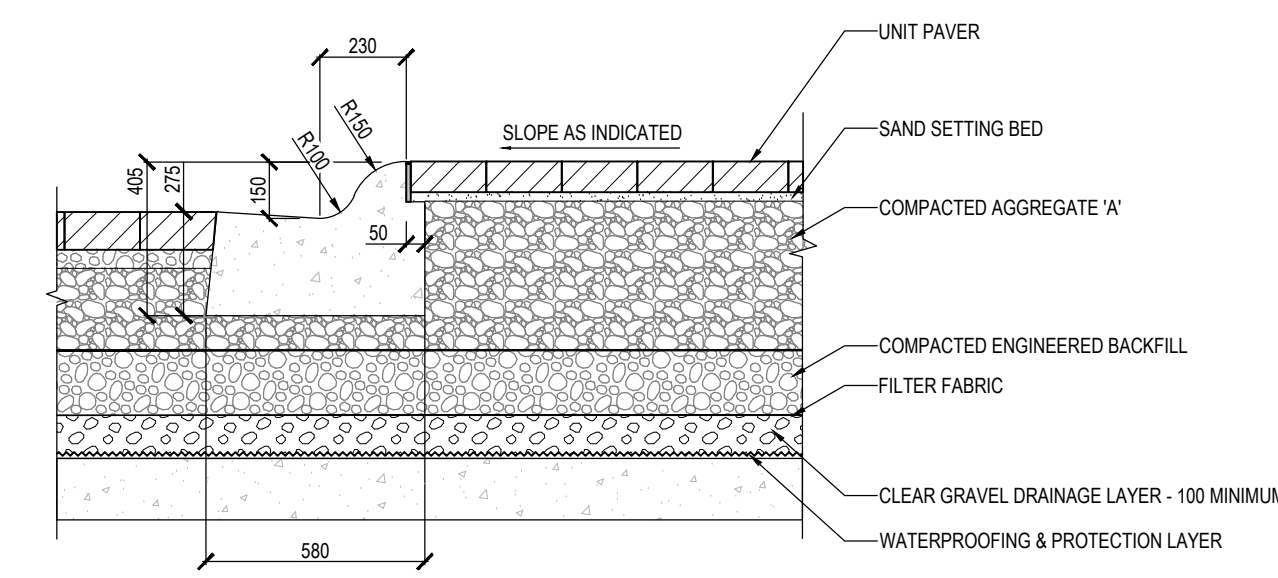


3 STANDARD ROLLED CURB AND GUTTER
1:20

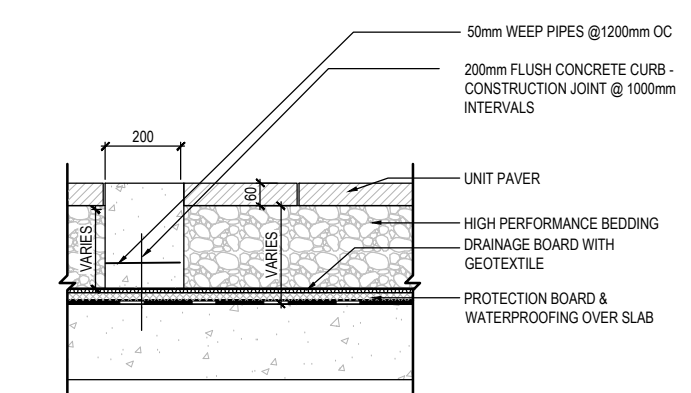

4 FLUSH CONCRETE CURB ON SLAB
1:20

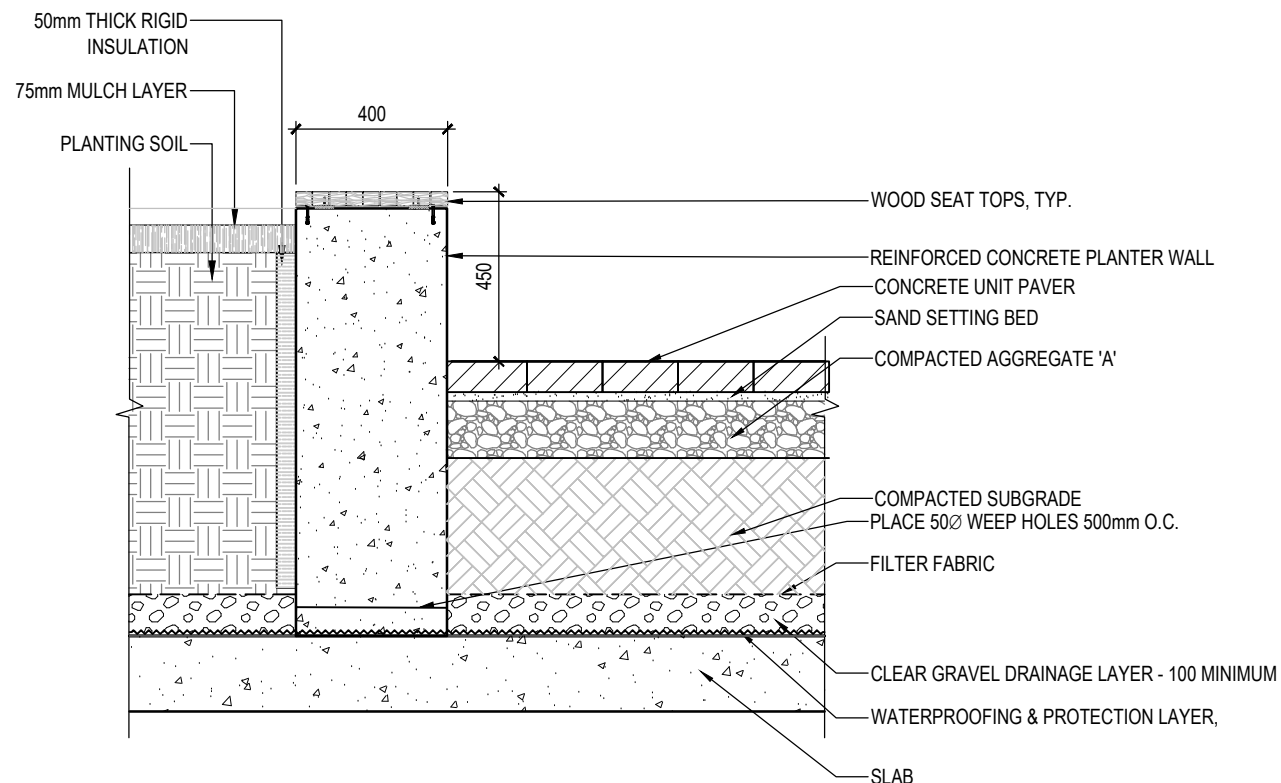

5 WOOD TOP BENCH ON CONCRETE SEAT WALL
N.T.S.

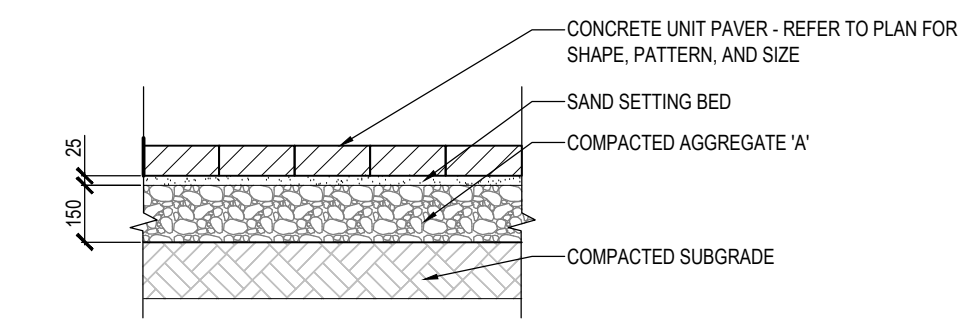

6 UNIT PAVERS ON GRADE
1:20

Revisions

8	ISSUED FOR SPA	2024-09-03	AK
7	ISSUED FOR COORDINATION	2024-08-30	AK
6	ISSUED FOR COORDINATION	2024-08-27	AK
5	ISSUED FOR COORDINATION	2024-08-21	AK
4	ISSUED FOR UDRP	2024-07-30	AK
3	ISSUED FOR COORDINATION	2024-07-15	AK
2	ISSUED FOR COORDINATION	2024-07-12	AK
1	ISSUED FOR COORDINATION	2024-07-09	AK



Signature
YYYY-MM-DD
Date

Keymap



Scale North
AS SHOWN


Phase
SPA
Date
2024-07-09

Drawing Name
LANDSCAPE DETAILS


Sheet Number
NOT FOR CONSTRUCTION

LS.201

September 3, 2024 5:20 PM I:\01-PROJECTS\2022\21-1047 RICHMOND RD, OTTAWA\01-CAD\01-CURRENT\SPA\PILOT-SHEET-TEMPLATES\LS.201 LANDSCAPE DETAILS.DWG

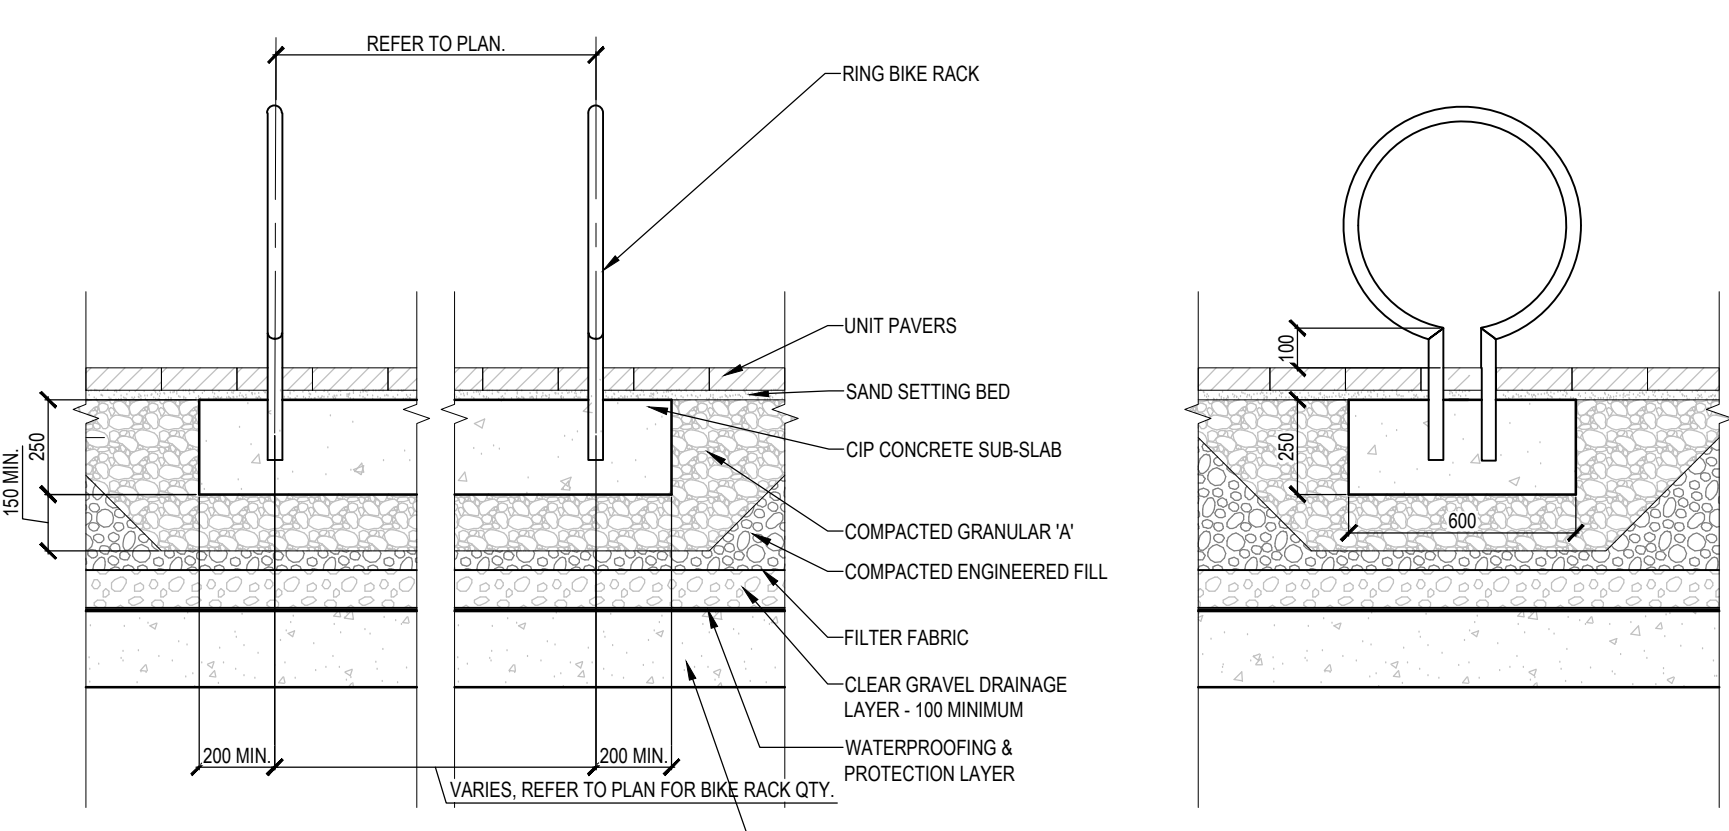

7 BIKE RACK
N.T.S.

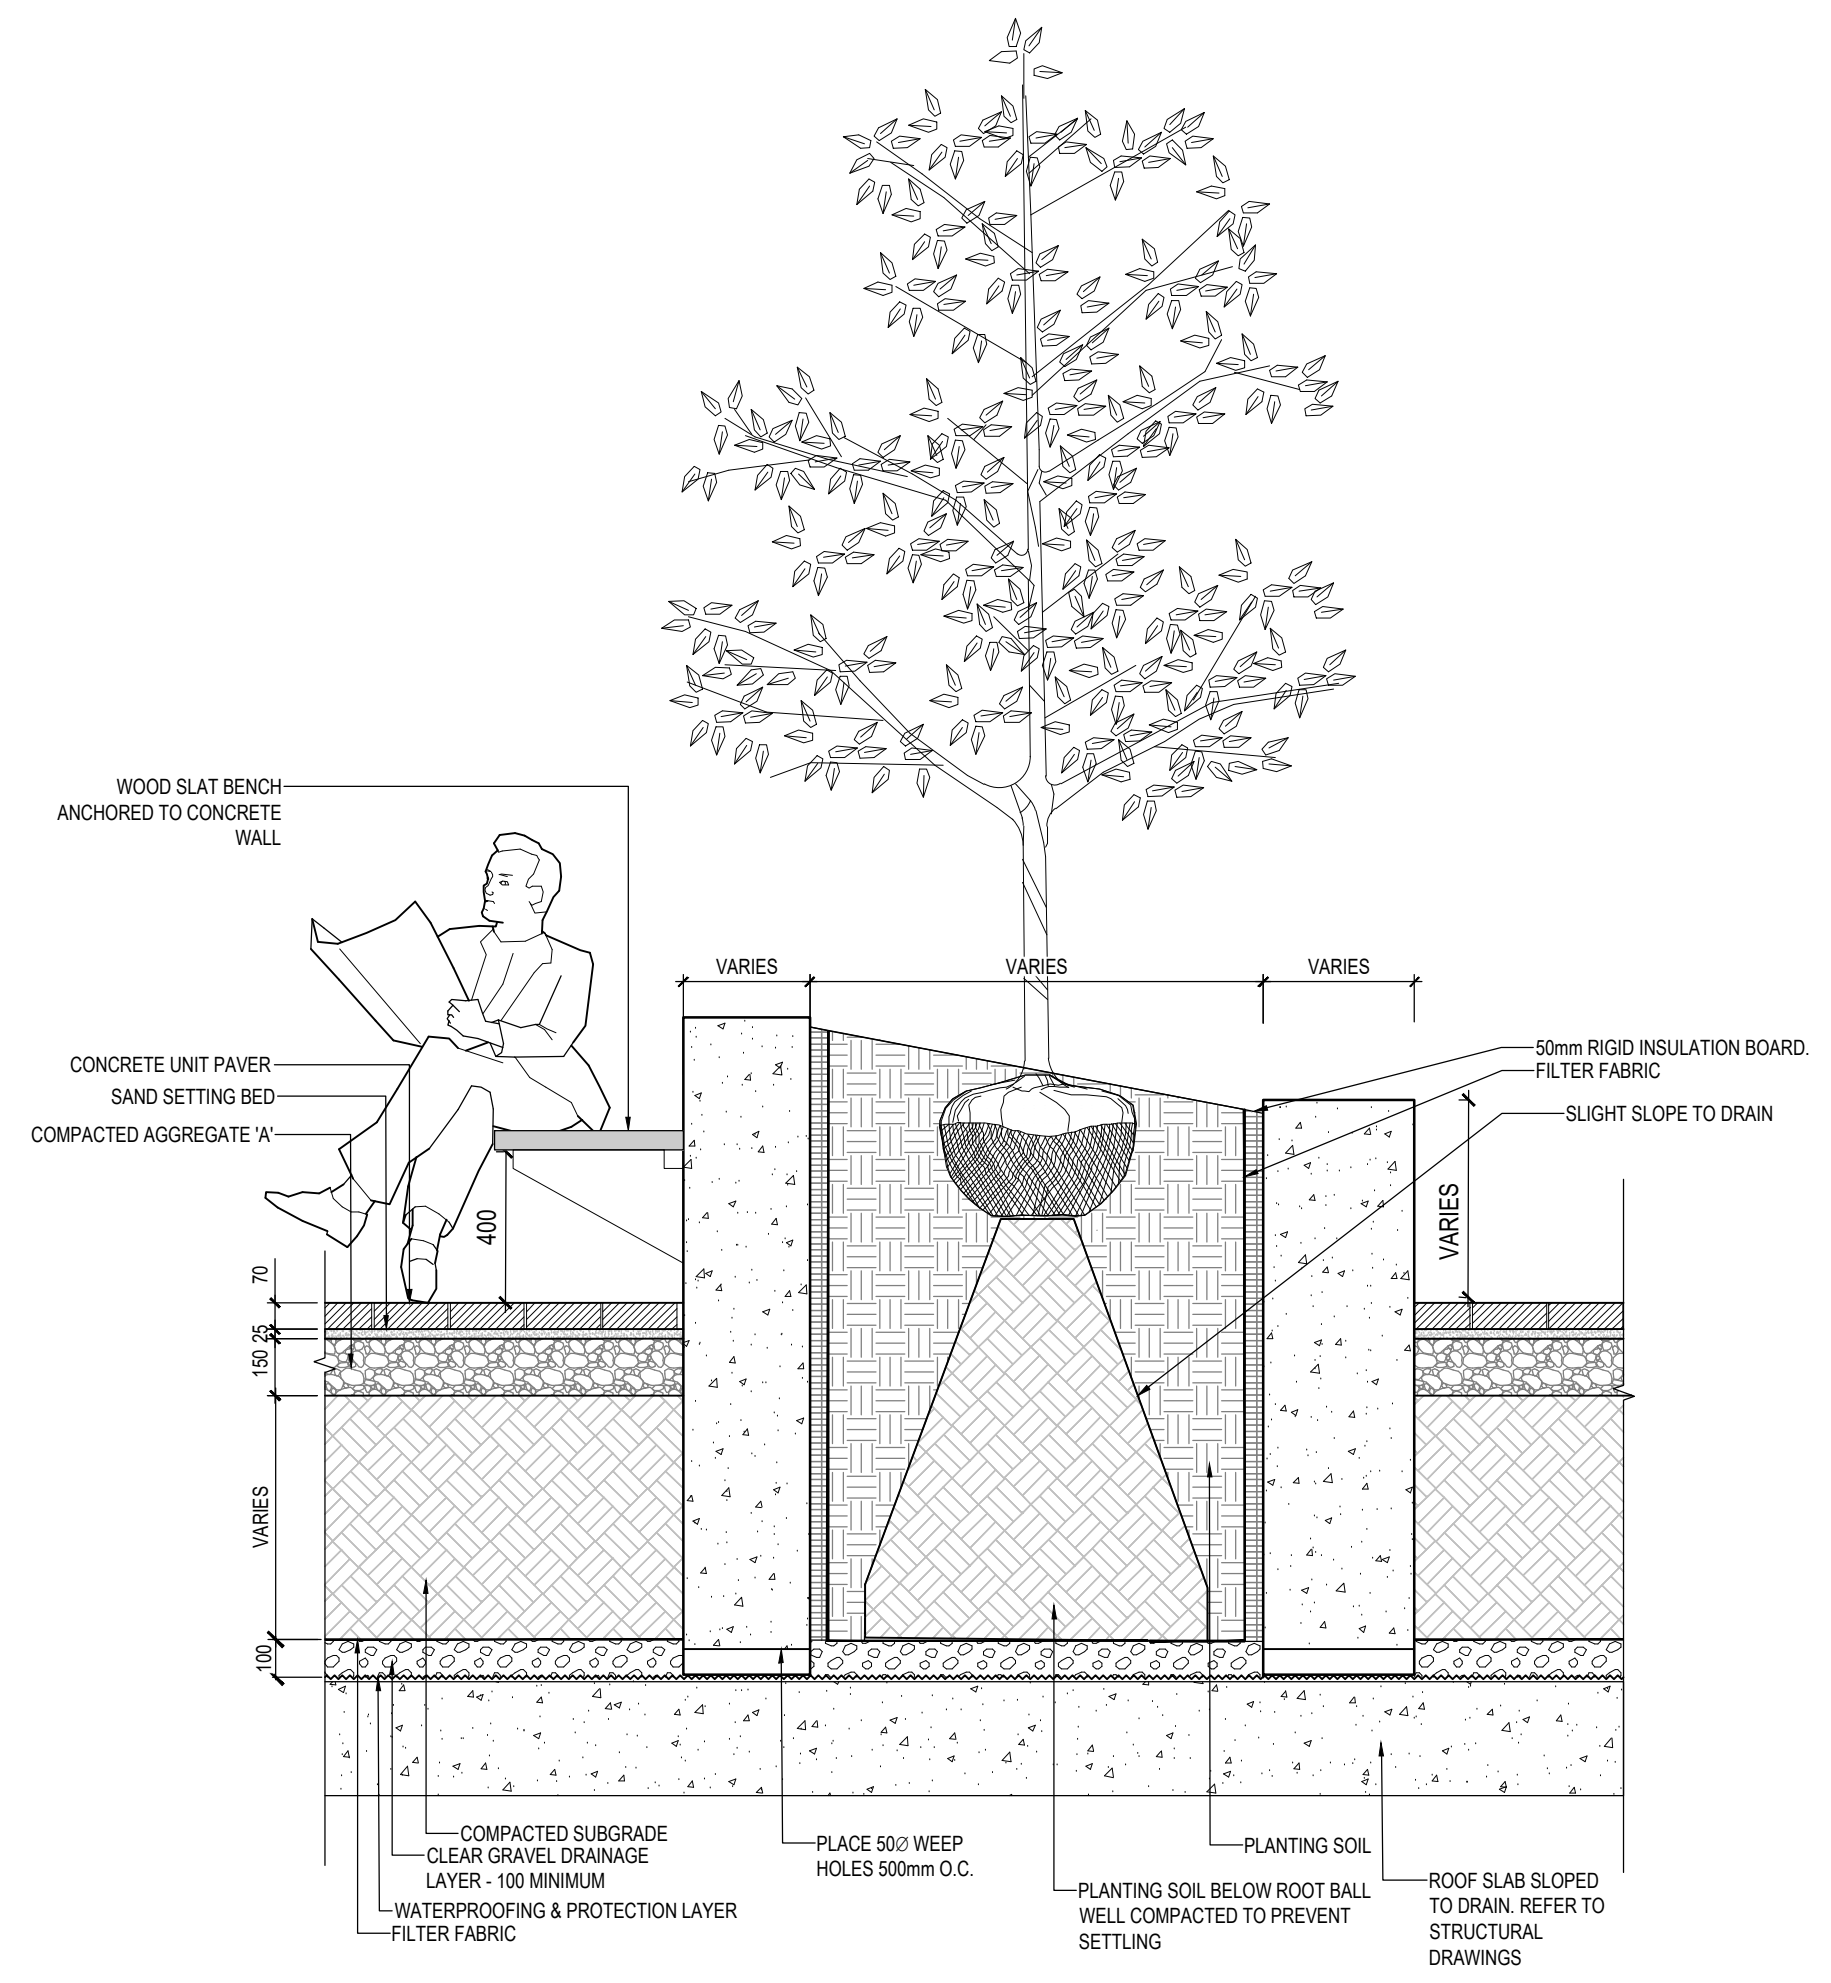

8 CONCRETE PLANTER ON SLAB
N.T.S.


1047 RICHMOND RD

OTTAWA, ON K2B 6R1


Project Number
22-178

Client
FENGATE
2275 UPPER MIDDLE RD. E.,
SUITE 700
OAKVILLE, ON L6H 0C3


Consultant
ARCHITECTURE
RLA/ARCHITECTURE
55 Beach Street
OTTAWA, ON K1S3J6, CANADA
TEL: 613.724.9932

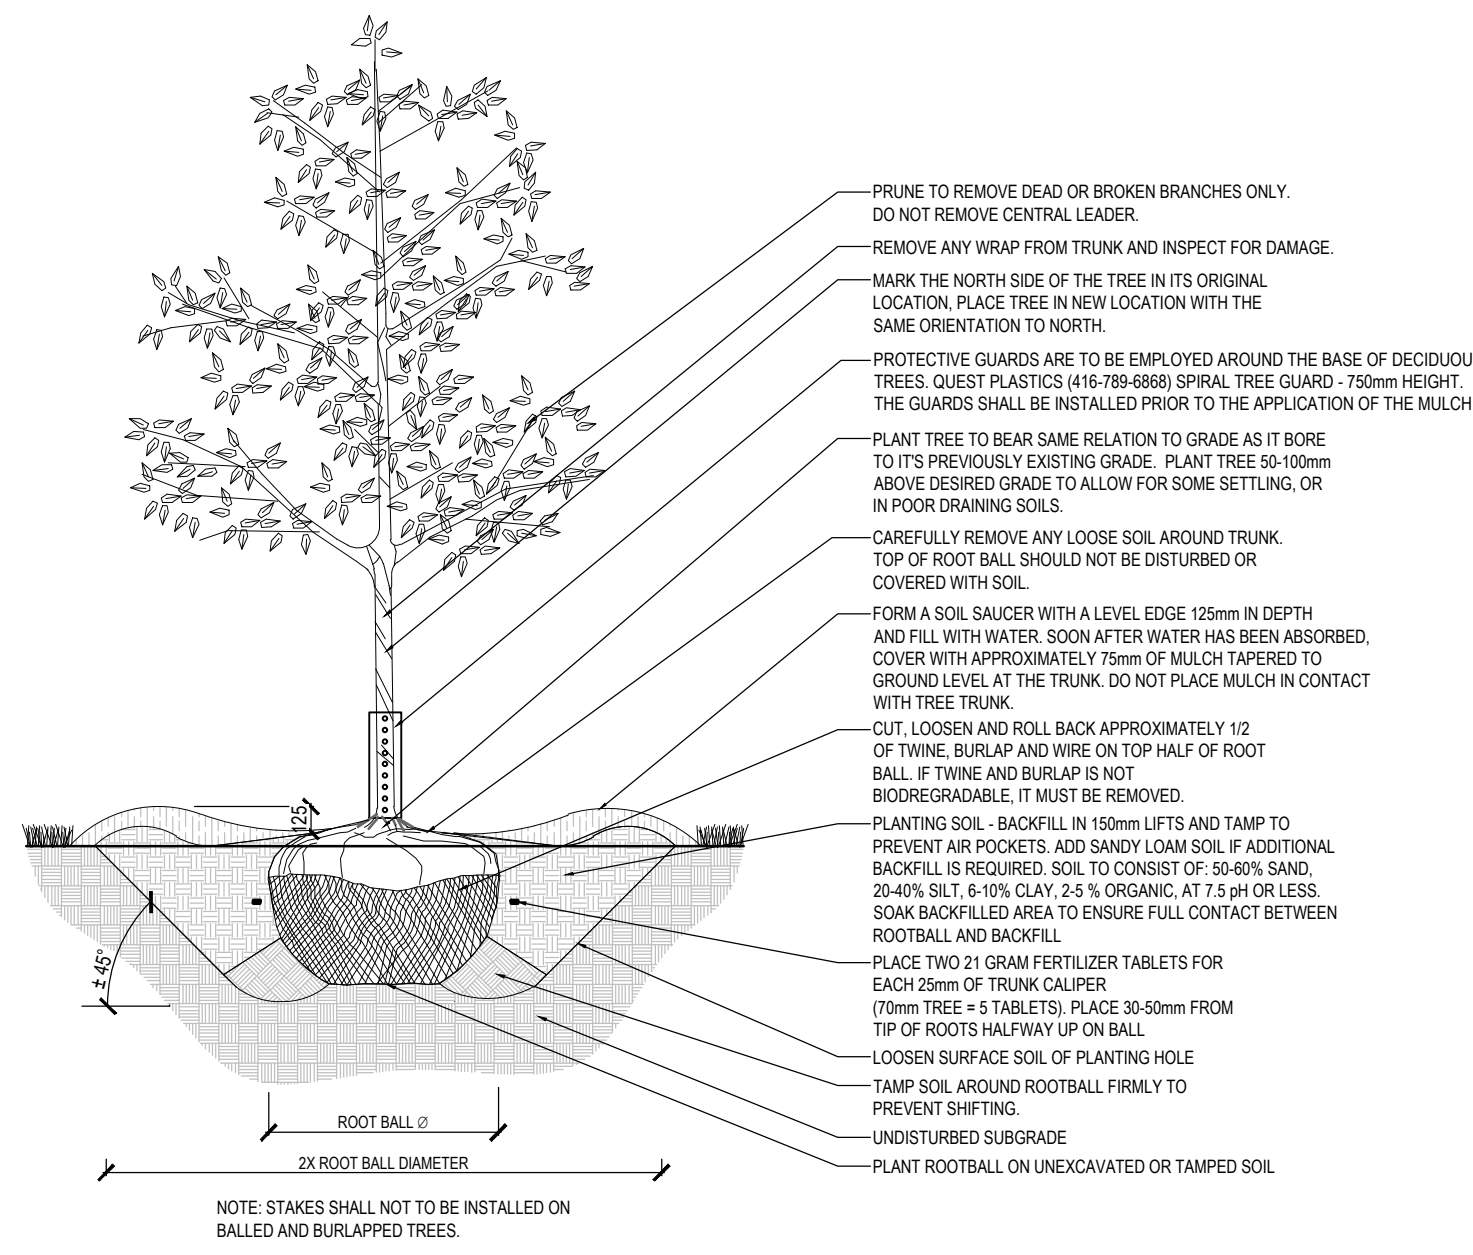

1 B&B DECIDUOUS TREE PLANTING DETAIL
N.T.S.

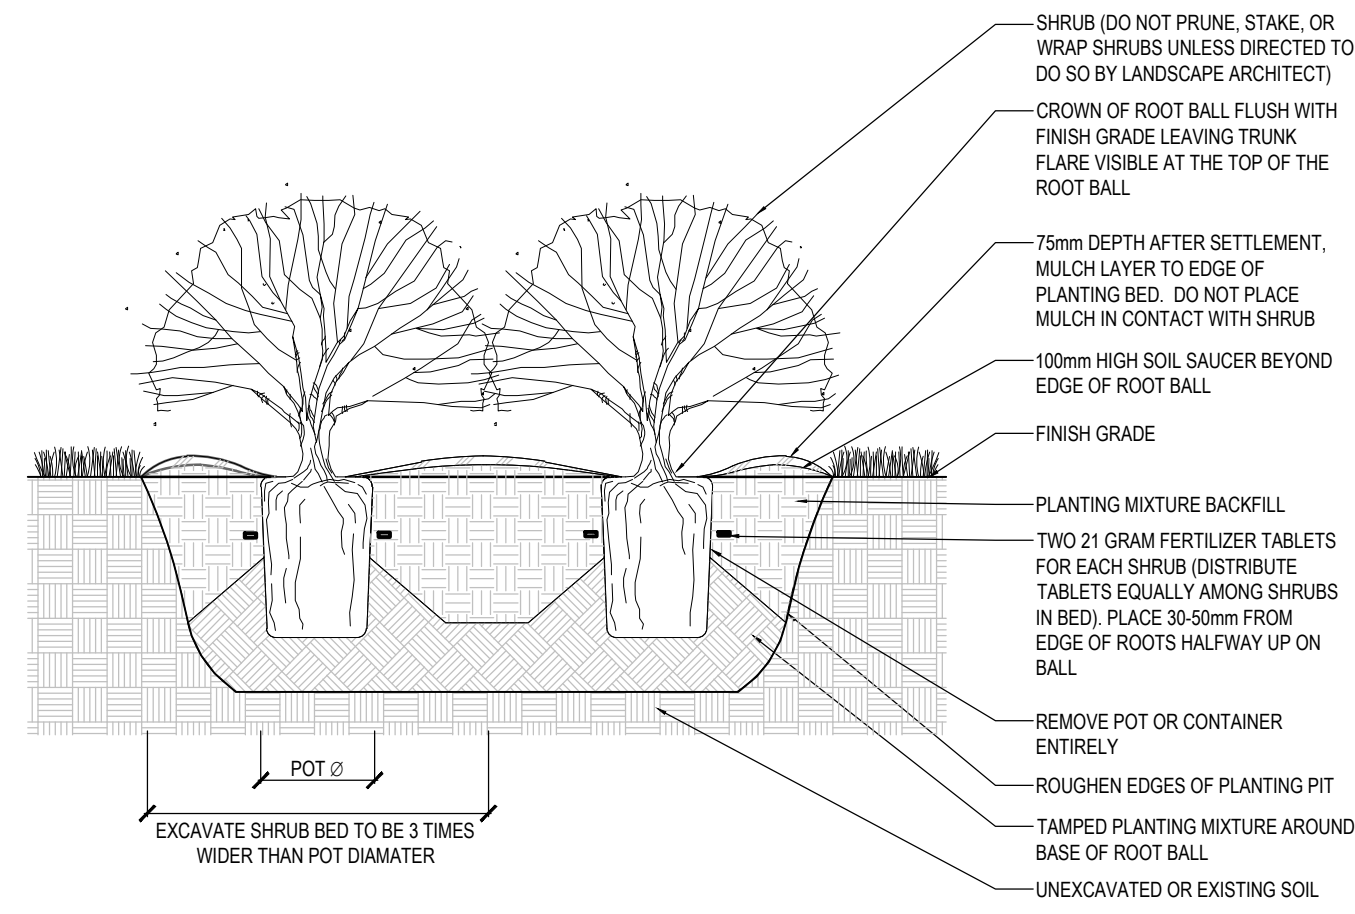

2 POTTED SHRUB BED PLANTING DETAIL
N.T.S.

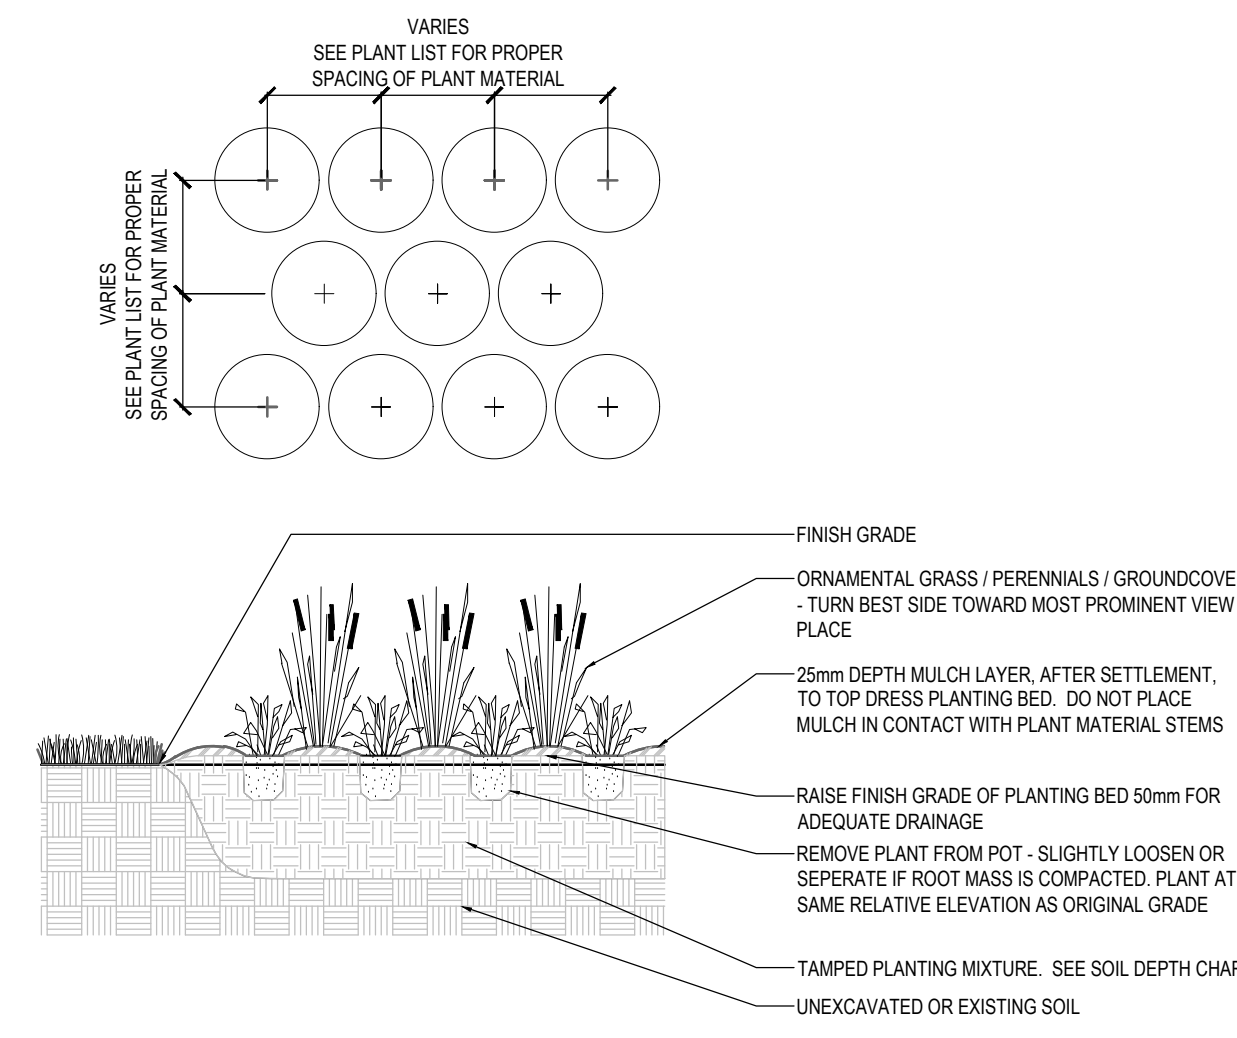

3 GROUND COVER PLANTING
N.T.S.

Revisions


8	ISSUED FOR SPA	2024-09-03	AK
7	ISSUED FOR COORDINATION	2024-08-30	AK
6	ISSUED FOR COORDINATION	2024-08-27	AK
5	ISSUED FOR COORDINATION	2024-08-21	AK
4	ISSUED FOR LDRP	2024-07-30	AK
3	ISSUED FOR COORDINATION	2024-07-15	AK
2	ISSUED FOR COORDINATION	2024-07-12	AK
1	ISSUED FOR COORDINATION	2024-07-09	AK



Signature

YYYY-MM-DD
Date

Key map

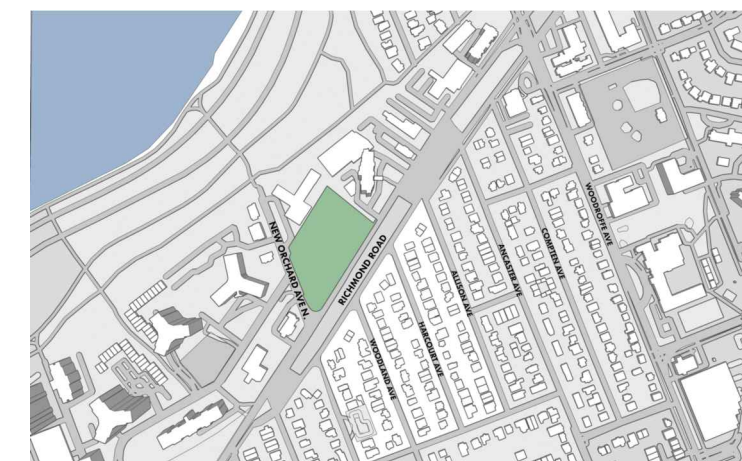

Scale North
AS SHOWN

Phase
SPA

Date
2024-07-09

Drawing Name
LANDSCAPE DETAILS

Sheet Number
NOT FOR CONSTRUCTION


LS.202




1 VIEW TOWARDS WORKING SPACE AND PEDESTRIAN MEWS
N.T.S



2 AERIAL VIEW
N.T.S

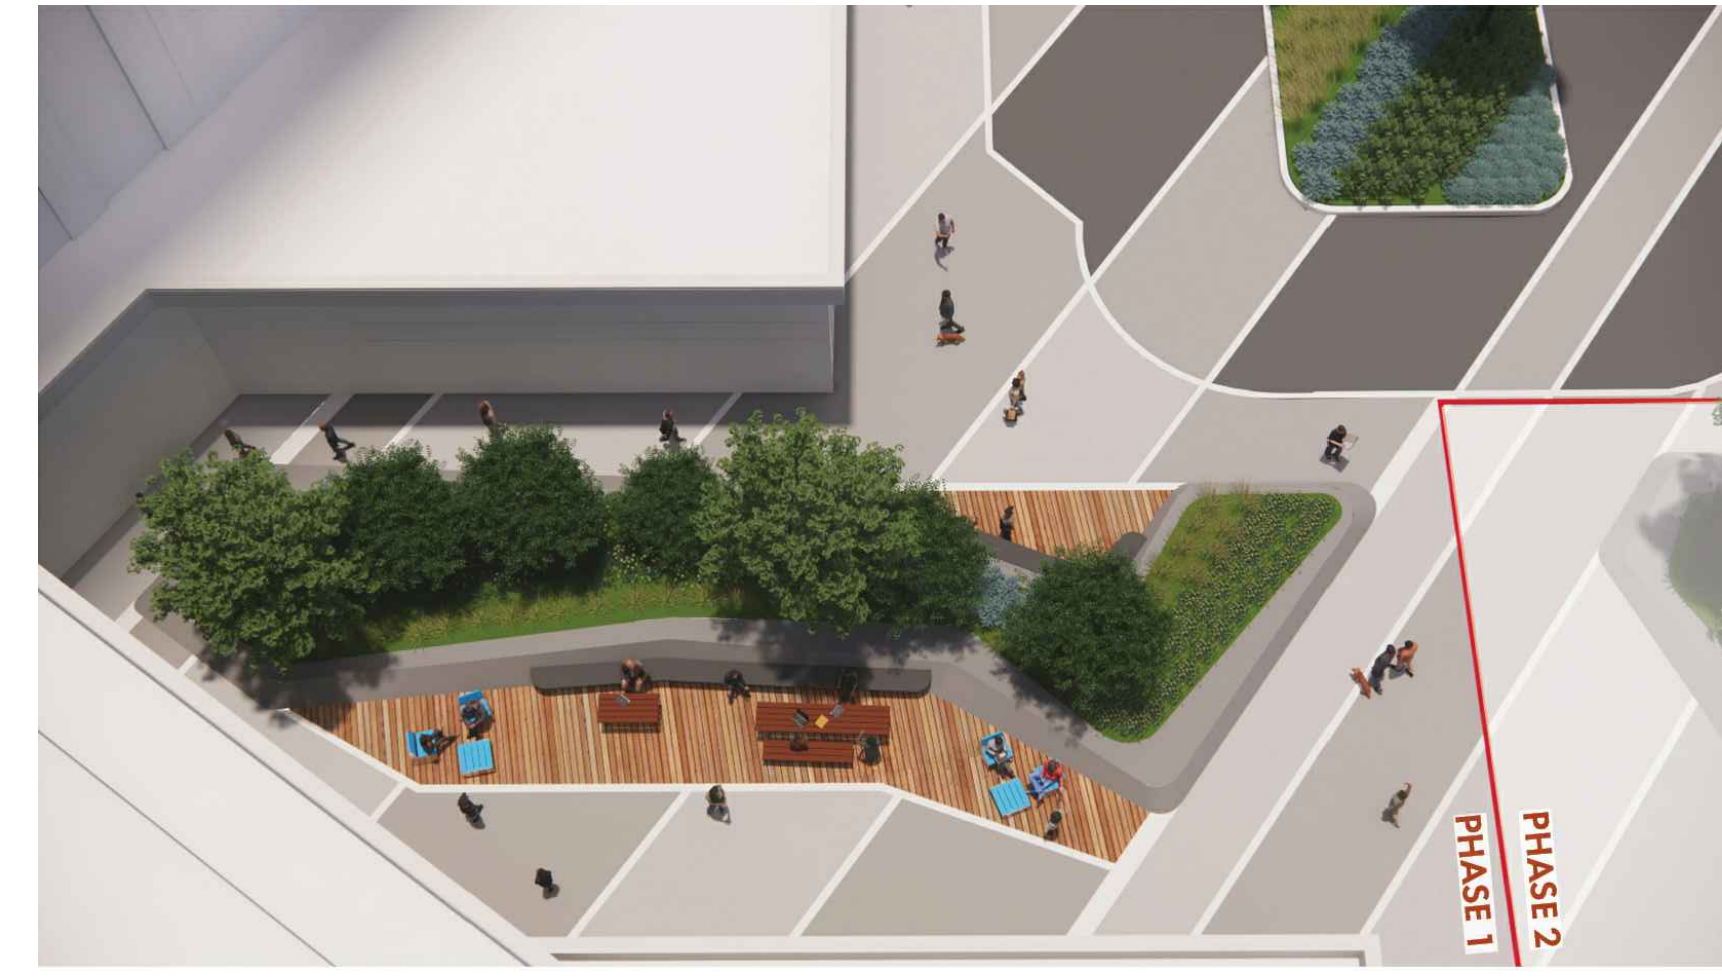

3 VIEW TOWARDS WORKING SPACE - OUTDOOR AMENITY
N.T.S

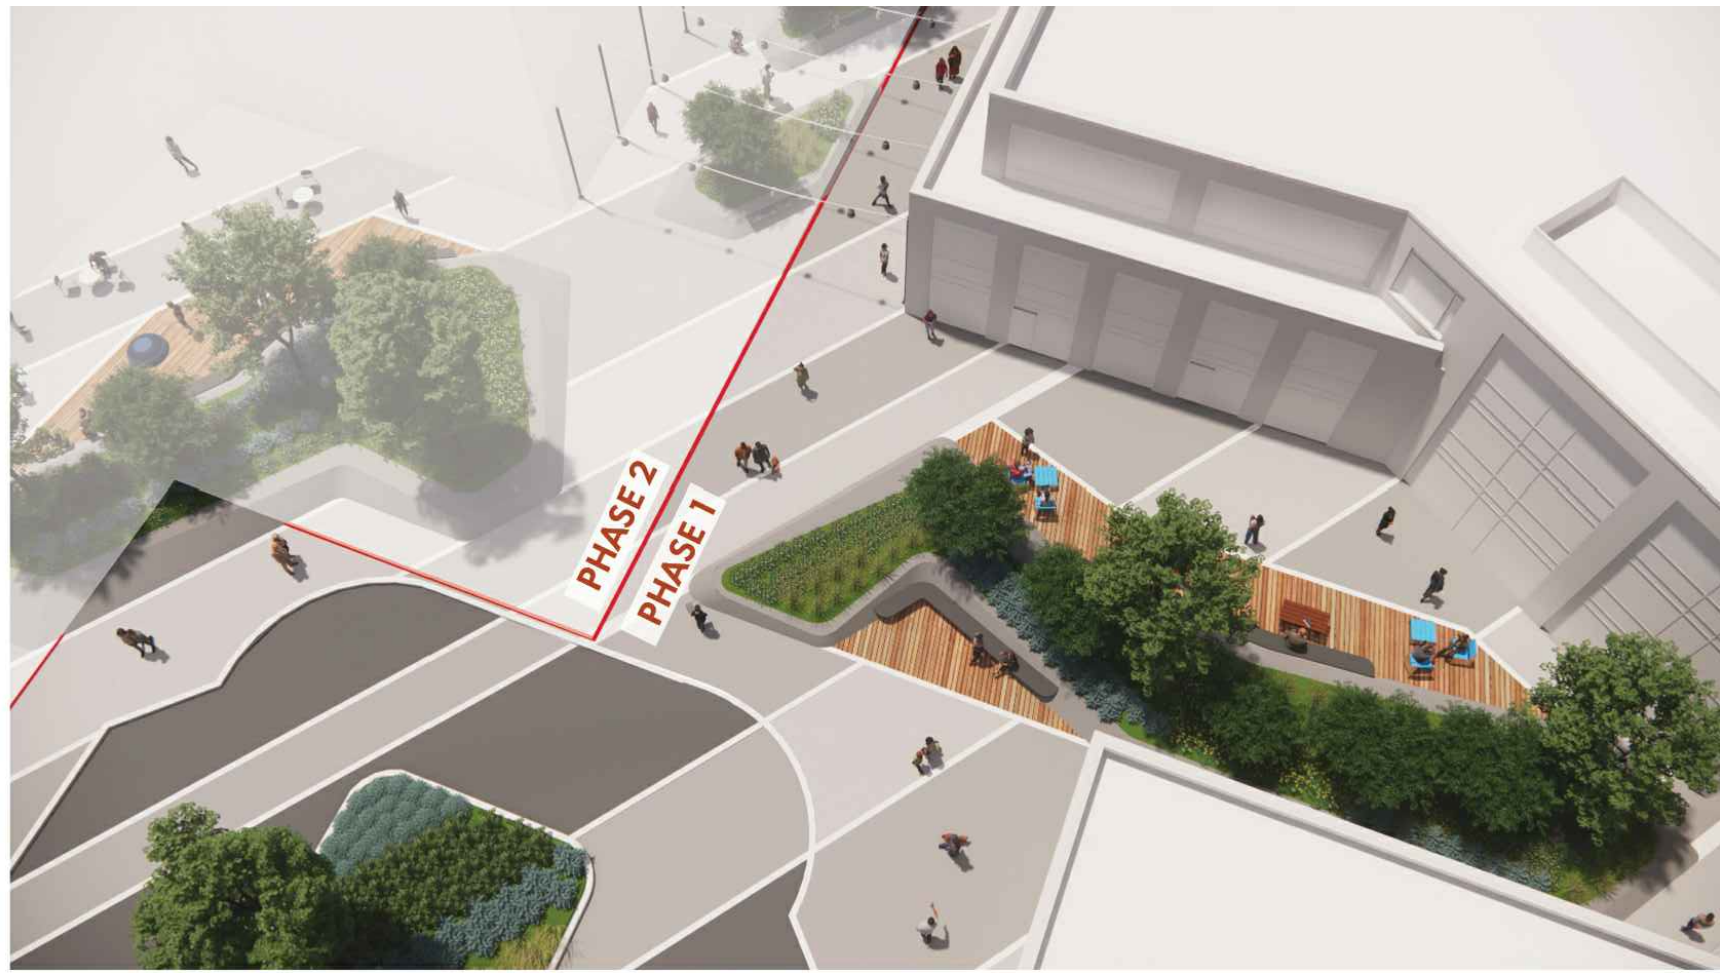

4 VIEW TOWARDS WORKING SPACE -OUTDOOR AMENITY
N.T.S



5 BUILDING FRONTAGE AND PEDESTRIAN ACCESS FROM RICHMOND ROAD
N.T.S



6 WORKING SPACE-OUTDOOR AMENITY
N.T.S



7 SCULPTURAL PLANTER- BUILDING ENTRANCE
N.T.S



8 OUTDOOR AMENITY AREA
N.T.S


Revisions

8	ISSUED FOR SPA	2024-09-03	AK
7	ISSUED FOR COORDINATION	2024-08-30	AK
6	ISSUED FOR COORDINATION	2024-08-27	AK
5	ISSUED FOR COORDINATION	2024-08-21	AK
4	ISSUED FOR LDRP	2024-07-30	AK
3	ISSUED FOR COORDINATION	2024-07-15	AK
2	ISSUED FOR COORDINATION	2024-07-12	AK
1	ISSUED FOR COORDINATION	2024-07-09	AK



Signature
YYYY-MM-DD
Date

Key map

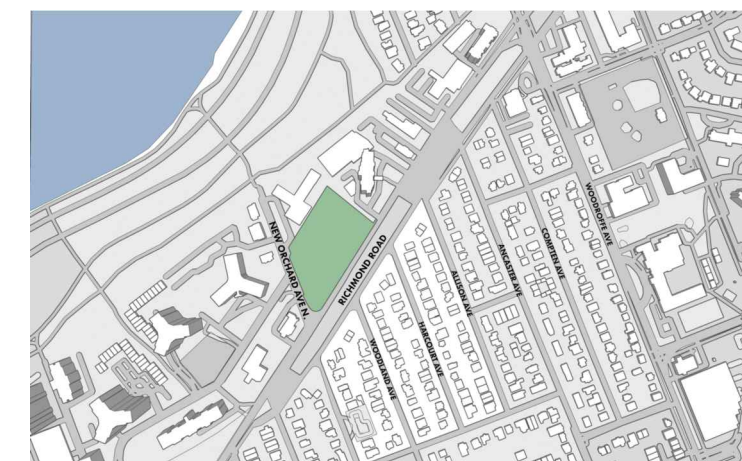

Scale North
AS SHOWN

Phase
SPA

Date
2024-07-09

Drawing Name

LANDSCAPE VIEWS

Sheet Number

NOT FOR CONSTRUCTION

LS.203