

1047 RICHMOND RD

PROJECT DESCRIPTION

A PROJECT OF
FENGATE ASSET MANAGEMENT
 2275 UPPER MIDDLE RD. E.,
 SUITE 700
 OAKVILLE, ON L6H 0C3



LANDSCAPE ARCHITECT



20 Champlain Boulevard, Suite 102
 Toronto, ON M3H 2Z1

(416) 638-4911
 info@studiotla.ca
 www.studiotla.ca

CONSULTANTS

RLA/ARCHITECTURE
 56 BEECH STREET
 OTTAWA, ONTARIO, K1S 3J6



STAMP



REVISIONS

DATE	PHASE	PROJECT NUMBER
3	ISSUED FOR SPA	2024-10-11
2	ISSUED FOR SPA	2024-09-03
1	ISSUED FOR ZBA	2023-07-12

DATE

2024

PHASE

SPA

PROJECT NUMBER

22-178



Sheet List Table

Sheet Number	Sheet Title
LC.000	COVER PAGE
LS.101	LANDSCAPE PLAN-ULTIMATE
LS.102	LANDSCAPE PLAN-INTERIM
LSV.100	SOIL VOLUME NOTES & SCHEDULE
LSV.101	SOIL VOLUME PLAN
LU.100	COMPOSITE UTILITY PLAN
LL.100	LANDSCAPE LIGHTING PLAN
LP.100	PLANTING SCHEDULE AND NOTES
LP.101	PLANTING PLAN
LS.200	LANDSCAPE DETAILS
LS.201	LANDSCAPE DETAILS
LS.202	LANDSCAPE DETAILS
LS.203	LANDSCAPE VIEWS

THE INTENT OF THIS DRAWING IS TO REPRESENT THE ULTIMATE SITE DESIGN FOR PHASE 1 AND PHASE 2.

- LEGEND**
- PLANTING AREA
 - SOD
 - UNIT PAVER
 - HEAVY DUTY UNIT PAVER
 - CONCRETE
 - WOOD DECK
 - PROPERTY LINE
 - BUILDING SETBACK LINE
 - BIKE RACK
 - BENCH
 - CATENARY LIGHTING
 - TACTILE PAVING
 - PROPOSED TREES
 - TREE REMOVAL
 - FIRE HYDRANT
 - VEHICULAR DIRECTION
 - SIAMSE CONNECTION
 - ROAD SIGN

Landscape Architect

STUDIO tla

20 Champlain Blvd, Suite 102 - Toronto ON - M3H 2Z1
(416) 638-4911 - info@studiotla.ca - studiotla.ca

1047 RICHMOND RD

OTTAWA, ON K2B 6R1

Project Number
22-178

Client
FENGATE
2275 UPPER MIDDLE RD. E.,
SUITE 700
OAKVILLE, ON L6H 0C3

Consultant
rla/architecture
ARCHITECTURE
56 Beach Street
OTTAWA, ON K1S3J6, CANADA
TEL: 613.724.9932

Revisions

Rev	Description	Date	By
9	ISSUED FOR SPA	2024-10-11	AK
8	ISSUED FOR SPA	2024-09-03	AK
7	ISSUED FOR COORDINATION	2024-08-30	AK
6	ISSUED FOR COORDINATION	2024-08-27	AK
5	ISSUED FOR COORDINATION	2024-08-21	AK
4	ISSUED FOR UDRP	2024-07-30	AK
3	ISSUED FOR COORDINATION	2024-07-15	AK
2	ISSUED FOR COORDINATION	2024-07-12	AK
1	ISSUED FOR COORDINATION	2024-07-09	AK



 
Signature
YYYY-MM-DD
Date

Keymap



Scale
AS SHOWN

North



Phase

SPA

Date

2024-07-09

Drawing Name


LANDSCAPE PLAN-ULTIMATE

Sheet Number

NOT FOR CONSTRUCTION

LS.101

© STUDIO tla

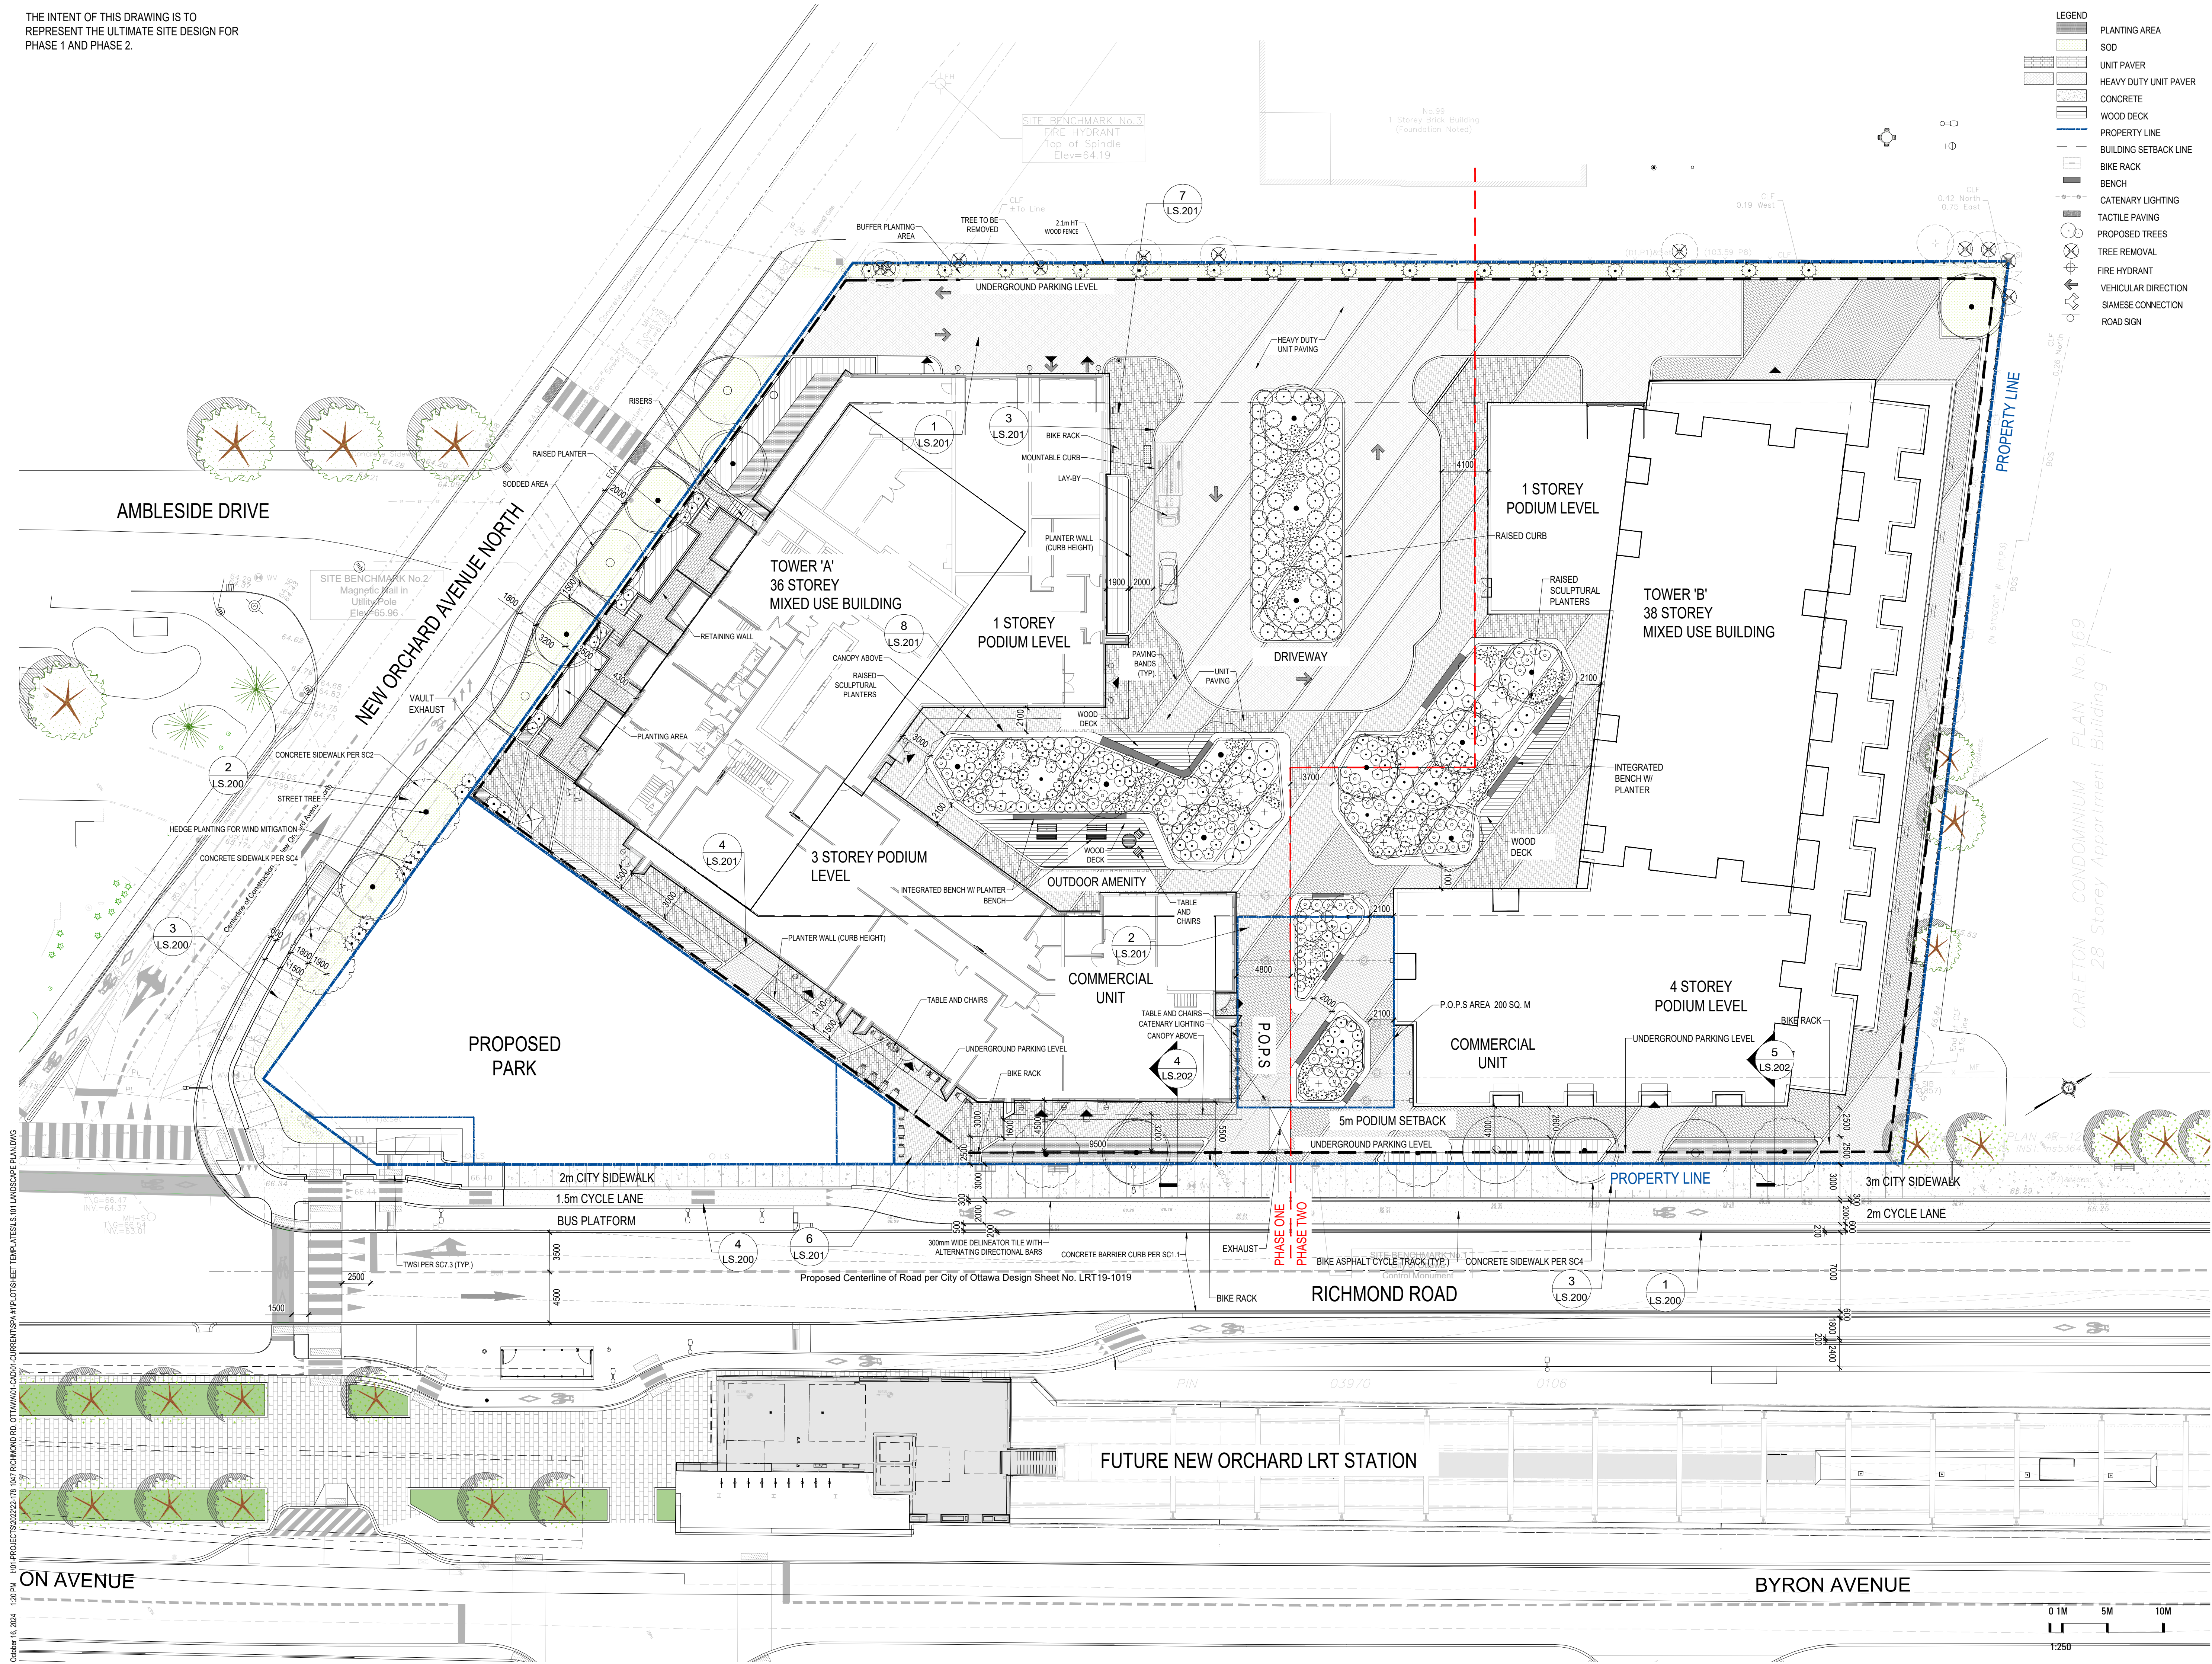

October 16, 2024 1:20 PM I:\01-PROJECTS\2022\22-178 1047 RICHMOND RD, OTTAWA\CAD\01-CURRENT\SPA\PLOTSHEET\TEMPLATES\01 LANDSCAPE PLAN.DWG

1047 RICHMOND RD

OTTAWA, ON K2B 6R1

Project Number
22-178

Client
FENGATE
2275 UPPER MIDDLE RD. E.,
SUITE 700
OAKVILLE, ON L6H 0C3


Consultant
rla/architecture
ARCHITECTURE
56 Beach Street
OTTAWA, ON K1S3J6, CANADA
TEL: 613.724.9932

Revisions


No.	Description	Date	By
9	ISSUED FOR SPA	2024-10-11	AK
8	ISSUED FOR SPA	2024-09-03	AK
7	ISSUED FOR COORDINATION	2024-08-30	AK
6	ISSUED FOR COORDINATION	2024-08-27	AK
5	ISSUED FOR COORDINATION	2024-08-21	AK
4	ISSUED FOR UDRP	2024-07-30	AK
3	ISSUED FOR COORDINATION	2024-07-15	AK
2	ISSUED FOR COORDINATION	2024-07-12	AK
1	ISSUED FOR COORDINATION	2024-07-09	AK

Signature
YYYY-MM-DD
Date

Key map

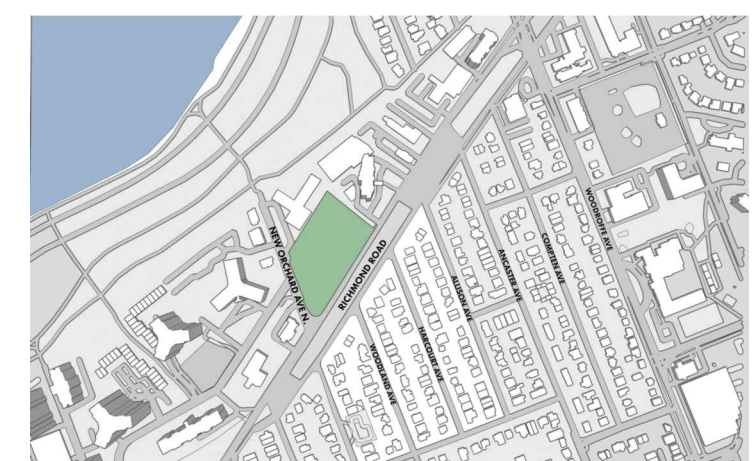

Scale
AS SHOWN

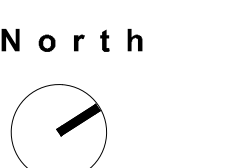

Phase
SPA

Date
2024-07-09


Drawing Name

LANDSCAPE PLAN-INTERIM

Sheet Number

NOT FOR CONSTRUCTION

LS.102

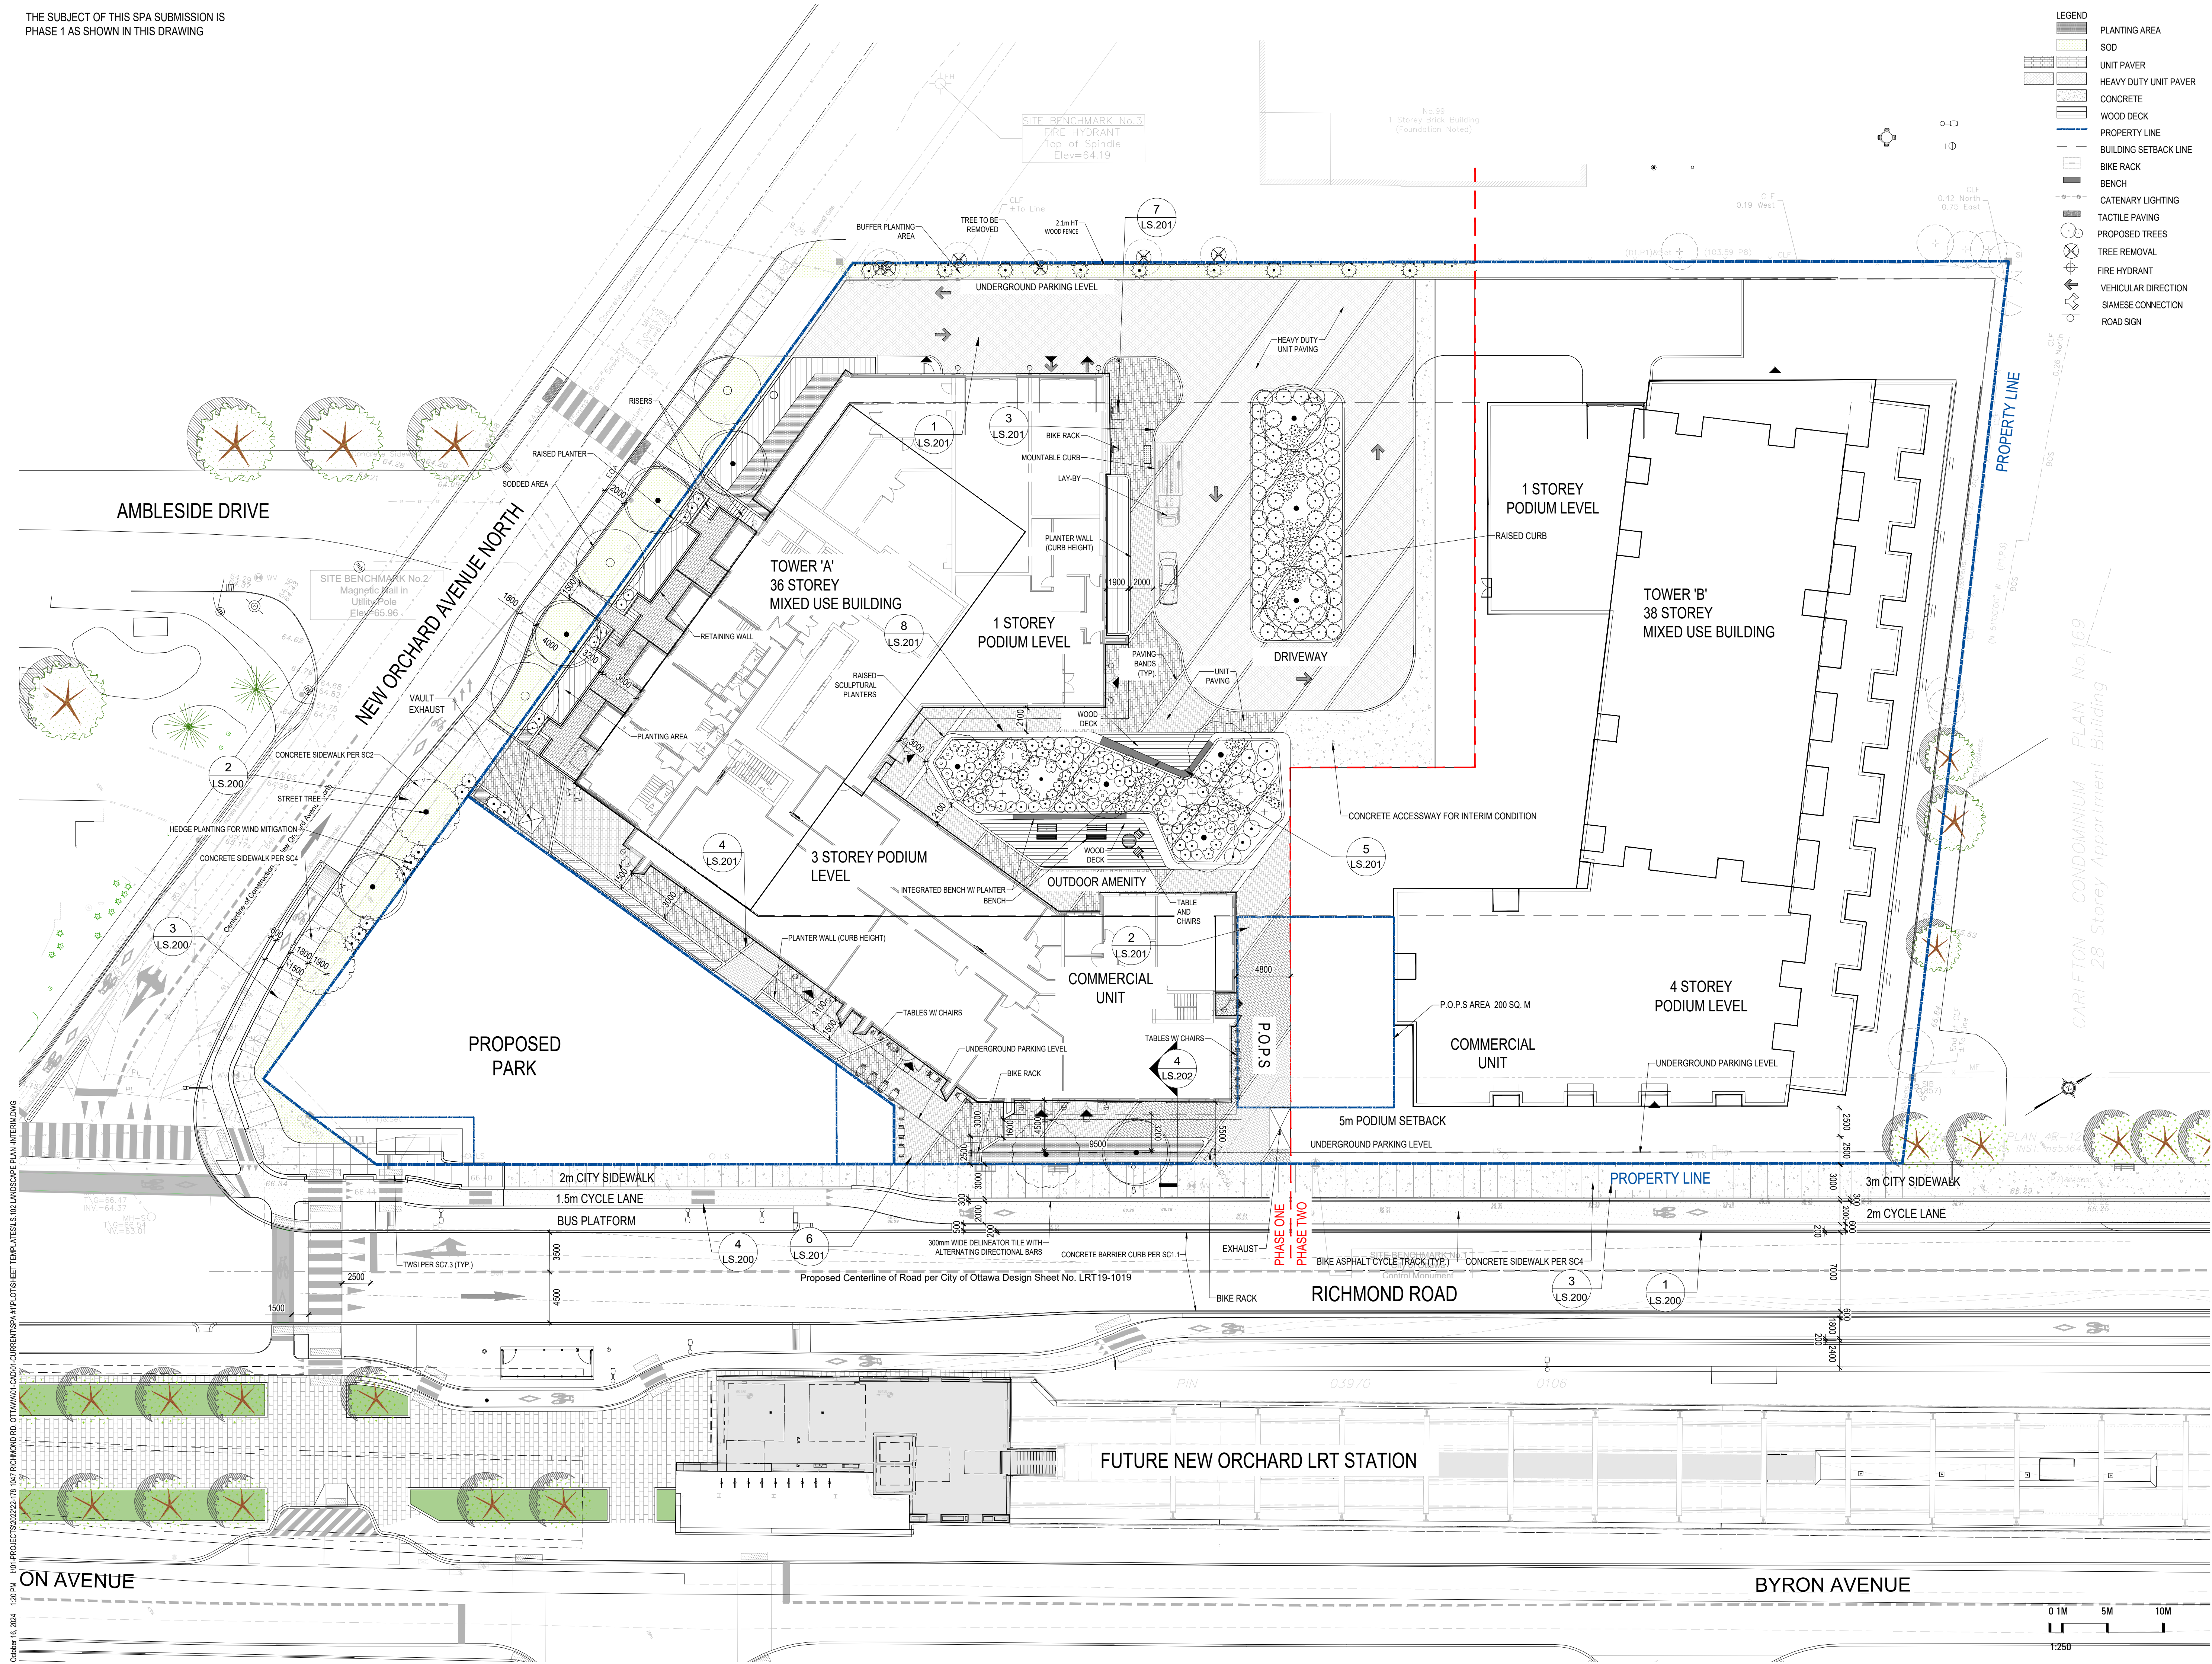

October 16, 2024 1:20 PM I:\01-PROJECTS\2022\1047 RICHMOND RD, OTTAWA\CAD\01-CURRENT SPA\PILOTSHEET\TEMPLATES\02 LANDSCAPE PLAN-INTERIM.DWG

1047 RICHMOND RD

OTTAWA, ON K2B 6R1

Project Number
22-178

Client **FENGATE**
FENGATE
2275 UPPER MIDDLE RD. E.,
SUITE 700
OAKVILLE, ON L6H 0C3

Consultant
ARCHITECTURE
RLA/ARCHITECTURE
55 Beach Street
OTTAWA, ON K1S3J6, CANADA
TEL: 613.724.9932



Revisions

9	ISSUED FOR SPA	2024-10-11	AK
8	ISSUED FOR SPA	2024-09-03	AK
7	ISSUED FOR COORDINATION	2024-08-30	AK
6	ISSUED FOR COORDINATION	2024-08-27	AK
5	ISSUED FOR COORDINATION	2024-08-21	AK
4	ISSUED FOR UDRP	2024-07-30	AK
3	ISSUED FOR COORDINATION	2024-07-15	AK
2	ISSUED FOR COORDINATION	2024-07-12	AK
1	ISSUED FOR COORDINATION	2024-07-09	AK




Signature

YYYY-MM-DD

Date

Key map

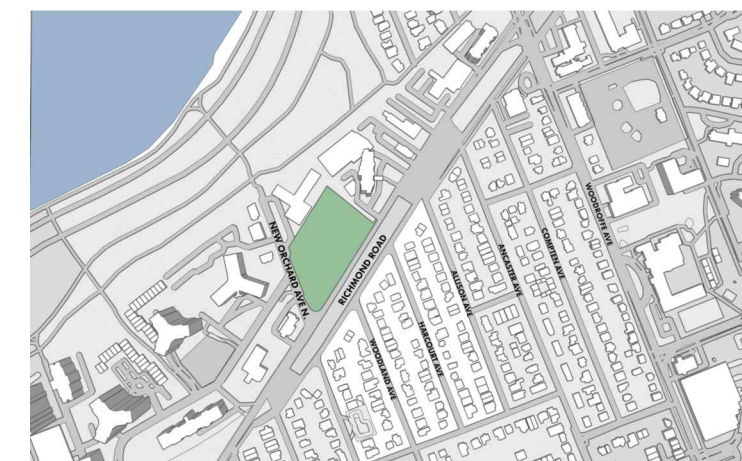

Scale **North**
AS SHOWN

Phase

SPA

Date

2024-07-09

Drawing Name

SOIL VOLUME NOTES & SCHEDULE

Sheet Number

NOT FOR CONSTRUCTION

LSV.100

	Location (City ROW, private property)	Soil Area (m ²)	Soil Depth(m*)	Proposed Soil Volume (m ³)	Tree Quantity	Proposed Soil Volume per tree (m ³)	Ottawa Target Soil Volume per tree (m ³)	Soil Adequacy percentagepp er tree	Soil Cells (Yes/No)
1 (Large Trees)	ROW	39	1.2	46.8	1	46.8	20	234%	No
2 (Large Trees)	ROW	53	1.2	63.6	2	31.8	18	177%	No
3 (Large Trees)	ROW	45	1.2	54	2	27.0	18	150%	No
4 (Large Trees)	ROW	58	1.2	69.6	3	23.2	18	129%	No
5 (Large Treess)	Private Property	59	1	59	1	59.0	20	295%	No
6 (Large Trees)	Private Property	175	1	175	3	58.3	18	324%	No
7 (Small Trees)	Private Property	150	1.2	180	7	25.7	12	214%	No
7 (Large Trees)	Private Property	68	1.2	81.6	4	20.4	20	102%	No
8 (Large Trees)	Private Property	39	1	39	2	19.5	18	108%	No
9 (Large Trees)	Private Property	60	1	60	3	20.0	18	111%	Yes
10 (Large Trees)	Private Property	40	1	40	2	20.0	18	111%	Yes
11 (Small Trees)	Private Property	29	1.2	34.8	2	17.4	12	145%	No
12 (Small Trees)	Private Property	32	1.2	38.4	3	12.8	12	107%	No
13 (Small Trees)	Private Property	120	1.2	144	8	18.0	12	150%	No
13 (Large Trees)	Private Property	80	1.2	96	4	24.0	20	120%	No
Totals		1047	17	1181.8	47	423.9	254	167%	

1047 RICHMOND RD

OTTAWA, ON K2B 6R1

Project Number
22-178

Client
FENGATE
2275 UPPER MIDDLE RD. E.,
SUITE 700
OAKVILLE, ON L6H 0C3

Consultant
RLA/ARCHITECTURE
55 Beach Street
OTTAWA, ON K1S3J6, CANADA
TEL: 613.724.9932



Revisions

9	ISSUED FOR SPA	2024-10-11	AK
8	ISSUED FOR SPA	2024-09-03	AK
7	ISSUED FOR COORDINATION	2024-08-30	AK
6	ISSUED FOR COORDINATION	2024-08-27	AK
5	ISSUED FOR COORDINATION	2024-08-21	AK
4	ISSUED FOR LDRP	2024-07-30	AK
3	ISSUED FOR COORDINATION	2024-07-15	AK
2	ISSUED FOR COORDINATION	2024-07-12	AK
1	ISSUED FOR COORDINATION	2024-07-09	AK




Signature
YYYY-MM-DD
Date

Key map



Scale
AS SHOWN

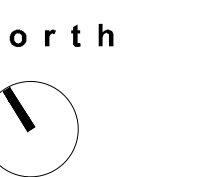

Phase

SPA

Date

2024-07-09


Drawing Name

SOIL VOLUME PLAN

Sheet Number

NOT FOR CONSTRUCTION

LSV.101

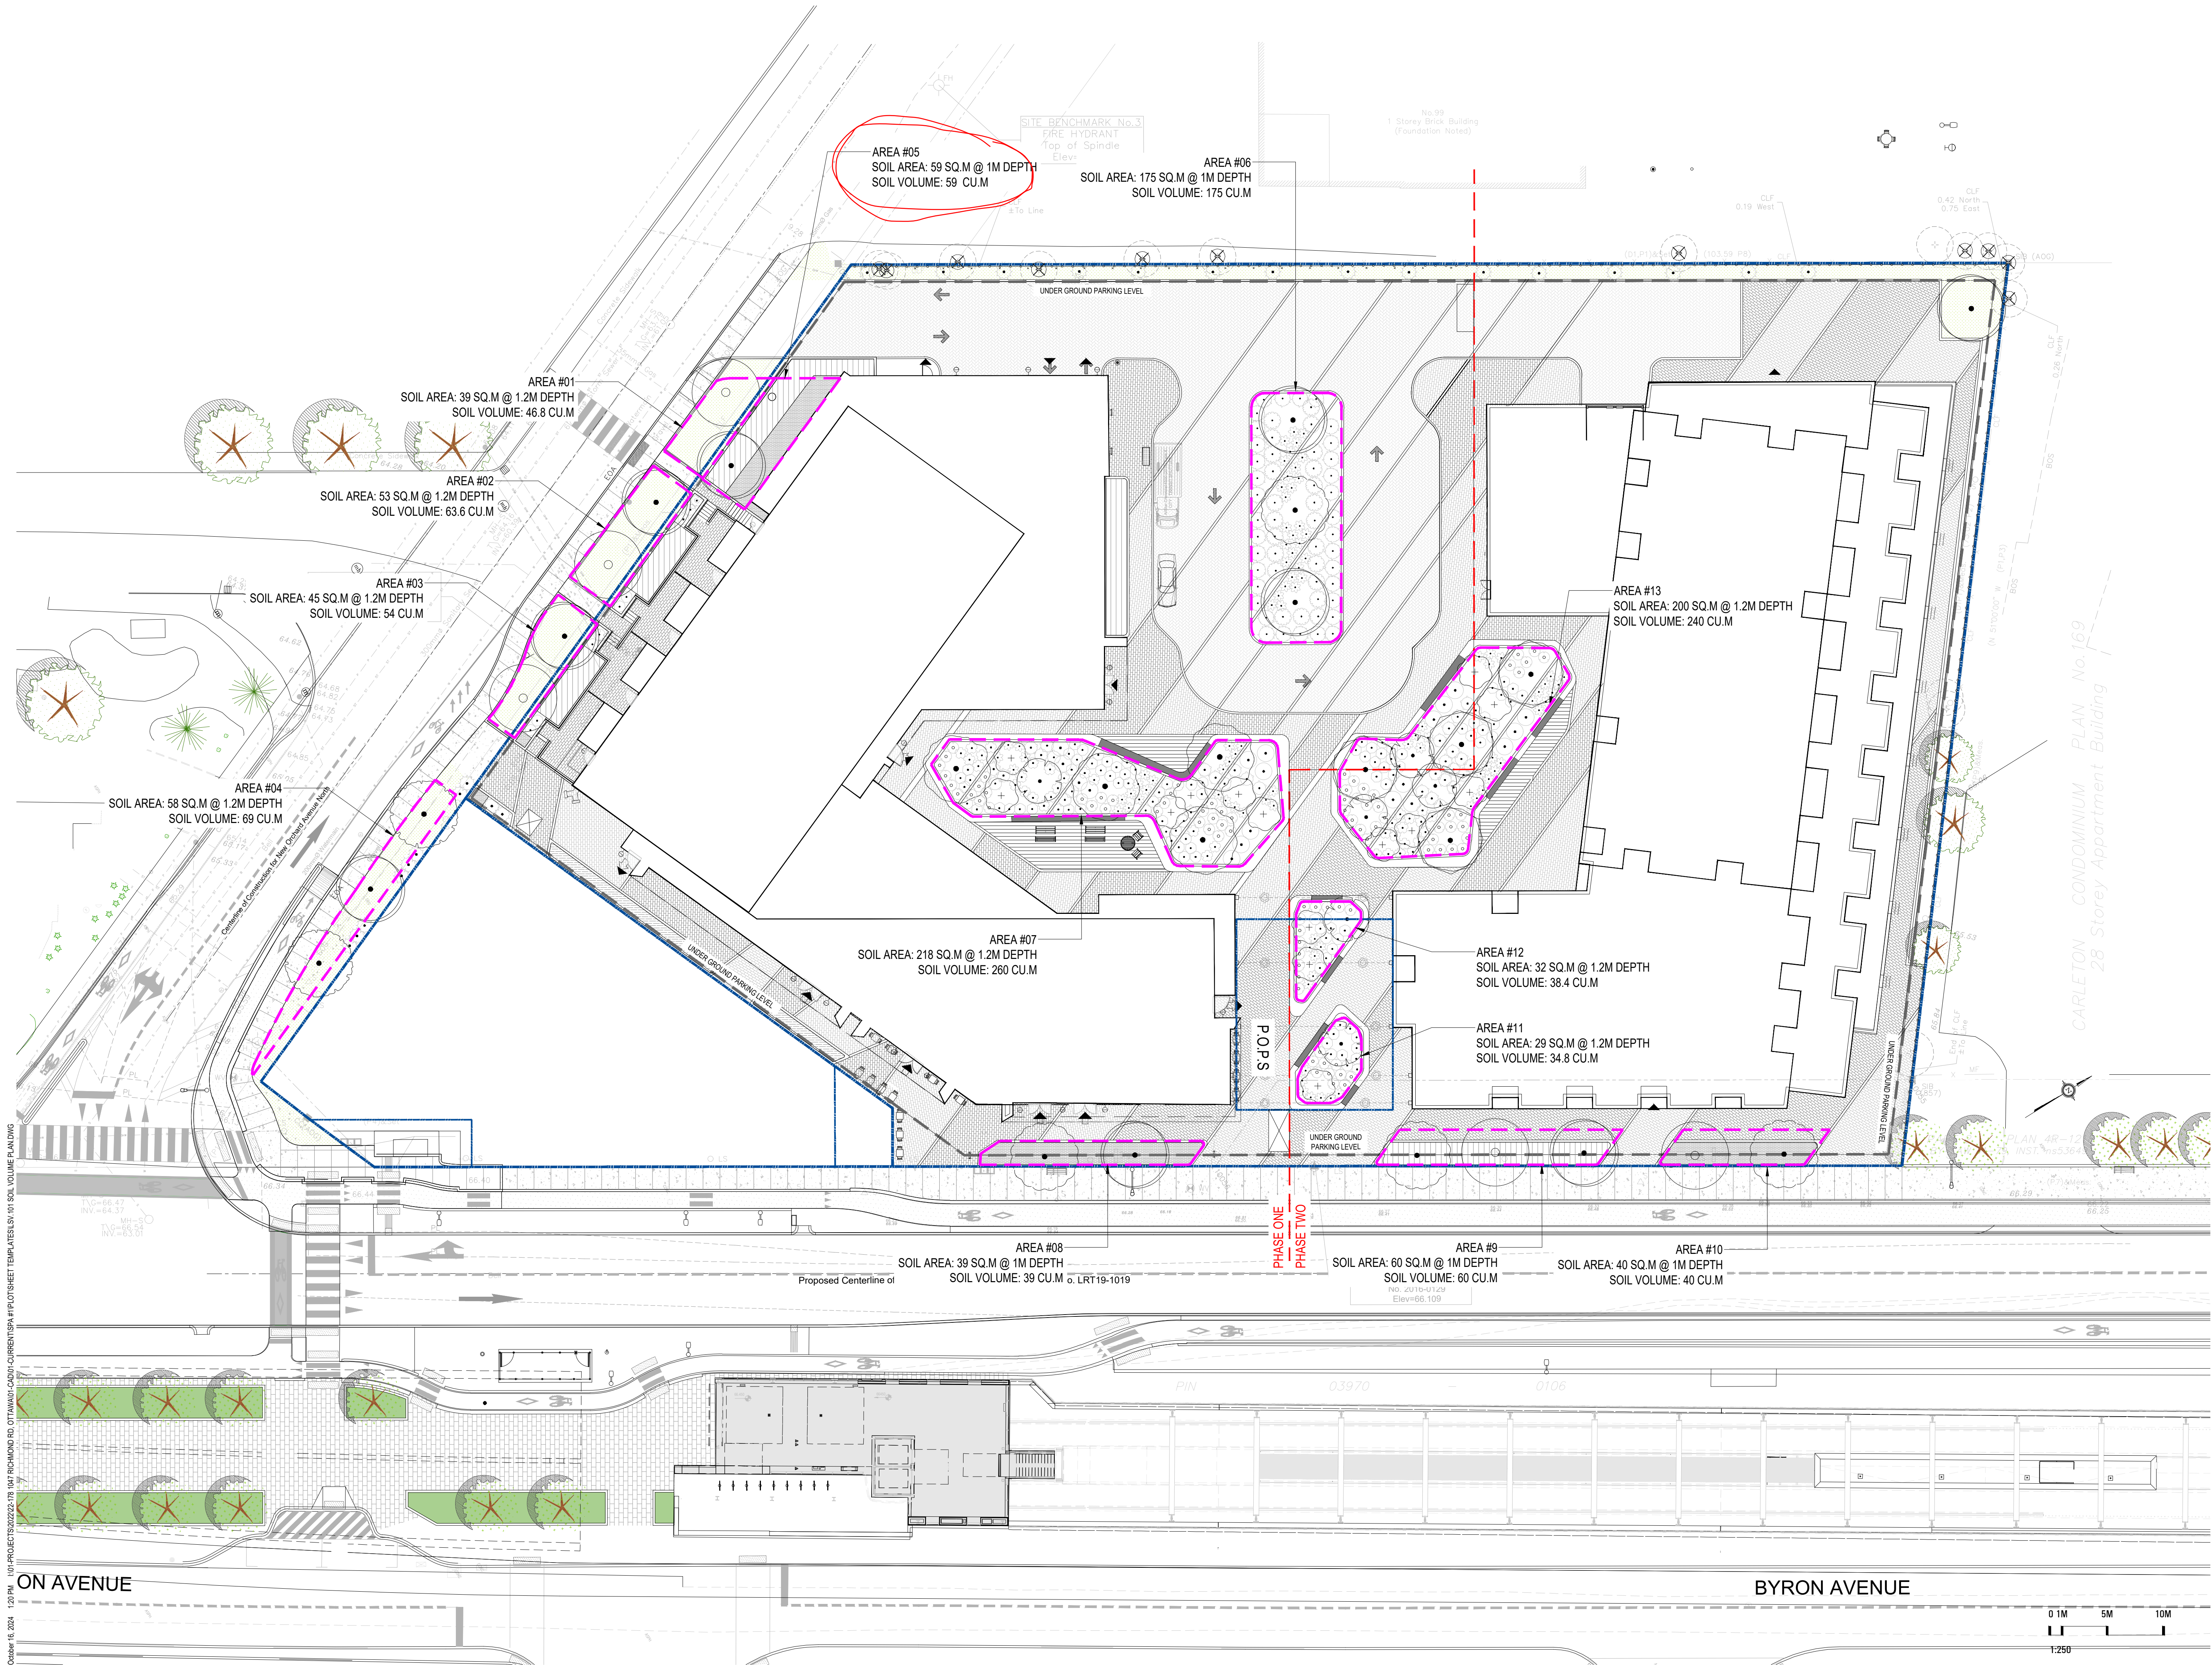

October 16, 2024 1:20 PM I:\01-PROJECTS\2022\22-178 1047 RICHMOND RD, OTTAWA\CAD\04-CURRENT\SPA#PLOTSHEET\TEMPLATES\SV\01 SOIL VOLUME PLAN.DWG

1047 RICHMOND RD

OTTAWA, ON K2B 6R1

Project Number
22-178

Client
FENGATE
2275 UPPER MIDDLE RD. E.,
SUITE 700
OAKVILLE, ON L6H 0C3

Consultant
ARCHITECTURE
RLA/ARCHITECTURE
56 Beach Street
OTTAWA, ON K1S3J6, CANADA
TEL: 613.724.9932



Revisions

Rev	Description	Date	By
9	ISSUED FOR SPA	2024-10-11	AK
8	ISSUED FOR SPA	2024-09-03	AK
7	ISSUED FOR COORDINATION	2024-08-30	AK
6	ISSUED FOR COORDINATION	2024-08-27	AK
5	ISSUED FOR COORDINATION	2024-08-21	AK
4	ISSUED FOR UDRP	2024-07-30	AK
3	ISSUED FOR COORDINATION	2024-07-15	AK
2	ISSUED FOR COORDINATION	2024-07-12	AK
1	ISSUED FOR COORDINATION	2024-07-09	AK




Signature
YYYY-MM-DD
Date

Key map



Scale
AS SHOWN

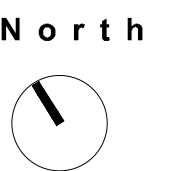

Phase
SPA

Date
2024-07-09


Drawing Name

COMPOSITE UTILITY PLAN

Sheet Number

NOT FOR CONSTRUCTION

LU.100

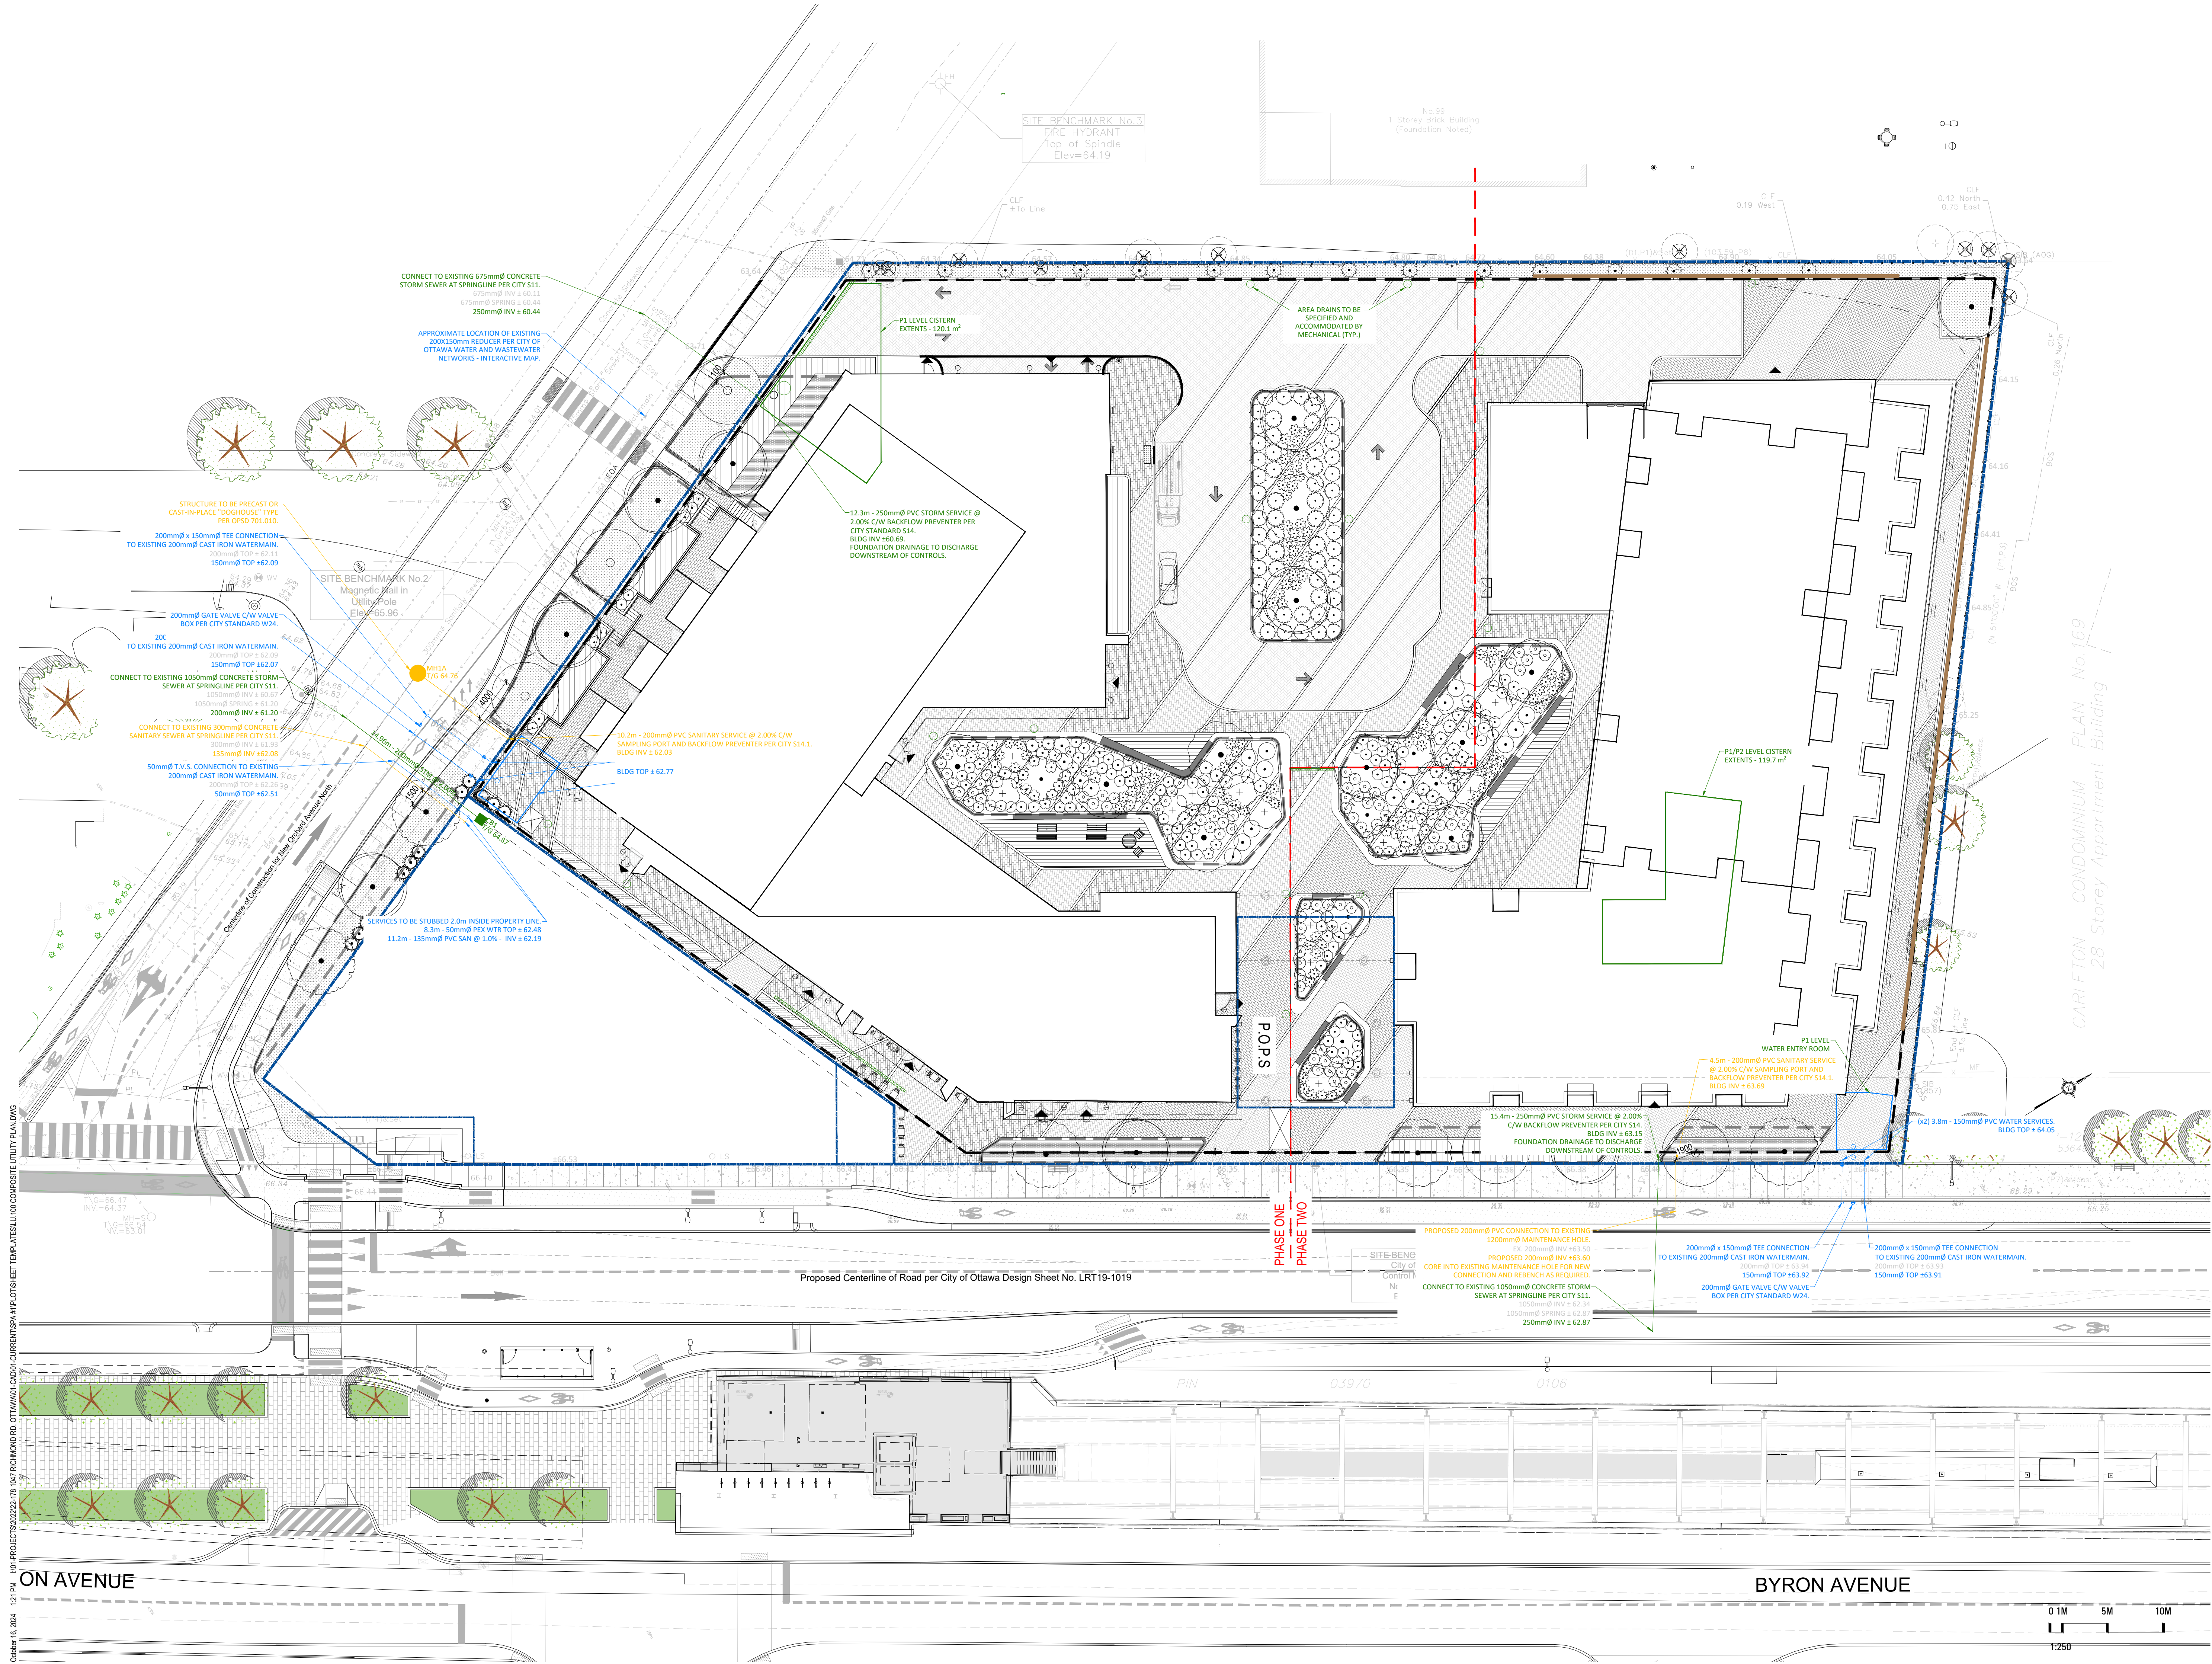

October 16, 2024 1:21 PM I:\01-PROJECTS\2022\22-178 1047 RICHMOND RD, OTTAWA\CAD\DWG\CURRENTS\SP\PILOTS\LU.100-COMPOSITE UTILITY PLAN.DWG

1047 RICHMOND RD

OTTAWA, ON K2B 6R1

Project Number
22-178

Client
FENGATE
FENGATE
2275 UPPER MIDDLE RD. E.,
SUITE 700
OAKVILLE, ON L6H 0C3

Consultant
RLA ARCHITECTURE
55 Beach Street
OTTAWA, ON K1S3J6, CANADA
TEL: 613.724.9932




Revisions

9	ISSUED FOR SPA	2024-10-11	AK
8	ISSUED FOR SPA	2024-09-03	AK
7	ISSUED FOR COORDINATION	2024-08-30	AK
6	ISSUED FOR COORDINATION	2024-08-27	AK
5	ISSUED FOR COORDINATION	2024-08-21	AK
4	ISSUED FOR UDRP	2024-07-30	AK
3	ISSUED FOR COORDINATION	2024-07-15	AK
2	ISSUED FOR COORDINATION	2024-07-12	AK
1	ISSUED FOR COORDINATION	2024-07-09	AK




Signature
YYYY-MM-DD
Date

Key map

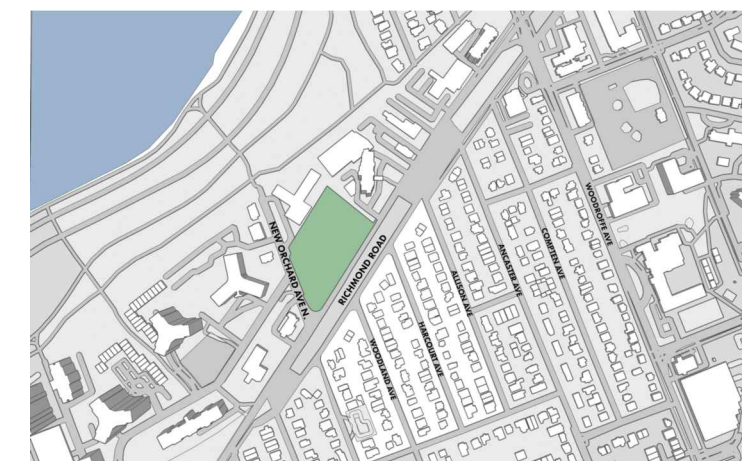

Scale
AS SHOWN

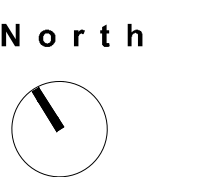

Phase
SPA

Date
2024-07-09

Drawing Name

LANDSCAPE LIGHTING PLAN


Sheet Number

NOT FOR CONSTRUCTION

LL.100

EXTERIOR LIGHTING FIXTURE SCHEDULE						
TYPE	DESCRIPTION	CATALOG NUMBER	LAMPS PER FIXTURE	VOLTS	MOUNTING	REMARKS
			TYPE	WATTS		
A	WALL SCONCE	MAC LIGHTING WS-W2106-30	LED	8.4	3000K	120 SURFACE C/W ACCESSORIES
B1	BOLLARD	SIGNIFY GARDCO FBL-42-14L-200-WW-G2-S-UN	LED	10.6	3000K	120 SURFACE C/W ACCESSORIES
B2	BOLLARD	SIGNIFY GARDCO FBL-42-14L-200-WW-G2-S-UN	LED	10.6	3000K	120 SURFACE C/W ACCESSORIES
C	WALL MOUNTED	MAC LIGHTING DC-W02517-F30A	LED	16.7	3000K	120 SURFACE C/W ACCESSORIES
P	POLE	GARDCO PPT-G-404-830-15M	LED	50.4	3000K	120 SURFACE C/W ACCESSORIES
R	RECESSED	BEGA Z4806K3	LED	22	3000K	120 SURFACE C/W ACCESSORIES
S	RECESSED	BEGA Z3556K3	LED	11	3000K	120 SURFACE C/W ACCESSORIES
W	WALL SCONCE	SIGNIFY GARDCO 101L-16L-530-WW-G2-4	LED	28.1	3000K	120 SURFACE C/W ACCESSORIES

NOTE: LIGHT FIXTURES EQUAL IN AESTHETICS AND PERFORMANCE ARE ACCEPTABLE.
ALL LED FIXTURES SHALL BE C/W DRIVERS.

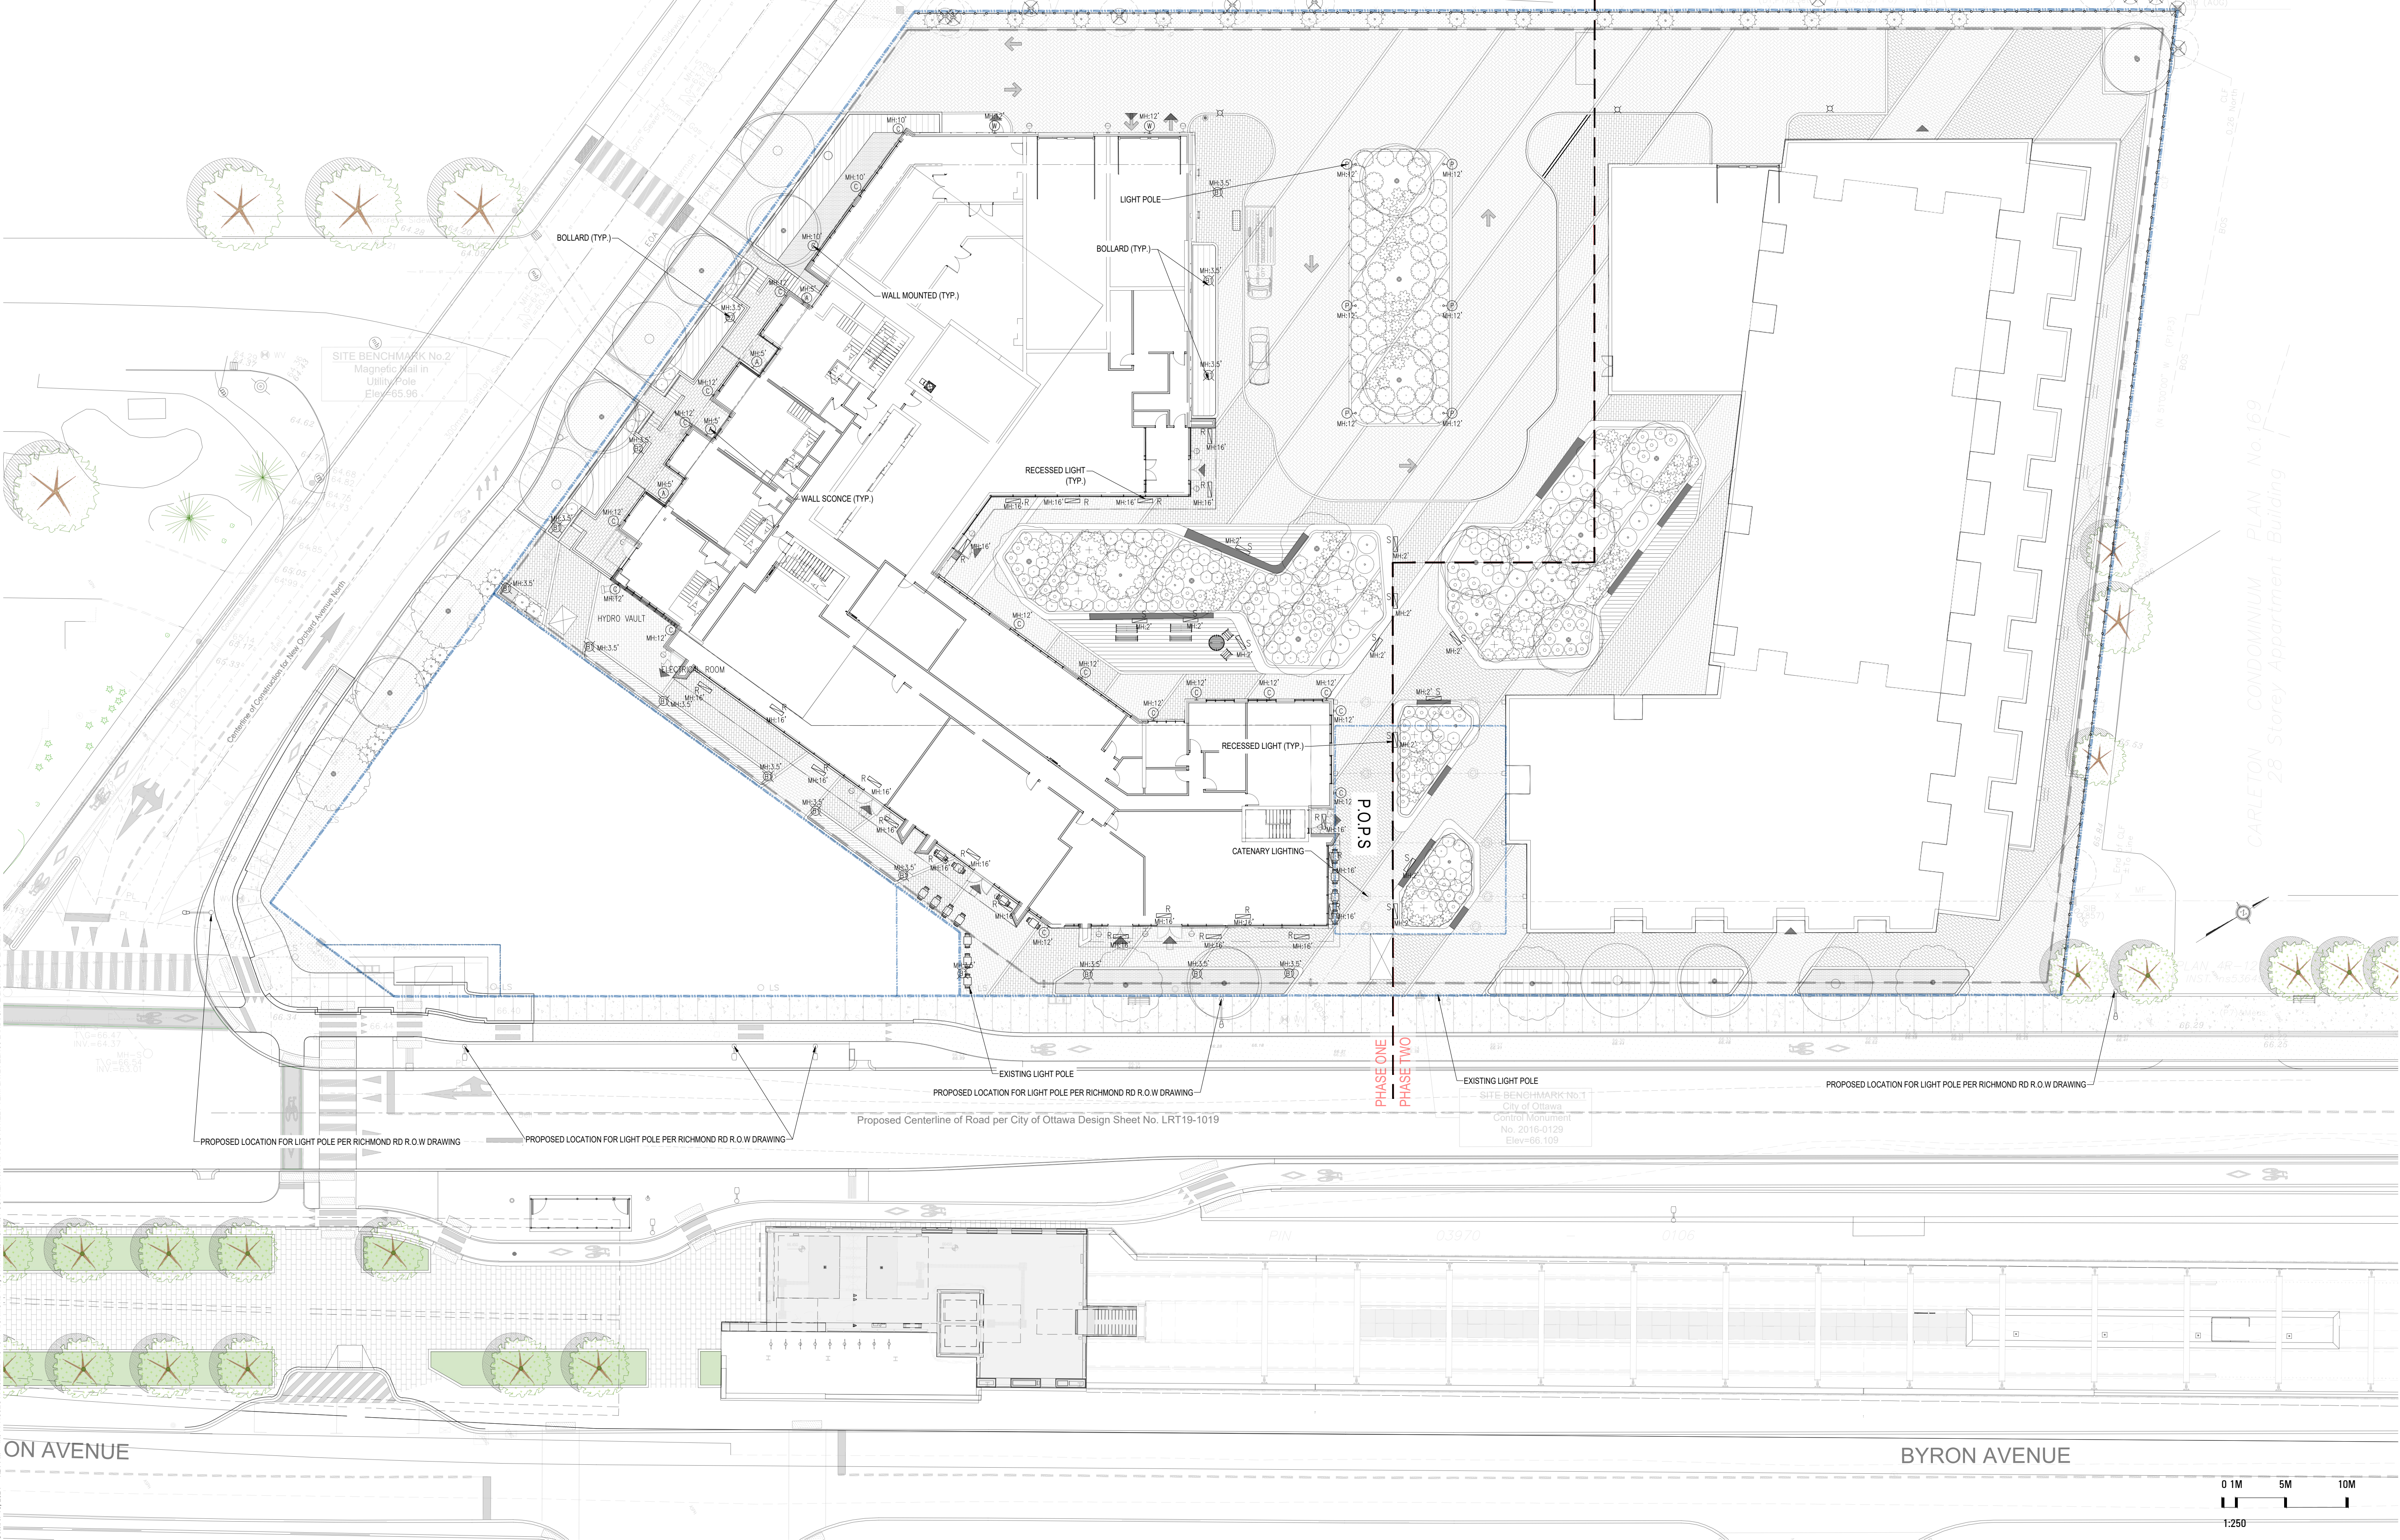

October 16, 2024 1:21 PM I:\01-PROJECTS\2022\22-178 1047 RICHMOND RD, OTTAWA\CAD\04-CURRENT SPA\PILOTSHEET\100 LANDSCAPE LIGHTING PLAN.DWG



20 Champlain Blvd, Suite 102 - Toronto ON - M3H 2Z1
(416) 638-4911 - info@studiotla.ca - studiotla.ca

1047 RICHMOND RD

OTTAWA, ON K2B 6R1

Project Number
22-178

Client
FENGATE
2275 UPPER MIDDLE RD. E.,
SUITE 700
OAKVILLE, ON L6H 0C3

Consultant
ARCHITECTURE
RLA/ARCHITECTURE
55 Beach Street
OTTAWA, ON K1S3J6, CANADA
TEL: 613.724.9932



PLANT SCHEDULE R.O.W							
SYMBOL	CODE	QTY	BOTANICAL NAME	COMMON NAME	CONT.	CAL.	REMARKS
TREES							
	AX	3	ACER X FREEMANII	FREEMAN MAPLE	B&B	60MM CAL.	NATIVE TO ONTARIO
	CO	2	CELTIS OCCIDENTALIS	COMMON HACKBERRY	B&B	60MM CAL.	NATIVE TO ONTARIO
	QR	3	QUERCUS RUBRA	NORTHERN RED OAK	B&B	70MM CAL.	NATIVE TO ONTARIO
SYMBOL	CODE	QTY	BOTANICAL NAME	COMMON NAME	CONT.	HT.	REMARKS
SHRUBS							
	Jj	8	JUNIPERUS COMMUNIS	COMMON JUNIPER	2 GAL.		NATIVE

PLANT SCHEDULE SUBJECT SITE										
SYMBOL	CODE	QTY	BOTANICAL NAME	COMMON NAME	CONT.	CAL.	HT.			REMARKS
TREES										
	AX	6	ACER X FREEMANII	FREEMAN MAPLE	B&B	60MM CAL.				NATIVE TO ONTARIO
	AA	14	AMELANCHIER ARBOREA	DOWNY SERVICEBERRY	B&B	60MM CAL.				NATIVE TO ONTARIO
	CC	6	CRATAEGUS CRUS-GALLI	COCKSPUR HAWTHORN	B&B	60MM CAL.				NATIVE TO ONTARIO
	GK	4	GYMNOCLADUS DIOICUS	KENTUCKY COFFEETREE	B&B					
	OV	4	OSTRYA VIRGINIANA	AMERICAN HOPHORNBEAM	B&B					NATIVE TO ONTARIO
	QM	4	QUERCUS MACROCARPA	BURR OAK	B&B					NATIVE TO ONTARIO
	QR	2	QUERCUS RUBRA	NORTHERN RED OAK	B&B	70MM CAL.				NATIVE TO ONTARIO
SYMBOL	CODE	QTY	BOTANICAL NAME	COMMON NAME	CONT.	HT.	SPR.			REMARKS
SHRUBS										
	AI	105	AMORPHA CANESCENS	LEADPLANT	2 GAL.					NATIVE, DROUGHT TOLERANT POLLINATOR SHRUB. ATTRACTS BUTTERFLIES.
	Ca	85	CEANOTHUS AMERICANUS	NEW JERSEY TEA	3 GAL.		60 CM			NATIVE, DROUGHT TOLERANT SHRUB. FRAGRANT POLLINATOR THAT ATTRACTS BUTTERFLIES AND HUMMINGBIRDS.
	Cf	33	CORNUS SERICEA 'FLAVIRAMEA'	YELLOW TWIG DOGWOOD	3 GAL.					SALT TOLERANT
	DI	96	DIERVILLA LONICERA	BUSH HONEYSUCKLE	2 GAL.					NATIVE
	Iw	37	ILEX VERTICILLATA	WINTERBERRY	1 GAL.					NATIVE
	Jj	17	JUNIPERUS COMMUNIS	COMMON JUNIPER	2 GAL.					NATIVE
	Jb	34	JUNIPERUS HORIZONTALIS 'BLUE CHIP'	BLUE CHIP CREEPING JUNIPER	2 GAL.		30 CM			
	Pa	23	PEROVSKIA ABROTANOIDES	RUSSIAN SAGE	2 GAL.					
	Rt	19	RHUS TYPHINA	STAGHORN SUMAC	2 GAL.					NATIVE
SYMBOL	CODE	QTY	BOTANICAL NAME	COMMON NAME	CONT.			SPACING		REMARKS
GRASSES										
	Pr	52,580	PANICUM VIRGATUM 'ROTSTRAHLBUSCH'	ROTSTRAHLBUSCH RED SWITCH GRASS	1 GAL.			50 mm		NATIVE, DROUGHT & SALT TOLERANT
	Sn	138.6 m²	SORGHASTRUM NUTANS	INDIAN GRASS	2 GAL.					NATIVE, SALT AND DROUGHT TOLERANT POLLINATOR

Revisions

9	ISSUED FOR SPA	2024-10-11	AK
8	ISSUED FOR SPA	2024-09-03	AK
7	ISSUED FOR COORDINATION	2024-08-30	AK
6	ISSUED FOR COORDINATION	2024-08-27	AK
5	ISSUED FOR COORDINATION	2024-08-21	AK
4	ISSUED FOR UDRP	2024-07-30	AK
3	ISSUED FOR COORDINATION	2024-07-15	AK
2	ISSUED FOR COORDINATION	2024-07-12	AK
1	ISSUED FOR COORDINATION	2024-07-09	AK




Signature
YYYY-MM-DD
Date

Keymap



Scale
AS SHOWN

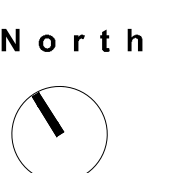

Phase
SPA

Date
2024-07-09

Drawing Name


PLANTING SCHEDULE AND NOTES

Sheet Number

NOT FOR CONSTRUCTION

LP.100


Canopy Cover Area Take-Offs	Area (m ²)
Total Site Area (subject site only; excluding Park)	9067
Phase 1	5065
Phase 2	4002
Total Open Space (subject site only; excluding Park)	4806
Phase 1	2942
Phase 2	1864
Tree Canopy Cover at Maturity (subject site only; excluding Park)	
Phase 1	640
Phase 2	840
Total Tree Canopy Cover at Maturity (within subject site only)	1480
Percentage of Site with Tree Cover at Maturity (Subject Site ONLY; excluding R.O.W. 16%)	
Tree Canopy Cover at Maturity (in R.O.W.)	582

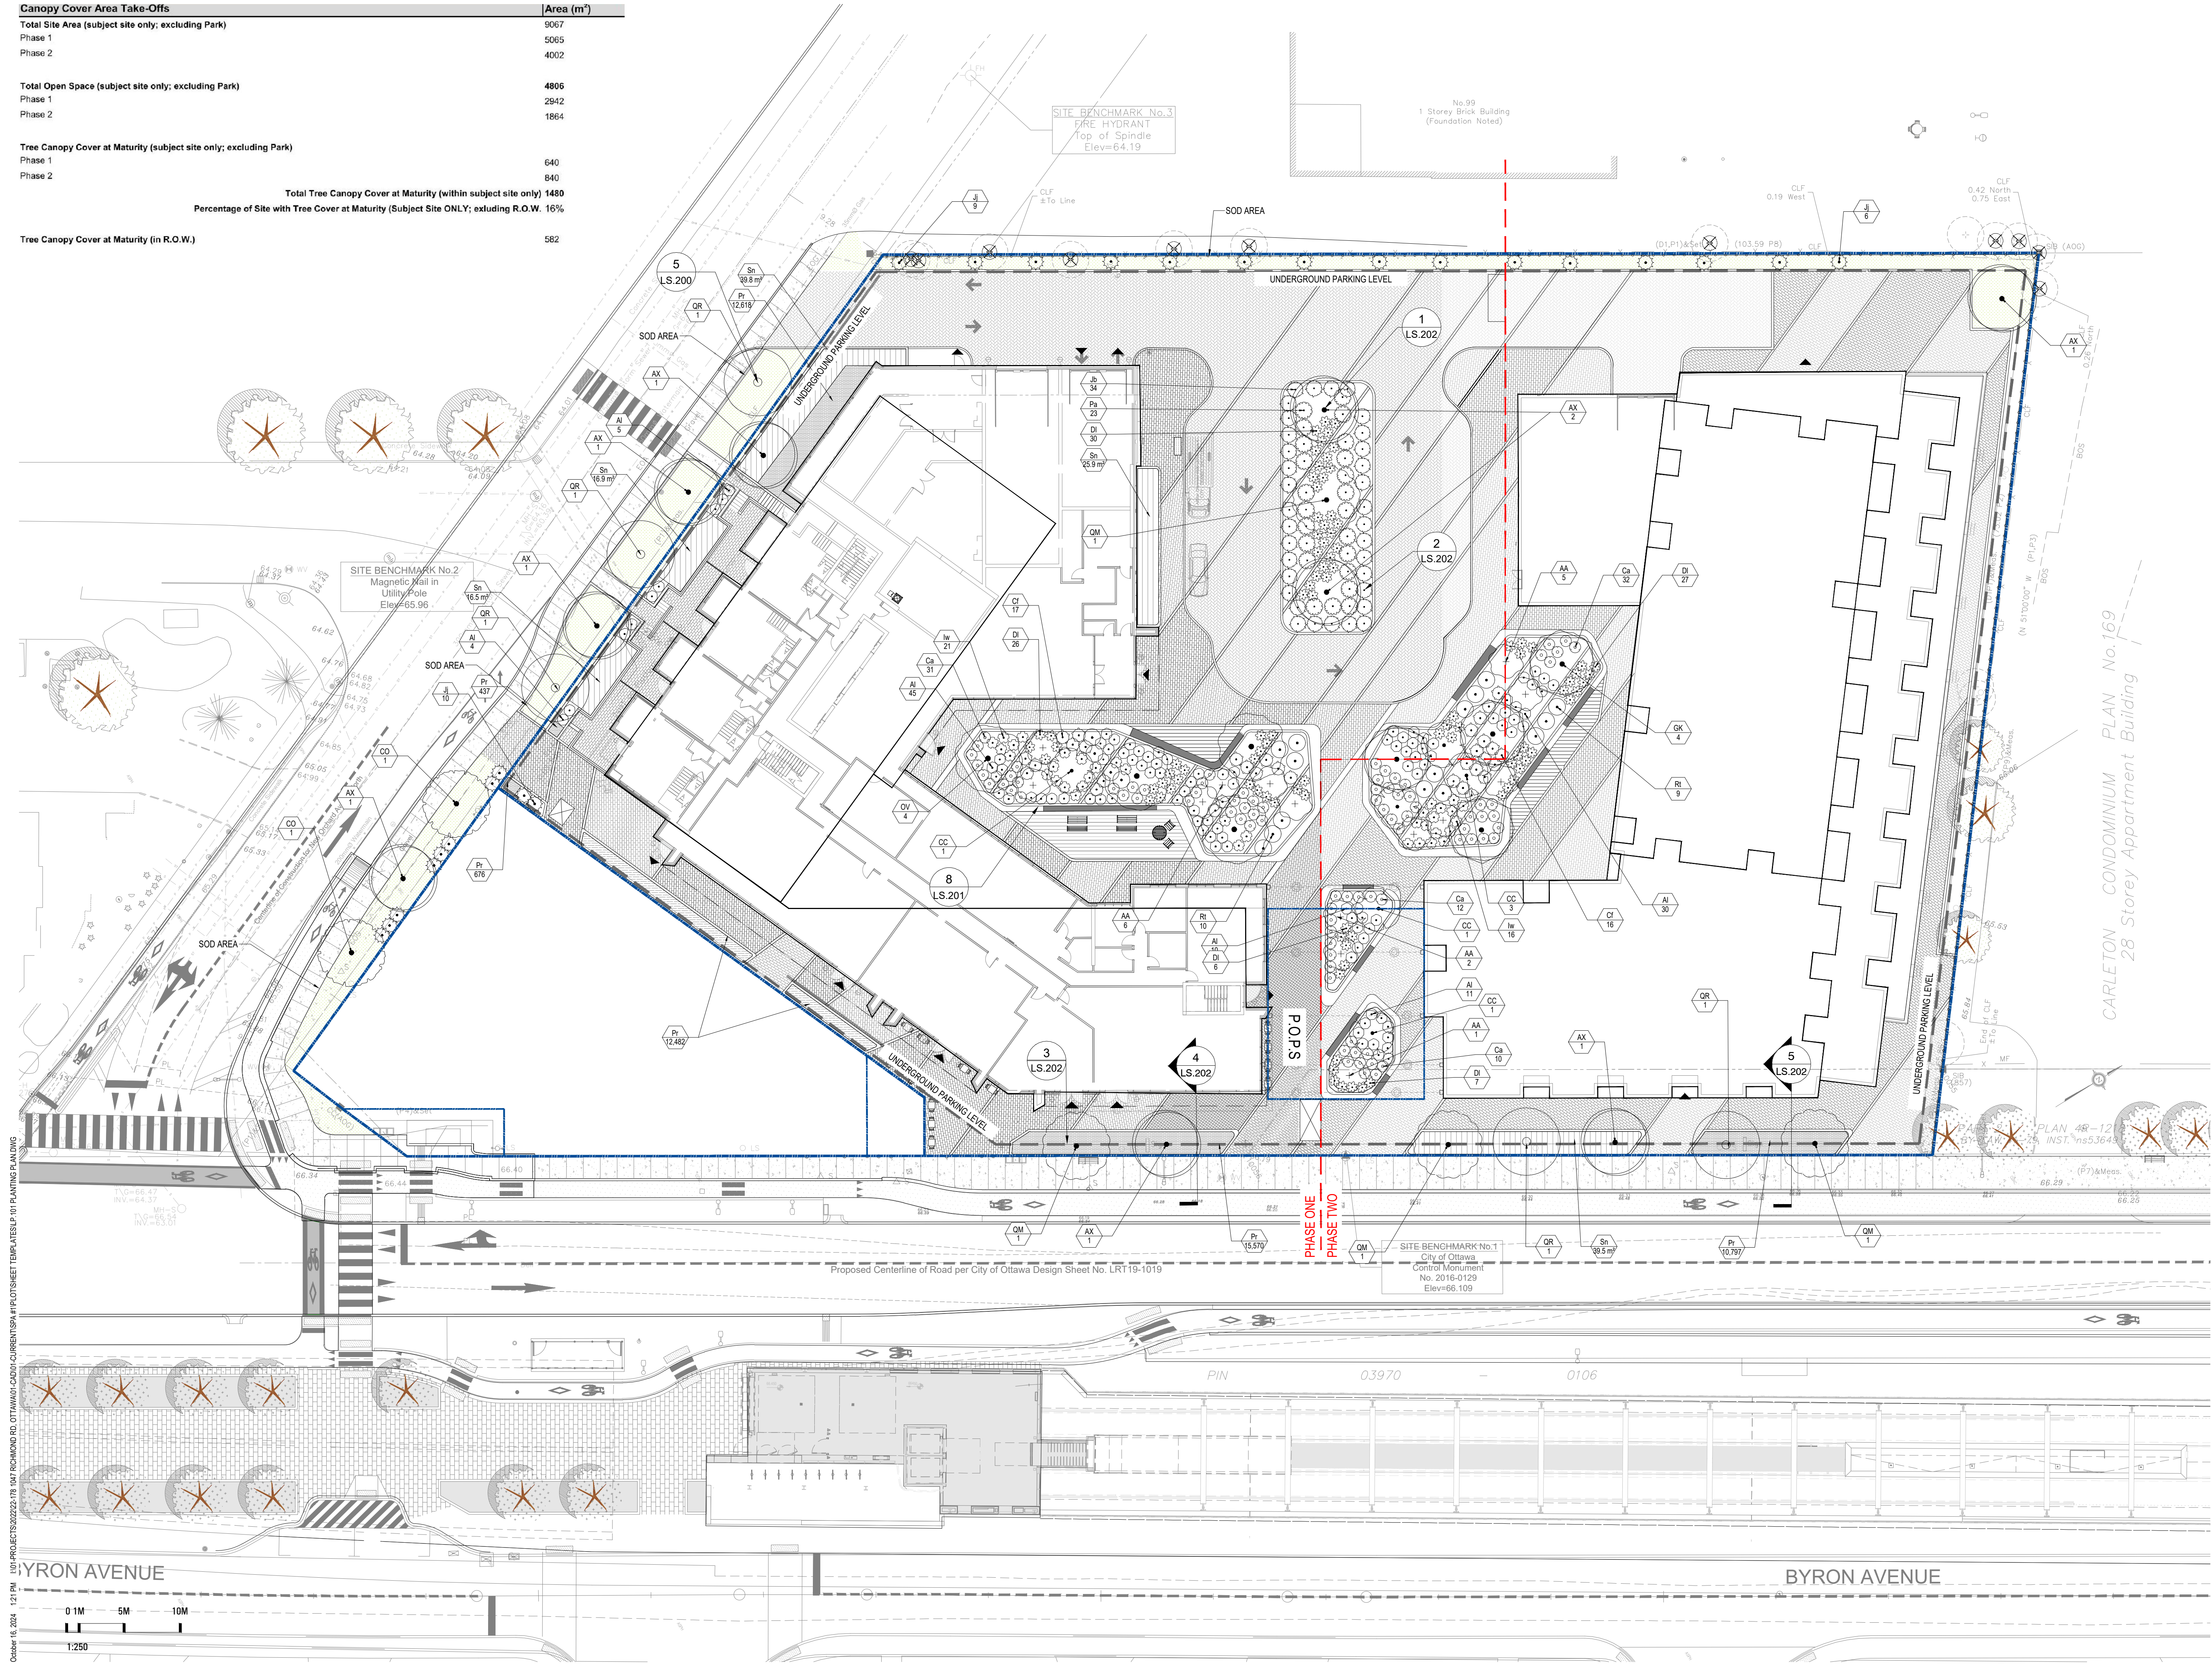

Revisions

Rev	Description	Date	By
9	ISSUED FOR SPA	2024-10-11	AK
8	ISSUED FOR SPA	2024-09-03	AK
7	ISSUED FOR COORDINATION	2024-08-30	AK
6	ISSUED FOR COORDINATION	2024-08-27	AK
5	ISSUED FOR COORDINATION	2024-08-21	AK
4	ISSUED FOR UDRP	2024-07-30	AK
3	ISSUED FOR COORDINATION	2024-07-15	AK
2	ISSUED FOR COORDINATION	2024-07-12	AK
1	ISSUED FOR COORDINATION	2024-07-09	AK

Signature
YYYY-MM-DD
Date

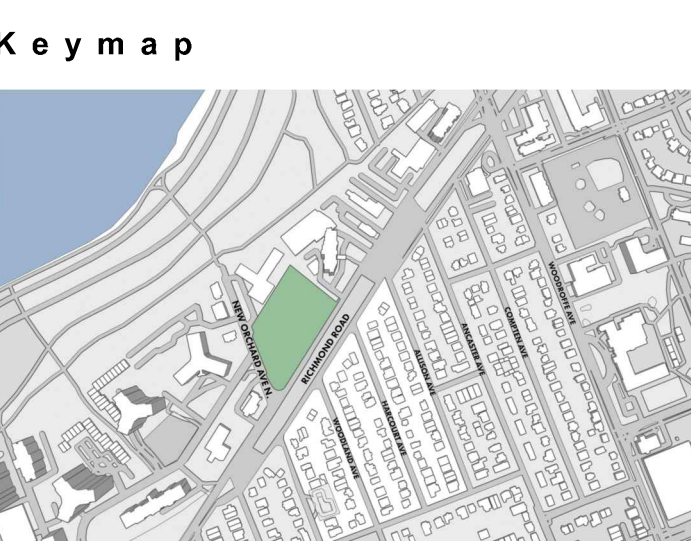

Scale
AS SHOWN

North

Phase
SPA


Date
2024-07-09

Drawing Name
PLANTING PLAN


Sheet Number
NOT FOR CONSTRUCTION

LP.101


October 16, 2024 1:21 PM I:\01-PROJECTS\2022\22-178 1047 RICHMOND RD, OTTAWA\CD\04-CURRENT\SPA\PLOTSHEET\TEMPLATES\101-PLANTING PLAN.DWG

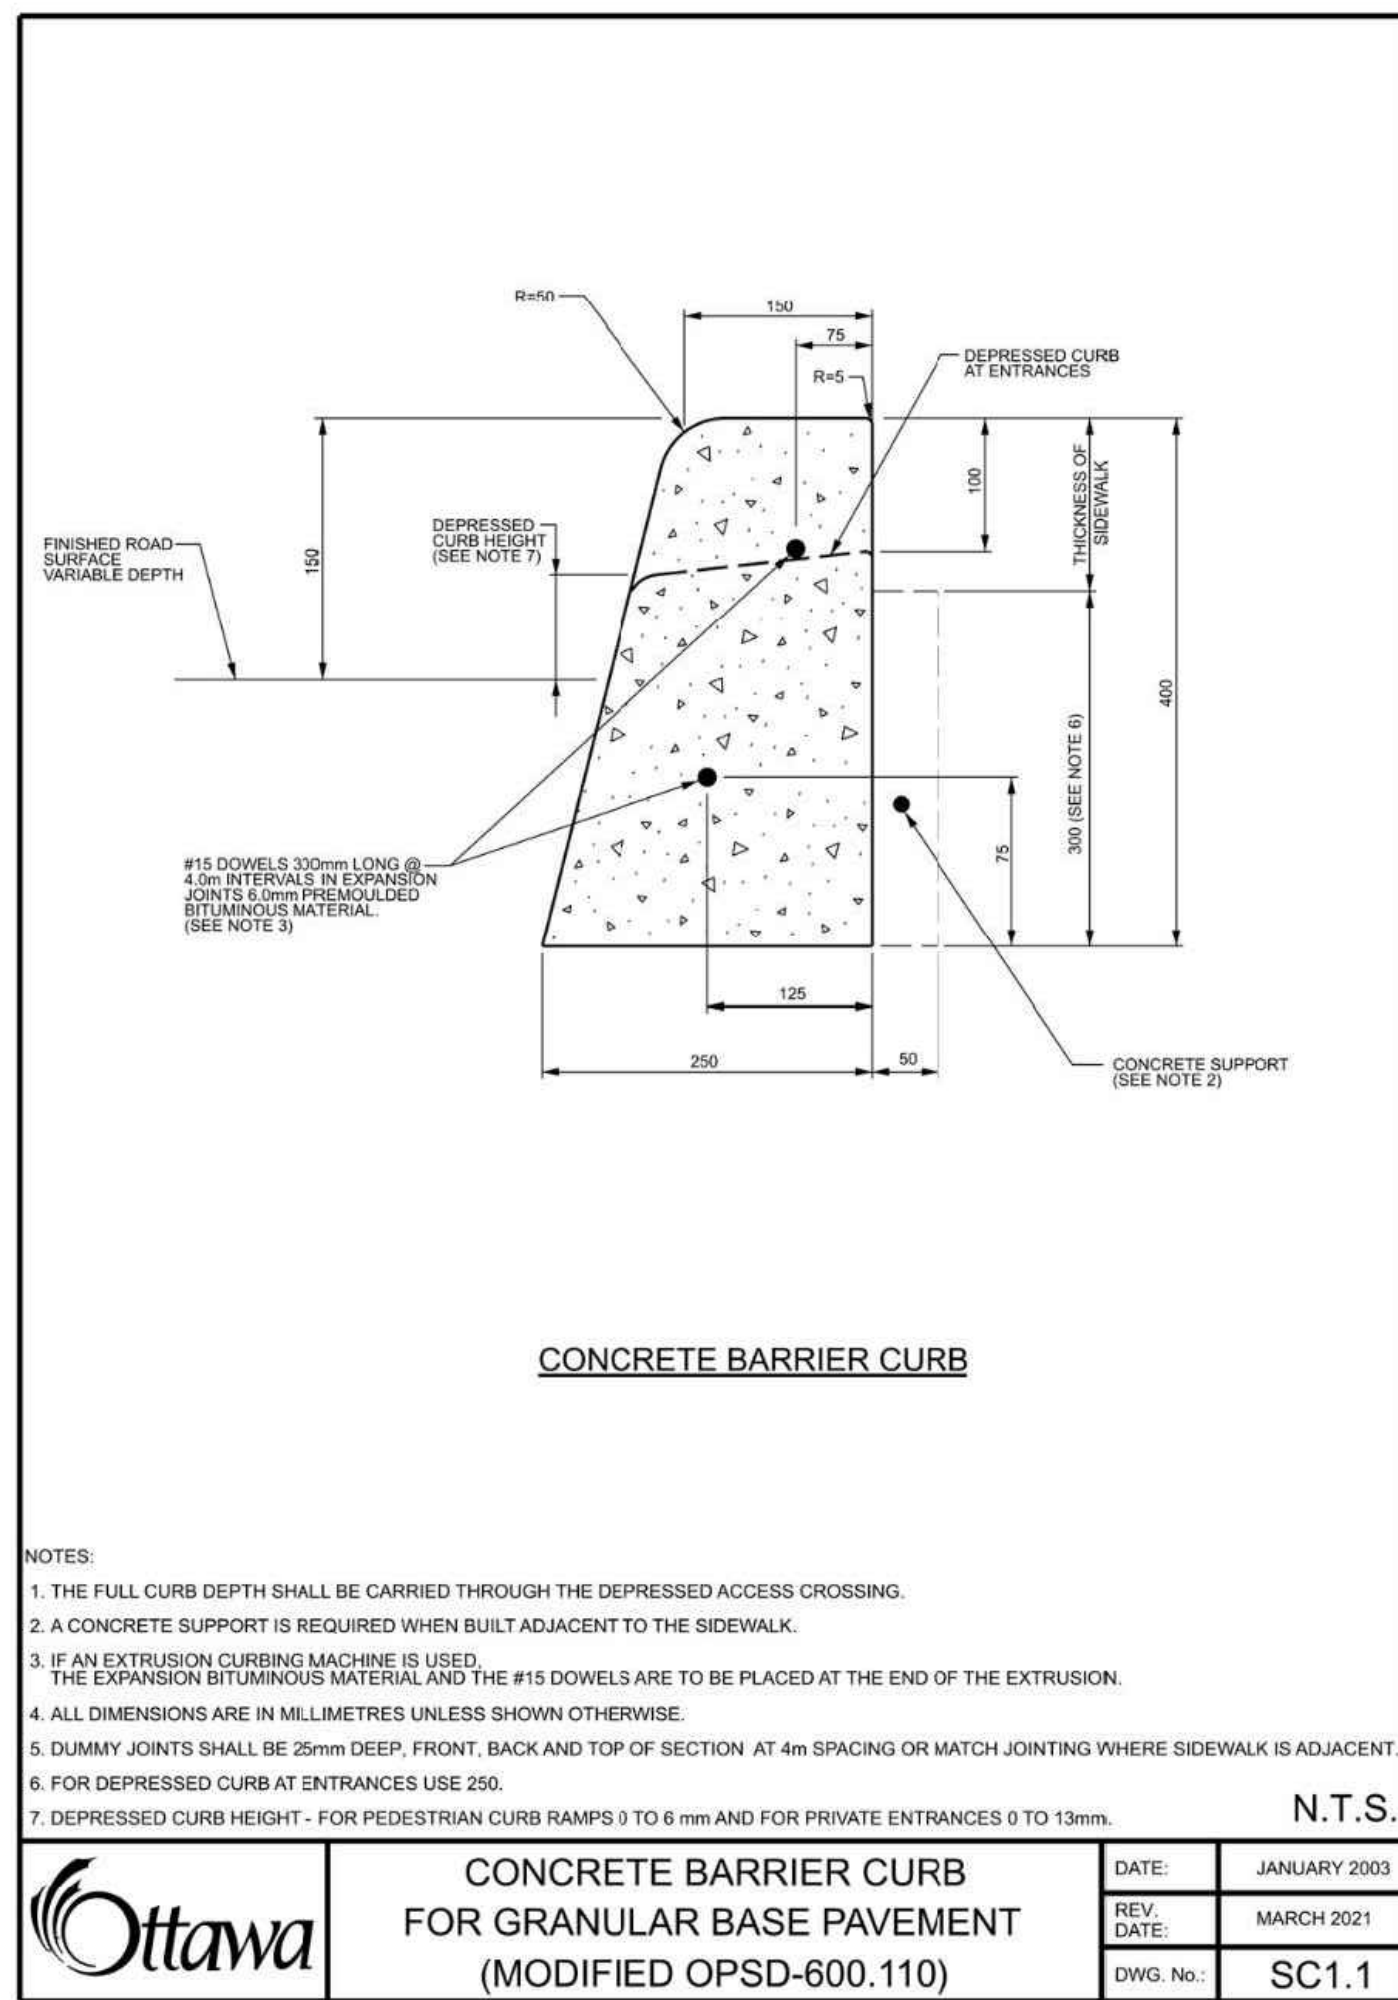


1 CONCRETE BARRIER CURB. SC 1.1
N.T.S.

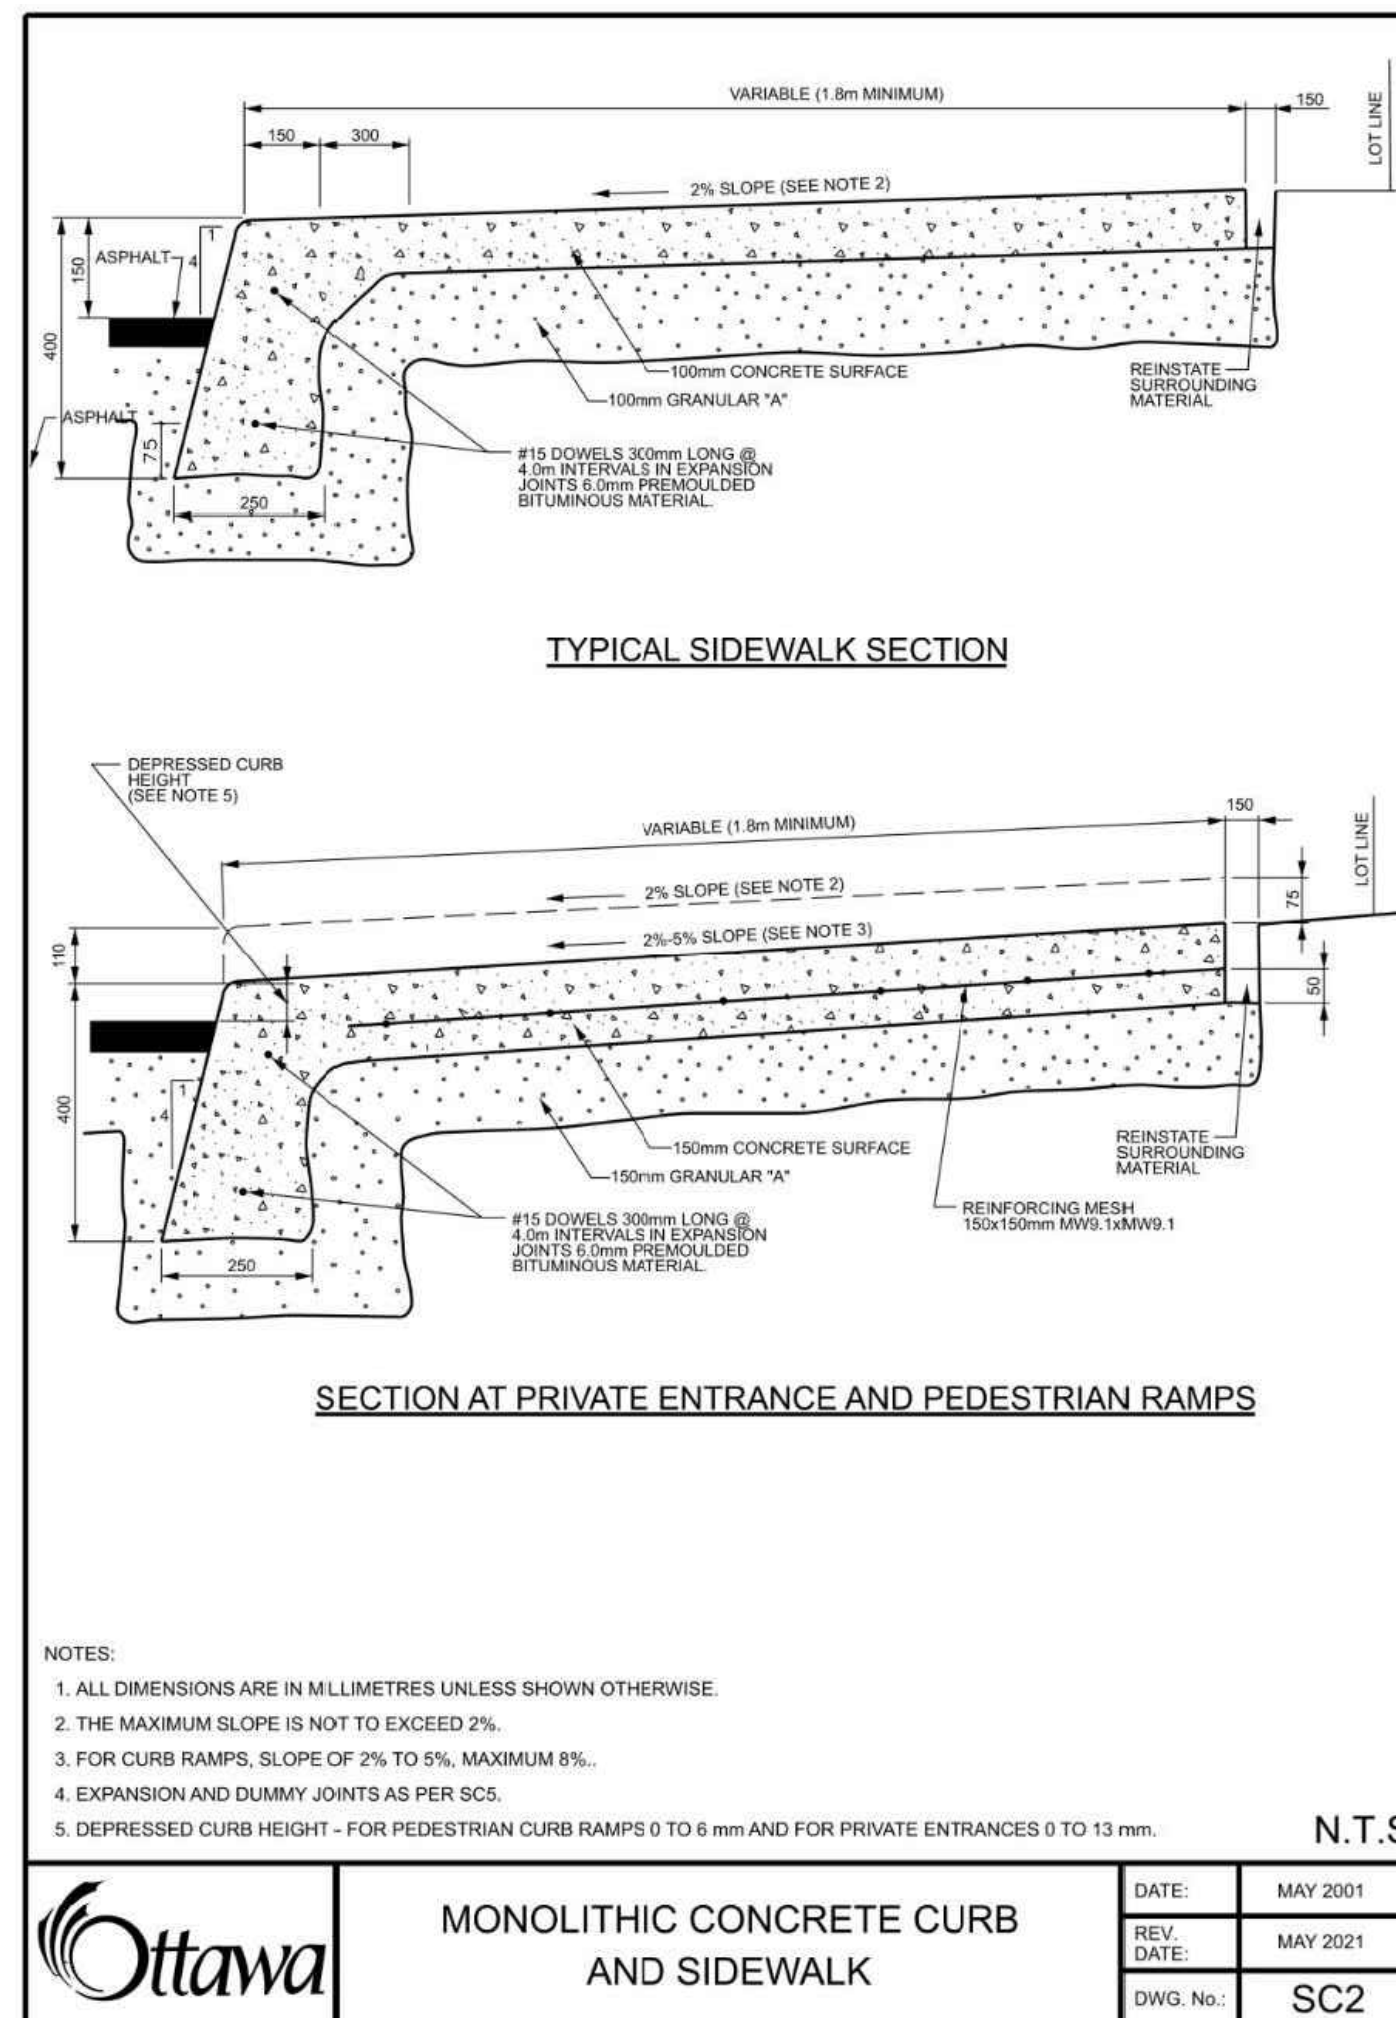


2 MONOLITHIC CONCRETE CURB AND SIDEWALK. SC2
N.T.S.

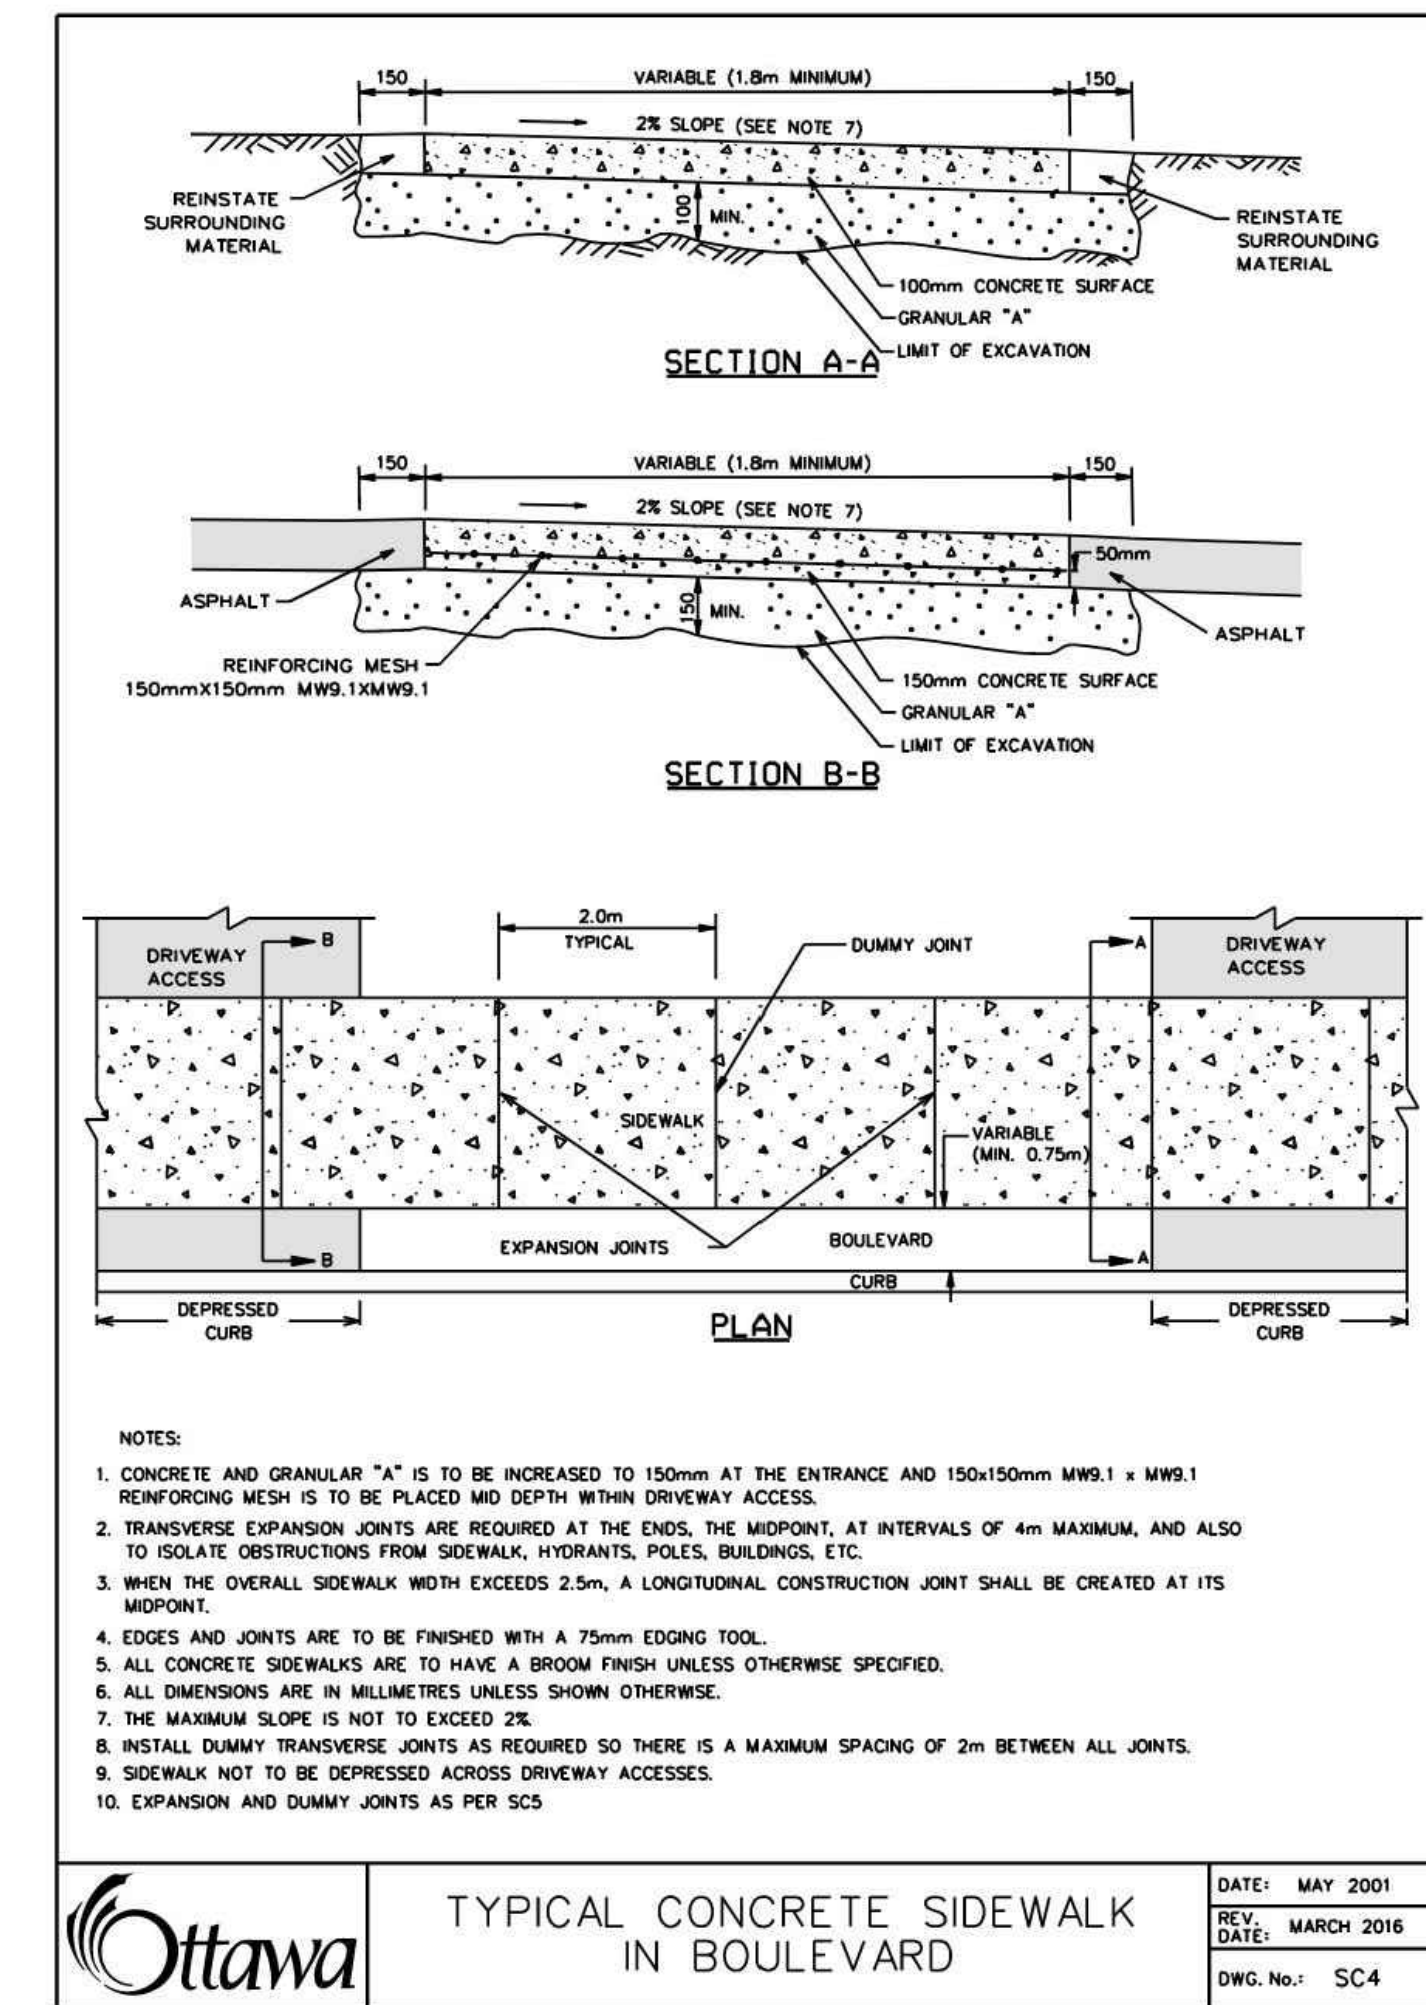


3 TYPICAL CONCRETE SIDEWALK IN BOULEVARD. SC4
N.T.S.

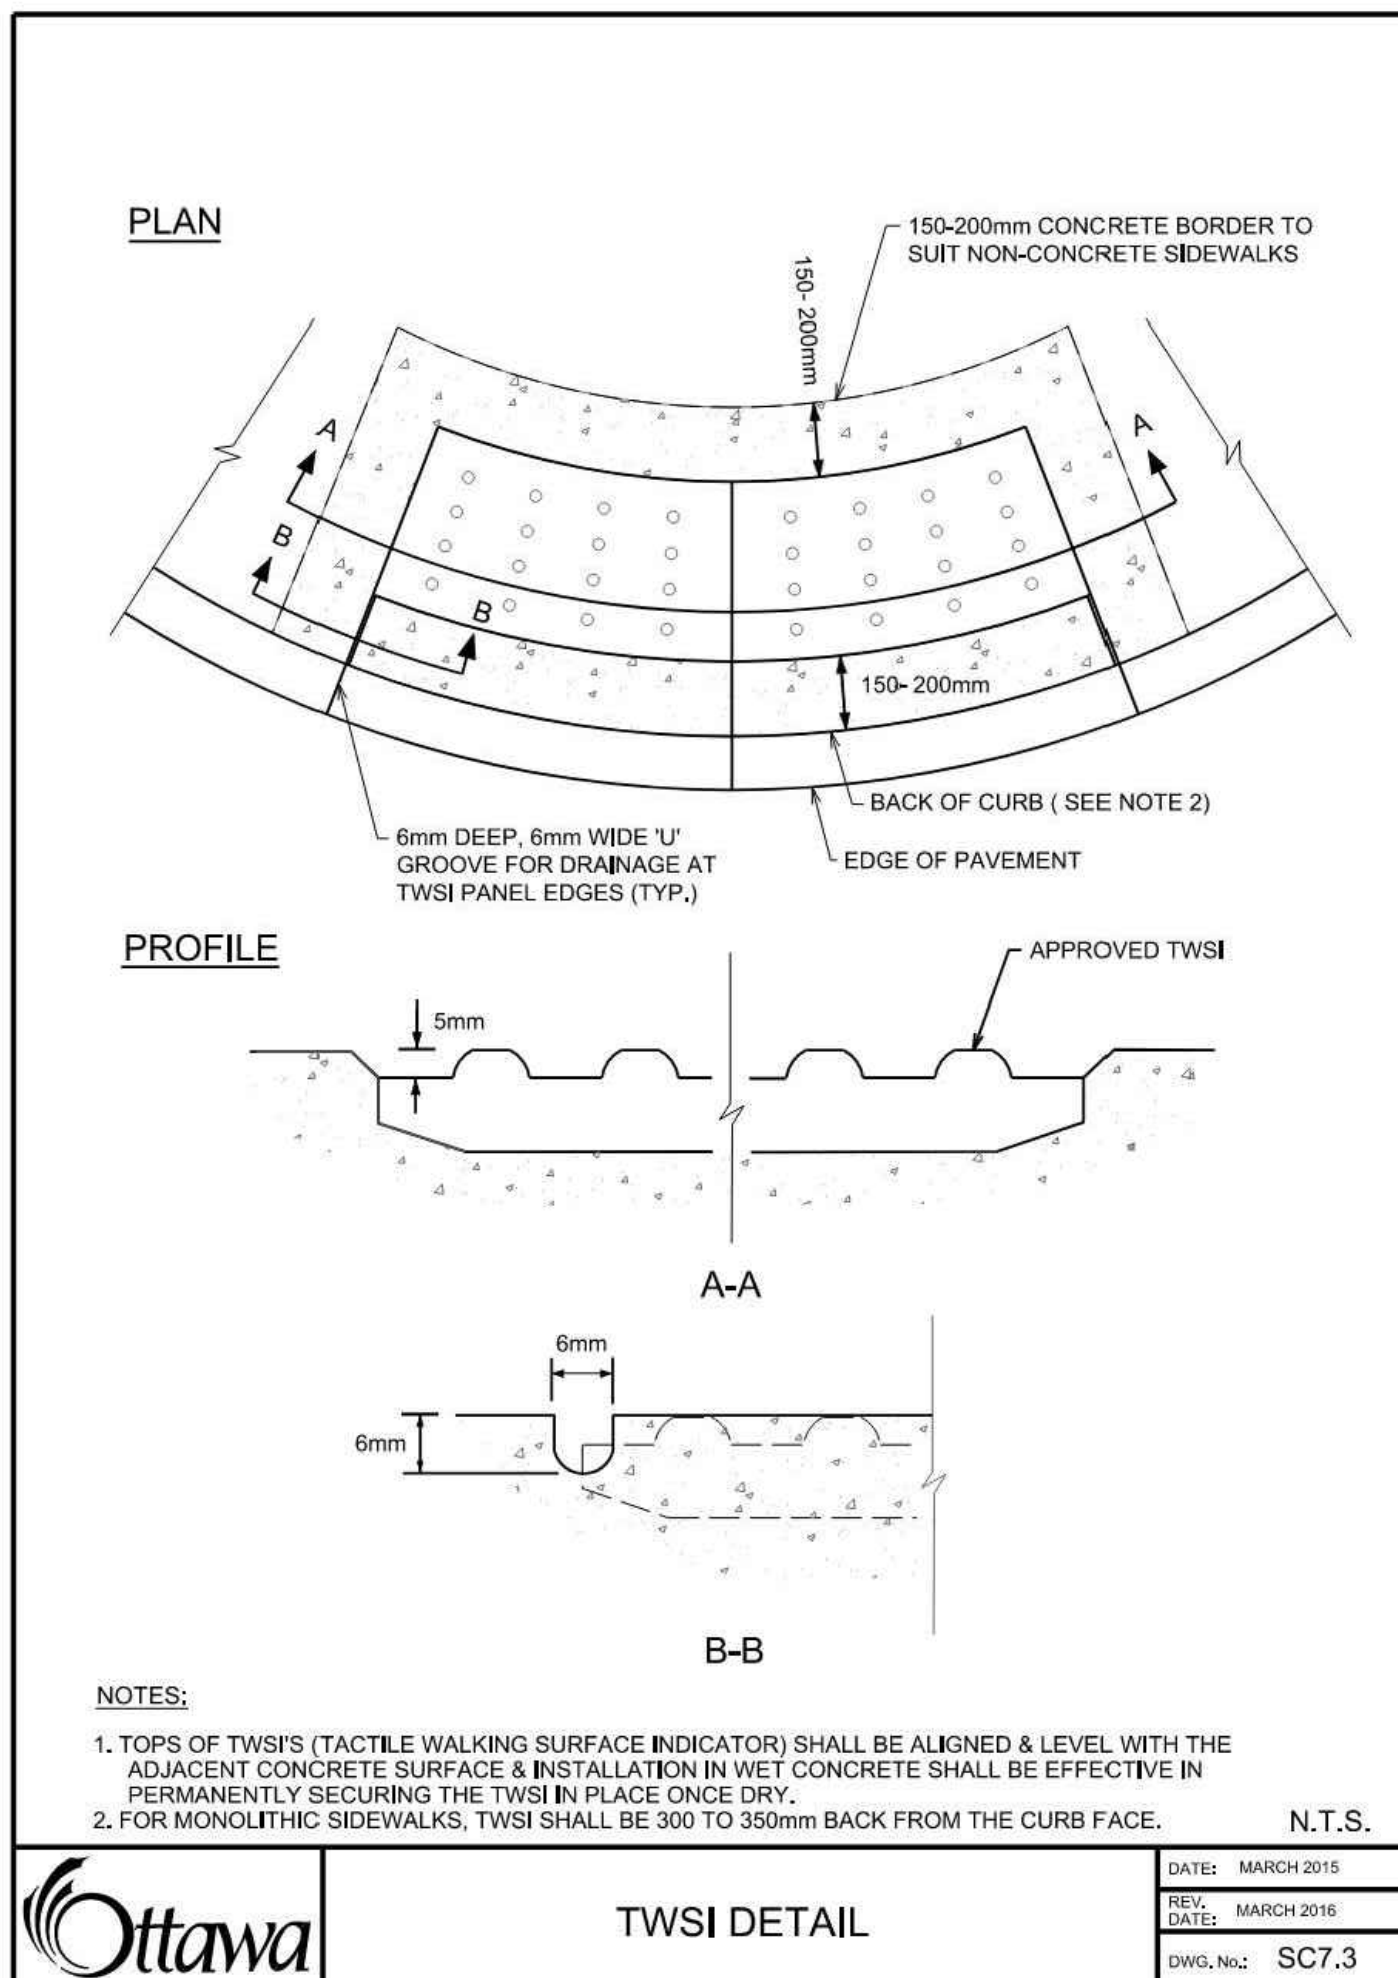

4 TWSI DETAIL. SC 7.3
N.T.S.

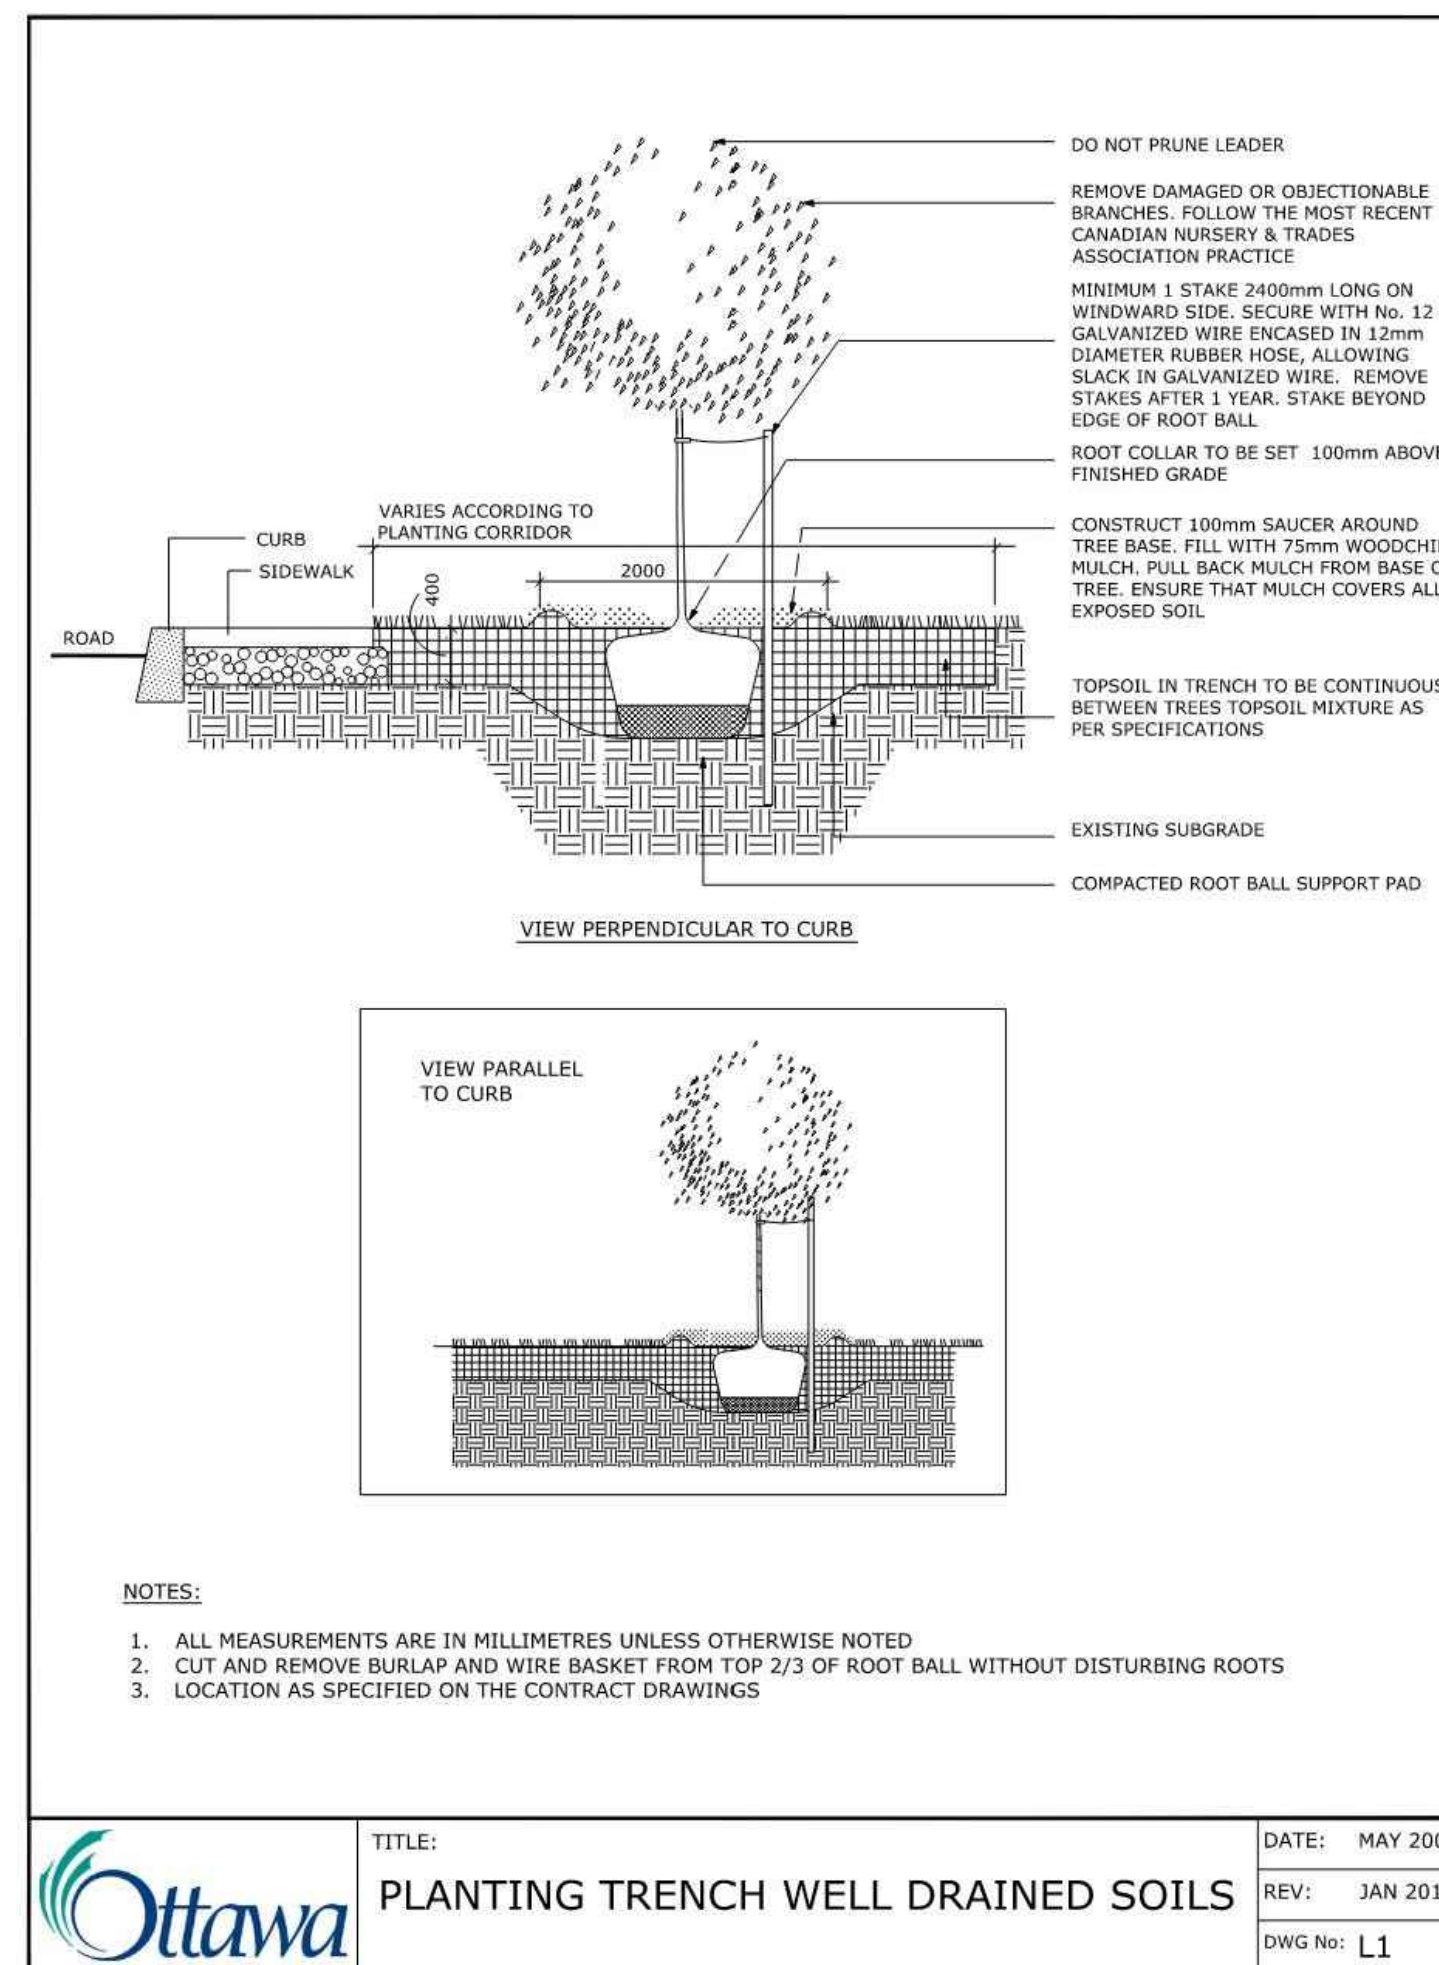

5 PLANTING TRENCH WELL DRAINED SOILS
N.T.S.

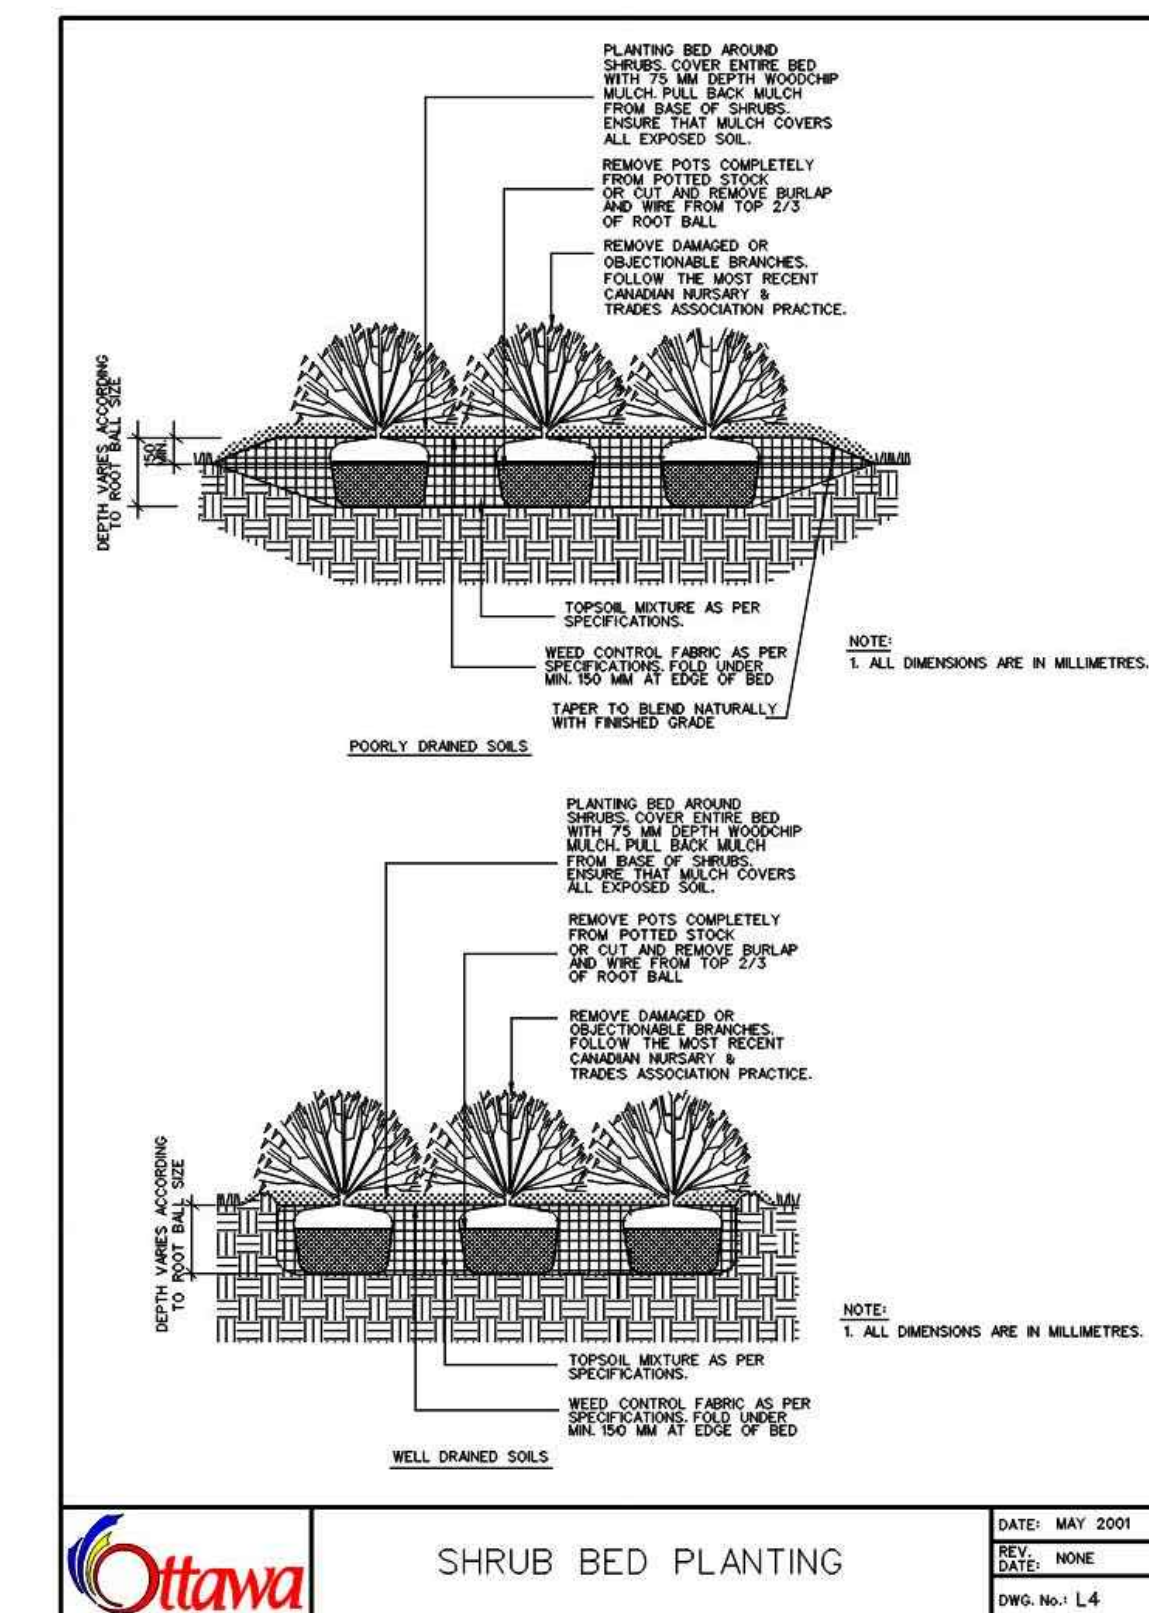


6 SHRUB BED PLANTING
N.T.S.

Revisions

9	ISSUED FOR SPA	2024-10-11	AK
8	ISSUED FOR SPA	2024-09-03	AK
7	ISSUED FOR COORDINATION	2024-08-30	AK
6	ISSUED FOR COORDINATION	2024-08-27	AK
5	ISSUED FOR COORDINATION	2024-08-21	AK
4	ISSUED FOR UDRP	2024-07-30	AK
3	ISSUED FOR COORDINATION	2024-07-15	AK
2	ISSUED FOR COORDINATION	2024-07-12	AK
1	ISSUED FOR COORDINATION	2024-07-09	AK

Signature
YYYY-MM-DD
Date

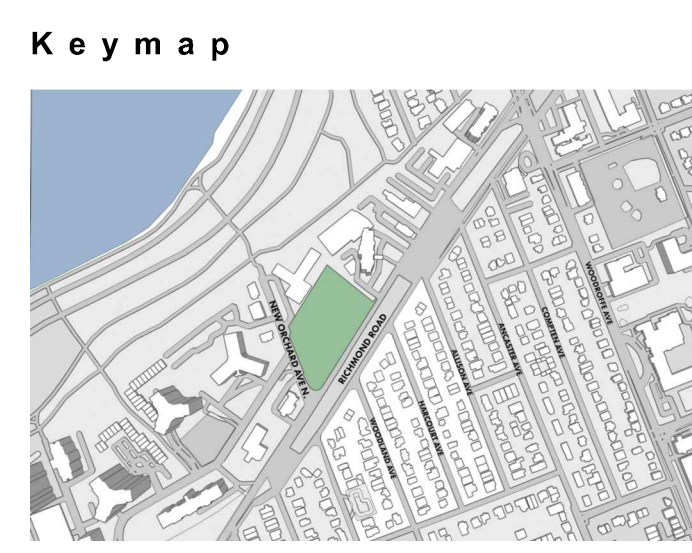

Scale North
AS SHOWN

Phase
SPA
Date
2024-07-09

Drawing Name
LANDSCAPE DETAILS

Sheet Number
NOT FOR CONSTRUCTION

LS.200


1047 RICHMOND RD

OTTAWA, ON K2B 6R1


Project Number
22-178

Client
FENGATE
2275 UPPER MIDDLE RD. E.,
SUITE 700
OAKVILLE, ON L6H 0C3


Consultant
RLA/ARCHITECTURE
55 Beach Street
OTTAWA, ON K1S3J6, CANADA
TEL: 613.724.9932

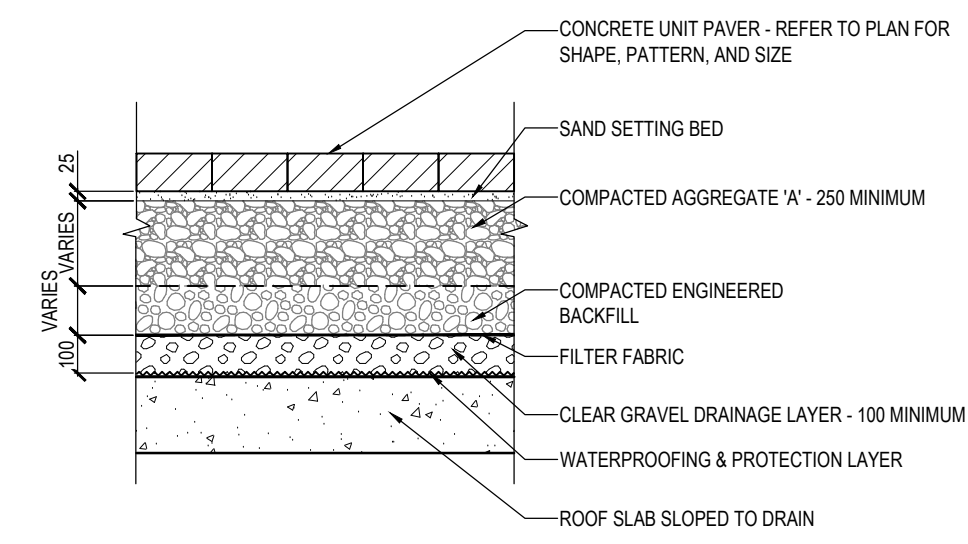


1 HEAVY DUTY UNIT PAVERS ON SLAB
1:20

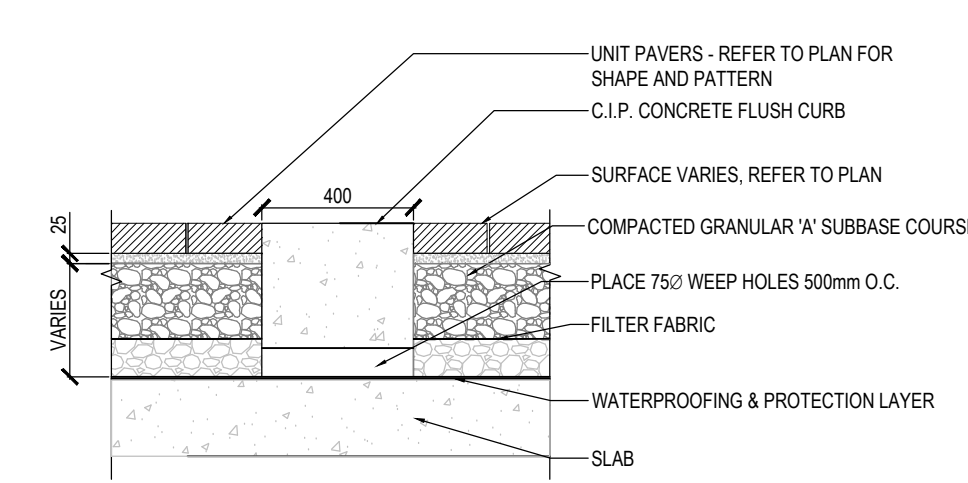


2 UNIT PAVERS ON SLAB
1:20

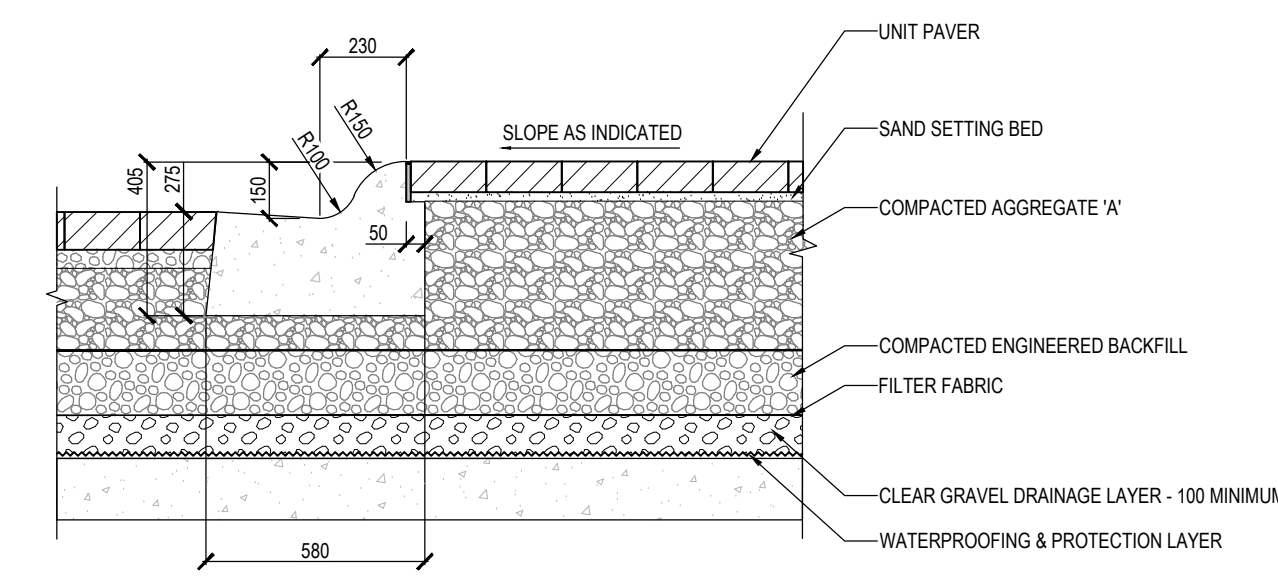


3 STANDARD ROLLED CURB AND GUTTER
1:20

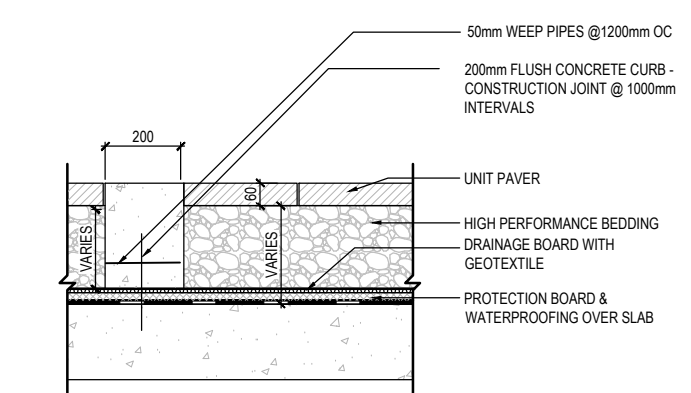

4 FLUSH CONCRETE CURB ON SLAB
1:20

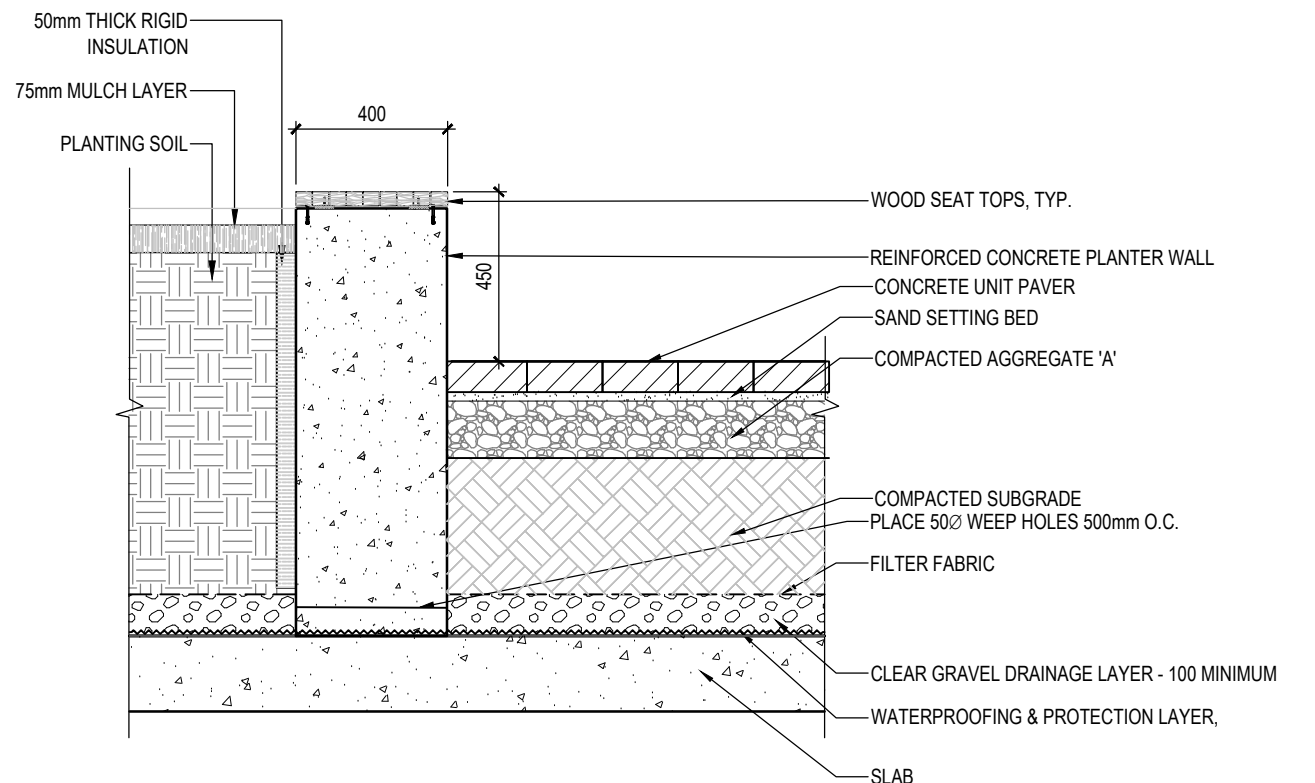

5 WOOD TOP BENCH ON CONCRETE SEAT WALL
N.T.S.

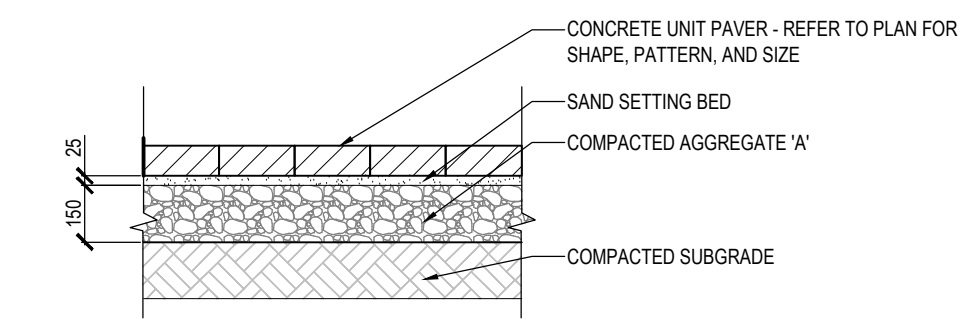

6 UNIT PAVERS ON GRADE
1:20


Revisions

Rev	Description	Date	By
9	ISSUED FOR SPA	2024-10-11	AK
8	ISSUED FOR SPA	2024-09-03	AK
7	ISSUED FOR COORDINATION	2024-08-30	AK
6	ISSUED FOR COORDINATION	2024-08-27	AK
5	ISSUED FOR COORDINATION	2024-08-21	AK
4	ISSUED FOR UDRP	2024-07-30	AK
3	ISSUED FOR COORDINATION	2024-07-15	AK
2	ISSUED FOR COORDINATION	2024-07-12	AK
1	ISSUED FOR COORDINATION	2024-07-09	AK



Signature
YYYY-MM-DD
Date

Keymap

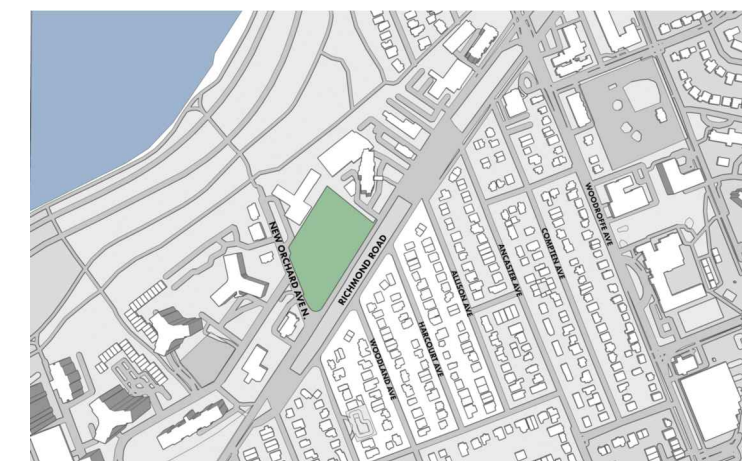

Scale North
AS SHOWN

Phase
SPA


Date
2024-07-09

Drawing Name
LANDSCAPE DETAILS


Sheet Number
NOT FOR CONSTRUCTION

LS.201

October 16, 2024 1:21 PM I:\01-PROJECTS\2022\21-1047 RICHMOND RD, OTTAWA\01-CAD\01-CURRENT\SPA\PILOT-SHEET-TEMPLATES\LS.201 LANDSCAPE DETAILS.DWG

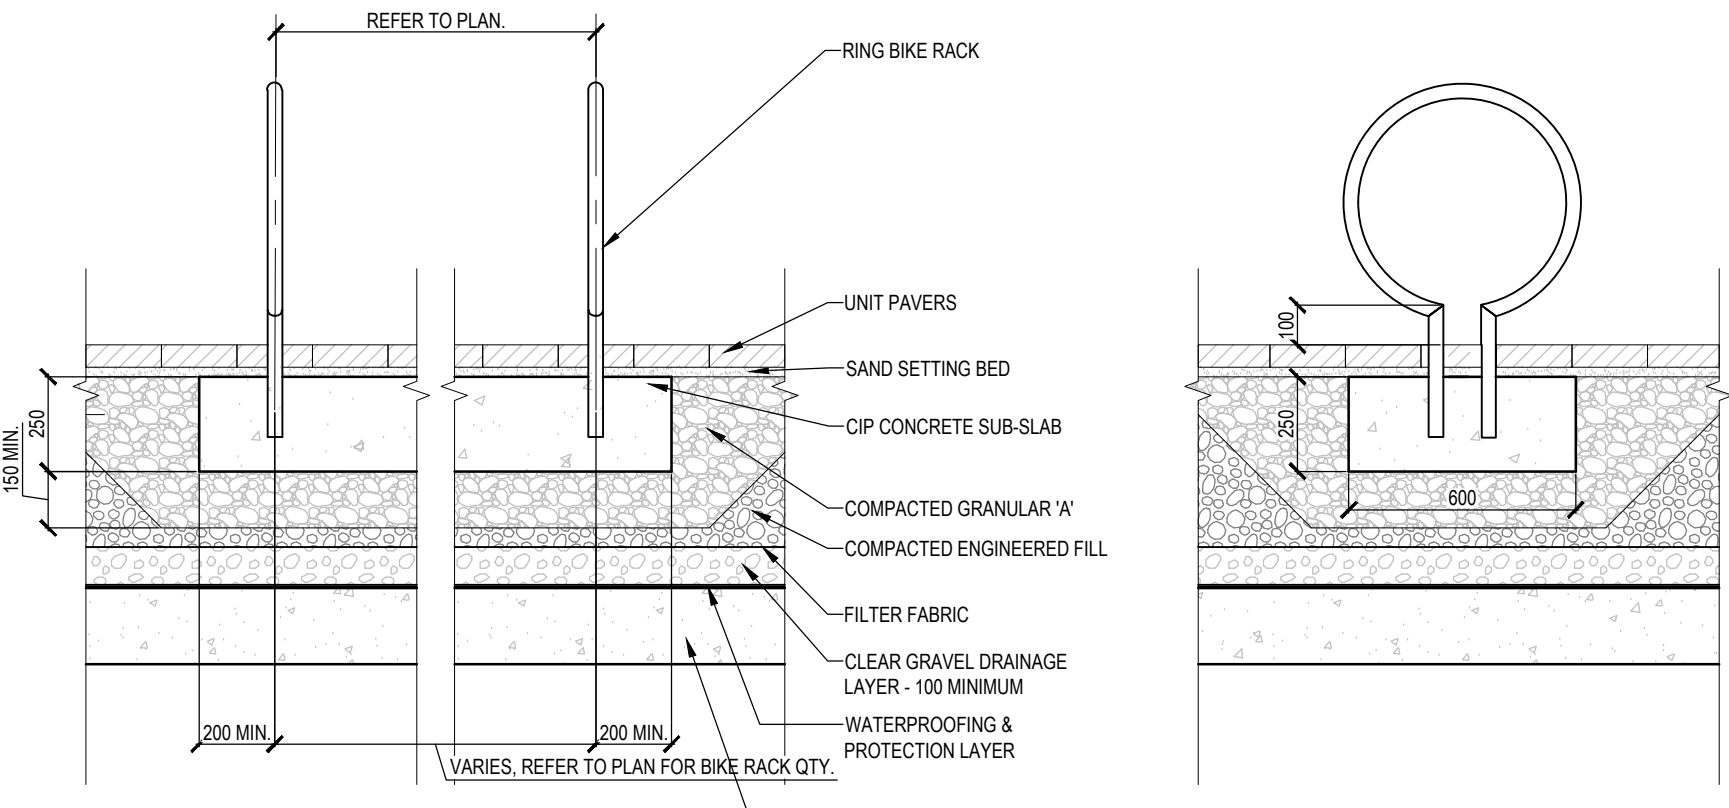

7 BIKE RACK
N.T.S.

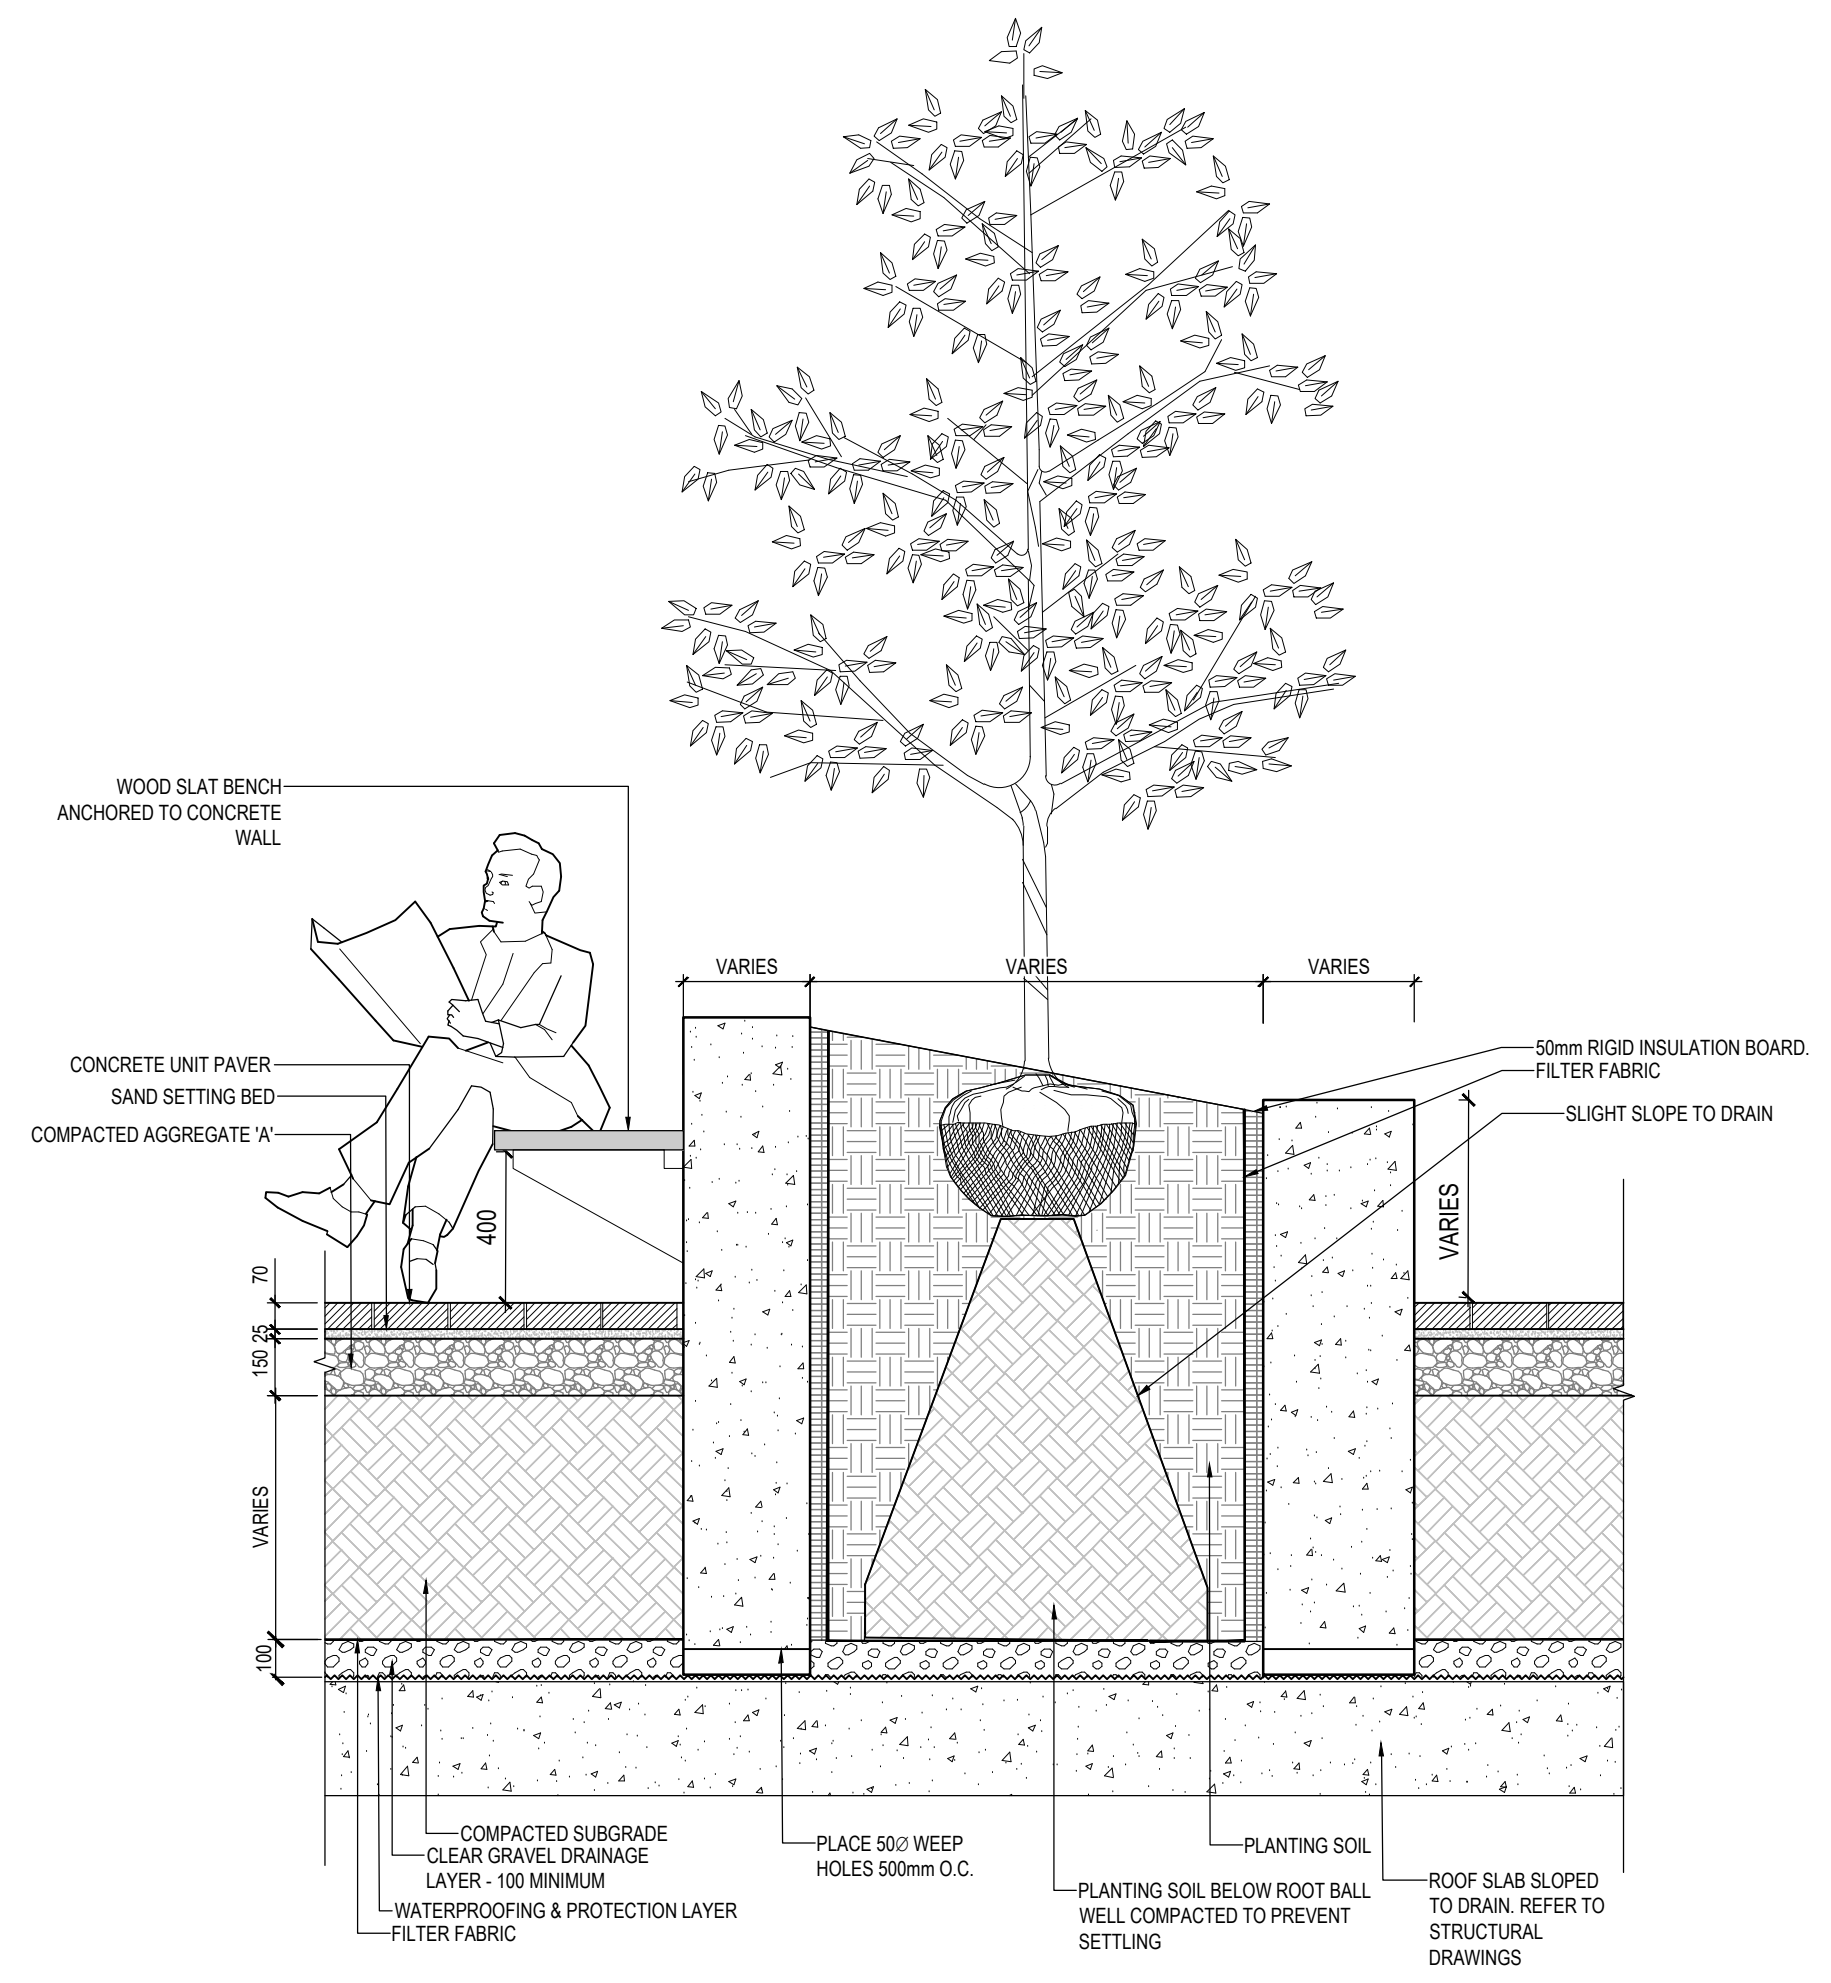

8 CONCRETE PLANTER ON SLAB
N.T.S.


1047 RICHMOND RD

OTTAWA, ON K2B 6R1


Project Number
22-178

Client
FENGATE
2275 UPPER MIDDLE RD. E.,
SUITE 700
OAKVILLE, ON L6H 0C3


Consultant
ARCHITECTURE
RLA/ARCHITECTURE
55 Beach Street
OTTAWA, ON K1S3J6, CANADA
TEL: 613.724.9932

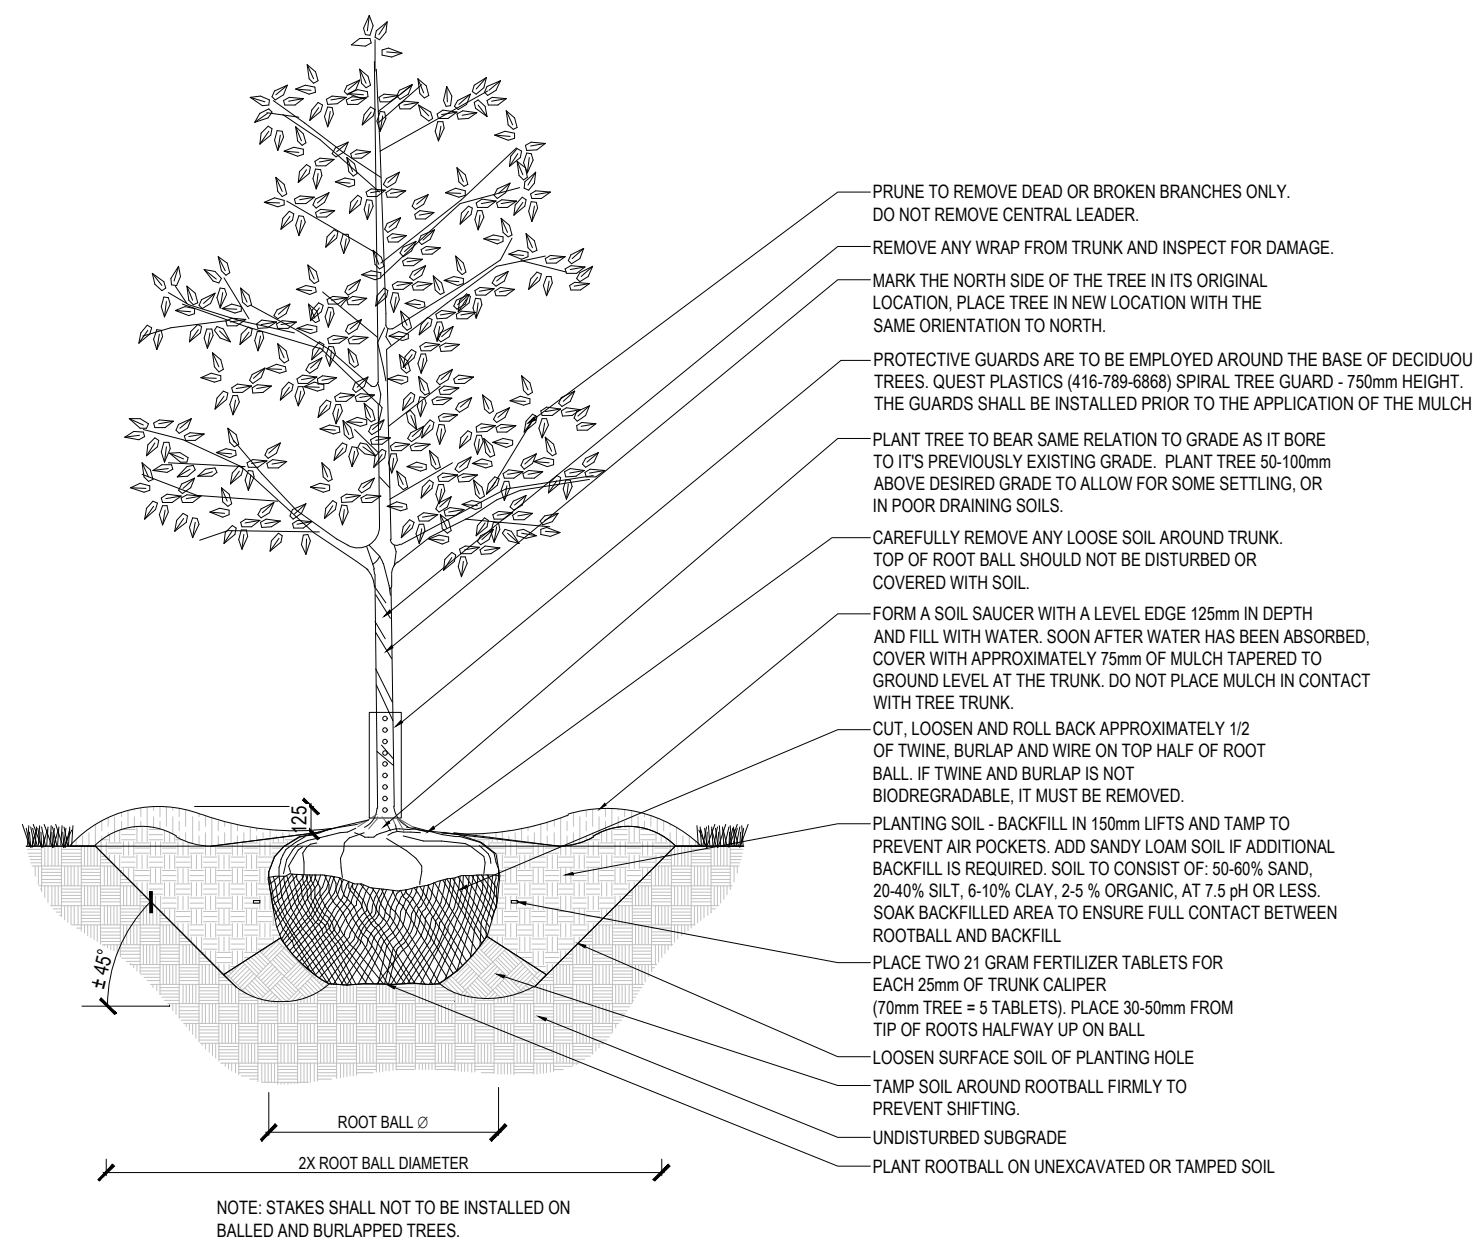


1 B&B DECIDUOUS TREE PLANTING DETAIL
N.T.S.

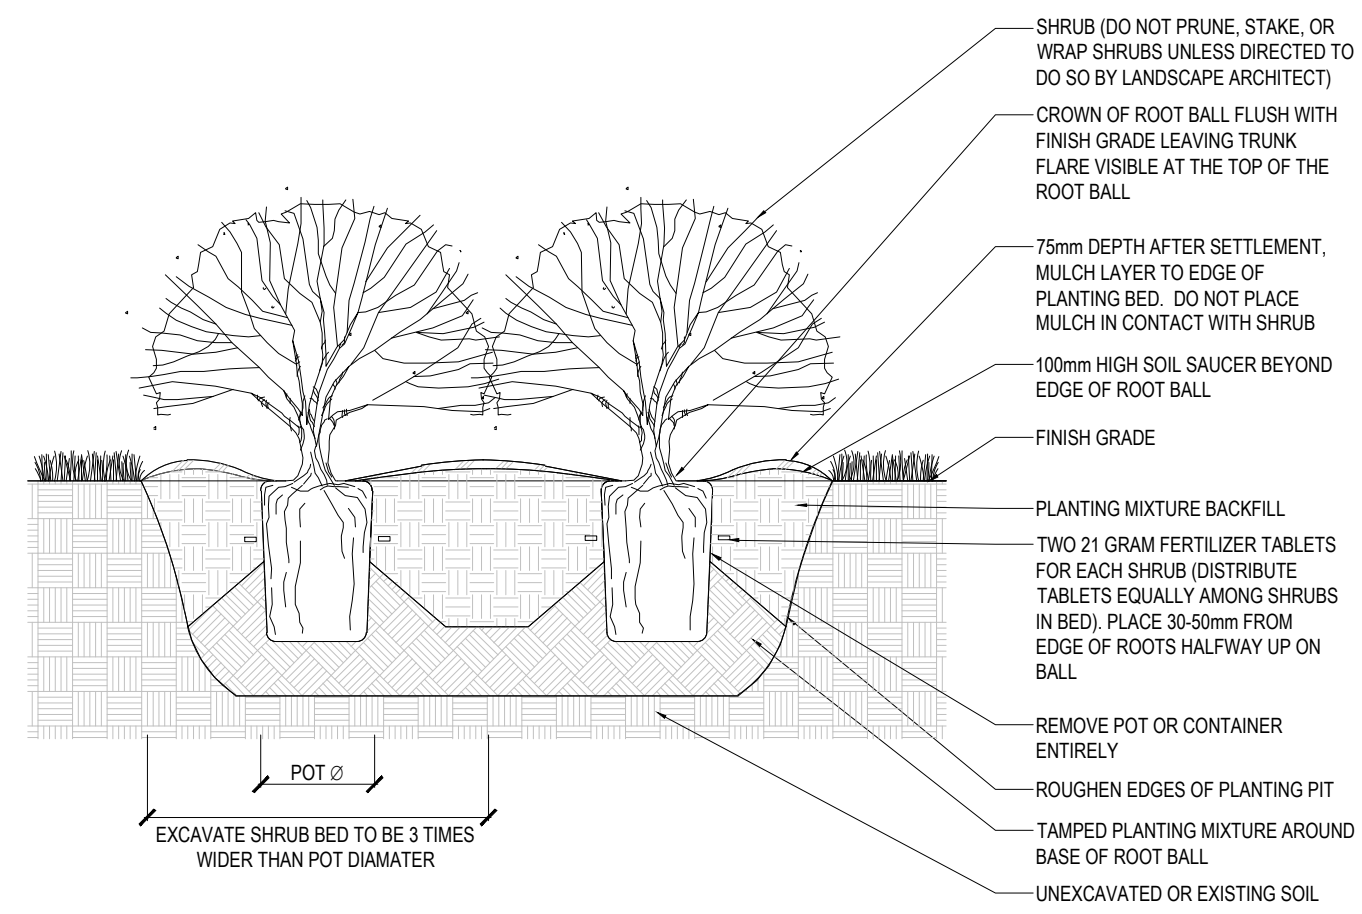


2 POTTED SHRUB BED PLANTING DETAIL
N.T.S.

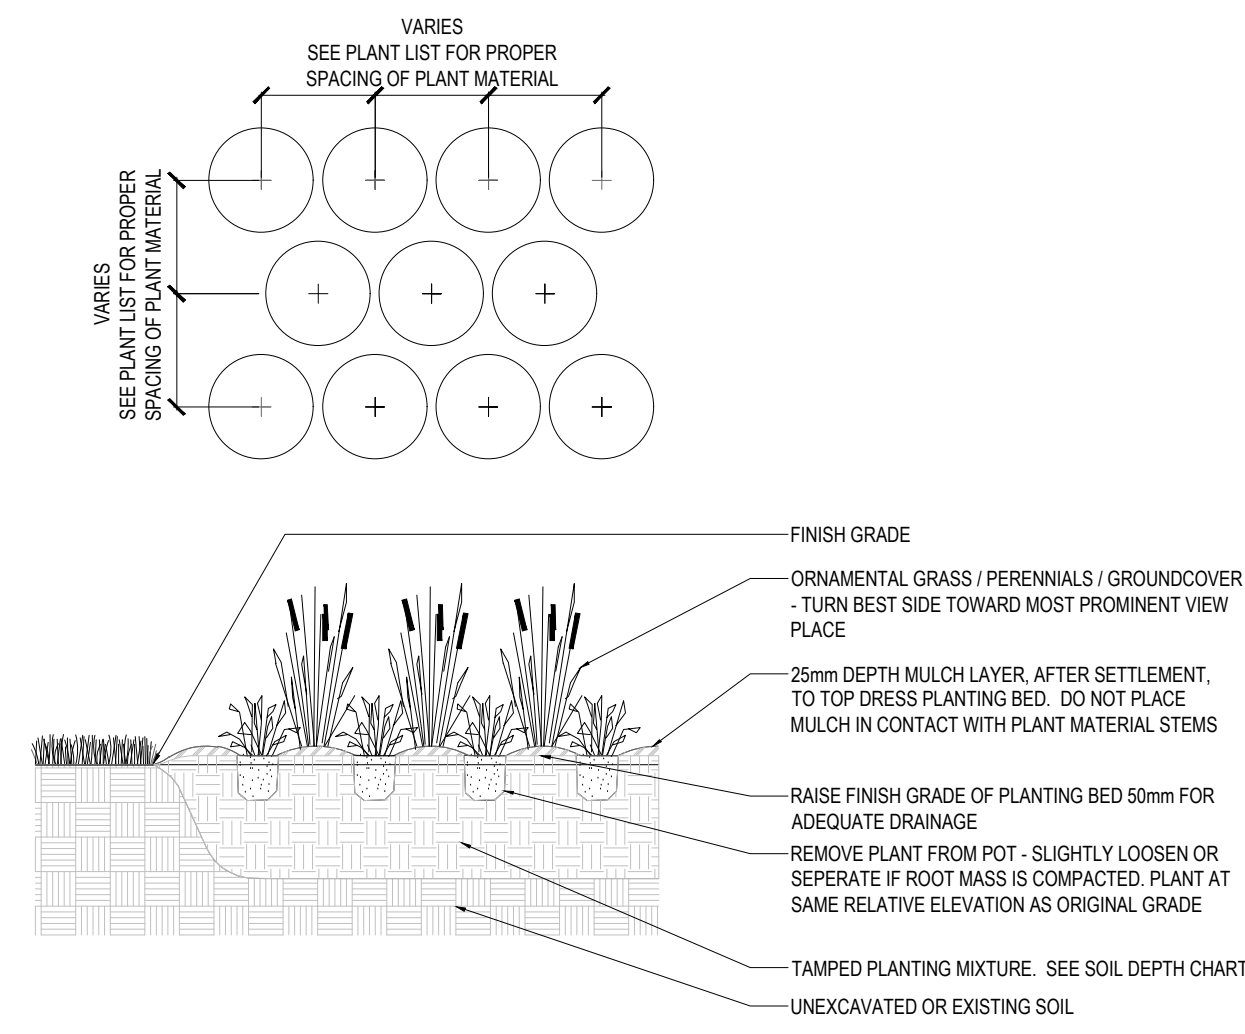

3 GROUND COVER PLANTING
N.T.S.

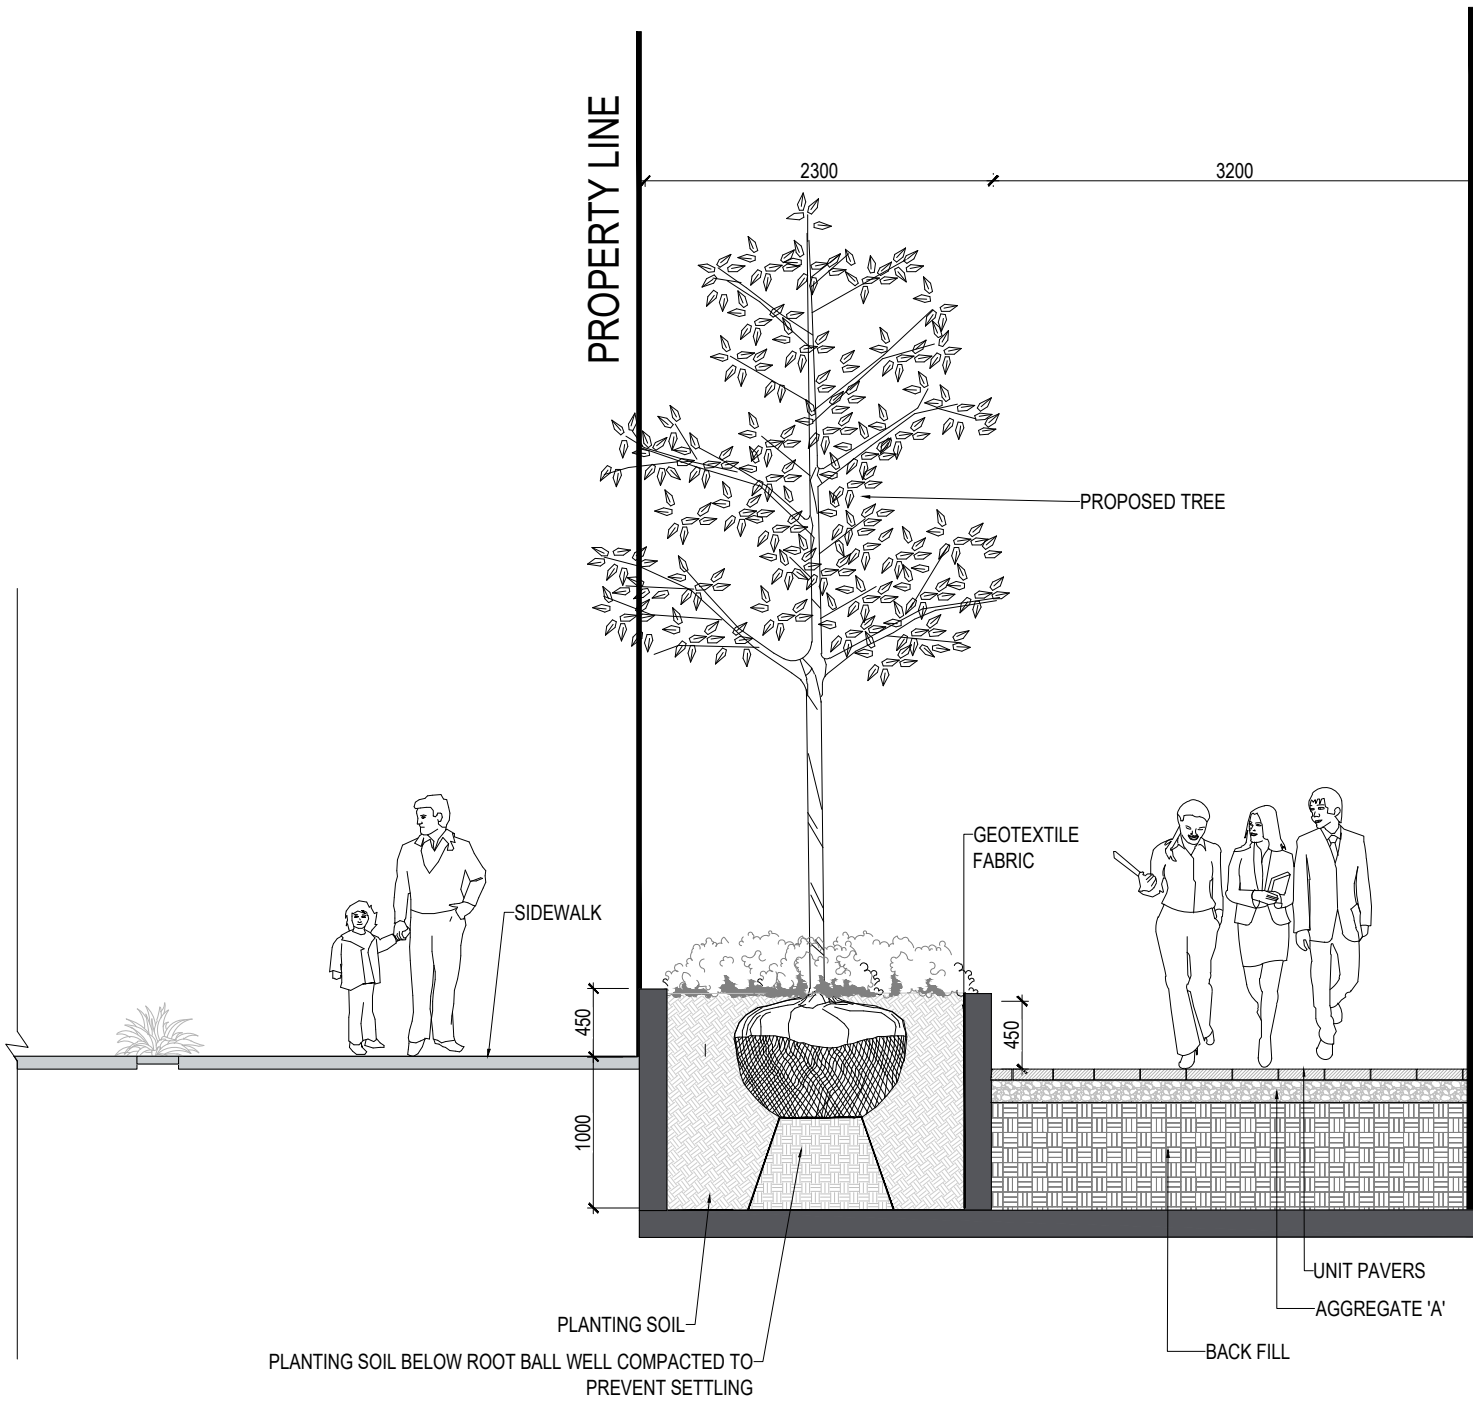


4 SECTION PHASE 1
N.T.S.

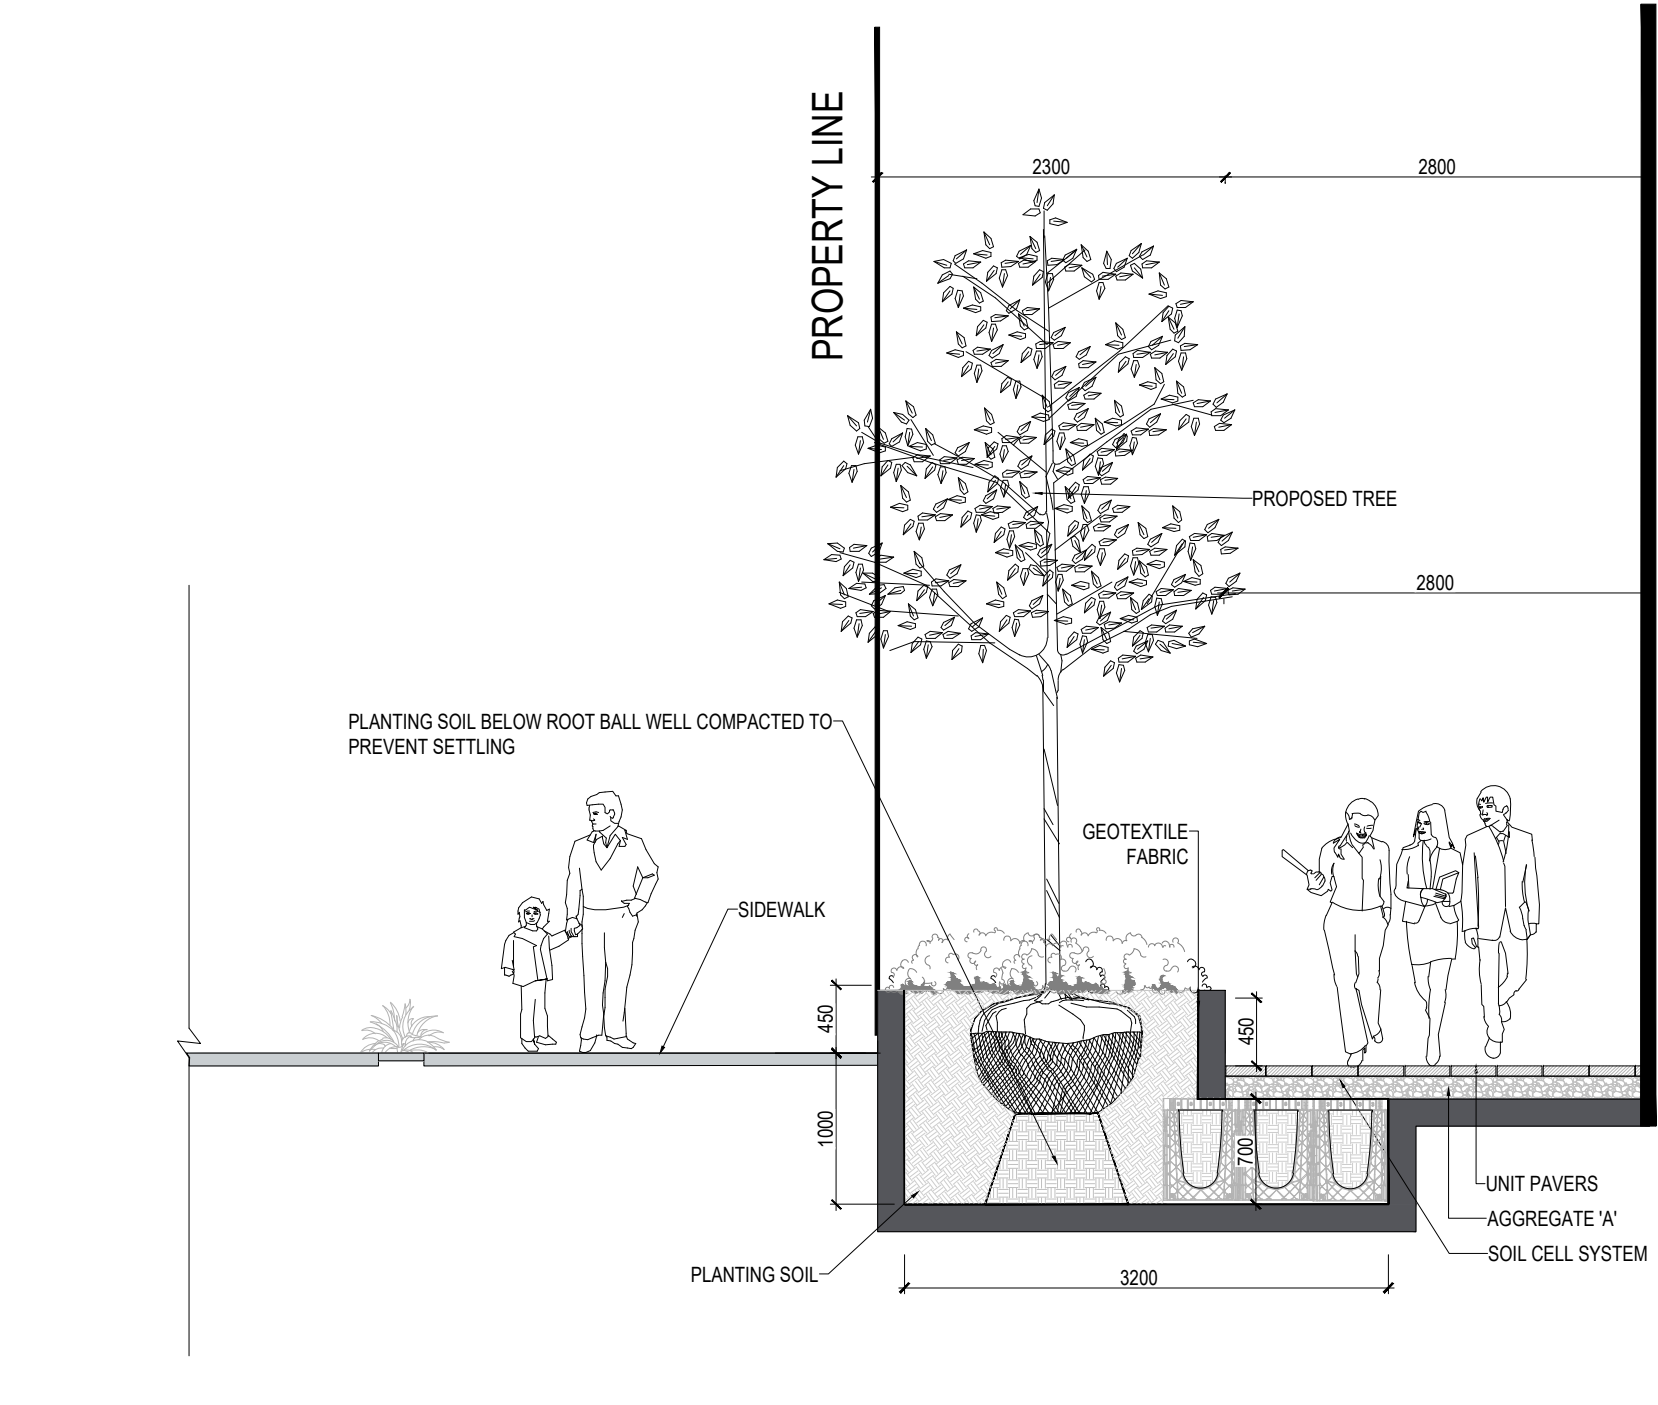

5 SECTION PHASE 2
N.T.S.


Revisions

9	ISSUED FOR SPA	2024-10-11	AK
8	ISSUED FOR SPA	2024-09-03	AK
7	ISSUED FOR COORDINATION	2024-08-30	AK
6	ISSUED FOR COORDINATION	2024-08-27	AK
5	ISSUED FOR COORDINATION	2024-08-21	AK
4	ISSUED FOR LDRP	2024-07-30	AK
3	ISSUED FOR COORDINATION	2024-07-15	AK
2	ISSUED FOR COORDINATION	2024-07-12	AK
1	ISSUED FOR COORDINATION	2024-07-09	AK

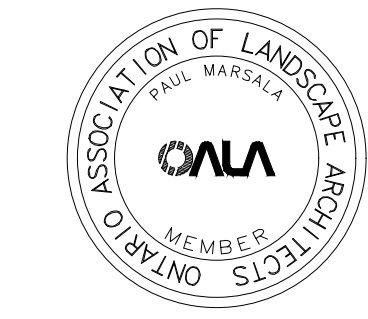

Signature
YYYY-MM-DD
Date

Key map

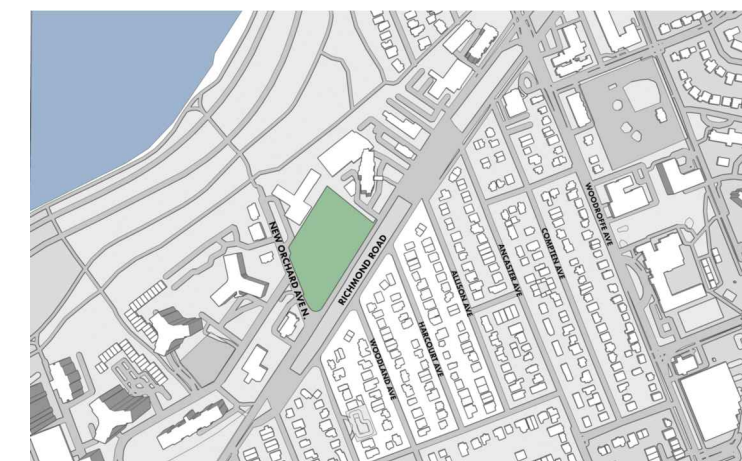

Scale North
AS SHOWN

Phase

SPA

Date

2024-07-09

Drawing Name

LANDSCAPE DETAILS

Sheet Number

NOT FOR CONSTRUCTION


LS.202




1 VIEW TOWARDS WORKING SPACE AND PEDESTRIAN MEWS
N.T.S



2 AERIAL VIEW
N.T.S

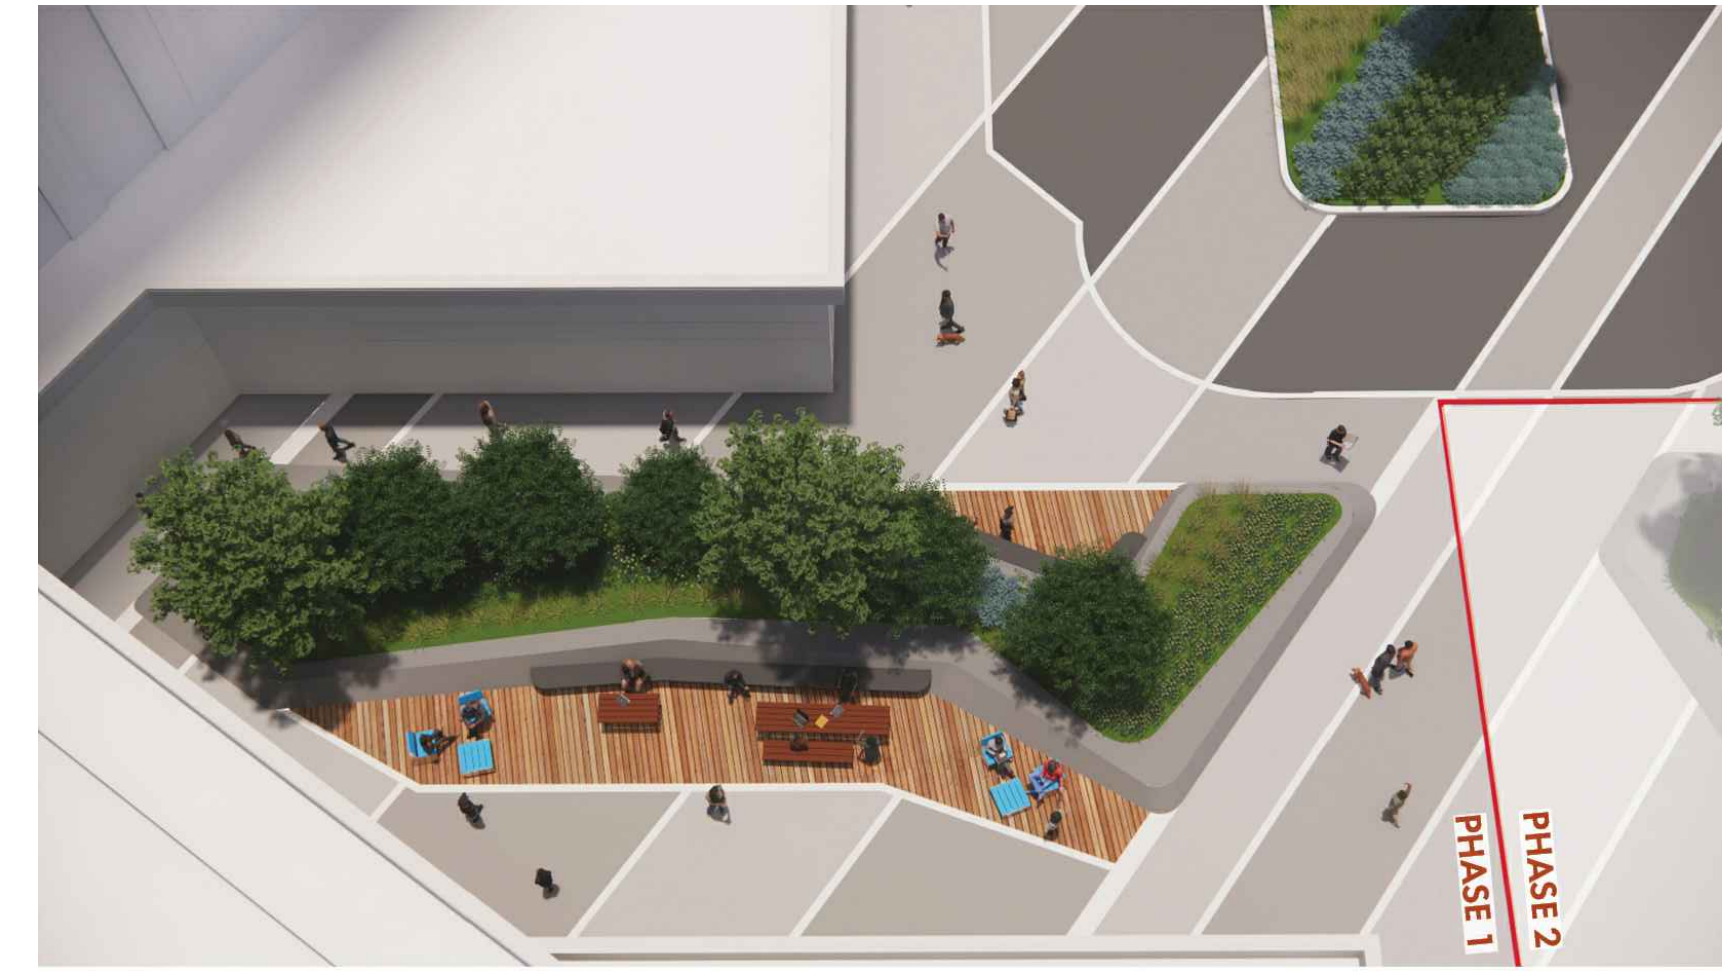

3 VIEW TOWARDS WORKING SPACE - OUTDOOR AMENITY
N.T.S

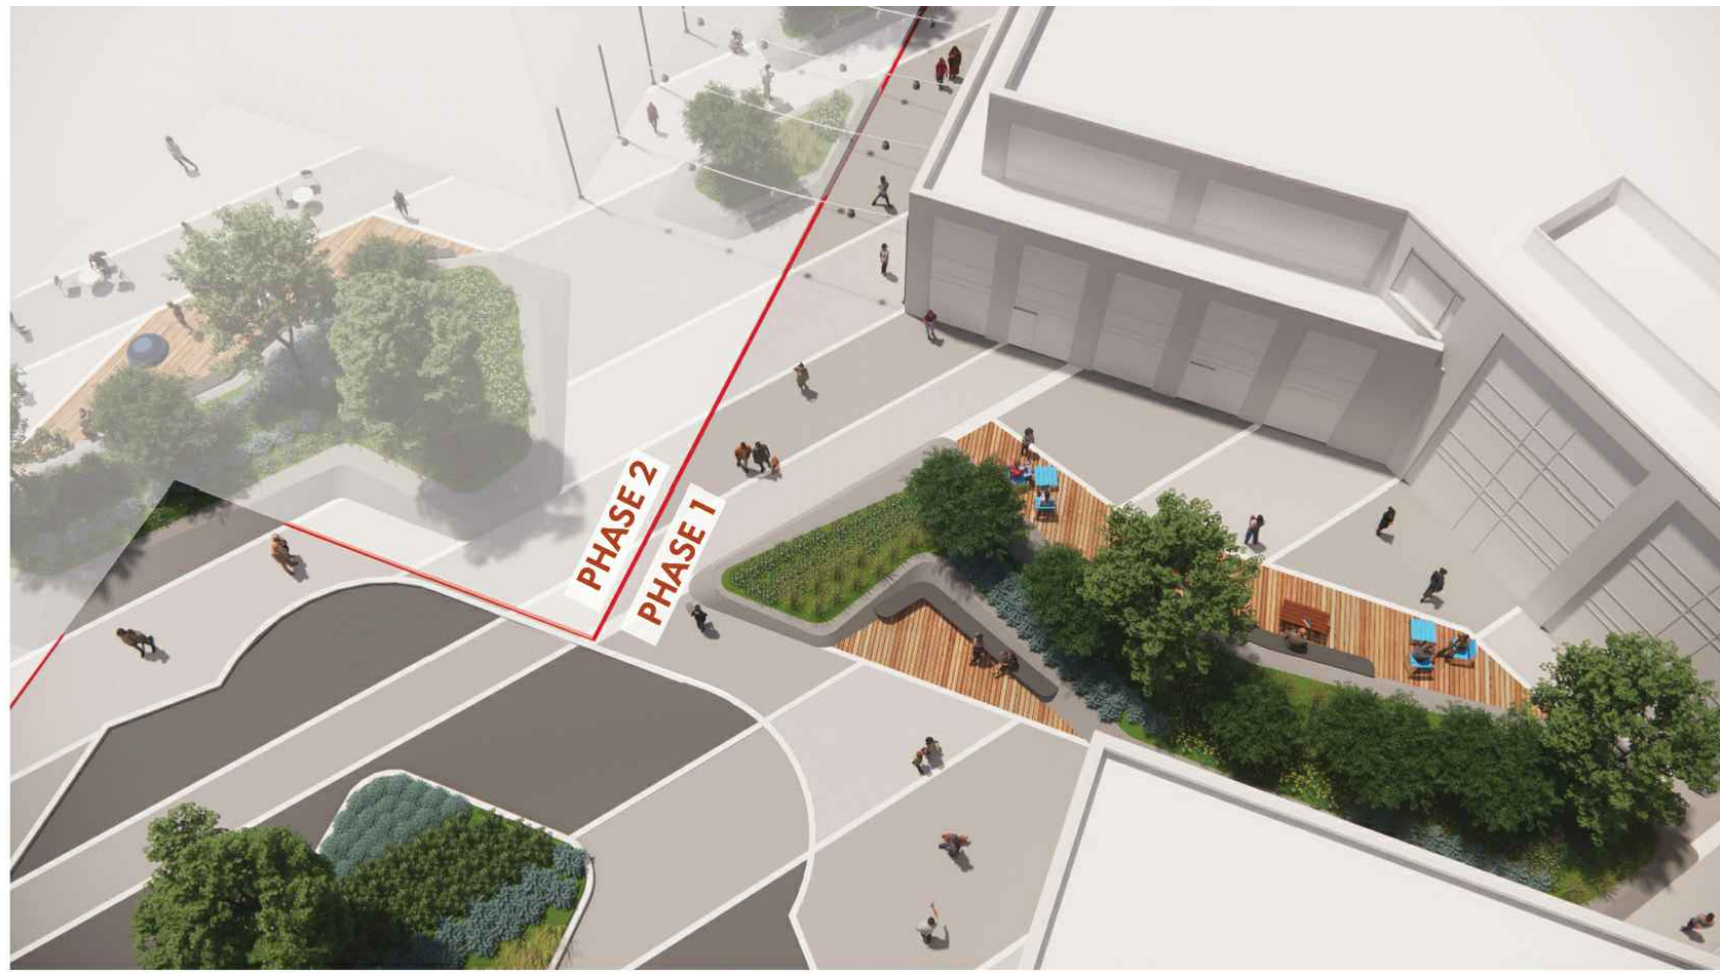

4 VIEW TOWARDS WORKING SPACE -OUTDOOR AMENITY
N.T.S



5 BUILDING FRONTAGE AND PEDESTRIAN ACCESS FROM RICHMOND ROAD
N.T.S



6 WORKING SPACE-OUTDOOR AMENITY
N.T.S



7 SCULPTURAL PLANTER- BUILDING ENTRANCE
N.T.S



8 OUTDOOR AMENITY AREA
N.T.S

Revisions

9	ISSUED FOR SPA	2024-10-11	AK
8	ISSUED FOR SPA	2024-09-03	AK
7	ISSUED FOR COORDINATION	2024-08-30	AK
6	ISSUED FOR COORDINATION	2024-08-27	AK
5	ISSUED FOR COORDINATION	2024-08-21	AK
4	ISSUED FOR LDRP	2024-07-30	AK
3	ISSUED FOR COORDINATION	2024-07-15	AK
2	ISSUED FOR COORDINATION	2024-07-12	AK
1	ISSUED FOR COORDINATION	2024-07-09	AK




Signature

YYYY-MM-DD

Date

Key map

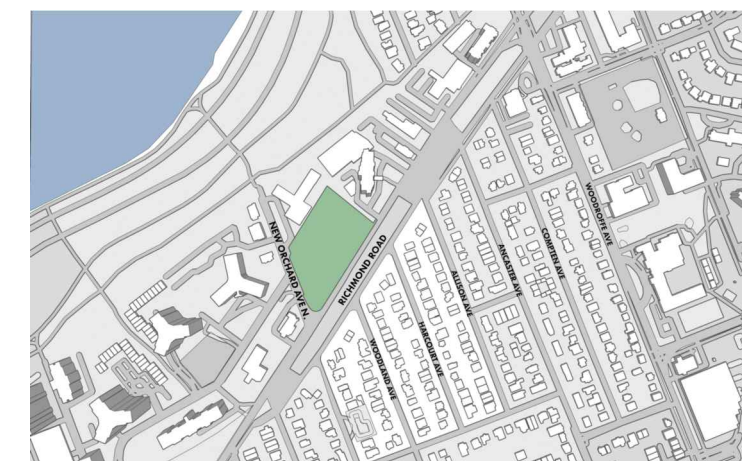

Scale

AS SHOWN

North

Phase

SPA

Date

2024-07-09

Drawing Name

LANDSCAPE VIEWS

Sheet Number

NOT FOR CONSTRUCTION

LS.203

© STUDIO rla