



LEGEND

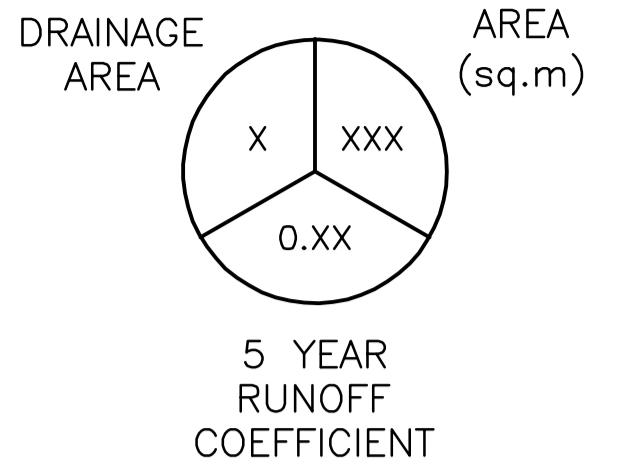

KEY PLAN

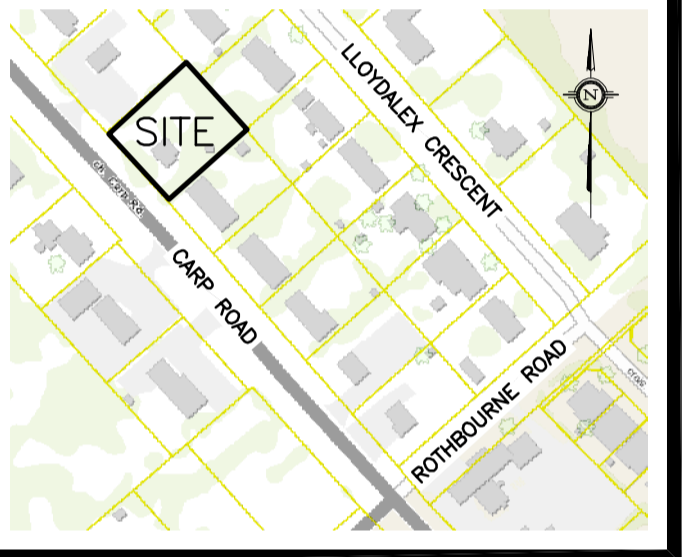

No.	DATE	REVISION
6	DEC 17-24	RE-ISSUED FOR APPROVAL
5	JUL 2-24	RE-ISSUED FOR APPROVAL
4	JUL 31-23	RE-ISSUED FOR APPROVAL
3	MAR 24-23	ISSUED FOR APPROVAL
2	DEC 15-22	ISSUED FOR COORDINATION
1	OCT 27-22	PRELIMINARY

D. B. GRAY ENGINEERING INC.
 Stormwater Management - Grading & Drainage - Storm & Sanitary Sewers - Watermain
 700 Long Point Circle
 Ottawa, Ontario
 613-425-8044
 d.gray@dbgrayengineering.com

Project
417 AUTO SALES
2026 CARP ROAD
 CARP, ONTARIO

POST-DEVELOPMENT DRAINAGE PLAN

Drawing Title
POST-DEVELOPMENT DRAINAGE PLAN

Engineer's Seal

Drawn: D.B.G.
 H. Scale: 1:100
 V. Scale:
 Date: OCT 27-22
 Job No.: 21021

Drawing No.
C-5
 of 5

NOT VALID UNLESS SIGNED & DATED