


LEGEND

DRAINAGE AREA

AREA (sq.m)

2 YEAR RUNOFF COEFFICIENT

Diagram showing a circle divided into three segments labeled 'x', 'xxx', and '0.xx'.

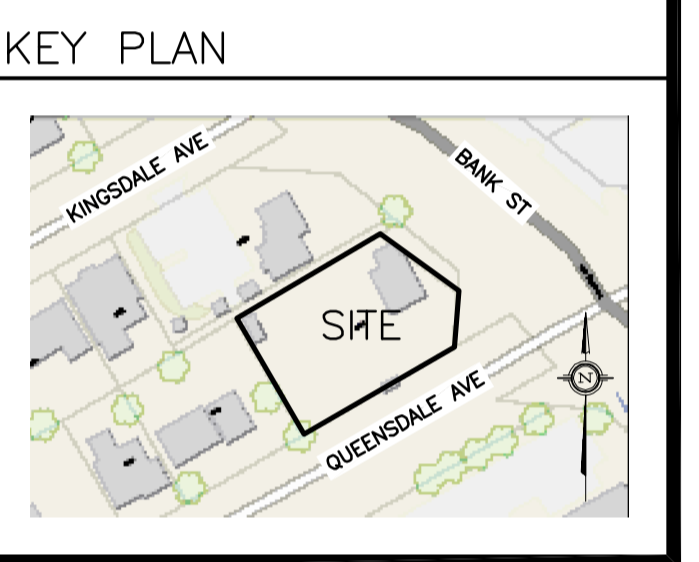

No.	DATE	REVISION
3	JAN 15-25	RE-ISSUED FOR APPROVAL
2	DEC 2-24	RE-ISSUED FOR APPROVAL
1	APR 26-24	ISSUED FOR APPROVAL

D. B. GRAY ENGINEERING INC.
 Stormwater Management - Grading & Drainage - Storm & Sanitary Sewers - Watermain
 700 Long Point Circle
 Ottawa, Ontario
 613-425-8044
 d.gray@dbgrayengineering.com

Project
PROPOSED 4-STORY APARTMENT BUILDING
2928 BANK STREET
 OTTAWA, ONTARIO

Drawing Title
POST-DEVELOPMENT DRAINAGE PLAN

Engineer's Seal

 NOT VALID UNLESS SIGNED & DATED

Drawn D.B.G.
 H. Scale 1:100
 V. Scale
 Date MAR 22-24
 Job No. 23019

Drawing No.
C-8
 of 8