


**LEGEND**

DRAINAGE AREA:  $\frac{x}{xxx}$   
 AREA (sq.m):  $0.xx$

5 YEAR RUNOFF COEFFICIENT

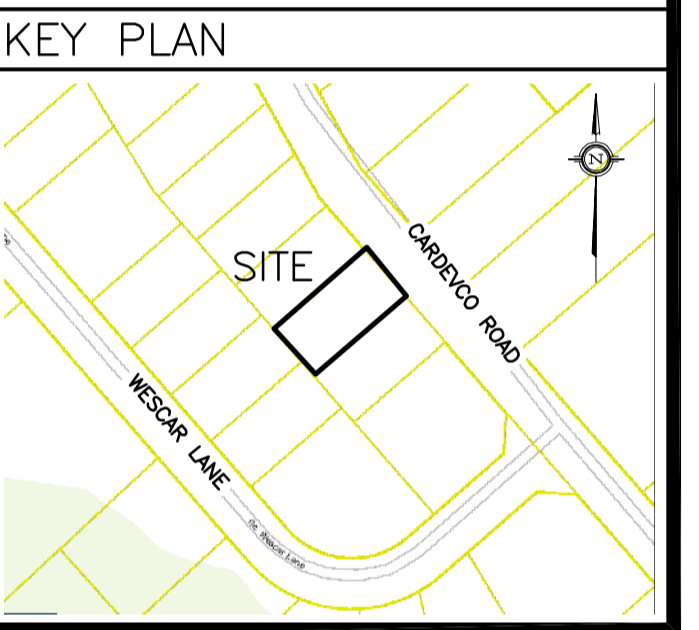

No.	DATE	REVISION
5	FEB 10-25	RE-ISSUED FOR APPROVAL
4	OCT 23-24	RE-ISSUED FOR APPROVAL
3	JUN 9-23	RE-ISSUED FOR APPROVAL
2	NOV 24-22	ISSUED FOR APPROVAL
1	NOV 15-22	ISSUED FOR COORDINATION

**D. B. GRAY ENGINEERING INC.**  
 Stormwater Management - Grading & Drainage - Storm & Sanitary Sewers - Wetlands  
 700 Long Point Circle 613-425-8044  
 Ottawa, Ontario d.gray@dbgrayengineering.com

Project  
**PROPOSED ADDITION  
 135 CARDEVCO ROAD  
 OTTAWA, ONTARIO**

Drawing Title  
**PRE & POST DEVELOPMENT  
 DRAINAGE PLAN**

Engineer's Seal  
  
 NOT VALID UNLESS SIGNED & DATED

Drawn: D.B.G.  
 H. Scale: 1:200  
 V. Scale:  
 Date: NOV 15-22  
 Job No.: 21081

Drawing No.  
**C-4  
 of 4**