


Label	CalcType	Units	Avg	Max	Min	AvgMin	MaxMin
pathway_Top	Illuminance	Fc	2.86	28.7	0.0	N.A.	N.A.
SPLILLAGE	Illuminance	Fc	0.09	0.4	0.0	N.A.	N.A.

Symbol	Qty	Label	Arrangement	LLF	Description	Lum. Lumens
⊙	2	EX1	SINGLE	0.900	DALS - FOCUS - CYLUS-CC	1125
⊙	2	EX2	SINGLE	0.900	DALS - SHIELD - DSW037-CC-V-BK	1994
⊙	2	EX3	SINGLE	0.900	TURD - RIGD-HS112#MULTI-KWVHD	1991
⊙	4	EX4	SINGLE	0.900	DALS - RISE - LSTP12-CC	318

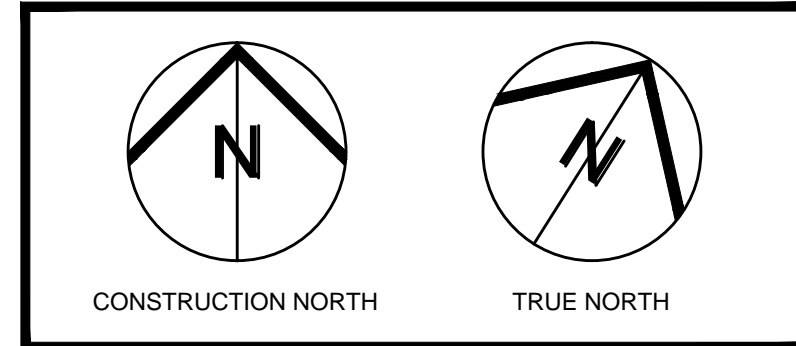

No	Issued for Site Plan Application	DATE
1	ISSUE/REVISION	22.04.2025
N°	ÉMISSION/RÉVISION	DD/MM/YY

ENGINEERING WISDOM

143 DEERCROFT AVE, OTTAWA, ON K2J 5H8
 TEL. (613) 366-8101
 FAX. (613) 366-8101
 E-Mail: INFO@WISDOMENGINEERING.CA

PROJECT NAME / NOM DU PROJET
**222 Baseline Rd
 Mid-Rise Apartments**
 Ottawa, ON

DRAWING TITLE / TITRE DU DESSIN
Electrical Site Plan

JOB No / N° DE PROJET 797-23	DATE / DATE April 2025
SCALE / ECHELLE 1:75	

DRAWN BY / DESSINÉ PAR OA	CHECKED BY / VÉRIFIÉ PAR MA
------------------------------	--------------------------------

STAMP:

DRAWING No / DESSIN N°
ES

REVISION No / RÉVISION N°
 0