



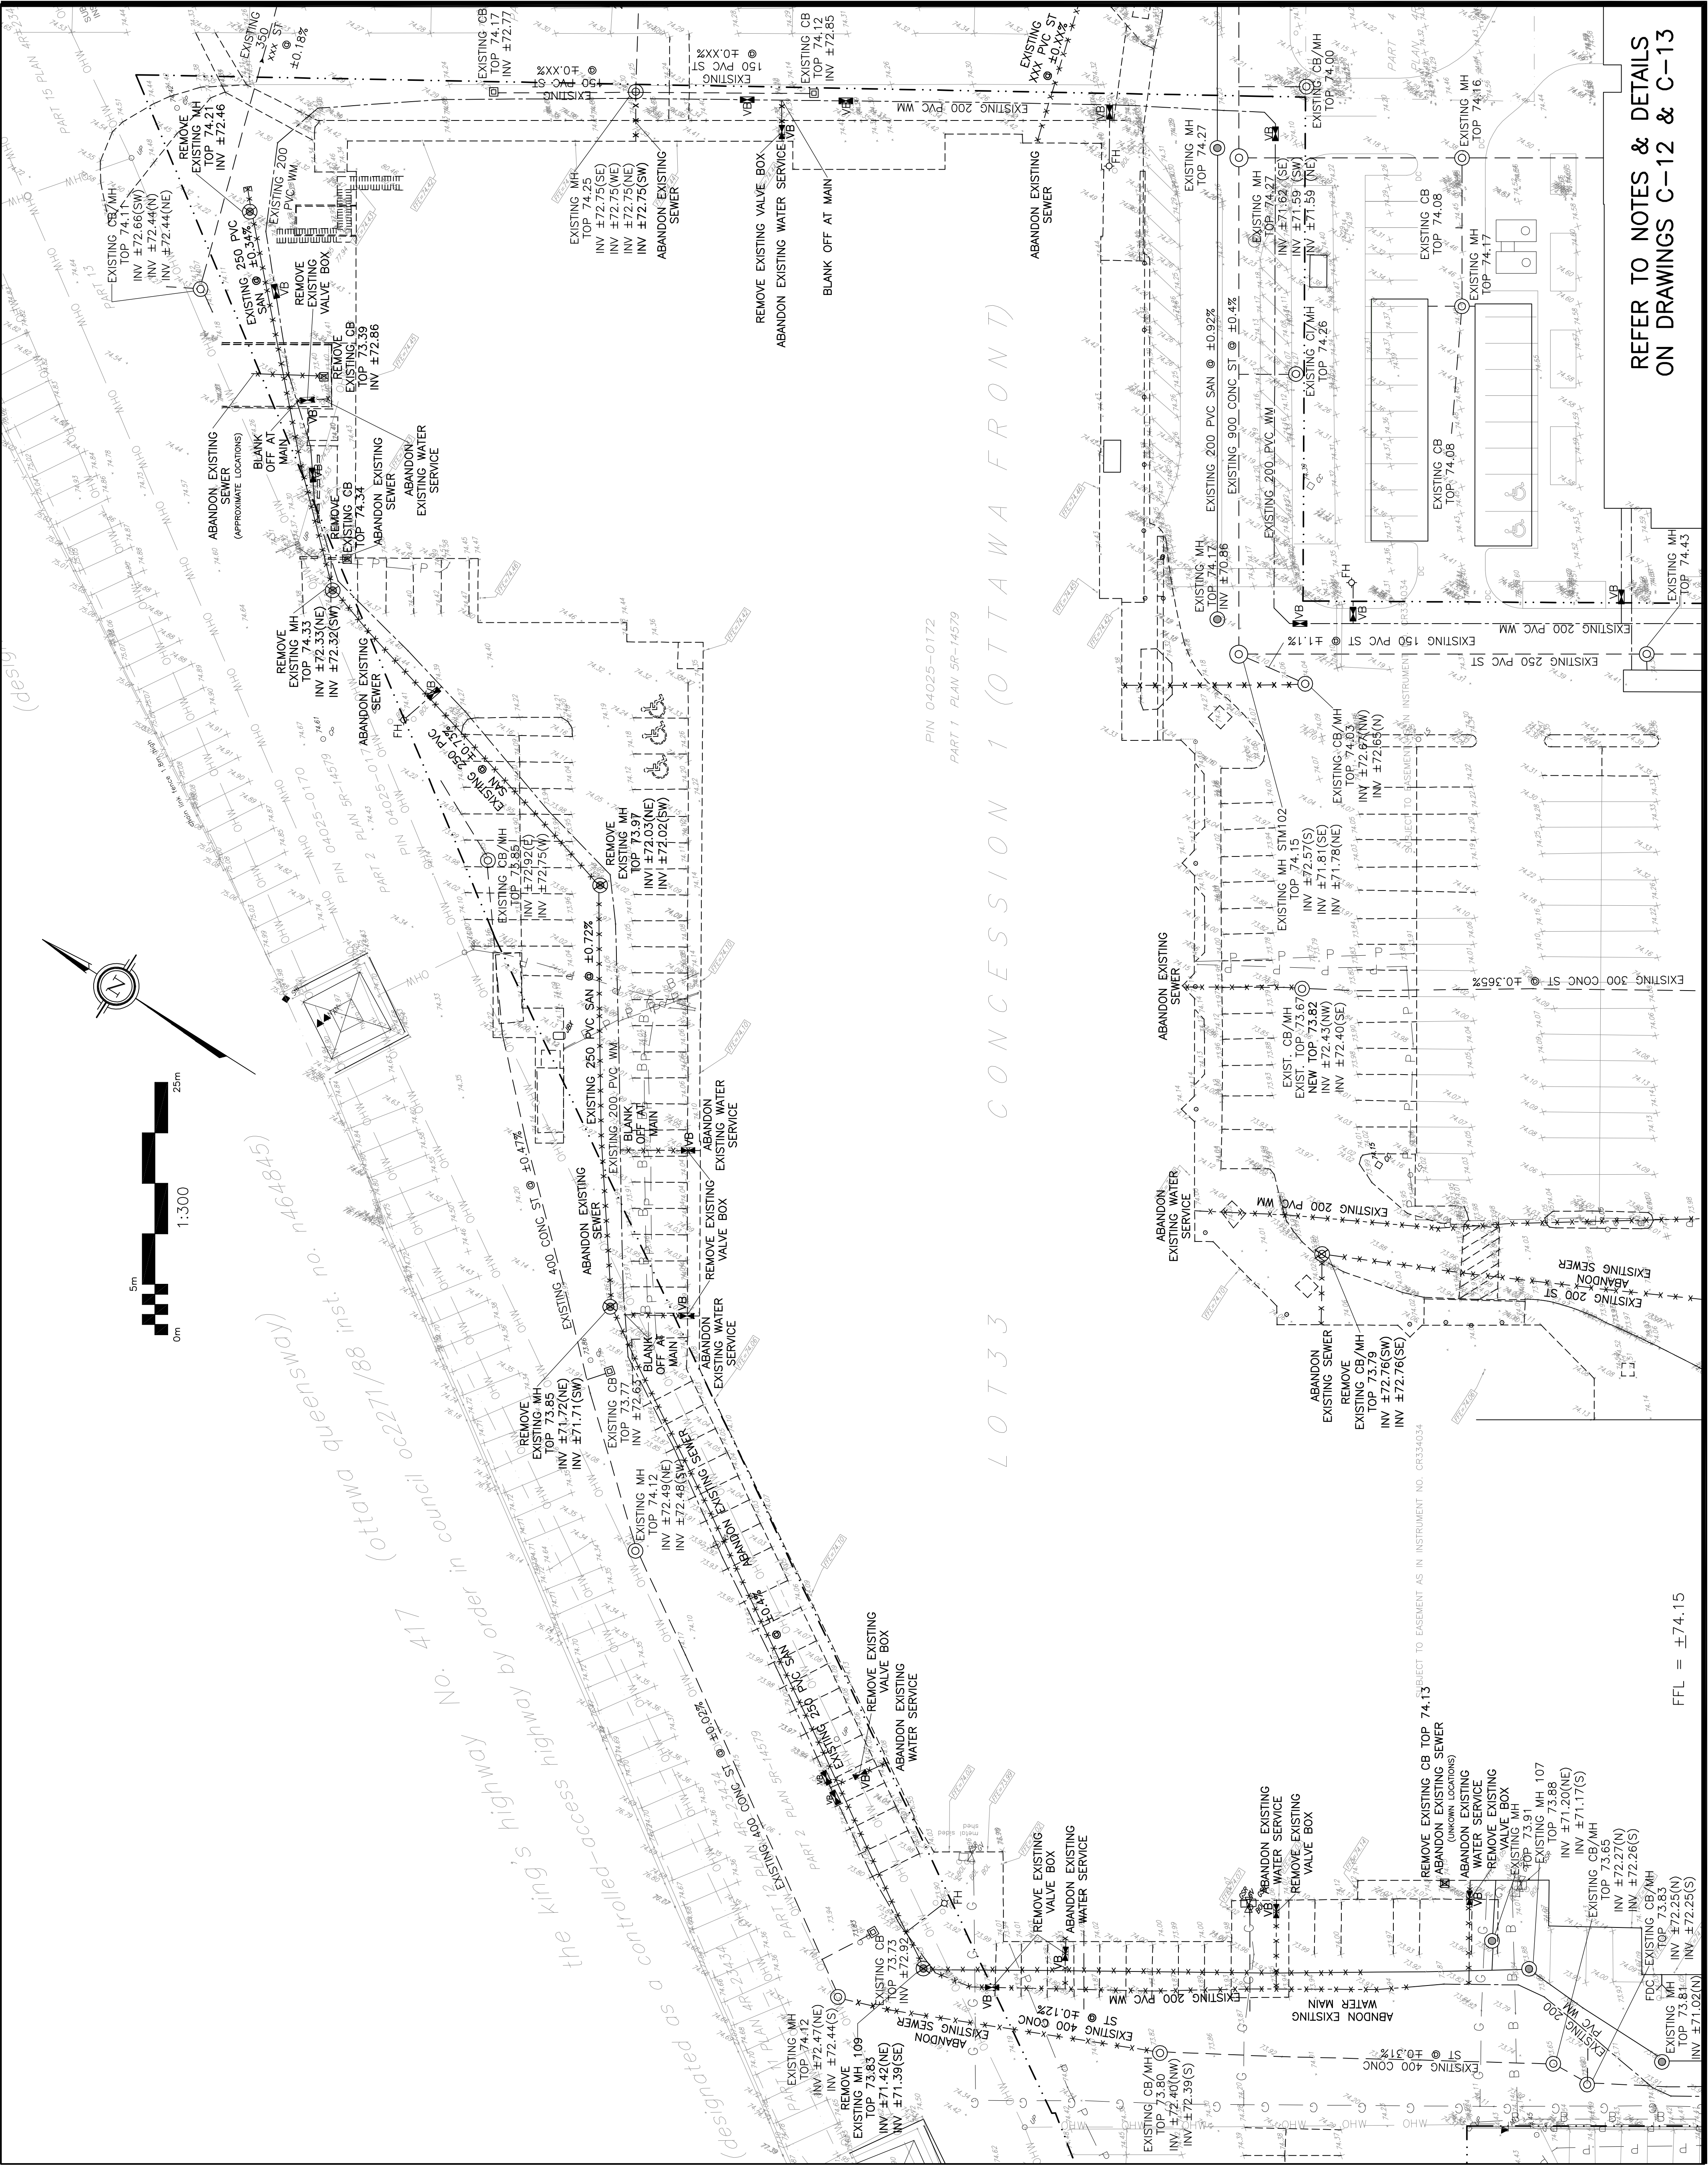

LEGEND	
FFL	FIRST FLOOR ELEVATION
TOP	TOP OF FOUNDATION
BFL	BASEMENT FLOOR ELEVATION
USF	UNDERSIDE OF FOOTING
---	PROPERTY LINE
CB	CATCH BASIN
MH	STORM MANHOLE
CB/MH	CATCH BASIN/MANHOLE
MH	SANITARY MANHOLE
FH	FIRE HYDRANT
FDC	FIRE DEPARTMENT CONNECTION
CS	CURB STOP & STANDPOST
VB	VALVE & VALVE BOX
SAN	SANITARY SEWER
ST	STORM SEWER
WS/WM	WATER SERVICE/WATERMAIN
OBV	OBVERT OF PIPE
SPL	SPRINGLINE OF PIPE
INV	INVERT OF PIPE
---	EXISTING GRADE ELEVATION

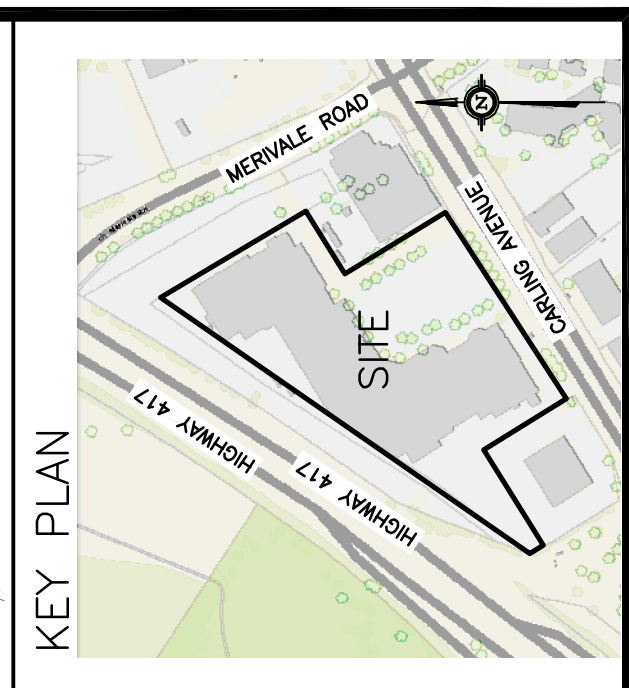

No.	DATE	REVISION
2	MAY 9-25	ISSUED FOR SITE PLAN APPROVAL
1	MAR 3-25	ISSUED FOR COORDINATION

D.B. GRAY ENGINEERING INC.
Professional Engineers - Consulting & Engineering
700 Long Point Circle
Ottawa, Ontario
d.gray@dbgrayengineering.com
613-425-8044

Project
PROPOSED REDEVELOPMENT OF WESTGATE SC PHASE 1B
1309 CARLING AVENUE
OTTAWA, ONTARIO

Drawing Title
EXISTING CONDITIONS, REMOVALS & ABANDONMENT PLAN
NORTH

Drawn D.B.G.	H. Scale 1:300	Date FEB 12-25	Job No. 25013
Drawing No. C-5 of 14			

REFER TO NOTES & DETAILS
ON DRAWINGS C-12 & C-13

FFL = ± 74.15