


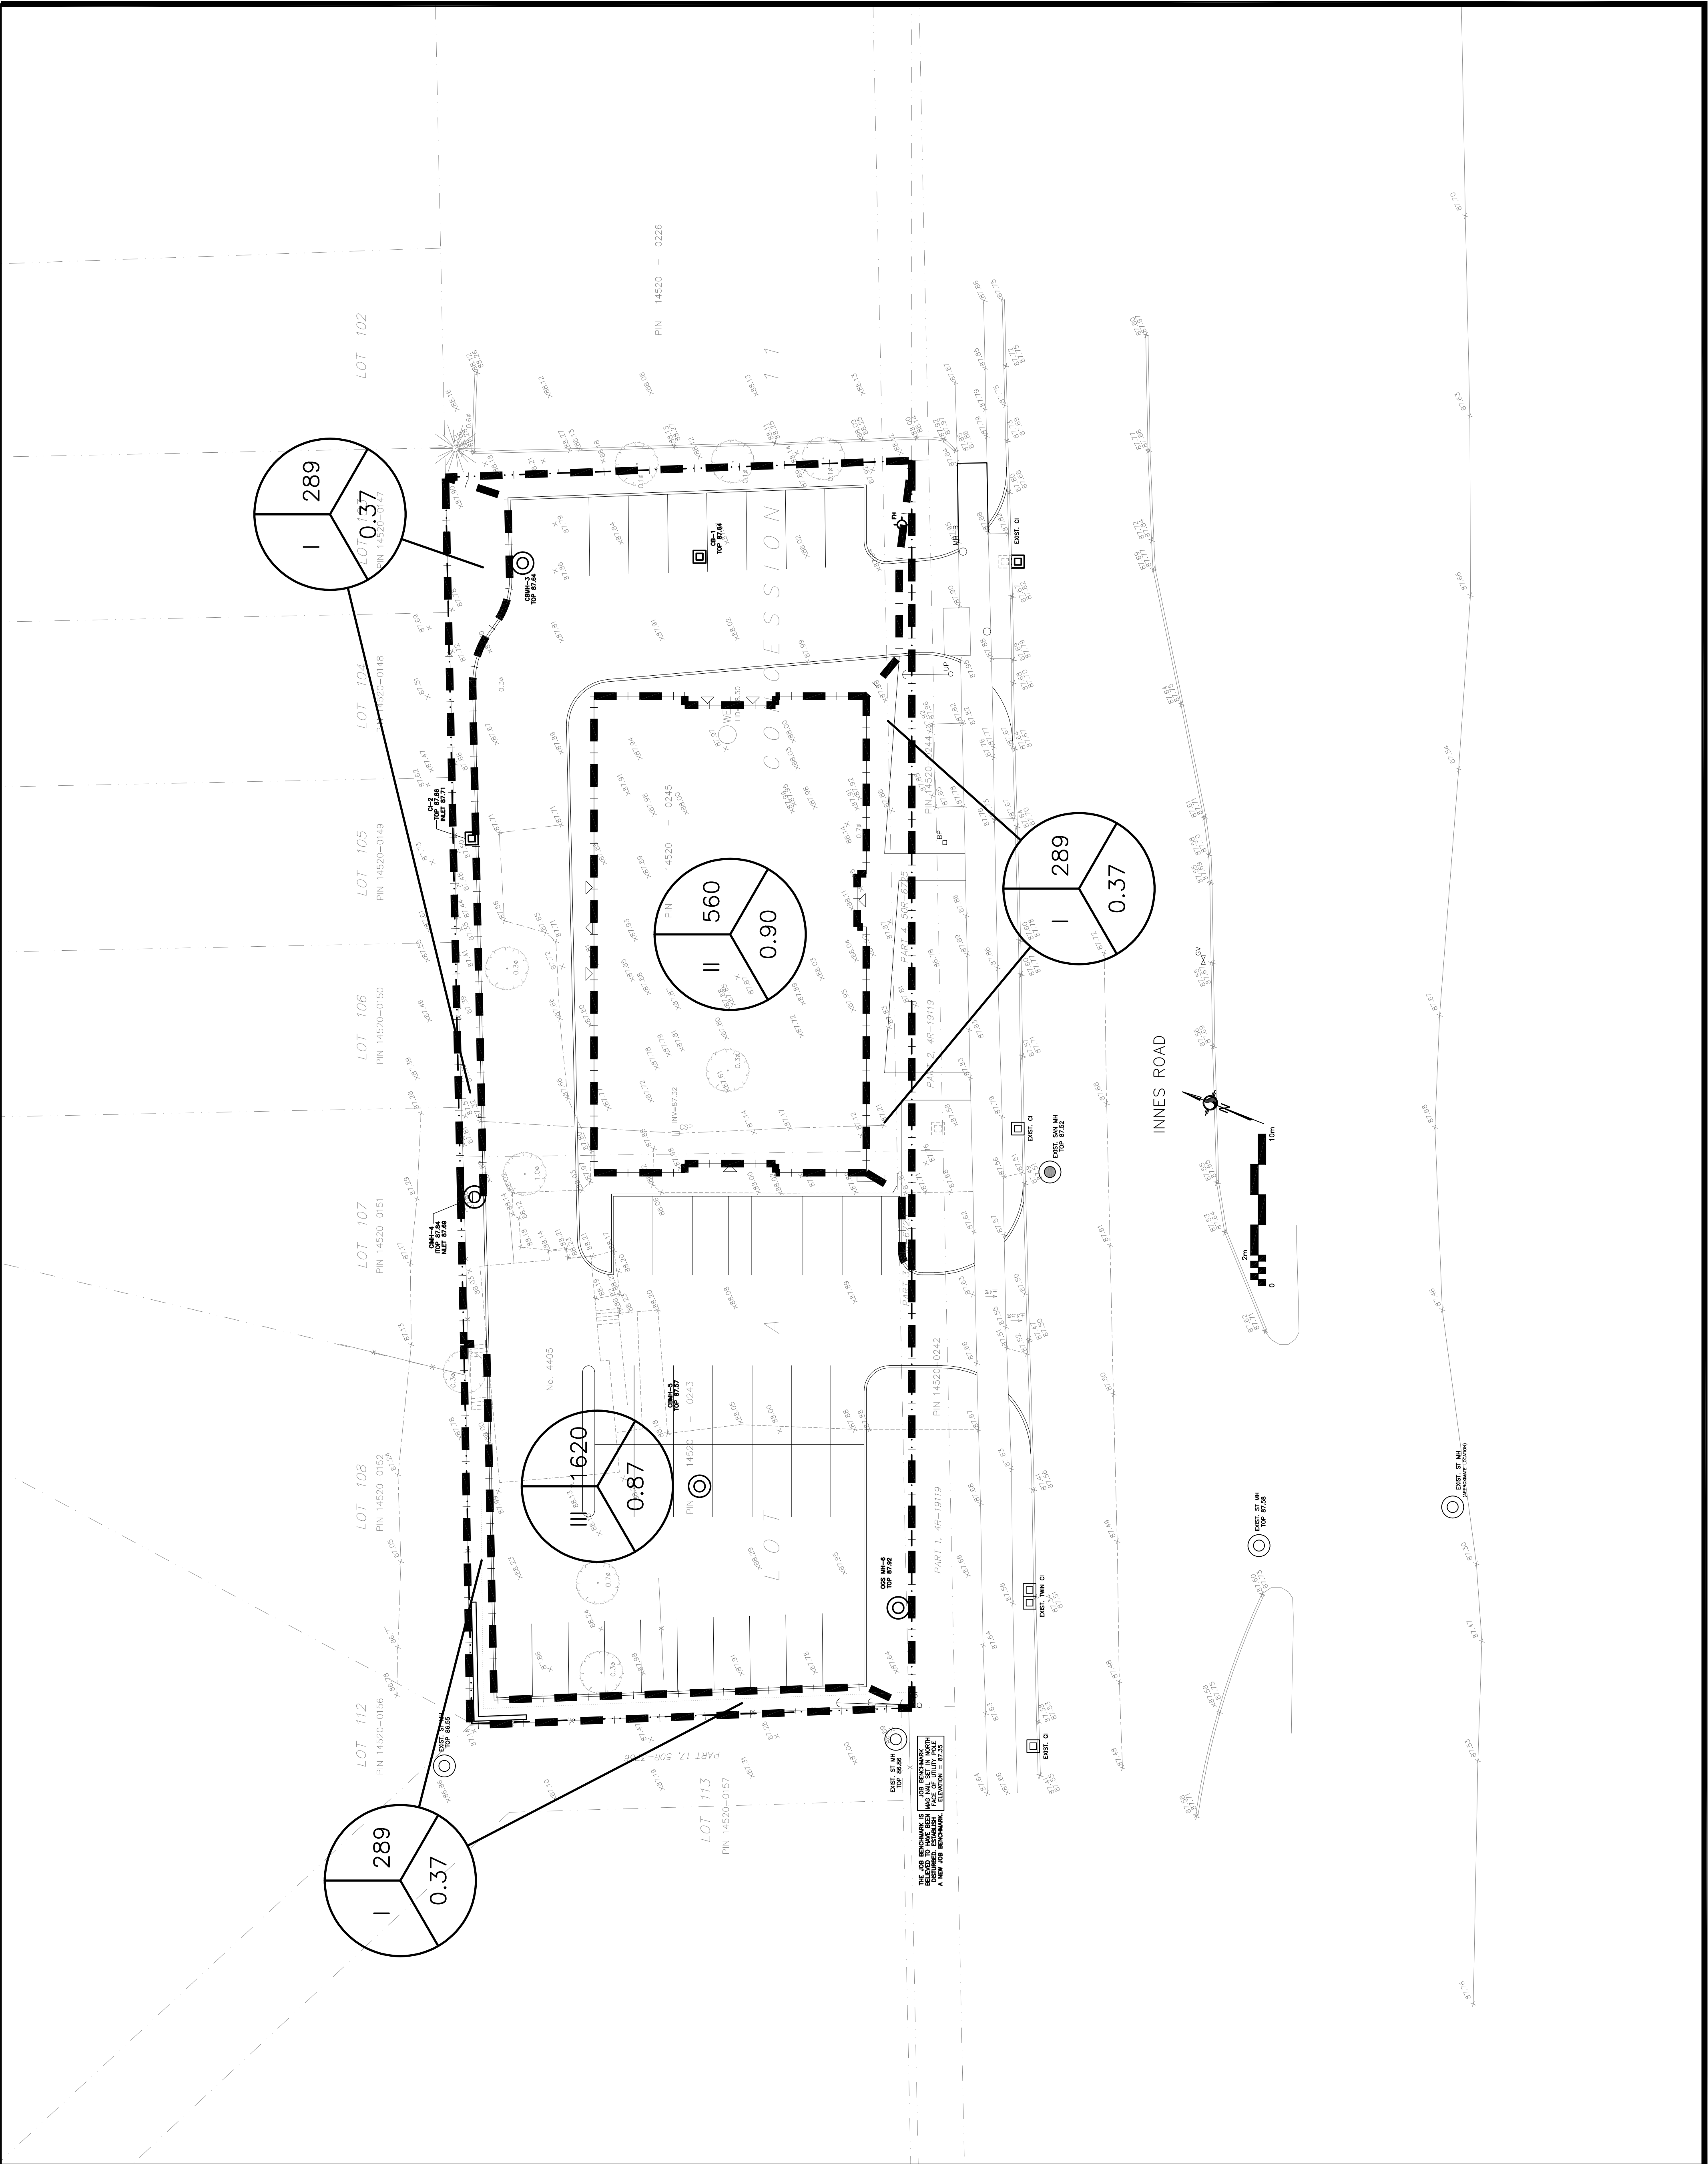

LEGEND

DRAINAGE AREA

AREA (sq.m)

x

xxx

0.xx

5-YEAR RUNOFF COEFFICIENT



No.	DATE	REVISION
1	JUL 15-25	ISSUED FOR APPROVAL

D. B. GRAY ENGINEERING INC.
700 Long Point Circle
Ottawa, Ontario
613-425-8044
d.gray@dbgrayengineering.com

Project
PROPOSED 2-STORY MEDICAL FACILITY
4405-4409 INNES ROAD
OTTAWA, ONTARIO

Drawing Title
DRAINAGE PLAN

Engineer's Seal

PROFESSIONAL ENGINEER

D.B. GRAY

018582

JUL 15-25

PROVINCE OF ONTARIO

Drawn

D.B.G.

H. Scale

1:200

V. Scale

Date

JUL 15-25

Job No.

25061

Drawing No.

C-12

of 12

NOT VALID UNLESS SIGNED & DATED