


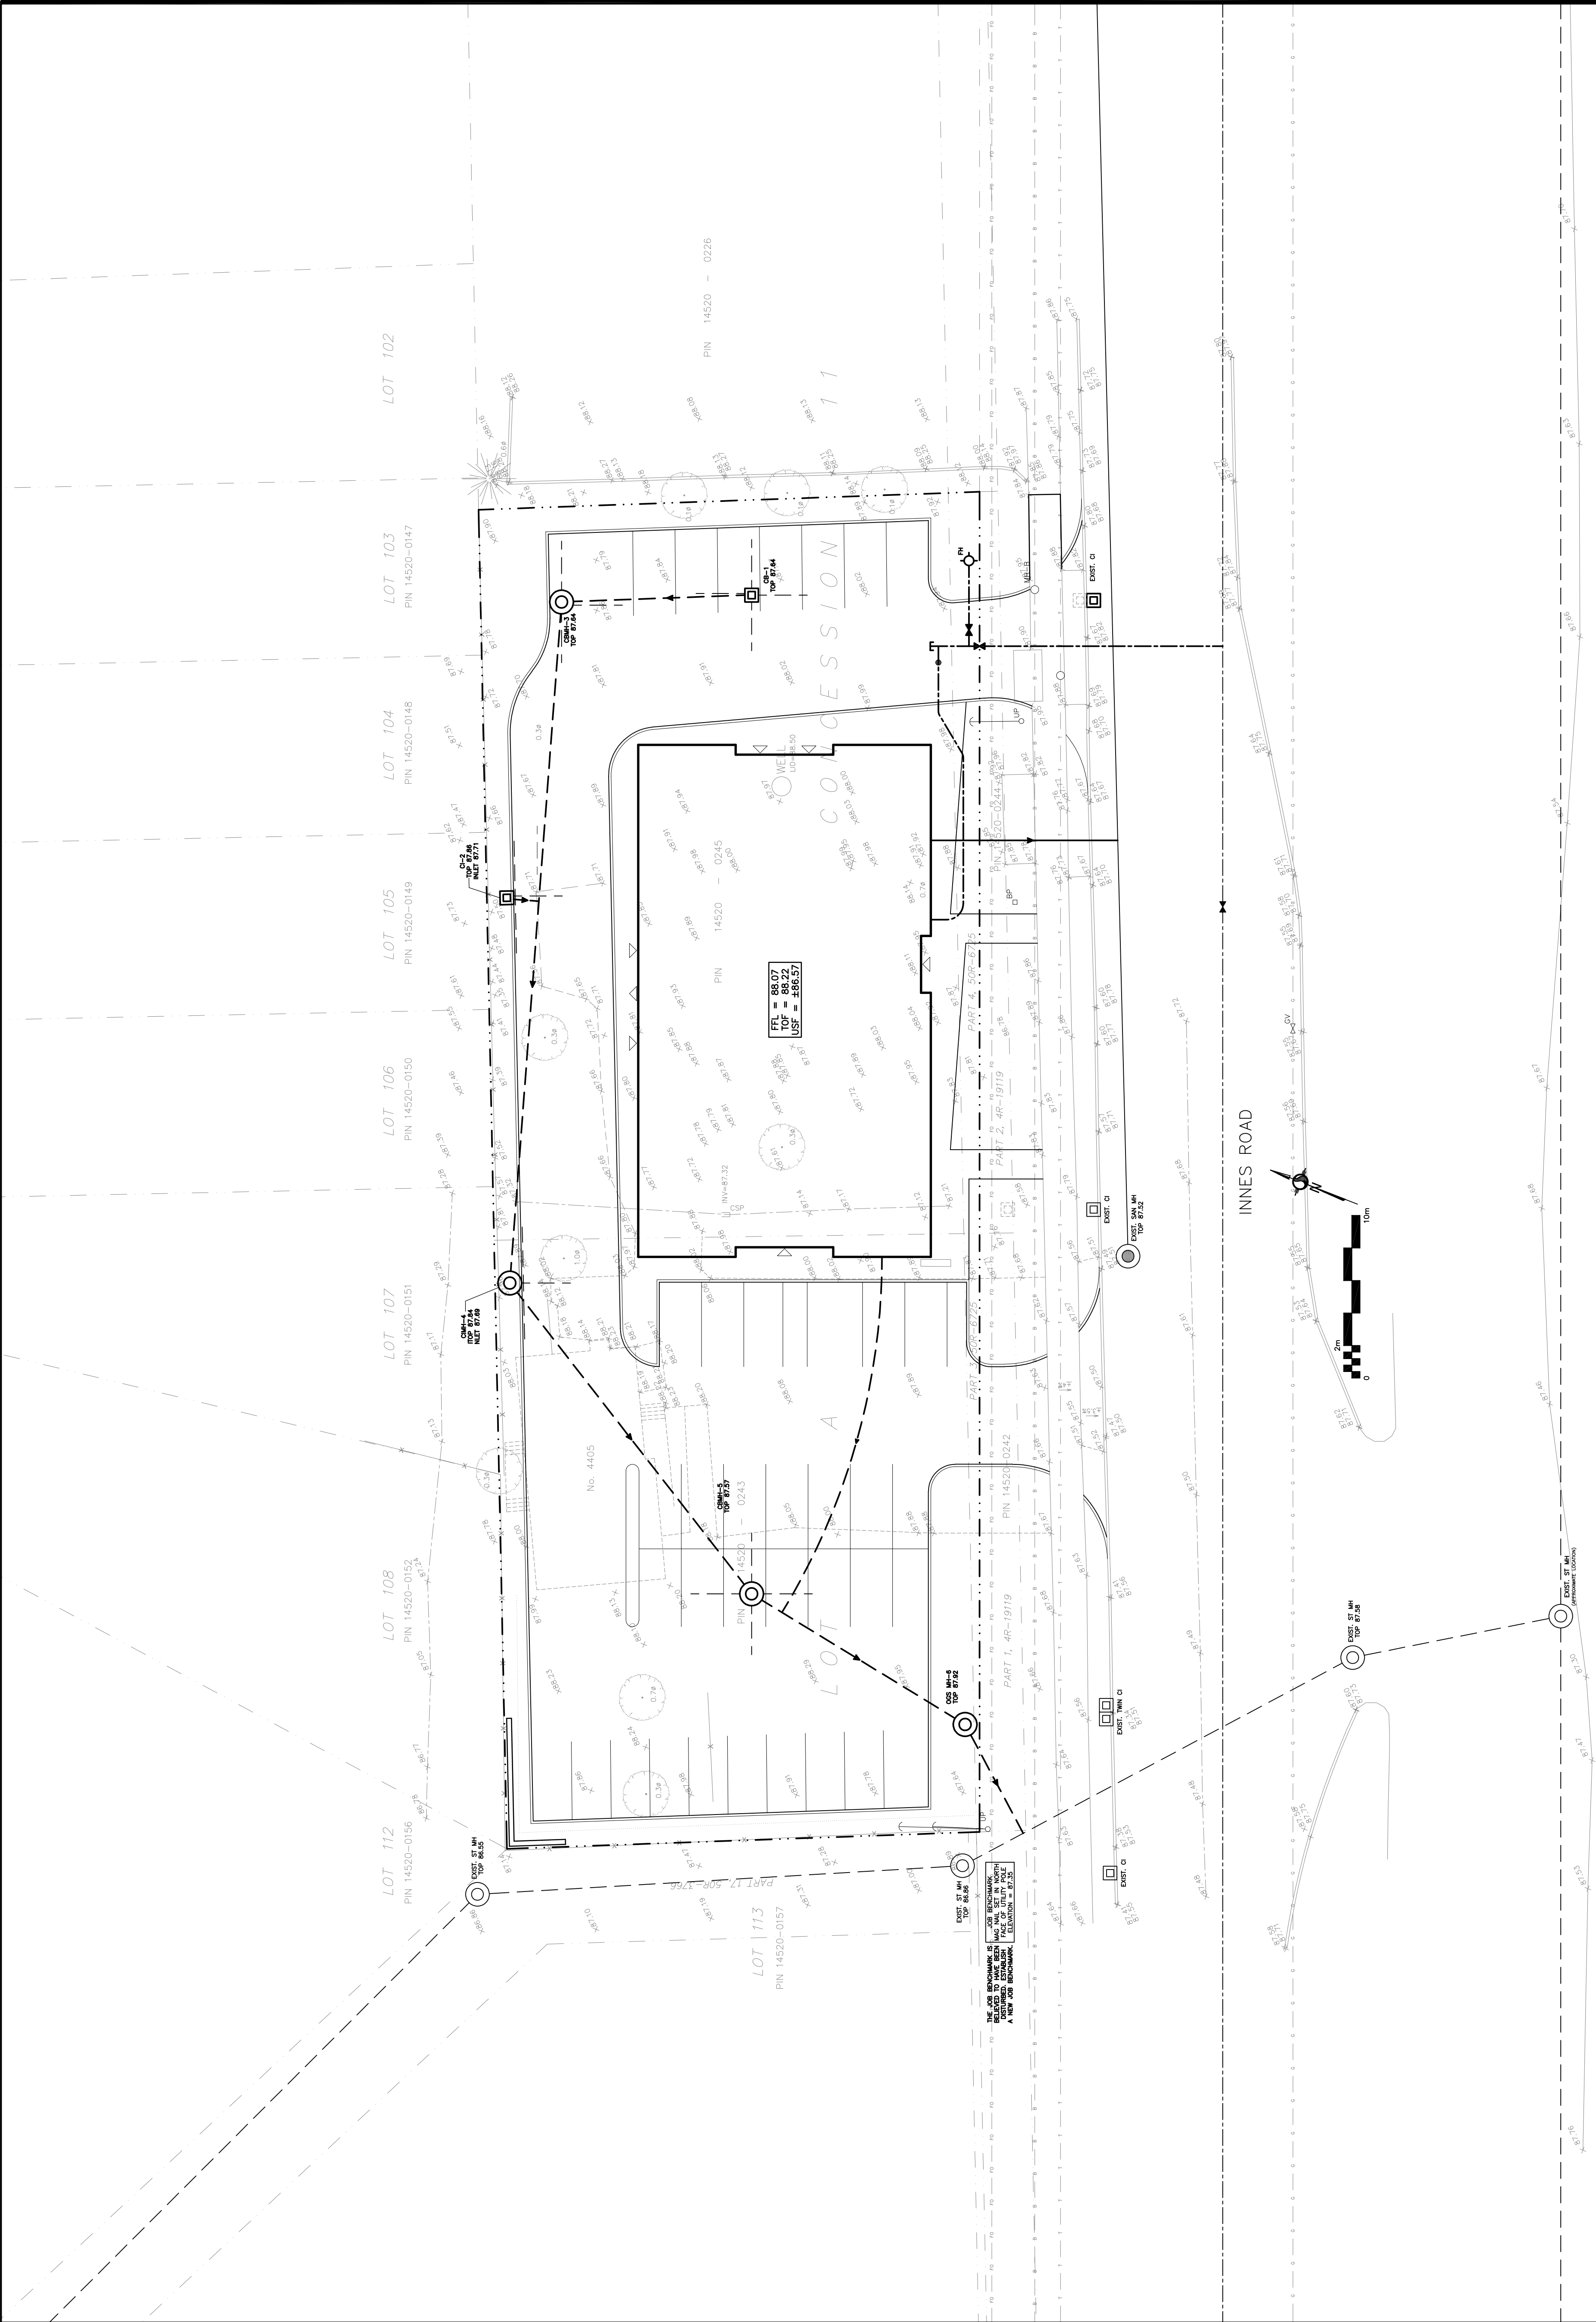

LEGEND

FFL	FINISHED FLOOR ELEVATION
TOF	TOP OF FOUNDATION
USF	UNDERSIDE OF FOOTING
---	PROPERTY LINE
CB	CATCH BASIN
CI	CURB INLET
MH	STORM MANHOLE
MH	SANITARY MANHOLE
FH	FIRE HYDRANT
CS	CURB STOP & SERVICE POST
VB	VALVE & VALVE BOX
SAN	SANITARY SEWER
ST	STORM SEWER
WS/WM	WATER SERVICE/WATERMAIN
OBV	OBVERT
SPL	SPRINGLINE
INV	INVERT
US	UNDERSIDE

KEY PLAN



No.	DATE	REVISION
1	JUL 15-25	ISSUED FOR APPROVAL

D. B. GRAY ENGINEERING INC.
Stormwater Management - Grading & Drainage - Storm & Sanitary Sewers - Pavement
700 Long Point Circle
Ottawa, Ontario
d.gray@dbgrayengineering.com
613-425-8044

Project
PROPOSED 2-STORY MEDICAL FACILITY
4405-4409 INNES ROAD
OTTAWA, ONTARIO

Drawing Title
SITE PLAN

Engineer's Seal
LICENSED PROFESSIONAL ENGINEER
D.B. GRAY
01018352
JUL 15-25
PROVINCE OF ONTARIO

Drawn: D.B.G.
H. Scale: 1:200
V. Scale:
Date: JUL 15-25
Job No.: 25061

Drawing No.:
C-1
of 12

NOT VALID UNLESS SIGNED & DATED

REFER TO NOTES & DETAILS
ON DRAWING No. C-10 & C-11