



APPROVED
By Sole Soyak at 6:47 pm, Jul 30, 2025

S. Soyak

SOLE SOYAK
PLANNER II
PLANNING, DEVELOPMENT AND BUILDING SERVICES
DEPARTMENT, CITY OF OTTAWA

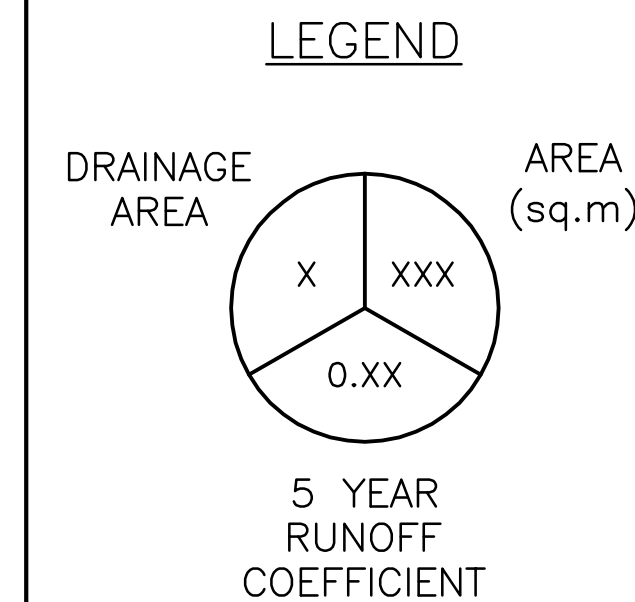

KEY PLAN

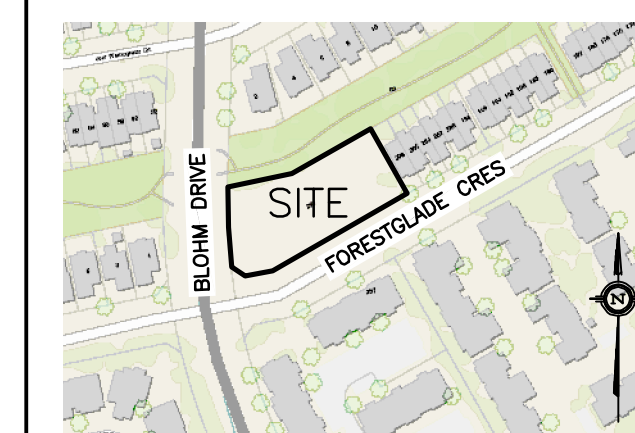


No.	DATE	REVISION
7	JUL 18-25	RE-ISSUED FOR SITE PLAN CONTROL & ISSUED FOR TENDER
6	JUN 26-25	ISSUED FOR BUILDING PERMIT
5	MAY 7-25	RE-ISSUED FOR SITE PLAN CONTROL
4	APR 4-25	ISSUED FOR SITE PLAN CONTROL
3	APR 2-25	ISSUED FOR COORDINATION
2	FEB 21-25	ISSUED FOR CLASS B COSTING
1	FEB 14-25	ISSUED FOR COORDINATION

D. B. GRAY ENGINEERING INC.
Stormwater Management - Grading & Drainage - Storm & Sanitary Sewers - Watermain
700 Long Point Circle
Ottawa, Ontario
613-425-8044
d.gray@dbgrayengineering.com

Project
**PROPOSED 3-STORY
OAC WOMEN'S SHELTER
250 FORESTGLADE CRESCENT
OTTAWA, ONTARIO**

Drawing Title
**POST DEVELOPMENT
DRAINAGE PLAN**

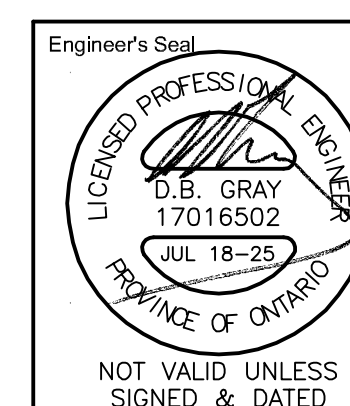

Drawn D.B.G.
H. Scale 1:200
V. Scale
Date FEB 14-25
Job No. 24053

Drawing No.
**C-7
of 7**

**REFER TO NOTES & DETAILS
ON DRAWINGS C-4 & C-5**

REFER TO THE GEOTECHNICAL REPORT: THE SUB-GRADE, GRANULAR LAYERS AND SURFACE OF PAVEMENT STRUCTURES AND OTHER HARD SURFACES SHALL BE CROWNED OR SLOPED TO PROMOTE DRAINAGE OF WATER AWAY FROM THE BUILDING AND OTHER SURFACE STRUCTURES. SUB-DRAINS SHALL BE INSTALLED AT THE SUB-GRADE LEVEL AT LOCATIONS AS INDICATED ON THE PLAN TO ENSURE EFFECTIVE DRAINAGE OF SUBSURFACE WATER. THE SUB-DRAINS SHALL CONNECT TO CATCH BASINS OR STORM MANHOLES. THE SUB-DRAINS SHALL BE INSTALLED IN ACCORDANCE WITH OPSS/MUNI 405.

CB/MH-7 CAN BE
USED AS THE
MONITORING MANHOLE

