

10	issue for SPA	2025/11/25
09	issue for coordination	2025/05/16
08	issue for coordination	2025/05/07
07	issue for coordination	2025/04/30
06	issue for coordination	2025/04/23
05	issue for coordination	2025/04/21
04	issue for coordination	2025/04/07
rev'n	description / la description	yyyy/mm/dd



designed / conçu BM EM	drawn / dessiné BM EM	reviewed / examiné DF
date 2023/07/14	project number / No. du projet 23002	

NOTES:

THESE NO

DO NOT C

Fotenn Consultants Inc. IS NOT RESPONSIBLE FOR ACCURACY OF BASE INFORMATION.
REFER TO CIVIL ENGINEERING DRAWINGS FOR GRADING & SITE SERVICING INFORMATION.
REFER TO LIGHTING PLAN.

THE CONTRACTOR IS RESPONSIBLE FOR CONFIRMING SITE CONDITIONS AND REPORTING ANY DISCREPANCIES TO THE LANDSCAPE ARCHITECT.

THE CONTRACTOR IS RESPONSIBLE FOR CONFIRMING EXACT LOCATIONS OF ALL UNDERGROUND SERVICES AND OBTAINING CLEARANCE FROM ALL APPLICABLE UTILITIES. PROPOSED WORKS FOUND TO BE IN CONFLICT WITH UNDERGROUND SERVICES MAY BE ADJUSTED AT THE DIRECTION OF THE LANDSCAPE ARCHITECT.

LANDSCAPE ELEMENTS SHOWN ARE SUBJECT TO THE FINAL LOCATION OF UNDERGROUND SERVICES AND UTILITIES.

DO NOT INSTALL TREES ON PROPERTY / LOT LINES OR WITHIN DRAINAGE EASEMENTS.

PERFORM WORK IN ACCORDANCE WITH DETAILS AND SPECIFICATIONS.

ALL PLANT MATERIAL SHALL BE No. 1 NURSERY STOCK AND SHALL MEET OR EXCEED THE SPECIFICATION OF THE Canadian Standards for Nursery Stock, ASPUBLISHED BY THE Canadian Nursery Landscape Association.

LAYOUT OF PLANTING MATERIAL TO BE APPROVED BY LANDSCAPE ARCHITECT PRIOR TO INSTALLATION.

SPECIES SUBSTITUTIONS ARE NOT PERMITTED WITHOUT PRIOR WRITTEN APPROVAL OF THE LANDSCAPE ARCHITECT.

ALL UN-PAVED SURFACES NOT INDICATED FOR LANDSCAPE TREATMENT AND THOSE DAMAGED DURING CONSTRUCTION TO RECEIVE 150mm DEPTH TOPSOIL & SOD.

IMPORTANT NOTICE FOR CONTRACTOR:

THE CITY OF OTTAWA REQUIRES A Certificate of Completion (F1) Landscape Works TO BE SUBMITTED AND SEALED BY THE LANDSCAPE ARCHITECT.

CONTRACTORS ARE RESPONSIBLE FOR FAMILIARIZING THEMSELVES WITH THE REQUIREMENTS OF THIS PROCESS AND PROVIDING SUFFICIENT NOTICE TO THE LANDSCAPE ARCHITECT TO CONDUCT SITE REVIEWS DURING INSTALLATION OF TREES. THE 1 YEAR WARRANTY PERIOD SHALL NOT COMMENCE UNTIL THE LANDSCAPE ARCHITECT HAS SUBMITTED THE F1 Certificate.

PRIOR TO INSTALLATION OF TREES, THE OWNER SHALL CONTACT THE PLANNING AND GROWTH MANAGEMENT AND FORESTRY SERVICES TO REVIEW THE SPECIES AND LOCATION OF TREES.

PRELIMINARY
NOT FOR CONSTRUCTION


PLANT SCHEDULE SITE

PLANT SCHEDULE SITE

SYMBOL	CODE	QTY	BOTANICAL NAME	COMMON NAME	SIZE / CONDITION / SPACING
DECIDUOUS TREES					
	AC	2	Amelanchier canadensis	Canadian Serviceberry	50mm cal. / W.B. (single stem, tree form)
	CS	1	Catalpa speciosa	Northern Catalpa	70mm cal. / W.B.
	CA	1	Cornus alternifolia	Pagoda Dogwood	60mm cal. / W.B.
SHRUBS					
	Roh	27	Rosa rugosa 'Henry Hudson'	Henry Hudson Rose	#3 Pot / 100cm sp.
SHRUB AREAS					
241.3 m²					
alm	80	Alchemilla mollis	Lady's Mantle	#1 Pot / 50cm sp.	
ck	36	Cornus sericea 'Kelsey'	Kelsey's Dwarf Red Twig Dogwood	#1 Pot / 75cm sp.	
Hw	2	Hamamelis virginiana	Common Witch Hazel	#3 Pot / Refer to plan for spacing	
hvf	8	Hosta x 'Frances Williams'	Frances Williams Hosta	#3 Pot / 150cm sp.	
hoh	50	Hosta x 'Hudson Bay'	Hudson Bay Hosta	#1 Pot / 60cm sp.	
Hh	22	Hosta x 'Halcyon'	Halcyon Hosta	#2 Pot / 90cm sp.	
Hym	8	Hydrangea macrophylla 'Blushing Bride'	Endless Summer Blushing Bride Hydrangea	#3 pot / 150cm sp.	
HI	13	Hydrangea paniculata 'Limelight'	Limelight Panicle Hydrangea	#3 Pot / 125cm sp.	
mf	36	Monarda fistulosa	Bergamot	#1 Pot / 75cm sp.	
plf	9	Paeonia lactiflora	Chinese Peony	---	
pao	9	Papaver orientale 'Prince of Orange'	Oriental Poppy	---	
Roh	21	Rosa rugosa 'Henry Hudson'	Henry Hudson Rose	#3 Pot / 100cm sp.	
gem	101	Geranium maculatum	Spotted Geranium	#1 Pot / 45cm sp.	
26.8 m²					
acm	11	Achillea millefolium	Common Yarrow	#1 Pot / 30cm sp.	
adp	25	Adiantum pedatum	Northern Maidenhair Fern	#1 Pot / 30cm sp.	
eum	2	Eurybia macrophylla	Bigleaf Aster	#2 Pot / 90cm sp.	
pob	7	Polygonatum biflorum	Solomon's Seal	#1 Pot / 60cm sp.	
psa	10	Polystichum acrostichoides	Christmas Fern	#1 Pot / 45cm sp.	
Rht	2	Rhododendron tomentosum	Northern Labrador Tea	#3 Pot / 100cm sp.	
Sya	2	Symphoricarpos albus	Common Snowberry	#2 Pot / 75cm sp.	
tre	24	Trillium erectum	Purple Trillium	#1 Pot / 30cm sp.	
trg	24	Trillium grandiflorum	Large White Trillium	#1 Pot / 30cm sp.	
aru	34	Arctostaphylos uva-ursi	Kinnikinnick	4" pot / 25cm sp.	
-sdc	38	Cornus canadensis	Bunchberry Dogwood	plugs	
frv	106	Fragaria virginiana	Wild Strawberry	4" Pot / 15cm sp.	
89.5 m²					
ROADWAY (SALT TOLERANT)					
ang	24	Andropogon gerardii	Big Bluestem	#1 Pot / 75cm sp.	
caa	7	Calamagrostis x acutiflora 'Karl Foerster'	Karl Foerster Feather Reed Grass	#1 Pot / 60cm sp.	
Ho	36	Hosta x 'Stella de Oro'	Stella de Oro Daylily	#1 Pot / Refer to plan for spacing	
Rhg	9	Rhus aromatica 'Gro-Low'	Gro-Low Fragrant Sumac	#1 Pot / 90cm sp.	
Ror	14	Rosa rugosa	Rugosa Rose	#2 Pot / 90cm sp.	
Roh	14	Rosa rugosa 'Henry Hudson'	Henry Hudson Rose	#3 Pot / 100cm sp.	
Sji	14	Spiraea japonica 'Goldflame'	Goldflame Japanese Spirea	#2 Pot / 100cm sp.	
507.8 m²					
REFORESTATION (TREES & SHRUBS)					
AR		Acer rubrum	Red Maple	70mm cal. / W.B.	
-AH	1	Aesculus hippocastanum (whip stock)	European Horsechestnut	whip stock	
-CS	1	Catalpa speciosa (whip stock)	Northern Catalpa	whip stock	
CA	1	Cornus alternifolia	Pagoda Dogwood	60mm cal. / W.B.	
-CA	1	Cornus alternifolia	Pagoda Dogwood	#7 pot / 100cm	
-GB	1	Ginkgo biloba (whip stock)	Maidenhair Tree	whip stock	
-OV	1	Ostrya virginiana (whip stock)	American Hophornbeam	whip stock	
PR	1	Pinus resinosa	Red Pine	120cm ht. / W.B.	
-PR	1	Pinus resinosa (whip stock)	Red Pine	whip stock	
PS	1	Pinus strobus	White Pine	120cm ht. / W.B.	
-PS	1	Pinus strobus (whip stock)	White Pine	whip stock	
-QM	1	Quercus macrocarpa (whip stock)	Burr Oak	whip stock	
-TH	2	Thuja occidentalis	Eastern White Cedar	field dug clump	
TH	2	Thuja occidentalis	Eastern White Cedar	120cm ht. / W.B.	
Cos	6	Cornus sericea	Red Twig Dogwood	#3 Pot / 200cm sp.	
Cof	6	Cornus sericea 'Flaviramea'	Yellow Twig Dogwood	#3 Pot / 200cm sp.	
Sya	25	Symphoricarpos albus	Common Snowberry	#2 Pot / 75cm sp.	

NOTE: LAYOUT OF MATERIAL TO BE APPROVED BY LANDSCAPE ARCHITECT PRIOR TO INSTALLATION.

	35.9 m²	BUILDING (SALT TOLERANT)		
acm	26	Achillea millefolium	Common Yarrow	#1 Pot / 30cm sp.
alm	21	Alchemilla mollis	Lady's Mantle	#1 Pot / 50cm sp.
ast	33	Asclepias tuberosa	Butterfly Milkweed	#1 Pot / 30cm sp.
caa	2	Calamagrostis x acutiflora 'Karl Foerster'	Karl Foerster Feather Reed Grass	---
gaa	2	Gaillardia aristata	Blanket Flower	---
Rhg	4	Rhus aromatica 'Gro-Low'	Gro-Low Fragrant Sumac	#1 Pot / Refer to plan for spacing
Sji	5	Spiraea japonica 'Goldflame'	Goldflame Japanese Spirea	#2 Pot / 100cm sp.
REFORESTATION (GROUND COVER)				
-aqc	967	Aquilegia canadensis 'Pink Lanterns'	Pink Lanterns Eastern Columbine	plugs
-poa	967	Polystichum acrostichoides	Christmas Fern	plugs
-asc	2,176	Asarum canadense	Wild Ginger	plugs
-doc	2,176	Cornus canadensis	Bunchberry Dogwood	plugs
73.7 m²				
EAST + SOUTH MARKET BUILDING				
caa	4	Calamagrostis x acutiflora 'Karl Foerster'	Karl Foerster Feather Reed Grass	---
CI	6	Cornus sericea 'Farrow'	Arctic Fire® Red Twig Dogwood	#3 Pot / 125cm sp.
ecp	50	Echinacea purpurea	Coneflower	#1 Pot / 45cm sp.
Hh	14	Hosta x 'Halcyon'	Halcyon Hosta	#2 Pot / 90cm sp.
mf	19	Monarda fistulosa	Bergamot	#1 Pot / 75cm sp.
ruh	29	Rudbeckia hirta	Black-eyed Susan	#1 Pot / 60cm sp.
Sji	10	Spiraea japonica 'Goldflame'	Goldflame Japanese Spirea	#2 Pot / 100cm sp.
GROUND COVERS				
	59.7 m²	TURFGRASS WITH SWM STORAGE		

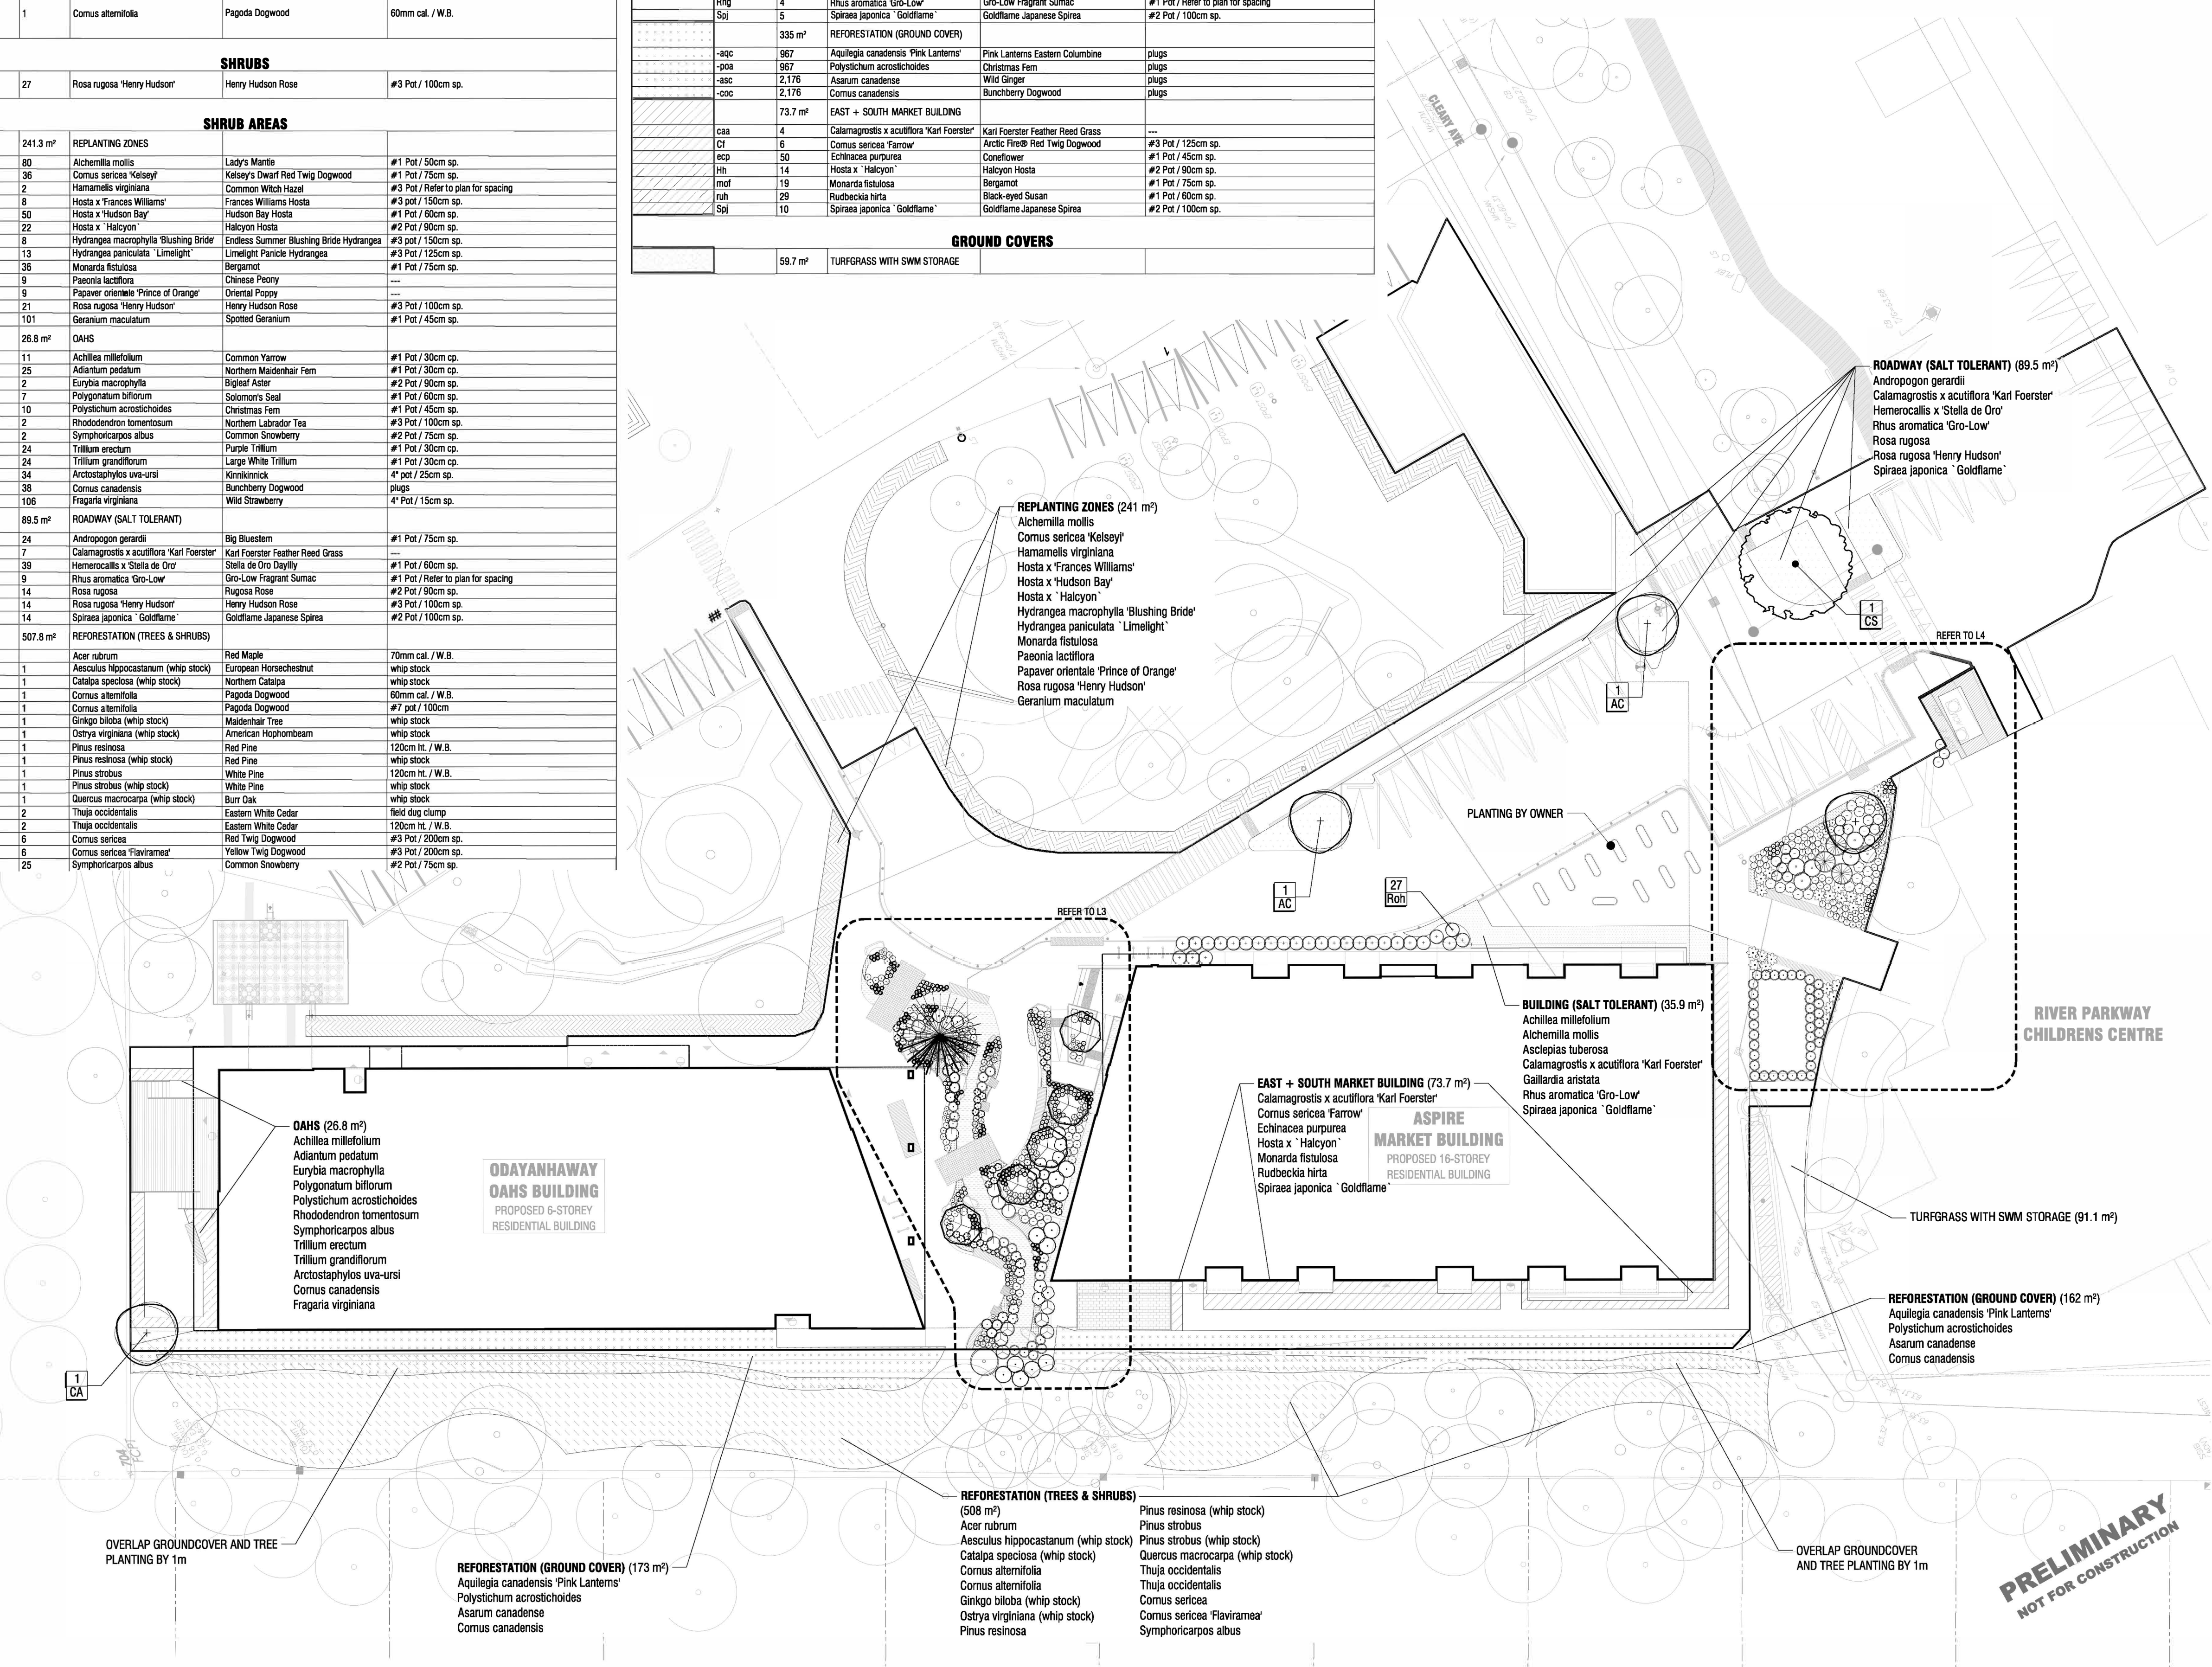

Copyright Reserved
The Copyrights to all designs and drawings are the property of Fotenn Consultants Inc. Unauthorized reproduction or use is prohibited. DO NOT SCALE DRAWING


Copyright réservés
Les droits d'auteur à tous les modèles et dessins sont la propriété de Fotenn Consultants Inc.
Reproduction ou utilisation non autorisée est interdite. NE PAS L'ÉCHELLE DE DESSIN

Client / Client




key plan / plan repère

legend / légende

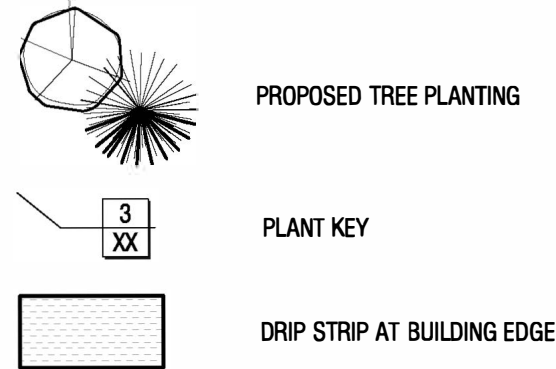

02	issue for SPA	2025/11/25
01	issue for coordination	2025/05/16
00	issue for coordination	2025/04/15
rev'n	description / la description	yyyy/mth/dd

FOTENN Planning + Design
420 O'Connor Street
Ottawa, ON, CANADA K2P 1W4
613.730.5709
fotenn.com

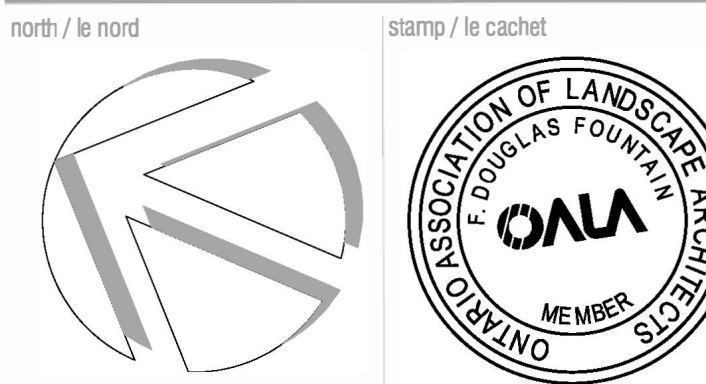

project / projet

30 CLEARY AVENUE


drawing / dessin

PLANTING PLAN

designed / conçu BM EM	drawn / dessiné BM EM	reviewed / examiné DF
date 2023/07/14	project number / No. du projet 23002	

drawing number / No. du dessin

L2

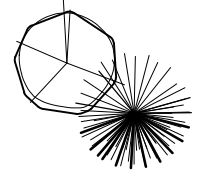

PLANT KEY



DRIP STRIP AT BUILDING EDGE

PRELIMINARY
NOT FOR CONSTRUCTION

1	ENTRY PLAZA PLANTING PLAN
L3	1:75

PLOT INFORMATION: DWG NAME: F:\PROJECTS\13000\13000-01\13000-01.dwg PLOT DATE: 2025-11-26 4:10:00 PM PLOT SIZE: 500mm x 500mm PLOTED BY: Suzanne Mitchell LAST SAVED BY: bmbd01



1 DAYCARE PLANTING PLAN
 L4 1:75

PLANT SCHEDULE DAYCARE				
CODE	QTY	BOTANICAL NAME	COMMON NAME	SIZE / CONDITION / SPACING
DECIDUOUS TREES				
AC	1	Amelanchier canadensis	Canadian Serviceberry	50mm cal. / W.B. (single stem, tree form)
SHRUBS				
Ck	18	Comus sericea 'Kelsey'	Kelsey's Dwarf Red Twig Dogwood	#1 Pot / 75cm sp.
Hi	6	Hydrangea paniculata 'Limelight'	Limelight Panicle Hydrangea	#3 Pot / 125cm sp.
Jm	3	Juniperus chinensis 'Mint Julep'	Mint Julep Juniper	#3 Pot / 150cm sp.
PERENNIALS & GRASSES				
acm	32	Achilles millefolium	Common Yarrow	#1 Pot / 30cm sp.
alm	22	Alchemilla mollis	Lady's Mantle	#1 Pot / 50cm sp.
ang	39	Andropogon gerardii	Big Bluestem	#1 Pot / 75cm sp.
ecp	28	Echinacea purpurea	Coneflower	#1 Pot / 45cm sp.
her	31	Heuchera richardsonii	Prairie Alum Root	#1 Pot / 30cm sp.
Hh	23	Hosta x 'Halcyon'	Halcyon Hosta	#2 Pot / 90cm sp.
mot	16	Monarda fistulosa	Bergamot	#1 Pot / 75cm sp.
GROUND COVERS				
frv	144	Fragaria virginiana	Wild Strawberry	4" Pot / 15cm sp.
gem	85	Geranium maculatum	Spotted Geranium	#1 Pot / 45cm sp.


Copyright Reserved
 The Copyrights to all designs and drawings are the property of Fotenn Consultants Inc. Unauthorized reproduction or use is forbidden. DO NOT SCALE DRAWING
 Copyright réservés
 Les droits d'auteur à tous les modèles et dessins sont la propriété de Fotenn Consultants Inc. Reproduction ou utilisation non autorisée est interdite. NE PAS L'ÉCHELLE DE DESSIN

Client / Client




key plan / plan repère


legend / légende

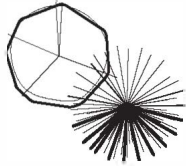

PROPOSED TREE PLANTING

 

PLANT KEY

 

DRIP STRIP AT BUILDING EDGE


02	issue for SPA	2025/11/25
01	issue for coordination	2025/05/16
00	issue for coordination	2025/04/15
rev'n	description / la description	yyyy/mm/dd

FOTENN
Planning + Design

420 O'Connor Street
 Ottawa, ON, CANADA K2P 1W4

613.730.5709
 fotenn.com

north / le nord

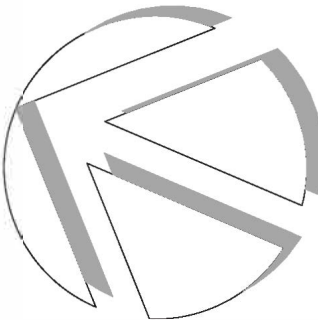

stamp / le cachet



project / projet

30 CLEARY AVENUE

drawing / dessin


DAYCARE ENTRY
 PLANTING PLAN

designed / conçu BM EM	drawn / dessiné BM EM	reviewed / examiné DF
date 2023/07/14	project number / No. du projet 23002	

drawing number / No. du dessin

L4


PRELIMINARY
 NOT FOR CONSTRUCTION

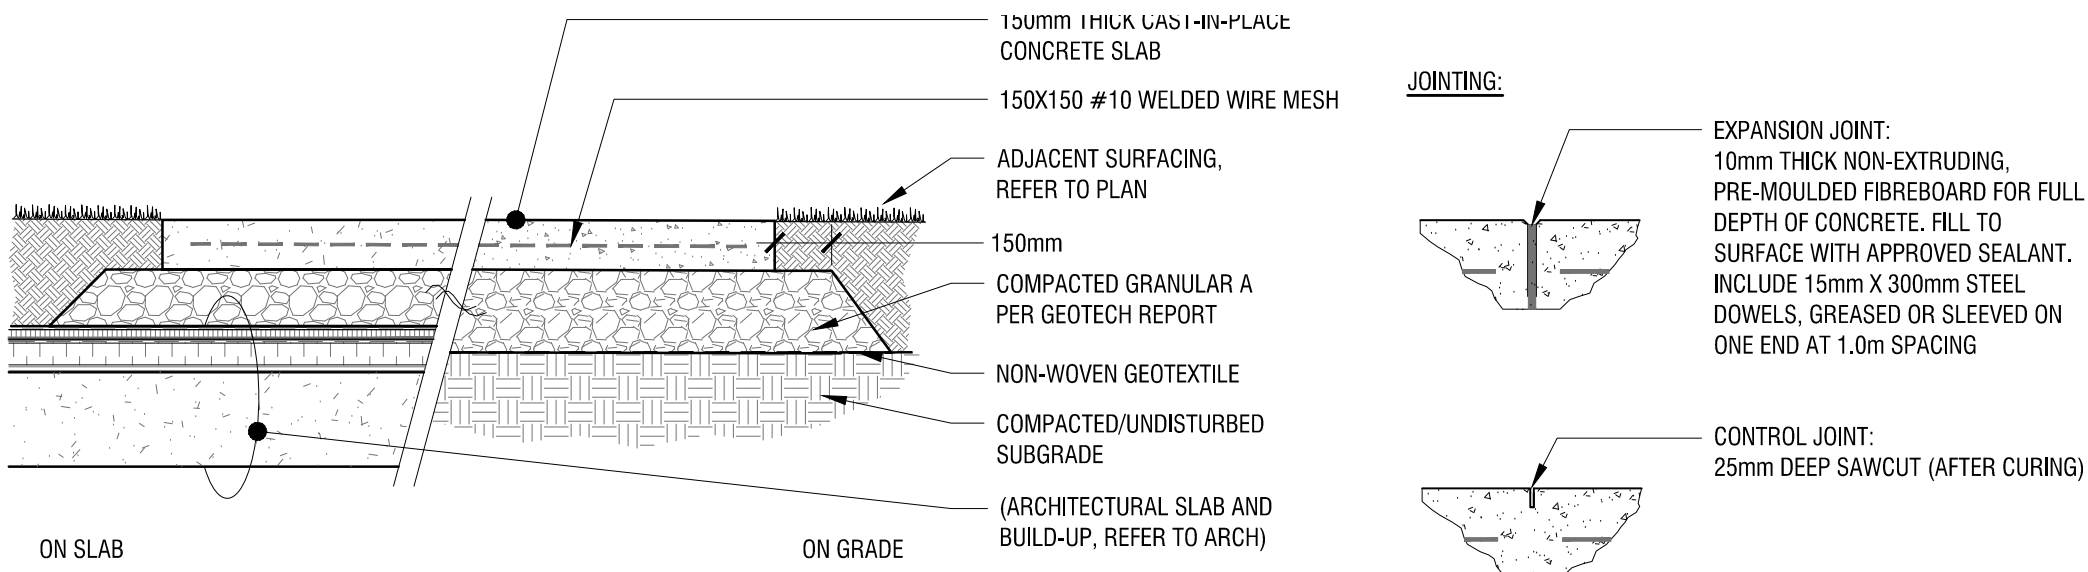

- NOTES:
- CONCRETE TO BE 32MPa WITH 5-7% AIR ENTRAINMENT AND LIGHT BROOM FINISH;
 - EXPANSION JOINTS: 13mm THICK BITUMINOUS FIBRE BOARD WITH 300mm, 10m DOWELS @ 600mm O.C., GREASED OR SLEEVED ON ONE END;
 - SAW-CUT JOINTS: TO 10mm DEPTH;
 - SEE PLAN FOR JOINTING LAYOUT. LAYOUT TO BE REVIEWED AND CONFIRMED BY LANDSCAPE ARCHITECT PRIOR TO CONCRETE POUR;
 - CONCRETE MIX AND INSTALLATION, AS PER SPECIFICATIONS;
 - CONCRETE FINISH PER SPECIFICATIONS;
 - COORDINATE INSTALLATION OF DRAINAGE, MECHANICAL, ELECTRICAL SCOPE AND COMPONENTS AS REQUIRED.

1 HD CONCRETE PAVING DETAIL


L5 N.T.S.

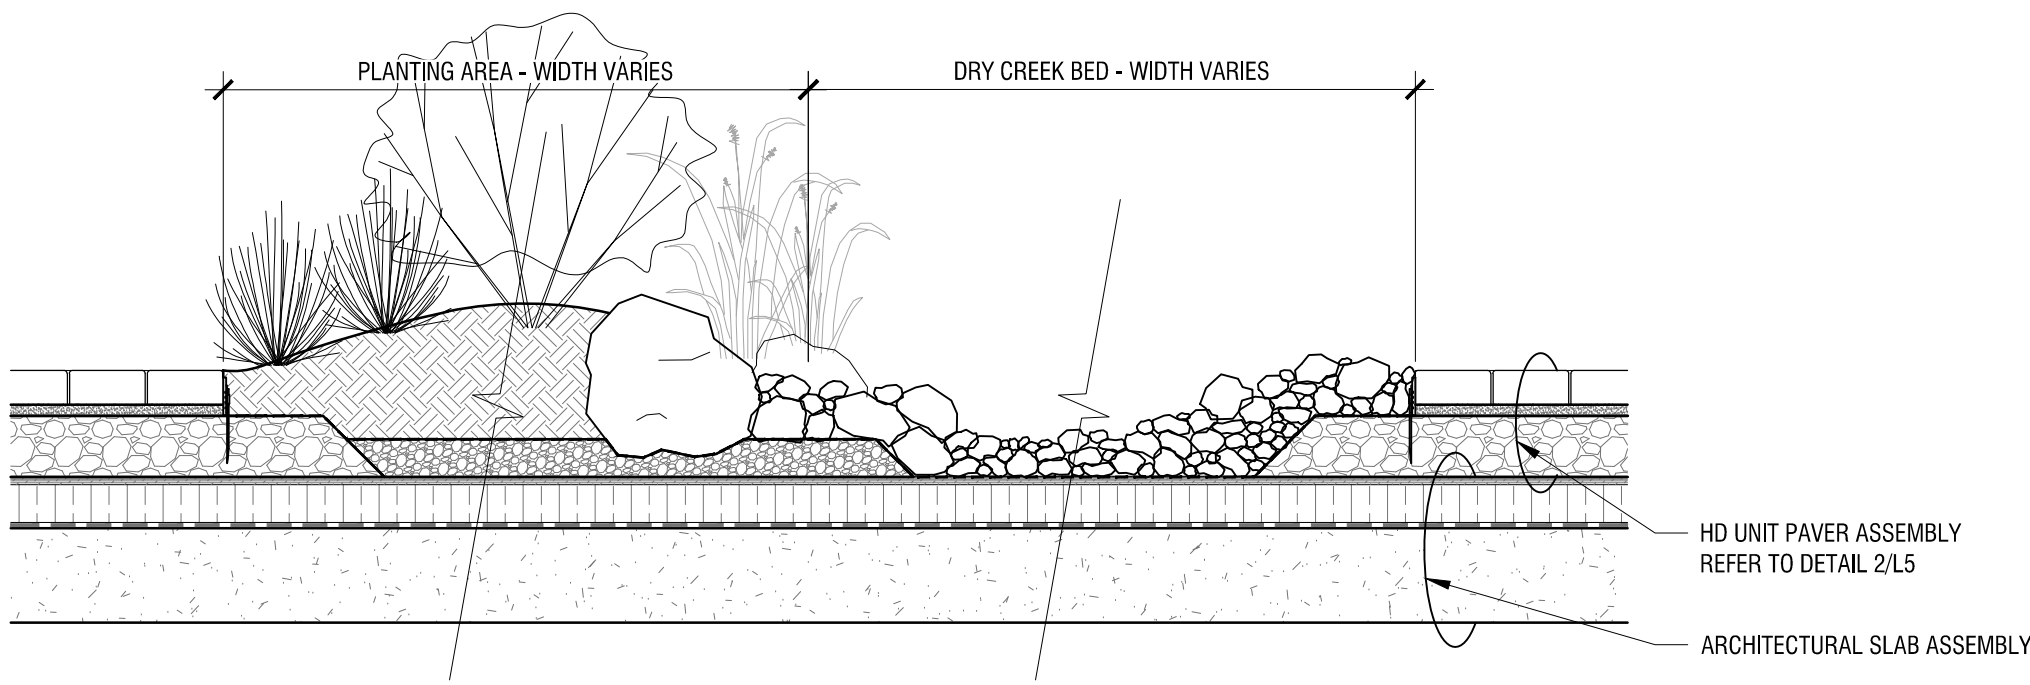

- NOTES:
- DRY CREEK BED SECTION VARIES. REFER TO PLAN FOR EXTENTS OF PLANTING AT EDGES OF DRY CREEK BED;
 - GENERAL NOTES ON ROCK AND BOULDER PLACEMENT:
 - SIZE 1 - FEATURE BOULDERS 750mm-2000mm IN DIA. TO BE PLACED AS SHOWN ON LANDSCAPE PLAN. FEATURE BOULDERS MUST BE REVIEWED AND ACCEPTED BY LANDSCAPE ARCHITECT PRIOR TO INSTALLATION.
 - SIZE 2 - BOULDERS 500mm-1000mm IN DIA. TO BE USED AT PLANTING EDGES TO RETAIN SOIL VOLUME;
 - SIZE 3 - BOULDERS 300mm-500mm IN DIA. TO BE USED AS CREEK BED FEATURES. TO BE PLACED PRIMARILY AT BED EDGES WITH OCCASIONAL PLACEMENT IN 'STREAM'.
 - SIZE 4 - ROCKS 150mm-300mm IN DIA. TO BE PLACED PRIMARILY AT CREEK EDGES BETWEEN SIZE 3 BOULDERS;
 - SIZE 5 - ROCKS 50mm-150mm IN DIA. TO FORM BASE OF DRY CREEK BED;
 - ALL ROCK AND BOULDER PLACEMENT IS TO BE REVIEWED ON SITE WITH LANDSCAPE ARCHITECT PRIOR TO INSTALLATION.

4 DRY CREEK BED DETAIL


L5 N.T.S.

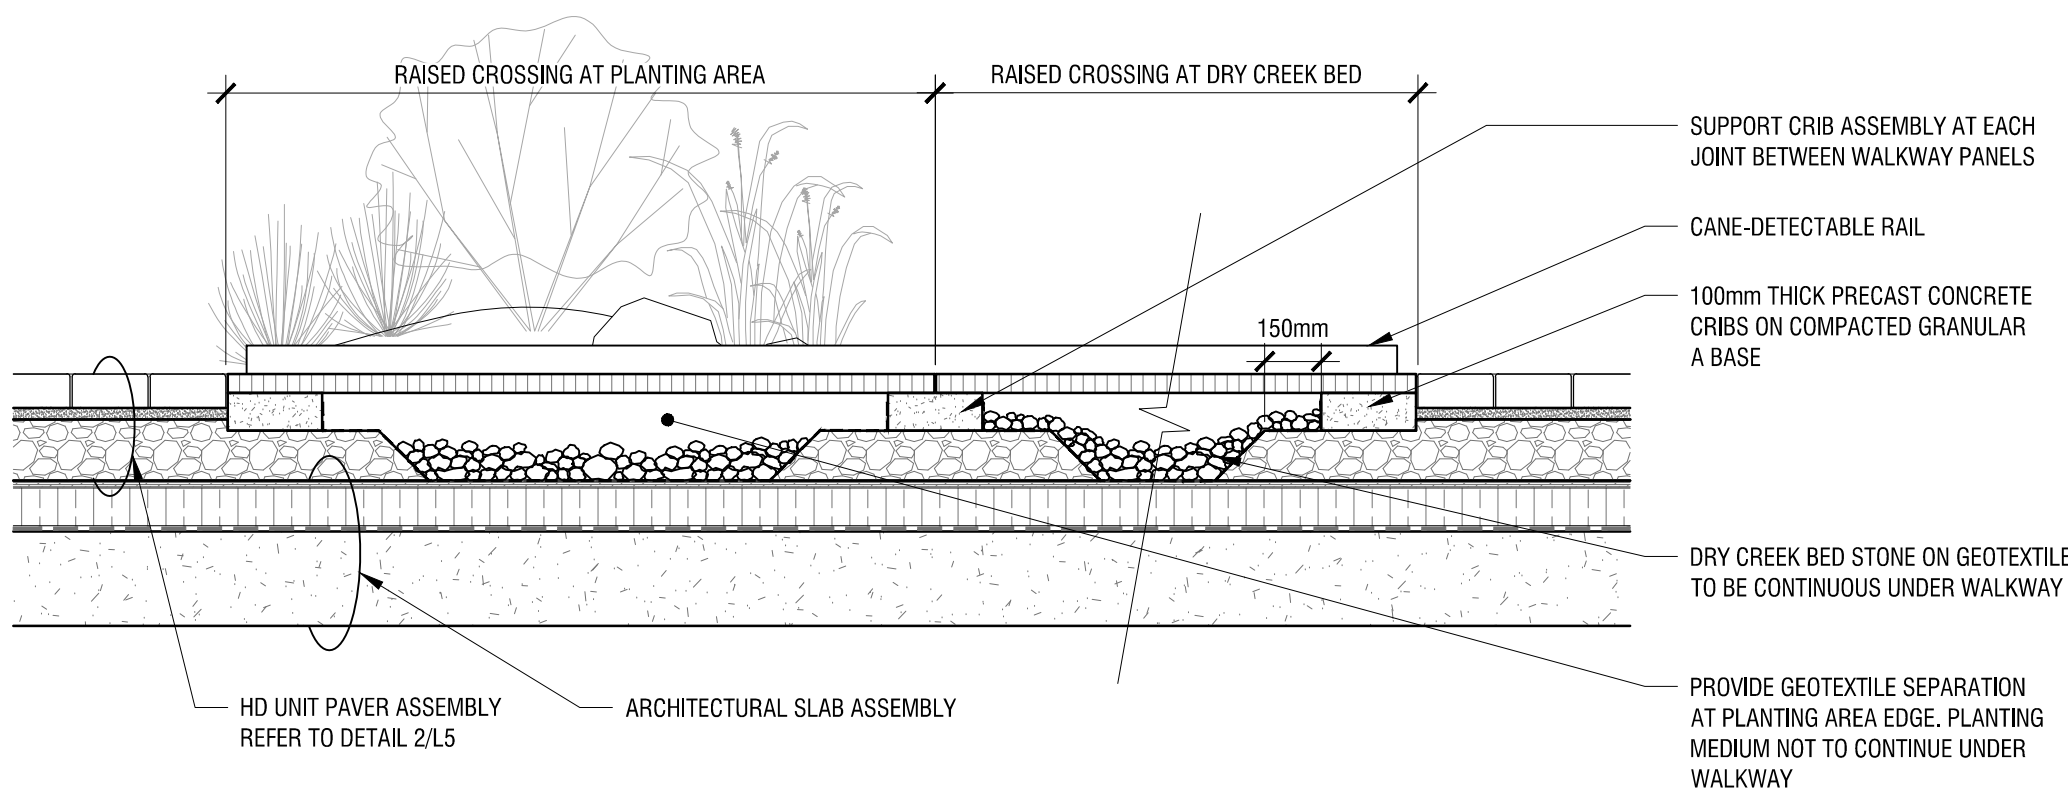

- NOTES:
- STEEL BAR GRATE PRODUCT TO BE CLASS C LOAD RATED;
 - STEEL BAR GRATE TO HAVE SERRATED FINISH FOR SLIP RESISTANCE.

7 RAISED CROSSING AT DRY CREEK BED DETAIL


L5 N.T.S.

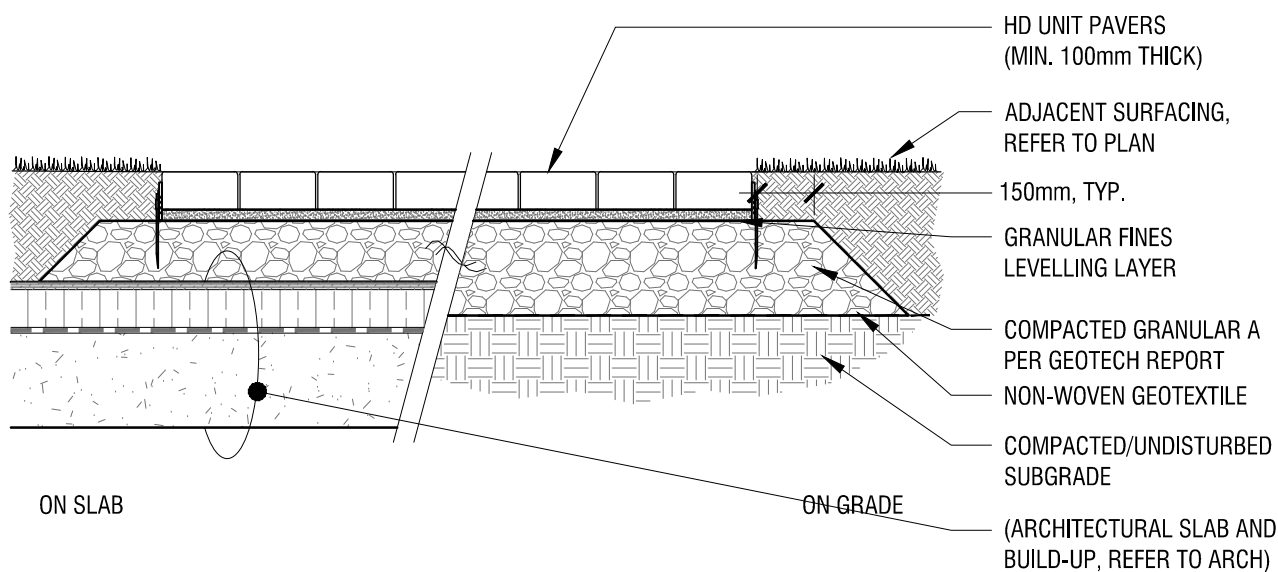

- NOTES:
- HEAVY DUTY/TRAFFIC RATE UNIT PAVERS. REFER TO SPECIFICATIONS;
 - JOINTING TYPE A - STANDARD. JOINTING TYPE B - PERMEABLE. REFER TO SPECIFICATIONS;
 - REFER TO LANDSCAPE PLAN FOR EXTENT AND TYPE OF UNIT PAVERS. LAYOUT TO BE REVIEWED AND CONFIRMED BY LANDSCAPE ARCHITECT PRIOR TO INSTALLATION;
 - COORDINATE INSTALLATION OF DRAINAGE, MECHANICAL, ELECTRICAL SCOPE AND COMPONENTS AS REQUIRED.

2 HD UNIT PAVER DETAIL


L5 N.T.S.

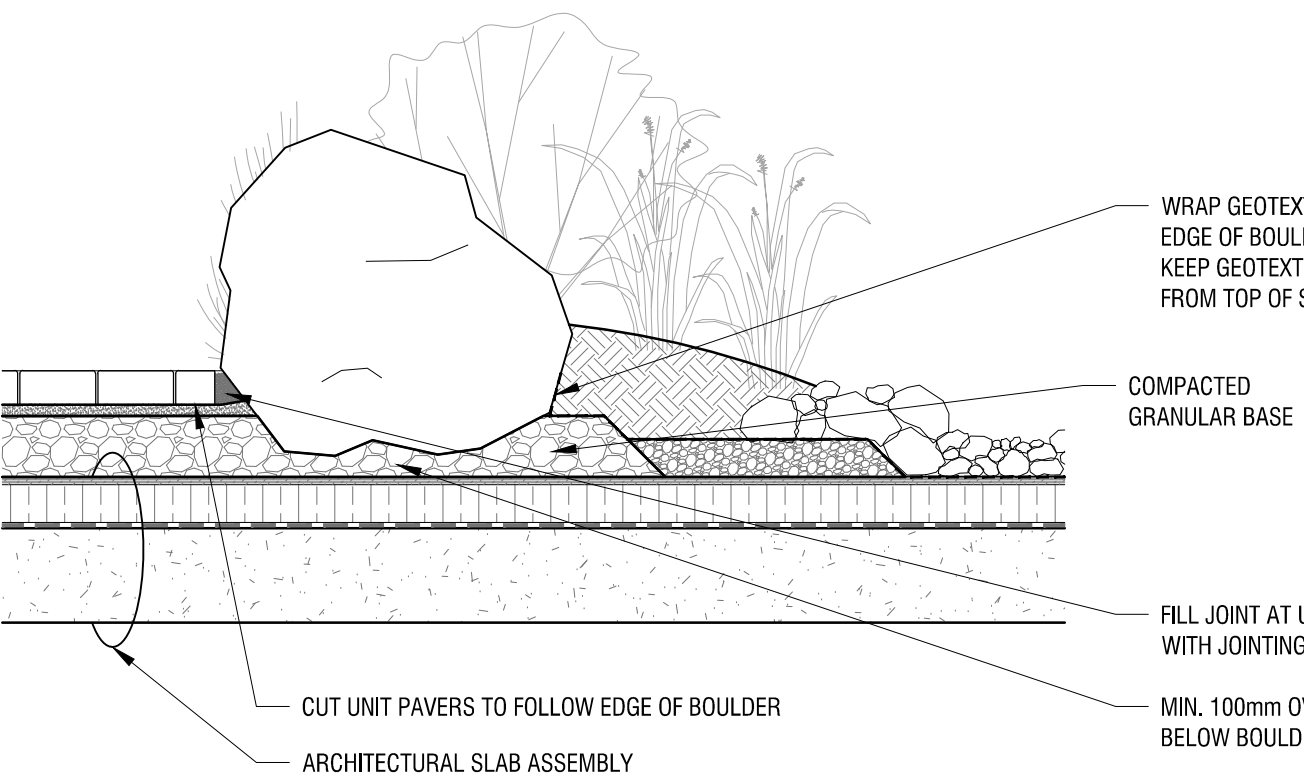

- NOTES:
- ALL BOULDER PLACEMENT TO BE REVIEWED ON SITE WITH LANDSCAPE ARCHITECT PRIOR TO INSTALLATION;
 - POSITION BOULDER WITH BOTTOM 1/3 BELOW FINISHED GRADE;
 - WHEN BURIAL OF BOTTOM 1/3 OF BOULDER CANNOT BE ACHIEVED DUE TO LIMITED DEPTH BETWEEN FINISHED GRADE AND SLAB, POSITION BOULDER SUCH THAT THE BOULDER WIDTH IS GREATER THAN THE OVERALL DEPTH;
 - CUT UNIT PAVERS ALONG EDGE OF BOULDER TO MATCH JOINTING WIDTH OF UNIT PAVER ASSEMBLY +/- 10mm.

5 BOULDER DETAIL


L5 N.T.S.

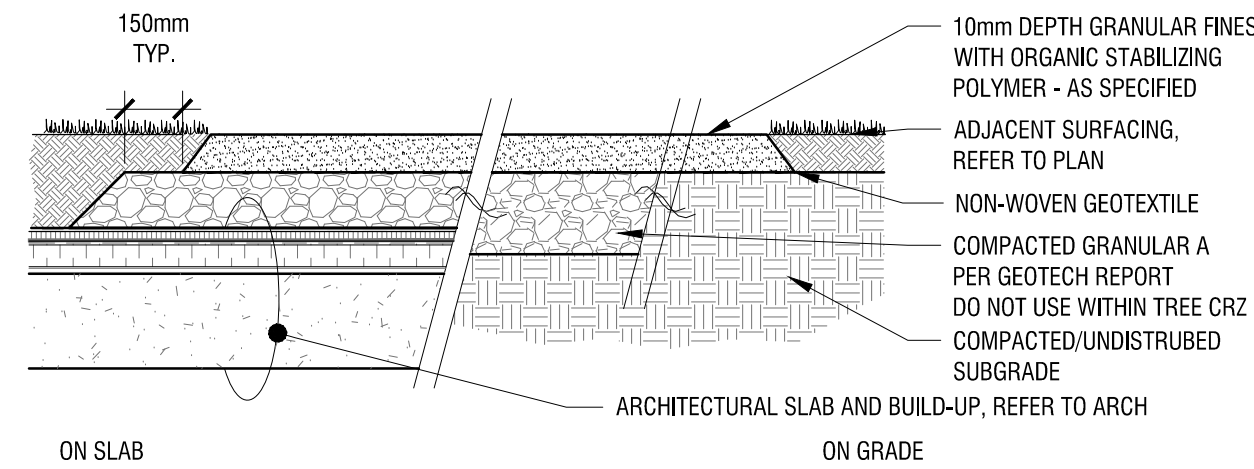

- NOTES:
- MAXIMUM 1% CROSS-SLOPE;
 - PROVIDE MINIMUM 150mm GRANULAR BASE FOR PATHWAY IN ALL AREAS OUTSIDE OF TREE CRZ;
 - FOR PATHWAY SECTIONS WITHIN CRZ:
 - REMOVE 100mm OF TOP LAYER OF ORGANICS AND COMPACT SUBGRADE. NO GRANULAR BASE TO BE USED. APPLY STONE DUST PATHWAY DIRECTLY ON COMPACTED SUBGRADE;
 - ALL EXCAVATION TO BE COMPLETED BY HAND AND UNDER THE SUPERVISION OF THE PROJECT ARBORIST.

3 STABILIZED GRANULAR PATHWAY DETAIL

L5 N.T.S.

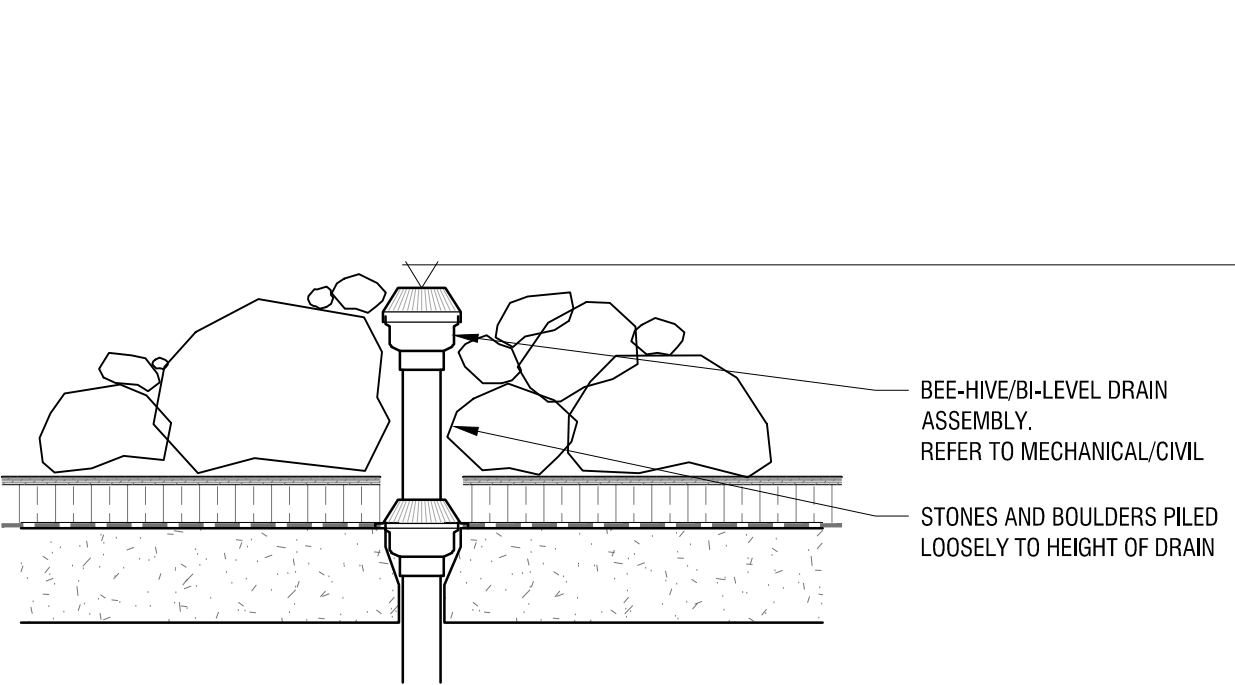

- NOTES:
- COORDINATE INSTALLATION OF DRAINAGE AND COMPONENTS AS REQUIRED;
 - REFER TO CIVIL FOR GRADING INFORMATION;
 - ALL ROCK AND BOULDER PLACEMENT IS TO BE REVIEWED ON SITE WITH LANDSCAPE ARCHITECT PRIOR TO INSTALLATION

6 ROCK PLACEMENT AT DRY CREEK DRAINAGE

L5 N.T.S.

Copyright Reserved
The Copyright to all designs and drawings are the property of Fotenn Consultants Inc. Unauthorized reproduction or use is forbidden. DO NOT SCALE DRAWING

Copyright réservés
Les droits d'auteur à tous les modèles et dessins sont la propriété de Fotenn Consultants Inc. Reproduction ou utilisation non autorisée est interdite. NE PAS L'ÉCHELLE DE DESSIN

Client / Client



key plan / plan repère

legend / légende

rev'n	description / la description	yyyy/mm/dd
02	issue for SPA	2025/11/25
01	issue for coordination	2025/05/16
00	issue for coordination	2025/04/07

FOTENN Planning + Design
420 O'Connor Street
Ottawa, ON, CANADA K2P 1W4
613.730.5709
fotenn.com

north / le nord

stamp / le cachet



project / projet

30 CLEARY AVENUE

drawing / dessin


LANDSCAPE CONSTRUCTION DETAILS

designed / conçu BM EM	drawn / dessiné BM EM	reviewed / examiné DF
date 2023/07/14	project number / No. du projet 23002	

drawing number / No. du dessin

L5


PRELIMINARY
NOT FOR CONSTRUCTION

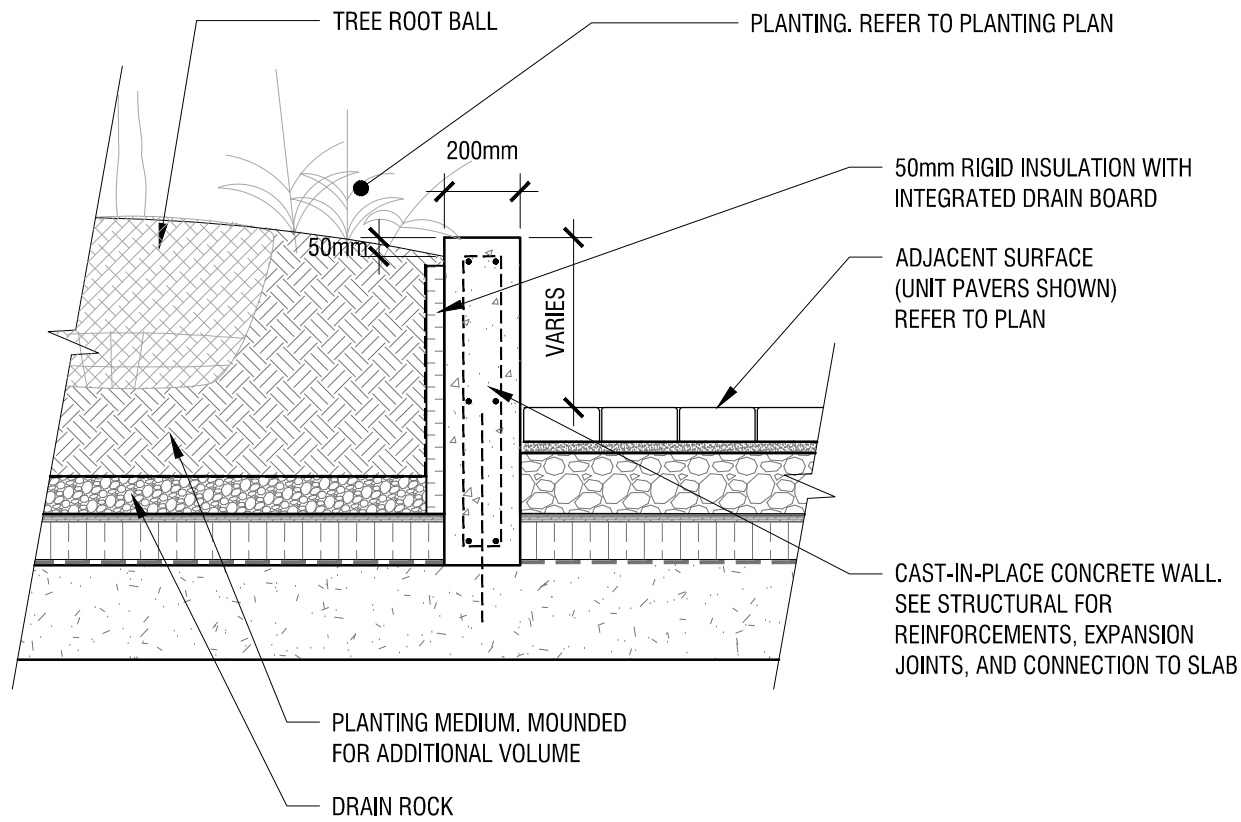

NOTES:

- CONCRETE TO BE CSA 32MPa CLASS C2, WITH 5-8% AIR ENTRAINMENT. SLUMP SHALL BE LESS THAN 90mm;
- BOARD FORM FINISH ON VERTICAL FACES
- TOP EDGES TO RECEIVE 10mm TOOLED RADIUS


1 LANDSCAPE SITE WALL DETAIL
L6 N.T.S.

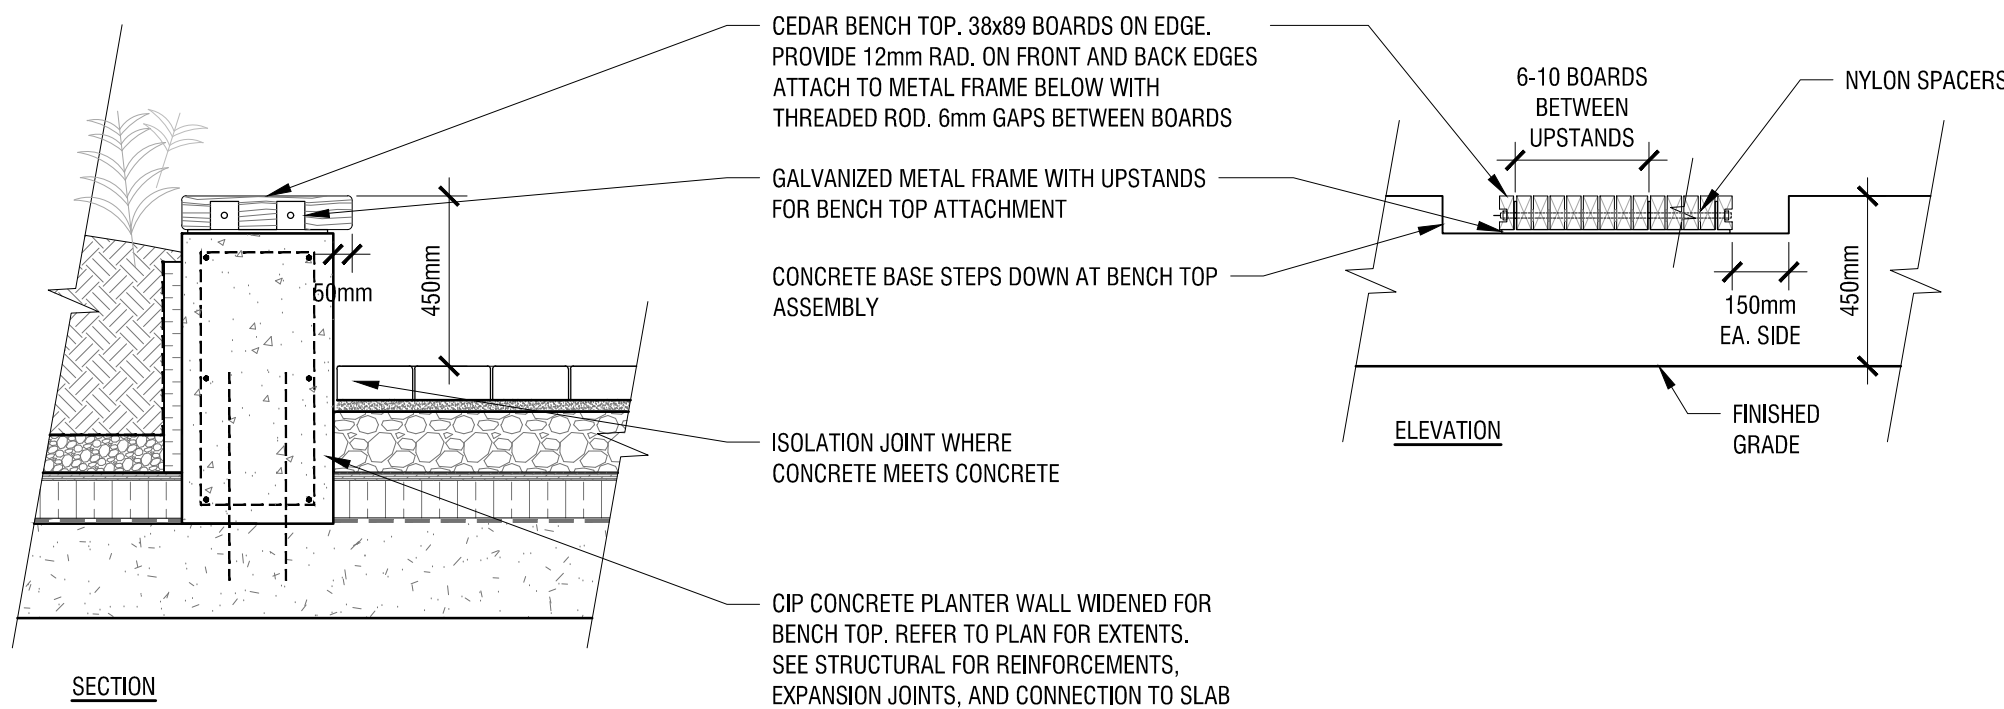

NOTES:

- CONCRETE TO BE CSA 32MPa CLASS C2, WITH 5-8% AIR ENTRAINMENT. SLUMP SHALL BE LESS THAN 90mm;
- BOARD FORM FINISH ON VERTICAL FACES
- TOP EDGES TO RECEIVE 10mm TOOLED RADIUS


2 BENCH TOP ON LANDSCAPE WALL
L6 N.T.S.

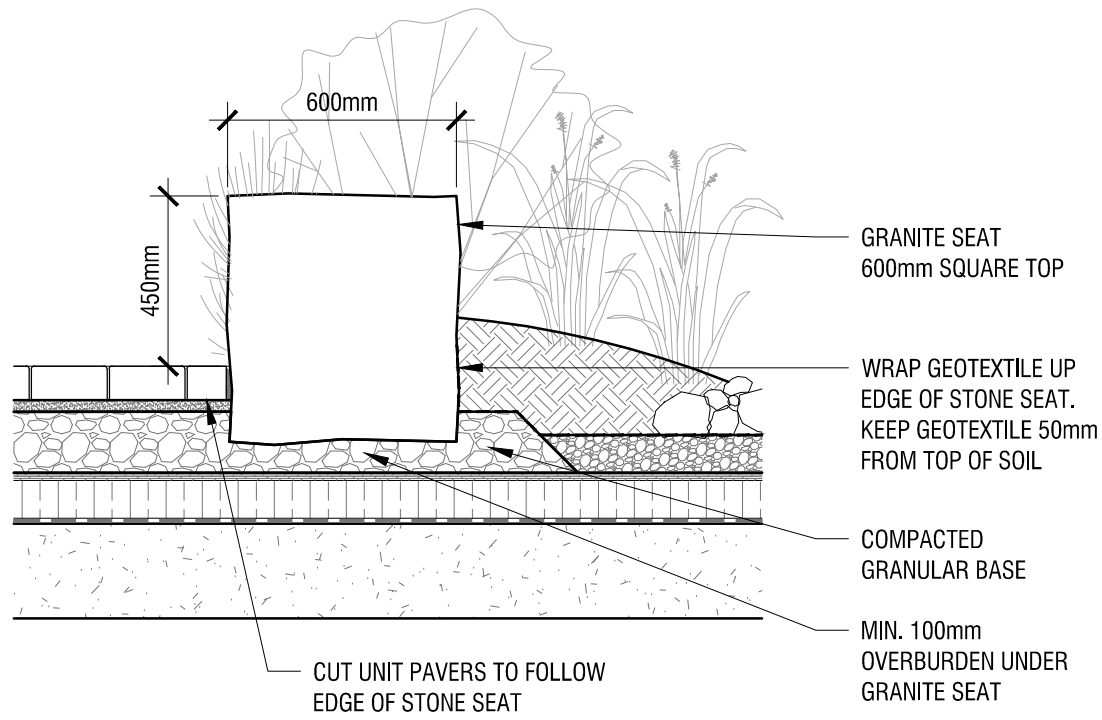


NOTES:

- PLACEMENT OF STONE SEATS TO BE REVIEWED ON SITE WITH LANDSCAPE ARCHITECT PRIOR TO INSTALLATION;
- POSITION STONE SEAT WITH MINIMUM OF BOTTOM 1/3 BELOW FINISHED GRADE;
- WHEN BURIAL OF BOTTOM 1/3 OF SEAT CANNOT BE ACHIEVED DUE TO LIMITED DEPTH BETWEEN FINISHED GRADE AND SLAB, STONE SEAT TO BE GROUTED IN PLACE;
- CUT UNIT PAVERS ALONG EDGE OF STONE SEAT TO MATCH JOINTING WIDTH OF UNIT PAVEMENT ASSEMBLY +/- 10mm.

3 GRANITE SEAT DETAIL
L6 N.T.S.

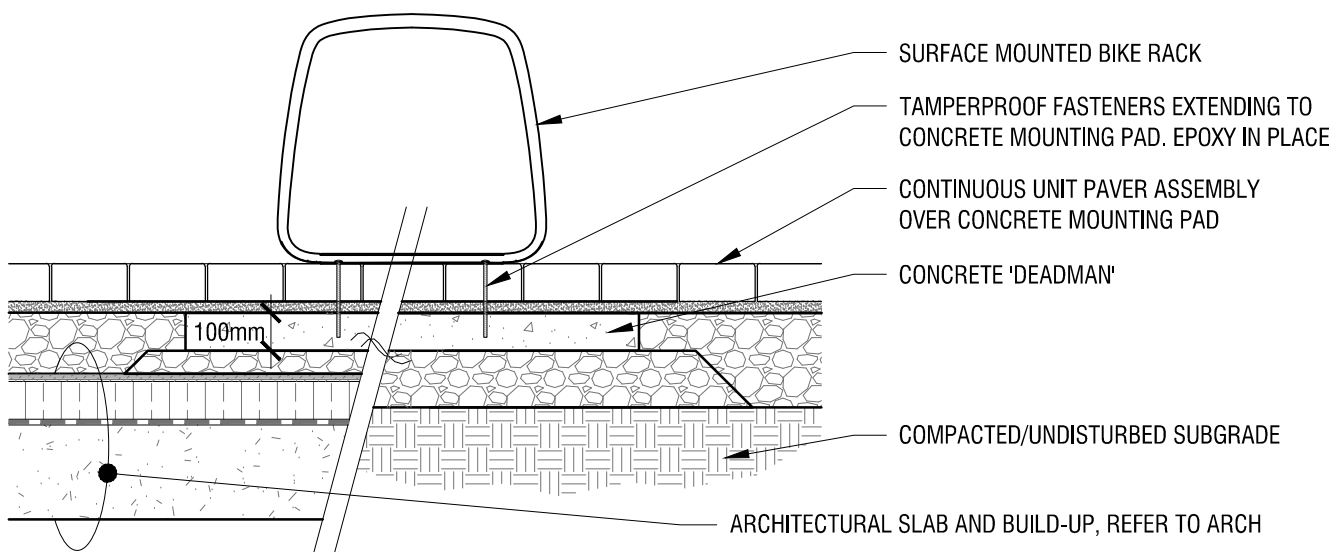

4 BIKE RACK
L6 N.T.S.

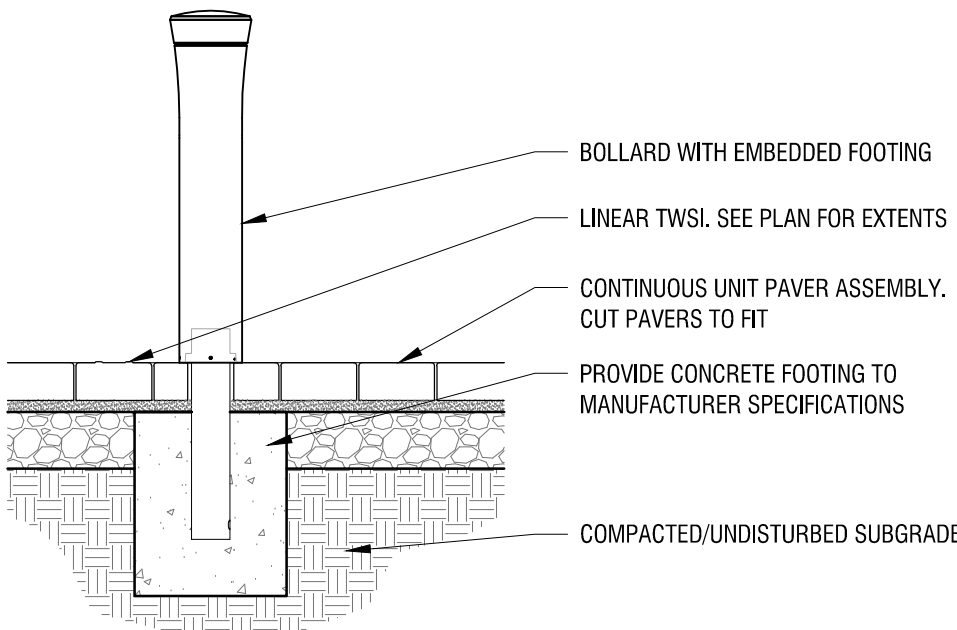

5 BOLLARD
L6 N.T.S.

PRELIMINARY
NOT FOR CONSTRUCTION

Copyright Reserved
The Copyrights to all designs and drawings are the property of Fotenn Consultants Inc. Unauthorized reproduction or use is forbidden. DO NOT SCALE DRAWING

Copyright réservés
Les droits d'auteur à tous les modèles et dessins sont la propriété de Fotenn Consultants Inc. Reproduction ou utilisation non autorisée est interdite. NE PAS L'ÉCHELLE DE DESSIN

Client / Client



key plan / plan repère

legend / légende

rev'n	description / la description	yyyy/mm/dd
02	issue for SPA	2025/11/25
01	issue for coordination	2025/05/16
00	issue for coordination	2025/04/07

FOTENN Planning + Design
420 O'Connor Street
Ottawa, ON, CANADA K2P 1W4
613.730.5709
fotenn.com

north / le nord

stamp / le cachet



project / projet

30 CLEARY AVENUE


drawing / dessin

LANDSCAPE CONSTRUCTION
DETAILS


designed / conçu BM EM	drawn / dessiné BM EM	reviewed / examiné DF
date 2023/07/14	project number / No. du projet 23002	

drawing number / No. du dessin


L6

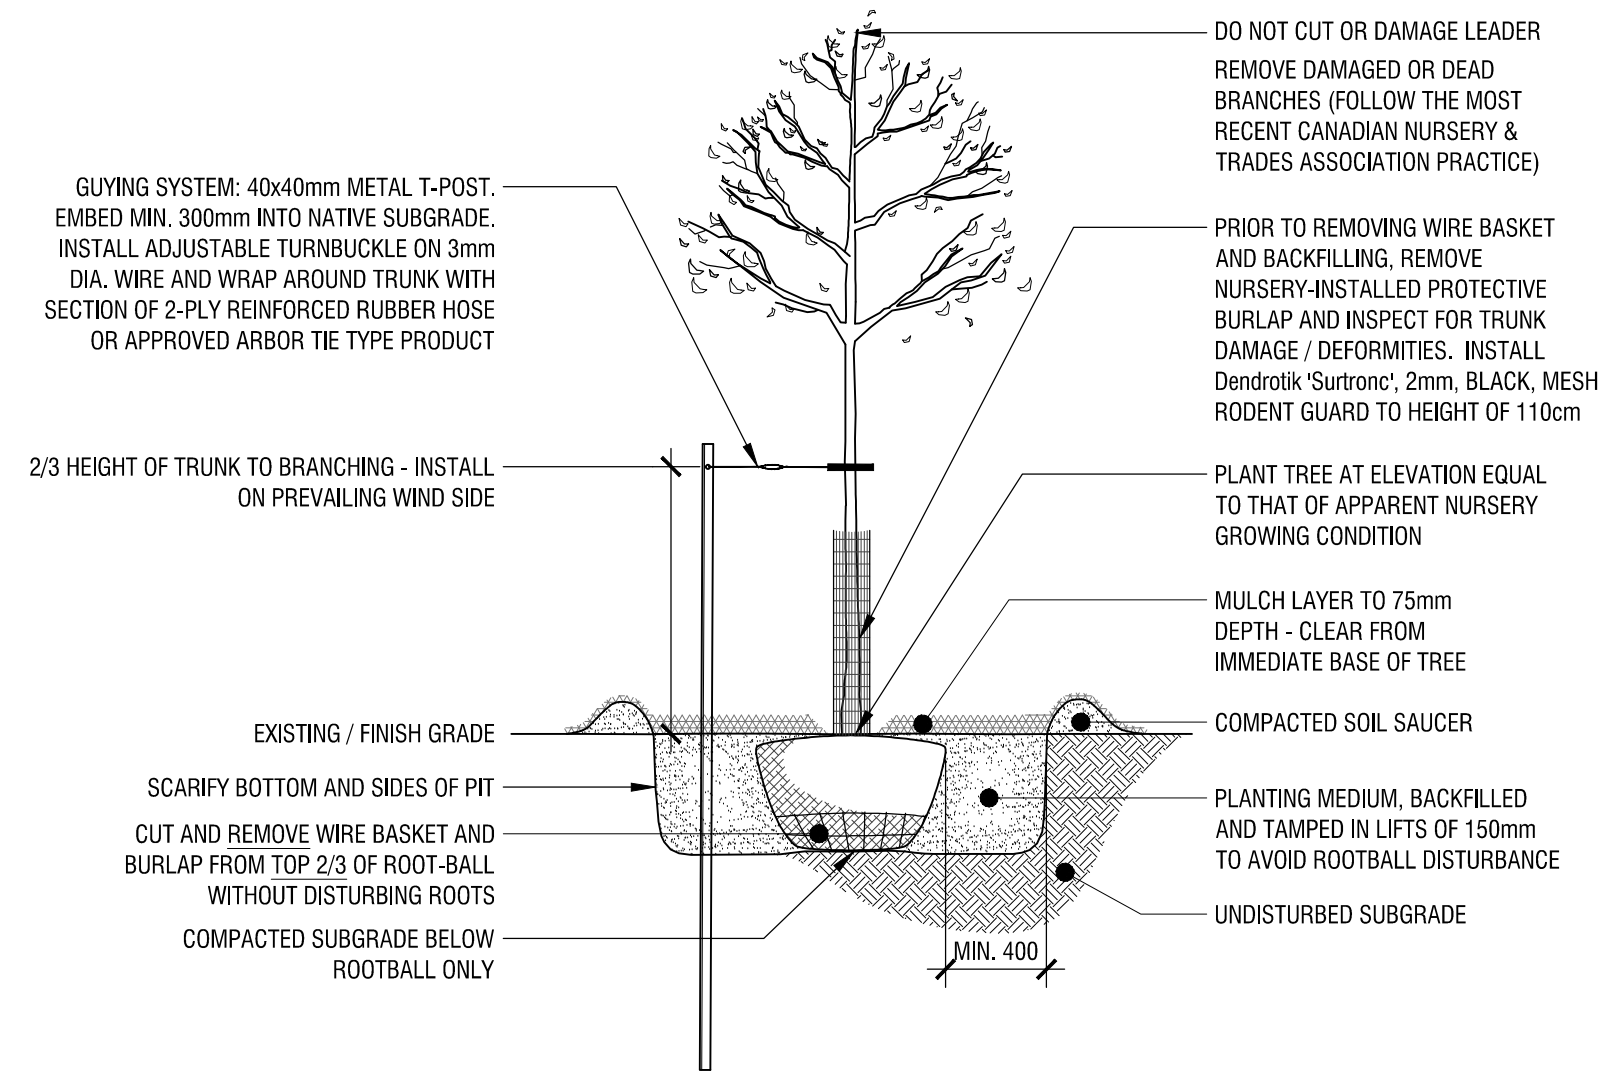


1 **DECIDUOUS PLANTING DETAIL**
L7 **N.T.S.**

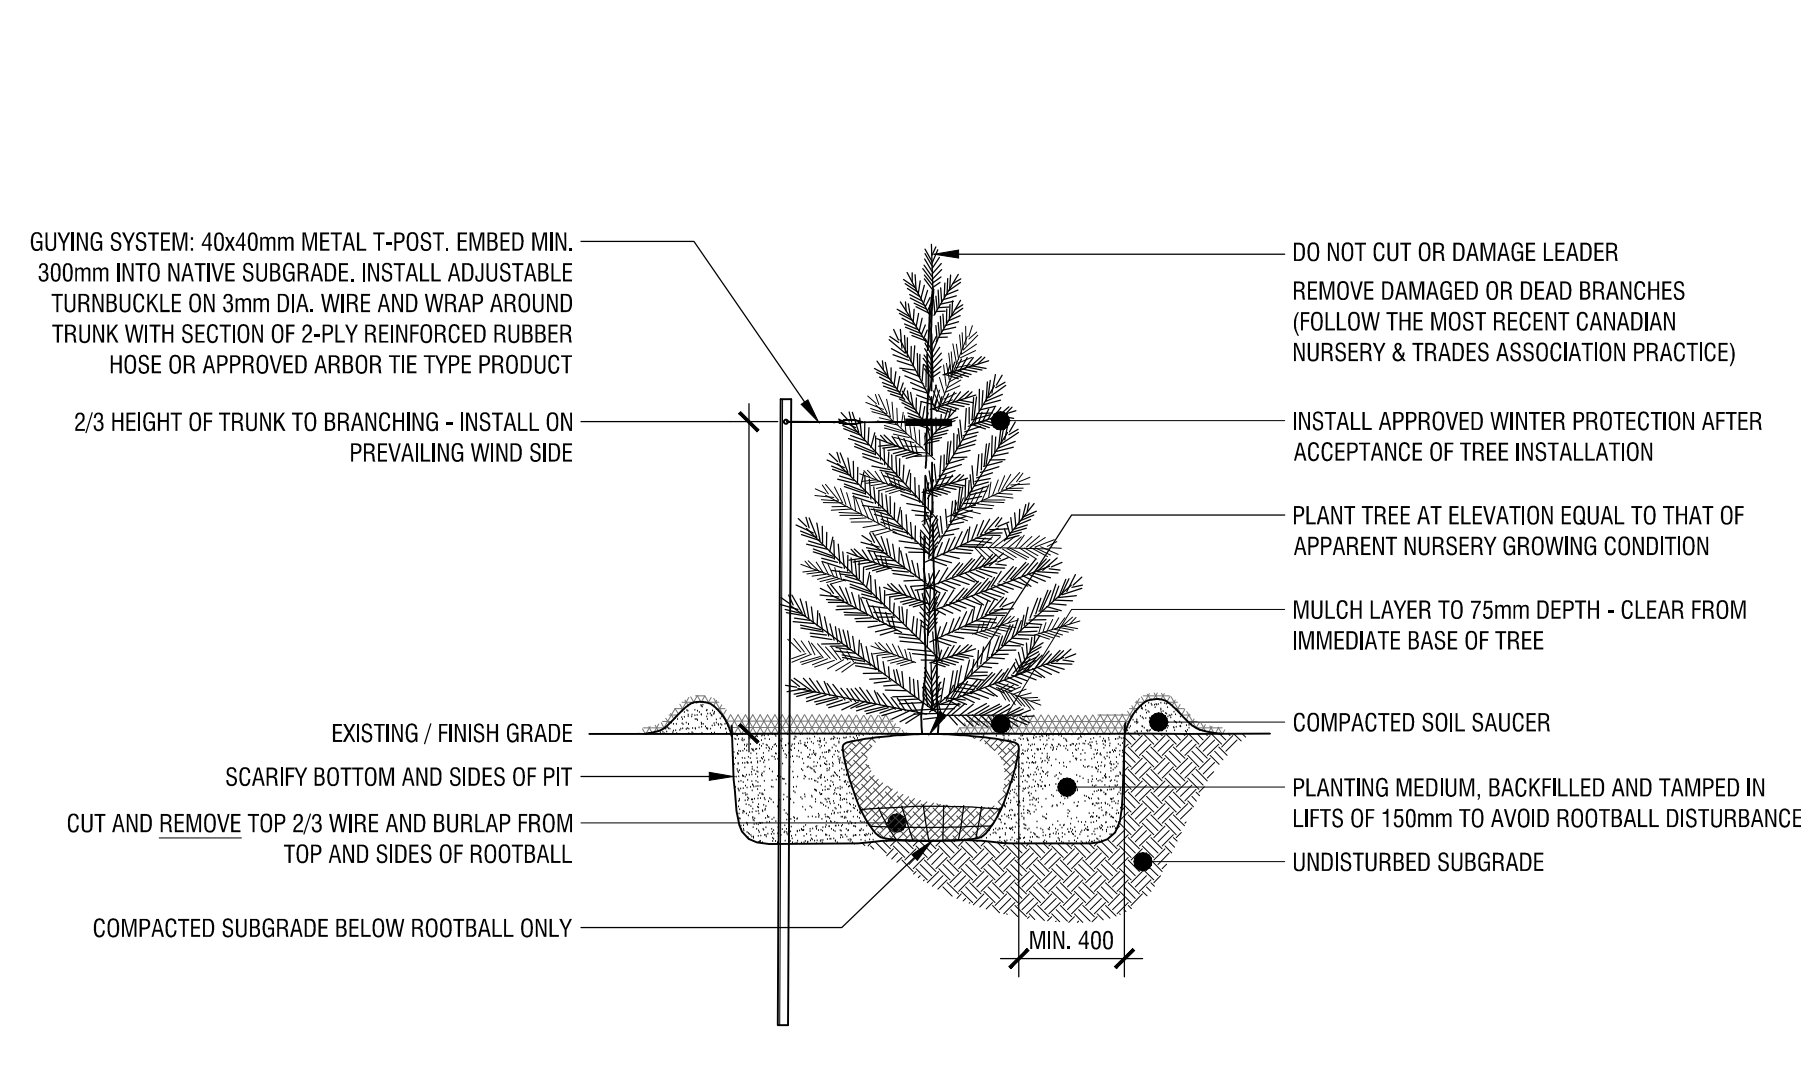


2 **CONIFEROUS PLANTING DETAIL**
L7 **N.T.S.**

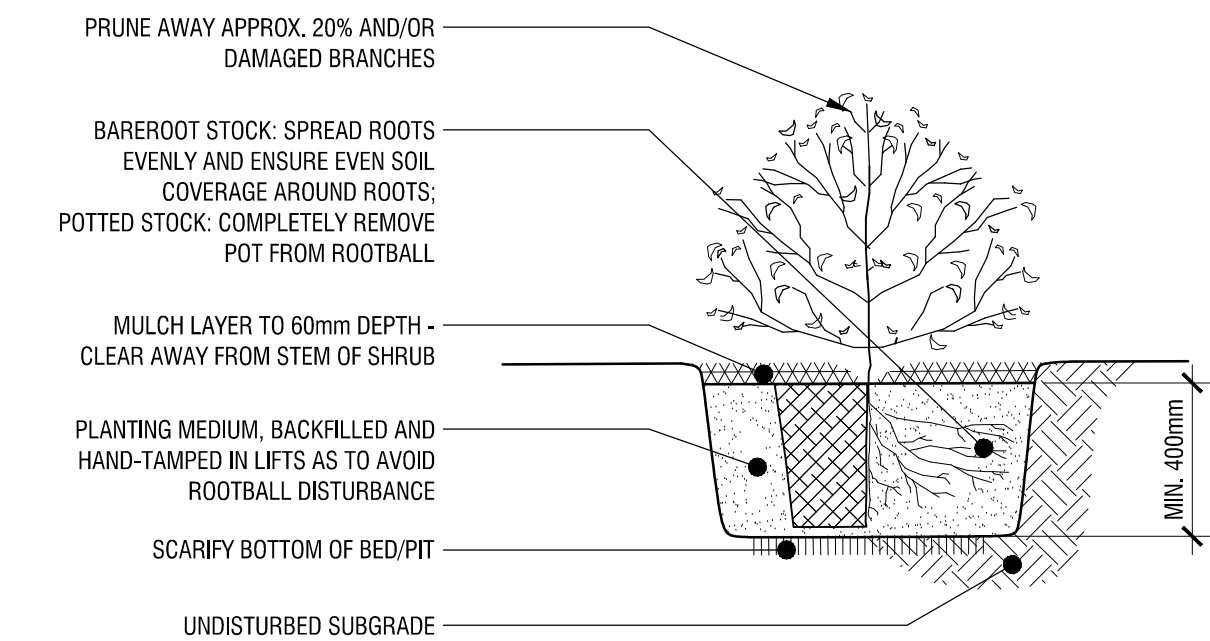

3 **SHRUB PLANTING DETAIL**
L7 **N.T.S.**

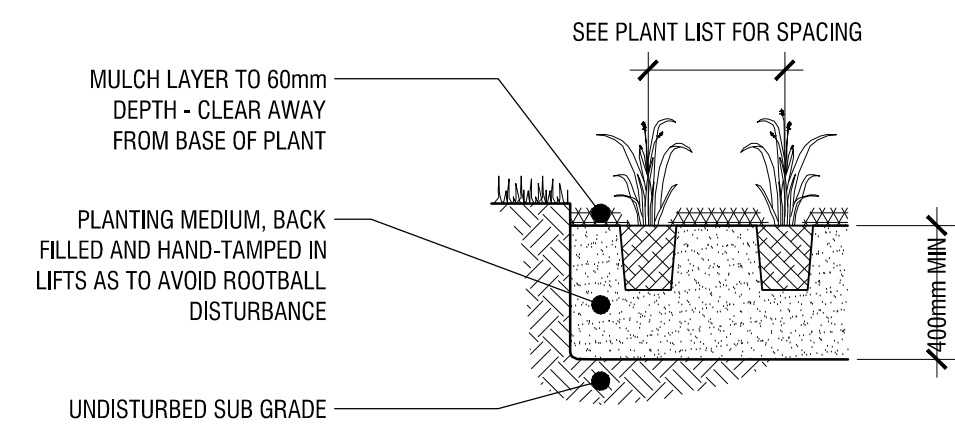

4 **PERENNIAL PLANTING DETAIL**
L7 **N.T.S.**

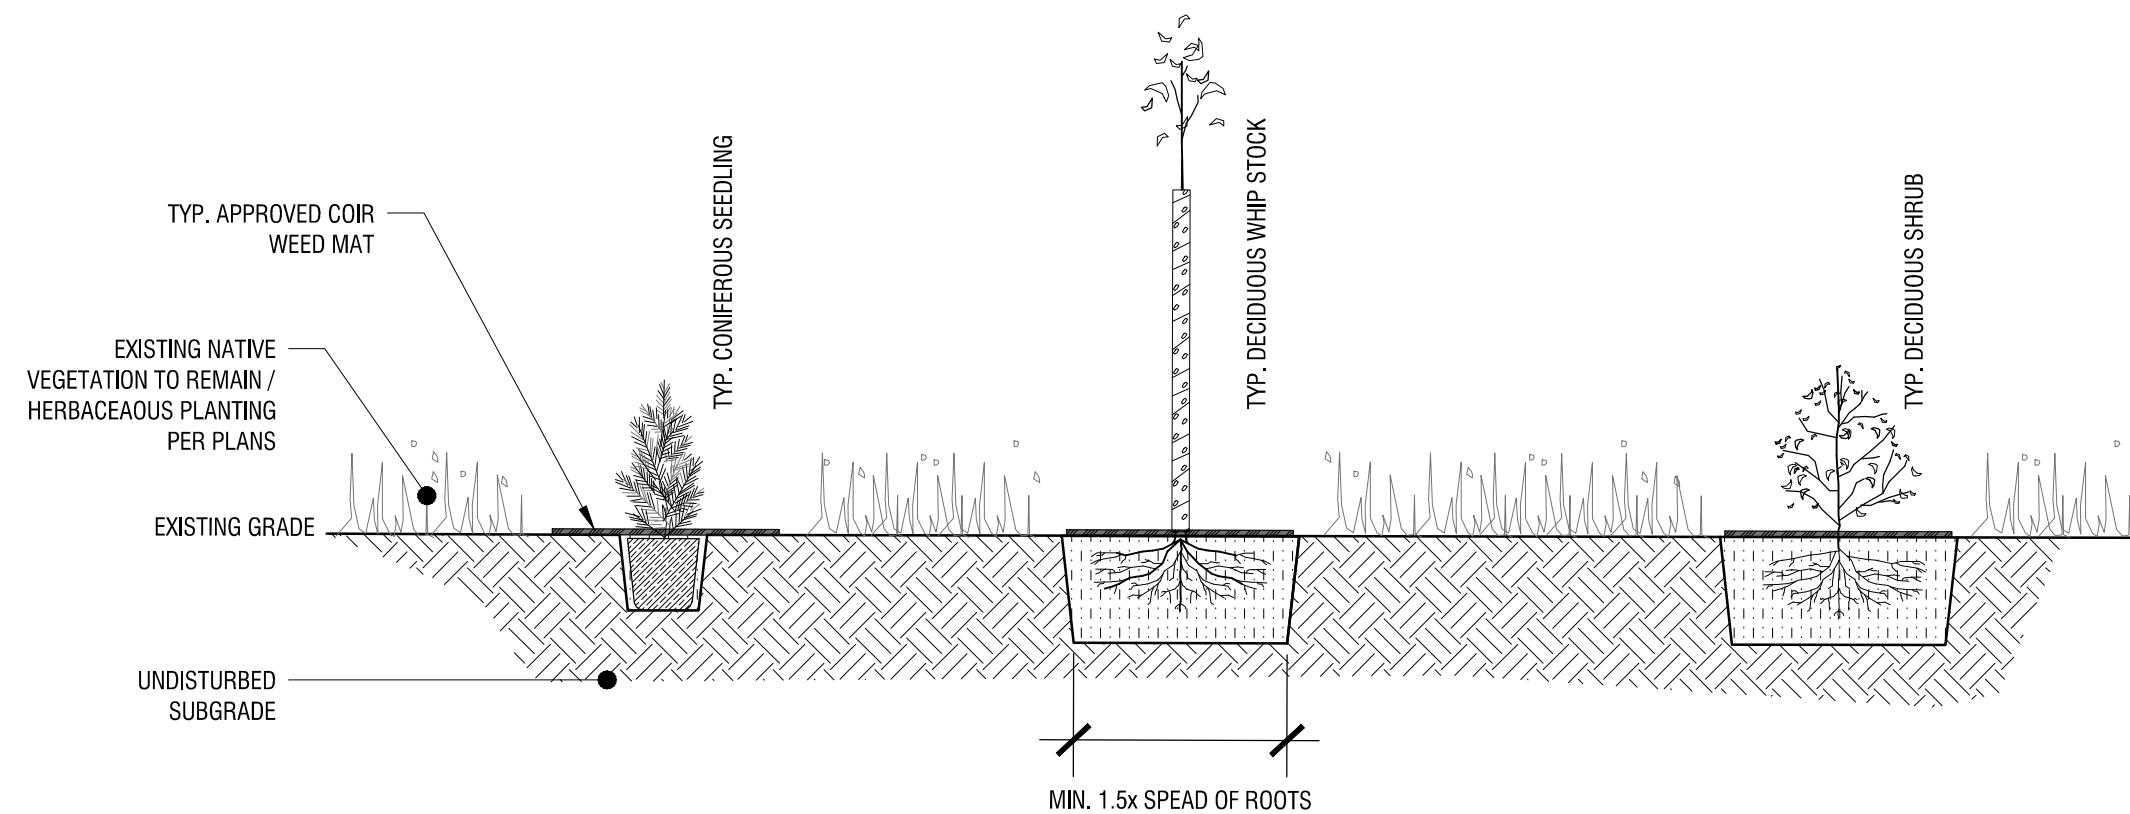

NOTES:

1. LOCATIONS AND SPACING OF PLANTS WILL BE PROVIDED IN THE FIELD BY THE LANDSCAPE ARCHITECT / FORESTER;
2. SCARIFY BOTTOM OF PLANTING PITS;
3. SPREAD ROOTS OF BARE ROOT STOCK EVENLY AND ENSURE FULL SOIL COVERAGE AROUND ROOTS;
4. BACKFILL PLANTING EXCAVATIONS WITH LOOSENED NATIVE SOIL. WHERE FOUND TO UN-SUITABLE, BLEND WITH APPROVED IMPORTED TOPSOIL;
5. REMOVE NATIVE HERBACEOUS GROWTH FROM IMMEDIATE BASE OF PLANT. INSTALL APPROVED BIO-DEGRADABLE COIR MATS (MIN. 600 0 x 10 THICK) AND FASTEN WITH 3 APPROVED BIO-DEGRADABLE STAKES;
6. INSTALL APPROVED FINE WIRE MESH OR PERFORATED PLASTIC RODENT BARRIER ON WHIP STOCK TREES;
7. REFER TO PLANTING SPECIFICATIONS FOR FURTHER DETAILS

5 **SUCCESSION/UNDERSTOREY PLANTING DETAIL**
L7 **N.T.S.**

PRELIMINARY
NOT FOR CONSTRUCTION

Copyright Reserved
The Copyrights to all designs and drawings are the property of Fotenn Consultants Inc. Unauthorized reproduction or use is forbidden. DO NOT SCALE DRAWING

Copyright réservés
Les droits d'auteur à tous les modèles et dessins sont la propriété de Fotenn Consultants Inc. Reproduction ou utilisation non autorisée est interdite. NE PAS L'ÉCHELLE DE DESSIN

Client / Client



key plan / plan repère

legend / légende

rev'n	description / la description	yyyy/mm/dd
02	issue for SPA	2025/11/25
01	issue for coordination	2025/05/16
00	issue for coordination	2025/04/07

FOTENN Planning + Design
420 O'Connor Street
Ottawa, ON, CANADA K2P 1W4
613.730.5709
fotenn.com

north / le nord

stamp / le cachet



project / projet

30 CLEARY AVENUE

drawing / dessin

**LANDSCAPE PLANTING
DETAILS**

designed / conçu BM EM	drawn / dessiné BM EM	reviewed / examiné DF
date 2023/07/14	project number / No. du projet 23002	

drawing number / No. du dessin

L7