


KEY PLAN

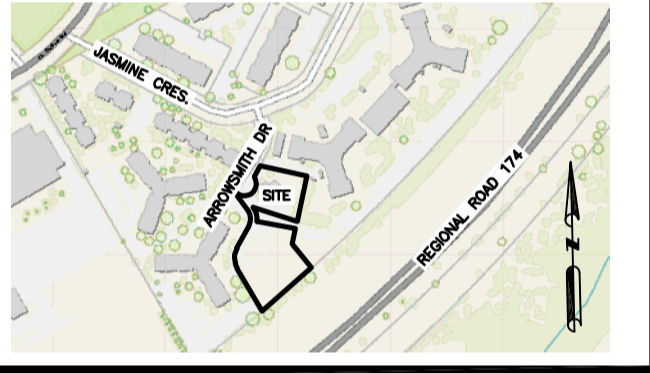


No.	DATE	REVISION
7	FEB 24-26	RE-ISSUED FOR APPROVAL
6	JAN 27-26	ISSUED FOR TENDER
5	DEC 10-25	RE-ISSUED FOR APPROVAL
4	JAN 17-25	ISSUED FOR ZONING
3	DEC 6-24	ISSUED FOR BUILDING PERMIT
2	DEC 21-22	ISSUED FOR APPROVAL
1	DEC 19-22	ISSUED FOR COORDINATION

**D. B. GRAY ENGINEERING INC.**  
 Stormwater Management - Grading & Drainage - Storm & Sanitary Sewers - Watermain  
 700 Long Point Circle 613-425-8044  
 Ottawa, Ontario d.gray@dbgrayengineering.com

Project  
**PROPOSED 6-STORY  
 MIXED-USE BUILDING  
 2040 ARROWSMITH DRIVE  
 OTTAWA, ONTARIO**

Drawing Title  
**PRE-DEVELOPMENT  
 DRAINAGE PLAN**

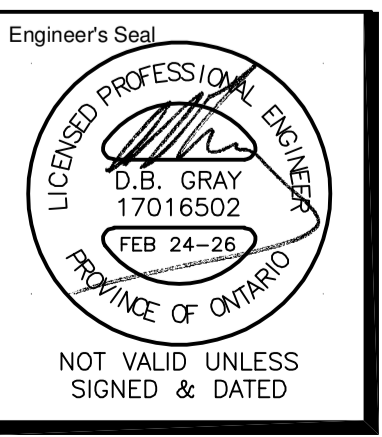

Drawn D.B.G.  
 H. Scale 1:400  
 V. Scale  
 Date NOV 29-22  
 Job No. 22062

Drawing No.  
**C-13  
 of 18**