


**LEGEND**

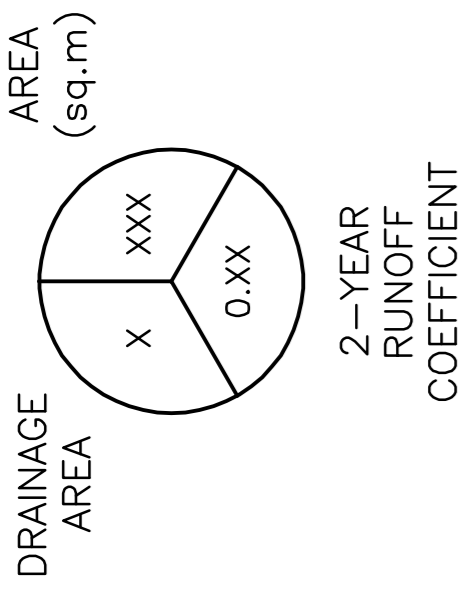

**KEY PLAN**



No.	DATE	REVISION
2	MAR 5-26	ISSUED FOR APPROVAL
1	JAN 30-26	ISSUED FOR COORDINATION

**D. B. GRAY ENGINEERING INC.**  
Professional Engineers - Consulting & Planning - Storm & Sanitary Services - Firearmless  
700 Long Point Circle  
Ottawa, Ontario    d.gray@dbgrayengineering.com

Project  
**PROPOSED 4-STORY APARTMENT BUILDINGS**  
**1770 HEATHERINGTON ROAD**  
OTTAWA, ONTARIO

Drawing Title  
**DRAINAGE PLAN**  
(BUILDING 1)

Engineer's Seal

Drawn: D.B.G.  
H. Scale: 1:200  
V. Scale: 1:200  
Date: JAN 30-26  
Job No.: 24135

Drawing No.  
**C-12**  
of 22

NOT VALID UNLESS SIGNED & DATED

