



REFER TO DETAILS ON DRAWING No. C-11  
 REFER TO NOTES ON DRAWING No. C-22

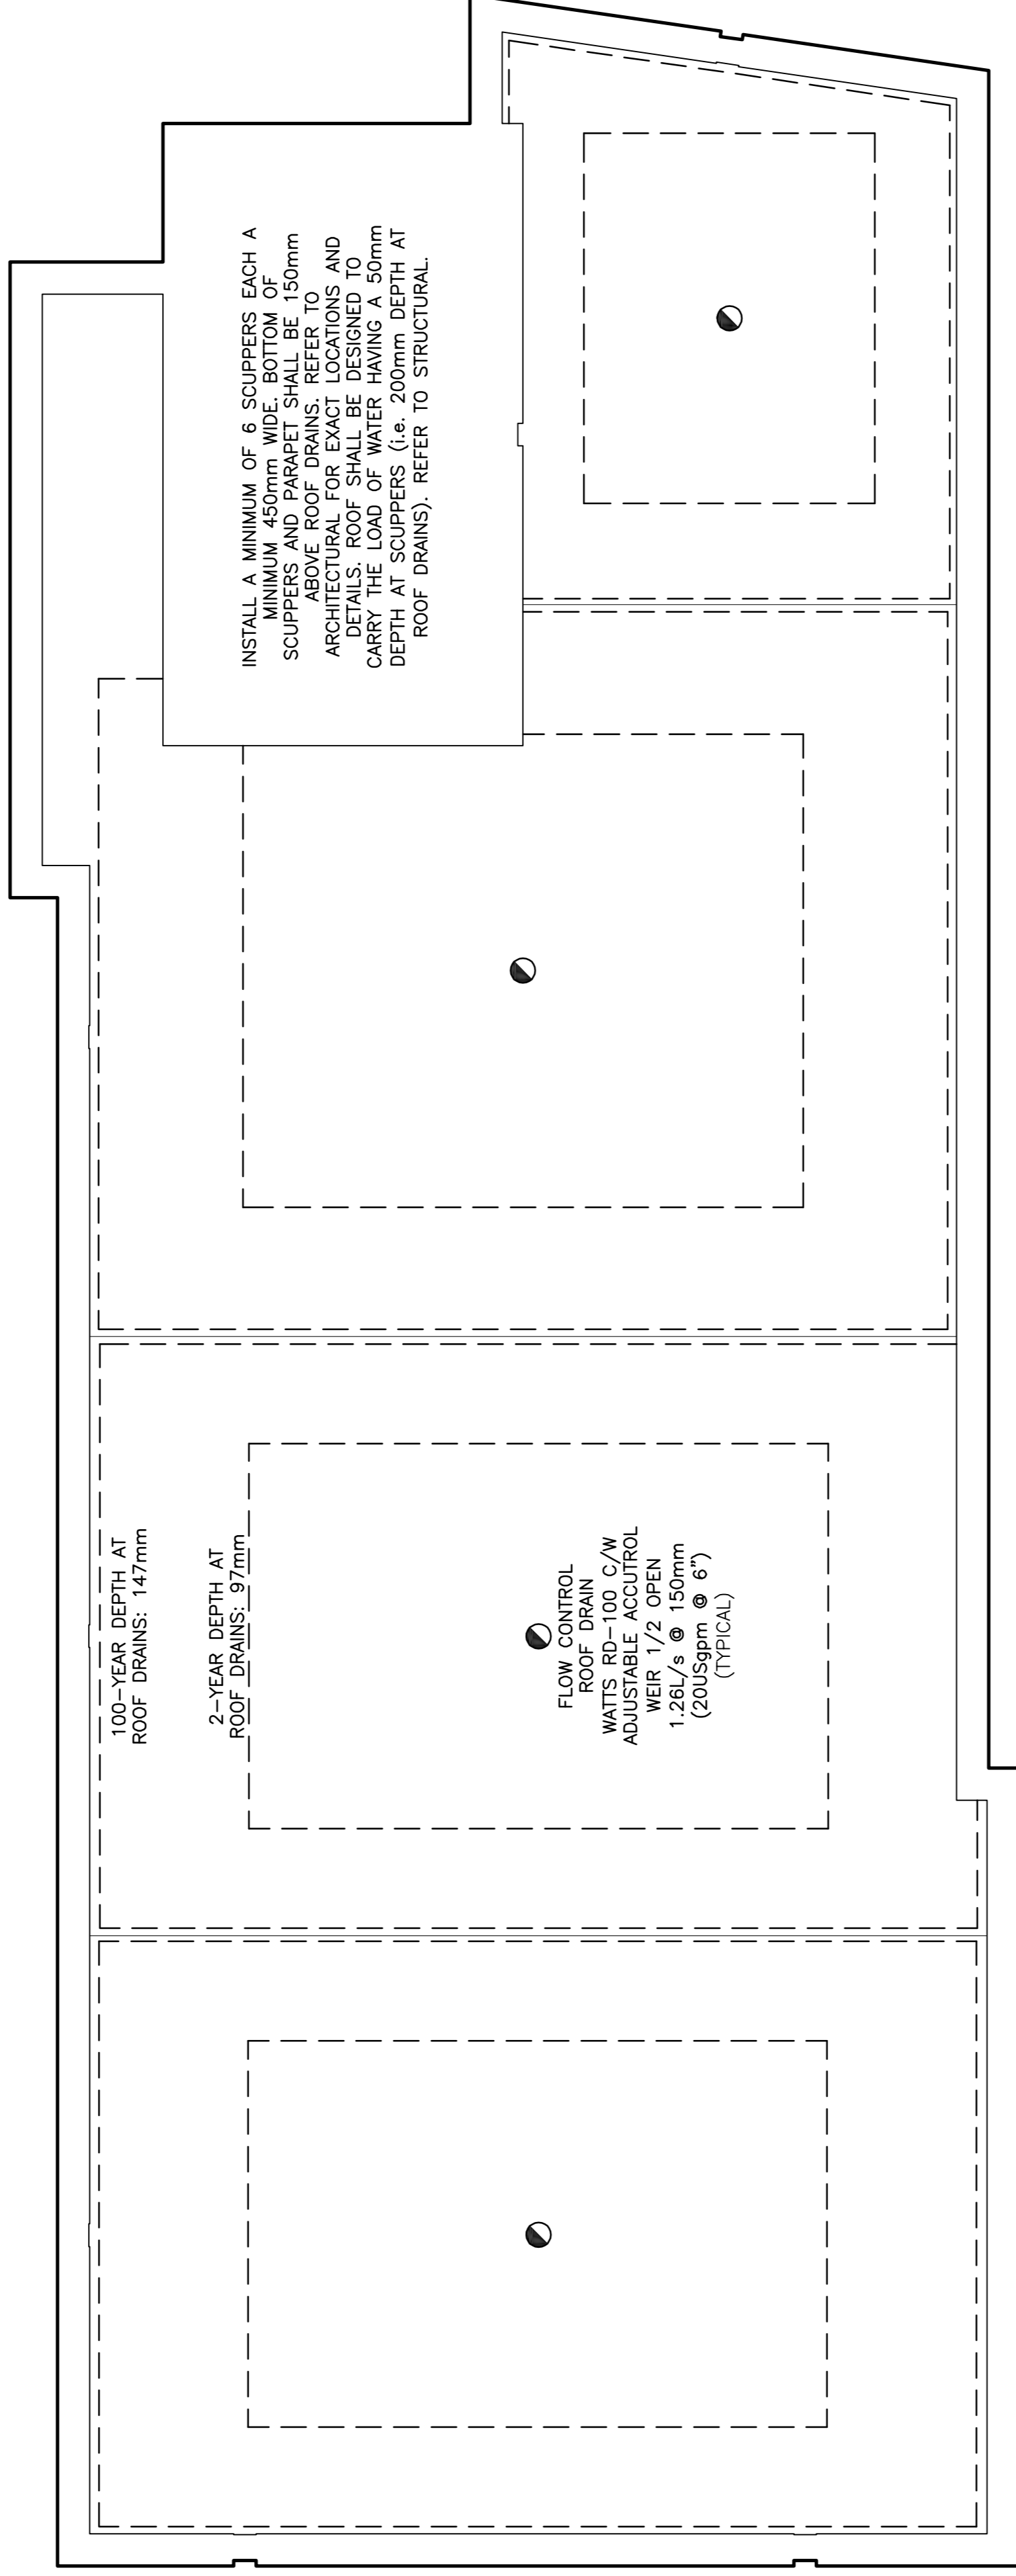


**LEGEND**

ROOF DRAIN

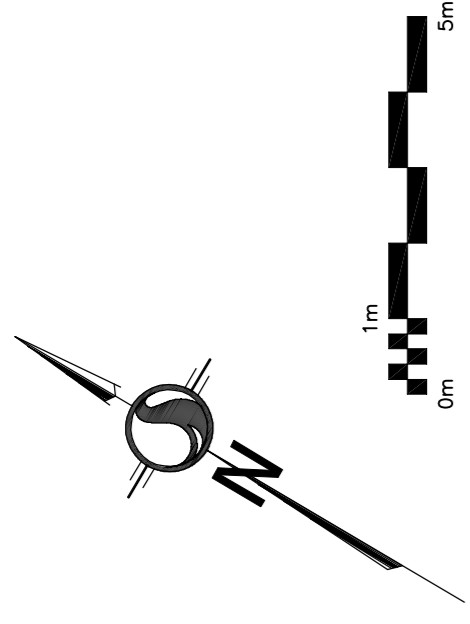

**KEY PLAN**

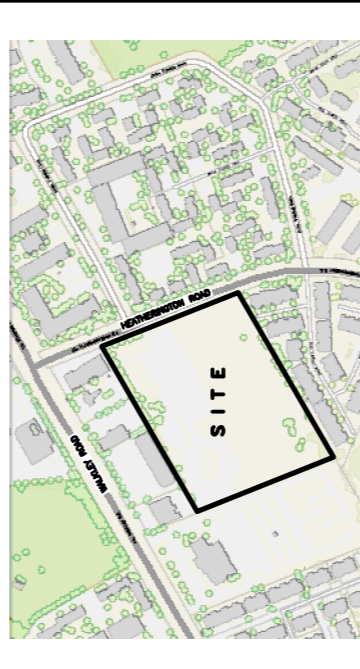

No.	DATE	REVISION
2	MAR 5-26	ISSUED FOR APPROVAL
1	JAN 30-26	ISSUED FOR COORDINATION

**D. B. GRAY ENGINEERING INC.**  
 Structural Management - Consulting & Planning - Storm & Sanitary Services - Remediation  
 700 Long Point Circle  
 Ottawa, Ontario d.gray@dbgrayengineering.com  
 613-425-8044

Project  
**PROPOSED 4-STORY APARTMENT BUILDINGS**  
 1770 HEATHERINGTON ROAD  
 OTTAWA, ONTARIO

Drawing Title  
**ROOF DRAINAGE PLAN**  
 (BUILDING 1)

Engineer's Seal  
  
 Drawn: D.B.G.  
 H. Scale: 1:100  
 V. Scale:  
 Date: JAN 30-26  
 Job No.: 24135  
 Drawing No.: C-10  
 of 22  
 NOT VALID UNLESS SIGNED & DATED