



REFER TO DETAILS ON DRAWING No. C-20
 REFER TO NOTES ON DRAWING No. C-22

LEGEND
 ROOF DRAIN

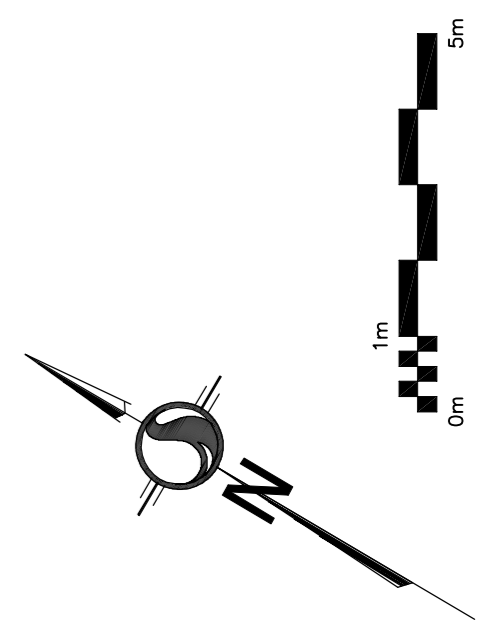

KEY PLAN

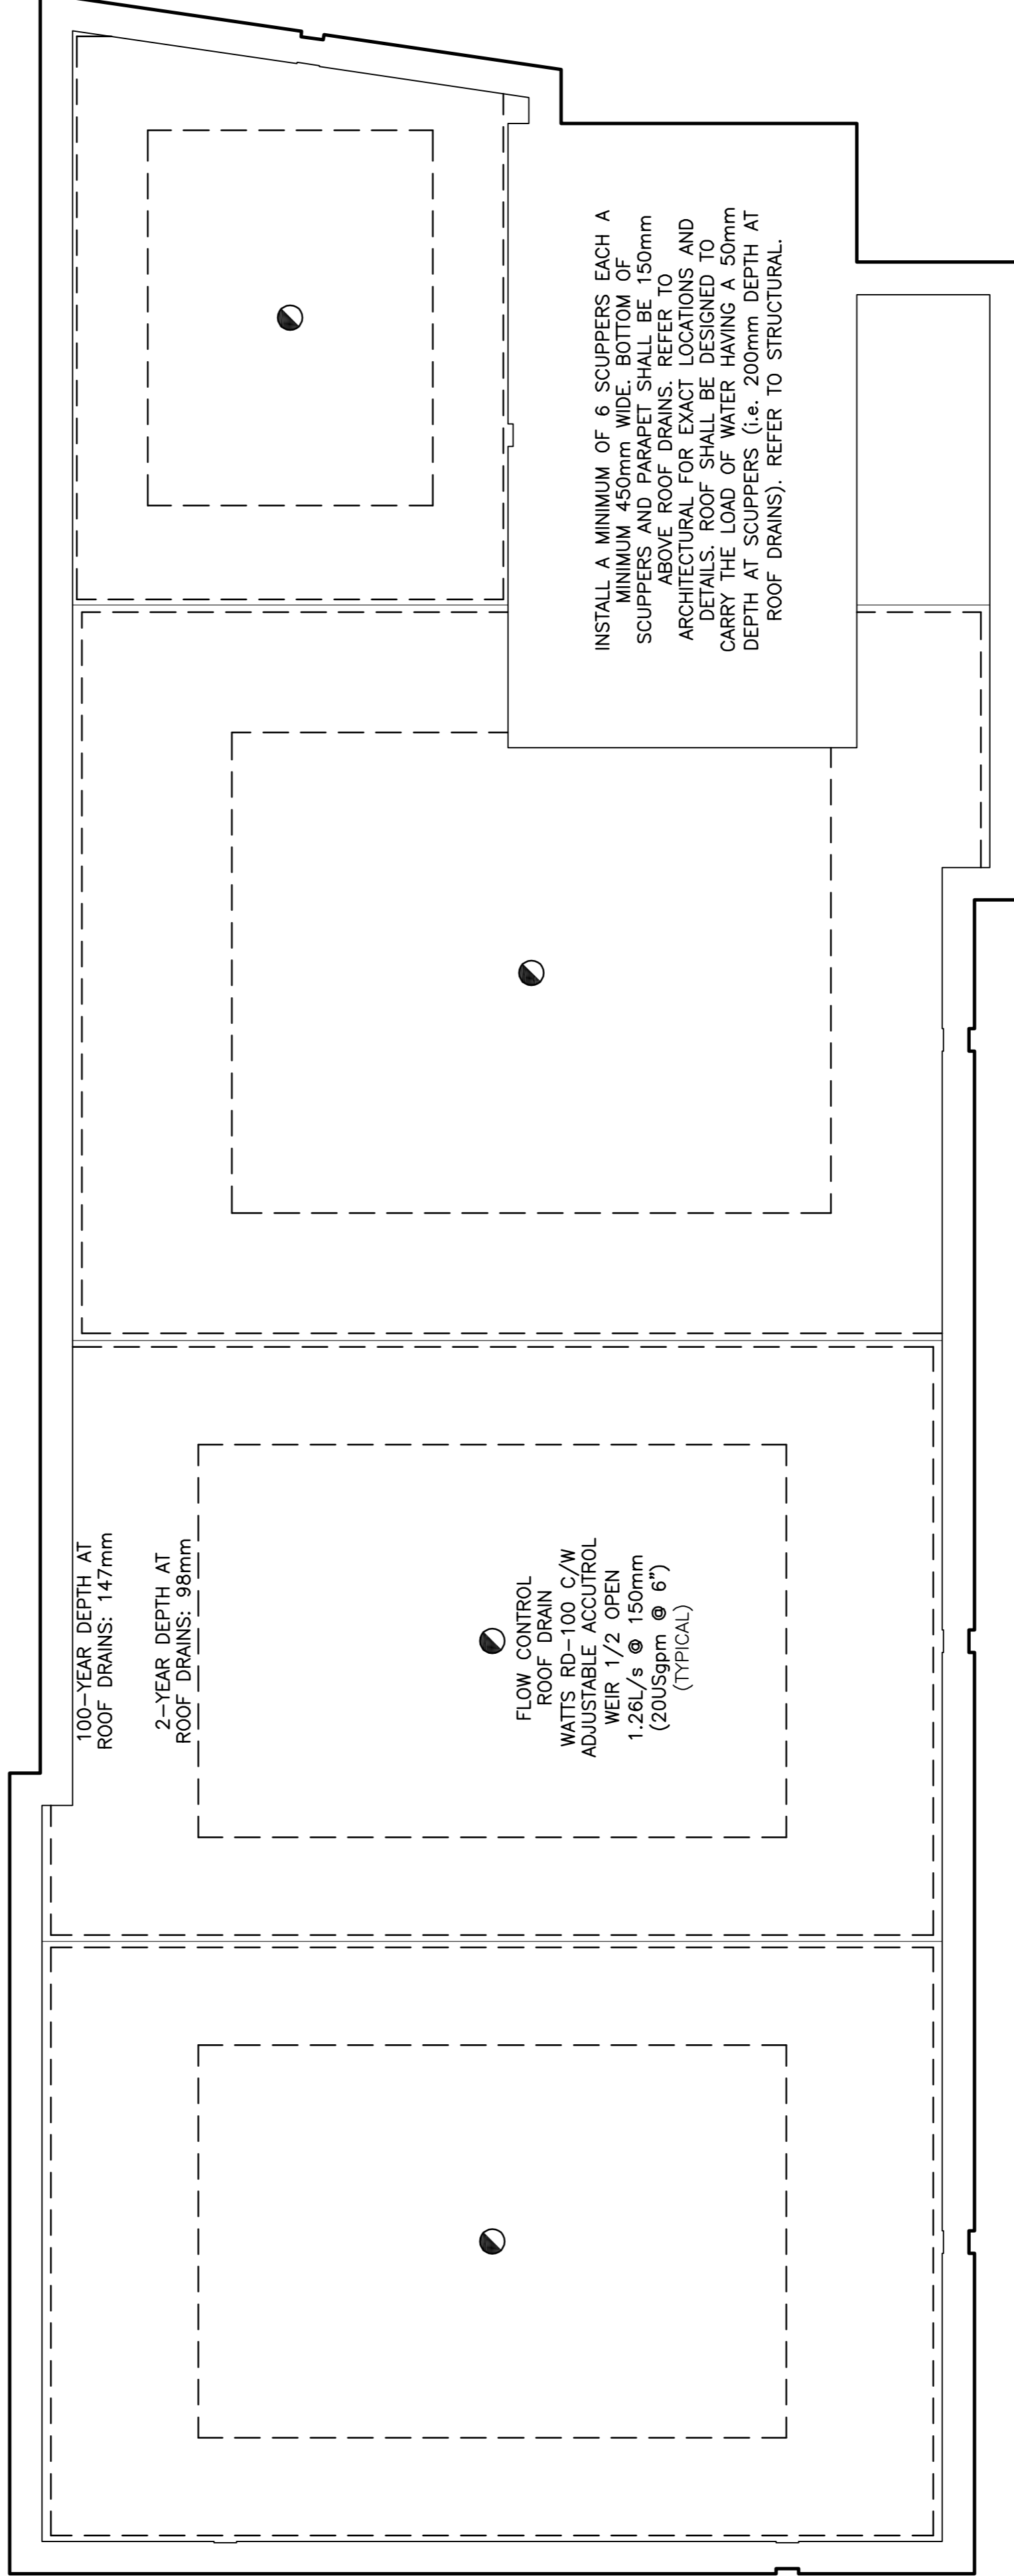

No.	DATE	REVISION
2	MAR 5-26	ISSUED FOR APPROVAL
1	JAN 30-26	ISSUED FOR COORDINATION

D. B. GRAY ENGINEERING INC.
 Structural Management - Consulting & Planning - Design & Safety Services - Performance
 700 Long Point Circle
 Ottawa, Ontario d.gray@dbgrayengineering.com 613-425-8044

Project
PROPOSED 4-STORY APARTMENT BUILDINGS
 1770 HEATHERINGTON ROAD
 OTTAWA, ONTARIO

Drawing Title
ROOF DRAINAGE PLAN
 (BUILDING 13)

Engineer's Seal

 Drawn: D.B.G.
 H. Scale: 1:100
 V. Scale:
 Date: JAN 30-26
 Job No.: 24135
 Drawing No. C-19 of 22
 NOT VALID UNLESS SIGNED & DATED