



1875 (PCL) 1087 (PCL) CUSTOM SHEET SIZE

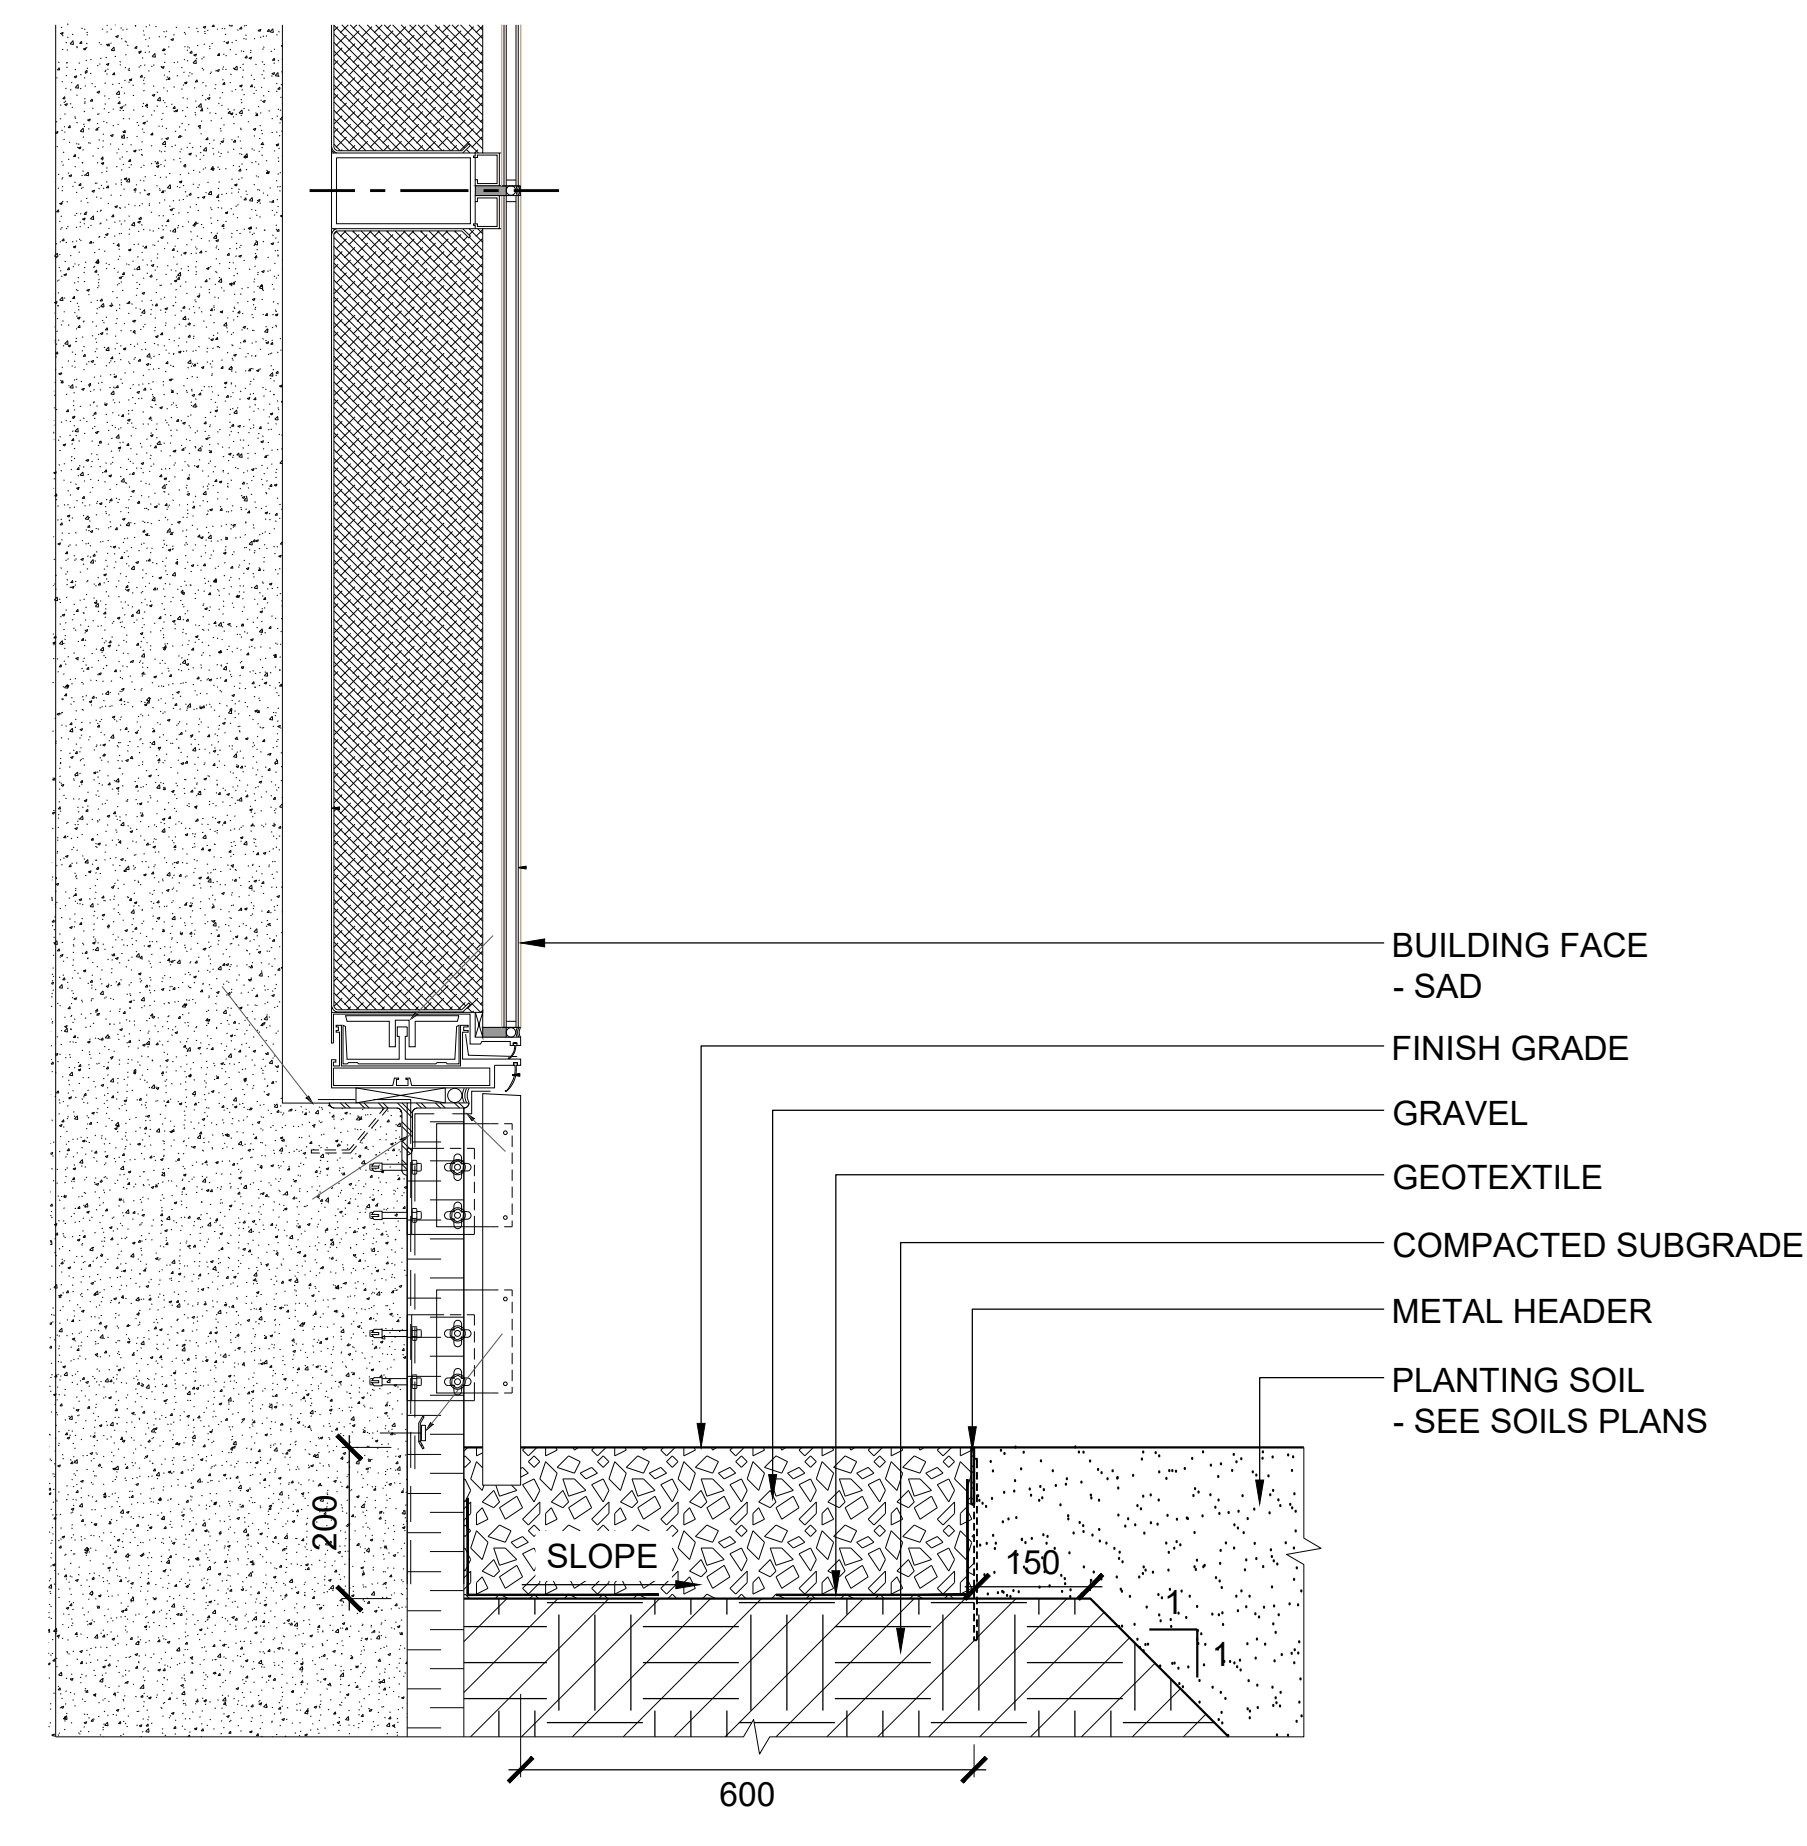


5 GRAVEL MAINTENANCE BAND AT TOWER A CW-02
SCALE 1 : 10
TYPICAL SECTION

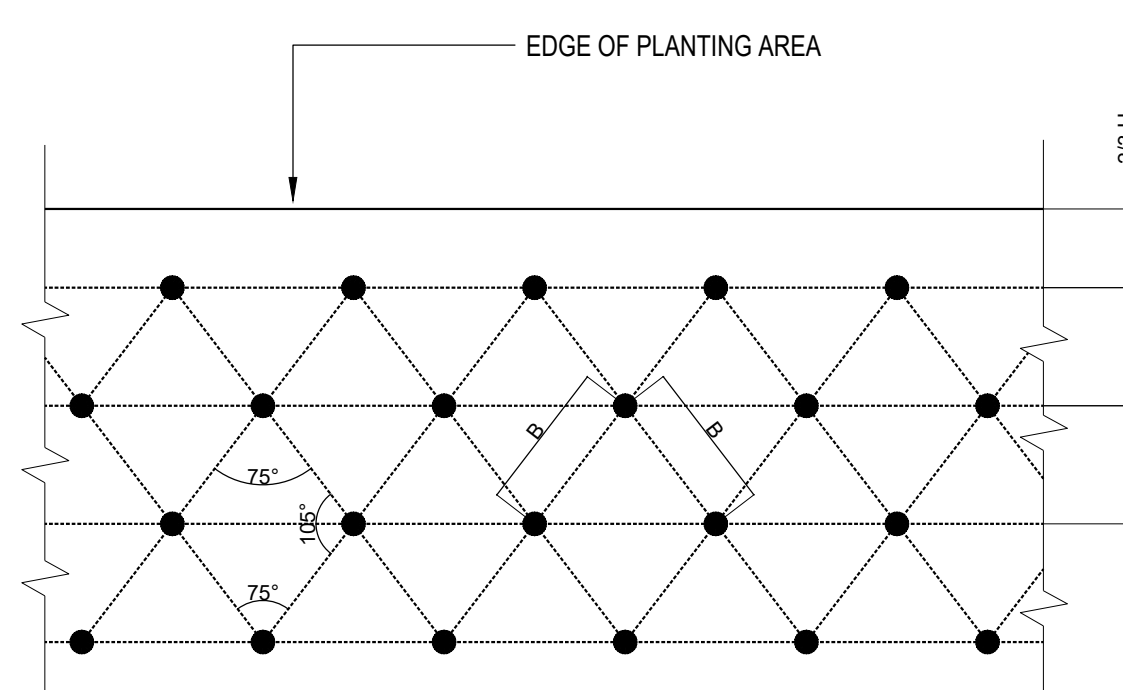


TRIANGULAR SPACING = B	DISTANCE BETWEEN ROWS = H	TOTAL AREA (SF) PER PLANT
6"	5"	0.21
8"	7"	0.39
9"	8"	0.50
10"	8 1/2"	0.59
12"	10 1/2"	0.88
15"	13"	1.35
18"	15 1/2"	1.94
21"	18"	2.63
24" (2')	21"	3.50
30"	26"	5.42


4 TRIANGULAR PLANTING SPACING DIAGRAM
REFERENCES

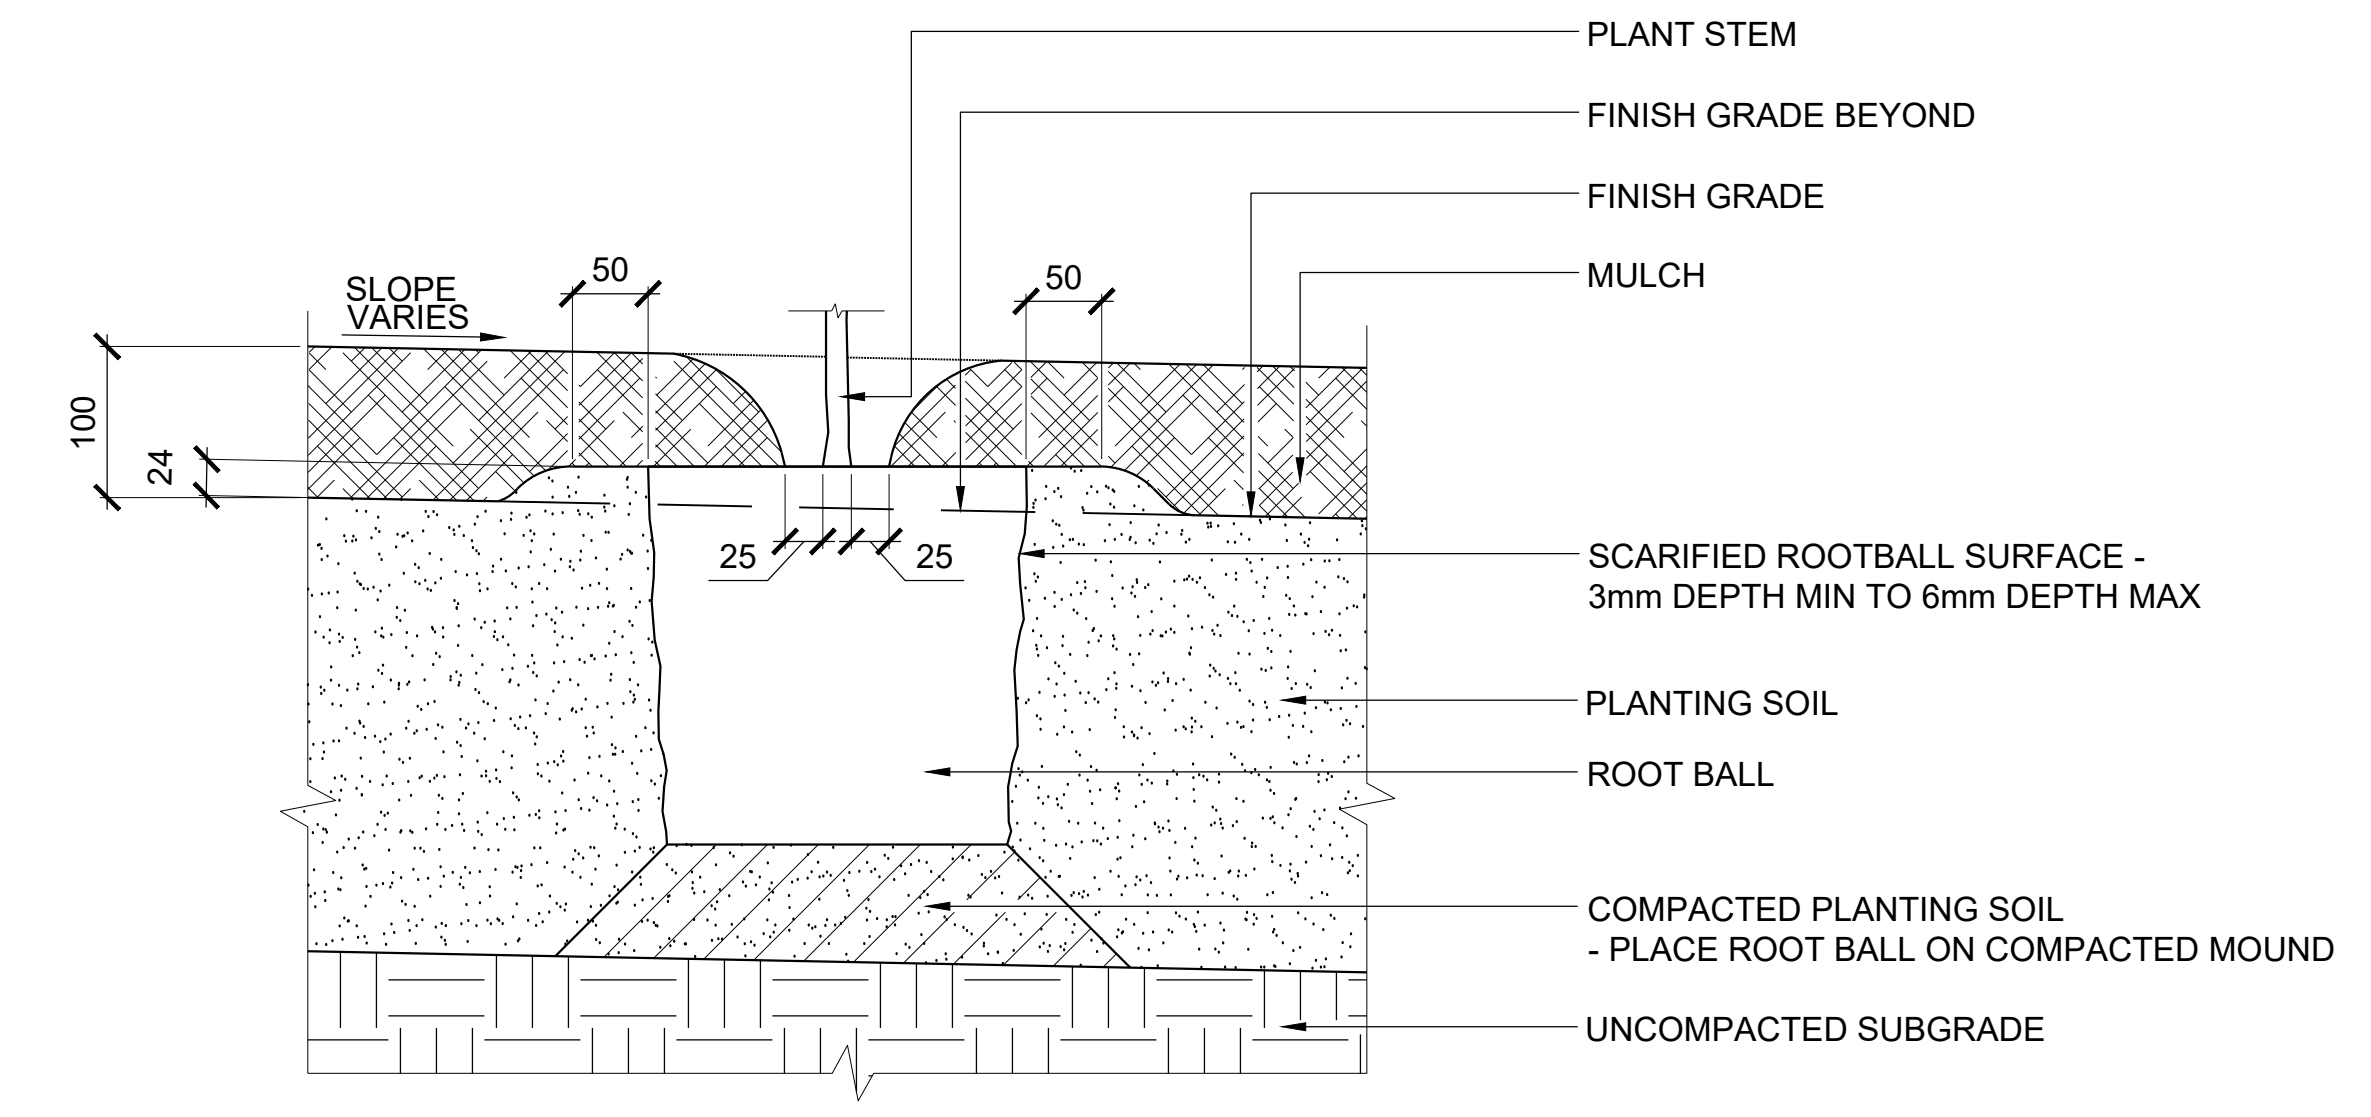

3 SHRUB PLANTING
SCALE 1 : 5
SECTION

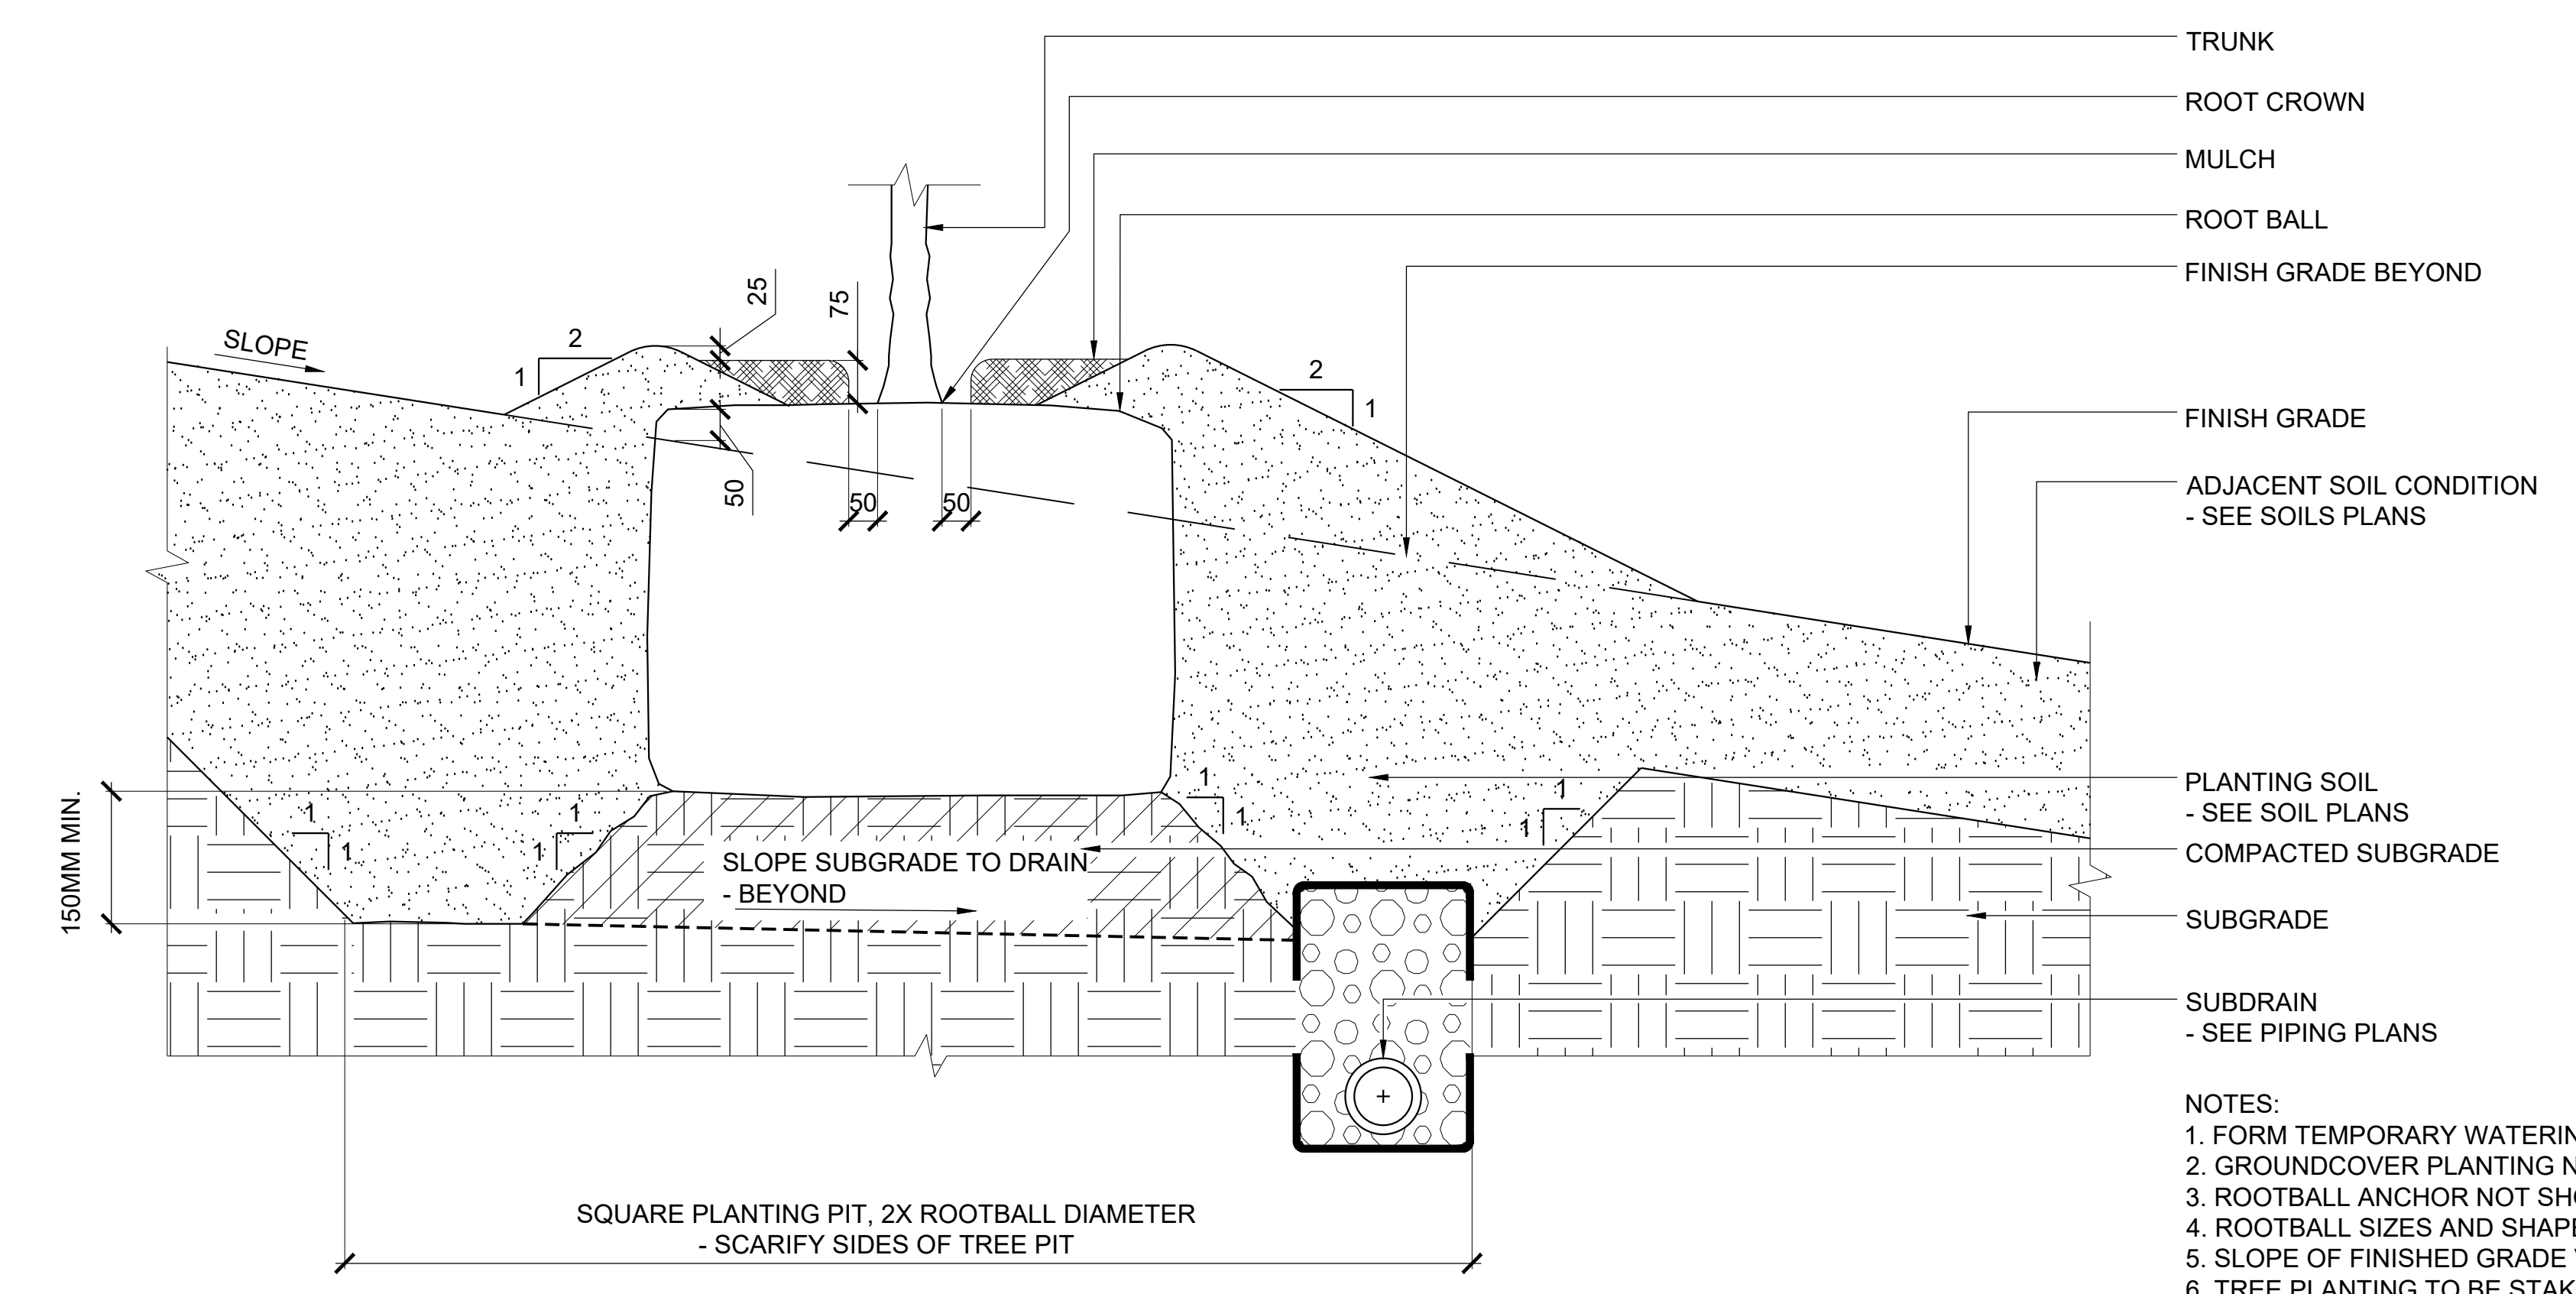

2 TREE PLANTING ON SLOPE
SCALE 1 : 10
SECTION

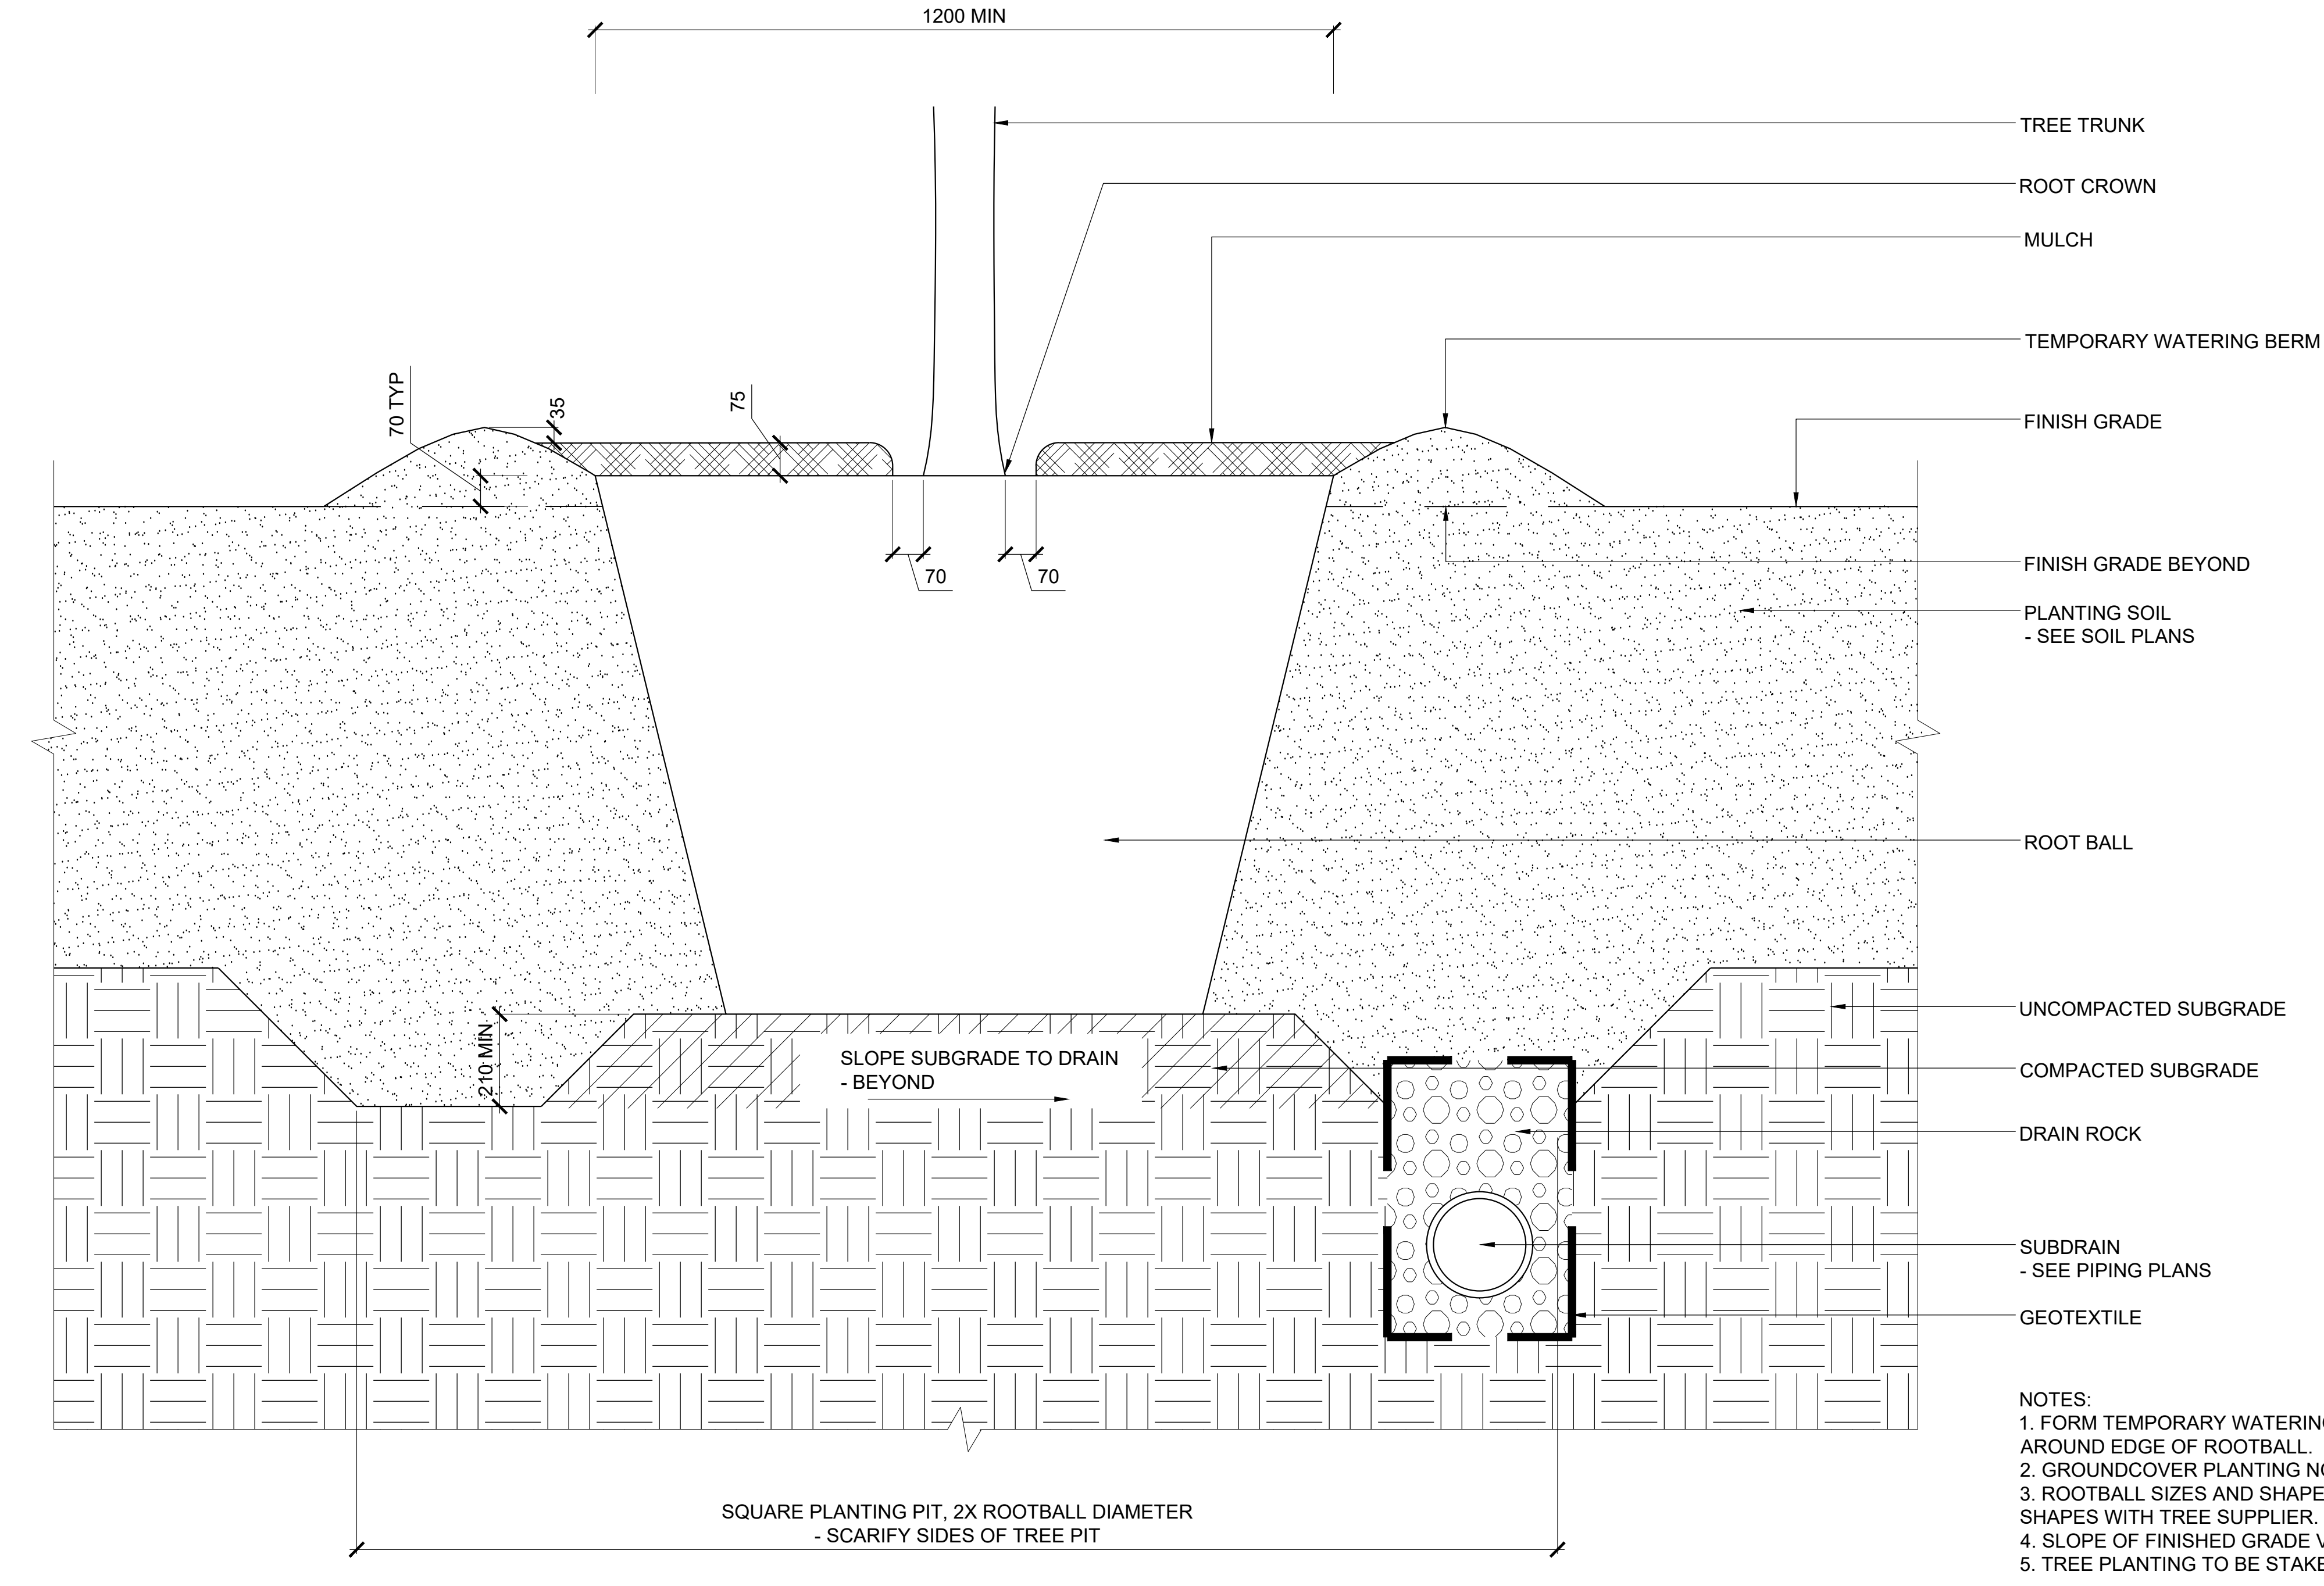

1 TREE PLANTING
SCALE 1 : 10
SECTION

- NOTES:
1. FORM TEMPORARY WATERING BERM AS CONTINUOUS RING AROUND EDGE OF ROOTBALL.
 2. GROUND COVER PLANTING NOT SHOWN FOR CLARITY.
 3. ROOTBALL ANCHOR NOT SHOWN FOR CLARITY.
 4. ROOTBALL SIZES AND SHAPES VARY. VERIFY SIZES AND SHAPES WITH TREE SUPPLIER.
 5. SLOPE OF FINISHED GRADE VARIES. SEE GRADING PLANS.
 6. TREE PLANTING TO BE STAKED AS REQUIRED.

- NOTES:
1. FORM TEMPORARY WATERING BERM AS CONTINUOUS RING AROUND EDGE OF ROOTBALL.
 2. GROUND COVER PLANTING NOT SHOWN FOR CLARITY.
 3. ROOTBALL SIZES AND SHAPES VARY. VERIFY SIZES AND SHAPES WITH TREE SUPPLIER.
 4. SLOPE OF FINISHED GRADE VARIES. SEE GRADING PLANS.
 5. TREE PLANTING TO BE STAKED AS REQUIRED.

PROJECT
**THE OTTAWA HOSPITAL
NEW CAMPUS
DEVELOPMENT -
PHASE 4 MAIN HOSPITAL
BUILDING**
900 CARLING AVE. OTTAWA ONTARIO

CLIENT
The Ottawa Hospital | L'Hôpital d'Ottawa

Infrastructure Ontario

PCL CONSTRUCTION | EllisDon

CLIENT PROJECT NO. **1070002**

KEY PLAN

THIS DRAWING TO BE PRINTED IN COLOUR

REVISIONS

NO.	DESCRIPTION	DATE
08	SITE PLAN CONTROL RESUBMISSION R2	2025-03-27
07	DESIGN-BUILD BASELINE SUBMISSION	2025-03-09
06	SITE PLAN CONTROL RESUBMISSION	2025-01-13
05	65% DD SUBMISSION	2025-06-19
04	SITE PLAN CONTROL RESUBMISSION	2025-06-05
03	65% DD SUBMISSION	2025-06-05
02	35% DD SUBMISSION	2025-01-29
01	ACFOR READINESS	2025-01-09

DRAWING STATUS
NOT FOR CONSTRUCTION

DISCREPANCIES MUST BE REPORTED IMMEDIATELY TO THE ARCHITECT BEFORE PROCEEDING. ONLY FIGURED DIMENSIONS ARE TO BE USED. CONTRACTORS MUST CHECK ALL DIMENSIONS ON SITE. THIS DRAWING IS PROTECTED BY COPYRIGHT.

ALL DIMENSIONS ARE SHOWN IN METRIC.

AUTHOR
PWP

VERTECHS DESIGN
landscape architects

PROJECT TEAM
DESIGN/BUILDER: POLED, A JOINT VENTURE
ARCHITECTURAL: PARRON ARCHITECTS LIMITED, ZOOH LABARNE PRATTE ARCHITECTES, ADAMSON ASSOCIATE ARCHITECTS, 888 ARCHITECTS INC.
STRUCTURAL: STEPHENSON ENGINEERING LTD, BOUTHILLET PARIZEAU INC.
MECHANICAL: HJI ANGIS & ASSOCIATES LTD, CROSBY ENGINEERING LTD.
ELECTRICAL: MCELVEY & BIRN INTERNATIONAL INC.
CIVIL: HSP CANADA INC.
LANDSCAPE: VERTECHS DESIGN INC, PWP LANDSCAPE ARCHITECTURE
BUILDING CODE: UMG BUILDING CODE CONSULTANTS LTD.

AUTHOR PROJECT NO. **PCL2301_C**

DRAWING TITLE
PLANTING DETAILS

DRAWN: [] CHECKED: []
SCALE AT 42" x 60" DATE: 06-JAN-2025
AS NOTED

GRAPHIC SCALE: AS NOTED

DRAWING NO. **L27-100** REV NO. **08**

File Number: D07-12-26-0008 (Revision)
D07-12-23-0168 (Original)
Plan Number: 19424