

LEGEND

- FFL FINISHED FLOOR ELEVATION
- TOF TOP OF FOUNDATION
- USF UNDERSIDE OF FOOTING
- PROPERTY LINE
- CB CATCH BASIN
- CI CURB INLET
- MH STORM MANHOLE
- MH SANITARY MANHOLE
- FH FIRE HYDRANT
- CS CURB STOP & SERVICE POST
- VB VALVE & VALVE BOX
- SAN SANITARY SEWER
- ST STORM SEWER
- WS/WM WATER SERVICE/WATERMAIN
- OBV OBVERT
- SPL SPRINGLINE
- INV INVERT
- US UNDERSIDE

KEY PLAN



No.	DATE	REVISION
4	MAR 31-26	RE-ISSUED FOR APPROVAL
3	JAN 14-26	ISSUED FOR CONSTRUCTION
2	DEC 16-25	RE-ISSUED FOR APPROVAL
1	JUL 15-25	ISSUED FOR APPROVAL

D. B. GRAY ENGINEERING INC.
 Structural Management - Consulting & Planning - Design & Survey Services - Remediation
 700 Long Point Circle
 Ottawa, Ontario d.gray@dbgrayengineering.com


Project
PROPOSED 2-STORY MEDICAL FACILITY
 4405-4409 INNES ROAD
 OTTAWA, ONTARIO

Drawing Title
SITE PLAN

Engineer's Seal

 NOT VALID UNLESS SIGNED & DATED

Drawn: D.B.G.
 H. Scale: 1:200
 V. Scale: 1:200
 Date: JUL 15-25
 Job No.: 25061
 Drawing No.: **C-1**
 of 12

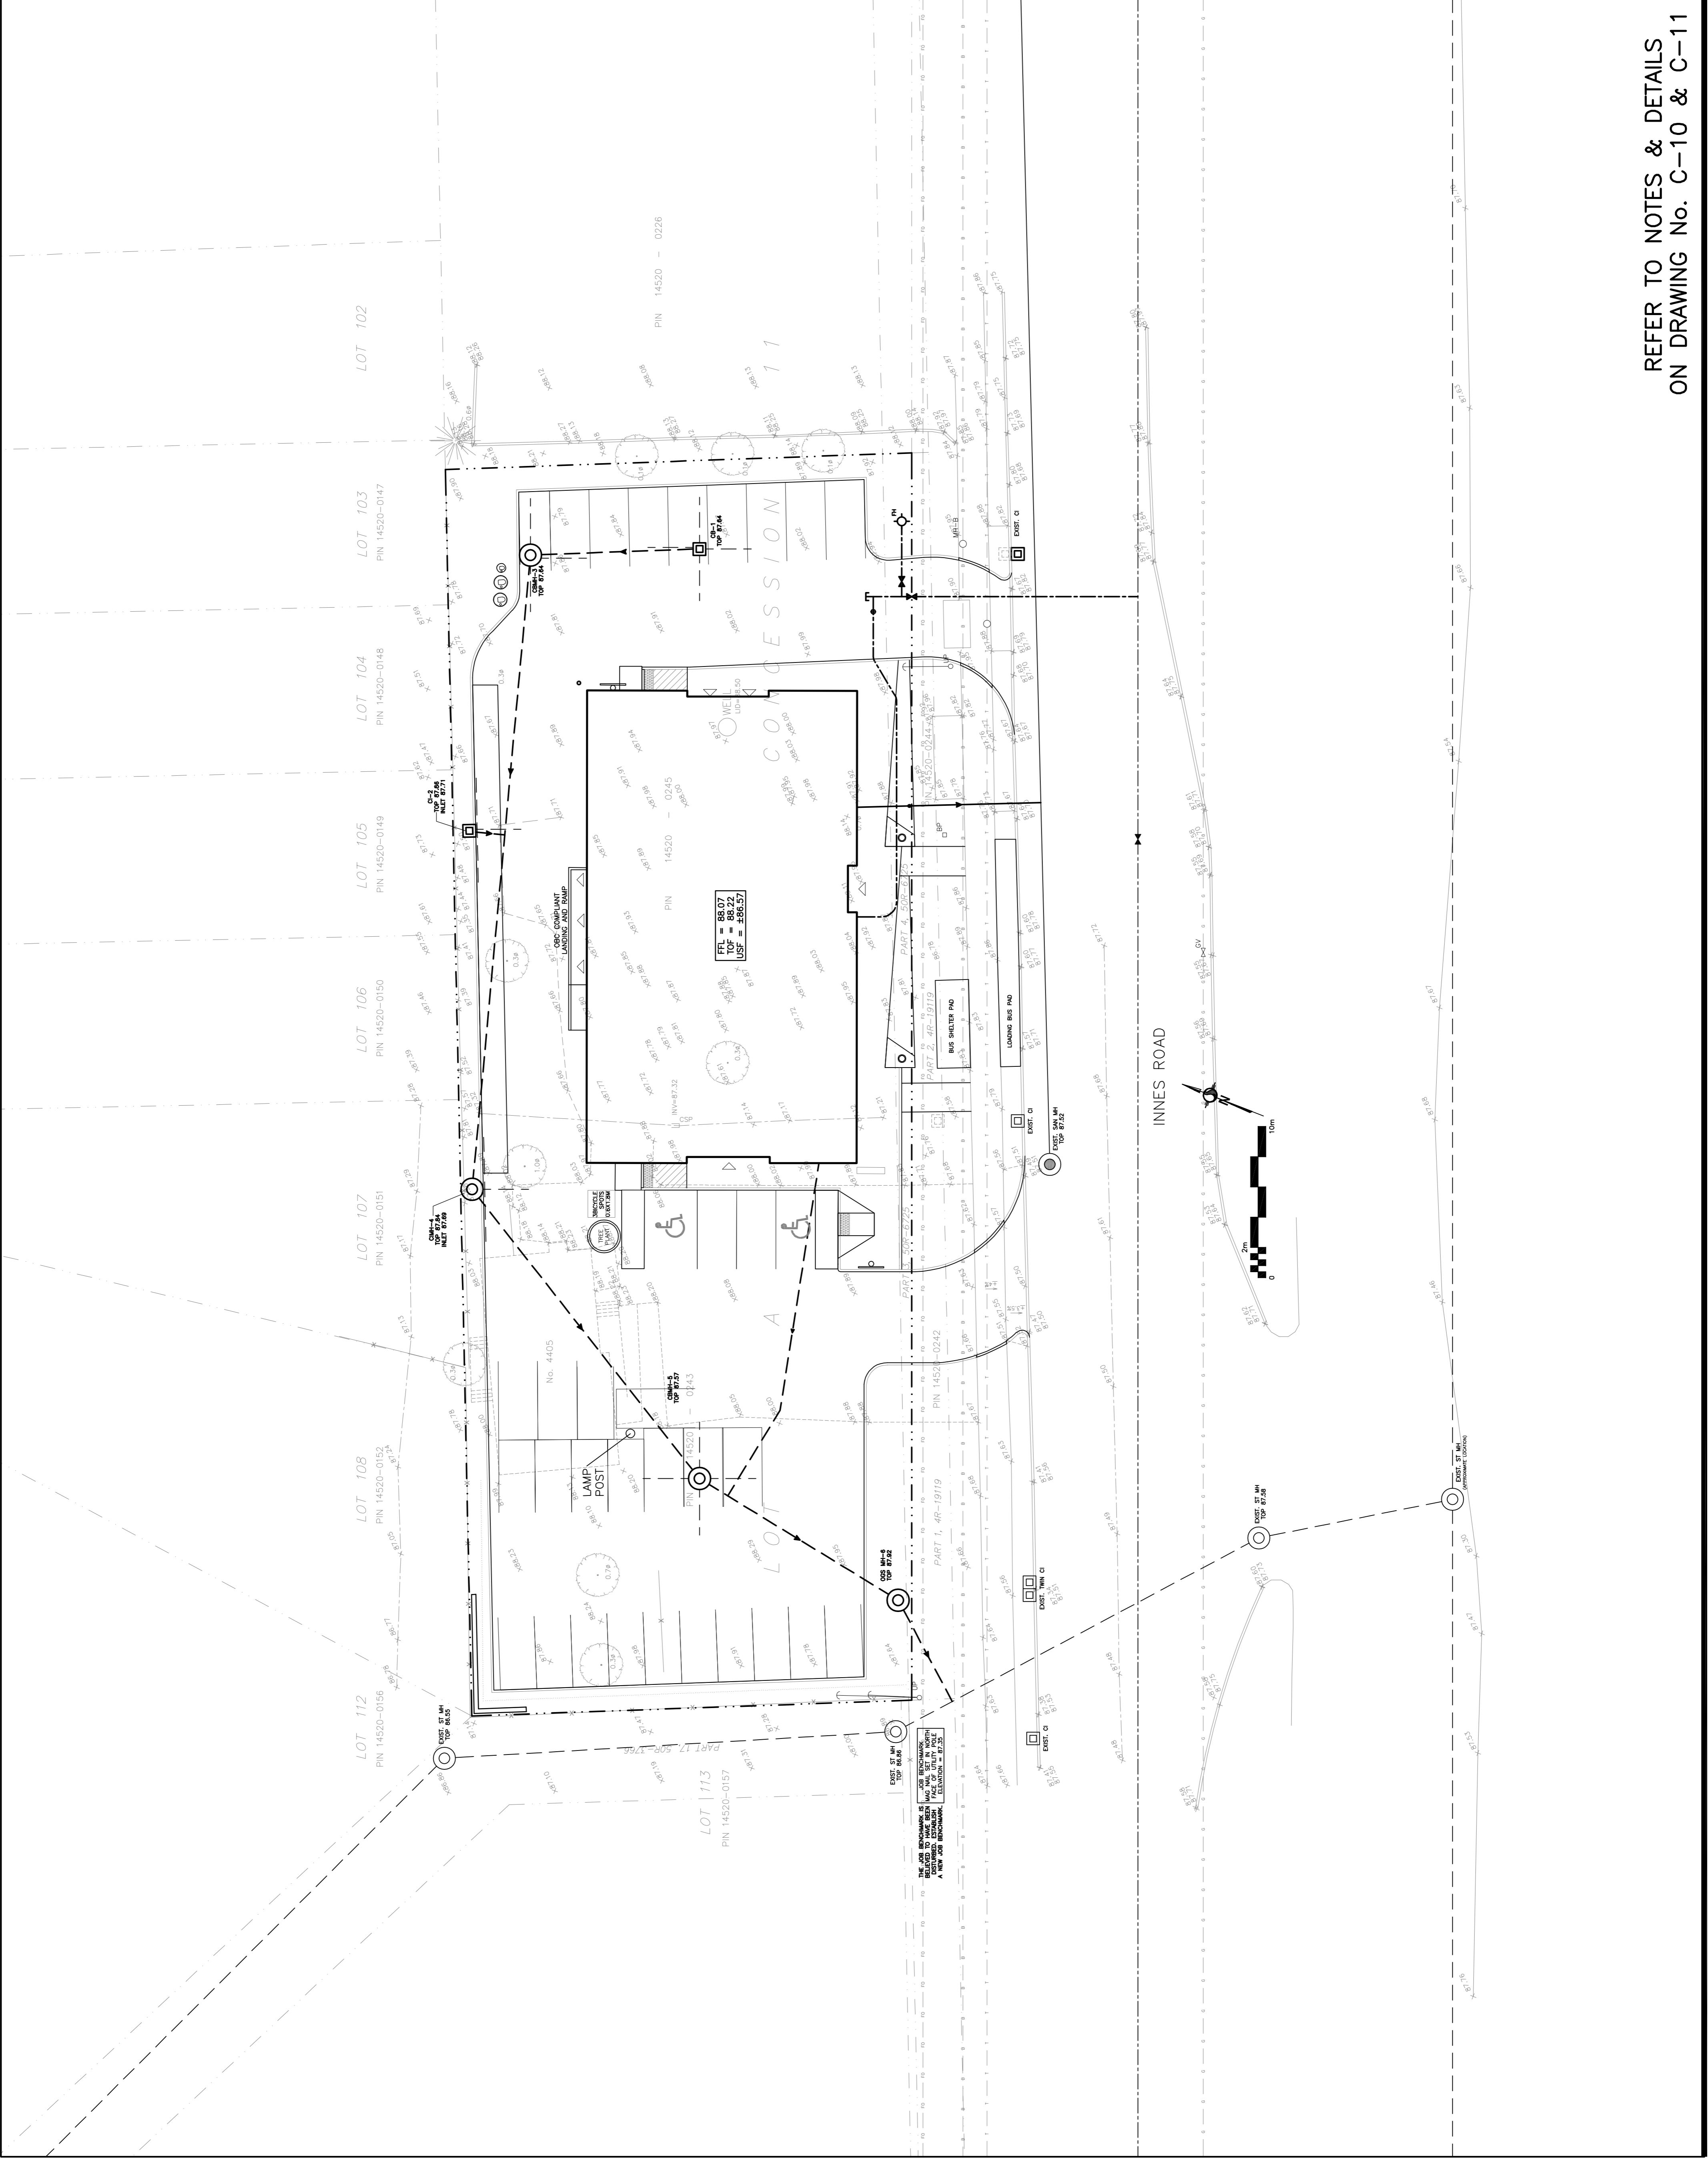

REFER TO NOTES & DETAILS
 ON DRAWING No. C-10 & C-11