


















THRUST BLOCK DIMENSION TABLES FOR PVC AND DI PIPE 400mm AND UNDER

PIPE SIZE (mm)	THRUST BLOCK WIDTH (mm)	THRUST BLOCK LENGTH (mm)	THRUST BLOCK HEIGHT (mm)
100	100	100	100
150	150	150	150
200	200	200	200
250	250	250	250
300	300	300	300
350	350	350	350
400	400	400	400

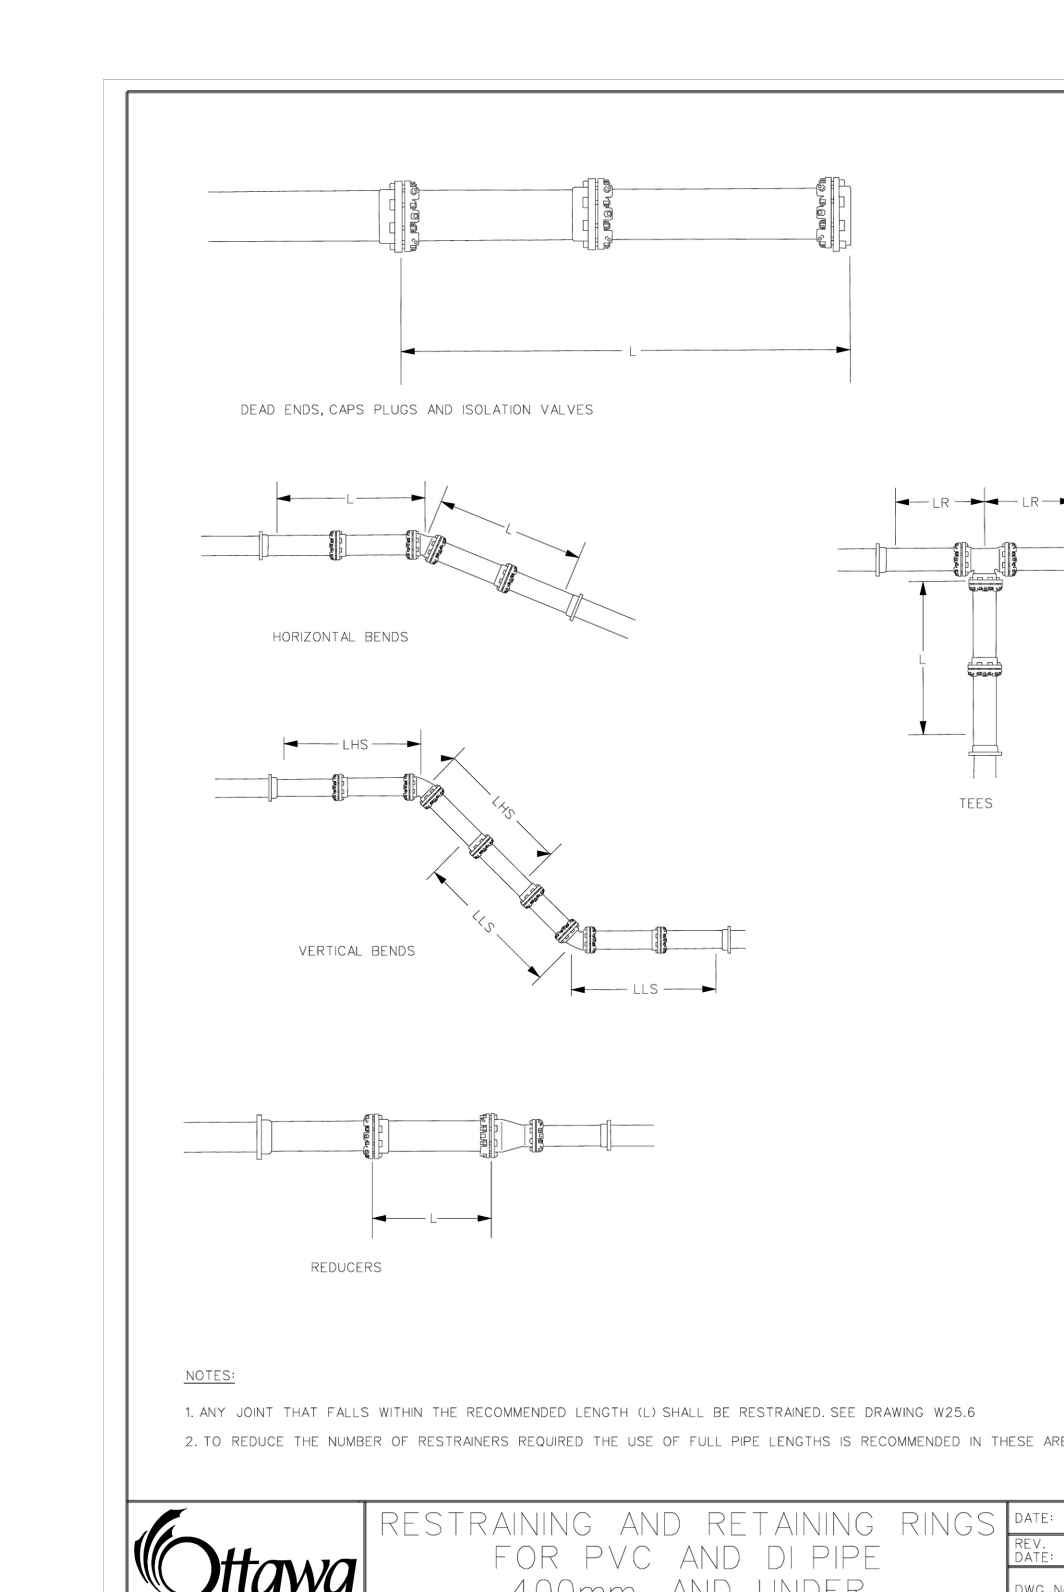

TABLES OF RESTRAINED LENGTHS FOR PVC AND DI PIPE 400mm AND UNDER

PIPE SIZE (mm)	RESTRAINED LENGTH (mm)
100	100
150	150
200	200
250	250
300	300
350	350
400	400

 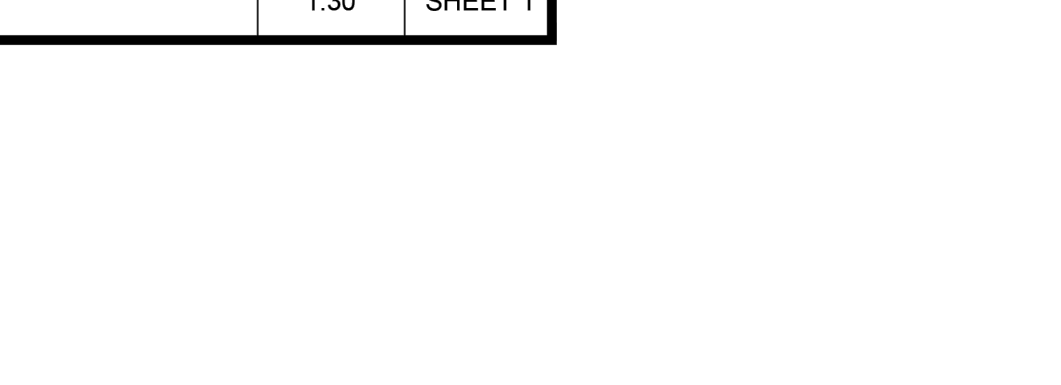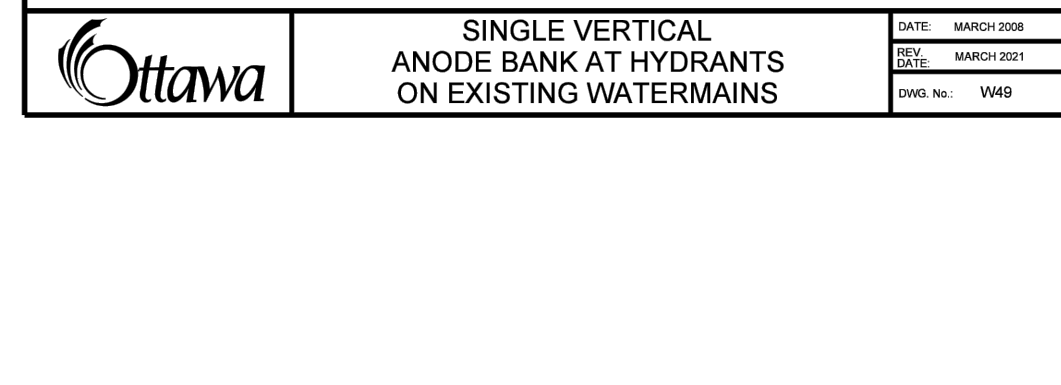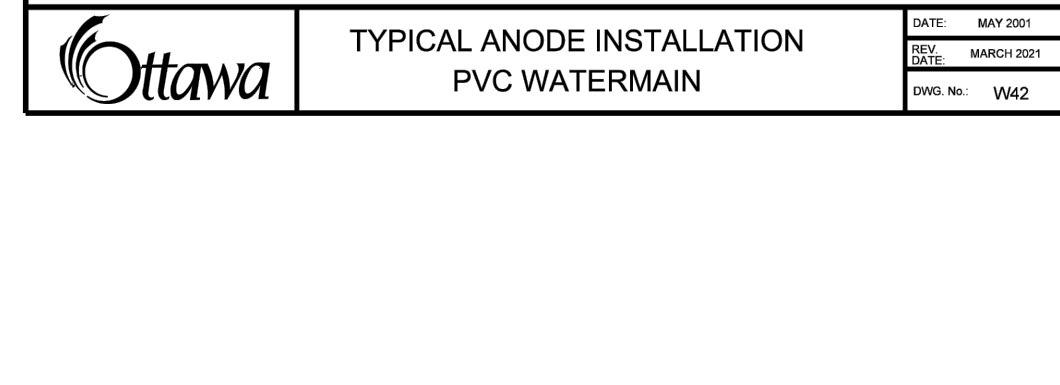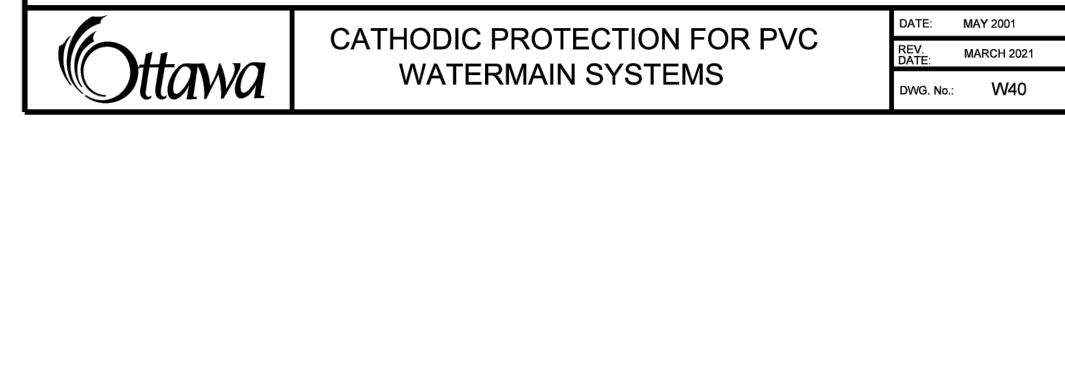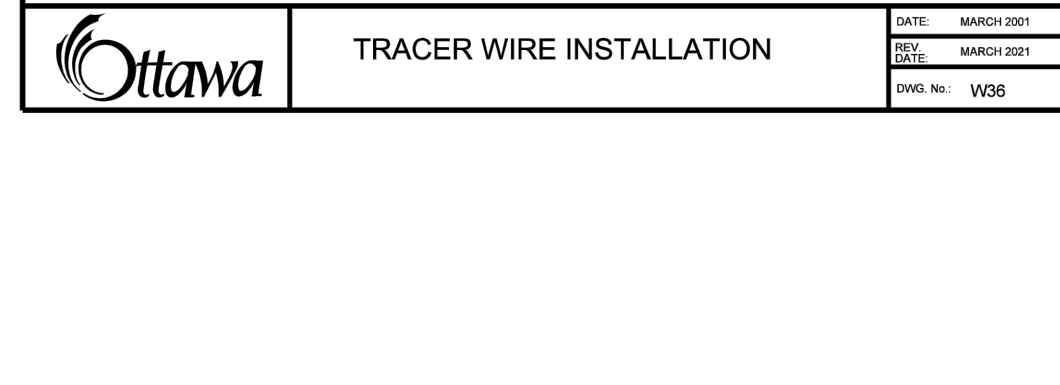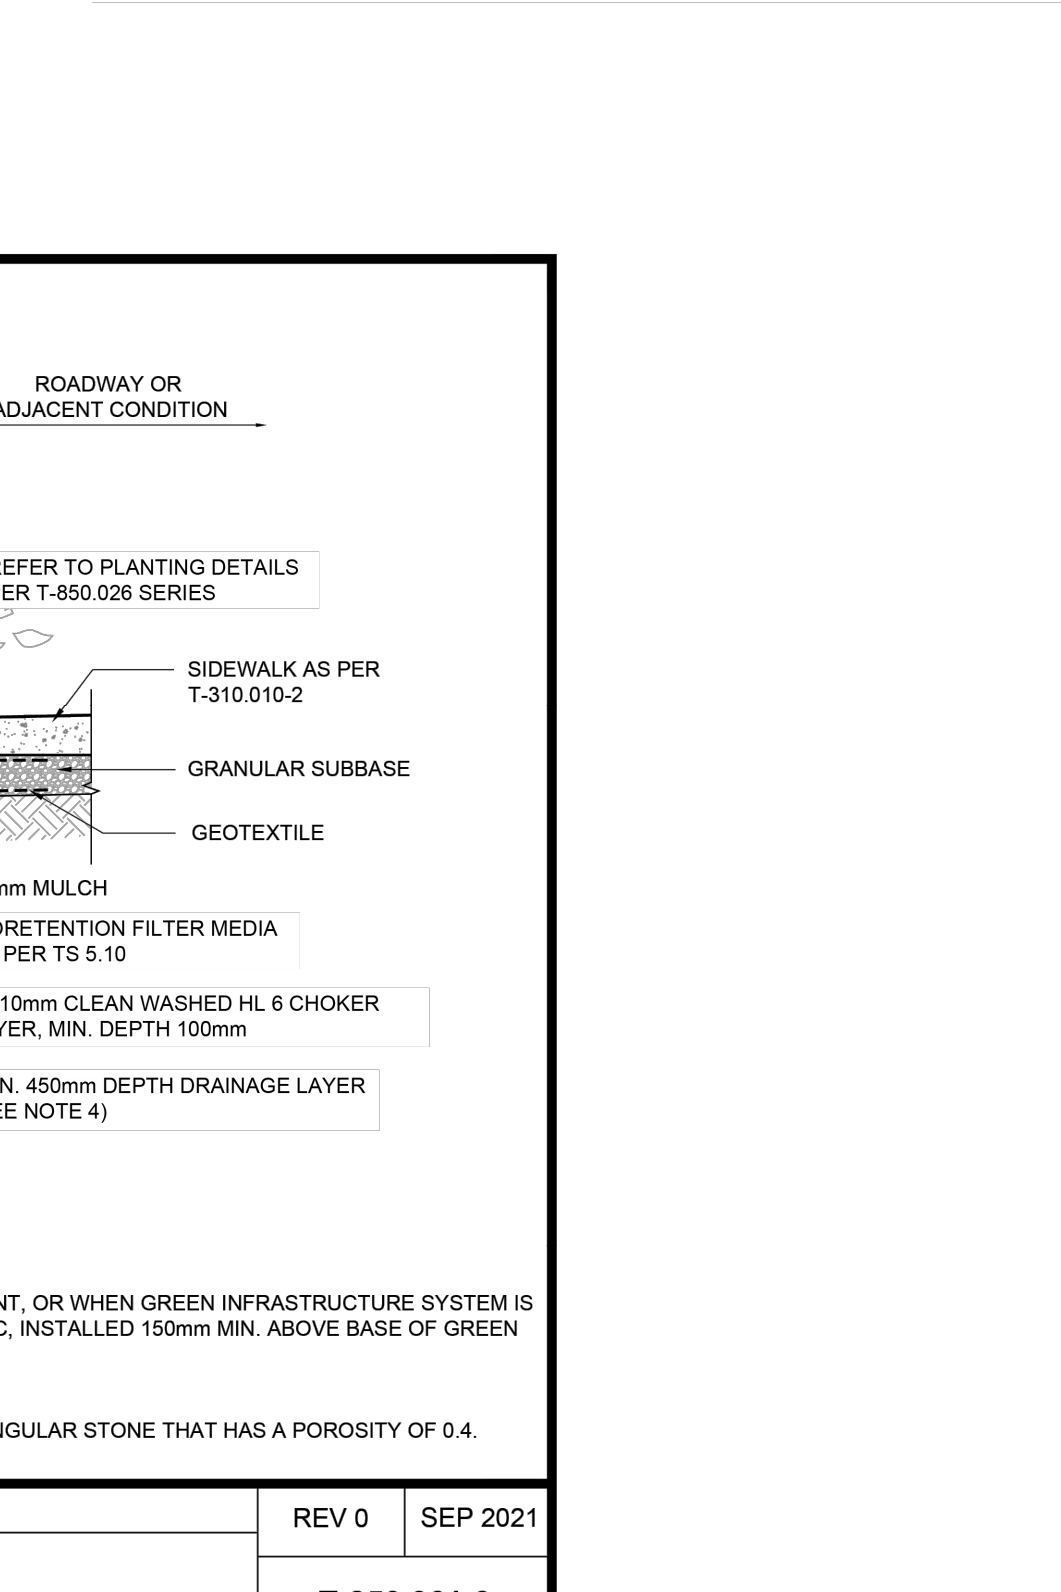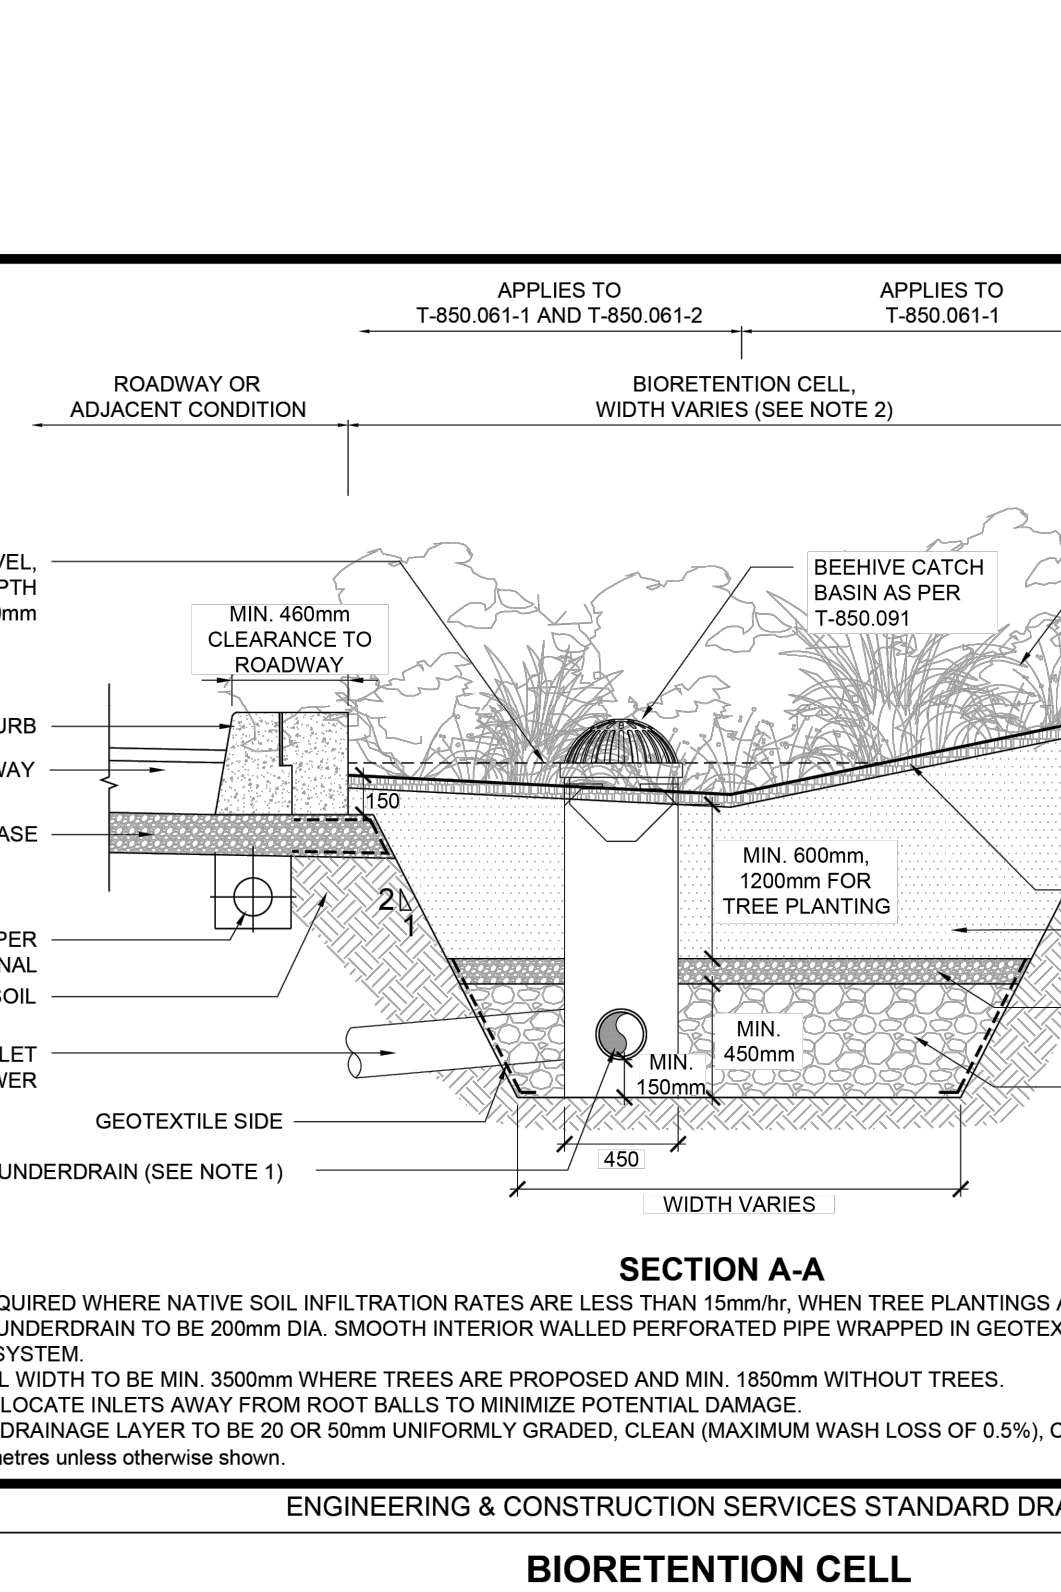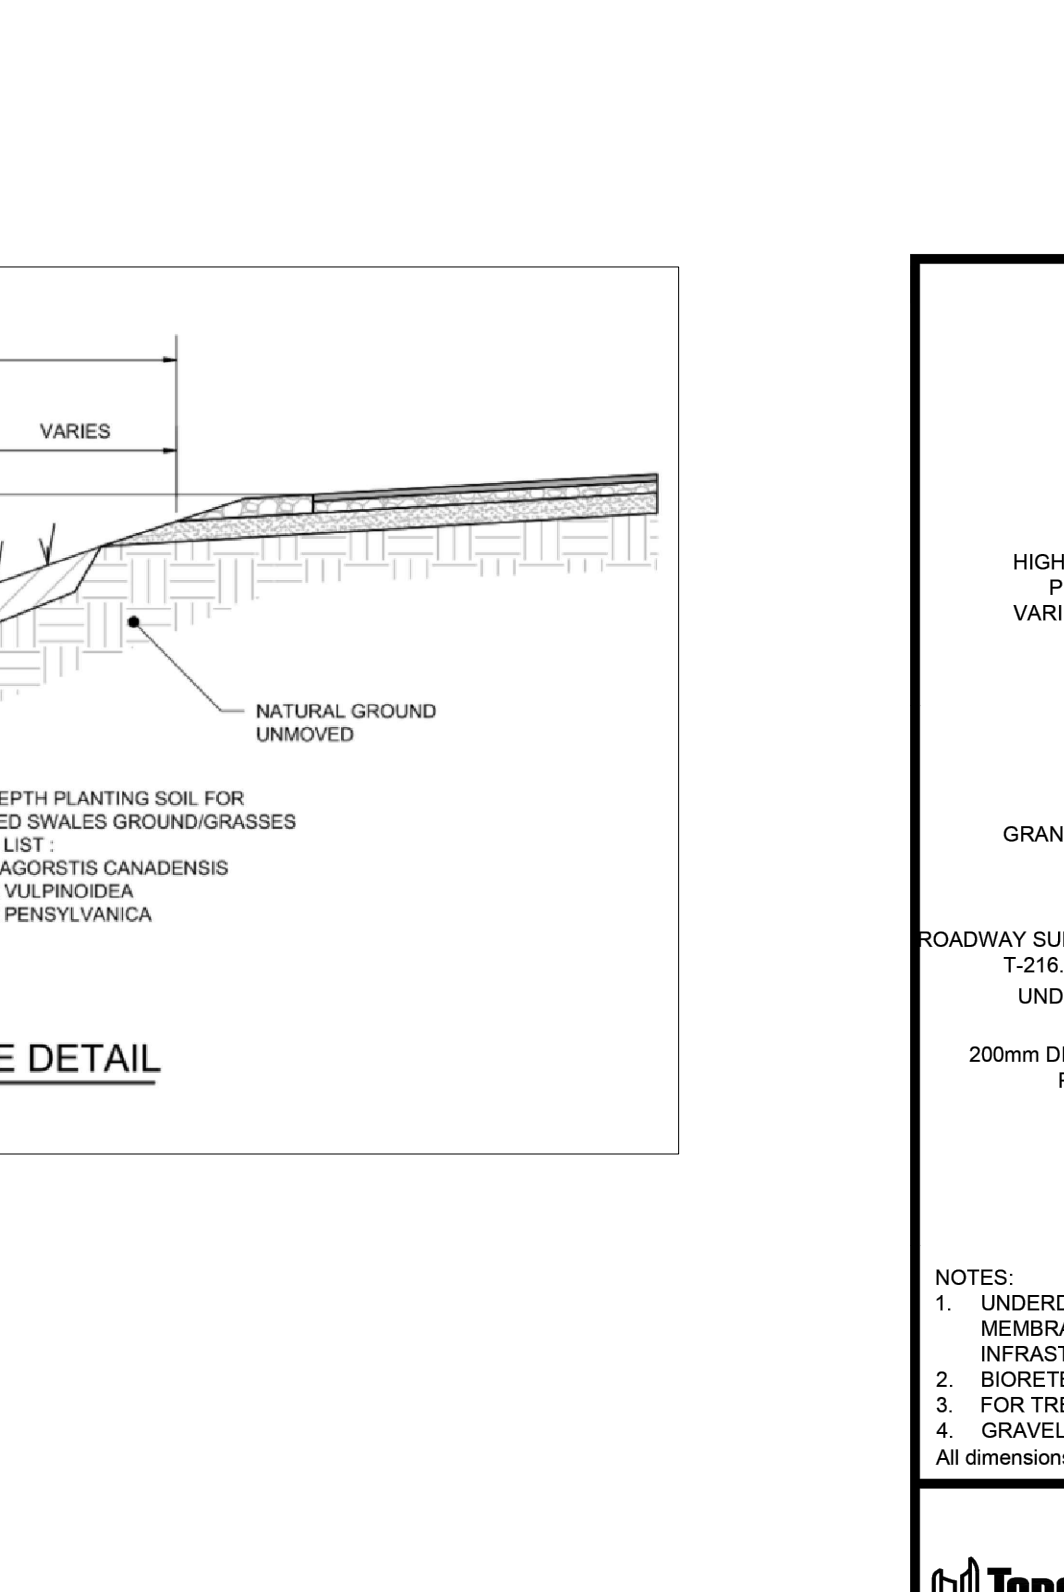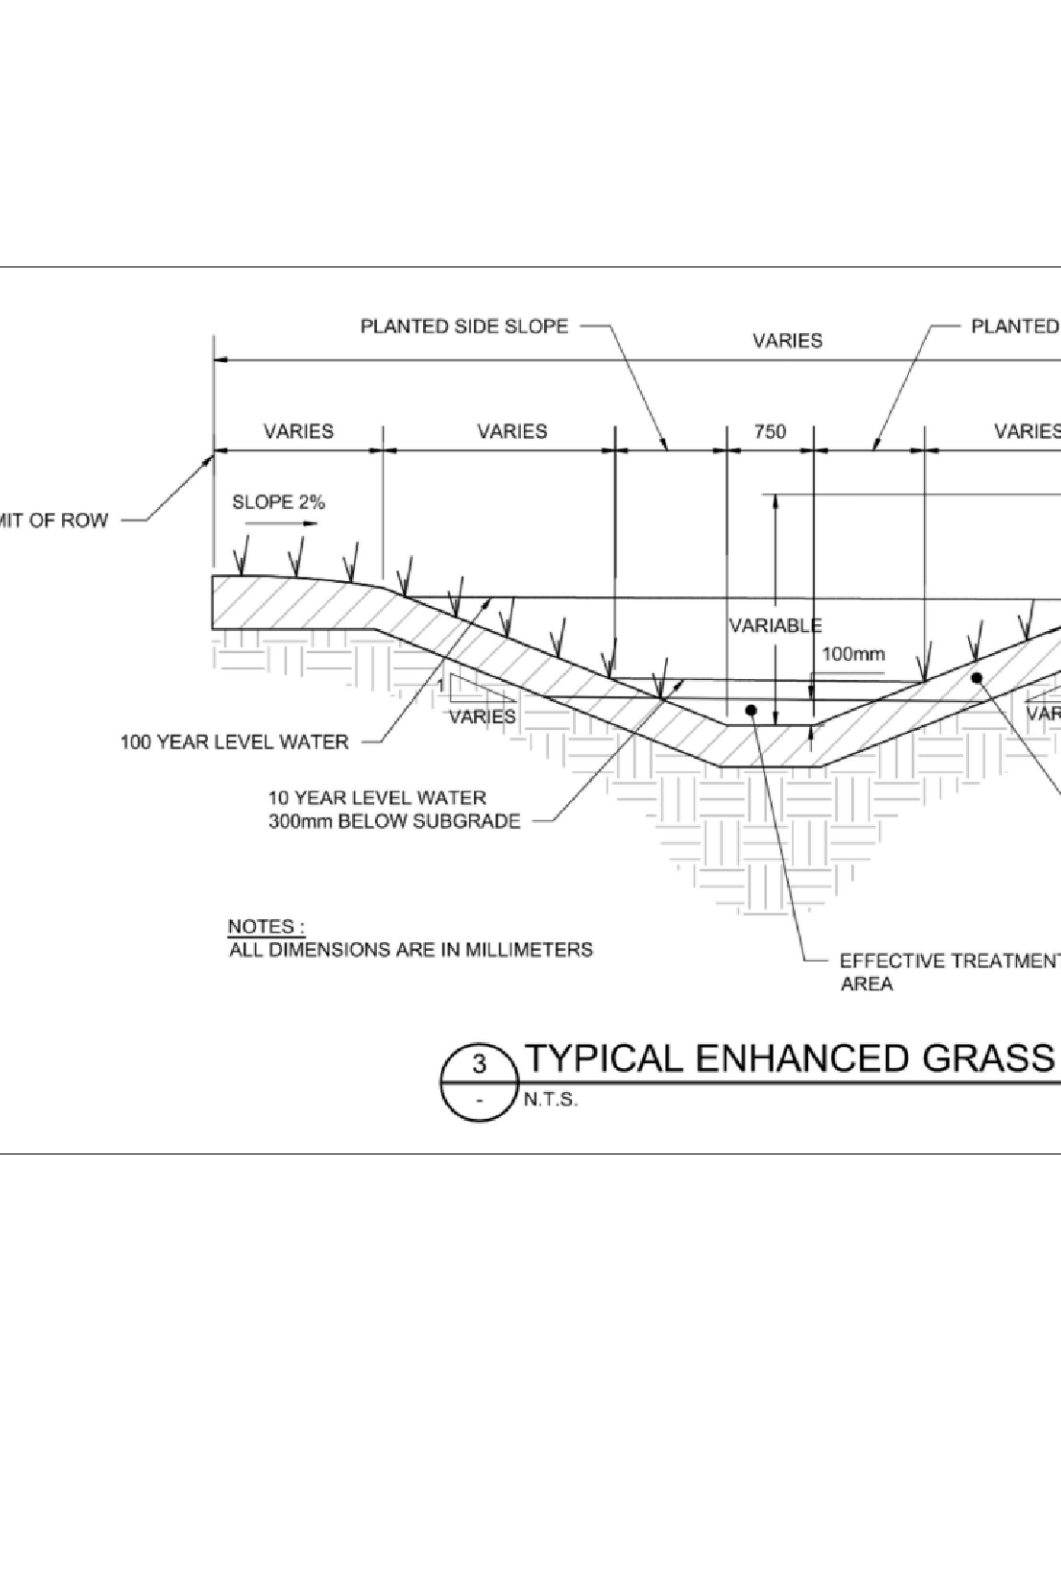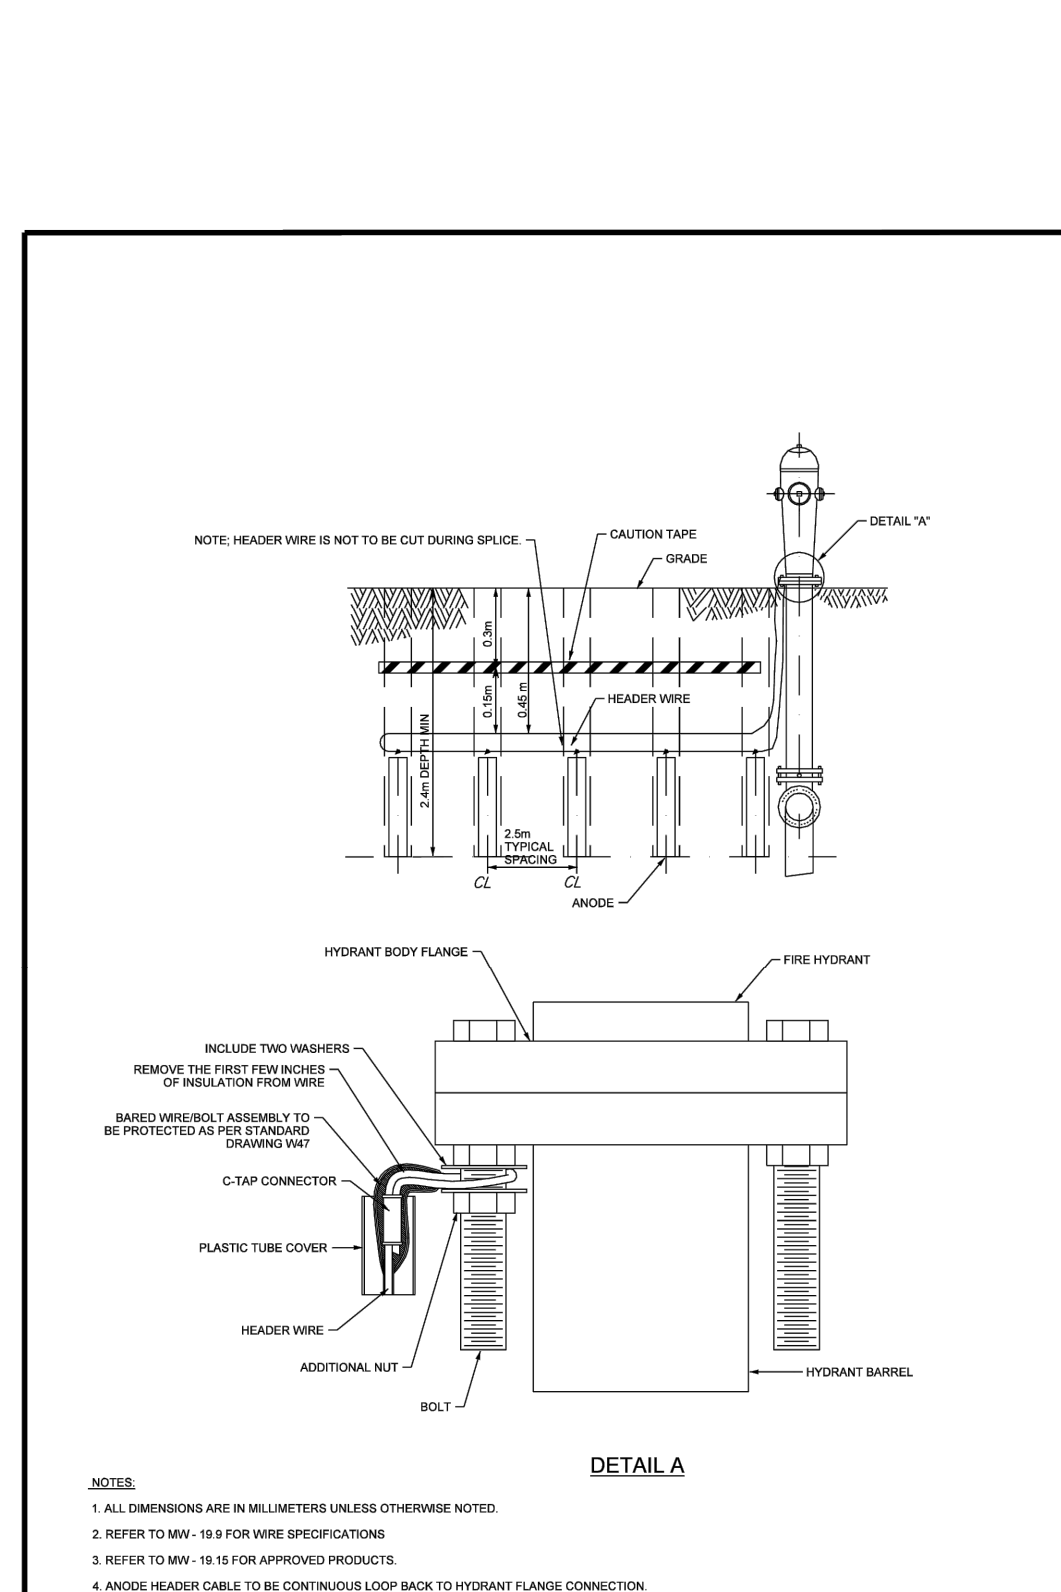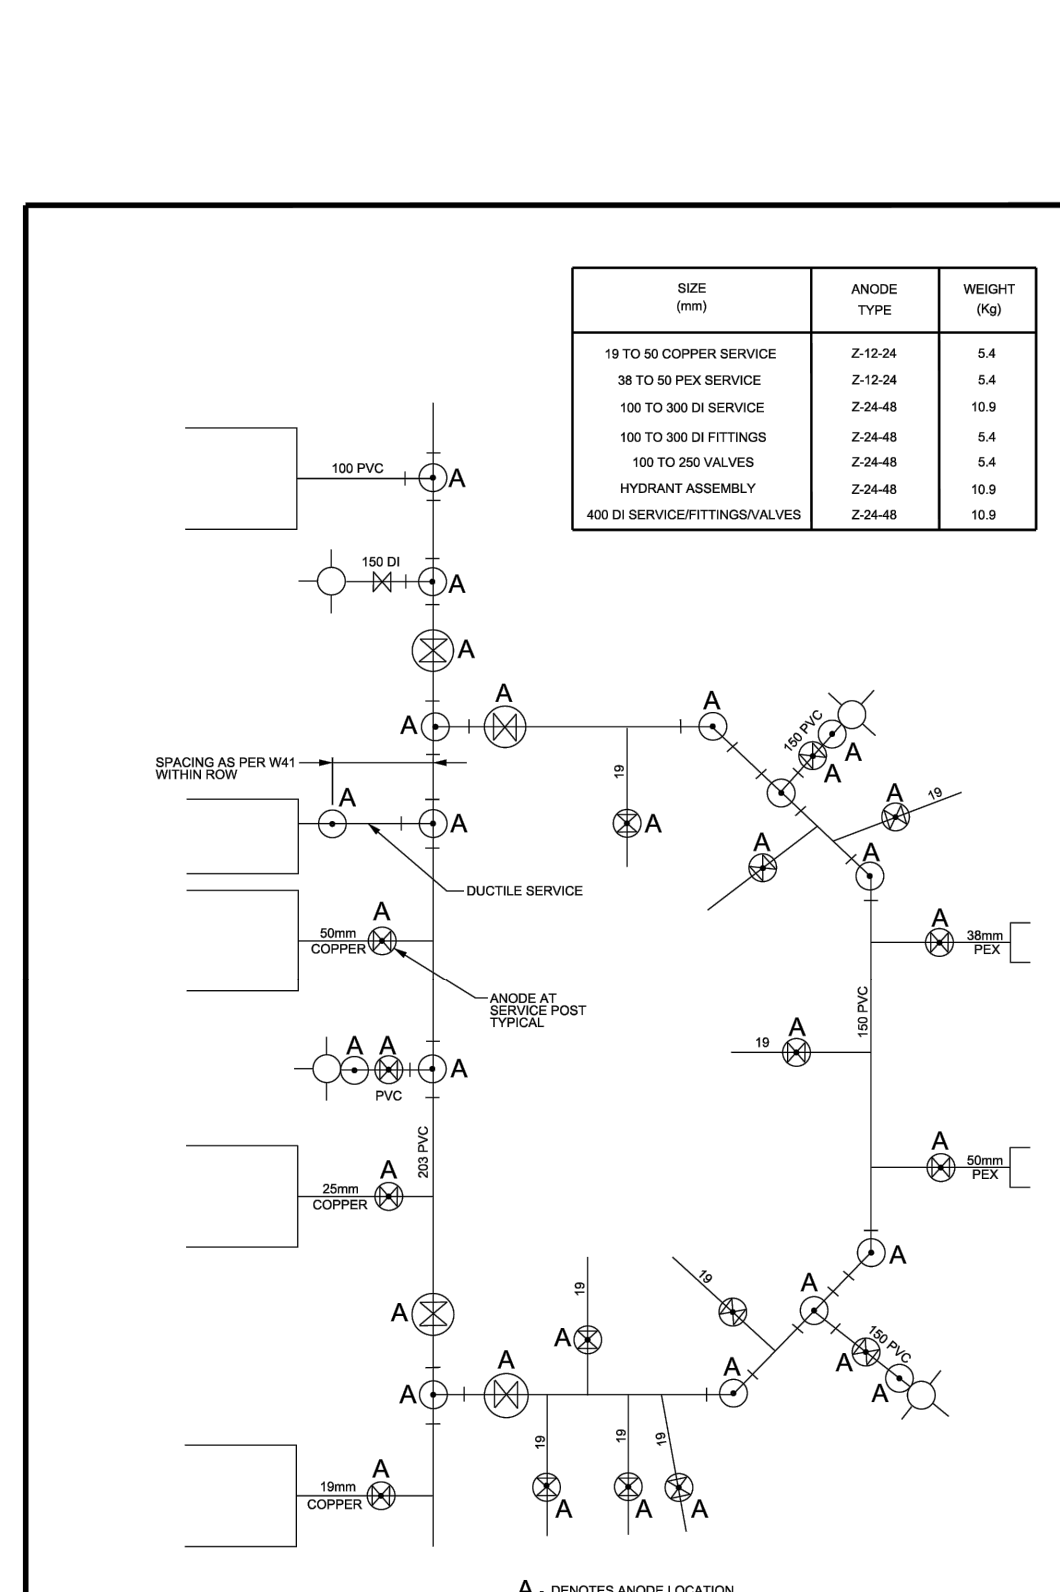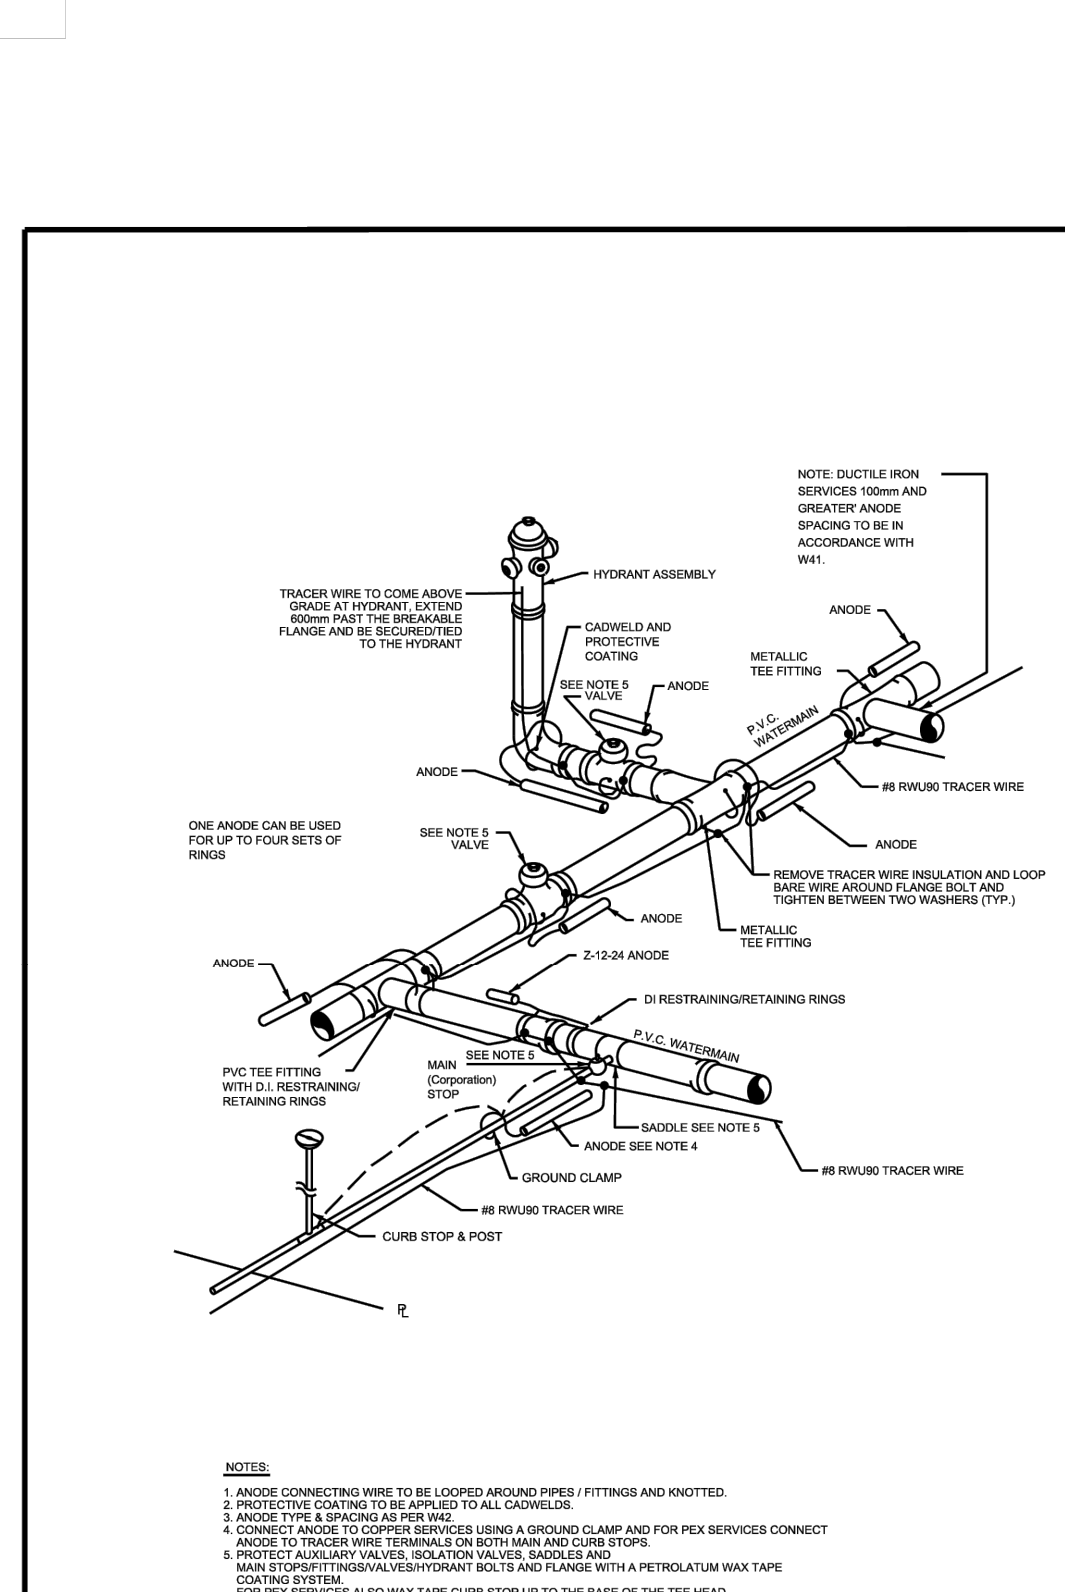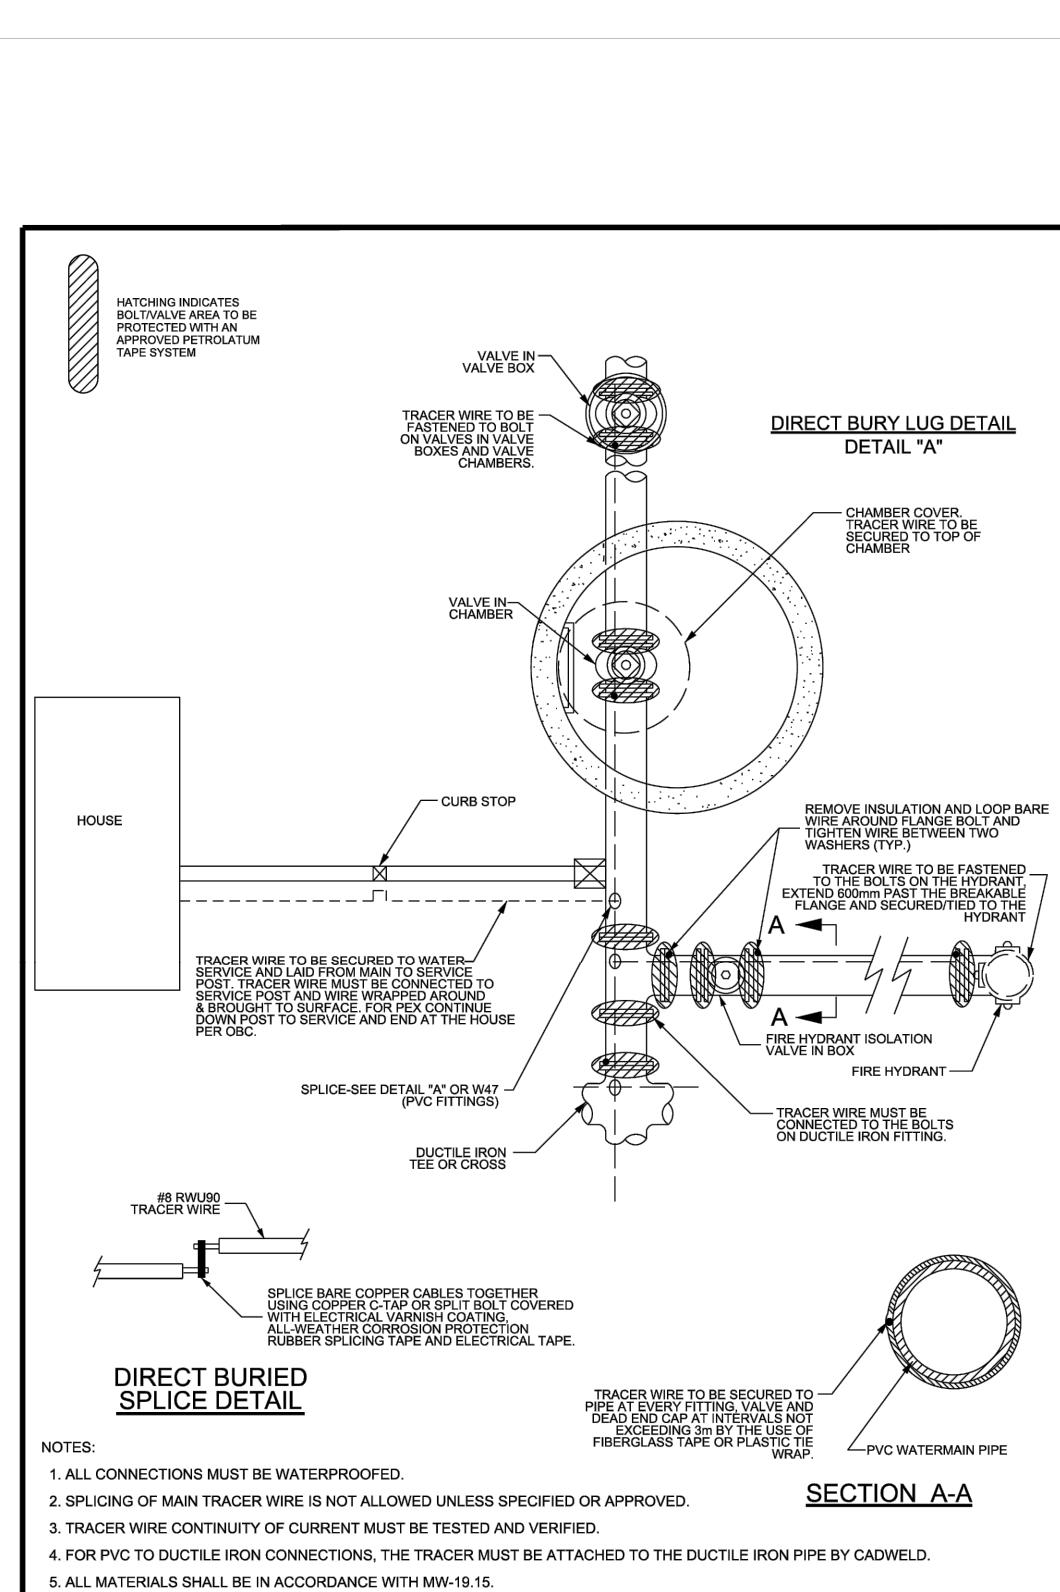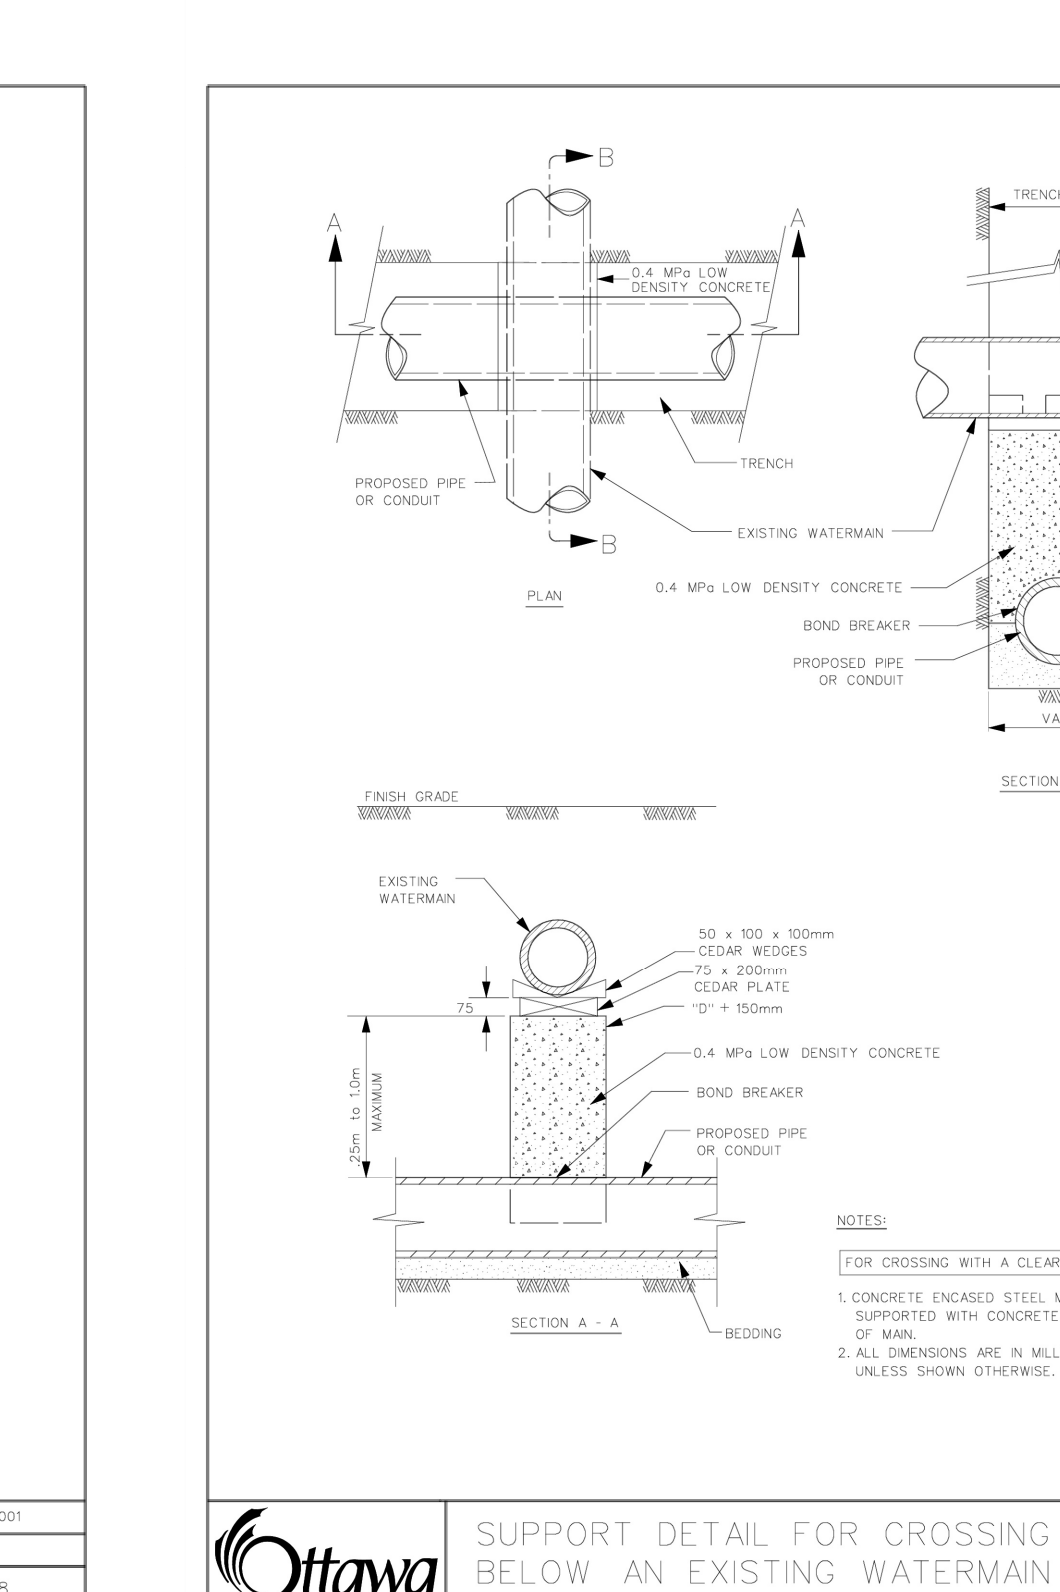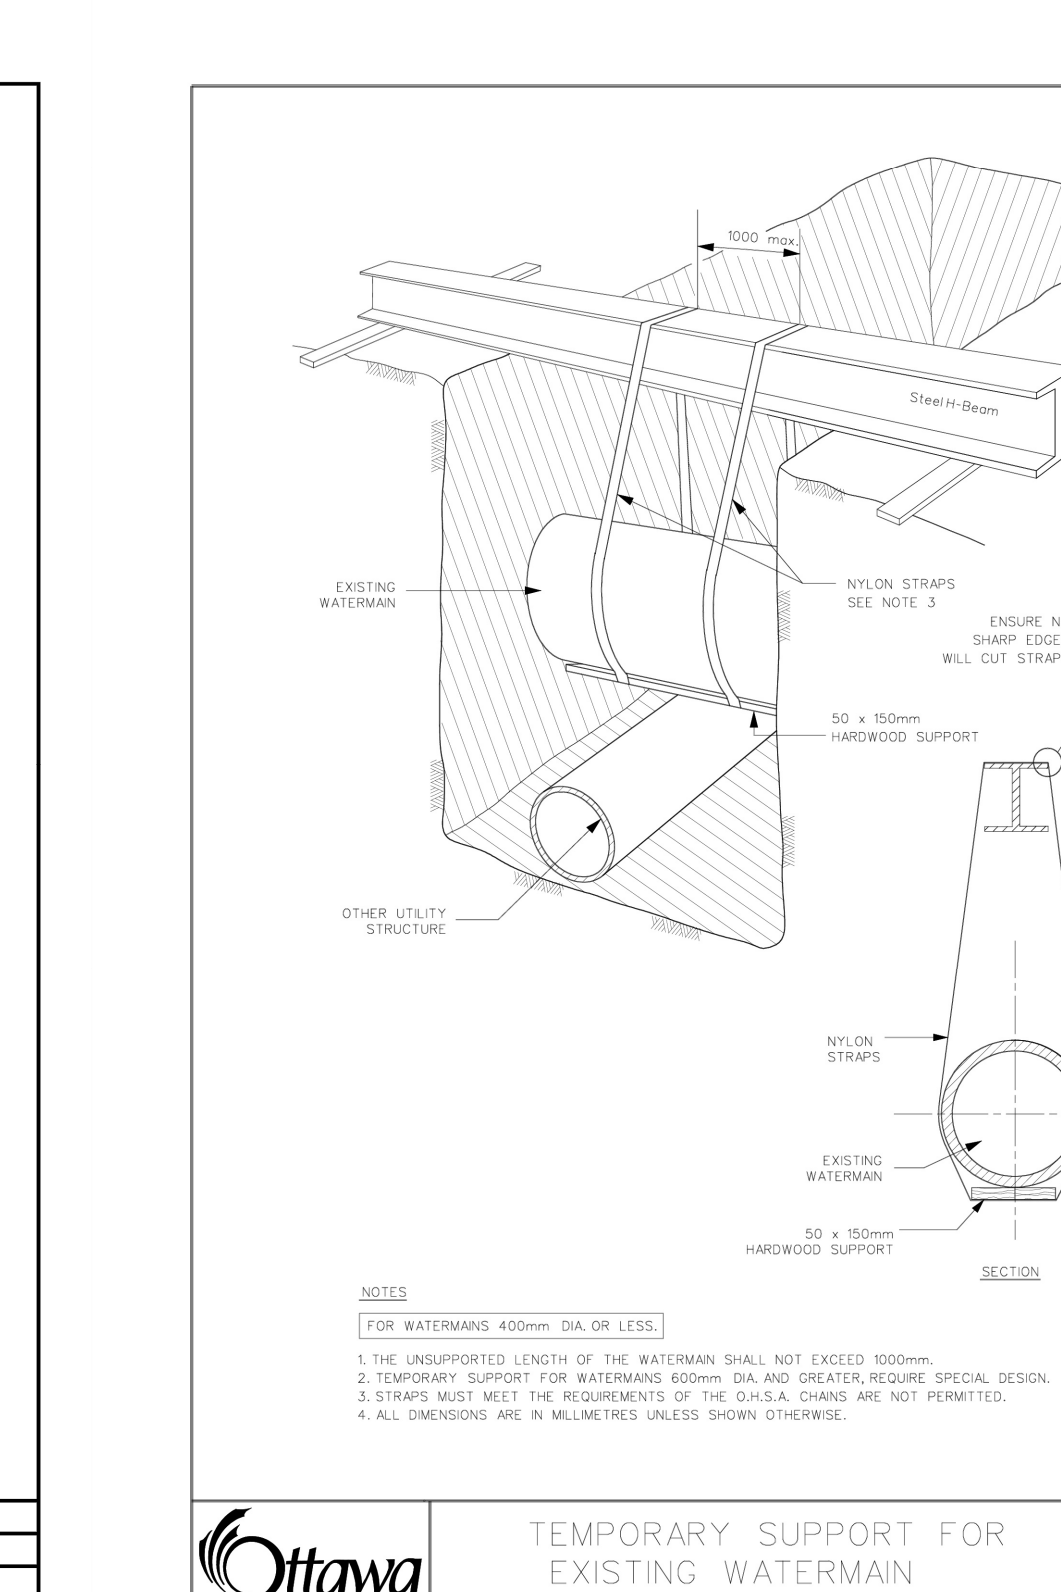

THE OTTAWA HOSPITAL NEW CAMPUS DEVELOPMENT - PHASE 4 MAIN HOSPITAL BUILDING

900 CARLING AVE, OTTAWA, ONTARIO

CLIENT: The Ottawa Hospital / L'Hôpital d'Ottawa

Infrastructure Ontario

PCL CONSTRUCTION / EllisDon

CLIENT PROJECT NO: 1070002

KEY PLAN: PROJECT NORTH

10 SITE PLAN CONTROL RESUBMISSION 2020-03-27

09 DESIGN BUILD BASELINE SUBMISSION 2020-03-05

07 FOUNDATION PERMIT SUBMISSION 2020-01-12

07 SITE PLAN CONTROL RESUBMISSION 2020-01-12

06 80% DO SUBMISSION 2020-09-19

05 SITE PLAN CONTROL RESUBMISSION 2020-06-05

04 60% DO SUBMISSION 2020-06-05

03 35% DO SUBMISSION 2020-07-28

02 ISSUED FOR ACP/R READINESS 2020-01-08

01 80% DO SUBMISSION 2020-08-15

REVISED DATE

REVISIONS

NOT FOR CONSTRUCTION

DISCREPANCIES MUST BE REPORTED IMMEDIATELY TO THE ARCHITECT BEFORE PROCEEDING. ONLY FIGURED DIMENSIONS ARE TO BE USED. CONTRACTORS MUST CHECK ALL DIMENSIONS ON SITE. THIS DRAWING IS PROTECTED BY COPYRIGHT.

ALL DIMENSIONS ARE SHOWN IN METRIC.

AUTHOR: wsp

PROJECT TEAM

DESIGN BUILDER: POLEJO & JOINT VENTURE

ARCHITECT: PARRON ARCHITECTS LIMITED, JOON LAMARIE PRATTE ARCHITECTES, ADAMSON ASSOCIATES ARCHITECTS, 888 ARCHITECTS OTTAWA INC.

STRUCTURAL: SIALS OPEN CANADA INC., BOUTHILLETTE FARGEAU INC.

MECHANICAL: HH ANGUS & ASSOCIATES LTD., SIALS OPEN CANADA INC.

ELECTRICAL: HUXLEY & BARN INTERNATIONAL INC.

CIVIL: HOP CHANG INC.

LANDSCAPE: VERTICUS DESIGN INC., PWP LANDSCAPE ARCHITECTURE

BUILDING CODE: UMG BUILDING CODE CONSULTANTS LTD.

AUTHOR PROJECT NO: CA0027758.0-51

STAMP

DRAWING TITLE: DETAILS 2 OF 2

DRAWN: L. CURELY / B. NANDAL, CHECKED: C. GRAHAM

SCALE: AS SHOWN

DATE: 2024-02-26

GRAPHIC SCALE

DRAWING NO: C1-901, REV NO: 10

File Number: D07-12-26-0008 (Revision) D07-12-23-0168 (Original) Plan Number: 19424