


- DOW'S LAKE OUTLET
- NEPEAN BAY TRUNK
- CARLING AVENUE
- PRESTON STREET

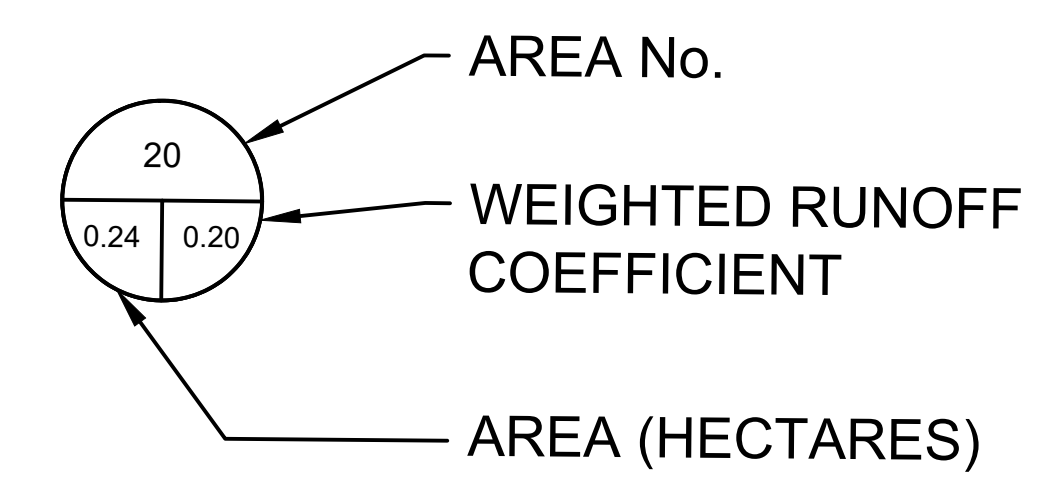

**THE OTTAWA HOSPITAL
NEW CAMPUS
DEVELOPMENT -
PHASE 4 MAIN HOSPITAL
BUILDING**

900 CARLING AVE, OTTAWA, ONTARIO

CLIENT: The Ottawa Hospital | L'Hôpital d'Ottawa

CONSTRUCTION: PCL | EllisDon

CLIENT PROJECT NO: 1070002

KEY PLAN: TRUE NORTH | PROJECT NORTH

NO.	DESCRIPTION	DATE
15	SITE PLAN CONTROL RESUBMISSION NO	2026-03-27
09	DESIGN BUILD BASELINE SUBMISSION	2026-03-05
08	FOUNDATION PERMIT SUBMISSION	2026-01-10
07	SITE PLAN CONTROL RESUBMISSION	2026-01-10
06	80% DD SUBMISSION	2025-09-19
05	SITE PLAN CONTROL RESUBMISSION	2025-09-25
04	60% DD SUBMISSION	2025-08-25
03	35% DD SUBMISSION	2025-07-28
02	ISSUED FOR ACIP READINESS	2025-01-28
01	80% SD SUBMISSION	2024-08-15
02	REVISED	DATE

REVISIONS

NOT FOR CONSTRUCTION

DISCREPANCIES MUST BE REPORTED IMMEDIATELY TO THE ARCHITECT BEFORE PROCEEDING. ONLY FIGURED DIMENSIONS ARE TO BE USED. CONTRACTORS MUST CHECK ALL DIMENSIONS ON SITE. THIS DRAWING IS PROTECTED BY COPYRIGHT.

ALL DIMENSIONS ARE SHOWN IN METRIC.

AUTHOR:

PROJECT TEAM

DESIGN BUILDER: POLED, A JOINT VENTURE

ARCHITECTURAL: PARKIN ARCHITECTS LIMITED
JOZSEF LAMARIE PRATTE ARCHITECTES
ADAMSON ASSOCIATES ARCHITECTS
RBS ARCHITECTS OTTAWA INC.

STRUCTURAL: SIALO-GIBBEN CANADA INC.
BOUHELLETTE PARISAU INC.

MECHANICAL: HJ ANGLUS & ASSOCIATES LTD.
SALAS GIBBEN CANADA INC.

ELECTRICAL: MCELVEY & BARNUM INTERNATIONAL INC.
HEP CANADA INC.

CIVIL: VERTECOSS DESIGN INC.
PIP LANDSCAPE ARCHITECTURE

BUILDING CODE: UMO BUILDING CODE CONSULTANTS LTD.

AUTHOR PROJECT NO: CA0027758.0-51

STAMP: STAMP

DRAWING TITLE: **POST-DEVELOPMENT DRAINAGE PLAN**

DRAWN: L. CURLEY / B. NANDLAL | CHECKED: C. GRAHAM

SCALE AT 47' x 60": 1/8" = 1'-0" | DATE: 2024-02-26

GRAPHIC SCALE: 1/8" = 1'-0"

DRAWING NO: C4-201 | REV NO: 10

File Number: D07-12-26-0008 (Revision)
D07-12-23-0168 (Original)
Plan Number: 19424