


- DOW'S LAKE OUTLET
- NEPEAN BAY TRUNK
- CARLING AVENUE
- PRESTON STREET

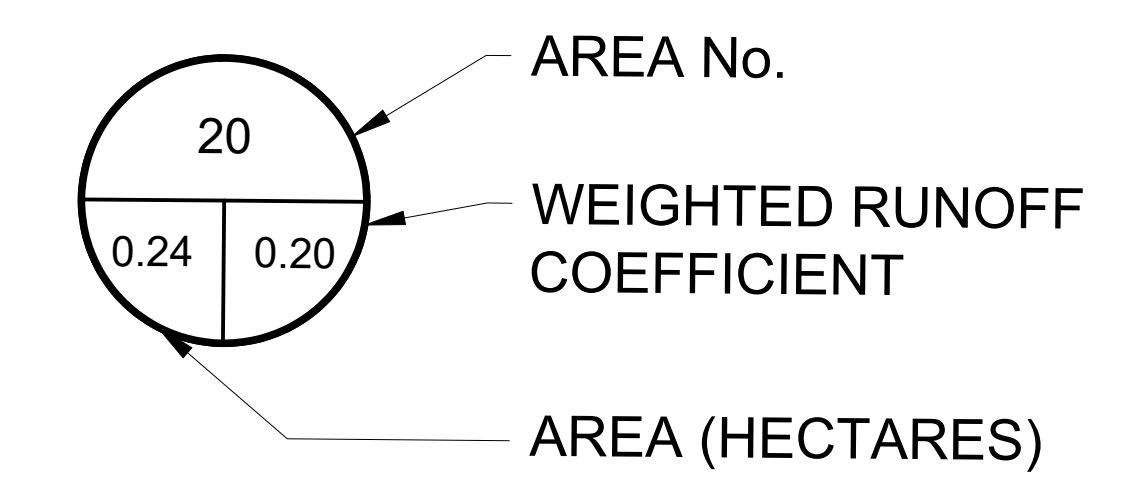

**THE OTTAWA HOSPITAL  
NEW CAMPUS  
DEVELOPMENT -  
PHASE 4 MAIN HOSPITAL  
BUILDING**

900 CARLING AVE, OTTAWA, ONTARIO

CLIENT: The Ottawa Hospital | L'Hôpital d'Ottawa

Infrastructure Ontario

PCL CONSTRUCTION | EllisDon

CLIENT PROJECT NO: 1070002

KEY PLAN: TRUE NORTH, PROJECT NORTH

13	SITE PLAN CONTROL RESUBMISSION NO.	2026-03-27
09	DESIGN-BUILD BASELINE SUBMISSION	2026-03-05
08	FOUNDATION PERMIT SUBMISSION	2026-01-12
07	SITE PLAN CONTROL RESUBMISSION	2026-01-12
06	80% DO SUBMISSION	2025-09-19
05	SITE PLAN CONTROL RESUBMISSION	2025-09-19
04	60% DO SUBMISSION	2025-06-05
03	30% DO SUBMISSION	2025-01-28
02	ISSUED FOR ACQP READINESS	2025-01-28
01	80% SD SUBMISSION	2024-08-15
N2	REVISED	DATE

DRAWING STATUS: **NOT FOR CONSTRUCTION**

DISCREPANCIES MUST BE REPORTED IMMEDIATELY TO THE ARCHITECT BEFORE PROCEEDING. ONLY FIGURED DIMENSIONS ARE TO BE USED. CONTRACTORS MUST CHECK ALL DIMENSIONS ON SITE. THIS DRAWING IS PROTECTED BY COPYRIGHT.

ALL DIMENSIONS ARE SHOWN IN METRIC.

AUTHOR: **wsp**

PROJECT TEAM:

DESIGN-BUILDER: POLARIS A JOINT VENTURE  
 ARCHITECTURAL: PARSON ARCHITECTS LIMITED, JOZON LAMARQUE PRATTE ARCHITECTES, ADAMSON ASSOCIATES ARCHITECTS  
 STRUCTURAL: S&S ARCHITECTS OTTAWA INC., S&S ARCHITECTS OTTAWA INC.  
 MECHANICAL: HJ ANGLIS & ASSOCIATES LTD., SALAS GREEN CANADA INC.  
 ELECTRICAL: MCELVEY & BARNUM INTERNATIONAL INC., HEP CANADA INC.  
 CIVIL: HEP CANADA INC.  
 LANDSCAPE: VERTICOS DESIGN INC., P&P LANDSCAPE ARCHITECTURE

BUILDING CODE: UMCG BUILDING CODE CONSULTANTS LTD.

AUTHOR PROJECT NO.: CA0027758.0-51

DRAWING TITLE: **PRE-DEVELOPMENT DRAINAGE PLAN**

DRAWN: L. CURLEY / B. NANDLAL | CHECKED: C. GRAHAM

SCALE AT 47° 48' P: 1:750 | DATE: 2024-02-28

GRAPHIC SCALE: 1:250

FILE NUMBER: D07-12-26-0008 (Revision)  
 D07-12-23-0168 (Original)  
 Plan Number: 19424

DRAWING NO.: **C4-200** | REV NO.: 10