


SOUTH MARCH BESS CIVIL PACKAGE

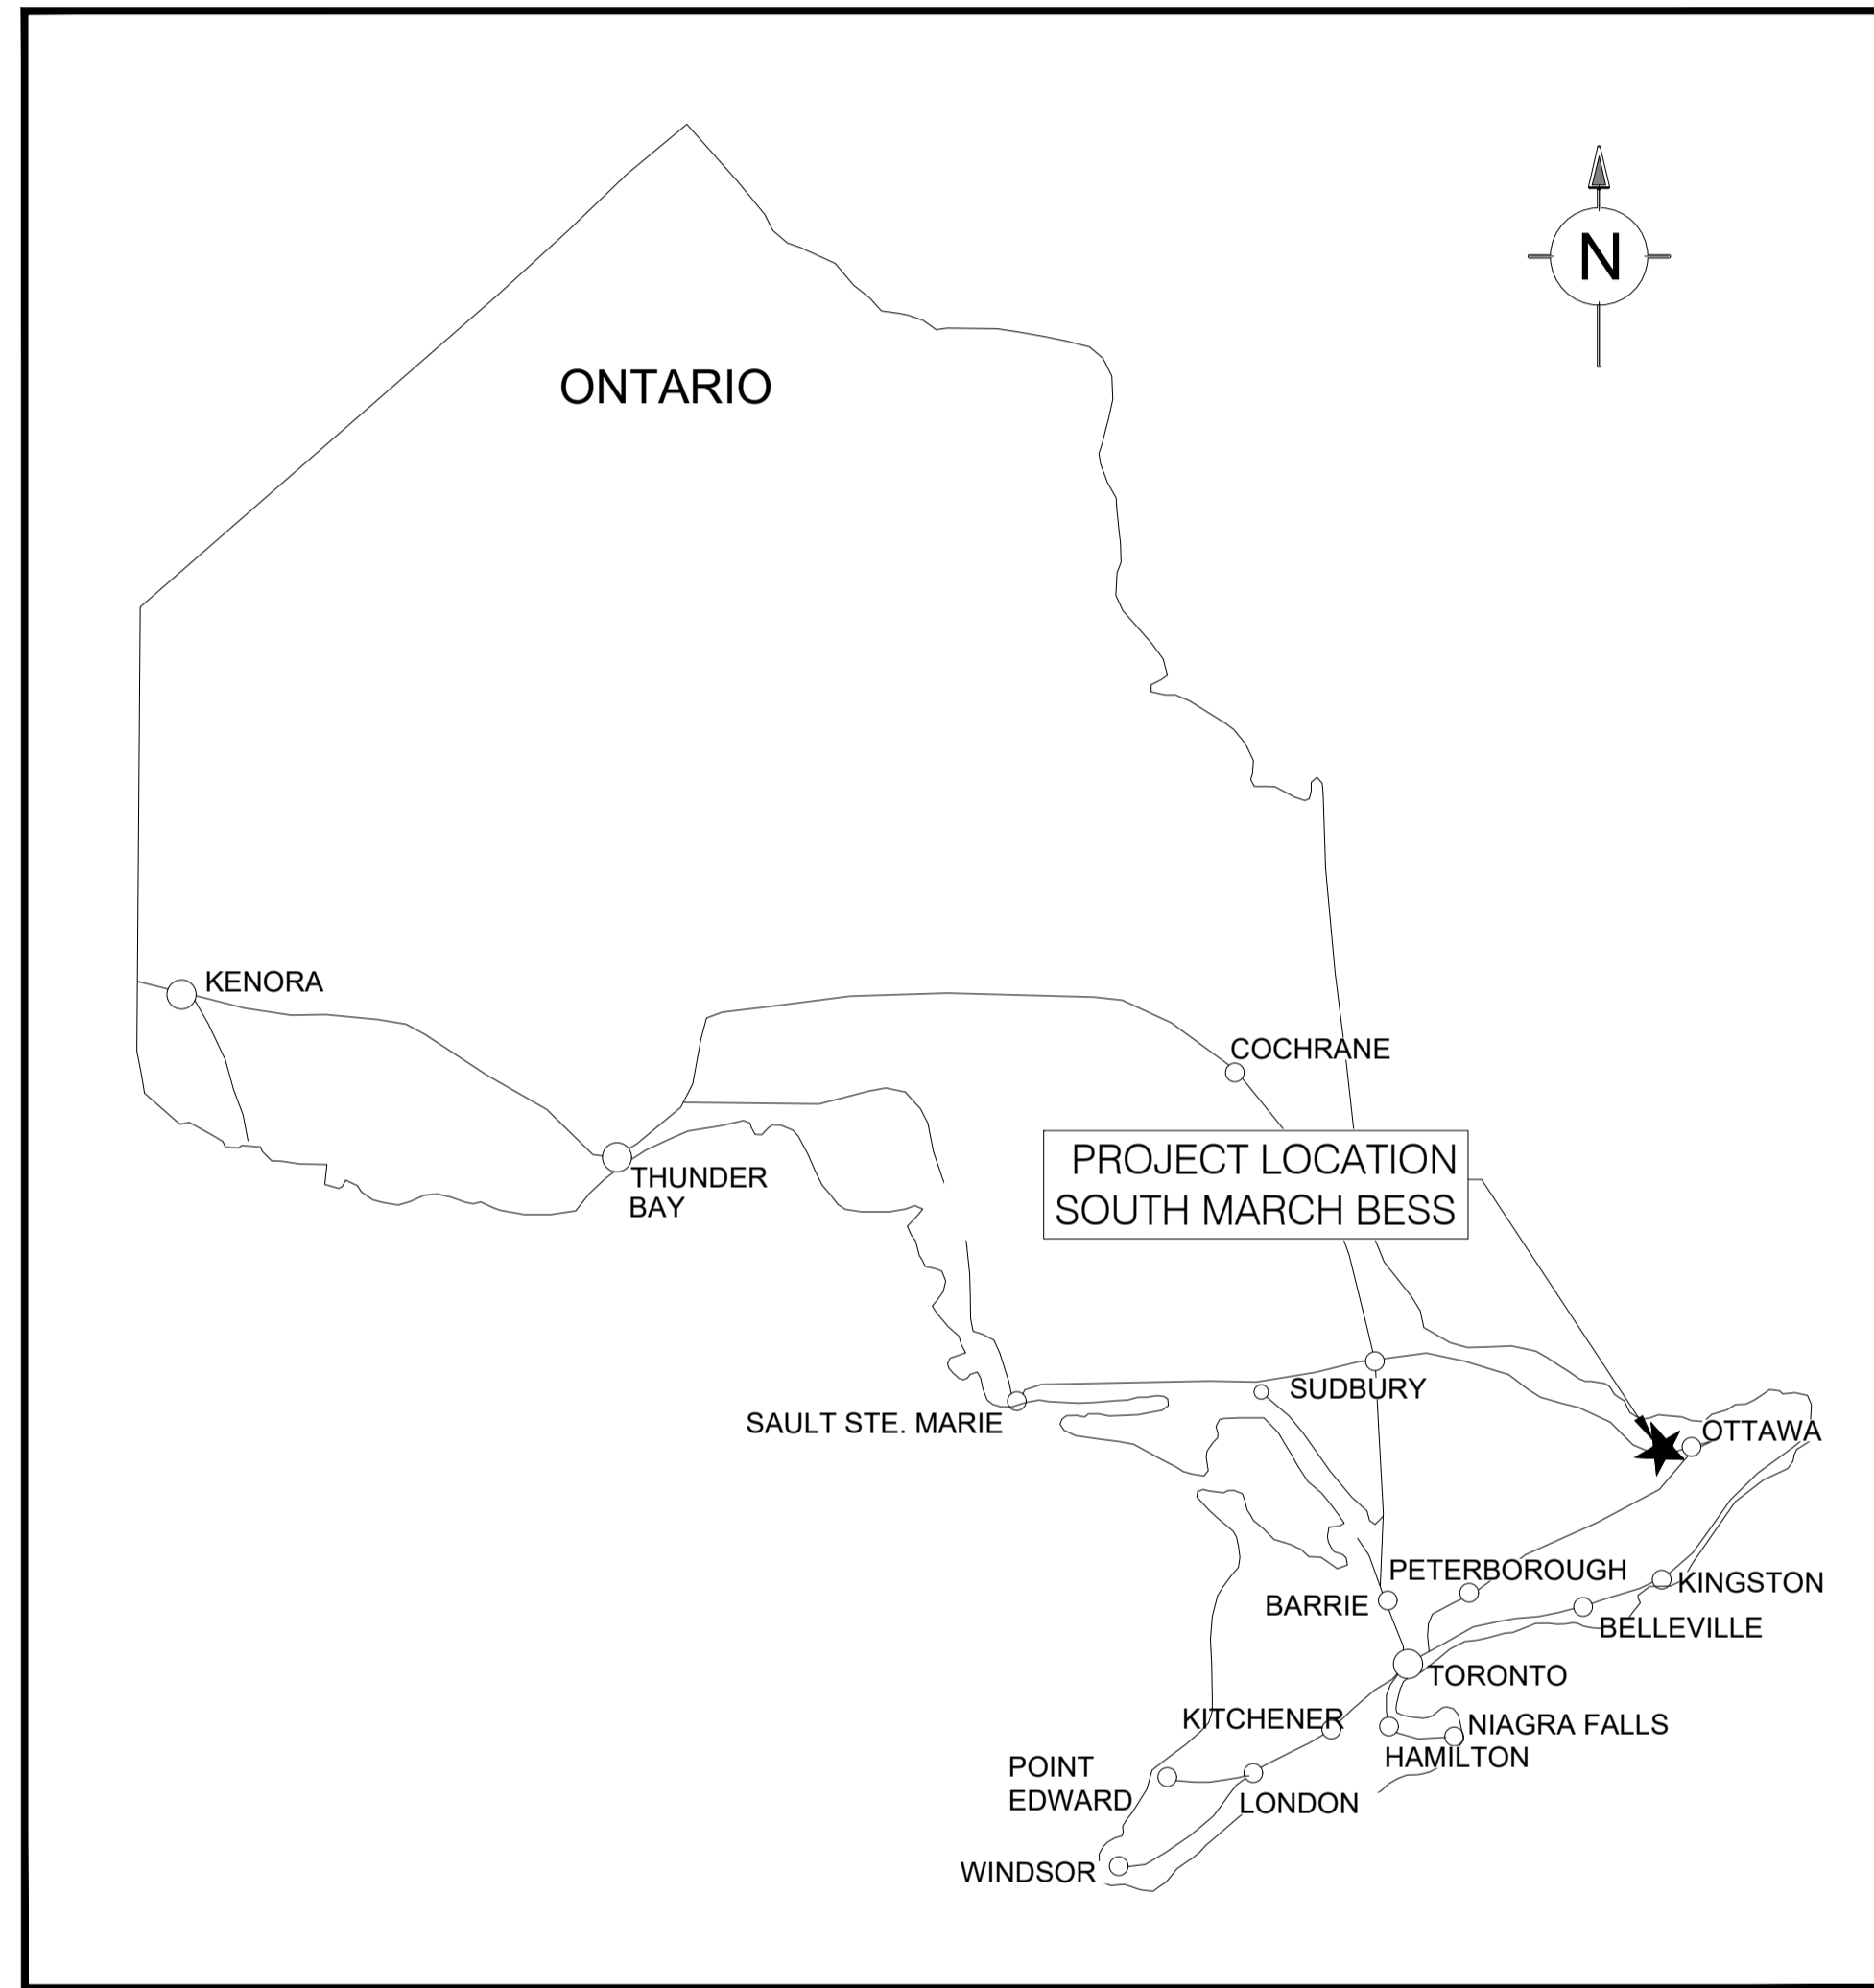

DRAWING INDEX				
BBA DRAWING NO.	REV.	DATE	CATEGORY	SHEET DESCRIPTION
7154023-100000-41-D01-0002	AD	2025-11-05	GENERAL	GENERAL NOTES, LEGEND AND ABBREVIATIONS
7154023-100000-41-D20-0001-01	AJ	2026-04-21	PLAN	SITE PLAN - SHEET 1
7154023-100000-41-D20-0001-02	AO	2026-04-21	PLAN	SITE PLAN - SHEET 2
7154023-100000-41-D20-0003	AG	2026-04-21	PLAN	SITE SERVICING AND FIRE PROTECTION PLAN
7154023-100000-41-D20-0004	AD	2026-01-23	PLAN & SECTIONS	WET POND
7154023-100000-41-D20-0005	AF	2026-04-21	PLAN	ROAD & FINISHED GRADE
7154023-100000-41-D20-0006	AD	2026-01-23	PROFILES	SITE GRADING
7154023-100000-41-D20-0007	AA	2025-11-05	PLAN	SETBACK FROM EXISTING RESIDENCES
7154023-100000-41-D30-0001	AA	2026-01-23	PLAN	PRE-DEVELOPMENT SUB-CATCHMENT AREAS
7154023-100000-41-D30-0002	AA	2026-01-23	PLAN	POST-DEVELOPMENT SUB-CATCHMENT AREAS
7154023-100000-41-D50-0001	AD	2025-11-05	DETAILS	STORMWATER AND WATER NETWORK
7154023-100000-41-D50-0002	AE	2026-04-21	DETAILS	ROAD AND DRAINAGE DETAILS
7154023-100000-41-D52-0001	AC	2026-04-21	PLAN	ROADS AND DITCHES , KEY PLAN
7154023-100000-41-D52-0002	AC	2026-04-21	PROFILES	ROADS AND DITCHES PROFILES
7154023-100000-41-D52-0003	AD	2026-04-21	PROFILES	ROADS AND DITCHES PROFILES
7154023-100000-41-D70-0001-01	AB	2026-04-21	PLAN	EROSION AND SEDIMENT CONTROL
7154023-100000-41-D70-0002-02	AB	2026-04-21	PLAN	EROSION AND SEDIMENT CONTROL
7154023-100000-41-D70-0003-03	AB	2026-04-21	PLAN	EROSION AND SEDIMENT CONTROL
7154023-100000-41-D70-0004-04	AB	2026-04-21	PLAN	EROSION AND SEDIMENT CONTROL
7154023-100000-41-D70-0005-05	AB	2026-04-21	PLAN	EROSION AND SEDIMENT CONTROL
7154023-100000-41-D70-0006-06	AB	2026-04-21	PLAN	EROSION AND SEDIMENT CONTROL
7154023-100000-41-D70-0002	AD	2026-11-05	DETAILS	EROSION AND SEDIMENT CONTROL
7154023-100000-41-D90-0001	AC	2025-11-05	STANDARD DETAILS	SECURITY FENCING

FOR PERMITTING

DRAWING No.	DESCRIPTION	REV	DESCRIPTION	VERIFIED BY	APPROVED BY	DATE
REFERENCE DRAWINGS						
	ENVIRONMENTAL-STANTEC.DWG	AK	FOR PERMITTING	B. THOMAS	V. BRUNELLE	2026-04-21
	XR-160402040-L-PLANTING.DWG	AJ	FOR PERMITTING	B. THOMAS	V. BRUNELLE	2026-02-19
	241451-SouthMarch_BESS-MTM9-Rev0	AI	FOR PERMITTING	B. THOMAS	V. BRUNELLE	2026-02-06
	SOUTH MARCH DITCH LINE TOPO	AH	FOR PERMITTING	B. THOMAS	V. BRUNELLE	2026-01-29
		AG	FOR PERMITTING	B. THOMAS	V. BRUNELLE	2026-01-23
		AF	FOR PERMITTING	B. THOMAS	V. BRUNELLE	2025-11-07
		AE	FOR PERMITTING	B. THOMAS	V. BRUNELLE	2025-11-05
7154023-402000-47-D20-0001	SOUTH MARCH BESS-250 MW 230KV-34.5 kV SUBSTATION	AD	FOR PERMITTING	E. AMELI	M. SHAHRAKI	2025-07-03

<p>APPLICATION FILE NUMBER : D07-12-25-0096 PLAN NUMBER : 19401</p>	<p>CLIENT:</p>	<p>PROJECT: SOUTH MARCH BESS 2555 AND 2625 MARCHURST RD, OTTAWA</p> <p>TITLE: GENERAL CIVIL COVER PAGE & DRAWING INDEX</p>	<table border="0" style="width: 100%;"> <tr> <td style="width: 50%;">DESIGNED BY: B. THOMAS</td> <td style="width: 50%;">DRAFTED BY: G. NORMAND</td> </tr> <tr> <td>VERIFIED BY: V. BRUNELLE</td> <td>APPROVED BY: V. BRUNELLE</td> </tr> <tr> <td>SCALE: N/A</td> <td>DATE: 2025-03-07</td> </tr> </table>	DESIGNED BY: B. THOMAS	DRAFTED BY: G. NORMAND	VERIFIED BY: V. BRUNELLE	APPROVED BY: V. BRUNELLE	SCALE: N/A	DATE: 2025-03-07
DESIGNED BY: B. THOMAS	DRAFTED BY: G. NORMAND								
VERIFIED BY: V. BRUNELLE	APPROVED BY: V. BRUNELLE								
SCALE: N/A	DATE: 2025-03-07								
<p>DRAWING No.: 7154023-100000-41-D01-0001</p>		<p>SHEET: 01</p>	<p>SIZE: A1</p>	<p>REV: AK</p>					

BY: NORMAND, GABRIEL. PRINTED: 2026-04-23 11:09:57