


*Allison Hamlin*


**ALLISON HAMLIN**  
**MANAGER, DEVELOPMENT REVIEW ALL WARDS**  
**PLANNING, DEVELOPMENT & BUILDING SERVICES**  
**DEPARTMENT, CITY OF OTTAWA**

**APPROVED**  
 By Allison Hamlin at 1:51 pm, May 21, 2026

REFER TO NOTES, DETAILS & SCHEDULES ON DRAWINGS C-10 & C-11

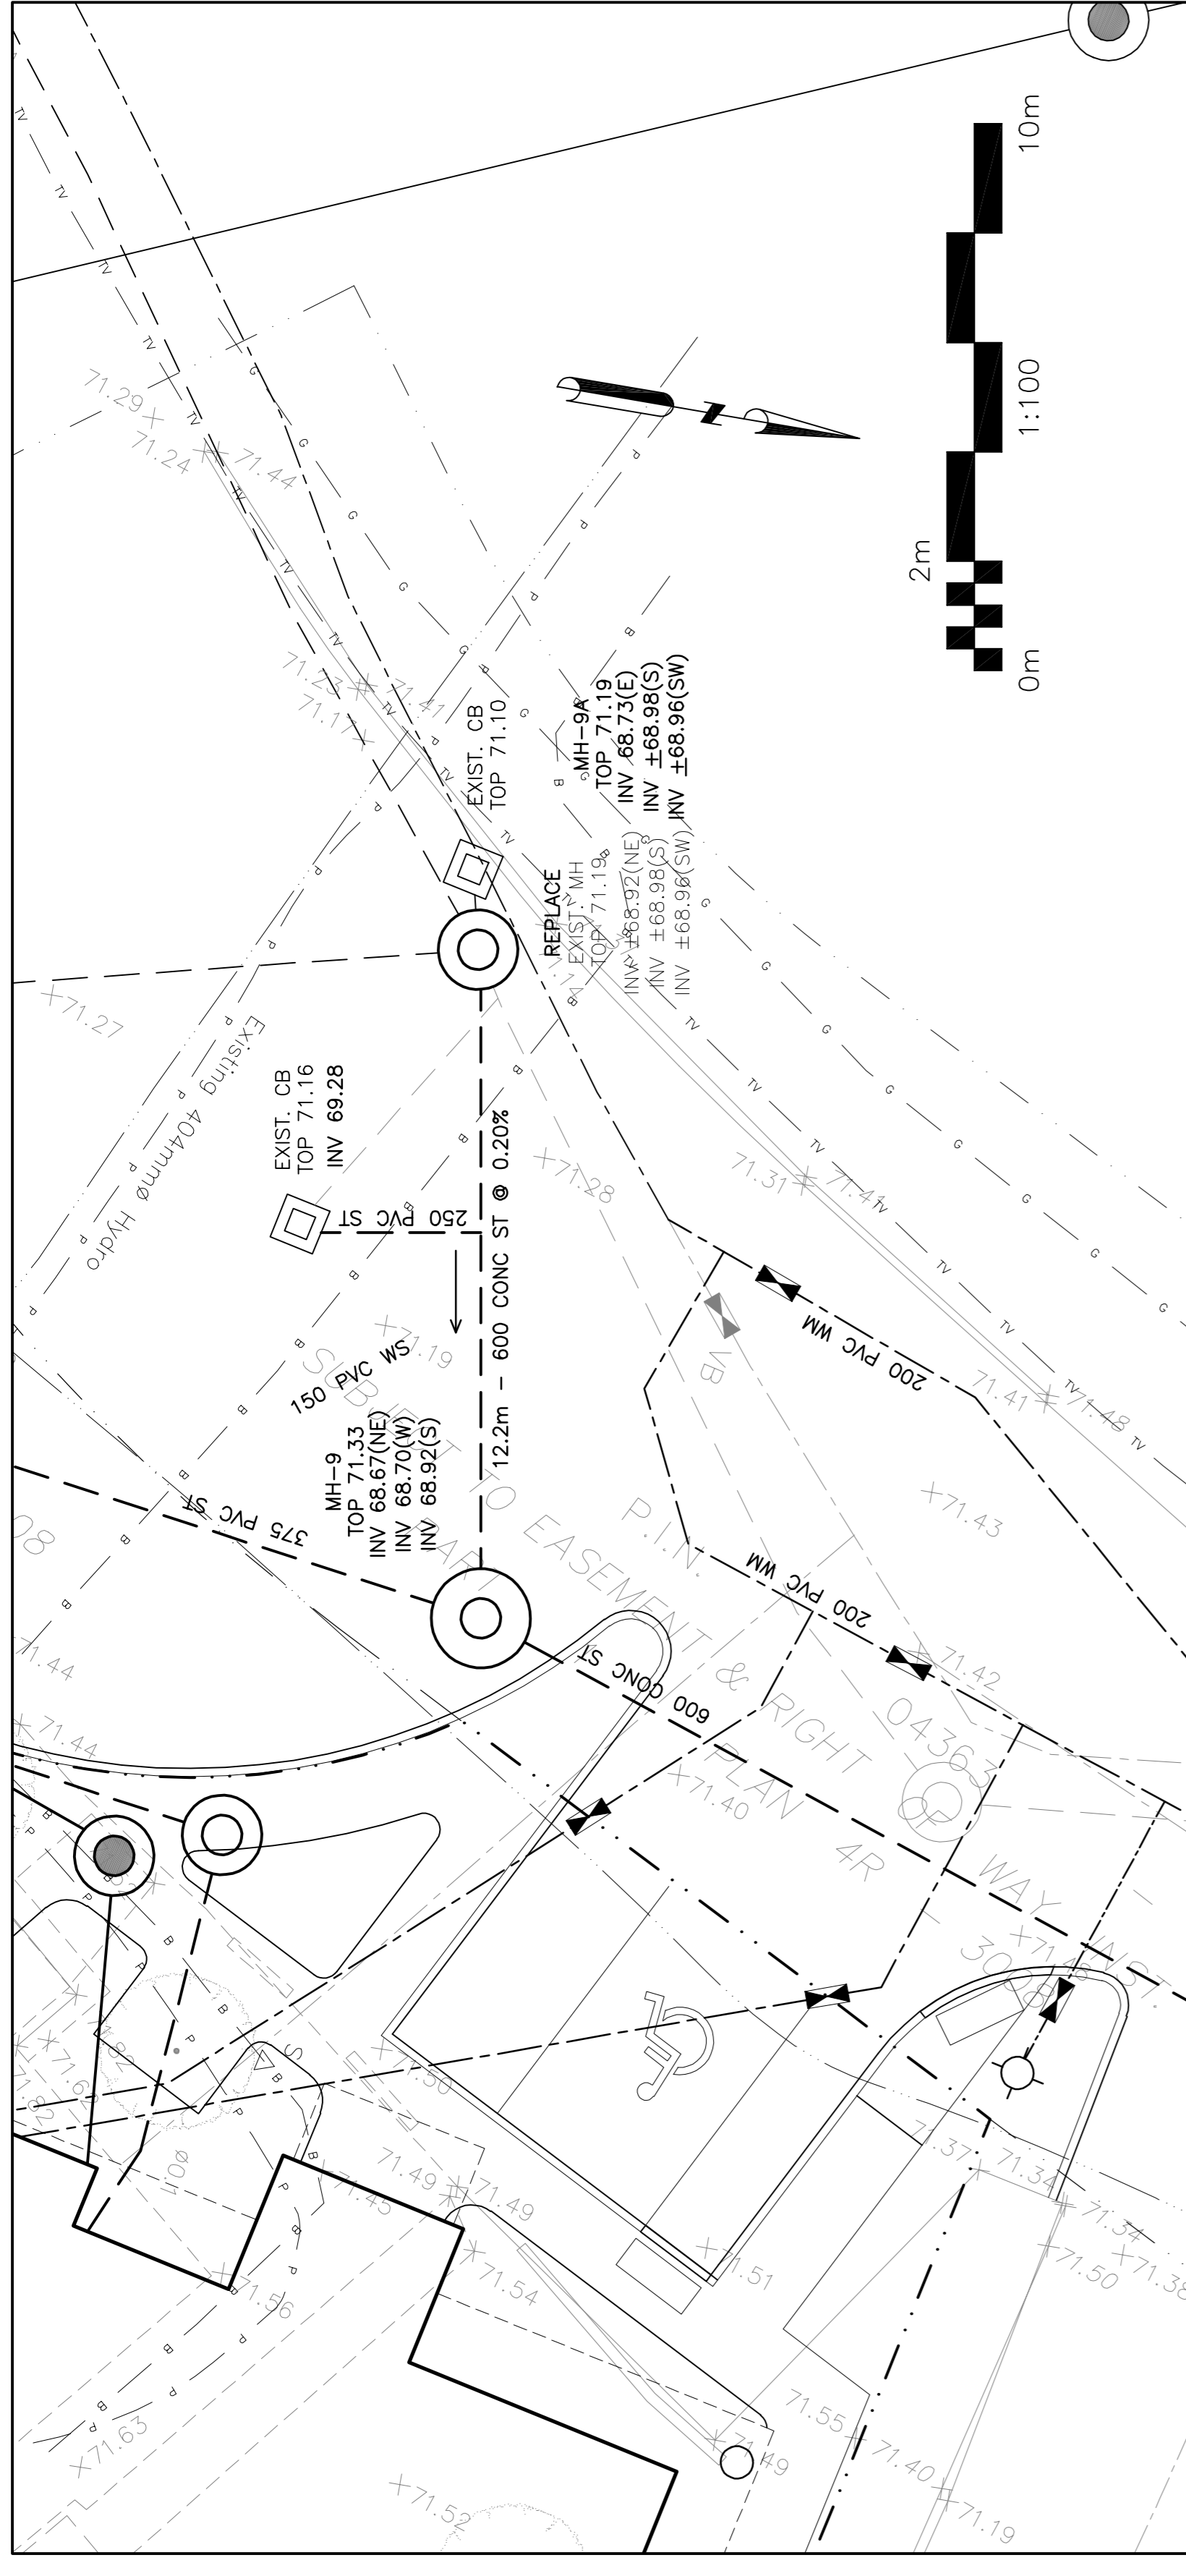

Stationing	Proposed Grade	Existing Grade	Storm Sewer Invert	Chainage Above Proposed Watermain
71.00				
70.00				
69.00				
68.00				
EXISTING GRADE ELEVATION				
STORM SEWER INVERT				
CHAINAGE ABOVE PROPOSED WATERMAIN				
71.00				
70.00				
69.00				
68.00				
EXISTING GRADE ELEVATION				
STORM SEWER INVERT				
CHAINAGE ABOVE PROPOSED WATERMAIN				
71.00				
70.00				
69.00				
68.00				
EXISTING GRADE ELEVATION				
STORM SEWER INVERT				
CHAINAGE ABOVE PROPOSED WATERMAIN				
71.00				
70.00				
69.00				
68.00				
EXISTING GRADE ELEVATION				
STORM SEWER INVERT				
CHAINAGE ABOVE PROPOSED WATERMAIN				
71.00				
70.00				
69.00				
68.00				
EXISTING GRADE ELEVATION				
STORM SEWER INVERT				
CHAINAGE ABOVE PROPOSED WATERMAIN				

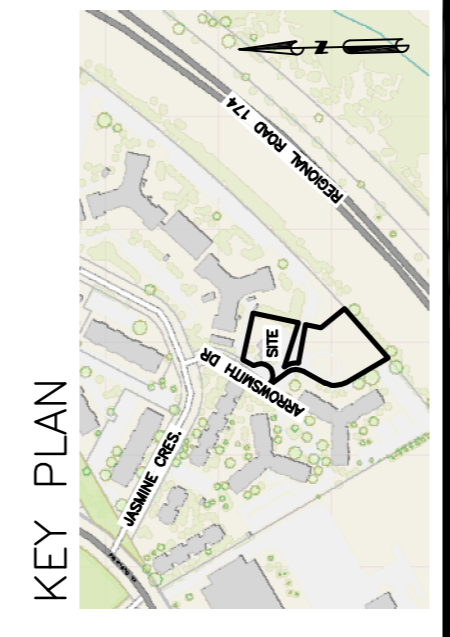

**LEGEND**

FFL	FINISHED FLOOR ELEVATION
TOP	TOP OF FOUNDATION
BFL	BASEMENT FLOOR ELEVATION
USF	UNDERSIDE OF FOOTING
---	PROPERTY LINE
CAZ	CRITICAL ROOT ZONE
CB	CATCH-BASIN
MH	STORM MANHOLE
CB/MH	CATCH-BASIN/MANHOLE
MH	SANITARY MANHOLE
PH	FIRE HYDRANT
FDC	FIRE DEPARTMENT CONNECTION
VB	VALVE & VALVE BOX
W	WATER METER
RM	REMOTE WATER METER
SAN	SANITARY SEWER
ST	STORM SEWER
WS/W	WATER SERVICE/WATERMAIN
OBV	OBJECT OF PIPE
SPL	SPRINGLINE OF PIPE
INV	INVERT OF PIPE

No.	DATE	REVISION
7	MAY 5-26	RE-ISSUED FOR APPROVAL
6	MAR 9-26	RE-ISSUED FOR APPROVAL
5	FEB 24-26	RE-ISSUED FOR APPROVAL
4	JAN 27-26	ISSUED FOR TENDER
3	DEC 10-25	RE-ISSUED FOR APPROVAL
2	JAN 17-25	ISSUED FOR ZONING
1	DEC 6-24	ISSUED FOR BUILDING PERMIT

**D. B. GRAY ENGINEERING INC.**  
 Professional Engineers - Consulting & Planning - Storm & Sanitary Sewers - Watermain  
 700 Long Point Circle  
 Ottawa, Ontario    d.gray@dbgrayengineering.com

**PROPOSED 6-STORY MIXED-USE BUILDING**  
 2040 ARROWSMITH DRIVE  
 OTTAWA, ONTARIO

**PLAN AND PROFILE**  
 STA 0+071.1 TO 0+083.3

Engineer's Seal  
 D.B. GRAY  
 LICENSED PROFESSIONAL ENGINEER  
 CIVIL  
 MAY 25-2026  
 NOT VALID UNLESS SIGNED & DATED

Drawn: D.B.G. 1:100  
 V. Scale: 1:20  
 Date: NOV 29-22  
 Job No.: 22062

Drawing No. **C-18** of 18  
 #18936

D07-12-23-0014