




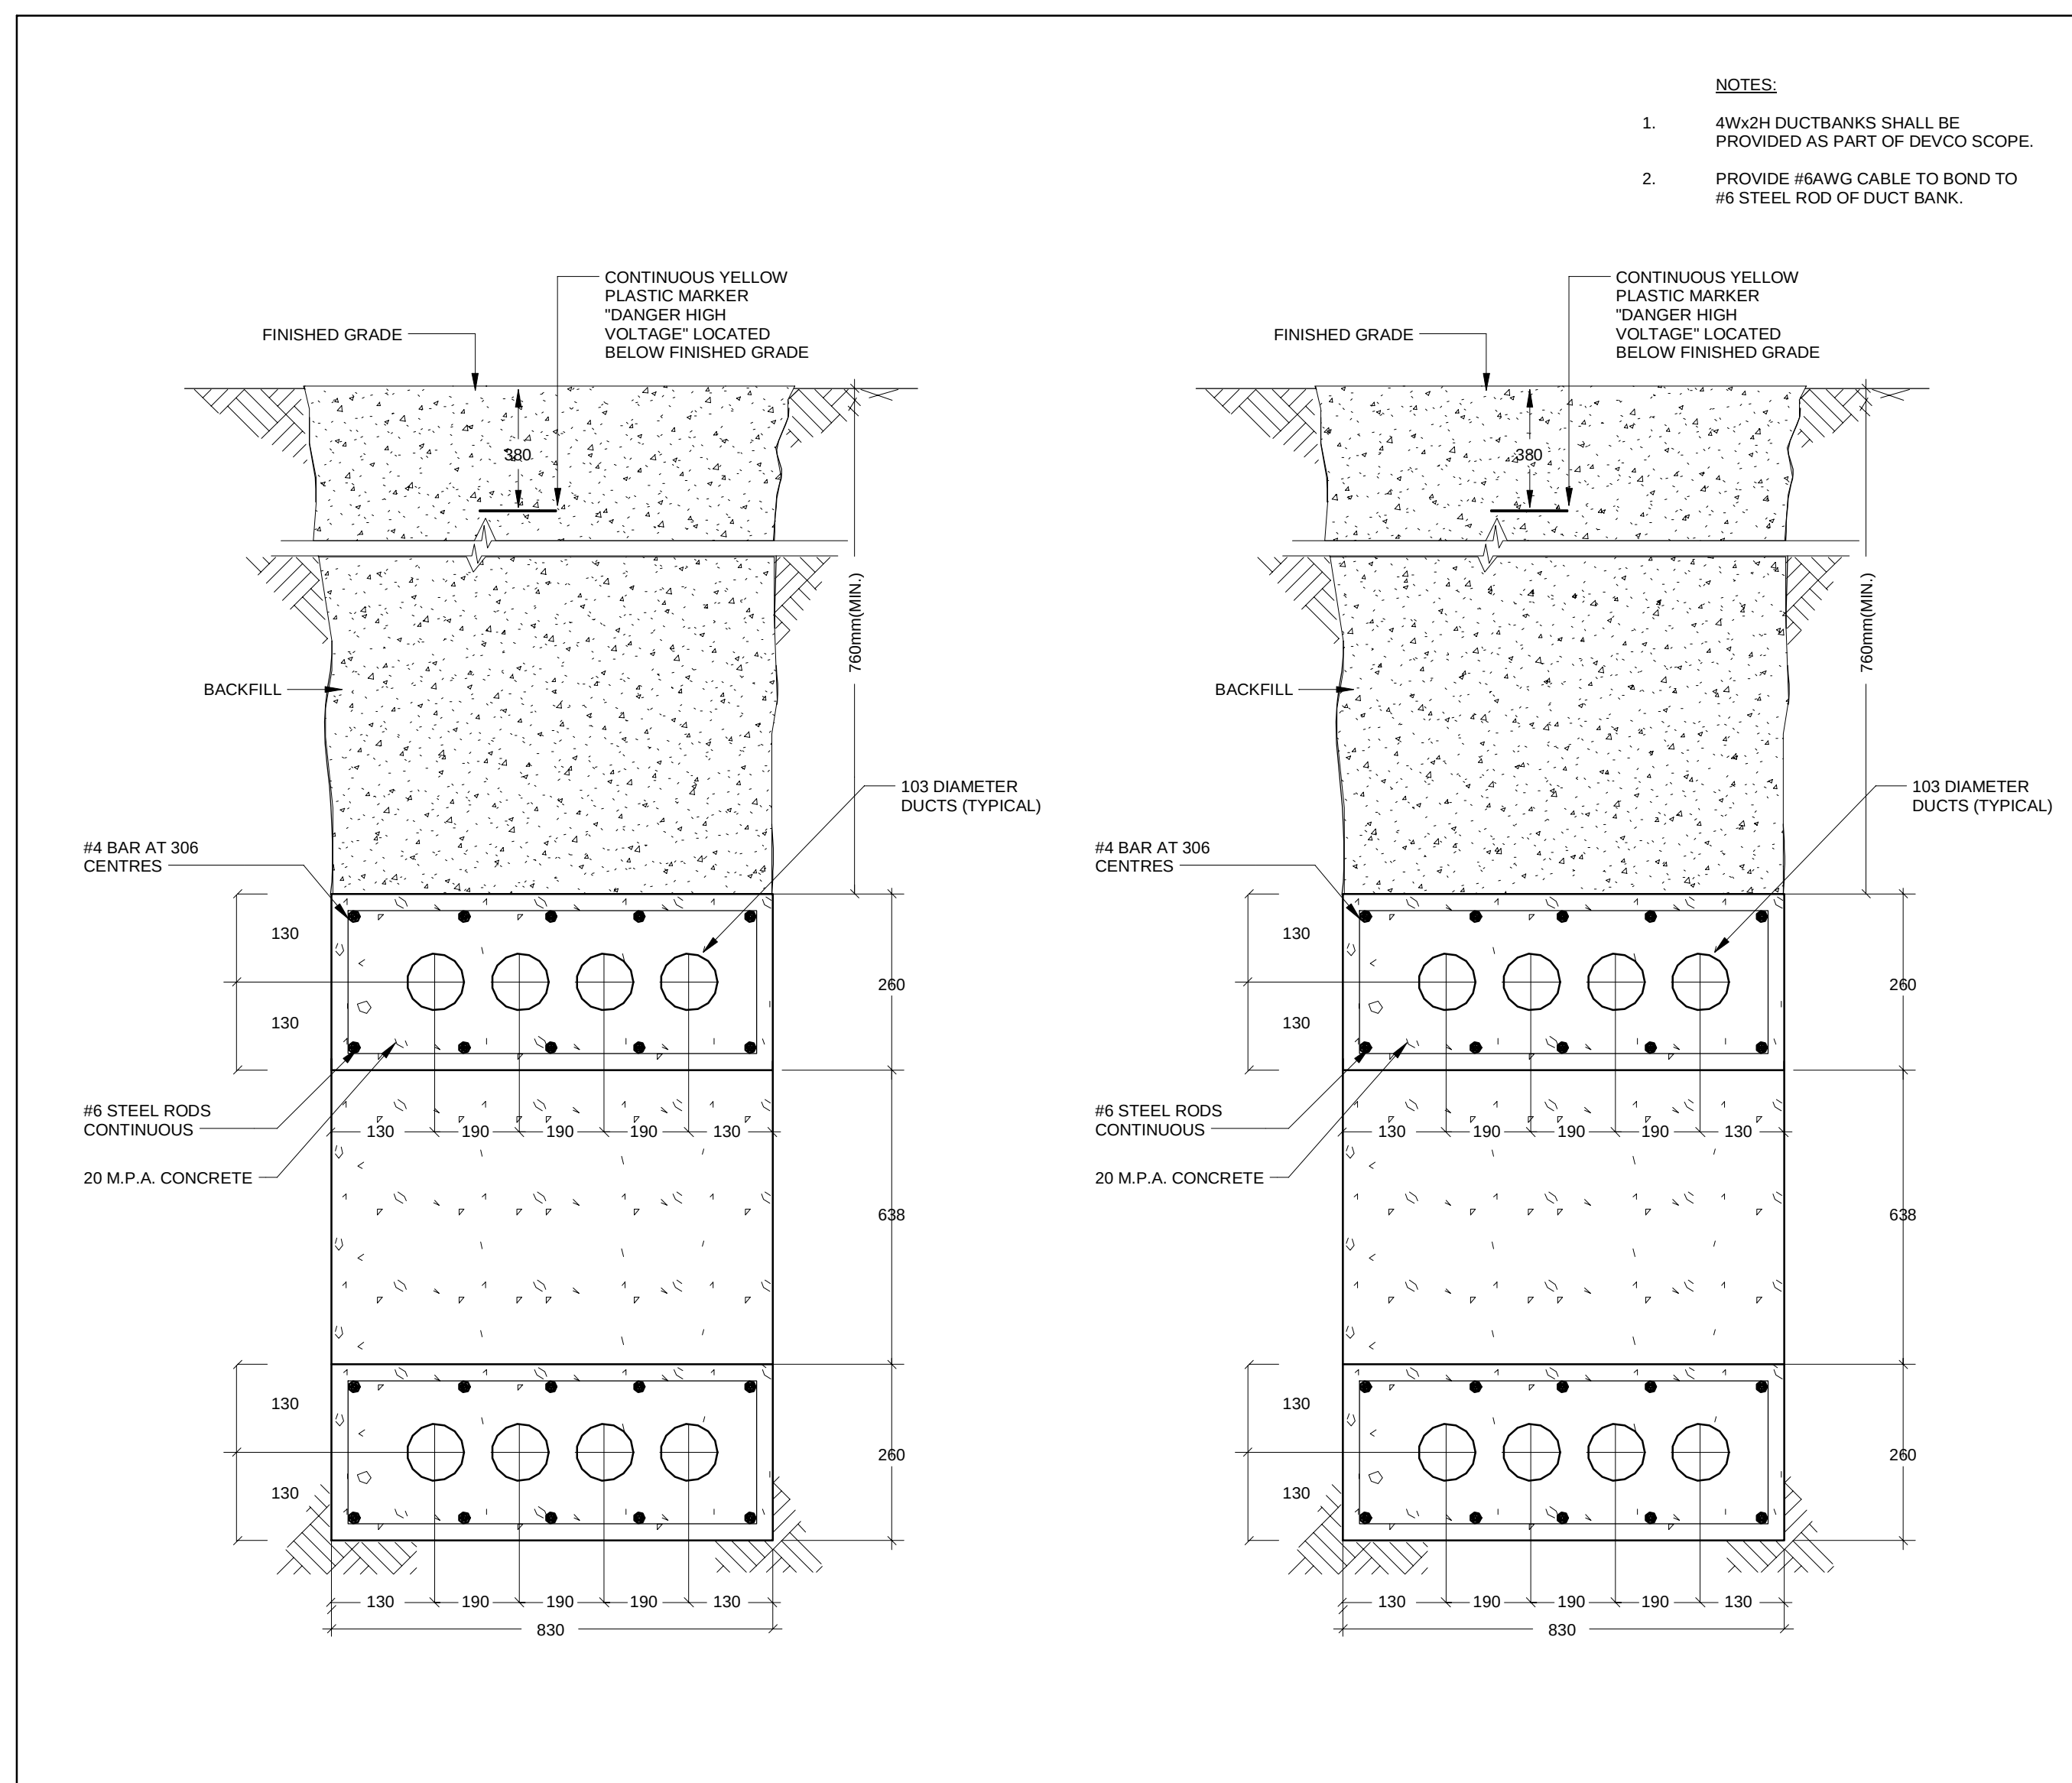


8 NORMAL POWER DUCT BANK DETAIL TO MANHOLE (FROM CUP)
E1-601 N.T.S.

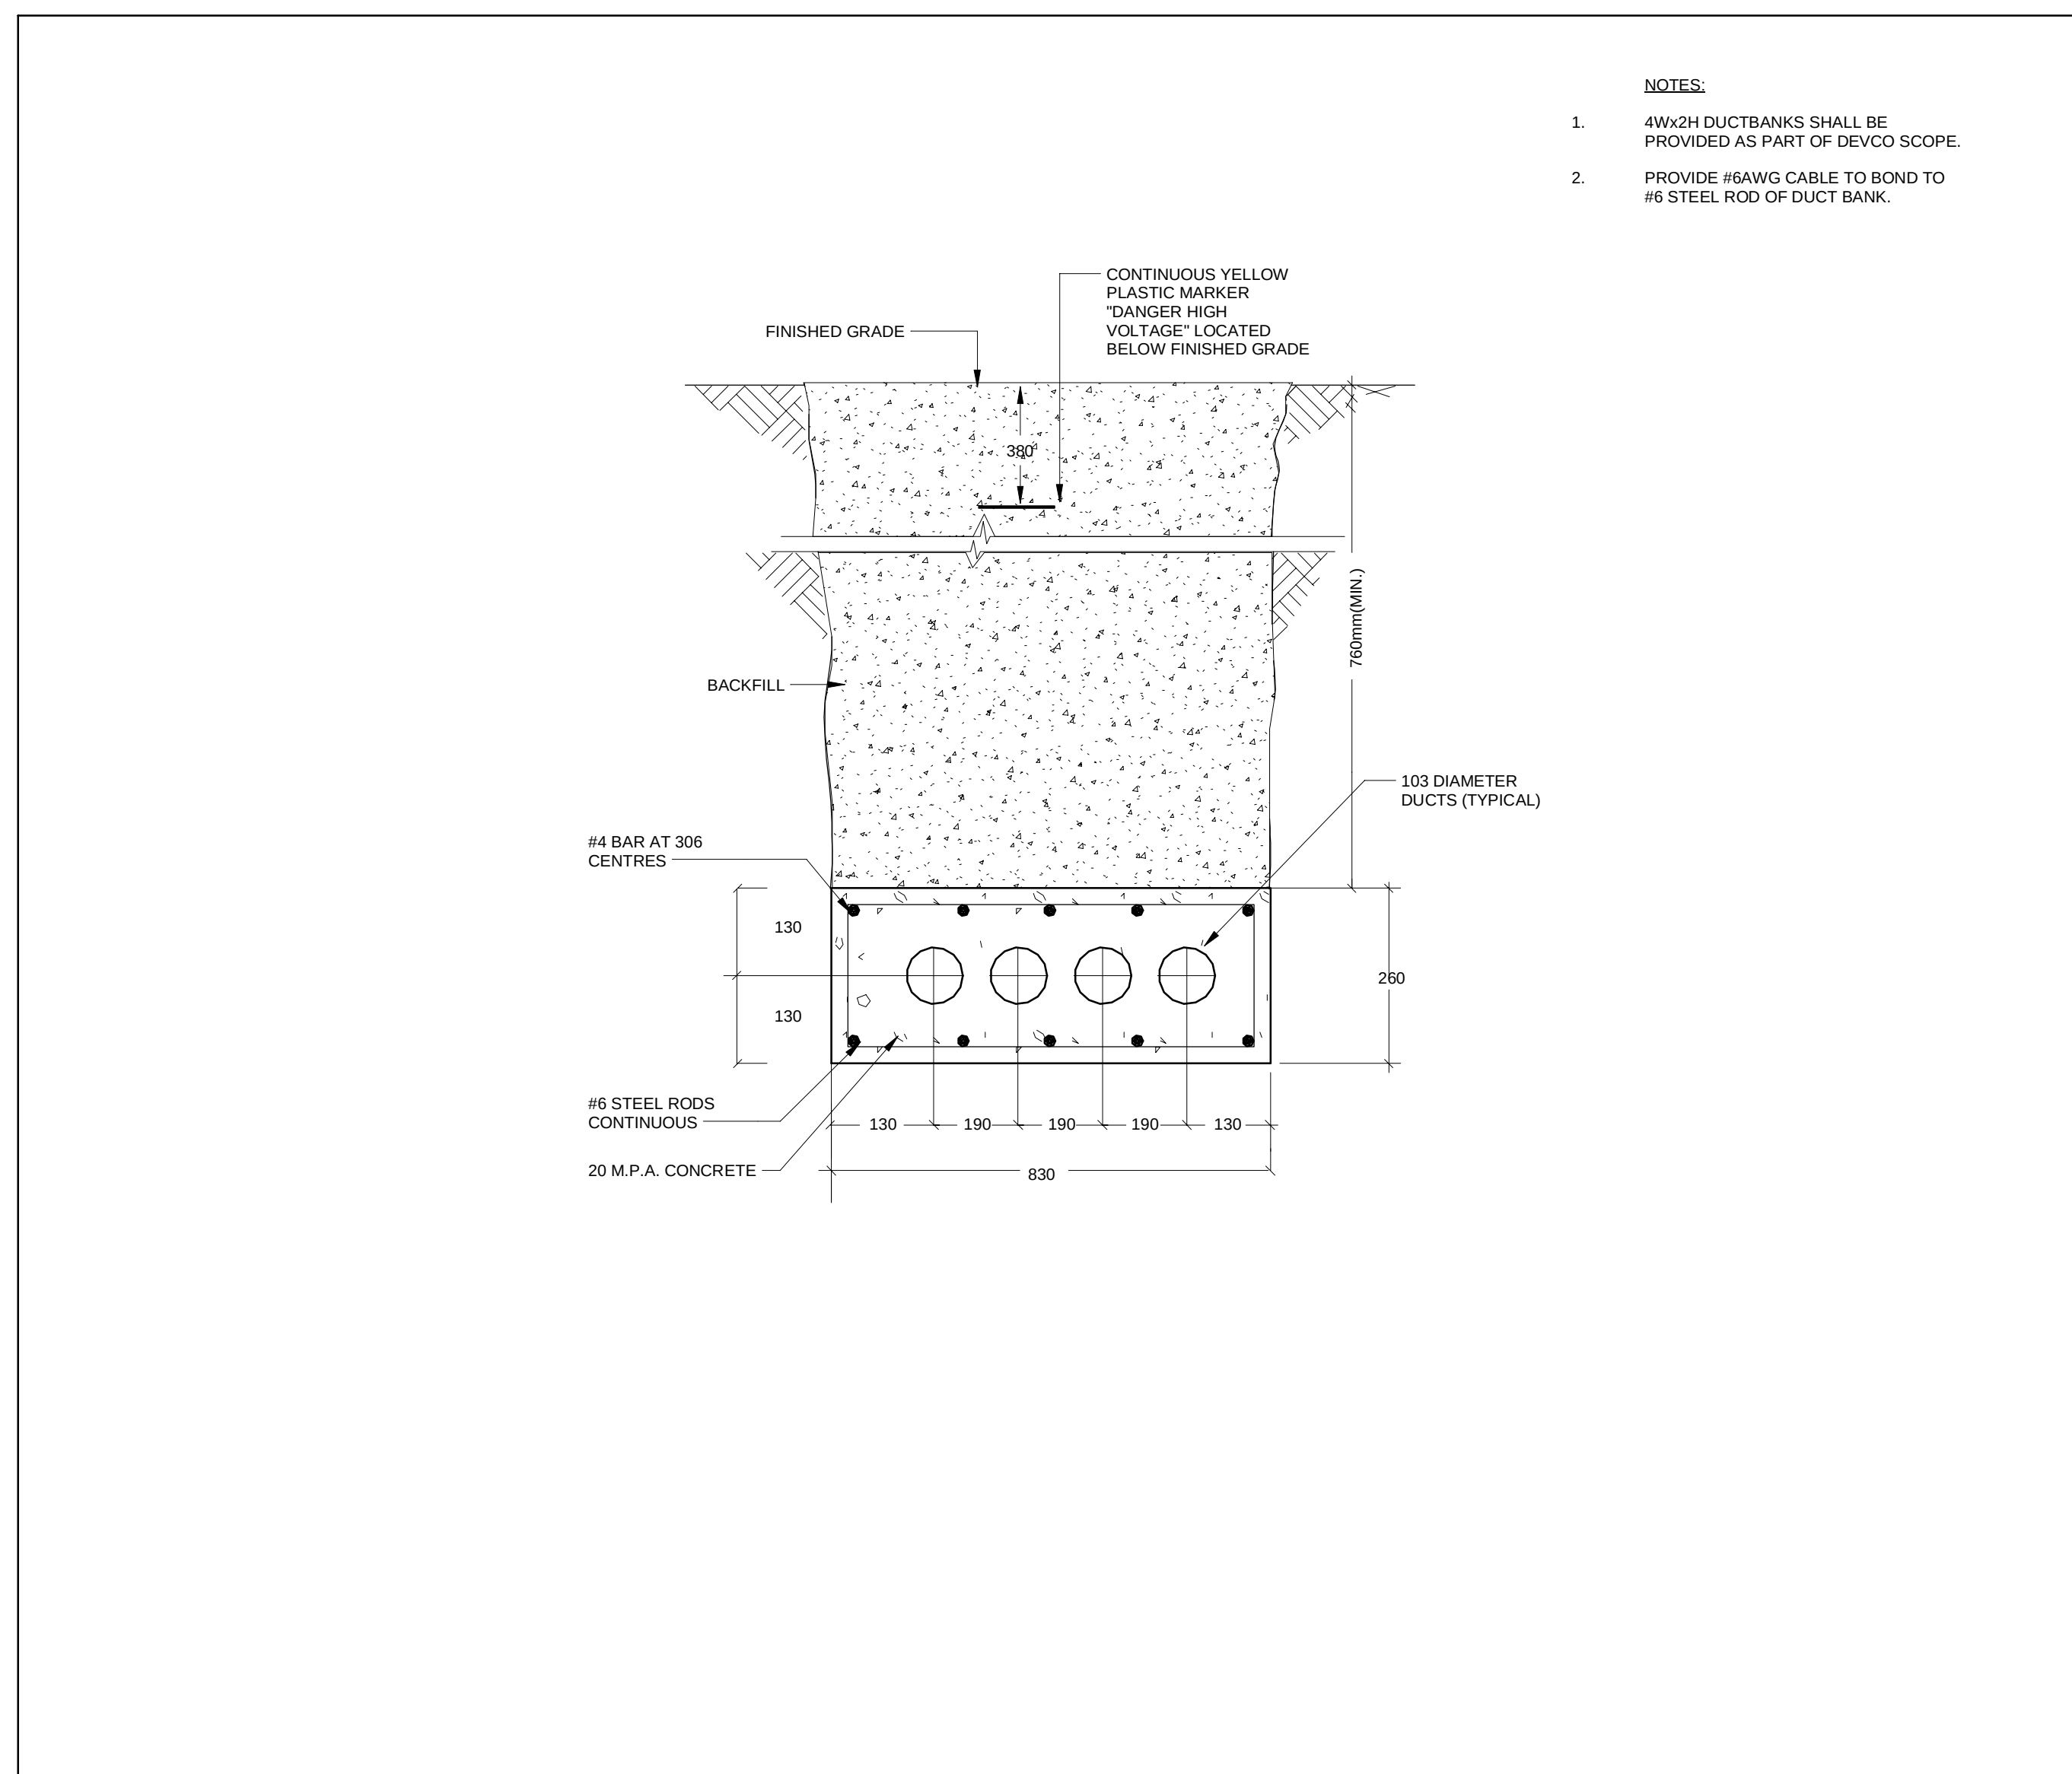


7 EMERGENCY POWER DUCT BANK DETAIL TO MANHOLE (FROM CUP TYPICAL OF THREE)
E1-601 N.T.S.

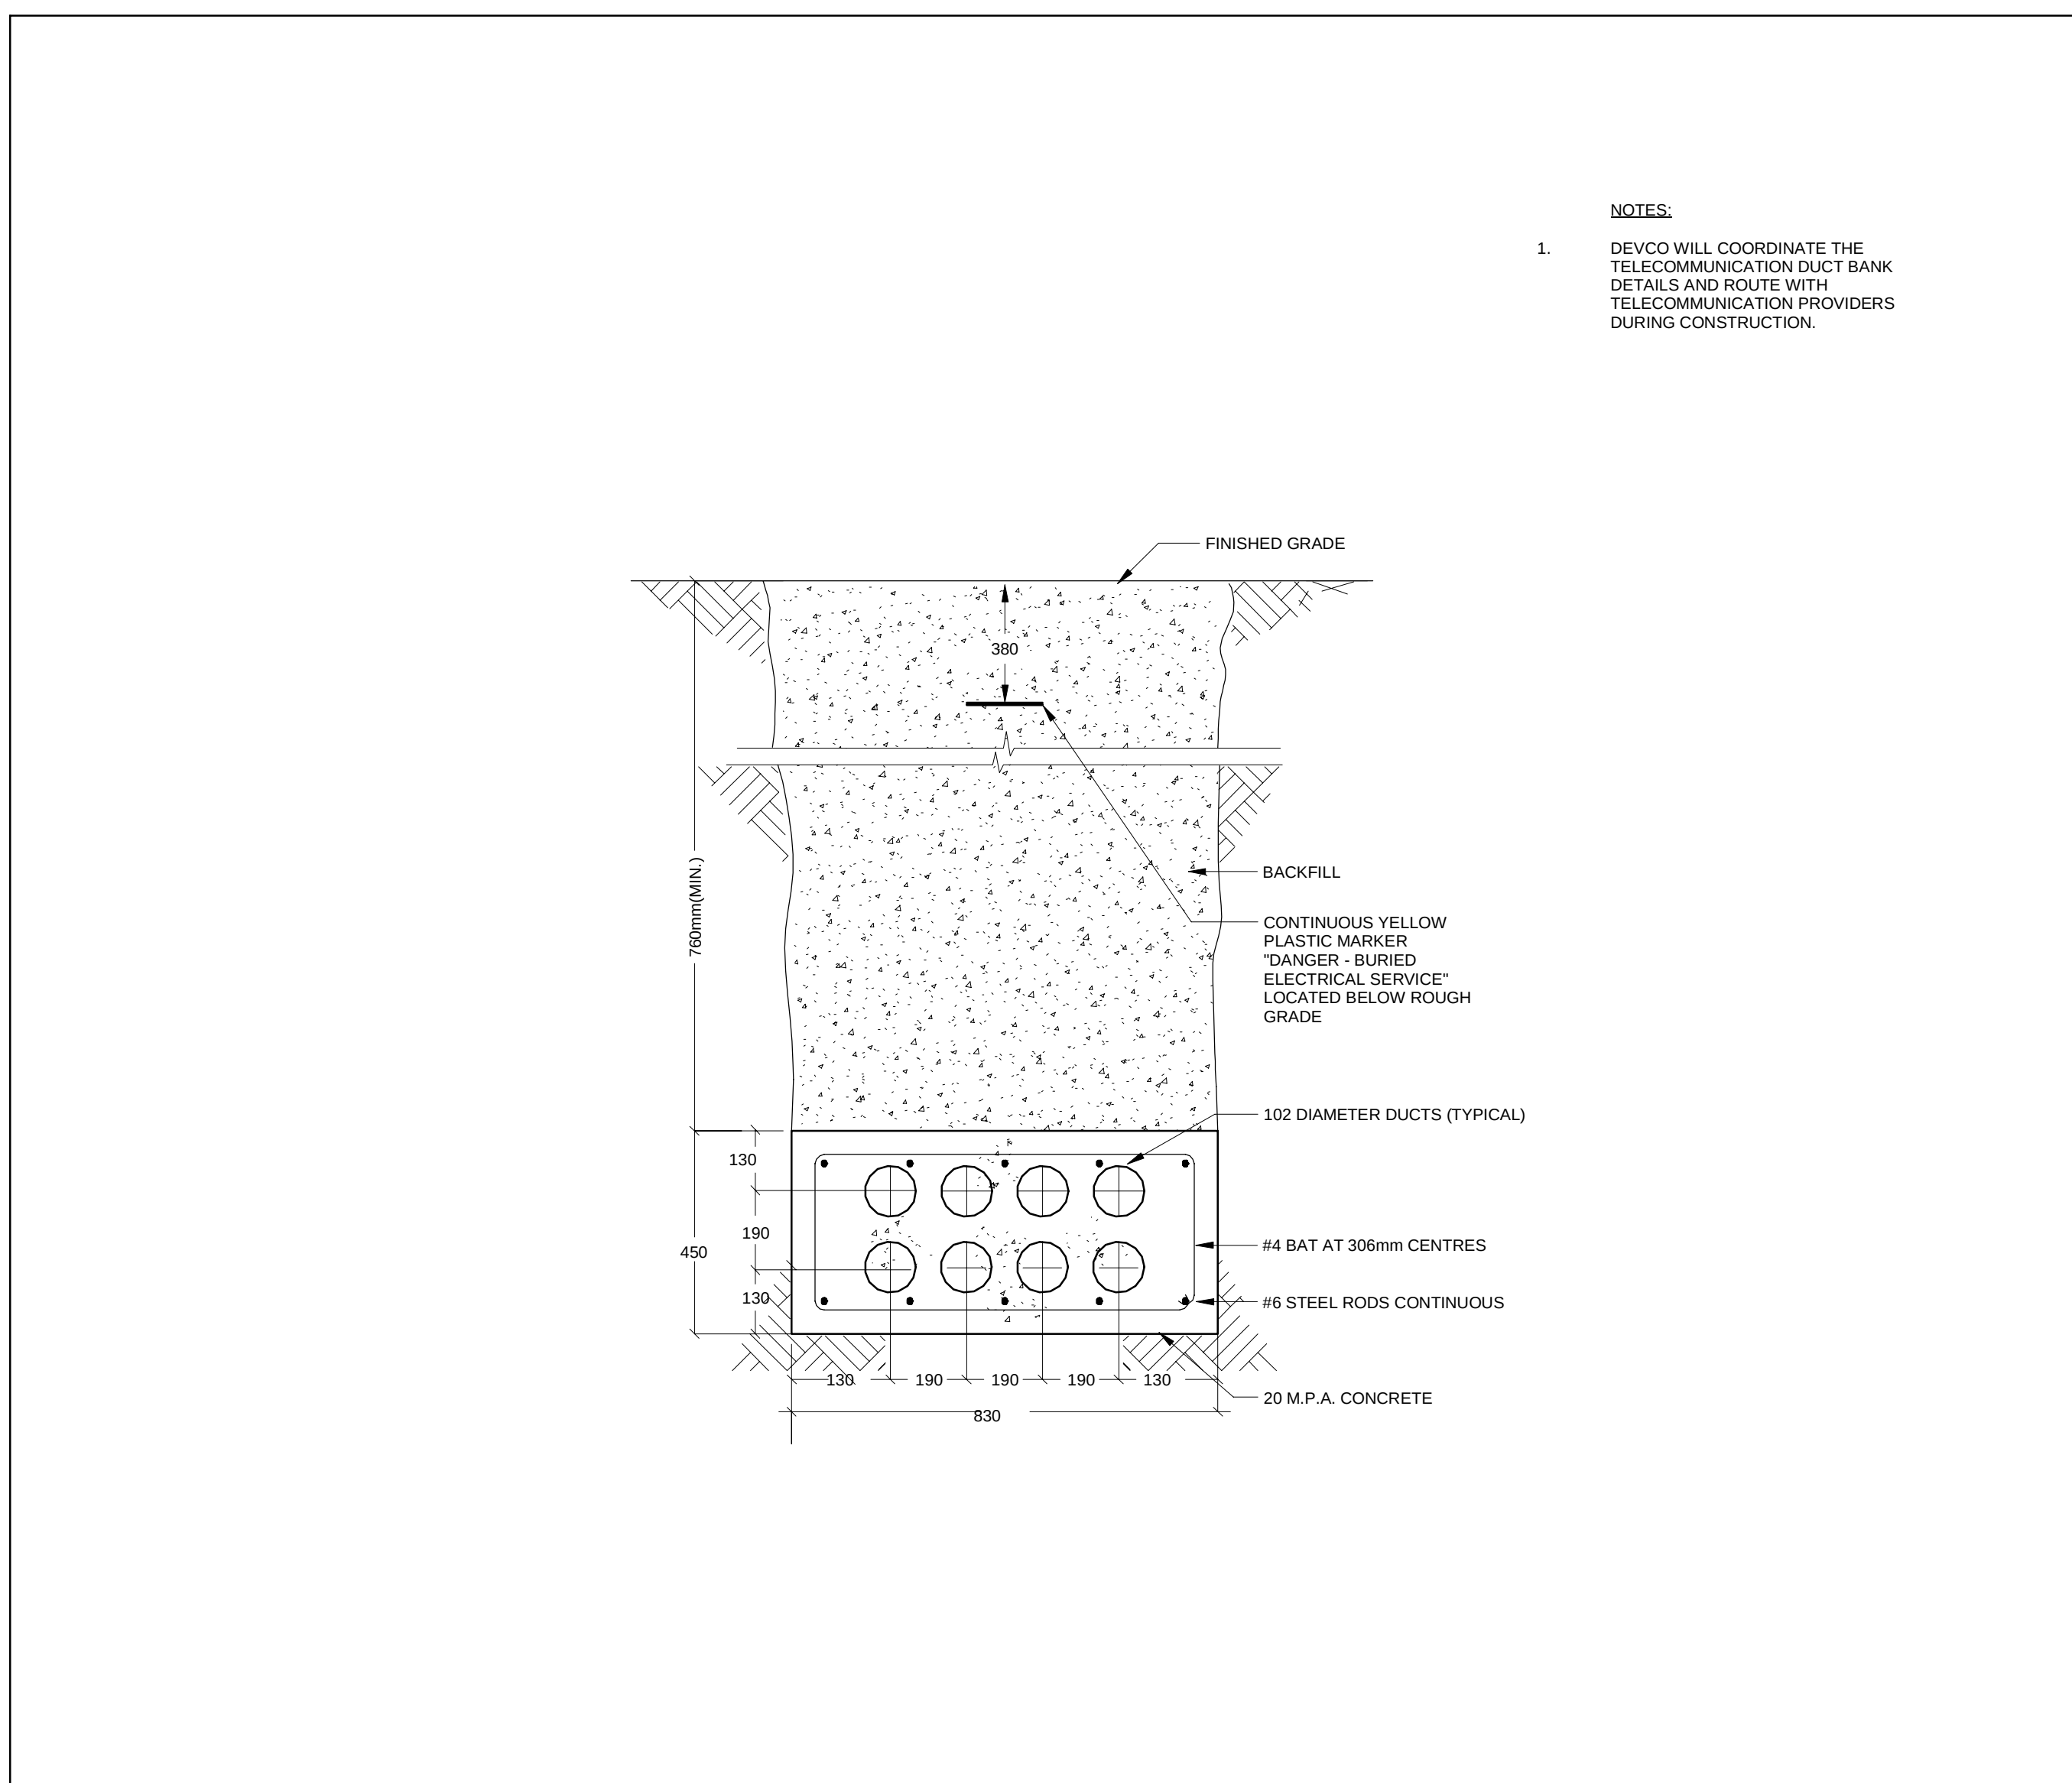


4 TELECOMM DUCT BANK - ENTRANCE FACILITY SOUTH
E1-601 N.T.S.

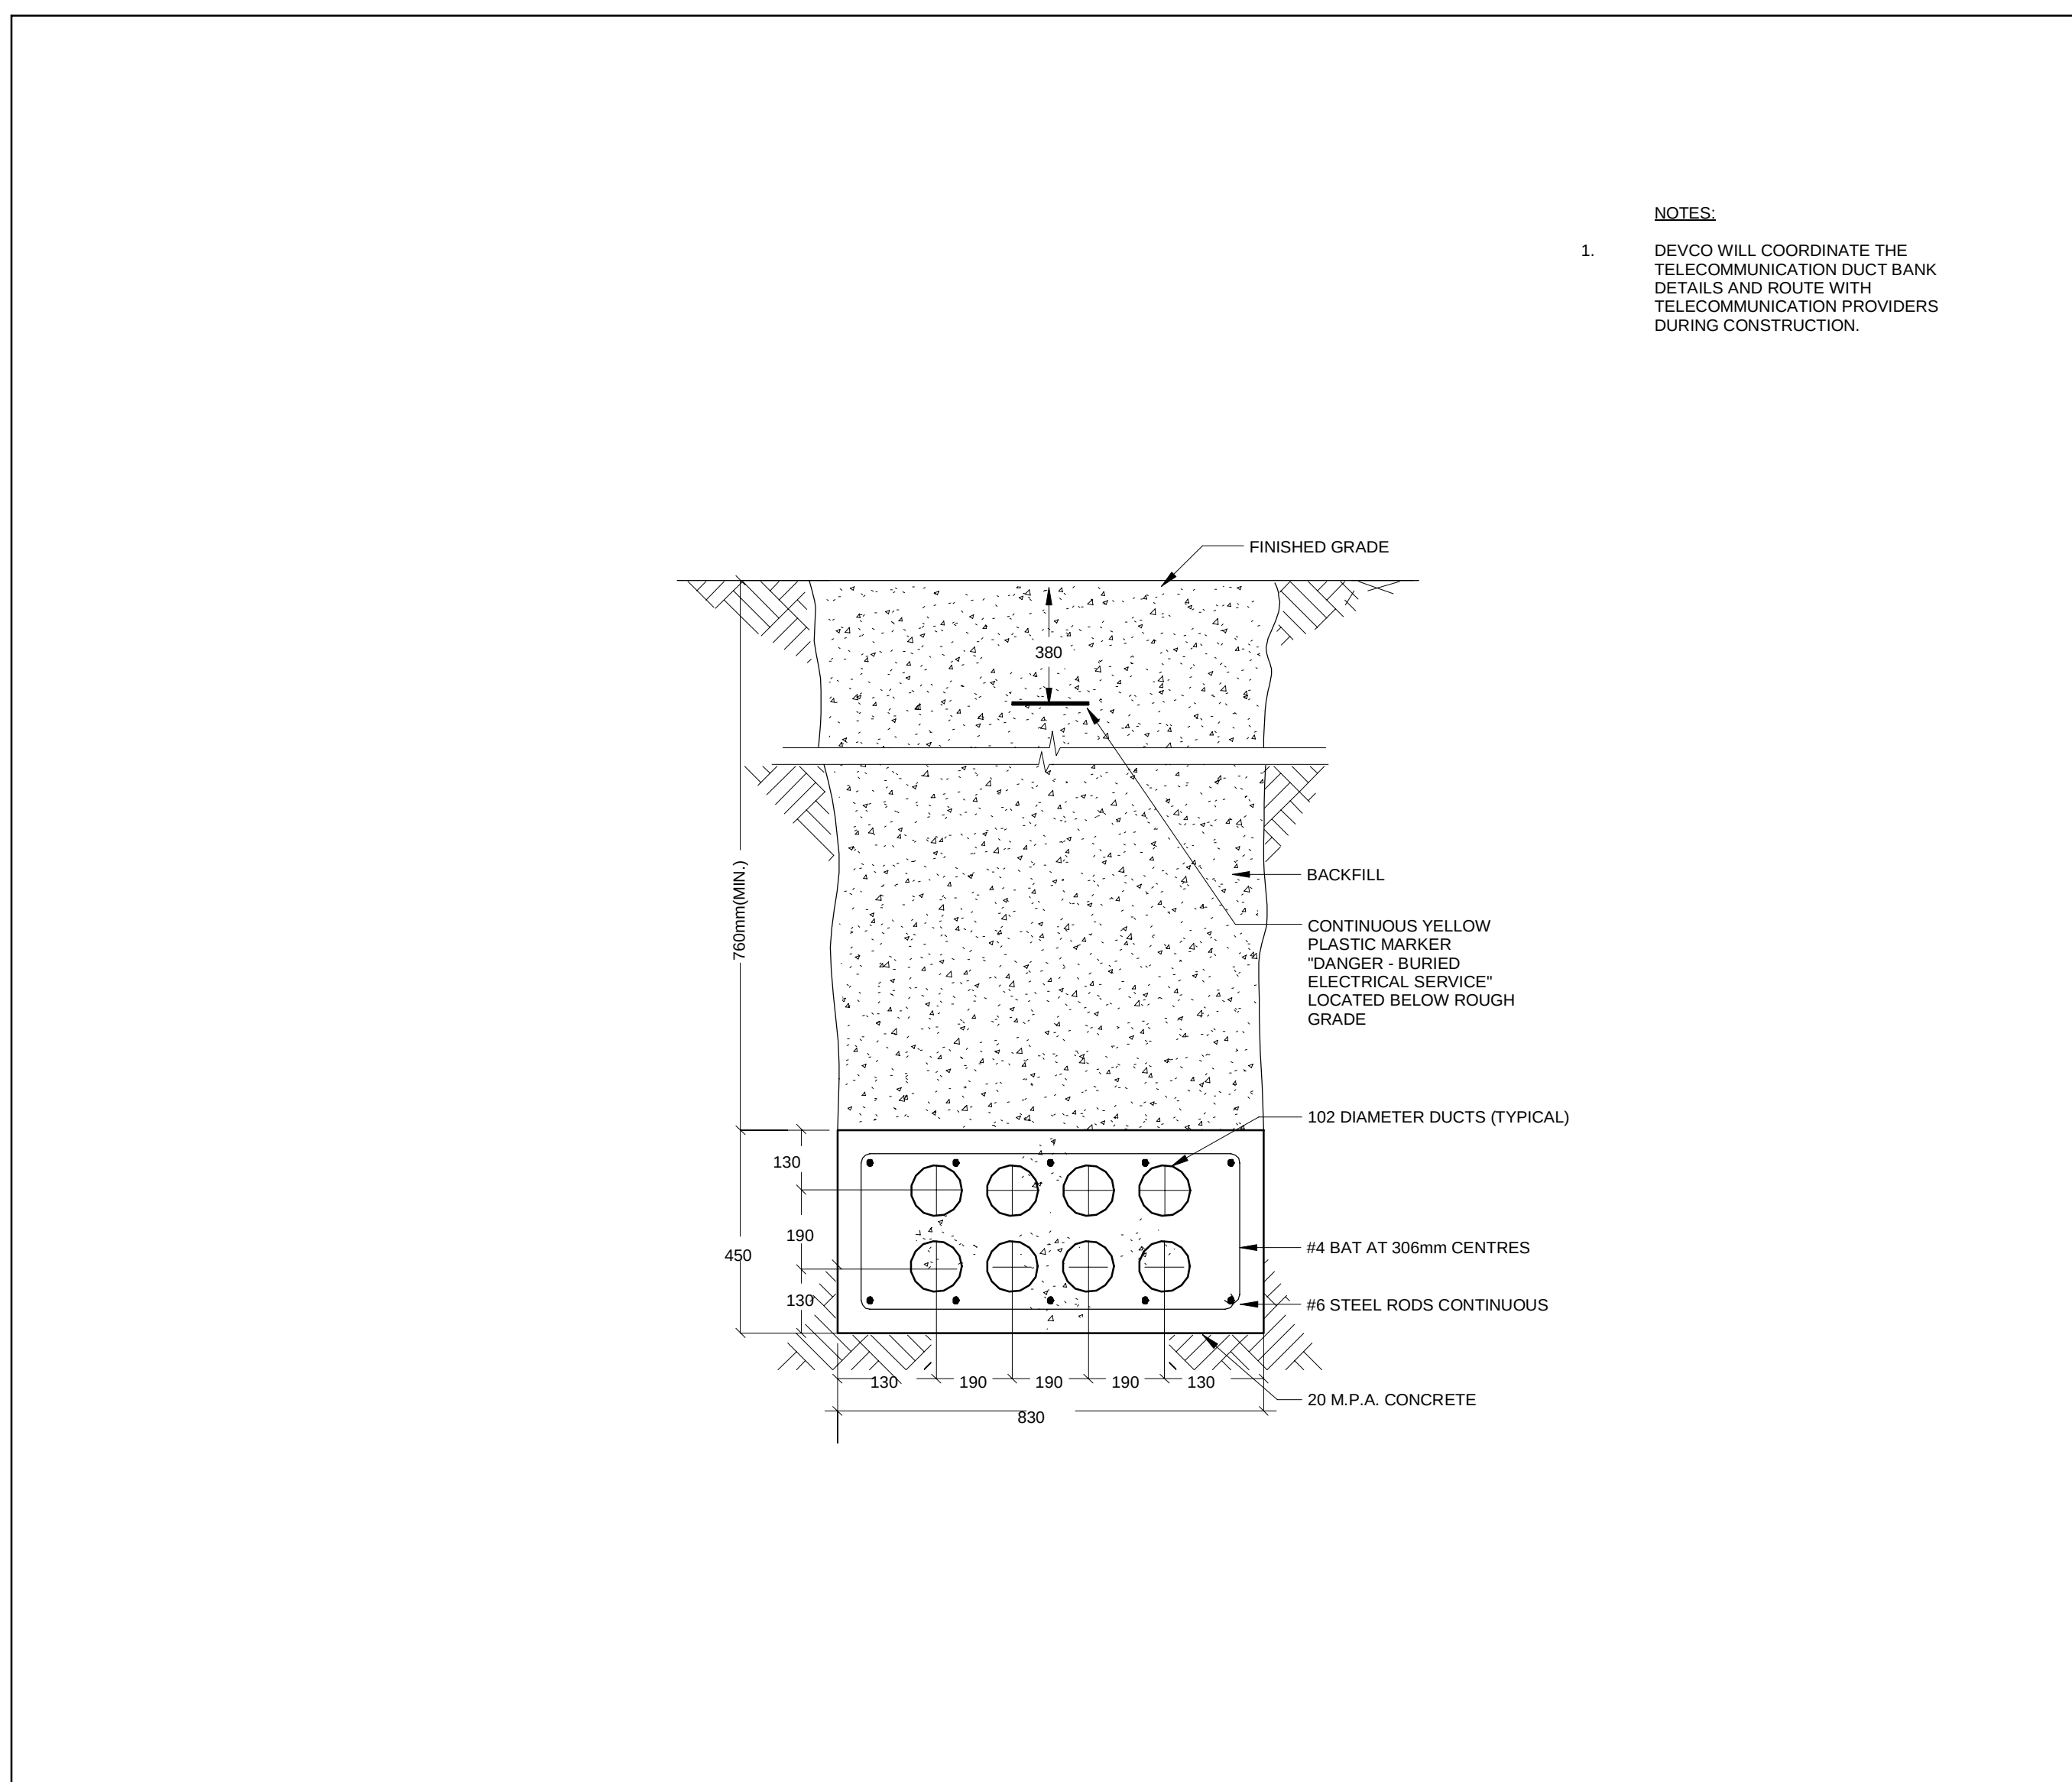


3 TELECOMM DUCT BANK - ENTRANCE FACILITY NORTH
E1-601 N.T.S.

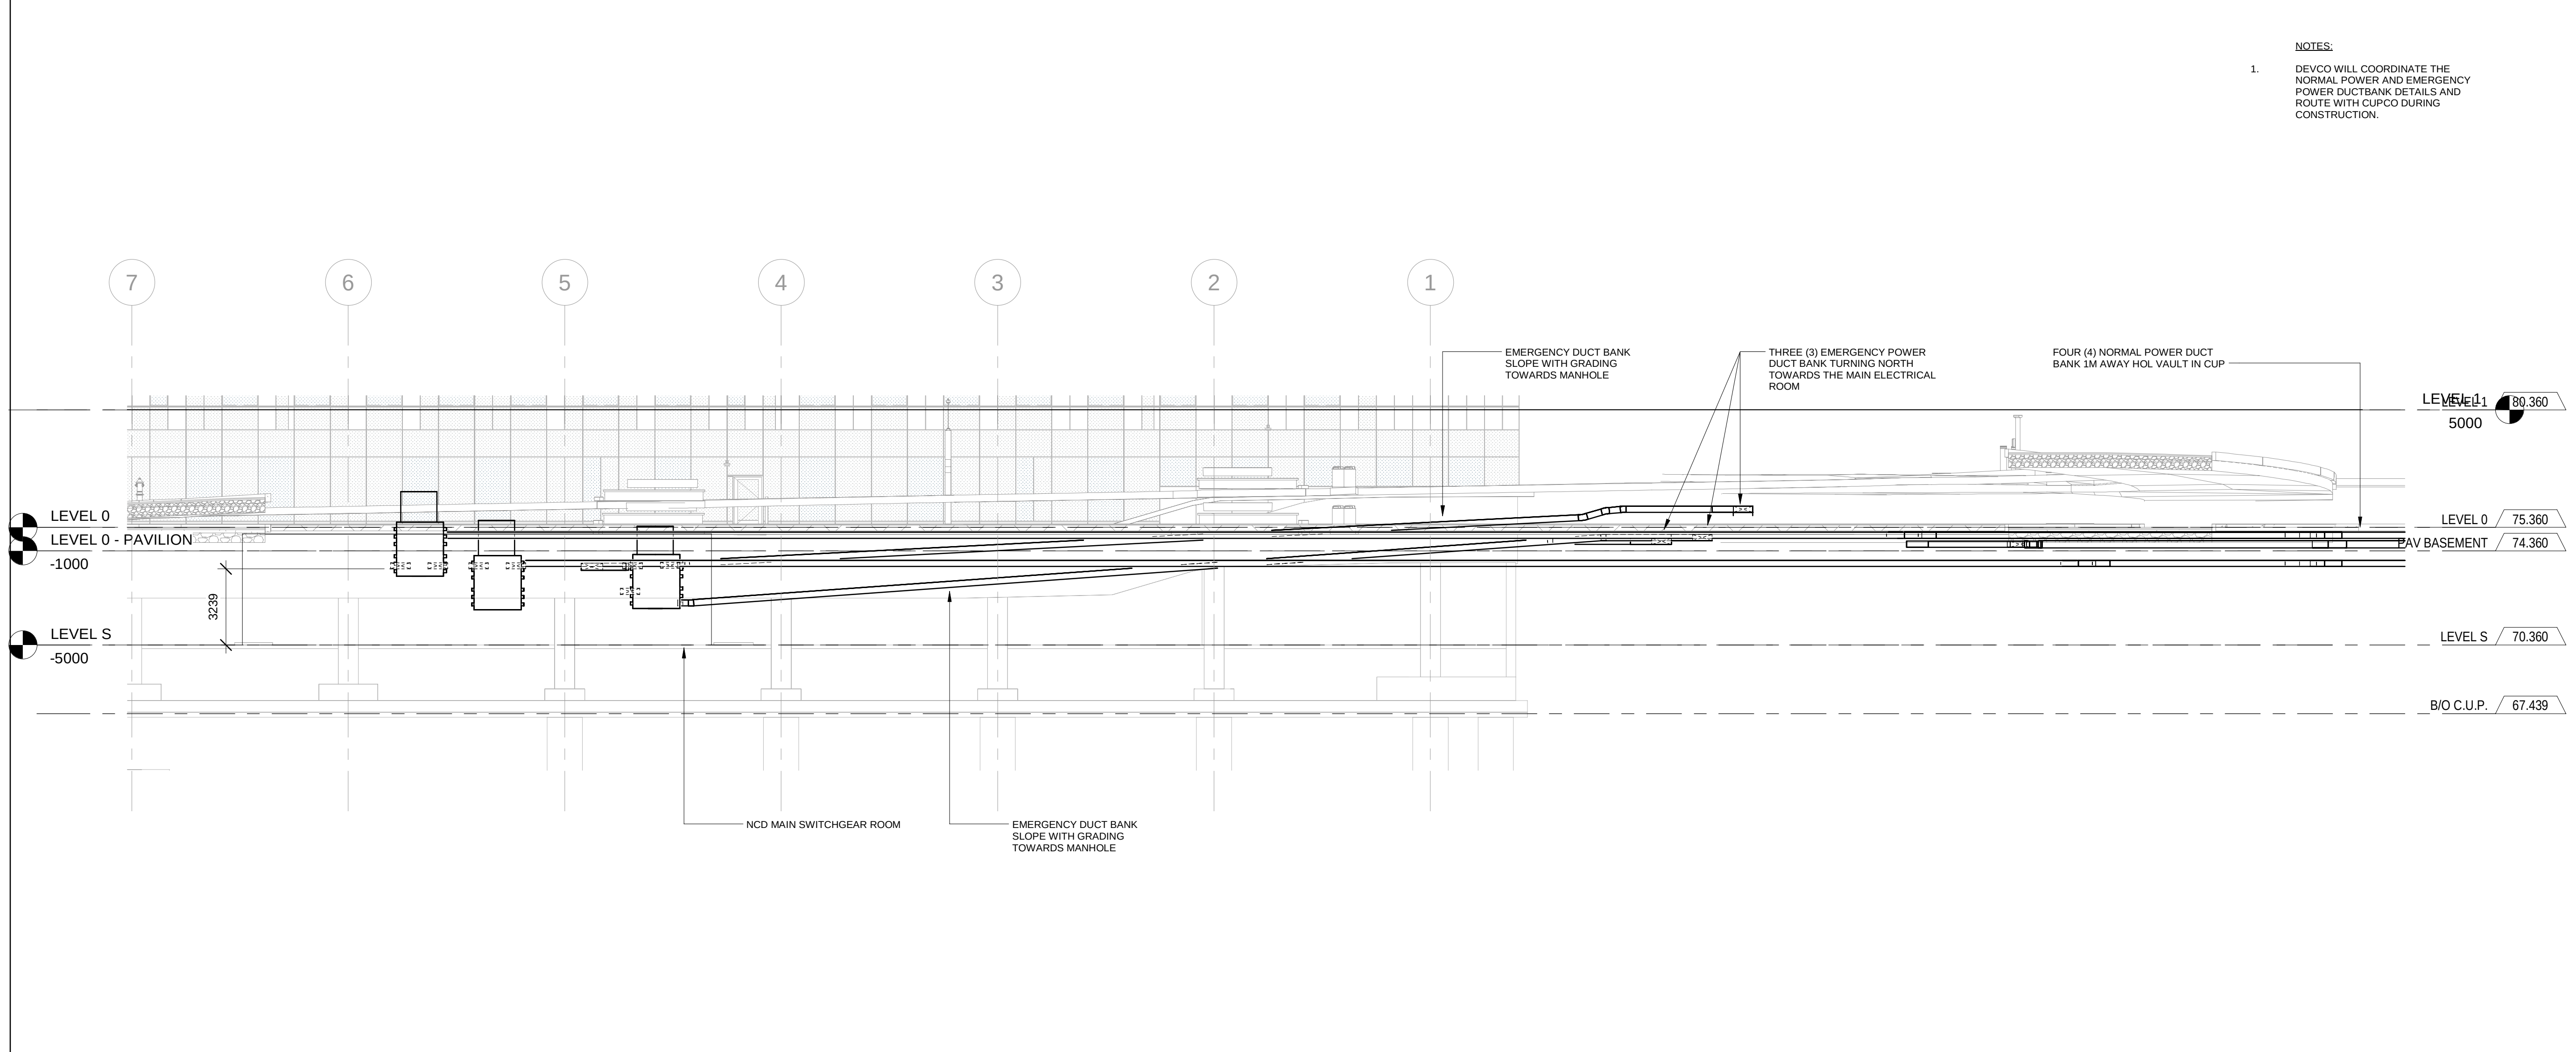


6 INCOMING DUCT BANK SECTION EAST-WEST
E1-601 1 : 150

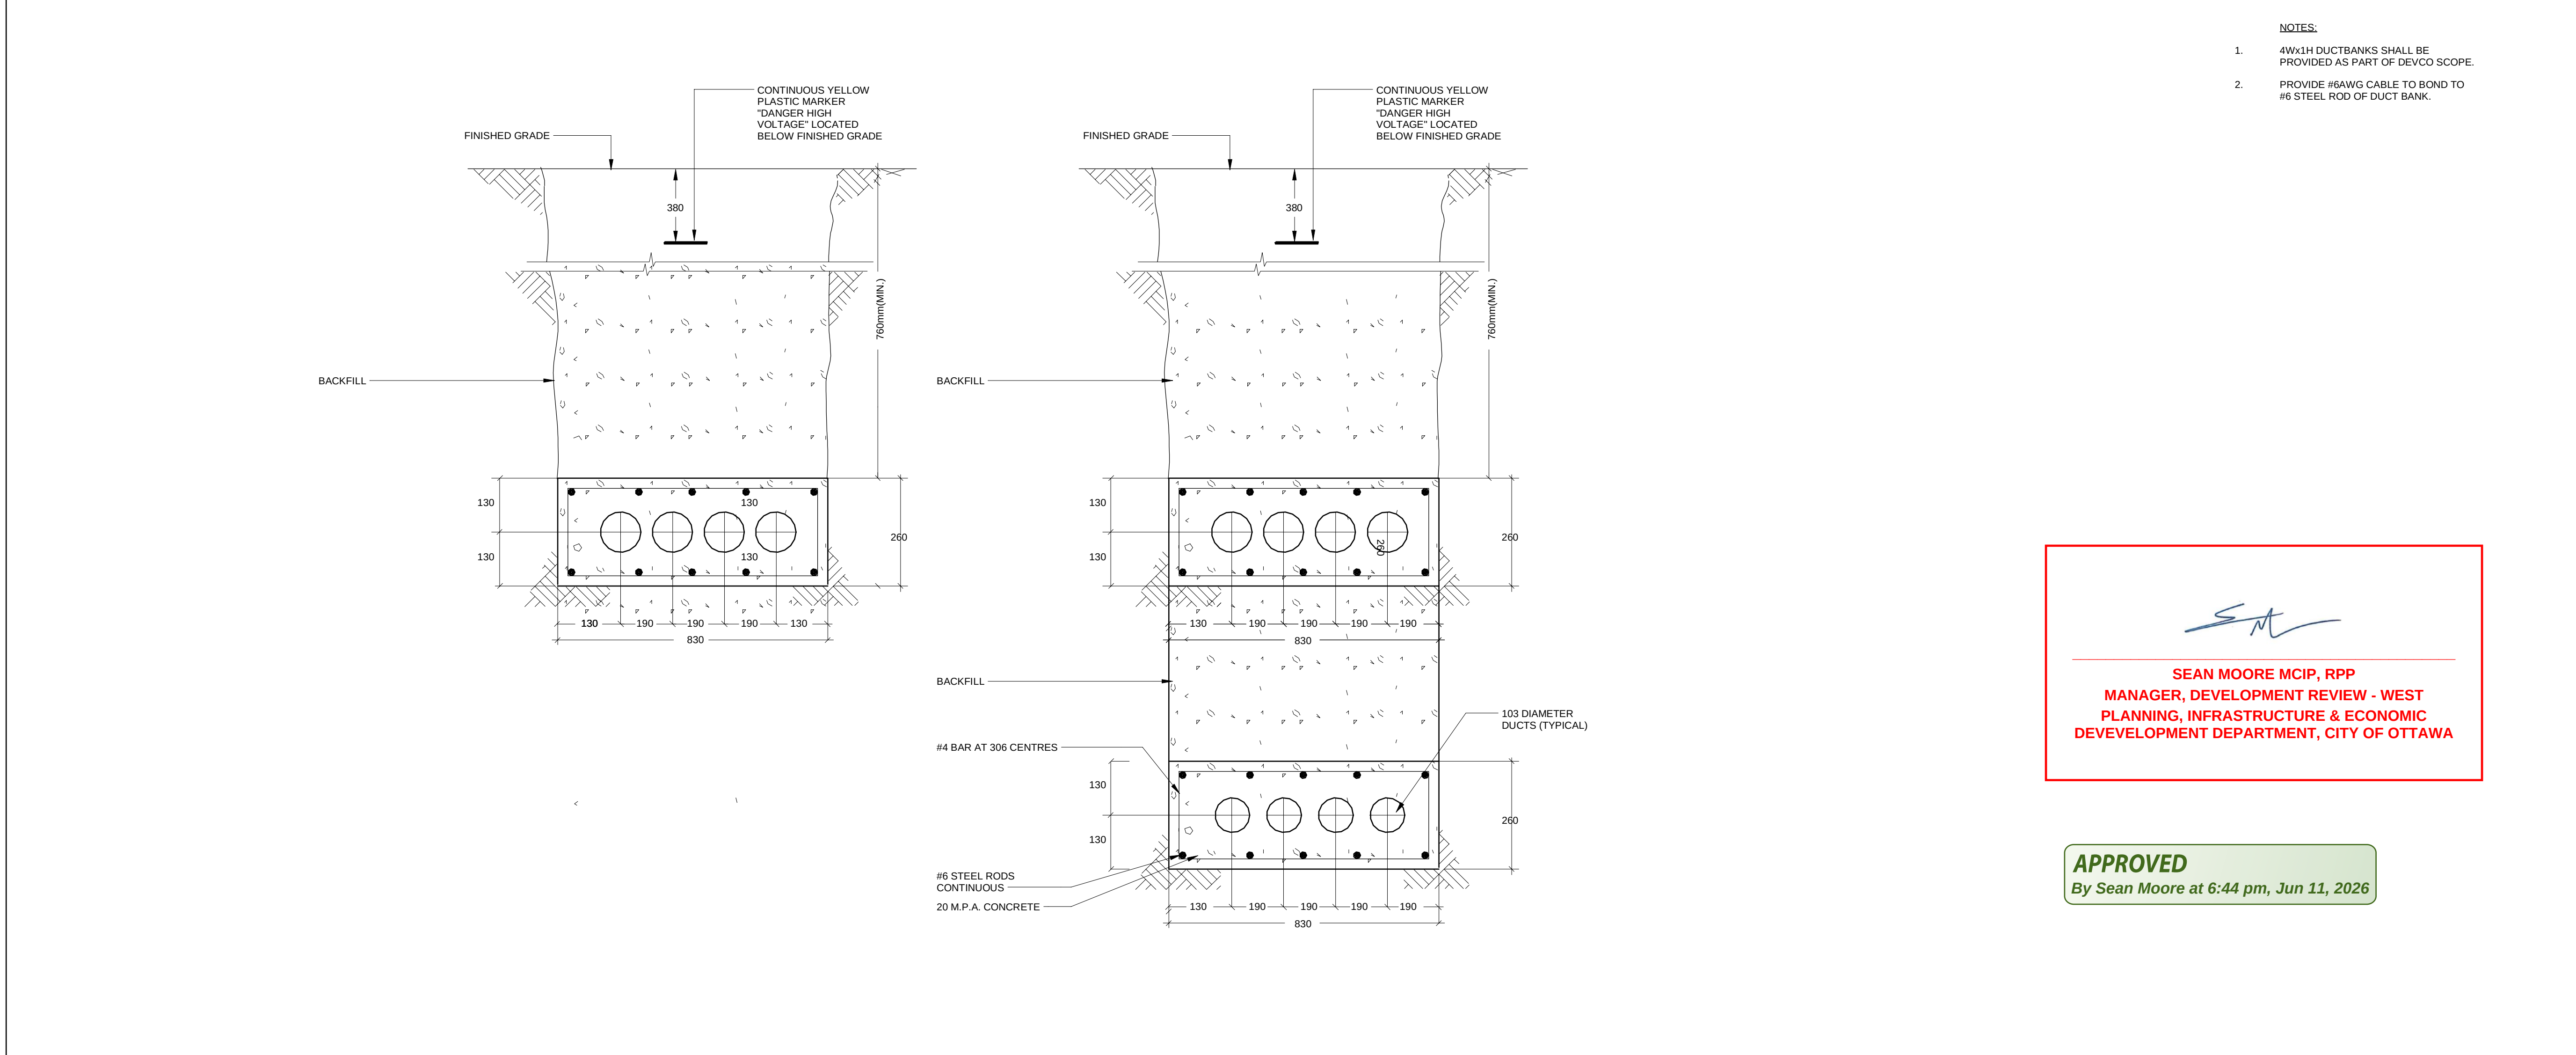

2 EMERGENCY POWER DUCT BANK DETAIL FROM MANHOLE
E1-601 N.T.S.

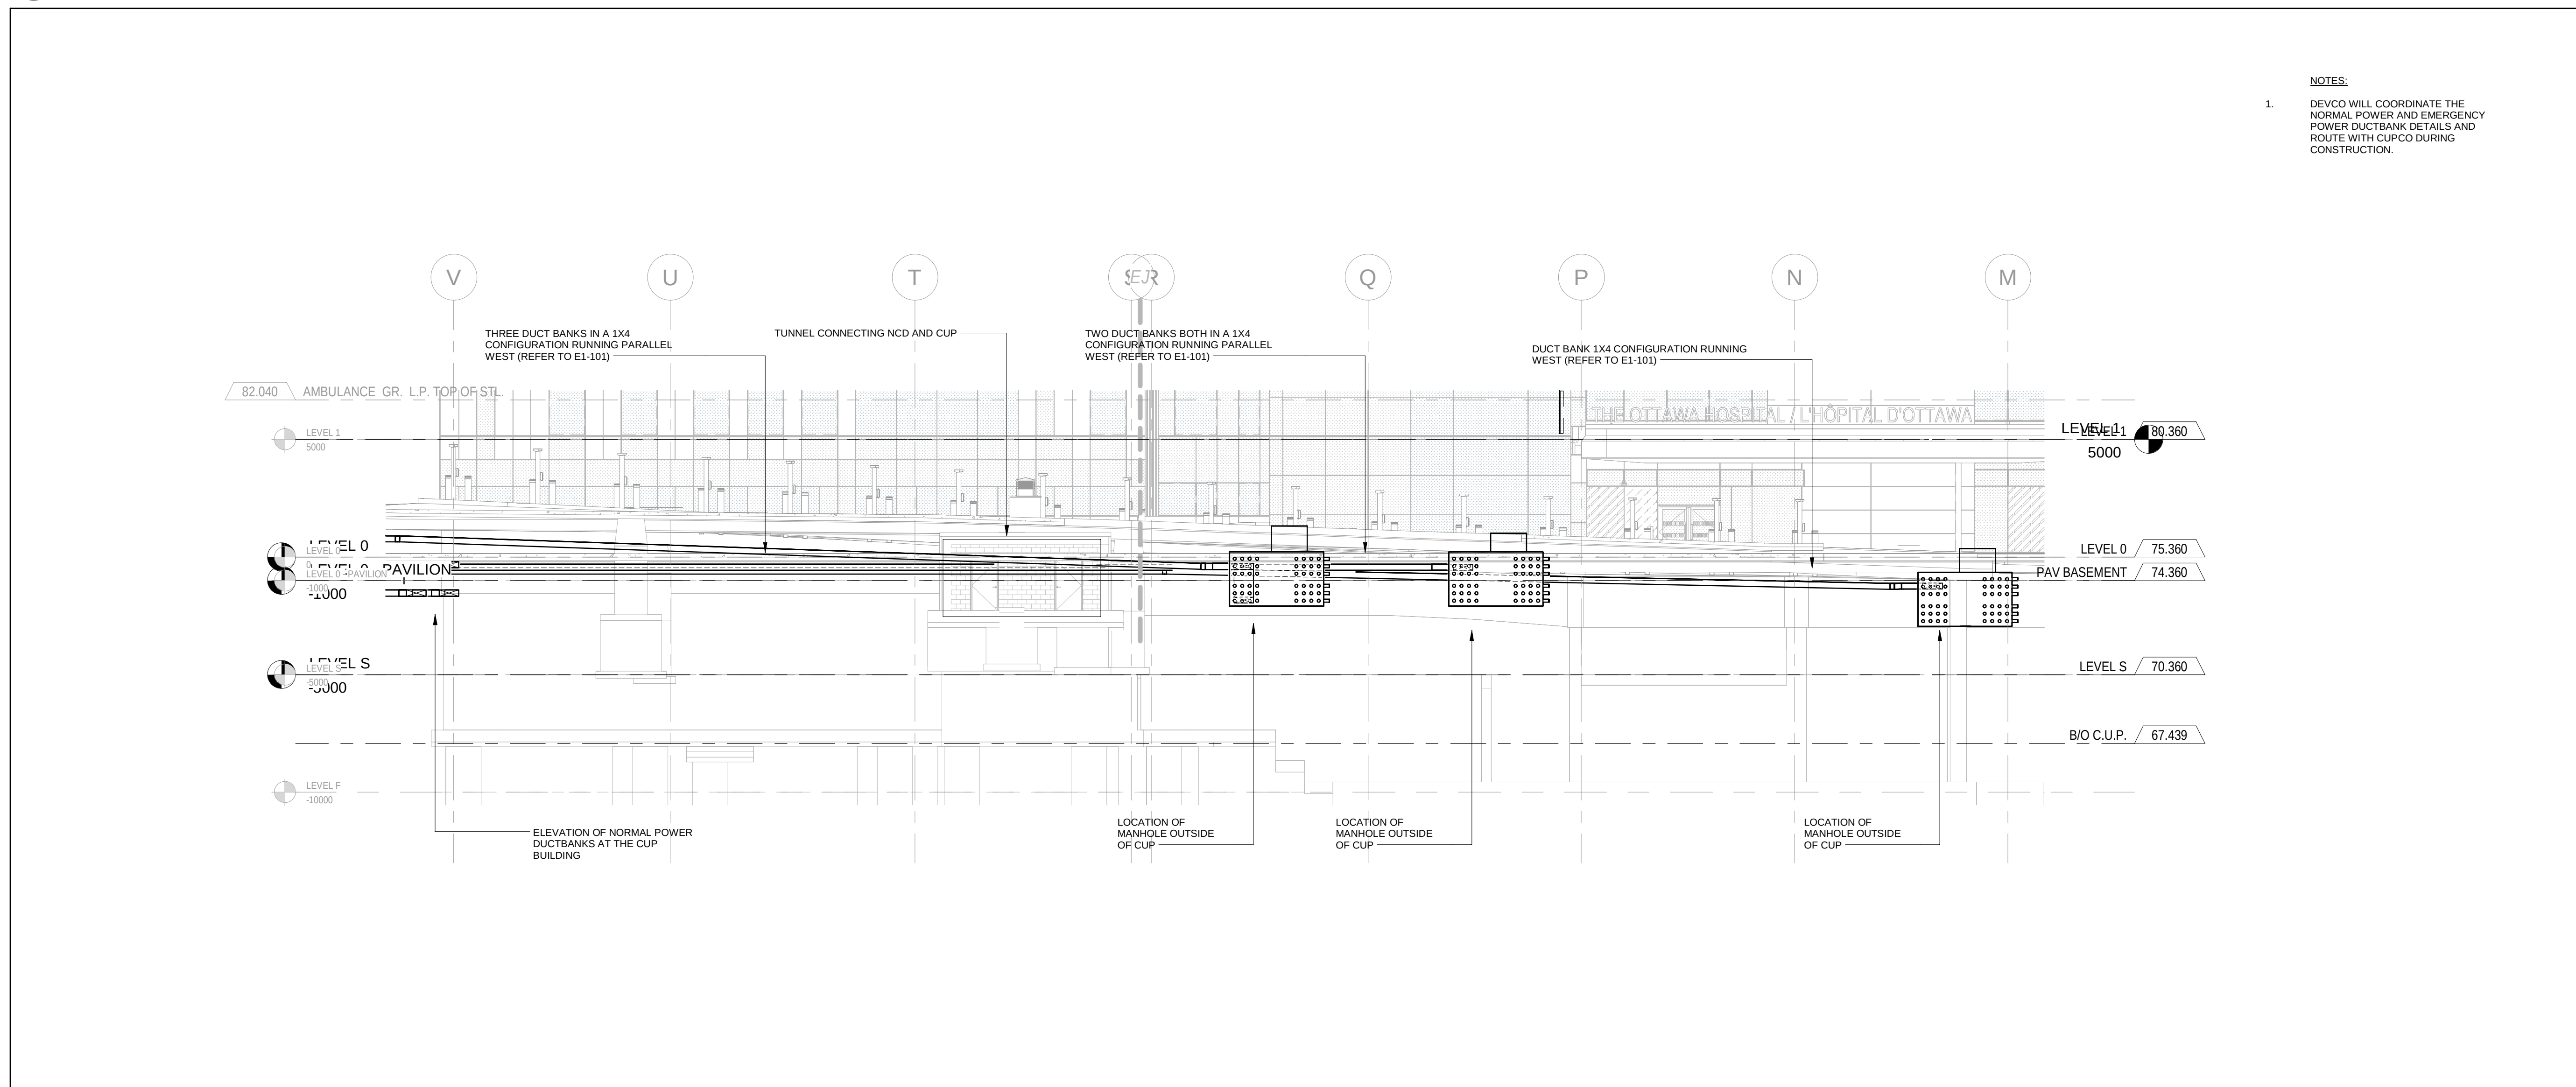

5 INCOMING DUCT BANK SECTION NORTH-SOUTH
E1-601 1 : 150

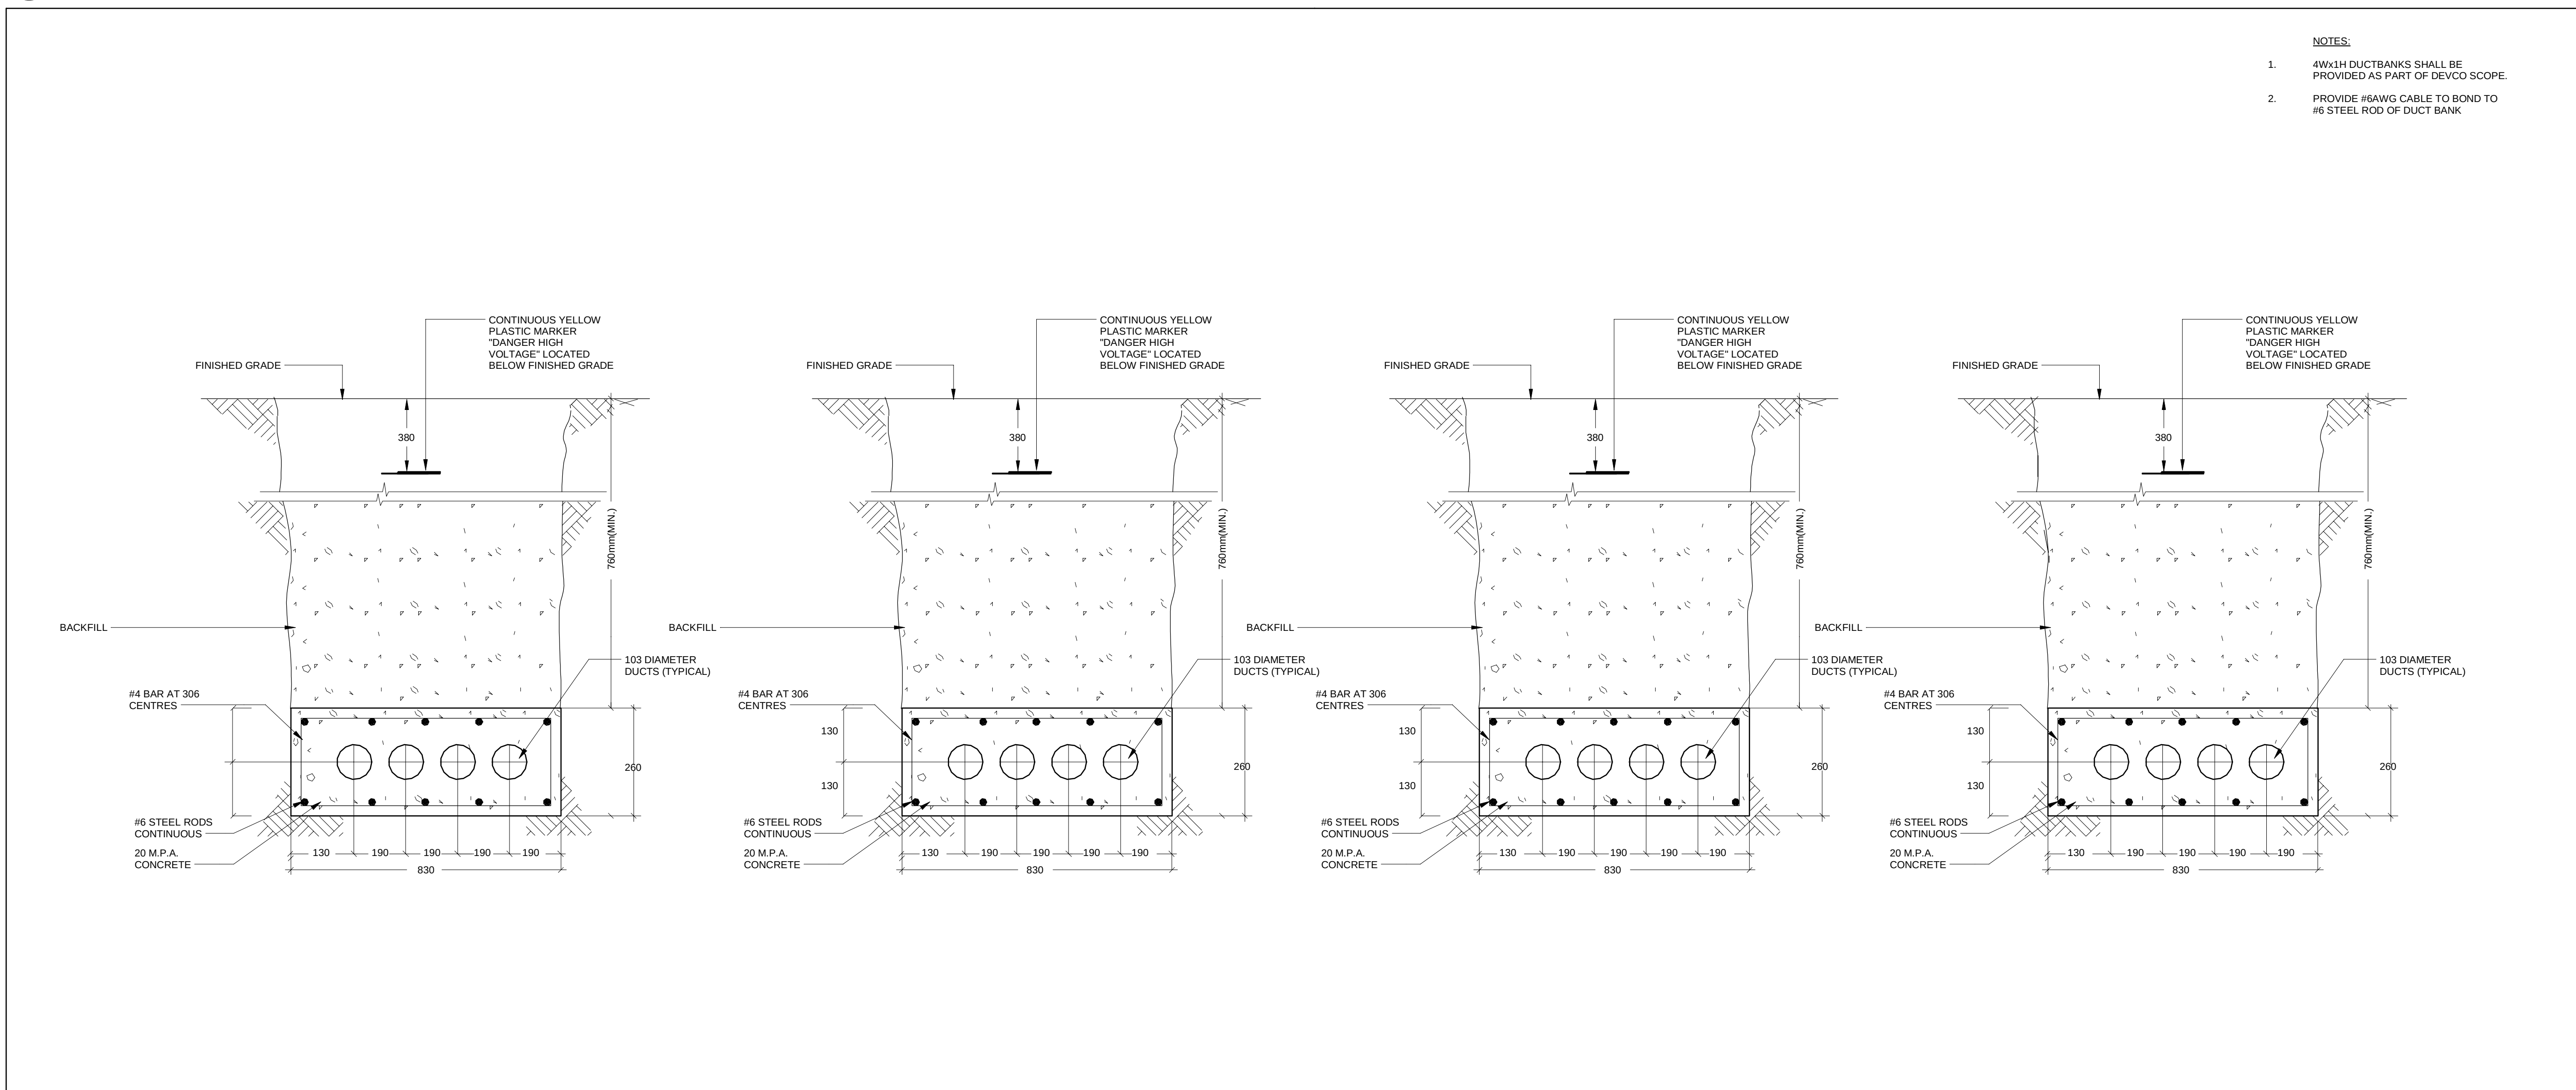

1 NORMAL POWER DUCT BANK DETAIL FROM MANHOLE
E1-601 N.T.S.

PROJECT

**THE OTTAWA HOSPITAL
NEW CAMPUS
DEVELOPMENT -
PHASE 4 MAIN HOSPITAL
BUILDING**

900 CARLING AVE. OTTAWA, ONTARIO

CLIENT

The Ottawa Hospital | L'Hôpital d'Ottawa

Infrastructure Ontario

PCL CONSTRUCTION | EllisDon

CLIENT PROJECT NO.

1070002

KEY PLAN

TRUE NORTH PROJECT NORTH

06 SITE PLAN CONTROL RESUBMISSION 2025-01-12
05 35% DO SUBMISSION 2025-09-10
04 SITE PLAN CONTROL RESUBMISSION 2025-06-05
03 15% DO SUBMISSION 2025-06-05
02 35% DO SUBMISSION 2025-01-28
01 80% DO SUBMISSION 2024-08-15
NCD ISSUED DATE

REVISIONS

DRAWING STATUS

NOT FOR CONSTRUCTION

DISCREPANCIES MUST BE REPORTED IMMEDIATELY TO THE ARCHITECT BEFORE PROCEEDING. ONLY DIMENSIONS ARE TO BE USED. CONTRACTORS MUST CHECK ALL DIMENSIONS ON SITE. THIS DRAWING IS PROTECTED BY COPYRIGHT.

ALL DIMENSIONS ARE SHOWN IN METRIC.

AUTHOR

MULVEY & BANANI

90 Sheppard Avenue East, Suite 500, Toronto, ON M2N 3A1
416-751-2525 | MBI.COM

PROJECT TEAM

DESIGN-BUILDER: PJCLD, A JOINT VENTURE

ARCHITECTURAL: PARSON ARCHITECTS LIMITED
2000 LAMARKE PRATTE ARCHITECTS
ADAMSON ASSOCIATE ARCHITECTS
800 ARCHITECTS OTTAWA INC.

STRUCTURAL: STEPHENSON ENGINEERING LTD.
BOUTHILLETTE PARDEAU INC.

MECHANICAL: HH ANGUS & ASSOCIATES LTD.
CROSSEY ENGINEERING LTD.

ELECTRICAL: MULVEY & BANANI INTERNATIONAL INC.
HWP CANADA INC.

CIVIL: VERTECHO DESIGN INC.

LANDSCAPE: PWP LANDSCAPE ARCHITECTURE

BUILDING CODE: LMDO BUILDING CODE CONSULTANTS LTD.

AUTHOR PROJECT NO.

2233-00

STAMP

DRAWING TITLE

**ELECTRICAL SITE
DETAILS**

DRAWN

CHECKED

SCALE AT 40' x 60'

NTS

DATE

08/15/24

GRAPHIC SCALE

DRAWING NO.

E1-601

REV NO.

06