




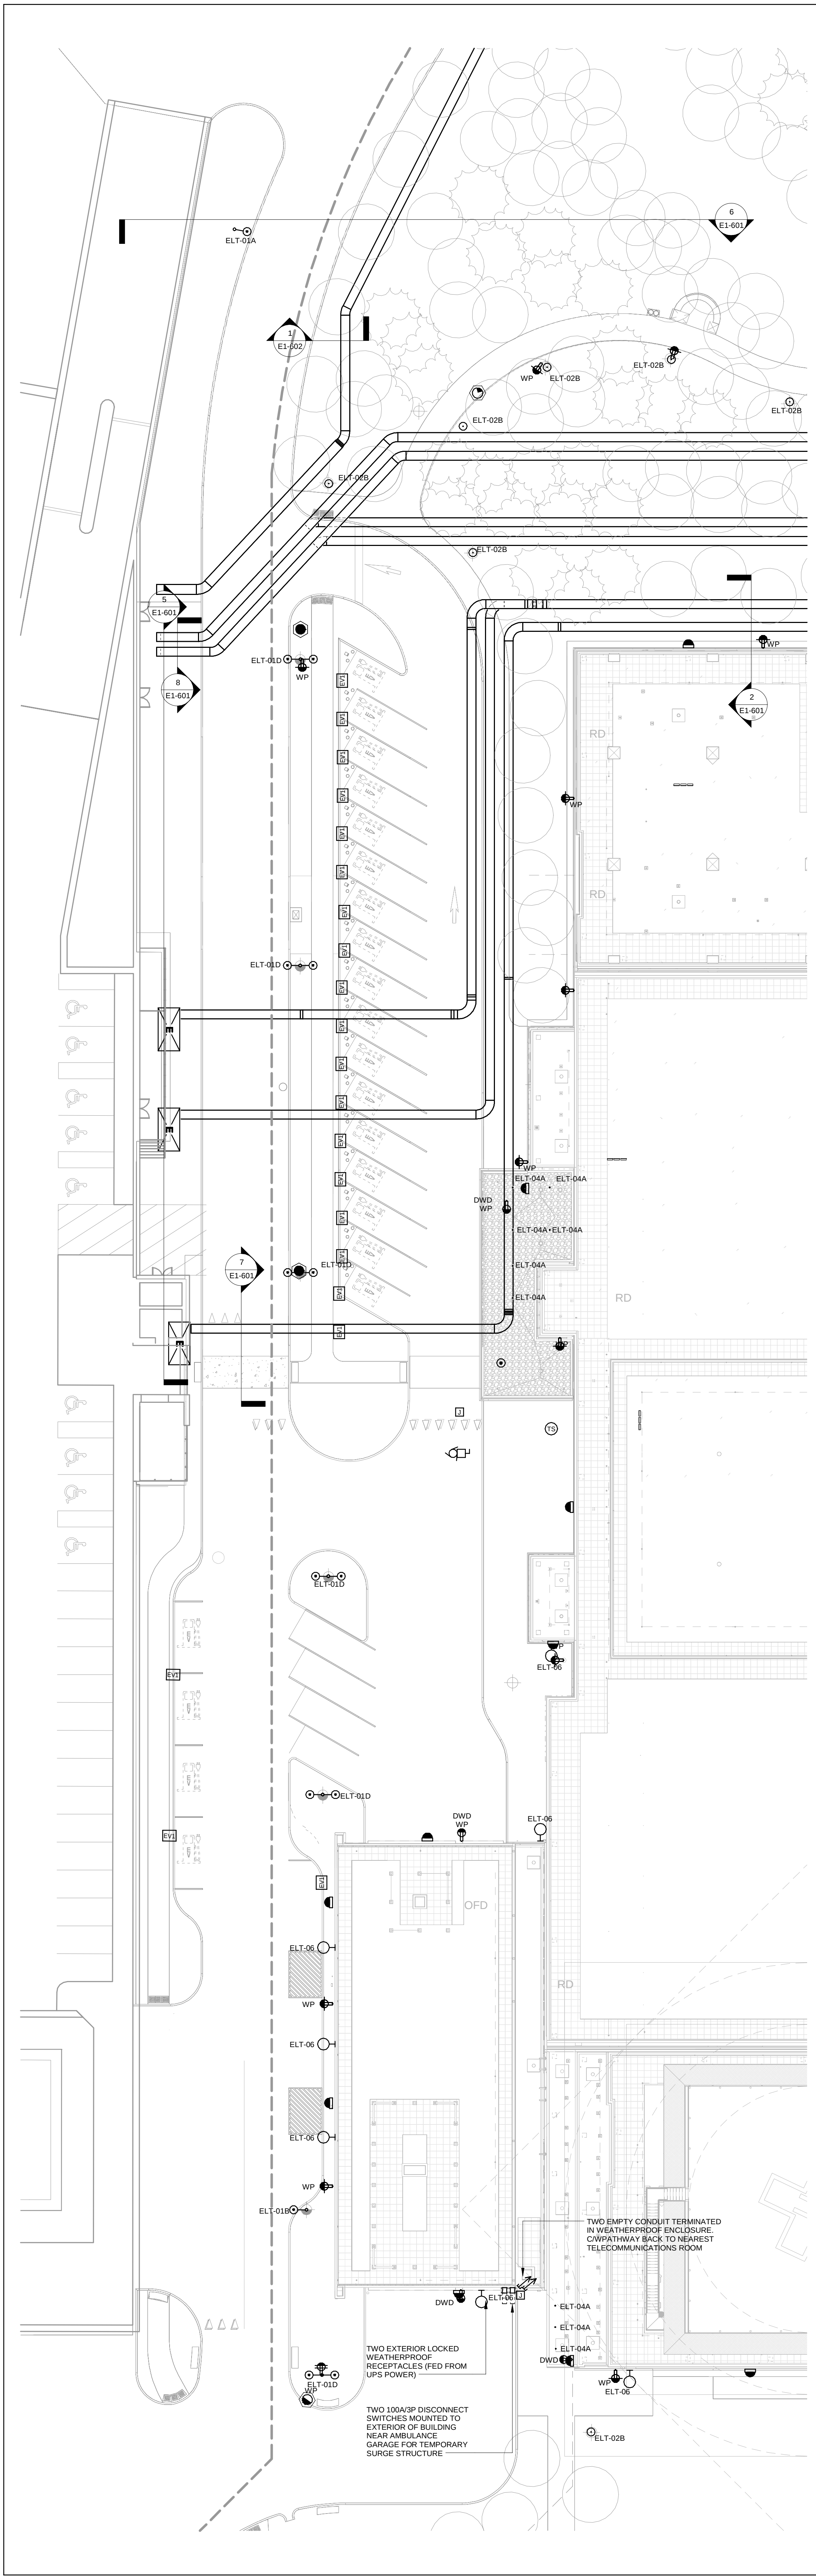

3 ELECTRICAL - ZONE 5A LEVEL 0 - EMERGENCY SERVICES PARKING (SOUTH)
E1-101.1 1: 250

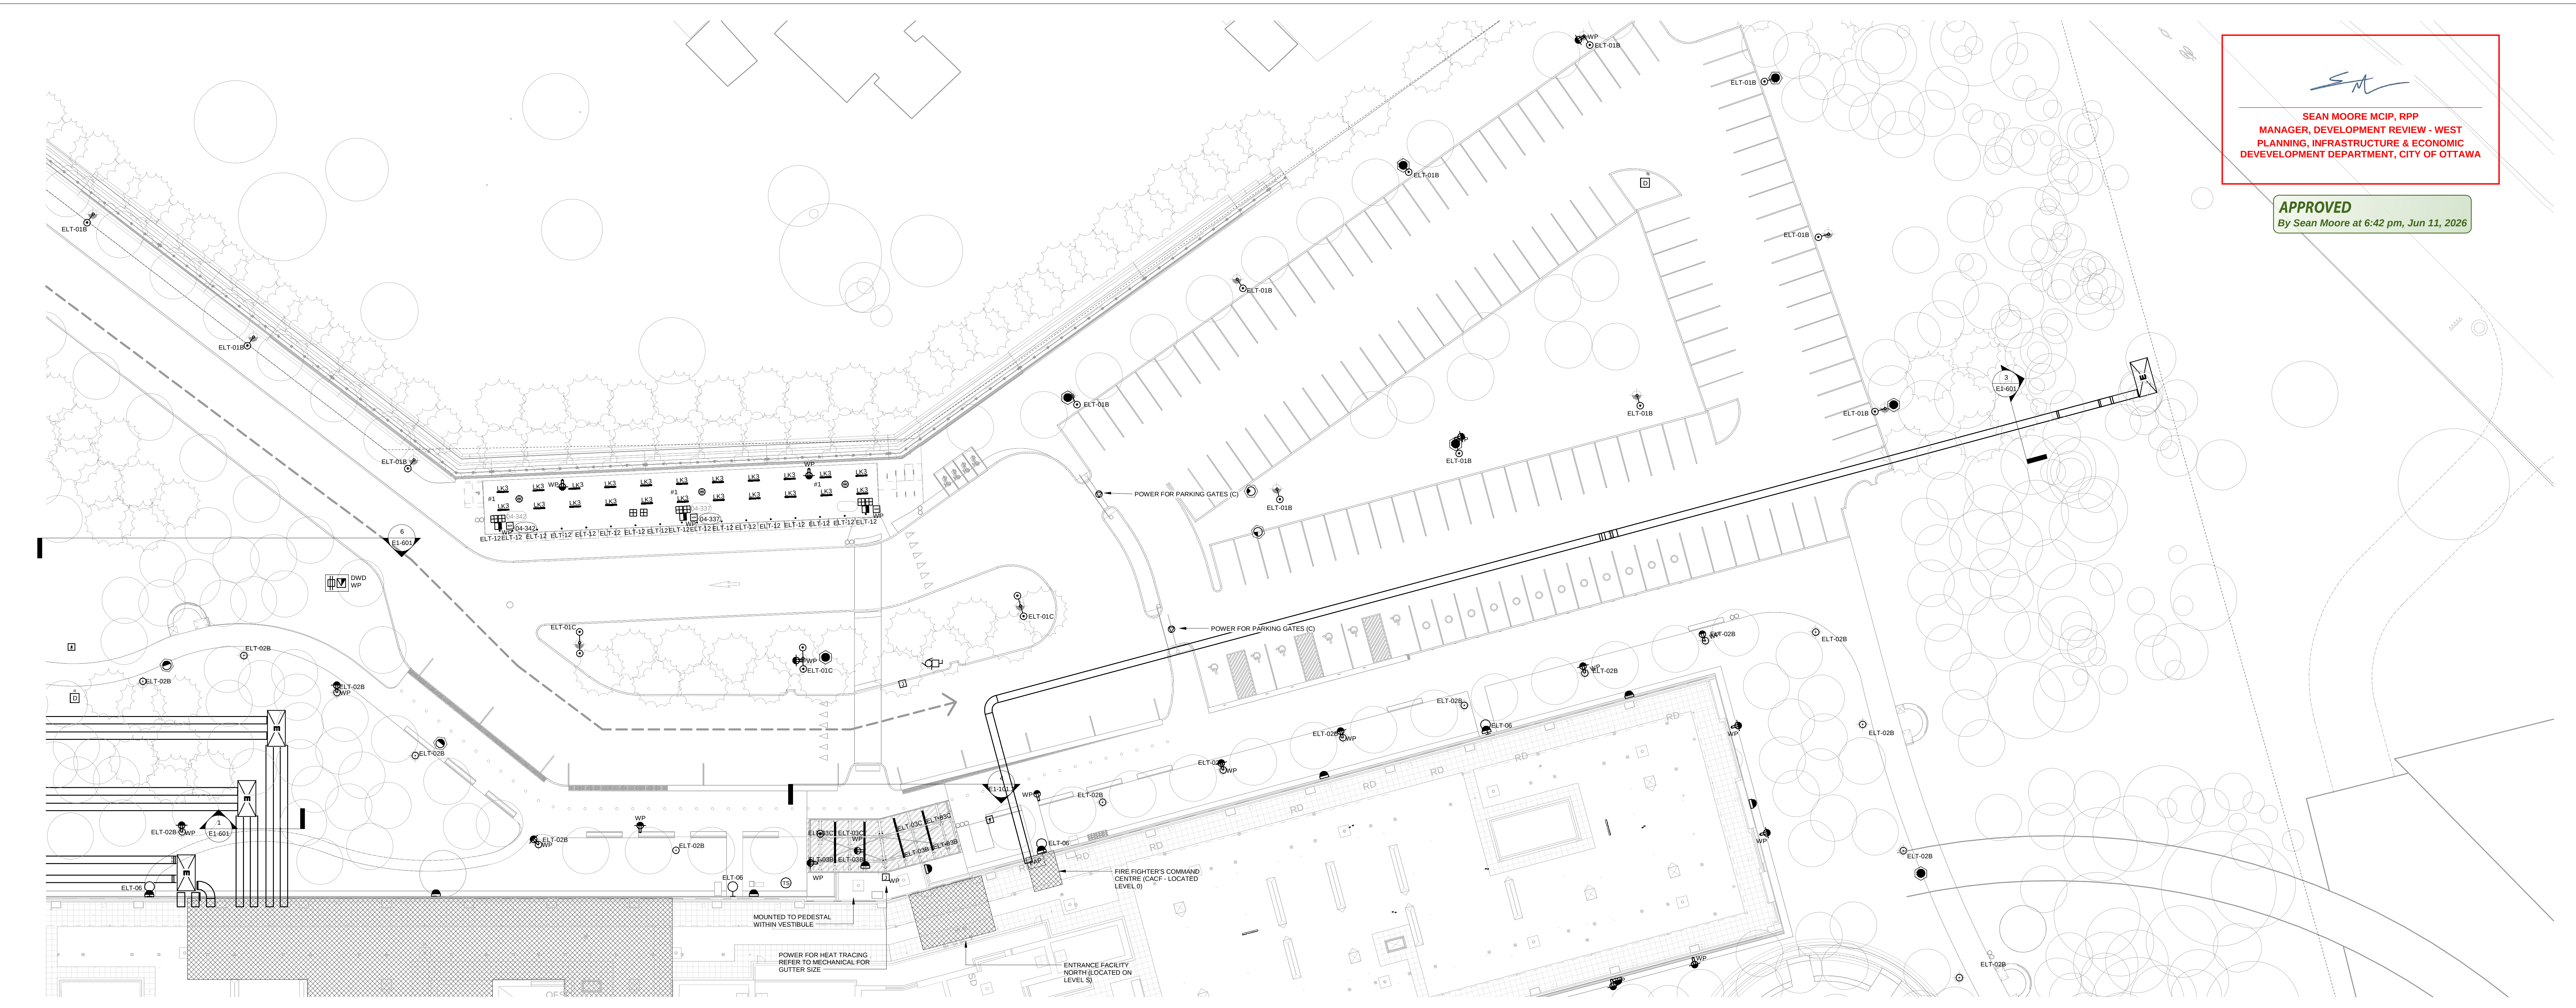

2 ELECTRICAL - ZONE 1 LEVEL 0 - WEST PARKING LOT
E1-101.1 1: 250

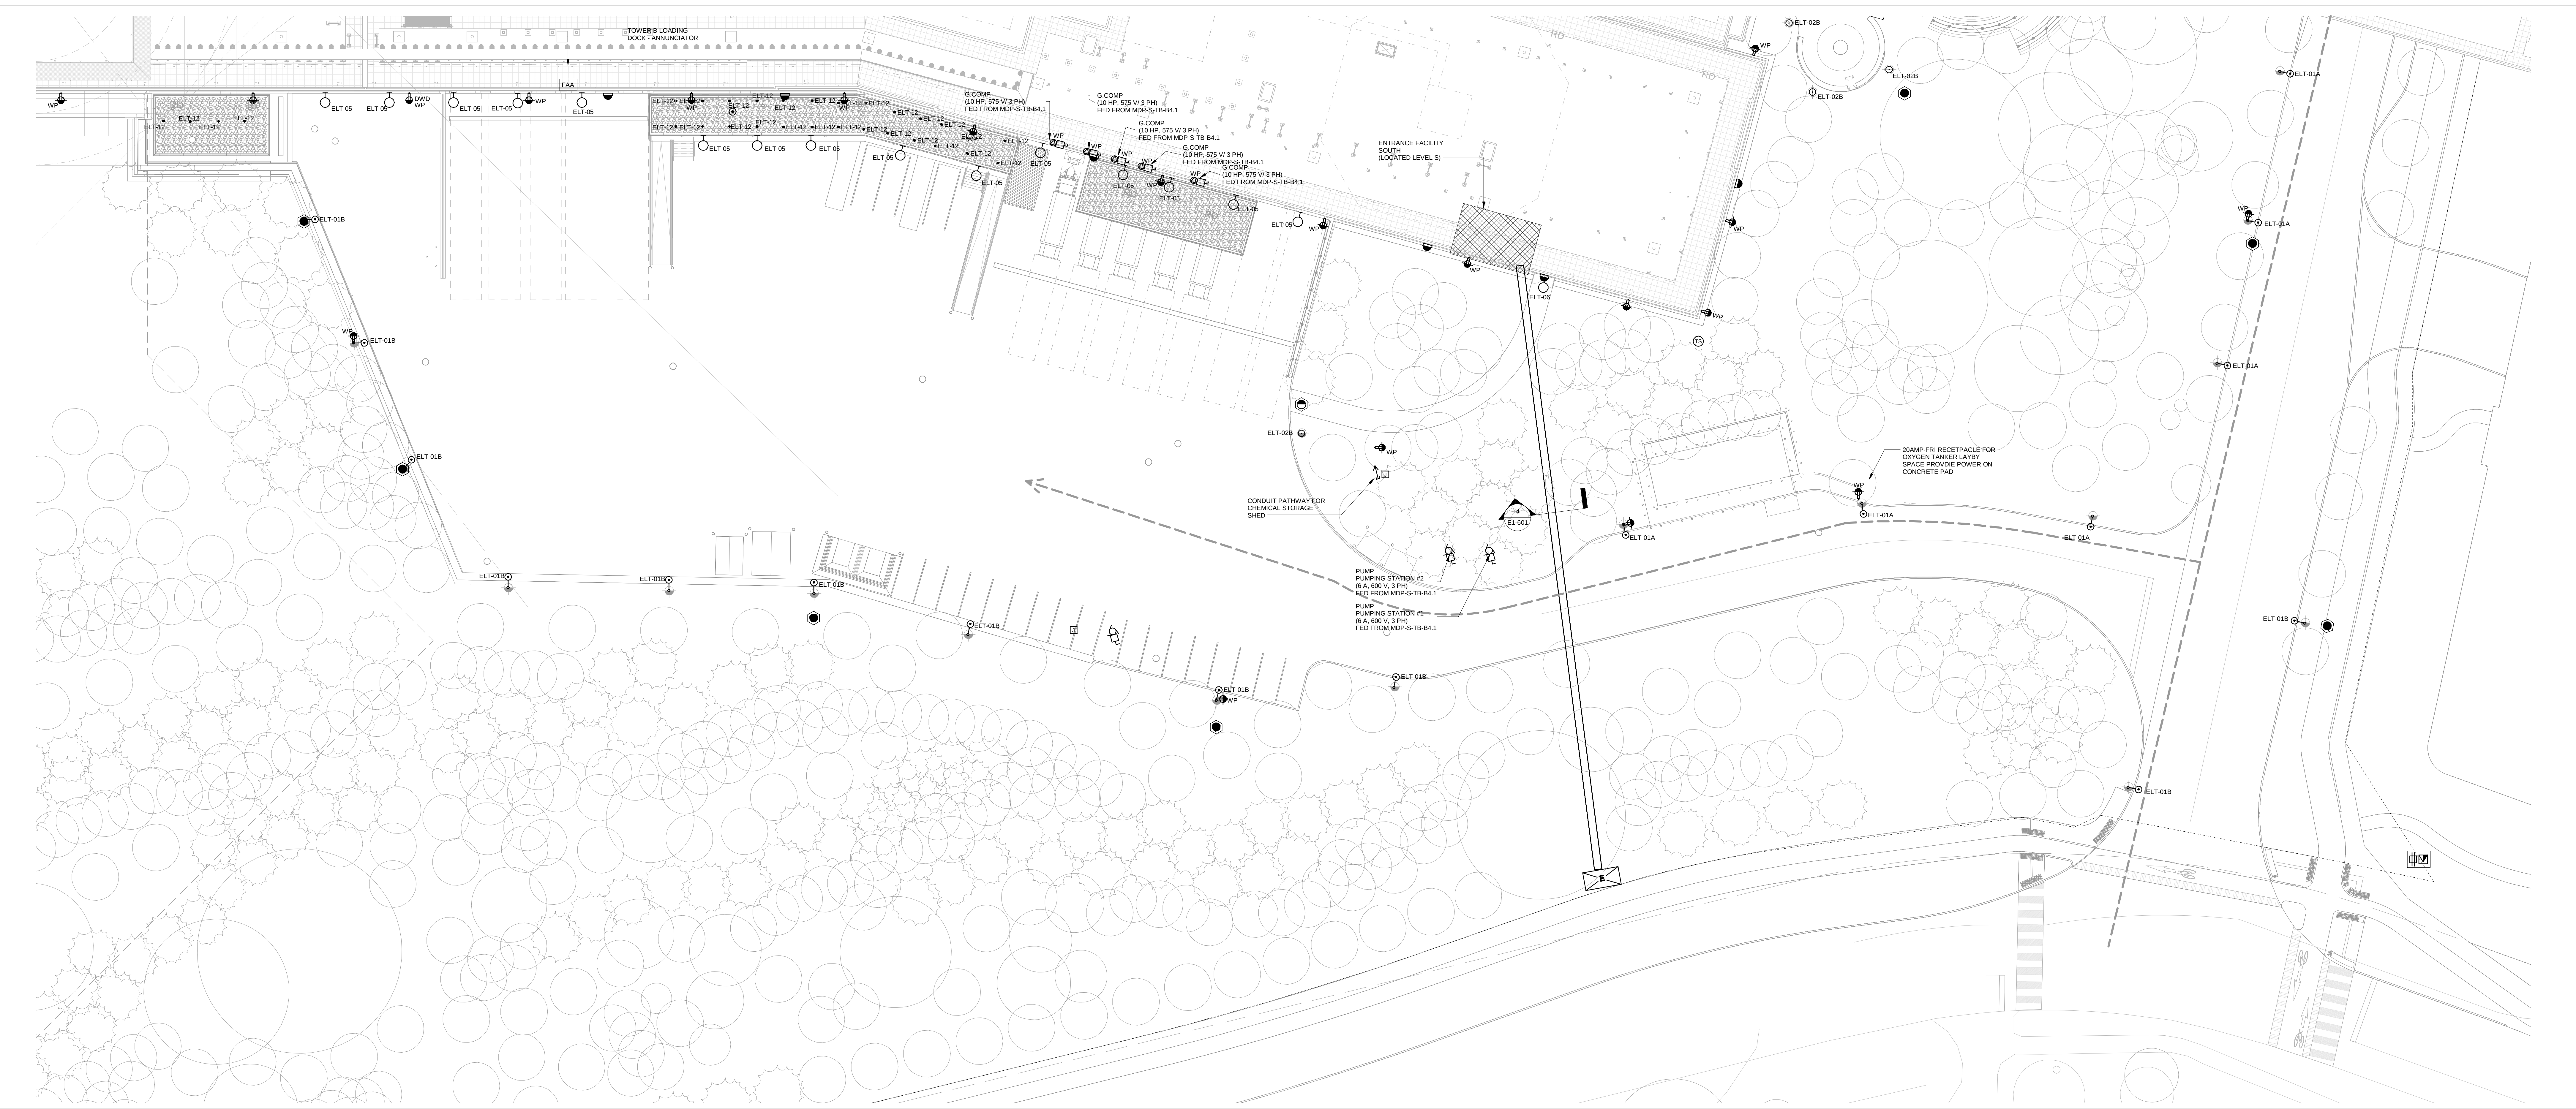

1 ELECTRICAL - ZONE 3 LEVEL S - LOADING DOCK
E1-101.1 1: 250

SEAN MOORE MCP, RPP
MANAGER, DEVELOPMENT REVIEW - WEST
PLANNING, INFRASTRUCTURE & ECONOMIC
DEVELOPMENT DEPARTMENT, CITY OF OTTAWA

APPROVED
By Sean Moore at 6:42 pm, Jun 11, 2026

PROJECT
**THE OTTAWA HOSPITAL
NEW CAMPUS
DEVELOPMENT -
PHASE 4 MAIN HOSPITAL
BUILDING**
900 CARLING AVE. OTTAWA, ONTARIO

CLIENT
**The Ottawa
Hospital** | **L'Hôpital
d'Ottawa**

**Infrastructure
Ontario**

PCL CONSTRUCTION | **EllisDon**

CLIENT PROJECT NO.
1070002

KEY PLAN
TRUE NORTH | PROJECT NORTH

REVISIONS

NO.	DESCRIPTION	DATE
01	SITE PLAN CONTROL RESUBMISSION	2026-01-12
02	15% DD SUBMISSION	2025-08-19
03	SITE PLAN CONTROL RESUBMISSION	2025-06-08
04	65% DD SUBMISSION	2025-06-05
05	35% DD SUBMISSION	2025-01-20
NO	DATE	

DISCREPANCIES MUST BE REPORTED IMMEDIATELY TO THE ARCHITECT BEFORE PROCEEDING. ONLY DIMENSIONS SHOWN ON SITE. THIS DRAWING IS PROTECTED BY COPYRIGHT.

ALL DIMENSIONS ARE SHOWN IN METRIC.

AUTHOR

MULVEY & BANANI
90 Sheppard Avenue East, Suite 501, Toronto, ON M2N 3A1
416.751.2521 | MBI.COM

PROJECT TEAM

DESIGN-BUILDER: PCL, A JOINT VENTURE

ARCHITECTURAL: PARSON ARCHITECTS LIMITED
JORDAN LAMARCA PRATTE ARCHITECTS
ADAMSON ASSOCIATE ARCHITECTS
BOO ARCHITECTS OTTAWA INC.

STRUCTURAL: STEPHENSON ENGINEERING LTD.
BOUHLLETTE PARDEAU INC.

MECHANICAL: HH ANGUS & ASSOCIATES LTD.
CROSLEY ENGINEERING LTD.

ELECTRICAL: MULVEY & BANANI INTERNATIONAL INC.

CIVIL: WSP CANADA INC.

LANDSCAPE: VERTICUS DESIGN INC.
PWP LANDSCAPE ARCHITECTURE

BUILDING CODE: LMGO BUILDING CODE CONSULTANTS LTD.

AUTHOR PROJECT NO.
2233-00

STAMP

DRAWING NO.
E1-101.1

REV NO.
05

DRAWN: [] CHECKED: []

SCALE: AT 40" x 60"
1: 250

DATE
01/28/25

GRAPHIC SCALE