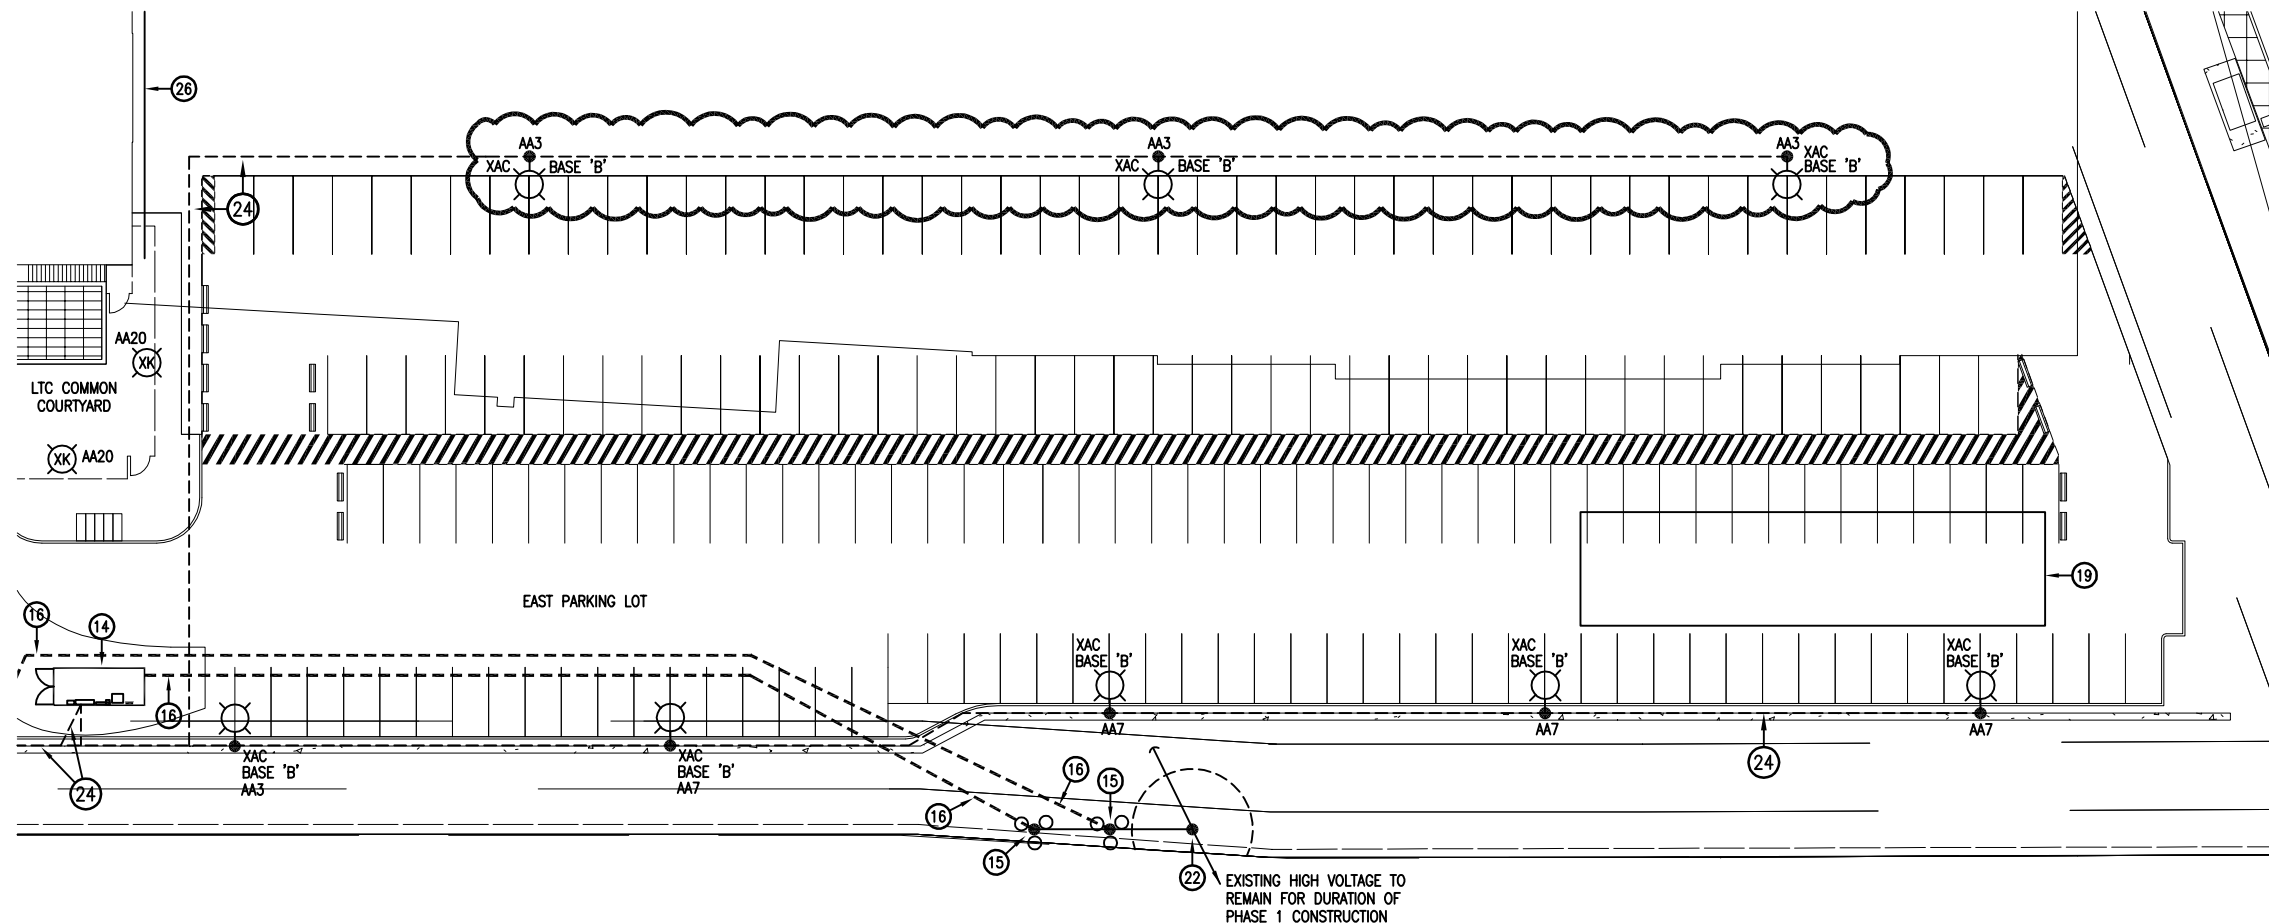


MNE Engineering Inc.
 22 Kevco Place – Box A
 Kitchener, Ontario N2C 2G5
 (519) 894-9408
www.mneengineering.ca

PROJECT: SCHLEGEL VILLAGES OTTAWA – LTC		03	
DRAWING: PARTIAL ELECTRICAL SITE PLAN		02	
DWG NO: SK-E39	JOB NO: 21020	01	BULLETIN REQUEST 49
SCALE: 1:500	DRAWING BY: A.A.G.	REV#	REVISION
DATE: JUNE 2025	CHECKED BY: P.J.G.	CLIENT: CORNERSTONE ARCHITECTURE INC.	