


Professional Engineers
Ontario
05/05/26
Licensed Engineering Technologist

Name: H. G. VAN DE GLIND
Number: 100647862

Limitations: Inspecting, designing, and assessing
residential and commercial sewage systems, grading designs
and soil analysis, and overseeing installation and compliance.

Association of Professional Engineers of Ontario

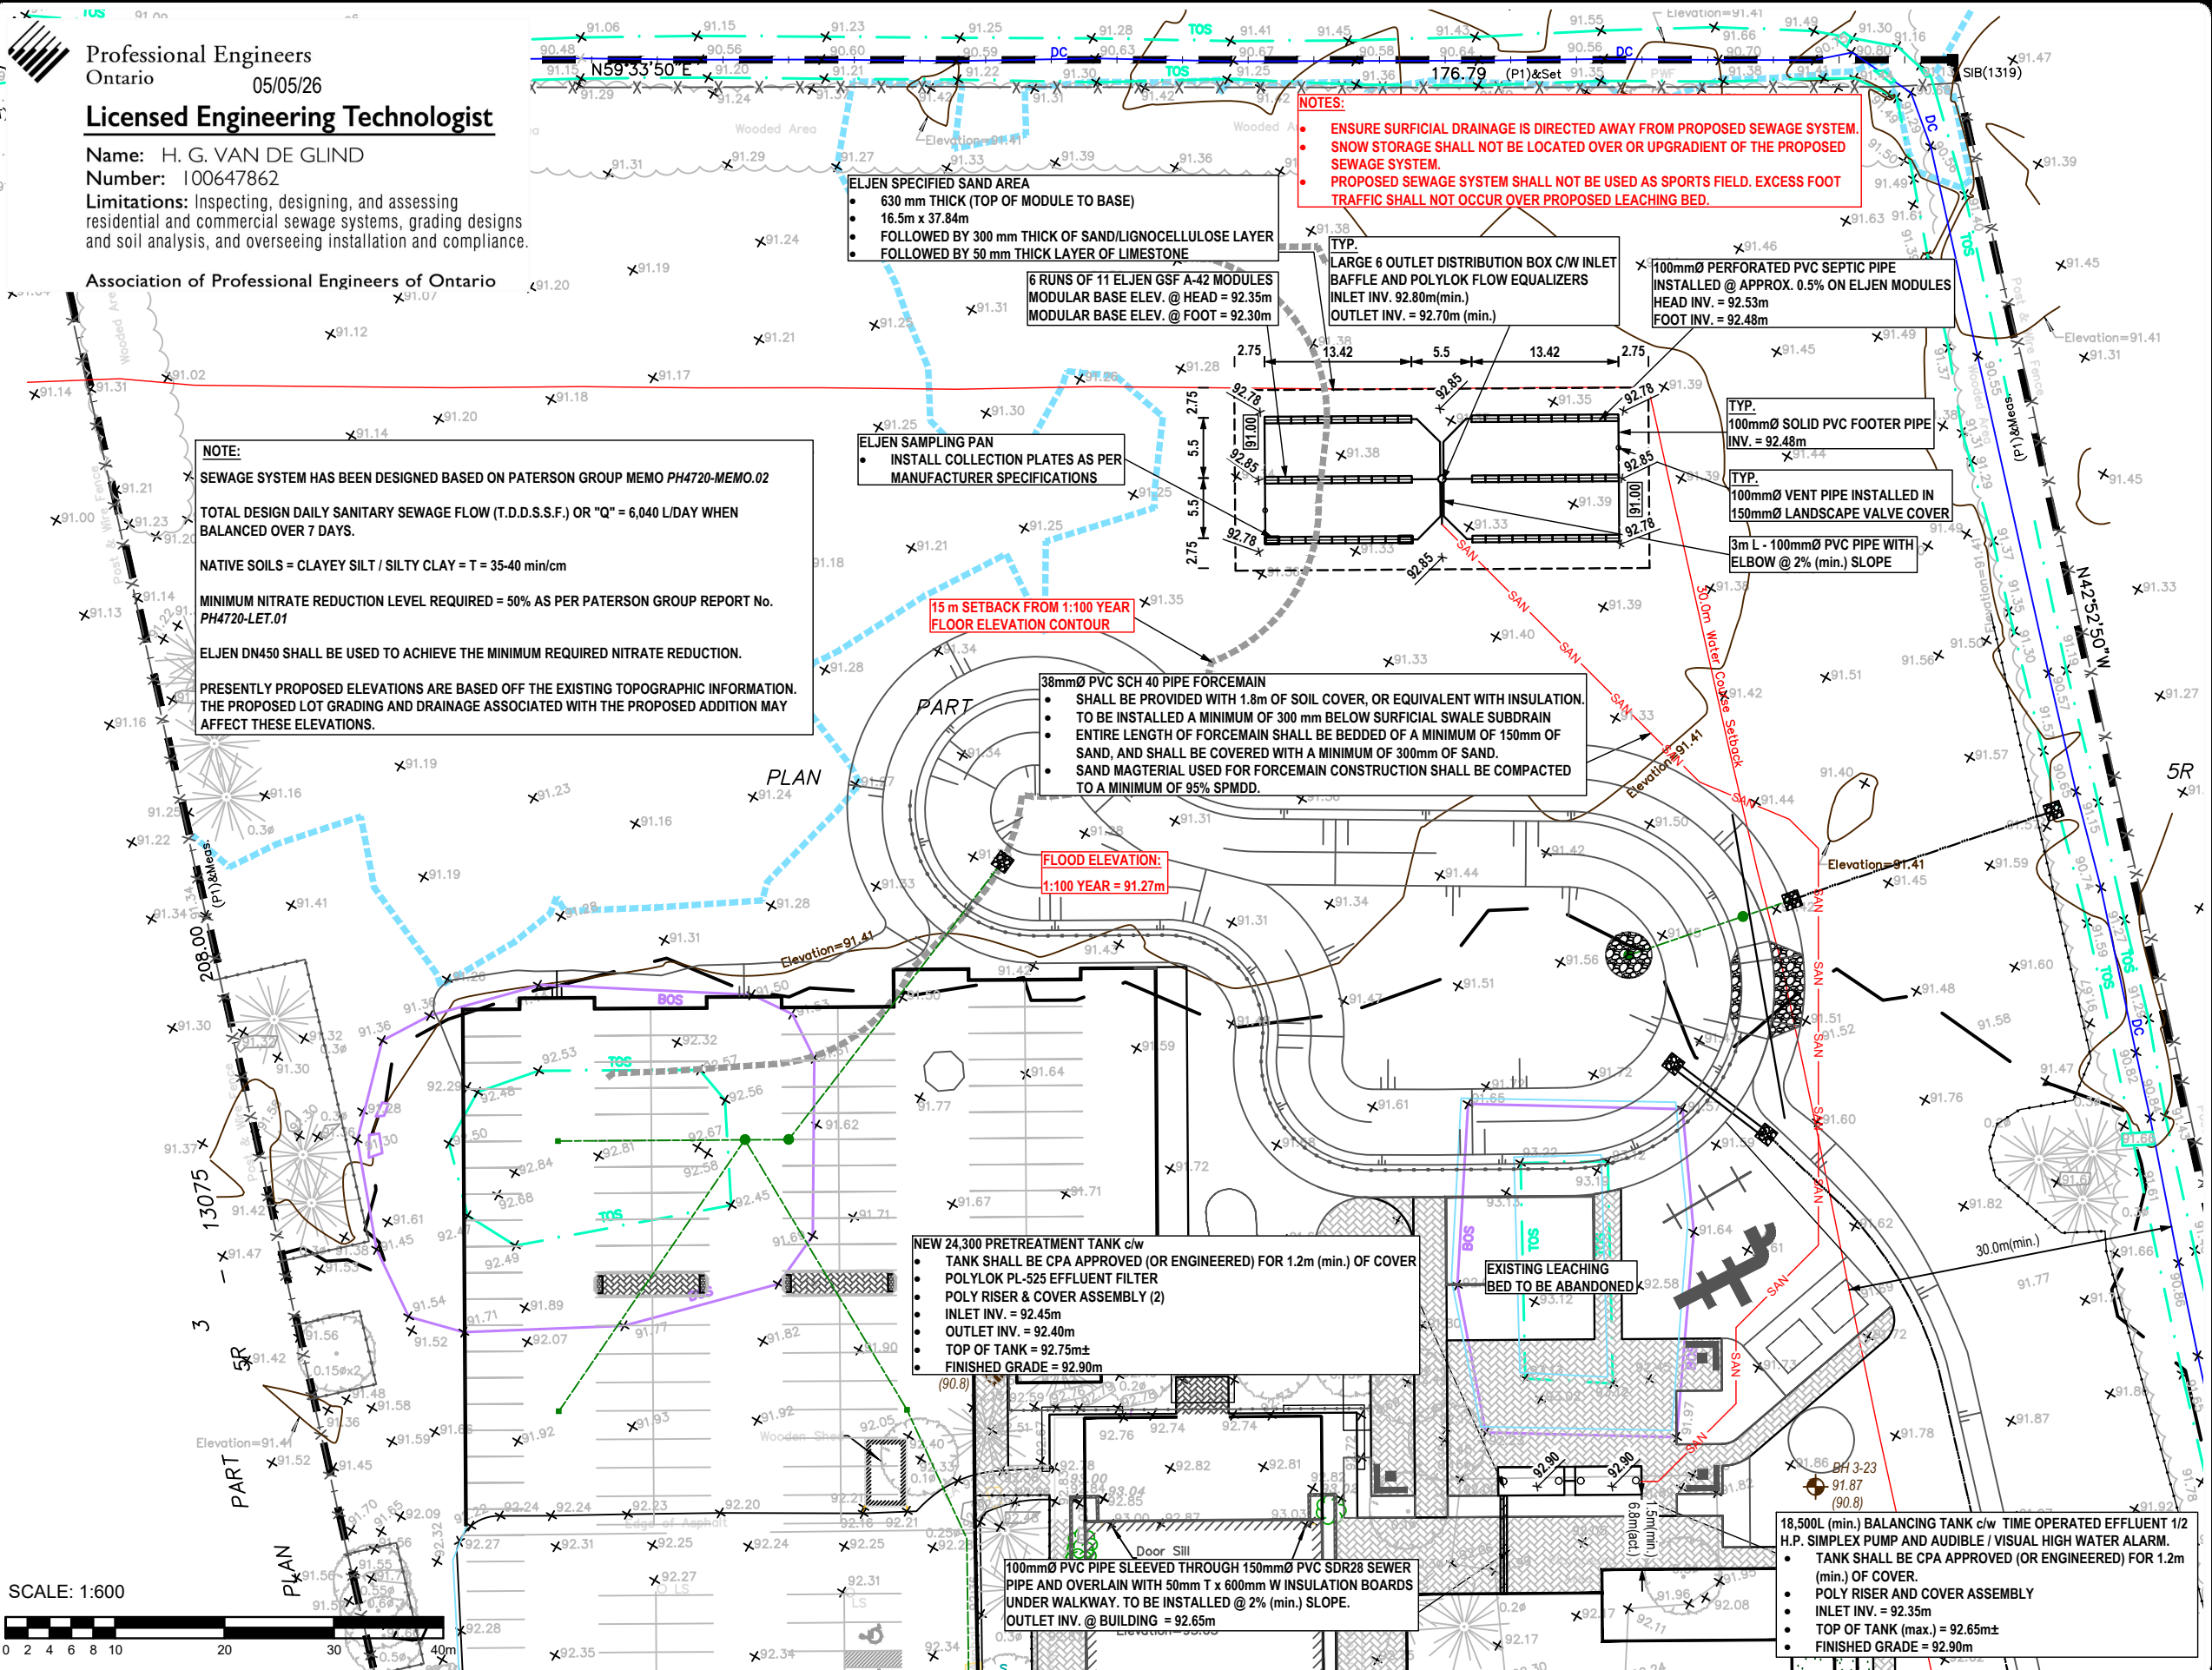

LEGEND:

- Test Hole Location
 - x 100.99 Existing Ground Surface Elev. (m)
 - x 102.30 Proposed Ground Surface Elev. (m)
 - 91.50 Proposed Subgrade Elev. (m)
 - (99.99) Ground Water Elev. (m) - 17/07/23
 - T/C Top of Foundation Wall
 - Existing Structure
 - Proposed Structure
 - Existing Coniferous Tree
 - Existing Deciduous Tree
- All units are in meters unless otherwise specified.

REFERENCE:

Base Plan Information obtained from Proposed Site Plan A1.0, dated August 29, 2024, by Lawrence Architect Inc. and from Site Grading Plan No. SG-1, dated September 2024 by Tatham Engineering

04/05/26	Issued with Revised Site Plan	6
07/01/26	Sewage System Location Revised	5
03/02/25	Issued with PH4720-MEMO.02	4
22/11/24	Proposed Grading Information Added	3
14/11/24	30m Setback Revised to Top of Bank	2
15/10/24	Proposed Grading Information Added	1
13/09/24	Issued for Preliminary Review	0
DD/MM/YY	DESCRIPTION	REV.

Consultant:



Client:

**BRUNSTAD
CHRISTIAN CHURCH**

Project:

**PROPOSED ADDITION TO
EXISTING CHURCH**

**1981 CENTURY ROAD
OTTAWA (CARP), ONTARIO**

Drawing:

**SEWAGE SYSTEM
LAYOUT PLAN**

Scale:

1:600

Drawn by:

HV

Date:

05/2026

Checked by:

MK

Drawing No.:

PH4720-1(rev.6)

p:\autocad drawings\hydrogeology\ph4720-1-brunstad christian church - 1981 century road, ottawa\ph4720-1(rev.6)-client.dwg