


LEGEND:

- H — EXISTING BURIED HYDRO CABLE
- B — EXISTING BURIED BELL
- FOC — EXISTING BURIED FIBRE OPTIC CABLE
- EXISTING GRADE
- PROPOSED GRADE
- PROPOSED CURB
- PROPOSED DEPRESSED CURB
- PROPOSED DEPRESSED CURB AND RAMP
- EXISTING DITCH AND FLOW DIRECTION
- PROPOSED DITCH AND FLOW DIRECTION
- FEE-101.25 PROPOSED BUILDING FINISHED FLOOR ELEVATION
- PROPOSED CURTAIN WALL FOOTING (CURB)
- PROPOSED STORM MANHOLE
- PROPOSED SANITARY MANHOLE
- PROPOSED FIRE HYDRANT
- PROPOSED CATCHBASIN CW TOP OF GRADE ELEVATION
- PROPOSED DITCH INLET CW TOP OF GRADE ELEVATION
- PROPOSED DRAIN TO BE HEEL PROOF. MAXIMUM OPENING TO BE 100mm
- PROPOSED SAMOSE CONNECTION
- PROPOSED WATER METER
- PROPOSED REMOVE WATER METER
- MAJOR STORM ROUTING
- HEAVY DUTY PAVING AREA

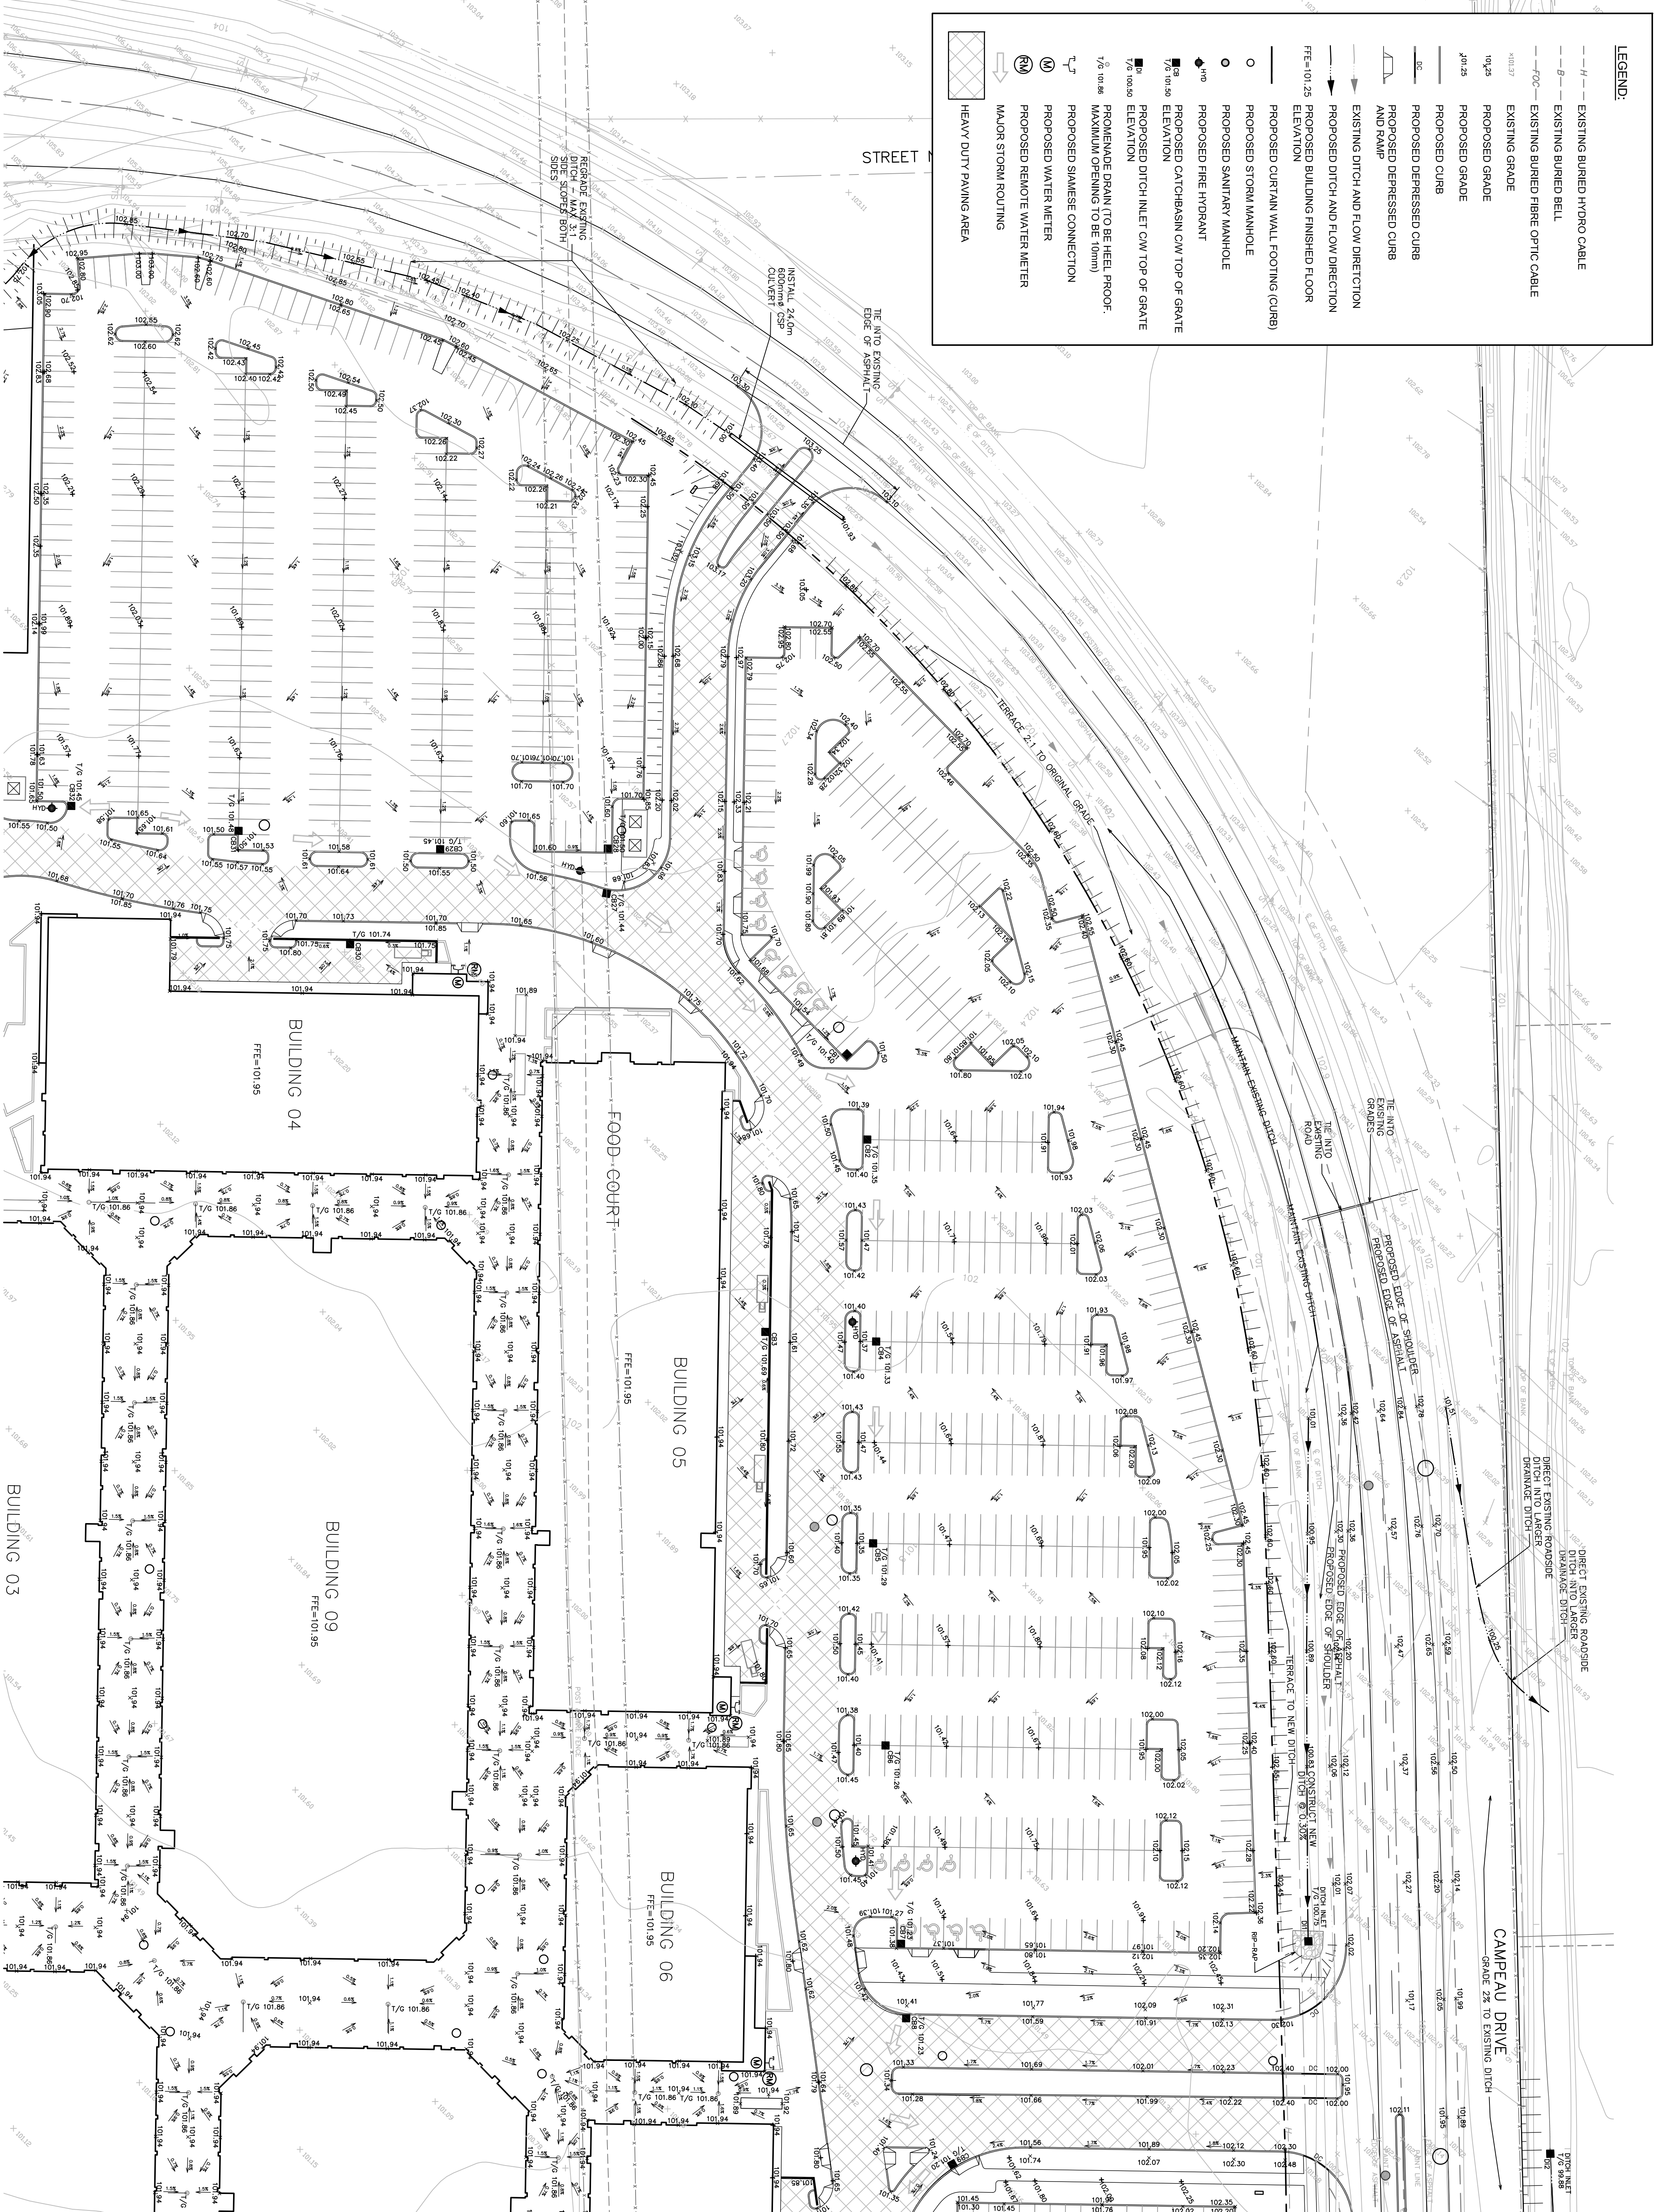

01	ISSUED FOR SITE PLAN APPROVAL	13/01/13
02		
03		
04		
05		
06		

PROJECT ARCHITECT
TURNER FLEISCHER
 TURNER FLEISCHER ARCHITECTS INC.
 57 Laurel Hill Drive, Toronto, Ontario M6G 1R9
 Telephone: (416) 596-1000
 turnerfleischer.com

DESIGN ARCHITECT
CREATE
 The Chrysler Building
 Architectural Planning & Design INC.
 405 Leavelle Street, Suite 70
 Toronto, Ontario M5T 1A7
 Phone: (416) 596-1000
 www.createinc.com

SITE CIVIL
IBI GROUP
 Architects, Engineers, Planners
 5th Floor, 230 Bimrose Street West
 Toronto, Ontario M5T 1A7
 Tel: (416) 596-1000
 Fax: (416) 596-0644

PLANNER
FOTENN URBAN DESIGN
 223 Market Street | Toronto, ON M5G 0Z8
 T: (416) 444-5253
 F: (416) 444-1463
 E: info@fotenn.com

DEVELOPER
RIOCAN
 RioCan Real Estate Investment Trust
 230 King Street West
 Toronto, Ontario M5G 1E4
 (416) 646 8330

DEVELOPER
TangerOutlets
 Tanger Outlets Centre
 3200 Northpark Drive, Suite 360
 Greenfield, North Carolina 27408

PROJECT
TANGER OUTLET CENTRES
 ONTARIO

GRADING PLAN
J. I. MORTATI
 LICENSED PROFESSIONAL ENGINEER
 PROVINCE OF ONTARIO

PROJECT NO. 32862
DATE JANUARY 2013
DRAWN BY M.M.
SCALE 1:500
CHECKED BY J.M.
FILE NAME —
DRAWING NUMBER C-200