




| LIGHTING SCHEDULE |  |                                   |
|-------------------|--|-----------------------------------|
| SYMBOL            | DESCRIPTION  | MODEL                             |
|                   | D-SERIES LED WALL LUMINAIRE WITH 1 LIGHT ENGINE, 10 LED'S, 1000mA DRIVER, 4000K COLOUR TEMPERATURE, TYPE 4 MEDIUM DISTRIBUTION, 3043 LUMENS, 120V, 0.37A, 40W, PHOTOELECTRIC CELL INSTALLED, FINISH TO BE CONFIRMED BY OWNER. TO BE MOUNTED @ 14' AGL. | DSXW1 LED 10C 1000 40K T4M 120 PE |

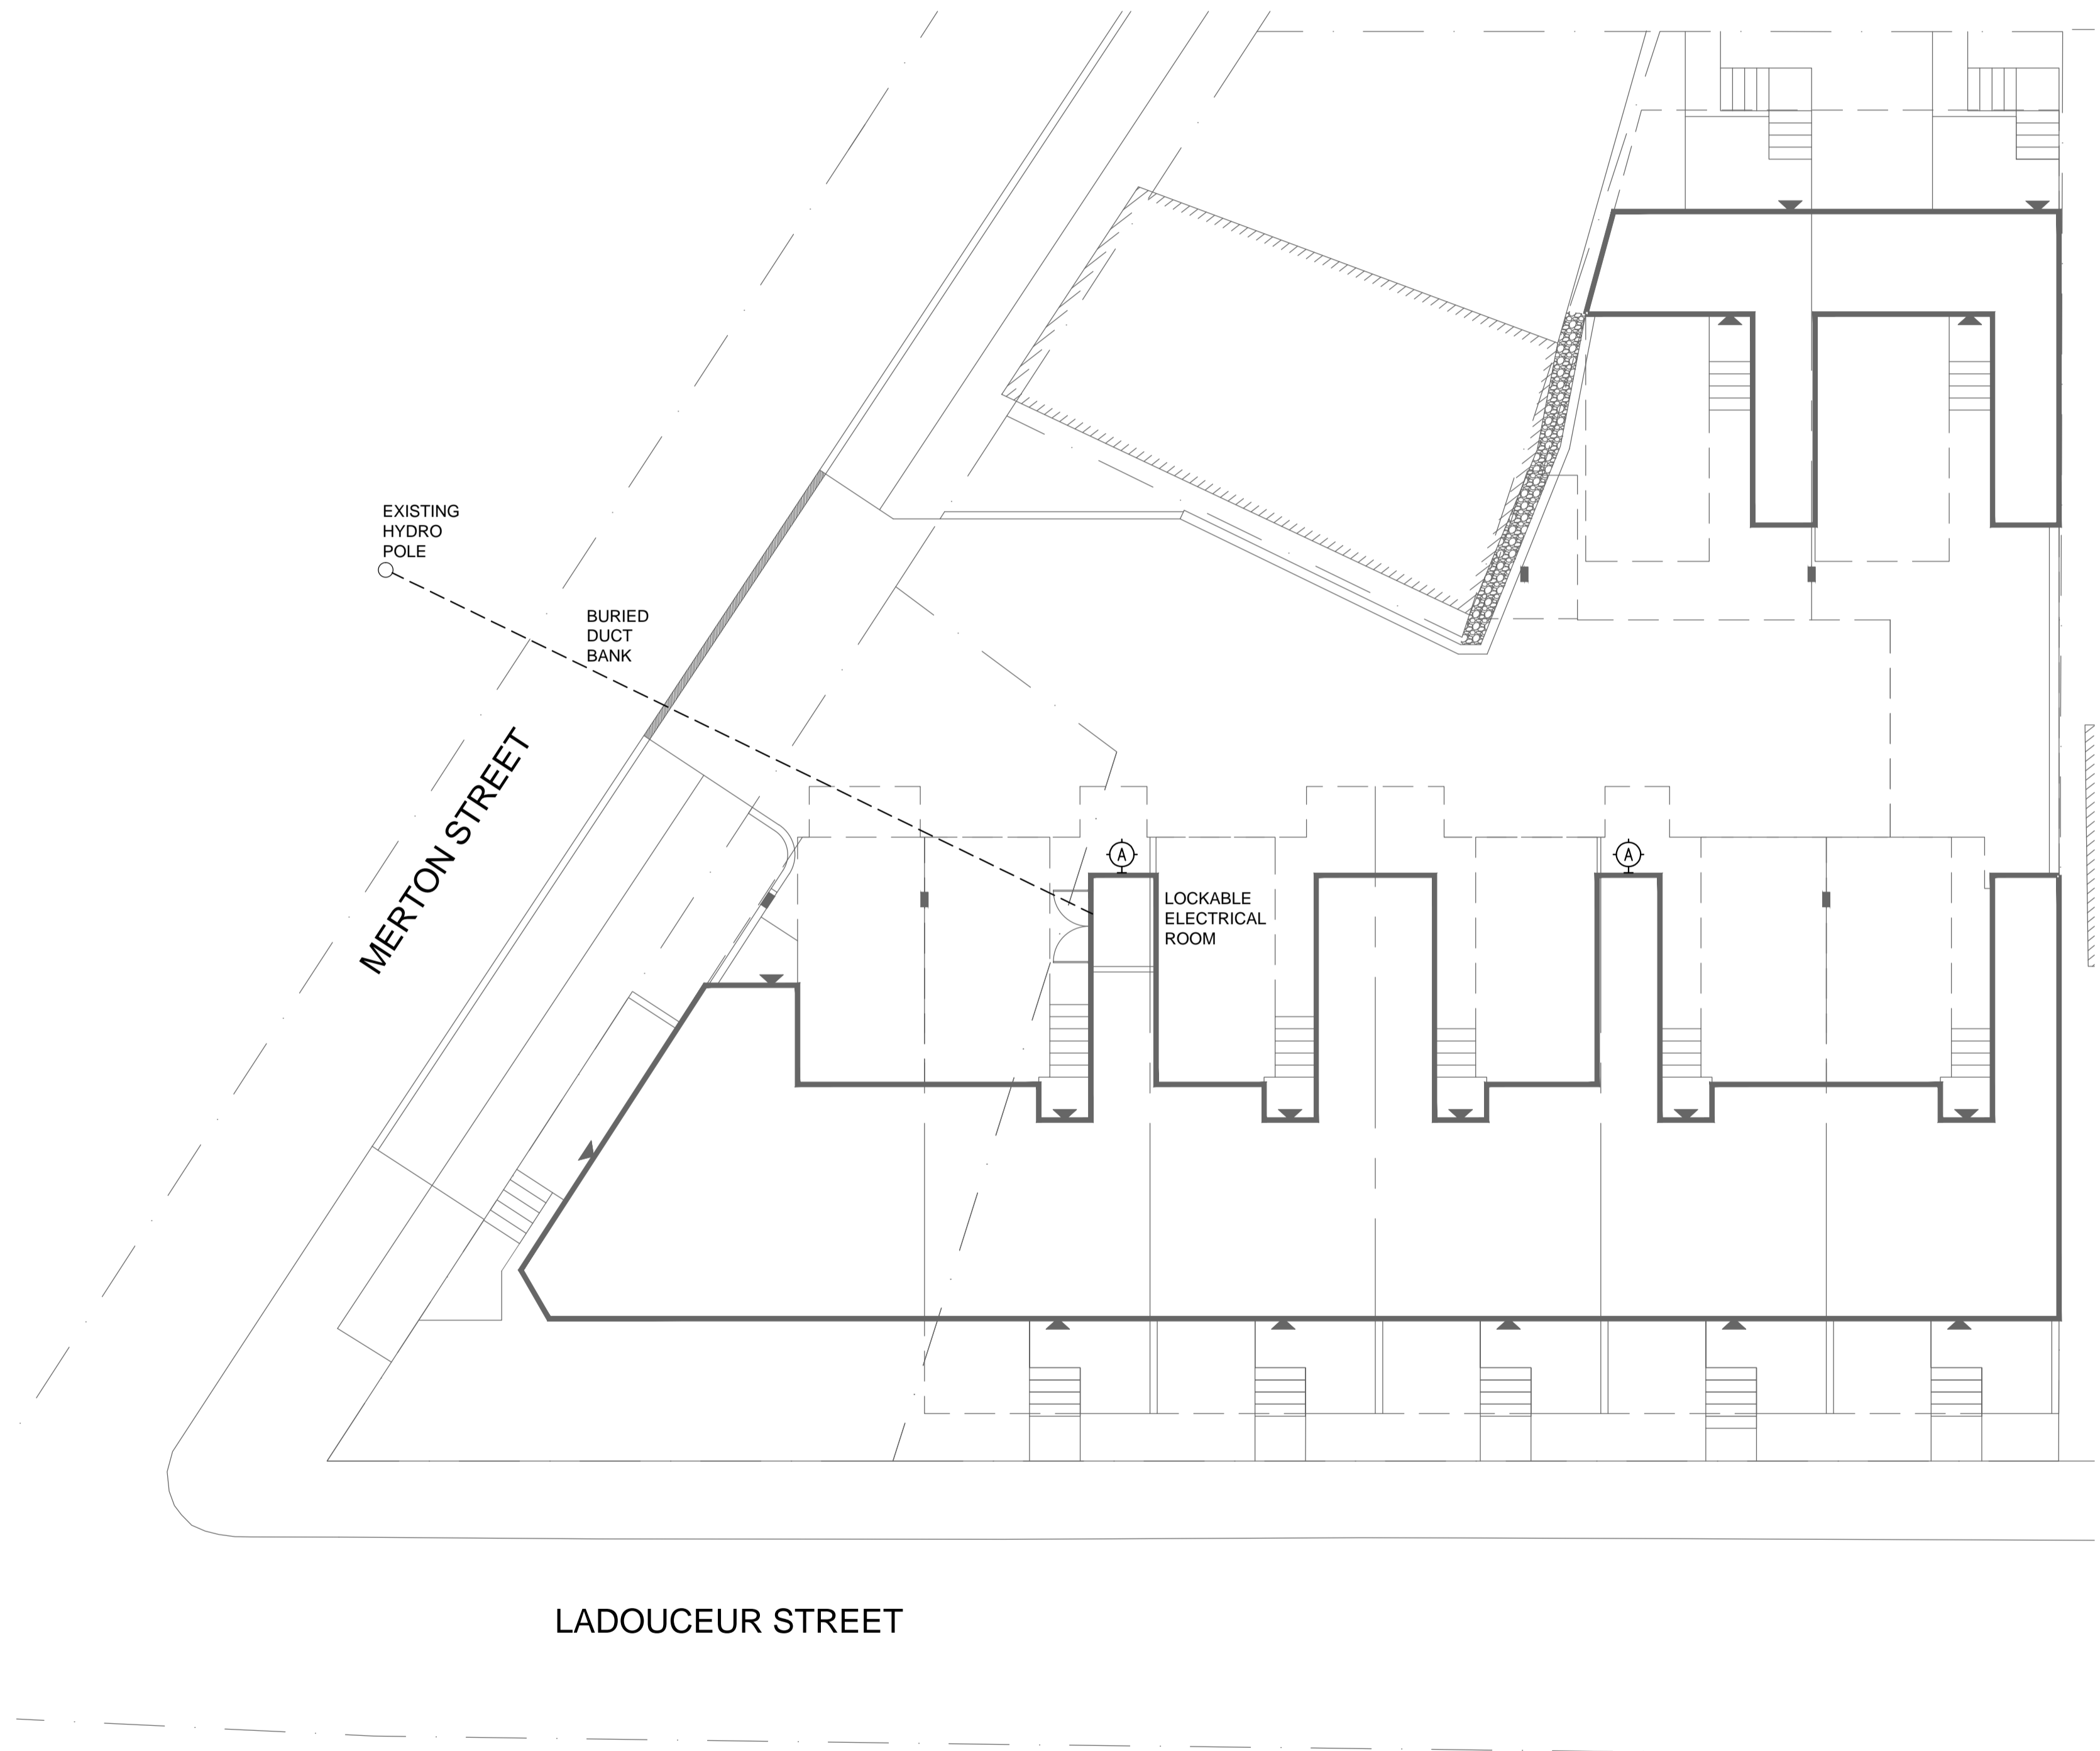

**1** SITE PLAN - UNDERGROUND LOW VOLTAGE DISTRIBUTION AND EXTERIOR SITE LIGHTING  
SPE1 1:100

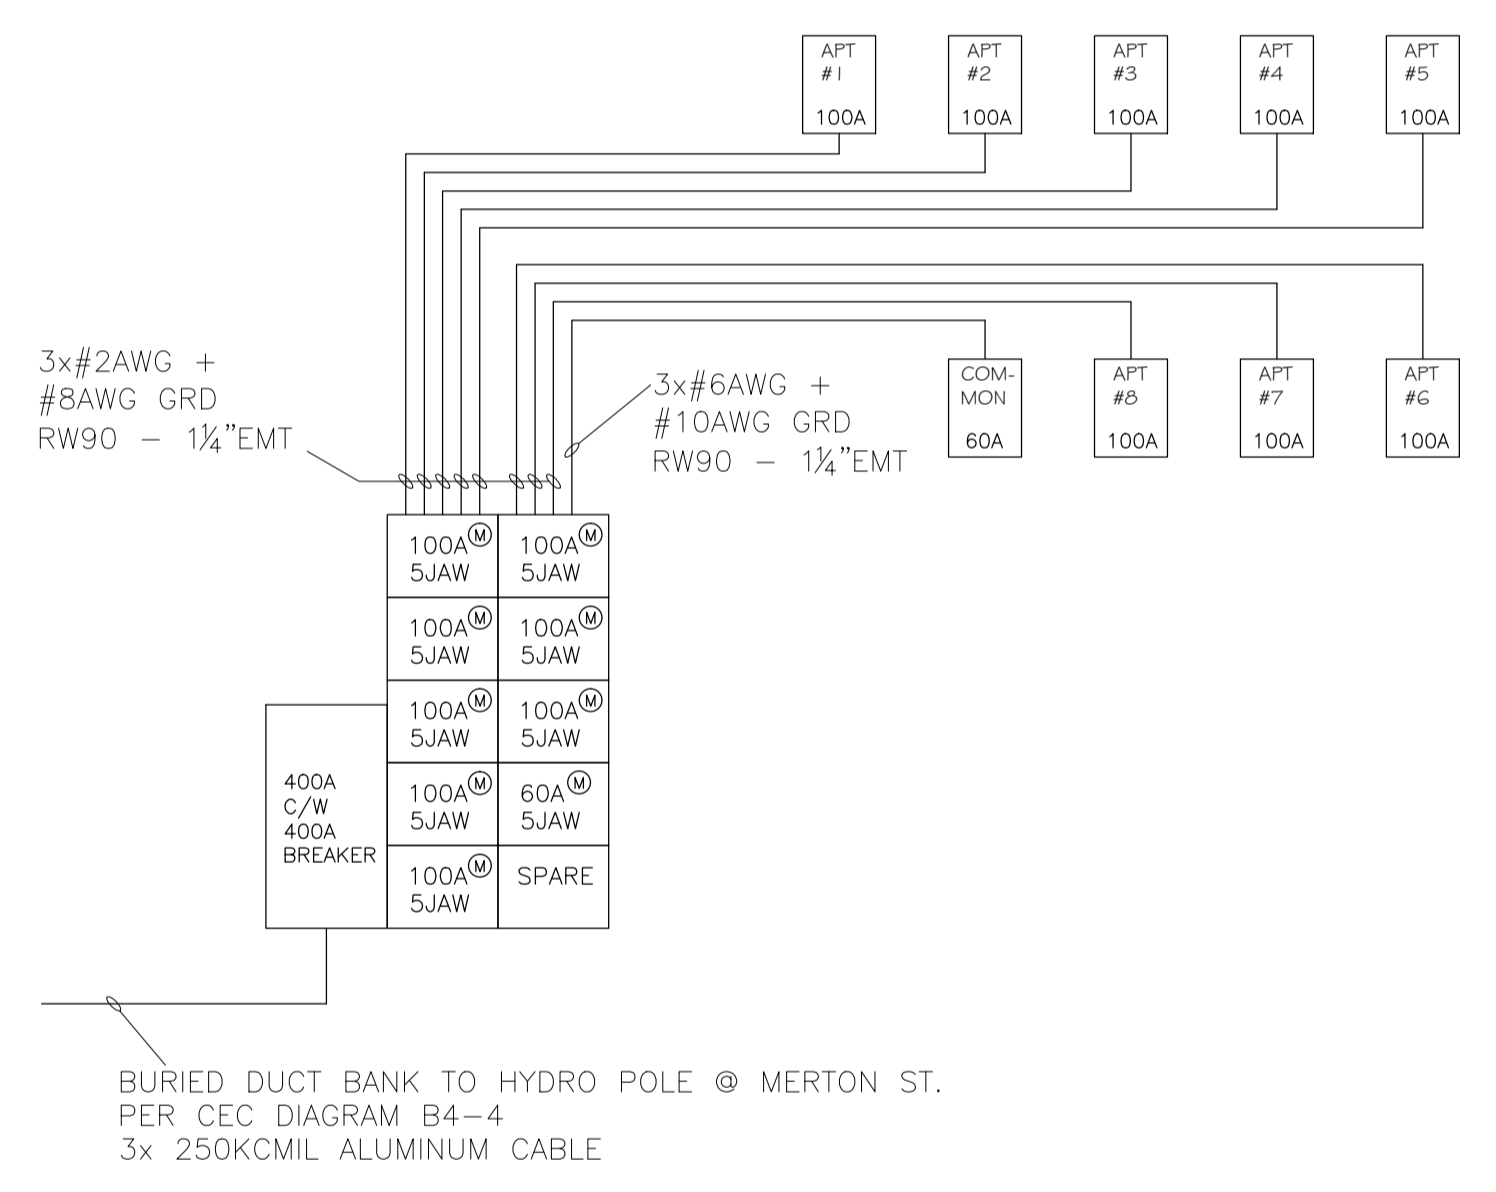

**1** SITE FEED SINGLE LINE DIAGRAM  
SPE1 N.T.S.

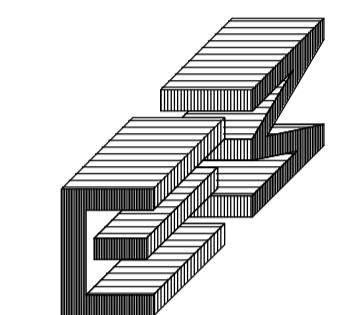

CHIARELLI ENGINEERING  
MANAGEMENT LTD.  
203-100 CRAIG HENRY DR.  
NEPEAN, ONTARIO K2G 5W3  
TEL. (613)225-1123  
FAX. (613)225-7298  
E-MAIL: info@cemlottawa.com

CONSULTANT NAME AND ADDRESS:

|    |  |  |  |
|----|--|--|--|
| 10 |  |  |  |
| 9  |  |  |  |
| 8  |  |  |  |
| 7  |  |  |  |
| 6  |  |  |  |
| 5  |  |  |  |
| 4  |  |  |  |
| 3  |  |  |  |
| 2  |  |  |  |

|   |            |      |                   |
|---|------------|------|-------------------|
| 1 | 2013-09-17 | N.K. | ISSUED FOR REVIEW |
|---|------------|------|-------------------|

| NO. | DATE | BY | DESCRIPTION |
|-----|------|----|-------------|
| 1   |      |    |             |

CONTRACTOR SHALL CHECK AND VERIFY ALL DIMENSIONS AND REPORT ANY OMISSIONS OR DISCREPANCIES TO THE ARCHITECT BEFORE PROCEEDING WITH THE WORK.  
DO NOT SCALE THE DRAWINGS

**TOWNHOUSES**

LOCATION CODE: ADDRESS:  
**54 Ladouceur St.**  
Ottawa, ON K0G 1J0  
PROJECT:  
**TOWNHOUSES @ 54 LADOUCEUR**

PROJECT NO: DRAWING TITLE:  
13-060 **ELECTRICAL SITE PLAN AND SINGLE LINE DIAGRAM**  
CAD FILE NAME: DWG NO: OF: SCALE:  
13-060\_E SPE1 1 AS NOTED