

COPE DRIVE EXTENSION

SIGNALIZED INTERSECTION

UNDEVELOPED AREA: 0.48 ACRE

PHASE 2
0.74 ACRES

19 CARS

BLDG Z
2,398-SF

2.00m CONCRETE SIDEWALK

FUTURE 2.00m CONCRETE SIDEWALK

FUTURE 2.00m CONCRETE SIDEWALK

2.00m ASPHALT PATHWAY


EXTENT OF WORK

GATEWAY FEATURE

EXTENT OF WORK


Contractor must check and verify all dimensions on the job and report any discrepancies to the Architect before proceeding with the work.
Do not scale the drawing.
This drawing was developed for a specific purpose; use for any other purpose is not permitted.
This drawing must be read in the context of all the other drawings which constitute the document.

SD-207

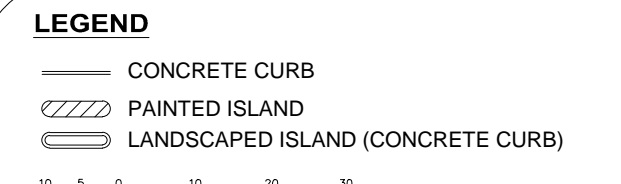

LIGHTING FIXTURE SCHEDULE

FIXTURE TYPE	QUANTITY	ARRANGEMENT	DESCRIPTION	ARR. LUM. LUMENS	BUG RATING	ARR. WATTS
D1W12-23	1	BACK-BACK	2-EAMMD3F40A1BLCK 20 FT POLE ON 3 FT BASE	16200	B2-U0-G2	266
SW12-23	3	SINGLE	1-EAMMD3F40A1BLCK 20 FT POLE ON 3 FT BASE	8100	B2-U0-G2	133

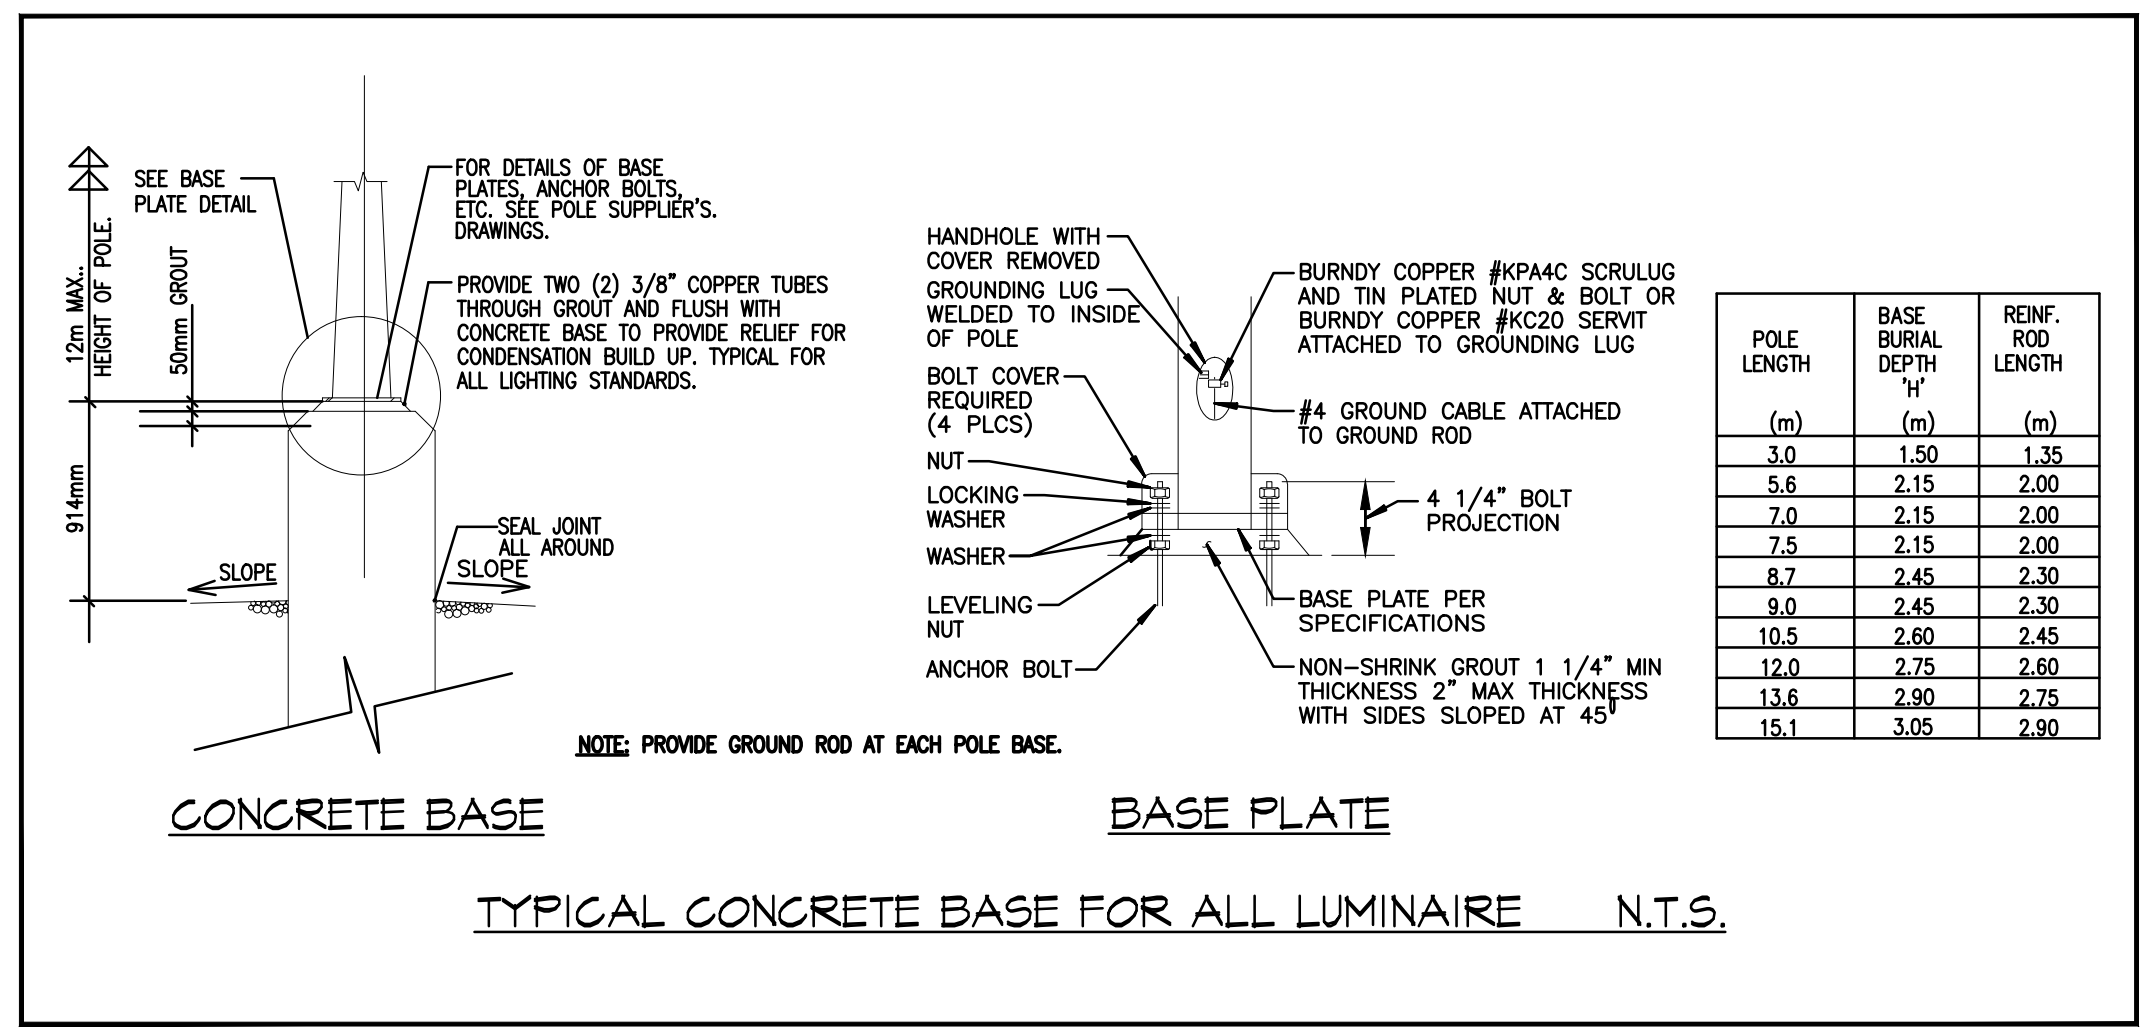

REVISIONS

No.	ISSUED FOR REVIEW	JAN/15/14	B.K.
	DESCRIPTION	DATE	BY
1.	ISSUED FOR REVIEW	JAN/15/14	B.K.

COMMERCIAL DEVELOPMENT
FERNBANK ROAD & TERRY FOX DRIVE
KANATA SOUTH, ONTARIO
SMART CENTRES
700 APPLEWOOD CRESENT, VAUGHAN, ON, L4K 5X3
TEL: 905-760-6200 FAX: 905-760-6202

PHOTOMETRIC SITE PLAN & DETAILS

h HAMMERSCHLAG + JOFFE INC.
89 Leavelle Road Toronto, Ontario Canada M5B 2T8
T: (416) 444-9283
F: (416) 444-1463
E: dwg@hampj.com

DESIGN BY: B.K.	CHECKED BY: M.H.	PROJECT No.
DRAWN BY: B.K.	CHECKED BY: M.H.	07040
SCALE: 1:1250	DATE: JANUARY 2014	DRAWING No.
CONSULTANTS NO.		ESP

H&J # 14-024