

B
RETAIL
 14,980 SM
 GFA (161,254 SF)

KEY PLAN N.T.S.



No.	REVISIONS	MARK	VOI	ALL	COPIES	PREPARED	DATE	BY
3	RE-ISSUED FOR SPA						MAY 17/2016	J.T.
2	ISSUED FOR SPA						MAR 09/2016	J.T.
1	ISSUED FOR COORDINATION						OCT 27/2015	J.T.

Contractor must check and verify all dimensions on the job and report any discrepancies to the Architect before proceeding with the work.								
Do not scale the drawing.								
This drawing contains copyright material belonging to the Architect.								
This drawing was developed for a specific purpose; use for any other purpose is not permitted.								
This drawing shall not be reproduced in whole or in part without the written approval of the Architect.								
This drawing must be read in the context of all the other drawings which constitute the document.								

BLOCK B - PHOTOMETRIC SITE PLAN AND DETAILS

SCALE: 1 : 500



COMMERCIAL DEVELOPMENT
CITY CENTRE EAST
 2012 OGLIVIE ROAD – GLOUCESTER
 OTTAWA, ON

h HAMBERSCHLAG + JOFFE INC.

© Licensed Prof. Firm
 Ontario, Canada REG-278
 T: (416) 464-9203
 F: (416) 464-1903
 E: dhj@trinityof.com

PROFESSIONAL ENGINEER
 REG. NO. 13-504C
 MAY 17/16
 TRINITY OF ONTARIO

DRAWN BY	J.T.	PROJECT No.	13-487
CHECKED BY	MH	DATE	MAY 17, 2016
ISSUED	MAY 17, 2016	ENC. No.	500P

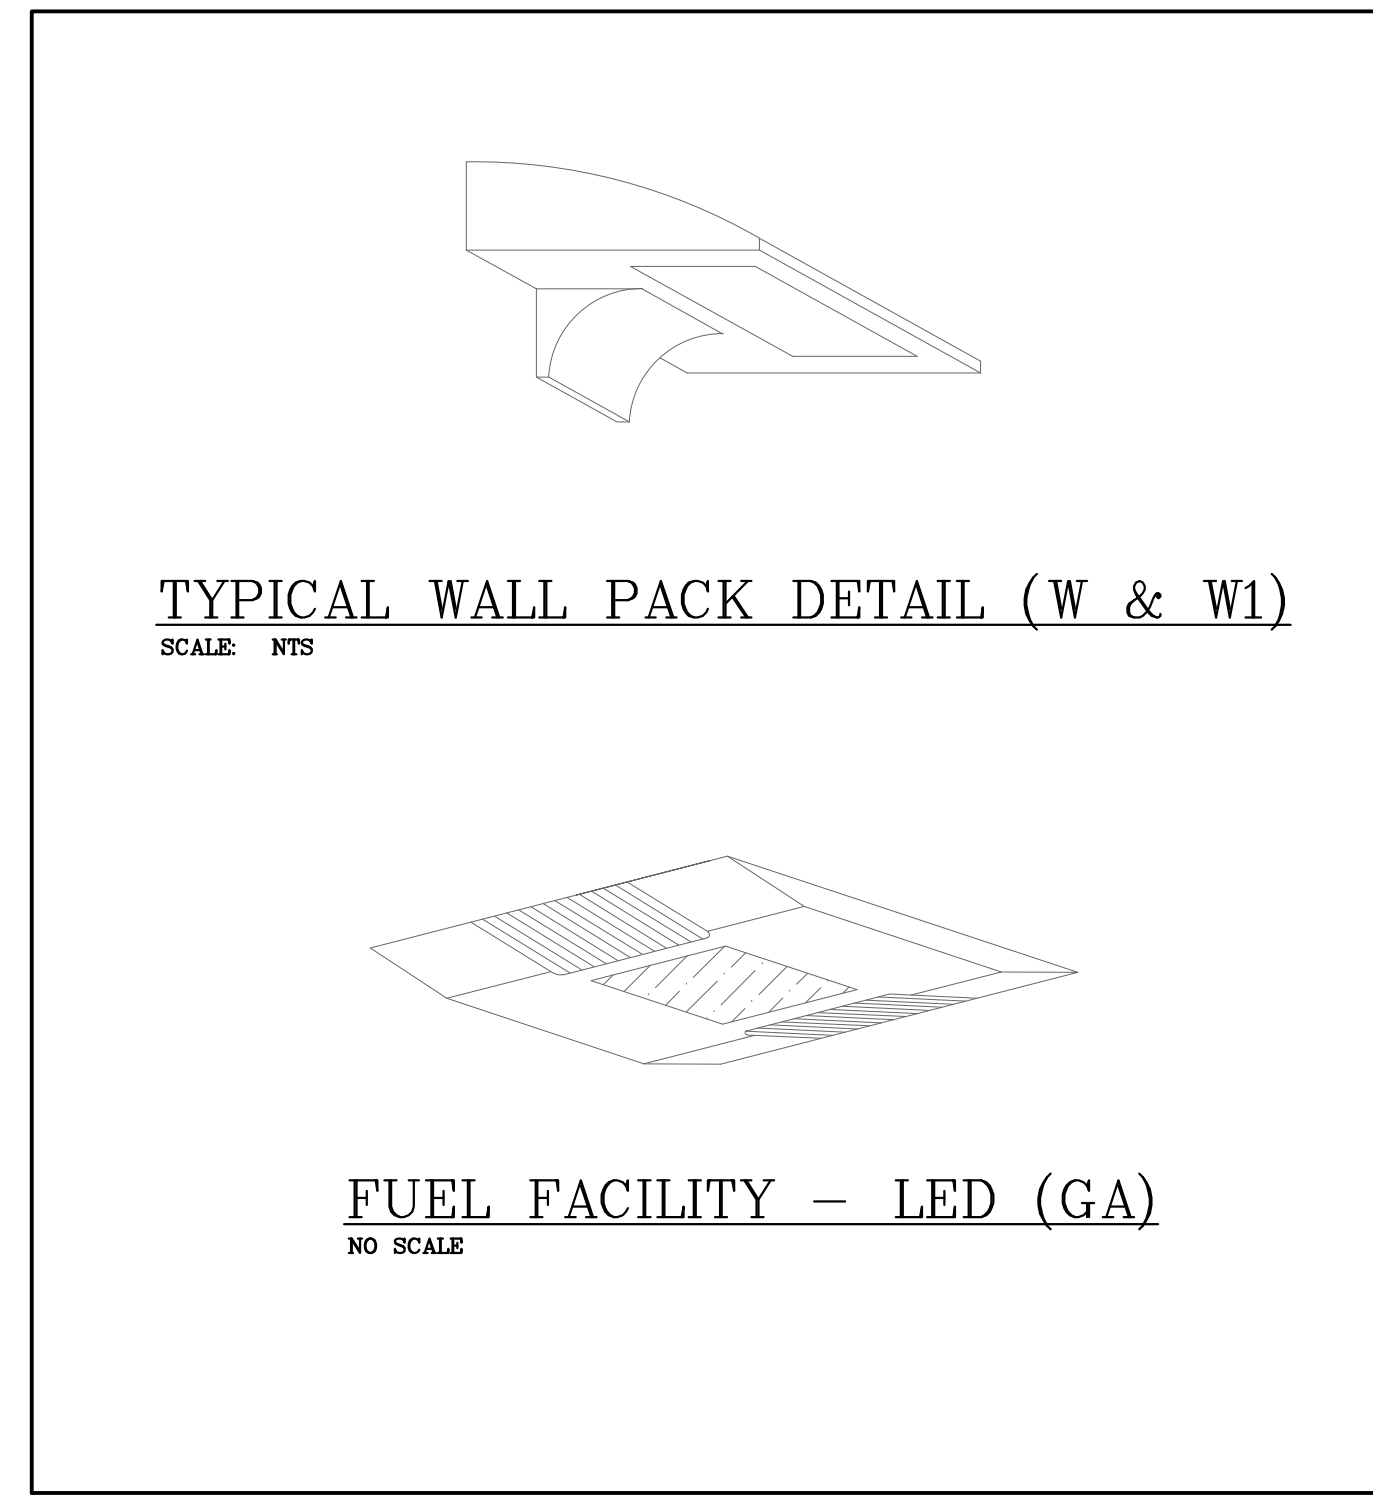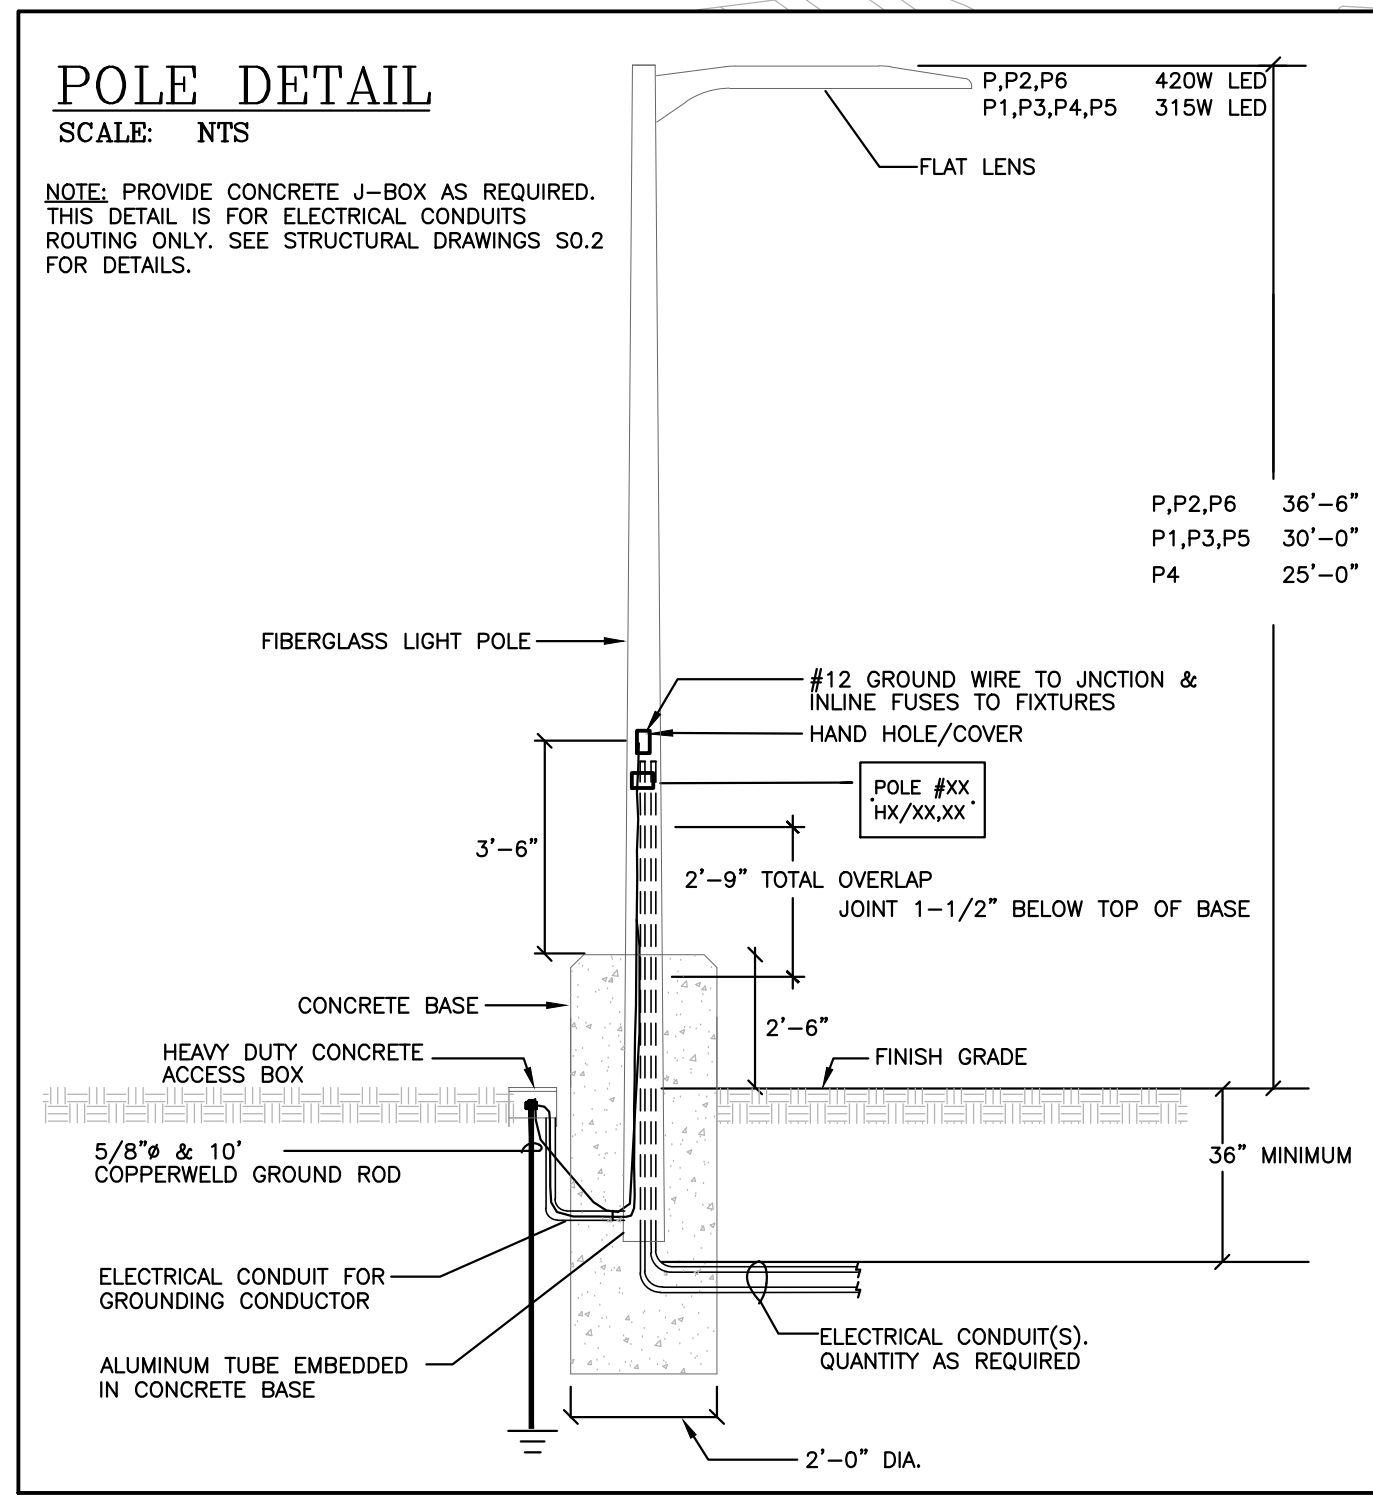

FIXTURE DESCRIPTION

(P)	COOPER GALLEON GLEON-AE-8-LED-E1-SM0-BZ, 420W TYPE 5 DISTRIBUTION, FIBERGLASS POLE 36'-6" ABOVE GRADE, WITH 2'-6" BASE.
(P1)	COOPER GALLEON GLEON-AE-6-LED-E1-SL3-HSS-BZ, 315W TYPE 3 DISTRIBUTION, FIBERGLASS POLE 30'-0" ABOVE GRADE, WITH 2'-6" BASE.
(P2)	COOPER GALLEON GLEON-AE-8-LED-E1-SM0-BZ, 420W TYPE 5 DISTRIBUTION, FIBERGLASS POLE 36'-6" ABOVE GRADE, WITH 2'-6" BASE.
(P3)	COOPER GALLEON GLEON-AE-6-LED-E1-SL4-HSS-BZ, 315W TYPE 3 DISTRIBUTION, FIBERGLASS POLE 30'-0" ABOVE GRADE, WITH 2'-6" BASE.
(P4)	COOPER GALLEON GLEON-AE-8-LED-E1-SM0-BZ, 420W TYPE 5 DISTRIBUTION, FIBERGLASS POLE 36'-6" ABOVE GRADE, WITH 2'-6" BASE.
(P5)	COOPER GALLEON GLEON-AE-6-LED-E1-SL3-BZ, 315W TYPE 3 DISTRIBUTION, FIBERGLASS POLE 30'-0" ABOVE GRADE, WITH 2'-6" BASE.
(P6)	COOPER GALLEON GLEON-AE-8-LED-E1-T3-BZ, 420W TYPE 3 DISTRIBUTION, FIBERGLASS POLE 36'-6" ABOVE GRADE, WITH 2'-6" BASE.
(W)	LITHONIA DSKW2 LED 40K 30C 700 T2M, 71W LED, 20" MOUNTING HEIGHT
(W1)	LITHONIA DSKW2 LED 40K 30C 700 T4FT, 71W LED, 20" MOUNTING HEIGHT
(W2)	LITHONIA DSKW1 LED 40K 10C 350 T2M, 13W LED, 20" MOUNTING HEIGHT
(GA)	120W LED, SURFACE SYMMETRIC DOWN LIGHT, FLAT LENS, 18" MOUNTING HEIGHT