

DATE:	MARCH 2016
REV.	
DATE:	
DWG. No.:	W51

SILICONE APPLIED BETWEEN CONCRETE AND WATER CHUTE

WATER CHUTE

CONCRETE TANK

No.	DATE	BY	REVISIONS



Jp2g Consultants Inc.
ENGINEERS • PLANNERS • PROJECT MANAGERS
RESEARCHERS • DESIGNERS




DESIGNED	-
DRAWN	JMS
CHECKED	NC
APPROVED	NC
SCALE:	NTS

**CITY OF OTTAWA
WATER FILL STATIONS**

**TYPICAL INSTALLATION OF
WATER CHUTE ON A CONCRETE
TANK**

DATE	OCT. 2004
PROJECT	2041145A
PLOTTED	OCT. 2004

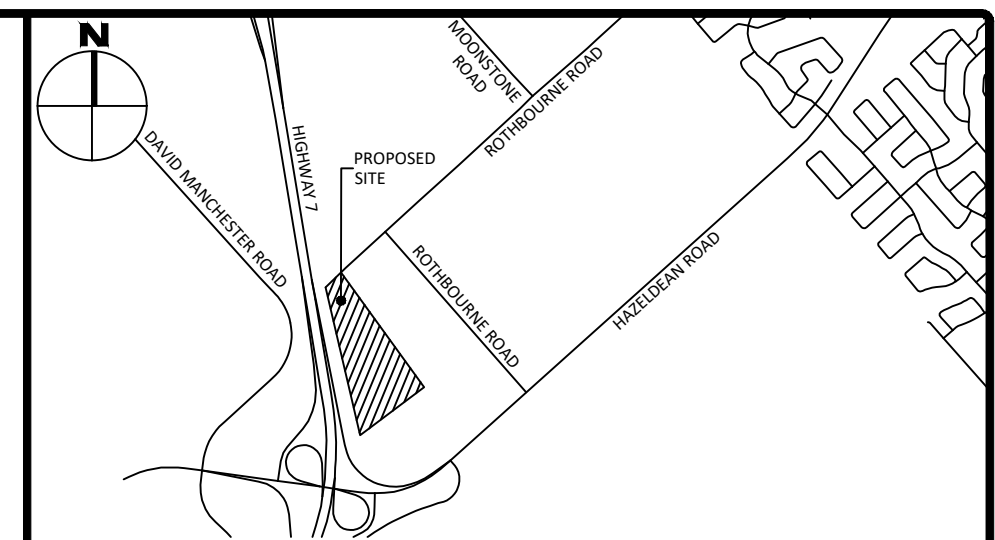FIGURE 10

LOCATION PLAN

FOR REVIEW ONLY
NOT FOR CONSTRUCTION

1	ISSUED FOR SITE PLAN CONTROL	JULY 17, 2019
No.	Revisions	Date

Check and verify all dimensions before proceeding with the work	Do not scale drawings
---	-----------------------


SCALE 1 : 1000



McINTOSH PERRY

115 Walgreen Road, RR3, Carp, ON K0A 1L0
Tel: 613-836-2184 Fax: 613-836-3742
www.mcintoshperry.com

Stamp:

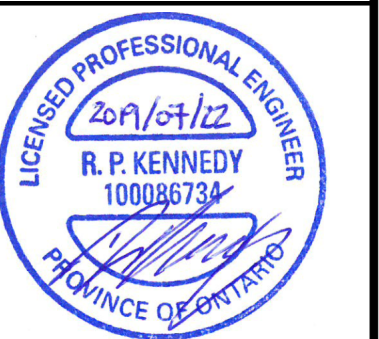

Client:

METRO TOWING
2759 LANCASTER ROAD
OTTAWA, ON K1B 4V8

Project:

**METRO TOW TRUCK
WAREHOUSE BUILDING**
6776 ROTHBOURNE RD.
OTTAWA, ON

Drawing Title:

DETAILS

Scale:	Project Number: CP-17-0381
Drawn By: C.D.H.	
Checked By: R.P.K.	Drawing Number: DETAILS
Designed By: C.D.H.	

DETAILS

XXXXXX