


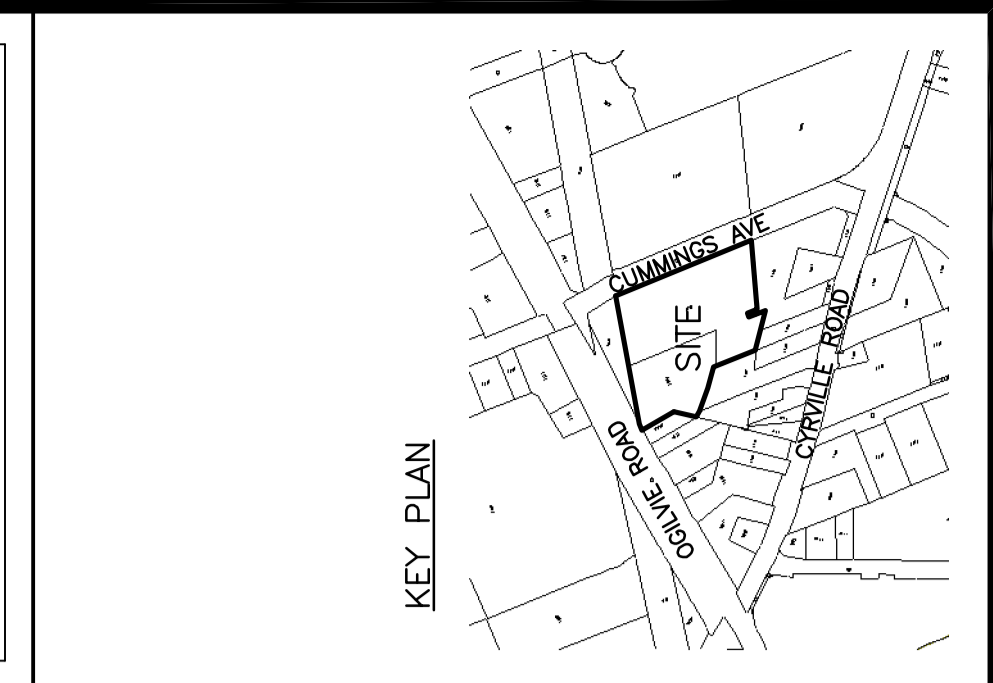

DRAWING LEGEND

- CB CATCH BASIN
- MH MANHOLE
- CB/MH CATCH BASIN/MANHOLE
- WM WATER SERVICE / WATERMAIN
- SS SANITARY SEWER
- ST STORM SEWER
- CS CURB STOP
- VV VALVE & VALVE BOX
- FH FIRE HYDRANT
- WM WATER METER
- RM REMOTE WATER METER READOUT
- UPO UTILITY POLE
- ± 93.79 PROPOSED GRADE ELEVATION
- 0.5% SLOPE OF GRADE
- SILT FENCE BARRIER
- PROPERTY LINE
- FFL=90.15 FIRST FLOOR ELEVATION
- USF=88.50 UNDERSIDE OF FOOTING ELEVATION



No.	Date	Revision
1	APR 12-12	ISSUED FOR APPROVAL

D. B. GRAY ENGINEERING INC.
 Structural Management, Consulting & Design, Storm & Sanitary Sewers, Watermain
 1052 Karsh Drive
 Ottawa, Ontario, K1G 4N1
 Tel: (613) 249-9044
 Fax: (613) 249-9815
 email: dgray@dbgrayeng.com

CUMMINGS AVE. & OGILVIE RD.
 TOWNHOUSES
 OTTAWA, ONTARIO.

GRADING PLAN

Engineer's Seal

 Drawn: D.B.G.
 Plot. Scale: 1:300
 Vert. Scale: 1:10
 Date: SEP 12 -11
 Job: 11041
 Drawing No.: SG-2 of 3
 NOT VALID UNLESS SIGNED & DATED

