
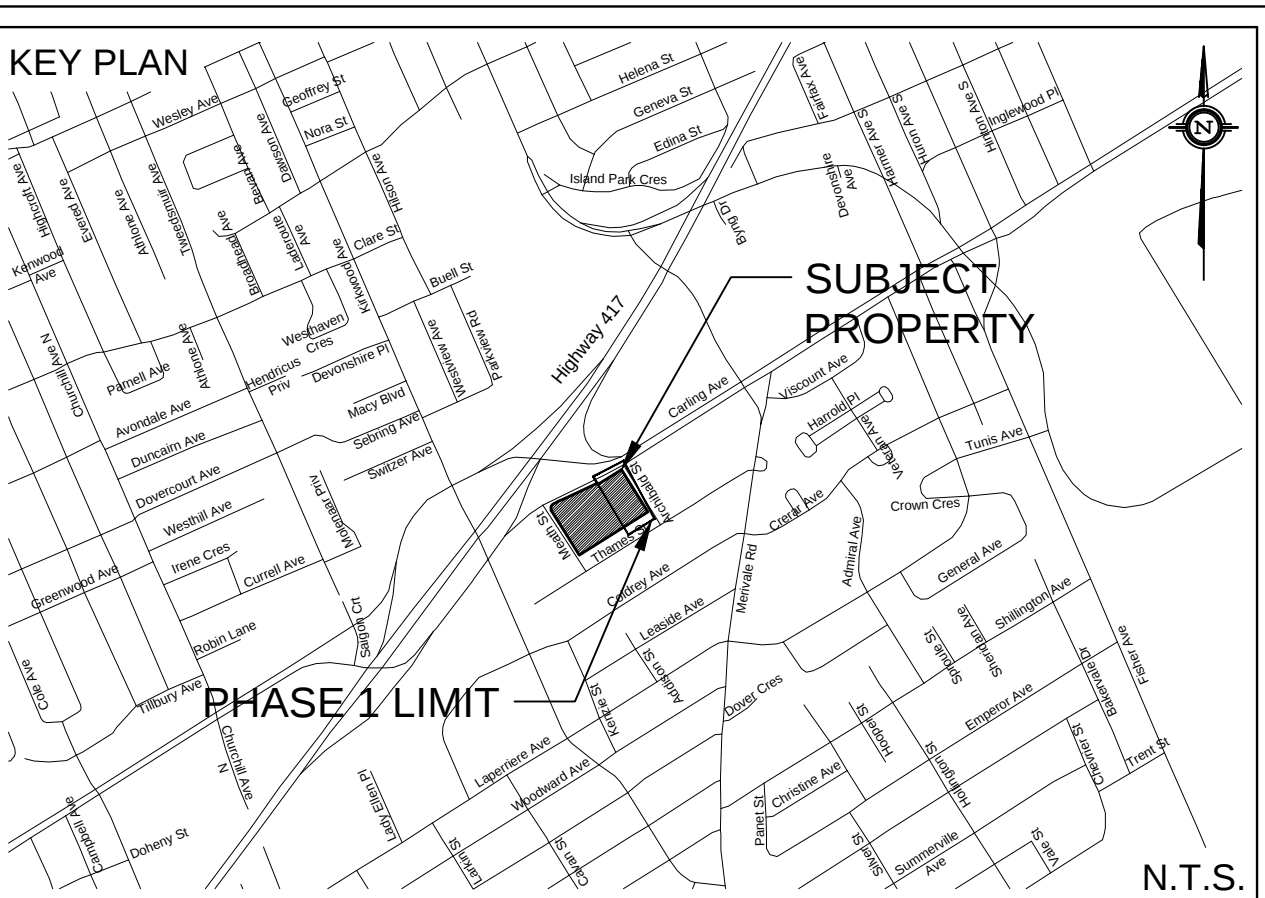


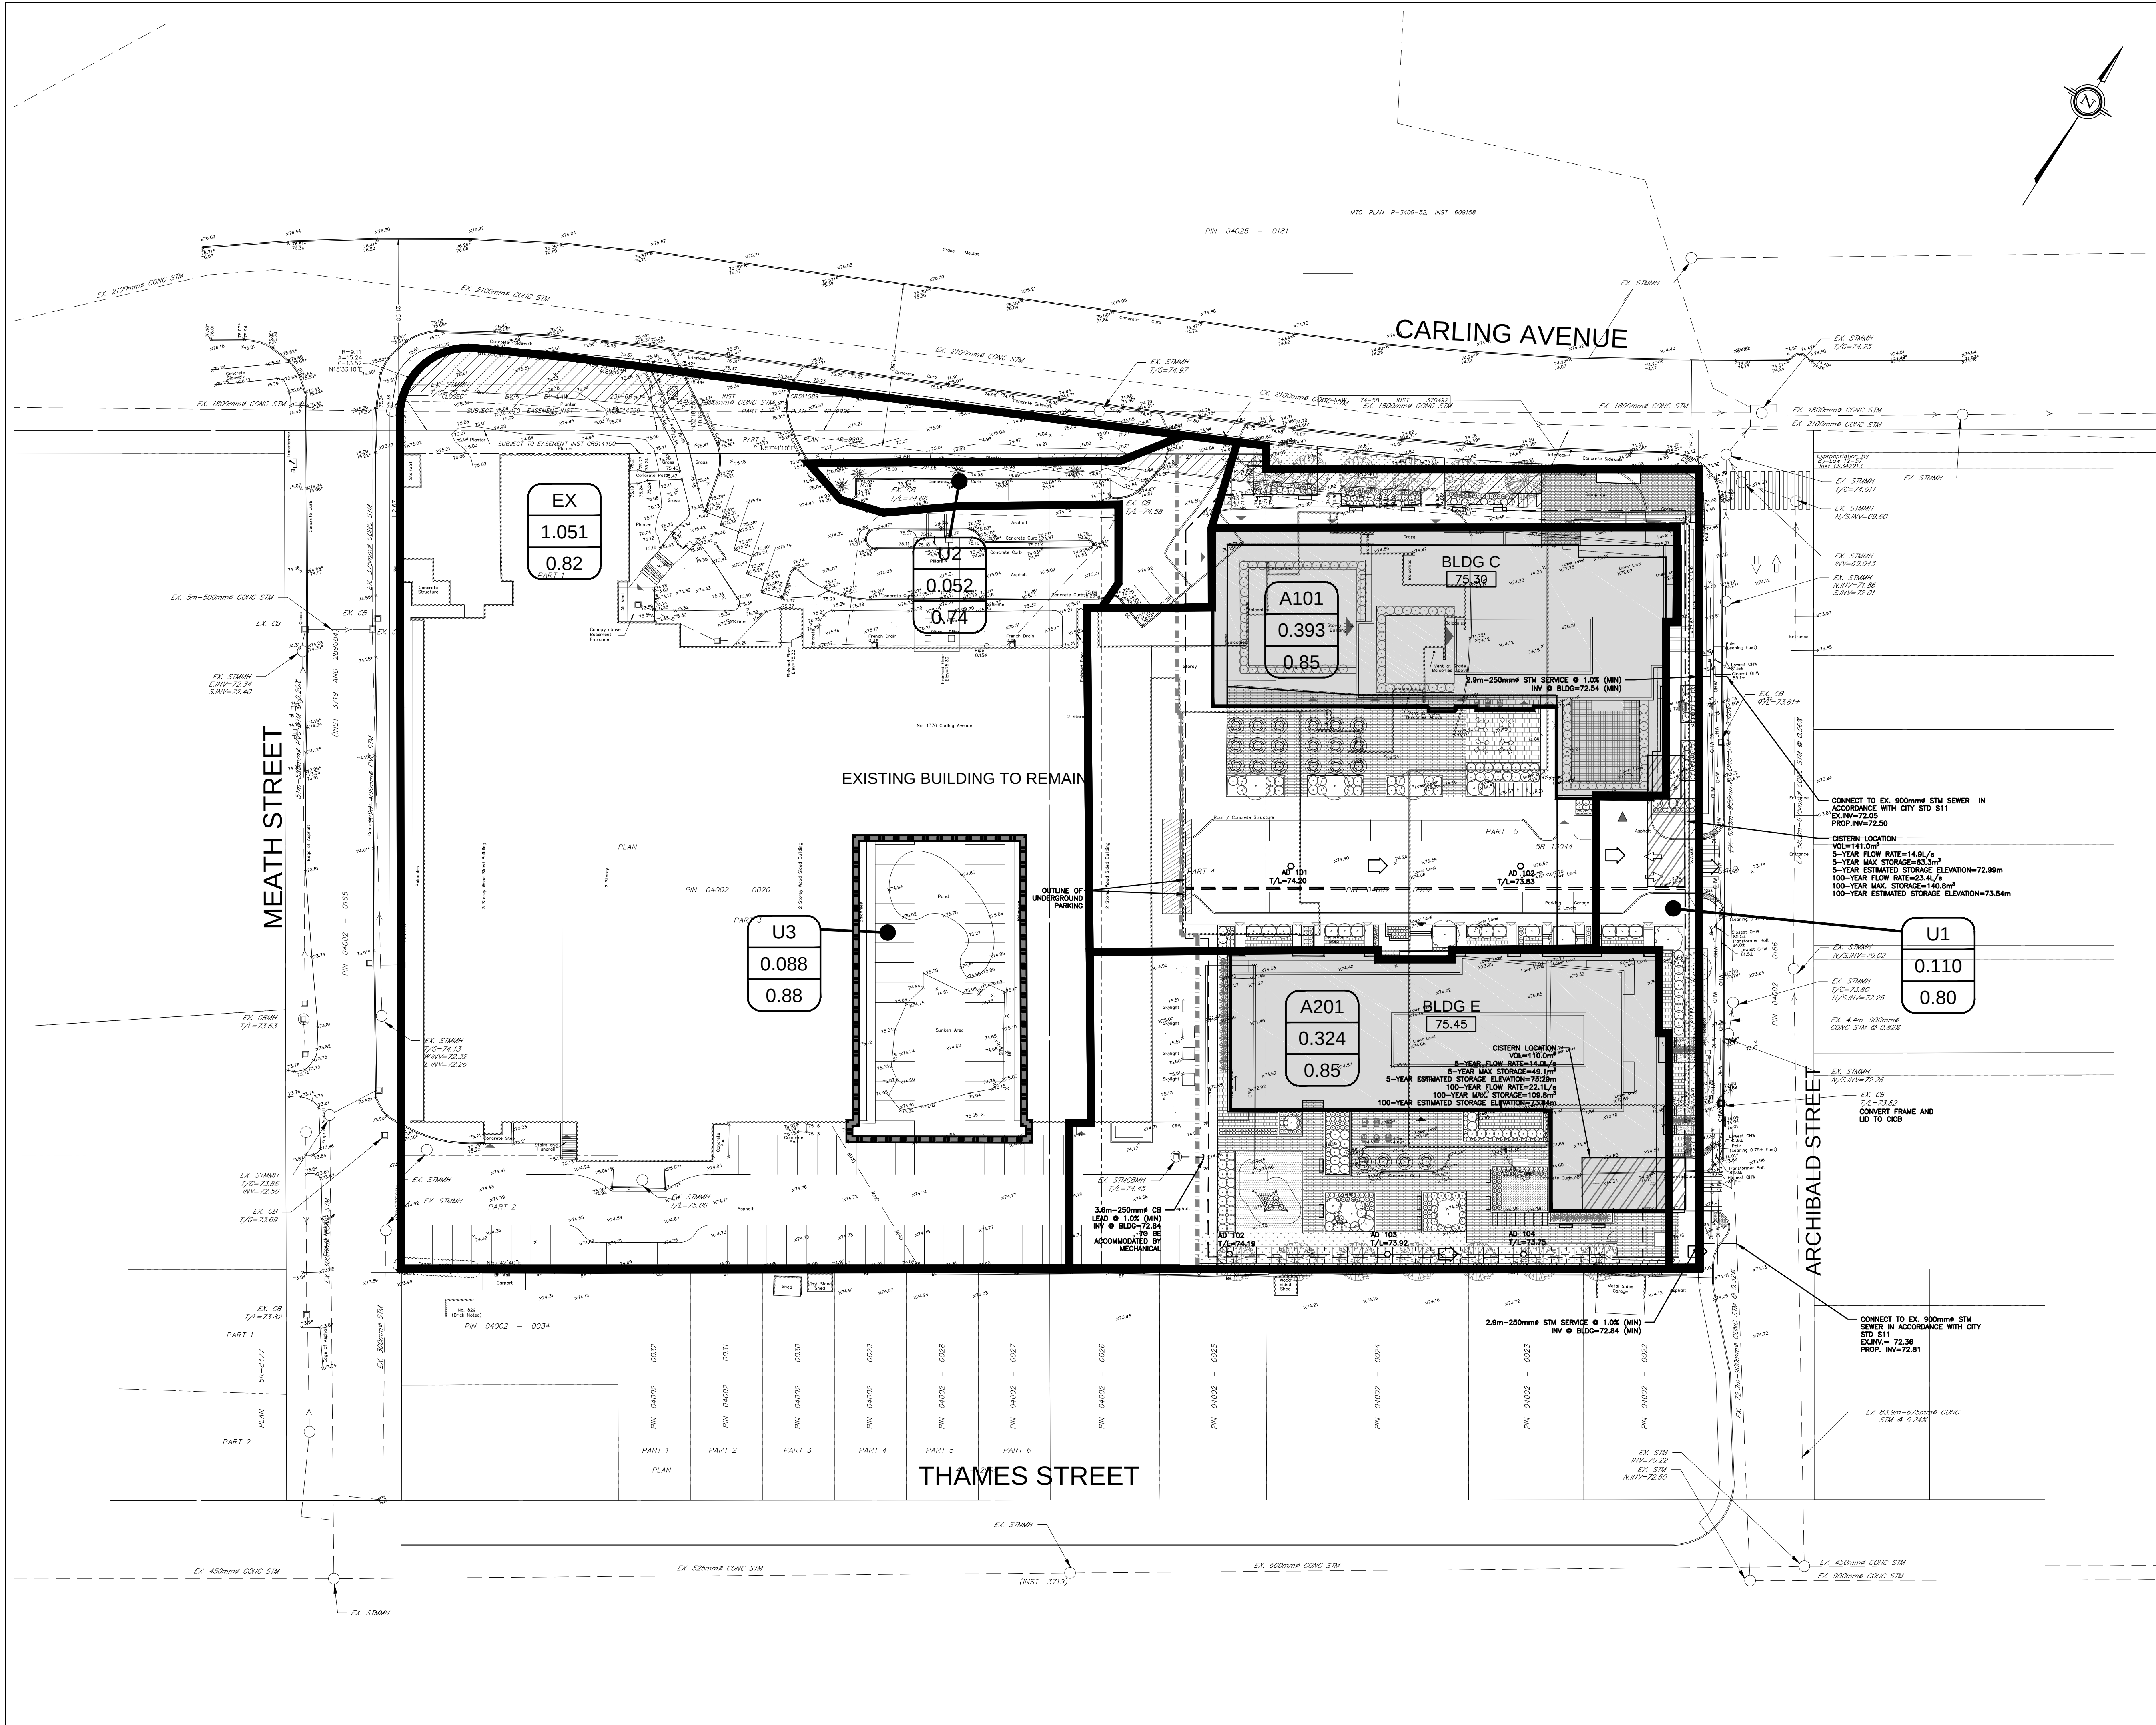

LEGEND

- PROPERTY LINE
- PROPOSED STORM SEWER
- DRAINAGE DIVIDE
- PROPOSED SWALE
- PROPOSED PERFORATED SUBRAIN
- MAJOR SYSTEM FLOW ROUTE
- DRAINAGE AREA ID
- AREA IN NO. 6
- RATIONAL METHOD RUNOFF
- PROPOSED STORM MANHOLE
- PROPOSED CATCH BASIN
- PROPOSED AREA DRAIN CONNECTED TO INTERNAL MECHANICAL SYSTEM
- ROAD WIDENING LIMITS
- PROPOSED INTERNAL CISTERN

EX6
4.010
0.19

APPROVED
By herweydo at 3:58 pm, Jan 16, 2019

DON HERWEYER, MCIP, RPP
MANAGER, DEVELOPMENT REVIEW - SOUTH
PLANNING, INFRASTRUCTURE & ECONOMIC
DEVELOPMENT DEPARTMENT, CITY OF OTTAWA

NOT FOR CONSTRUCTION

TOPOGRAPHIC INFORMATION
TOPOGRAPHIC INFORMATION PROVIDED BY ANNIS, O'SULLIVAN, VOLLEBEKK LTD.
PROJ. NO. 16427-15
RECEIVED APRIL 16, 2018

SITE PLAN INFORMATION
SITE PLAN PROVIDED BY GEIGORHUOT ARCHITECTS
PROJ. NO. 16-098
RECEIVED DECEMBER 03, 2018

GEOTECHNICAL STUDY
GEOTECHNICAL RECOMMENDATIONS PROVIDED BY PATERSON GROUP INC.
PROJ. NO. PG3736-1
DATED JANUARY 9, 2017

SITE SERVICING AND STORMWATER MANAGEMENT STUDY
SERVICING AND STORMWATER MANAGEMENT RECOMMENDATIONS PROVIDED BY DSEL
PROJ. NO. 16-908
DATED OCTOBER 2018

BENCH MARK
FIRE HYDRANT TOP OF SPINDLE LOCATED AT INTERSECTION OF CARLING AVENUE / ARCHIBALD STREET
ELEV=75.14

No.	BY	YY.MM.DD	DESCRIPTION
5	A.J.G.	18.12.05	ISSUED FOR MUNICIPAL REVIEW
4	A.J.G.	18.10.01	ISSUED FOR MUNICIPAL REVIEW
3	A.J.G.	18.05.10	ISSUED FOR MUNICIPAL REVIEW
2	A.J.G.	17.04.20	ISSUED FOR MUNICIPAL REVIEW
1	B.N.C.	17.04.05	ISSUED FOR COORDINATION

PROJECT No. 16-908

STORMWATER MANAGEMENT PLAN
1354 CARLING AVENUE © DSEL

HOLLOWAY LODGING CORPORATION 6009 Quinpool Road, 10th Floor
Halifax, Nova Scotia, B3K 5J7
Tel. (514) 516-2359

DSEL
david schaeffer engineering ltd
SMART SUBDIVISIONS™

120 Ibor Road Unit 103
Stittsville, Ontario, K2S 1E9
Tel. (613) 836-0856
Fax. (613) 836-7183
www.DSEL.ca

DRAWN BY: B.N.C. CHECKED BY: R.D.F. DRAWING NO. SHEET NO.
DESIGNED BY: B.N.C. CHECKED BY: A.D.F.
SCALE: 1:400 DATE: DECEMBER 2018 **SWM-1** 1 of 1