



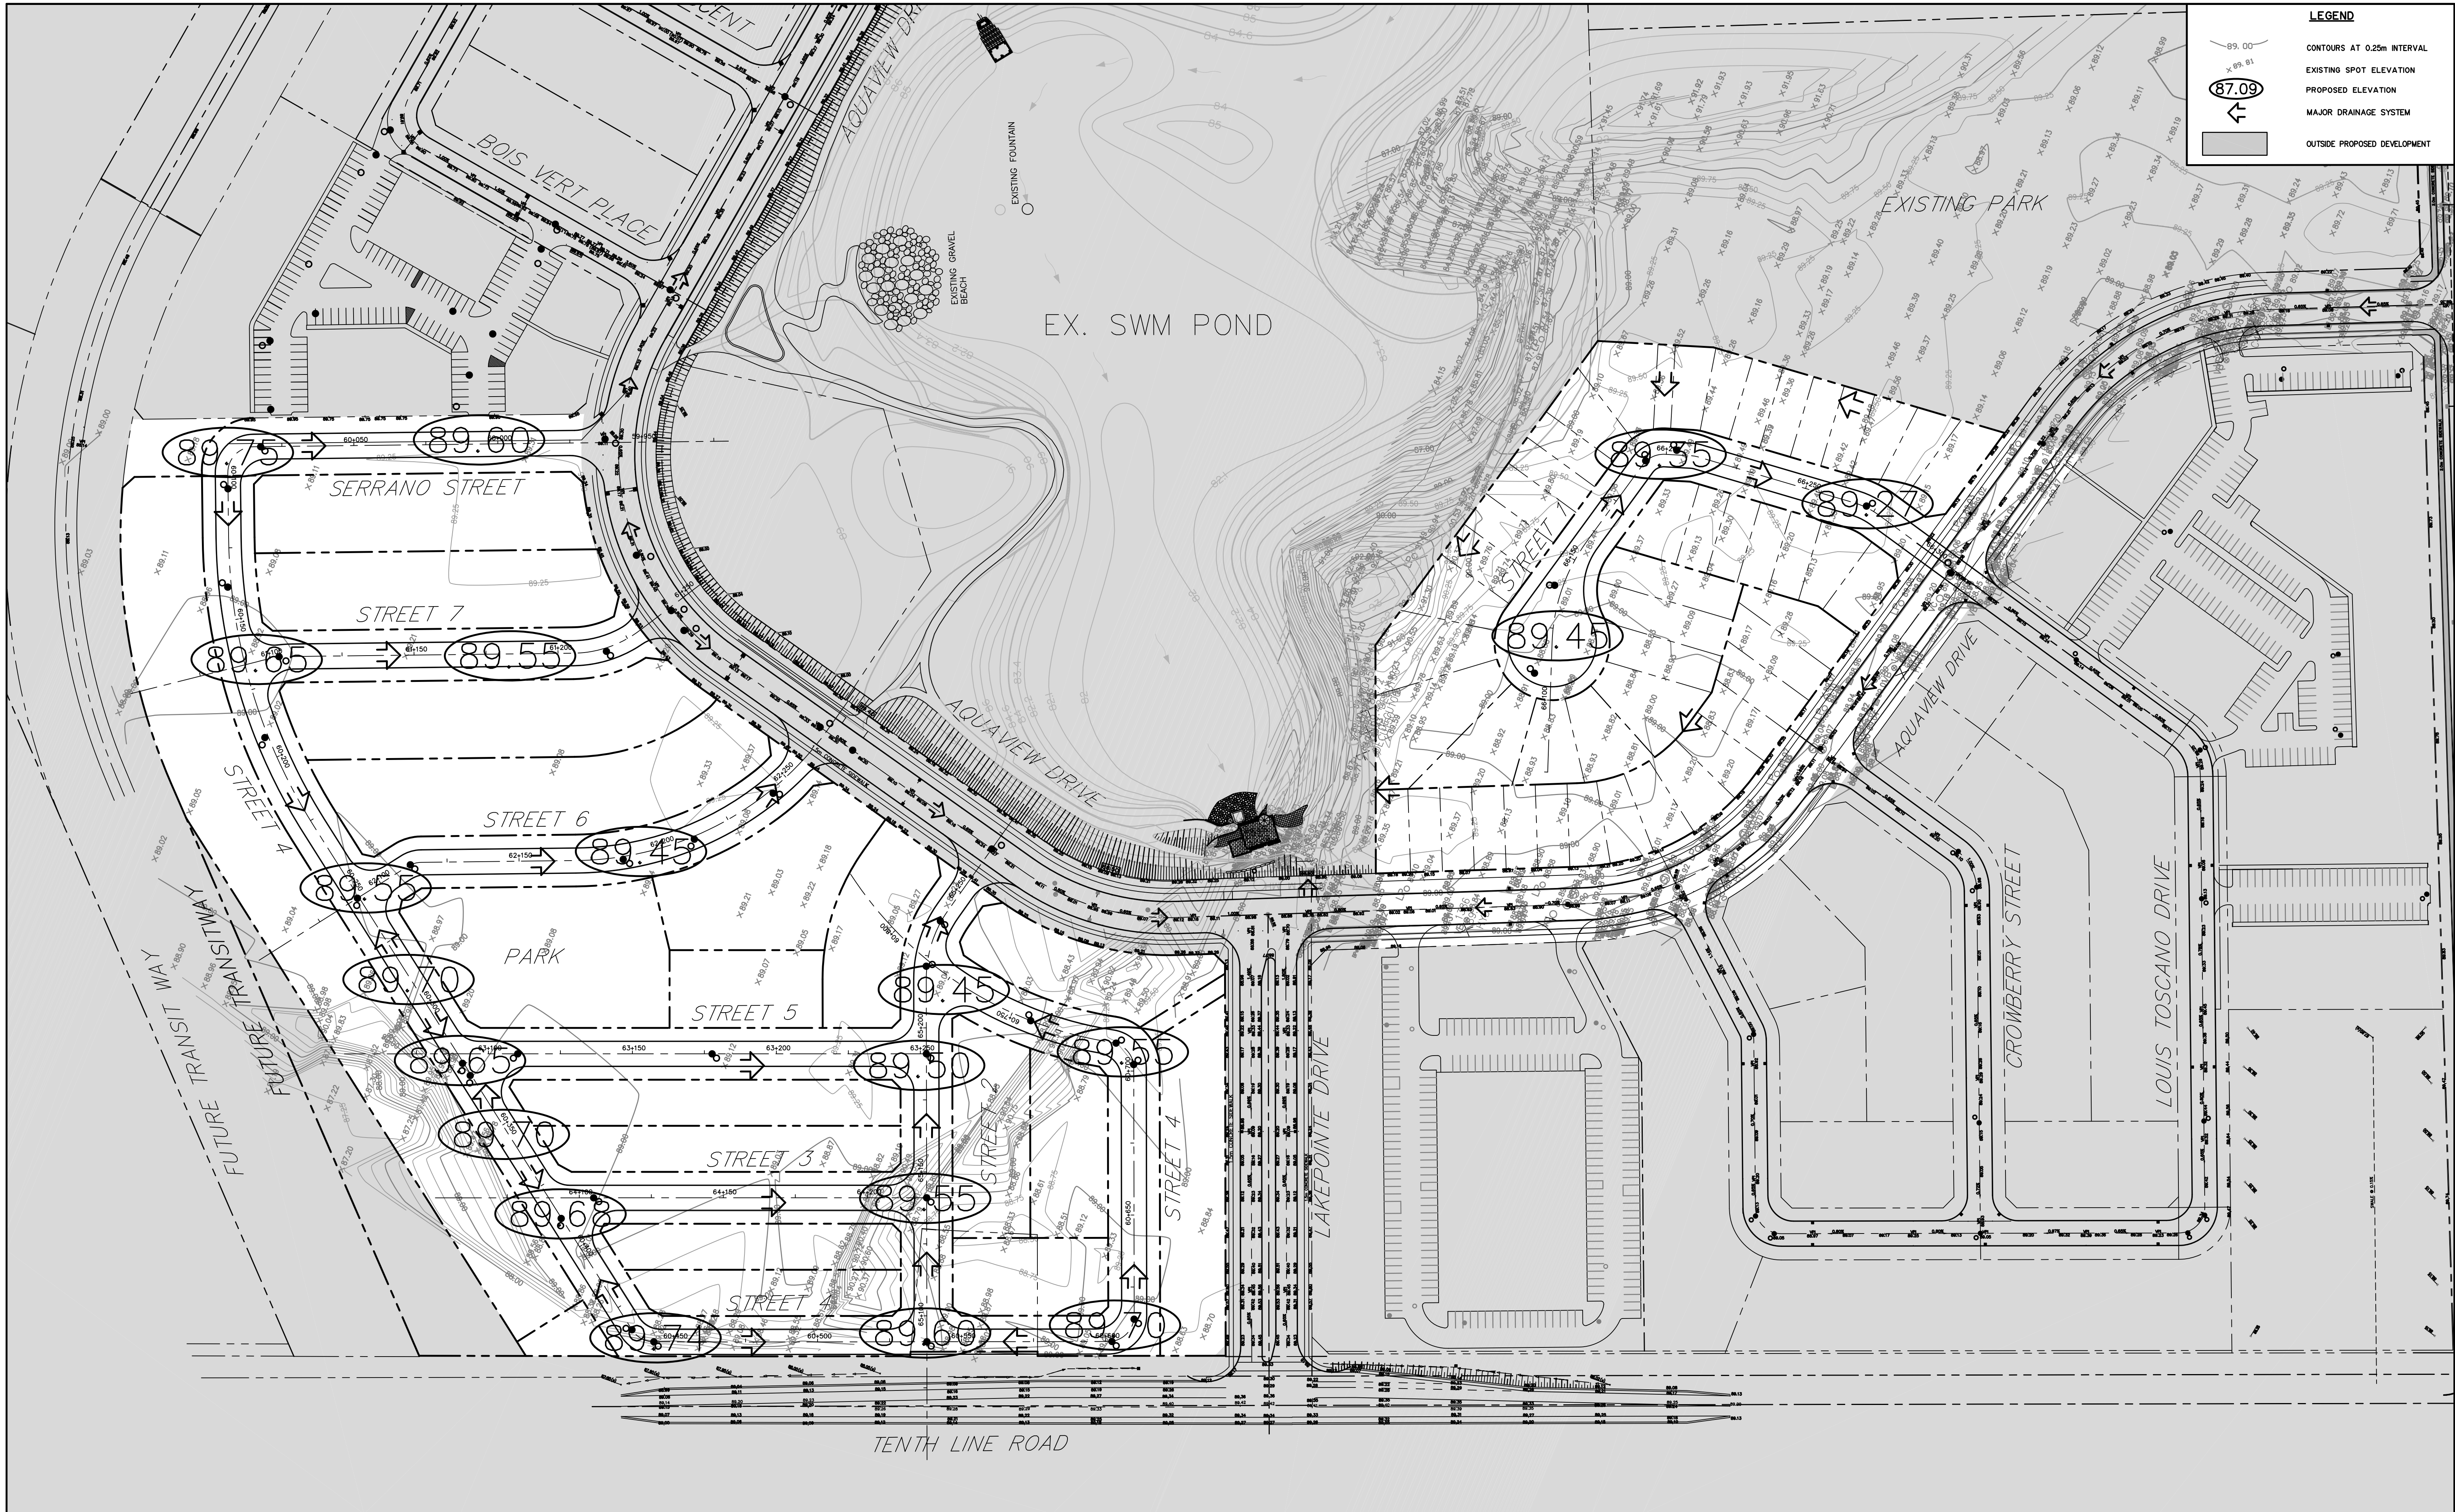

THE POSITION OF ALL POLE LINES, CONDUITS, WATERMANS, SEWERS AND OTHER UNDERGROUND AND OVERGROUND UTILITIES AND STRUCTURES IS NOT NECESSARILY SHOWN ON THE CONTRACT DRAWINGS, AND WHERE SHOWN, THE ACCURACY OF THE POSITION OF SUCH UTILITIES AND STRUCTURES IS NOT GUARANTEED. BEFORE STARTING WORK, DETERMINE THE EXACT LOCATION OF ALL SUCH UTILITIES AND STRUCTURES AND ASSUME ALL LIABILITY FOR DAMAGE TO THEM.

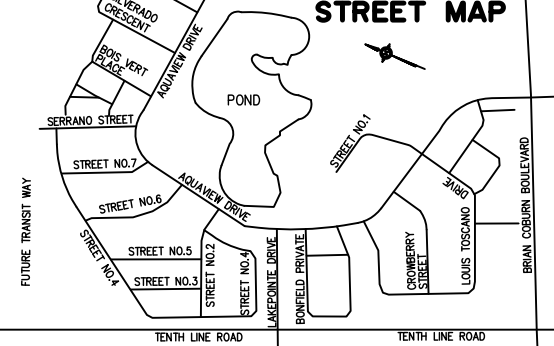

No.	REVISION	APPLIES WHEN DRAWING MODIFIED	DATE	BY
1	REVISED AS PER CITY COMMENTS		APR. 30/18	AGS
2	REVISED DRAFT PLAN		OCT. 18/18	AGS

SCALE

1 : 1000

0 10 20 30m

DESIGN

PLM

CHECKED

AGS

DRAWN

PLM

CHECKED

AGS

APPROVED

AGS



ATREL Engineering Ltd.

Engineers - Ingénieurs

1-2884 CHAMBERLAND STREET, ROCKLAND, ONTARIO K4K 1M6

TEL.: (613) 446-7423

CITY OF OTTAWA

AQUAVIEW

PLAN

MACRO GRADING PLAN

MINTO COMMUNITIES INC.

CLIENT No.

148

PROJECT No.

171203

DRAWING No.

171203-GRM