


Legend

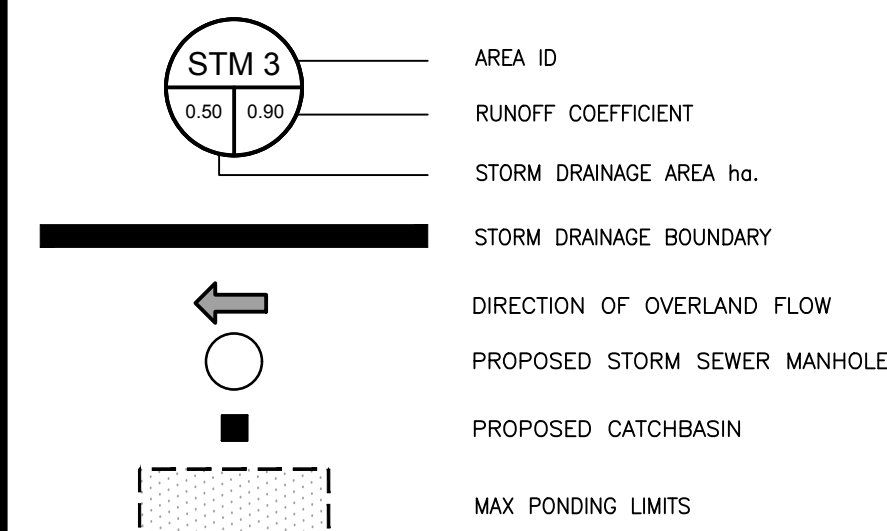

Notes

Revision	By	Appd.	17.12.03
1	MJS	DT	17.12.03

File Name:	MJS	SG	MJS	17.10.13
160401336 BLK 13 DB.DWG				

Permit Seal	DM	CHKD	DSGN	17.10.13



Client/Project
CAMPANALE HOMES
LONGFIELDS STATION
COMMERCIAL PLAZA
605 LONGFIELDS DRIVE
OTTAWA, ON, CANADA

Title
STORM DRAINAGE PLAN

Project No.	Scale
160401231	1:250

Drawing No.	Sheet	Revision
SD-1	5 of 6	1

SCHEDULE OF INLET CONTROL DEVICES					
STRUCTURE ID	DRAINAGE AREA ID	ICD TYPE	ICD INVERT (m)	100 YEAR HEAD (m)	100 YEAR FLOW (L/s)
STM MH 101	STM101	IPEX LMF 95	89.88	3.08	14.0
STM MH 102	STM102	IPEX LMF 75	90.26	3.28	9.1

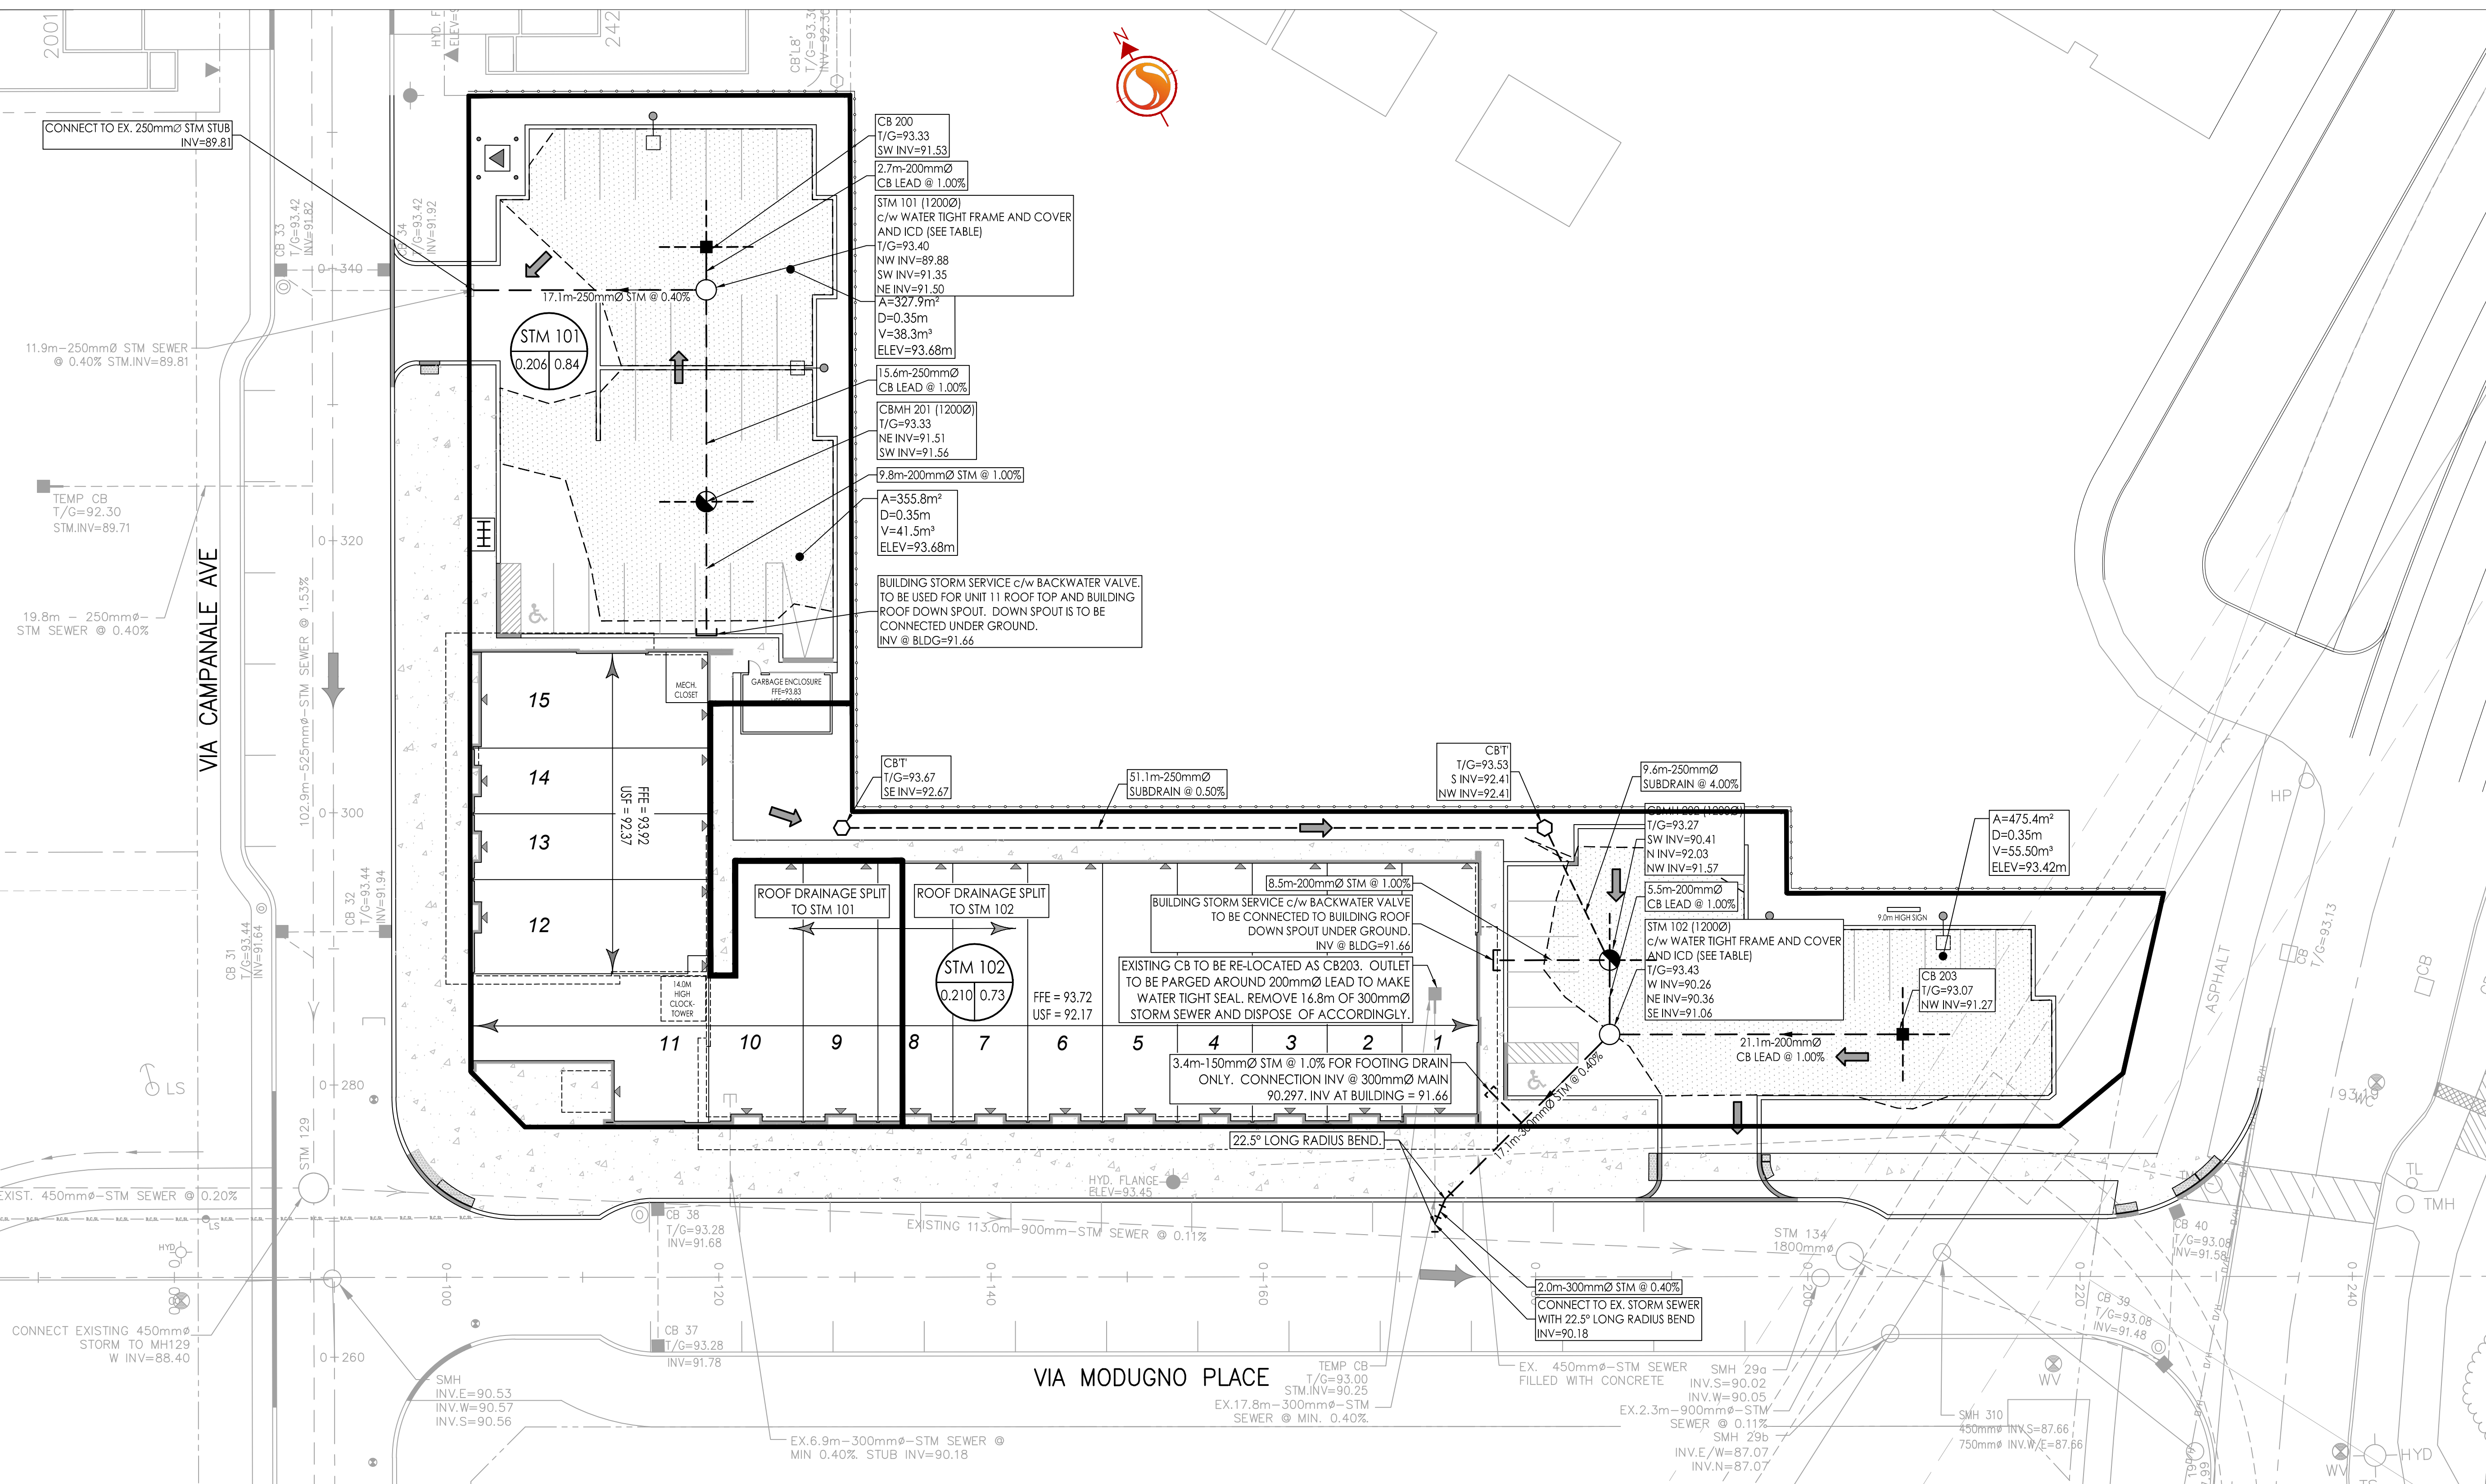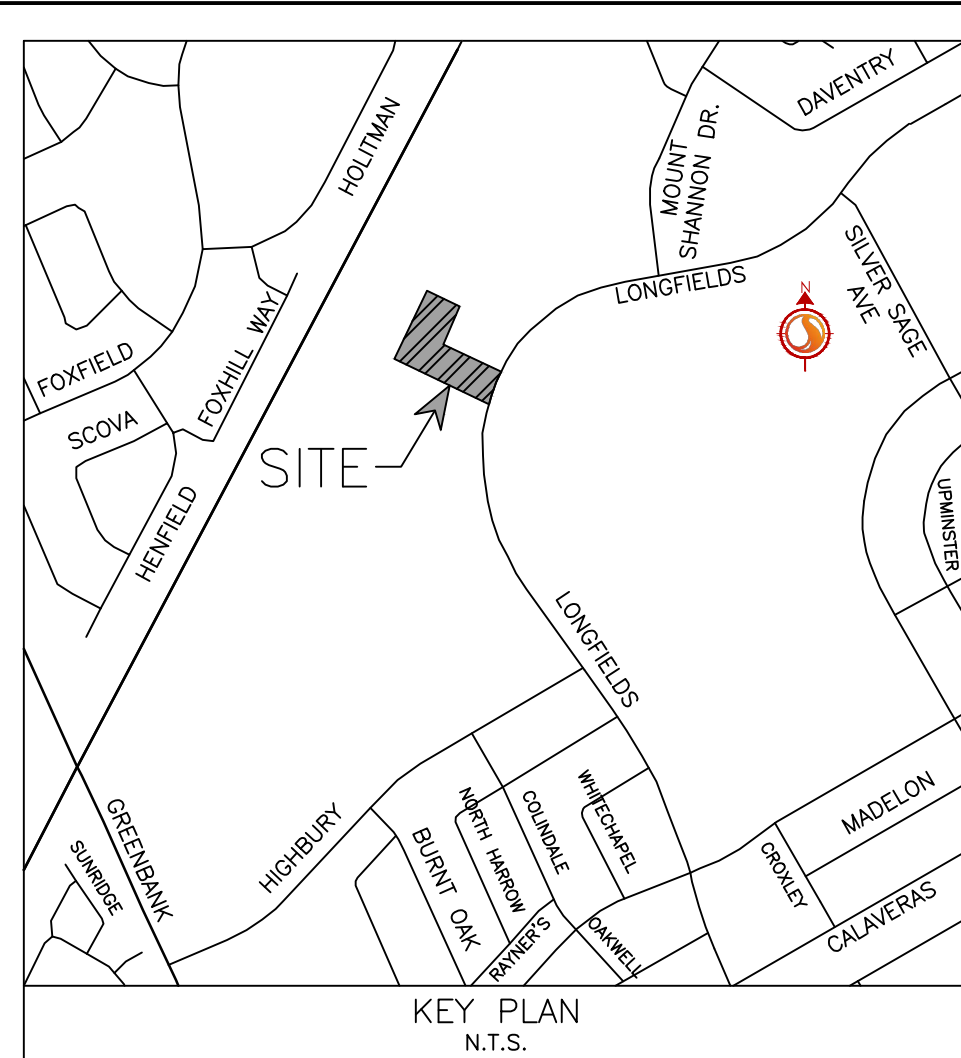

W:\projects\160401336_Longfields-Block 13 Design\Drawings\160401336_Blk 13 DB.dwg
20/11/13 11:17 AM by: mibocik, toom

ORIGINAL SHEET - ARCH-D