


1531 STITTSVILLE MAIN, STITTSVILLE
SITE LIGHTING PLAN
ELECTRICAL

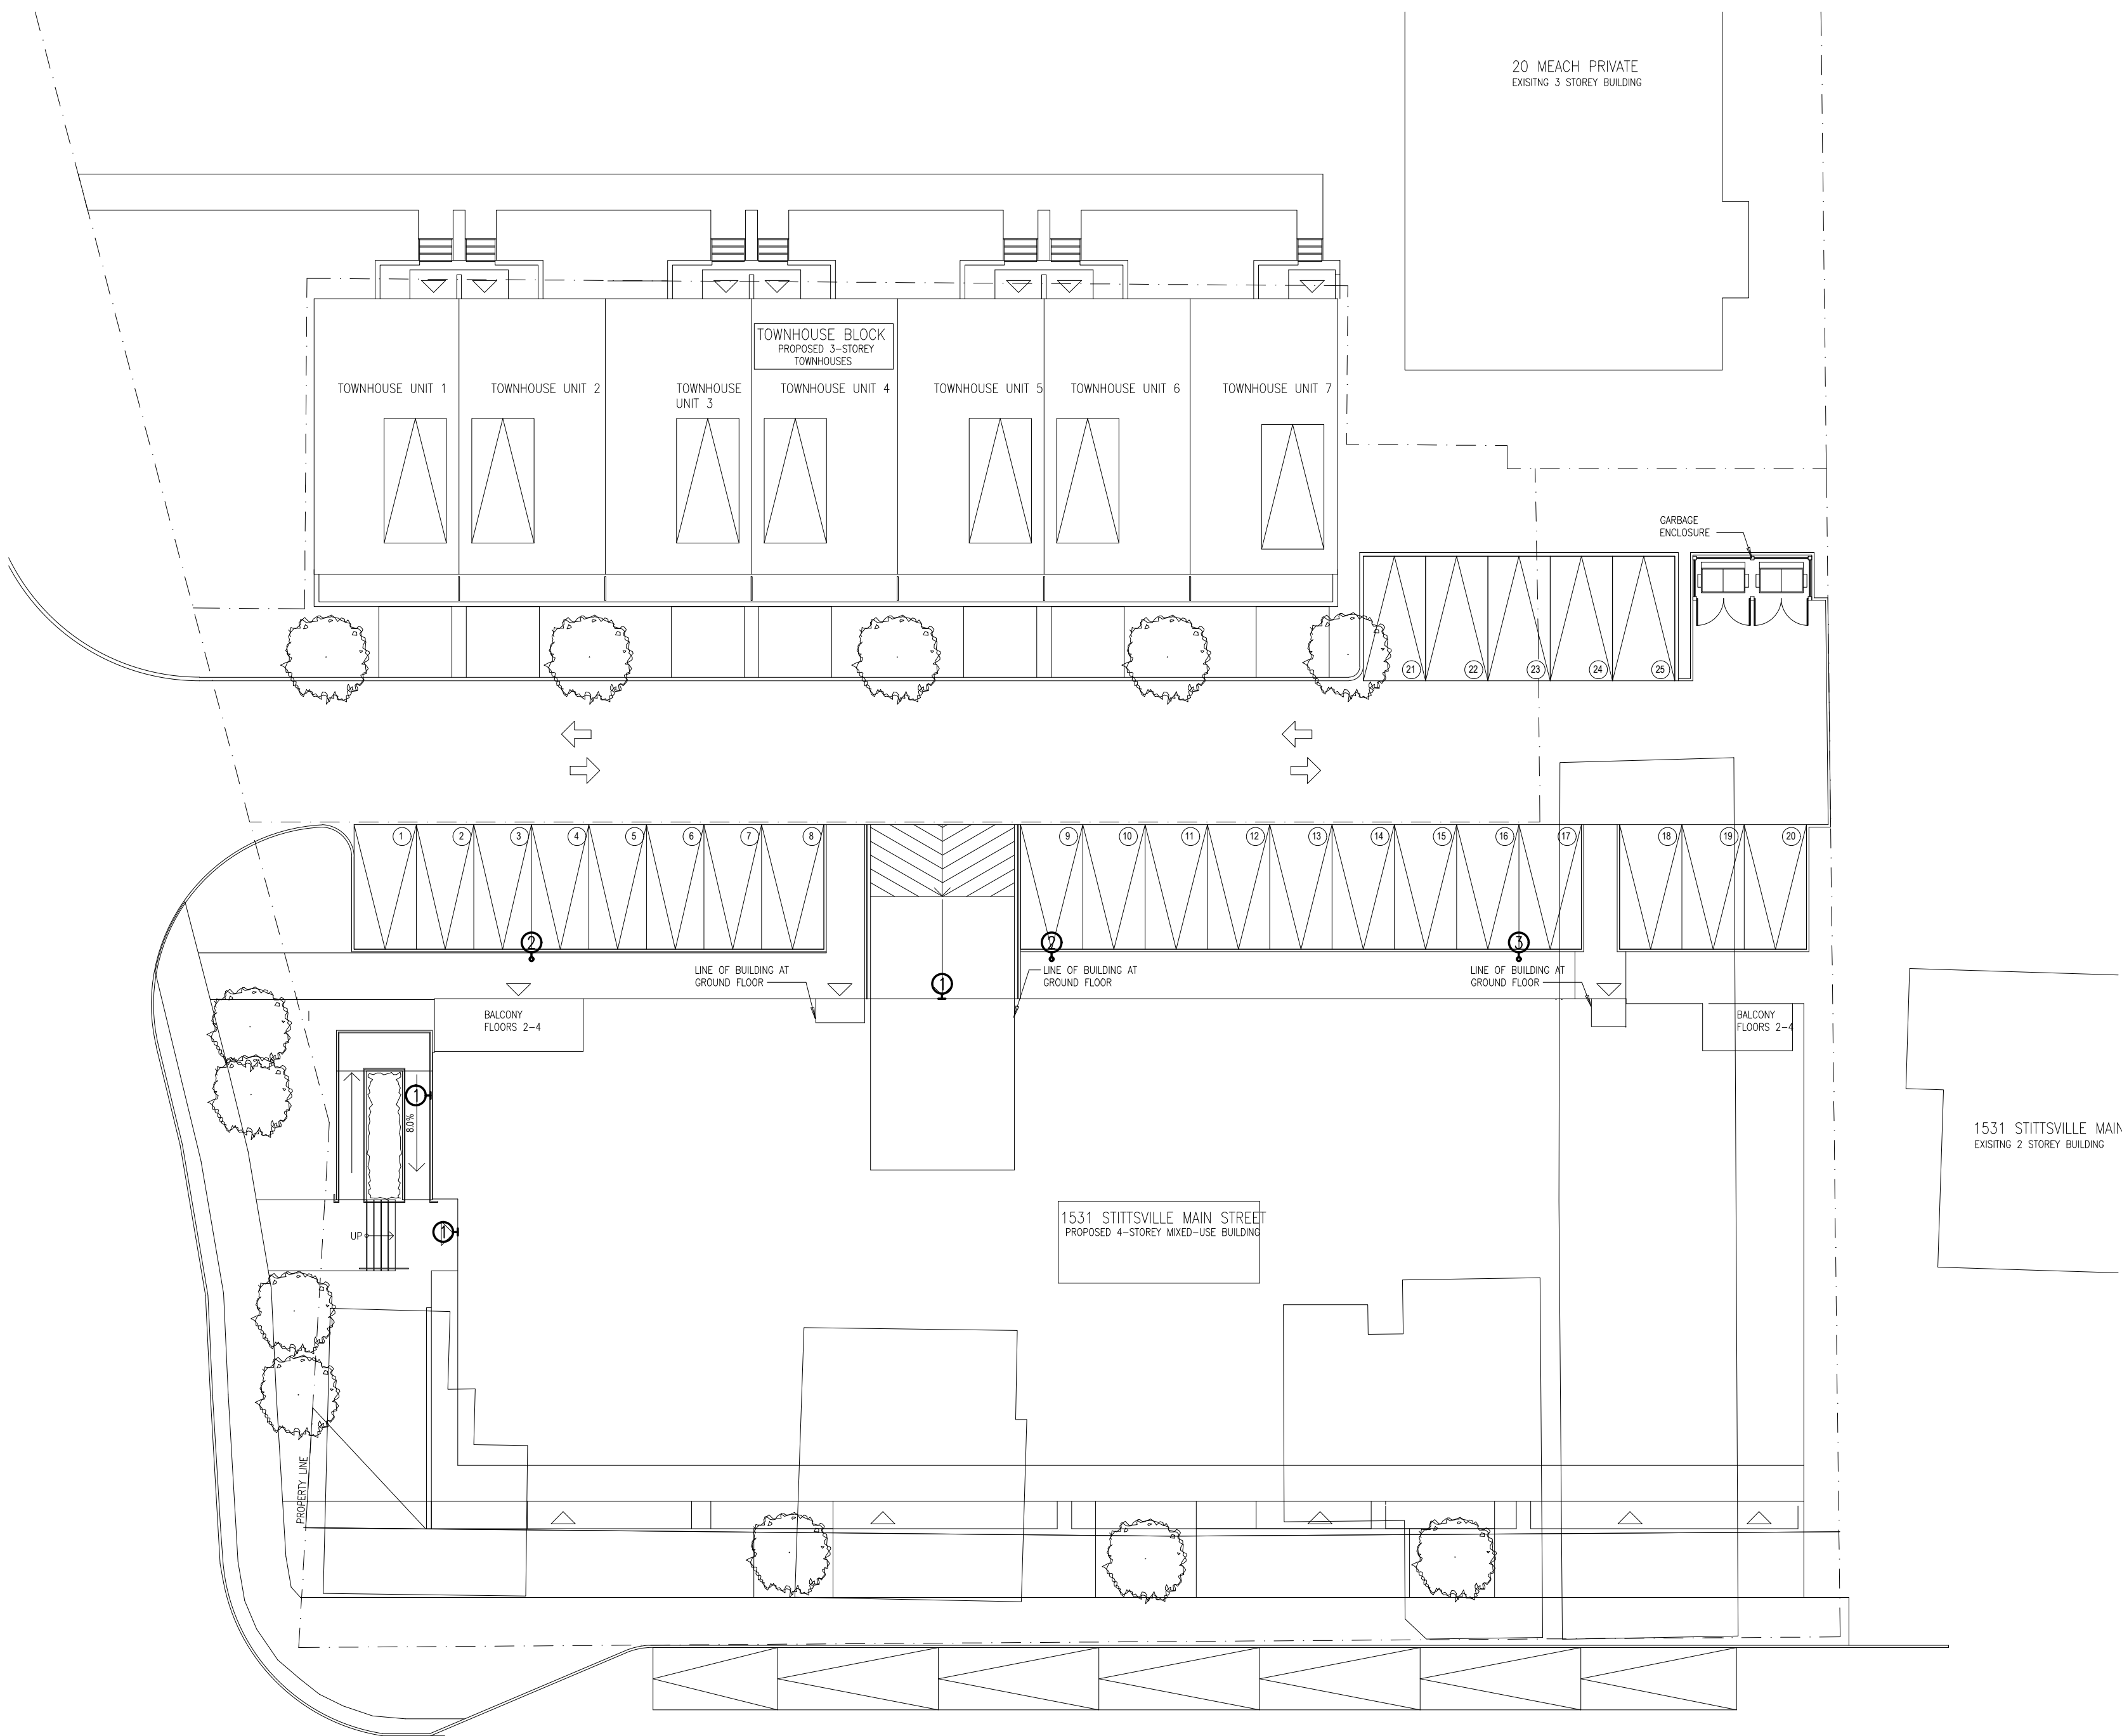


Client



LIGHTING FIXTURE SCHEDULE						
TYPE	DESCRIPTION	CATALOG NUMBER	LAMPS PER FIXTURE		VOLT	MOUNTING
			TYPE	WATTS COLOUR		
1	WALL PACK	EATON # XTOR2B-W #	LED	18 4000K	120	WALL
2	POLE MOUNTED LIGHT FIXTURE	EATON # GPC-AF-01-LED-E1-SL4-800 #	LED	44 4000K	120	POLE
3	POLE MOUNTED LIGHT FIXTURE	EATON # GPC-AF-02-LED-E1-SL4-800 #	LED	86 4000K	120	POLE

NOTES:
1. ALL MR16 LAMPS SHALL HAVE MINIMUM 6000 HOUR LIFE.

DRAWING LEGEND	
SYMBOL	DESCRIPTION
Ⓐ	WALL MOUNTED LIGHT FIXTURE - TYPE AS SHOWN
Ⓑ	EXTERIOR POLE MOUNTED LIGHT FIXTURE - TYPE AS SHOWN

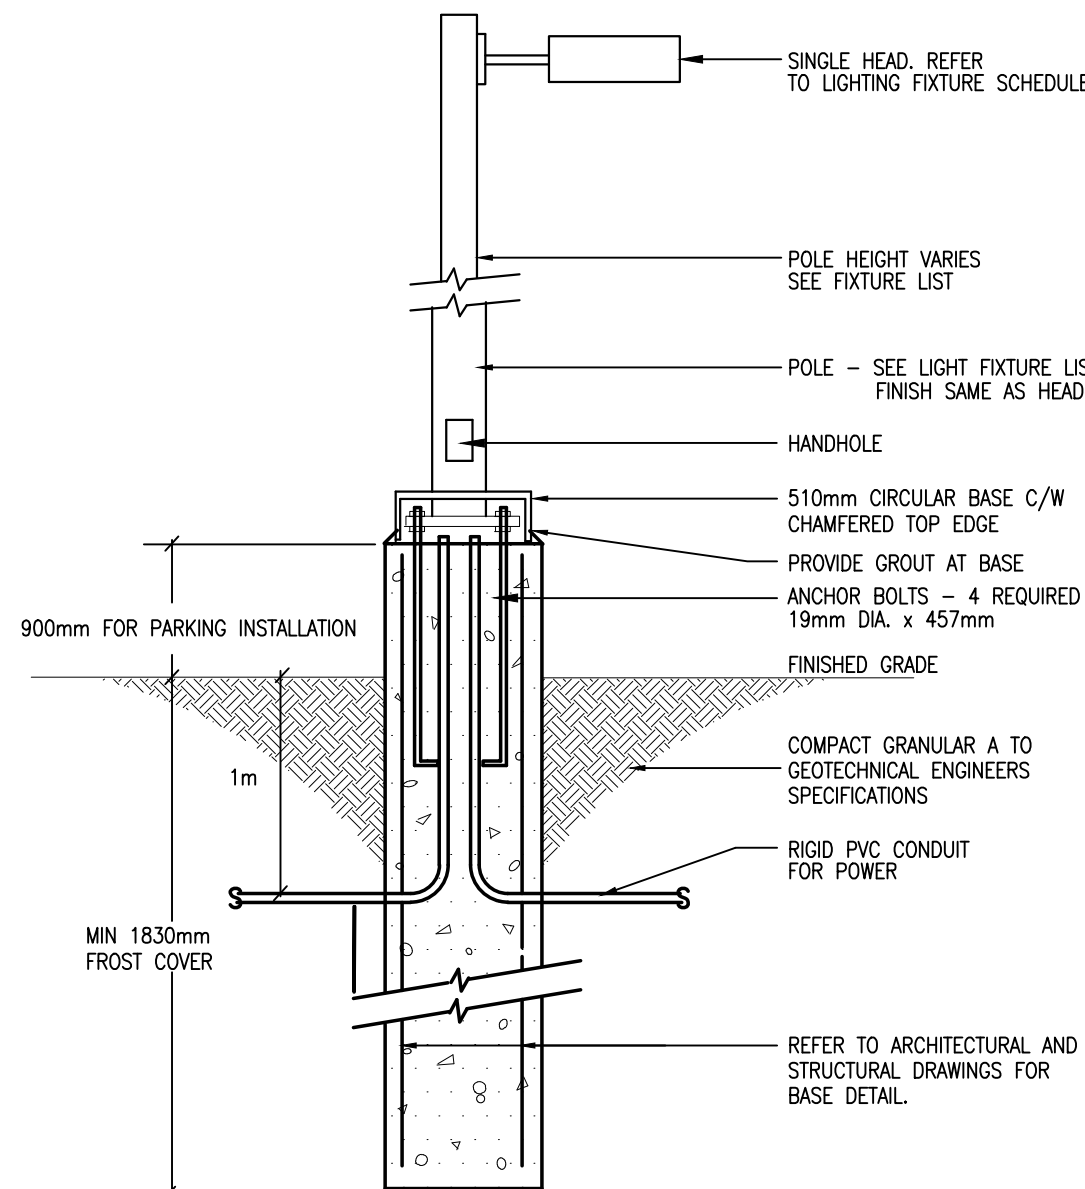

2
E1
TYPICAL BASE DETAIL
EXTERIOR LIGHT STANDARD
N.T.S.

THE ENGINEER WAIVES ANY AND ALL RESPONSIBILITY AND LIABILITY FOR PROBLEMS WHICH ARISE FROM FAILURE TO FOLLOW THESE PLANS, SPECIFICATIONS AND THE DESIGN INTENT THEY CONVEY, OR FOR PROBLEMS WHICH ARISE FROM OTHER FAILURE TO OBTAIN AND / OR FOLLOW THE ENGINEER'S GUIDANCE WITH RESPECT TO ANY ERRORS, OMISSIONS, INCONSISTENCIES, AMBIGUITIES OR CONFLICTS WHICH ARE ALLEGED.
THIS DRAWING IS THE PROPERTY OF GOODKEY WEEDMARK & ASSOCIATES LIMITED AND ALL COPYRIGHTS ARE RESERVED. NO USE OF THIS DRAWING MAY BE MADE WITHOUT EXPRESS WRITTEN CONSENT.
DO NOT SCALE DRAWINGS.
L'INGÉNIEUR DÉCLINE TOUTE RESPONSABILITÉ DÉCOULANT DE PROBLÈMES FAISANT SUITE AU NON RESPECT DES PLANS, DEVIS ET DE L'INTENTION DU CONCEPT QU'ILS INDICENT OU DE TOUTS LES PROBLÈMES POUVANT RÉSULTER DU DÉFAUT D'OBTENIR ET / OU DE SUIVRE LES CONSEILS DE L'INGÉNIEUR EN CE QUI CONCERNE LES ERREURS, OMISSIONS, INCONSISTANCES, AMBIGUITÉS OU CONFLITS ALLEGUÉS.
CE DESSIN EST LA PROPRIÉTÉ LITTÉRAIRE DE GOODKEY WEEDMARK & ASSOCIATES LIMITED ET TOUTS LES DROITS SONT RÉSERVÉS. L'UTILISATION EST INTERDITE SANS LE CONSENTEMENT ÉCRIT DE L'AUTEUR.
NE PAS MESURER LES DESSINS À L'ÉCHELLE

Goodkey Weedmark
Consulting Engineers

GOODKEY WEEDMARK & ASSOCIATES LIMITED
1688 Woodward Dr.
Ottawa Ontario
Canada K2C 3R8

613 727-5111 Voice
613 727-5115 Fax
www.gwal.com Web

Project north
Nord du projet

Seal/Scelus

LICENSED PROFESSIONAL ENGINEER
D.B. VYAS
100133120
PROVINCE OF ONTARIO

Project/Projet
**1531 STITTSVILLE MAIN
STITTSVILLE**

Drawing title/Titre du dessin
**ELECTRICAL
SITE PLAN**

Scale Échelle	1:200	Project no./No. du projet 2018-781
Design by Conçu par	M.E.	Drawing/Desin
Drawn by Dessiné par	M.E.	E1
Reviewed by Examiné par	D.V.	
Date	JANUARY 2019	Revision no: 0
Date		Acad file/Fichier: Z:\2018-781\ELEC

OF 1